




# CLR PROJECT 05-17-DR-208A

## MORRISON COURT DRAINAGE

### LITTLE ROCK, ARKANSAS

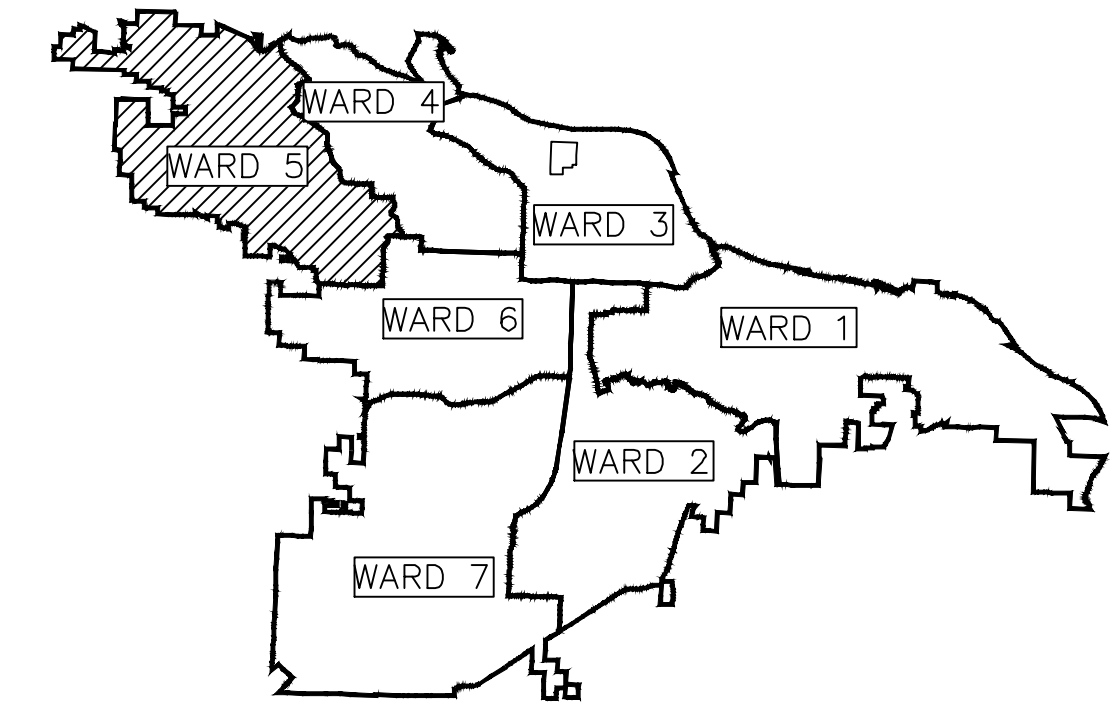

PROJECT LOCATION – WARD 5

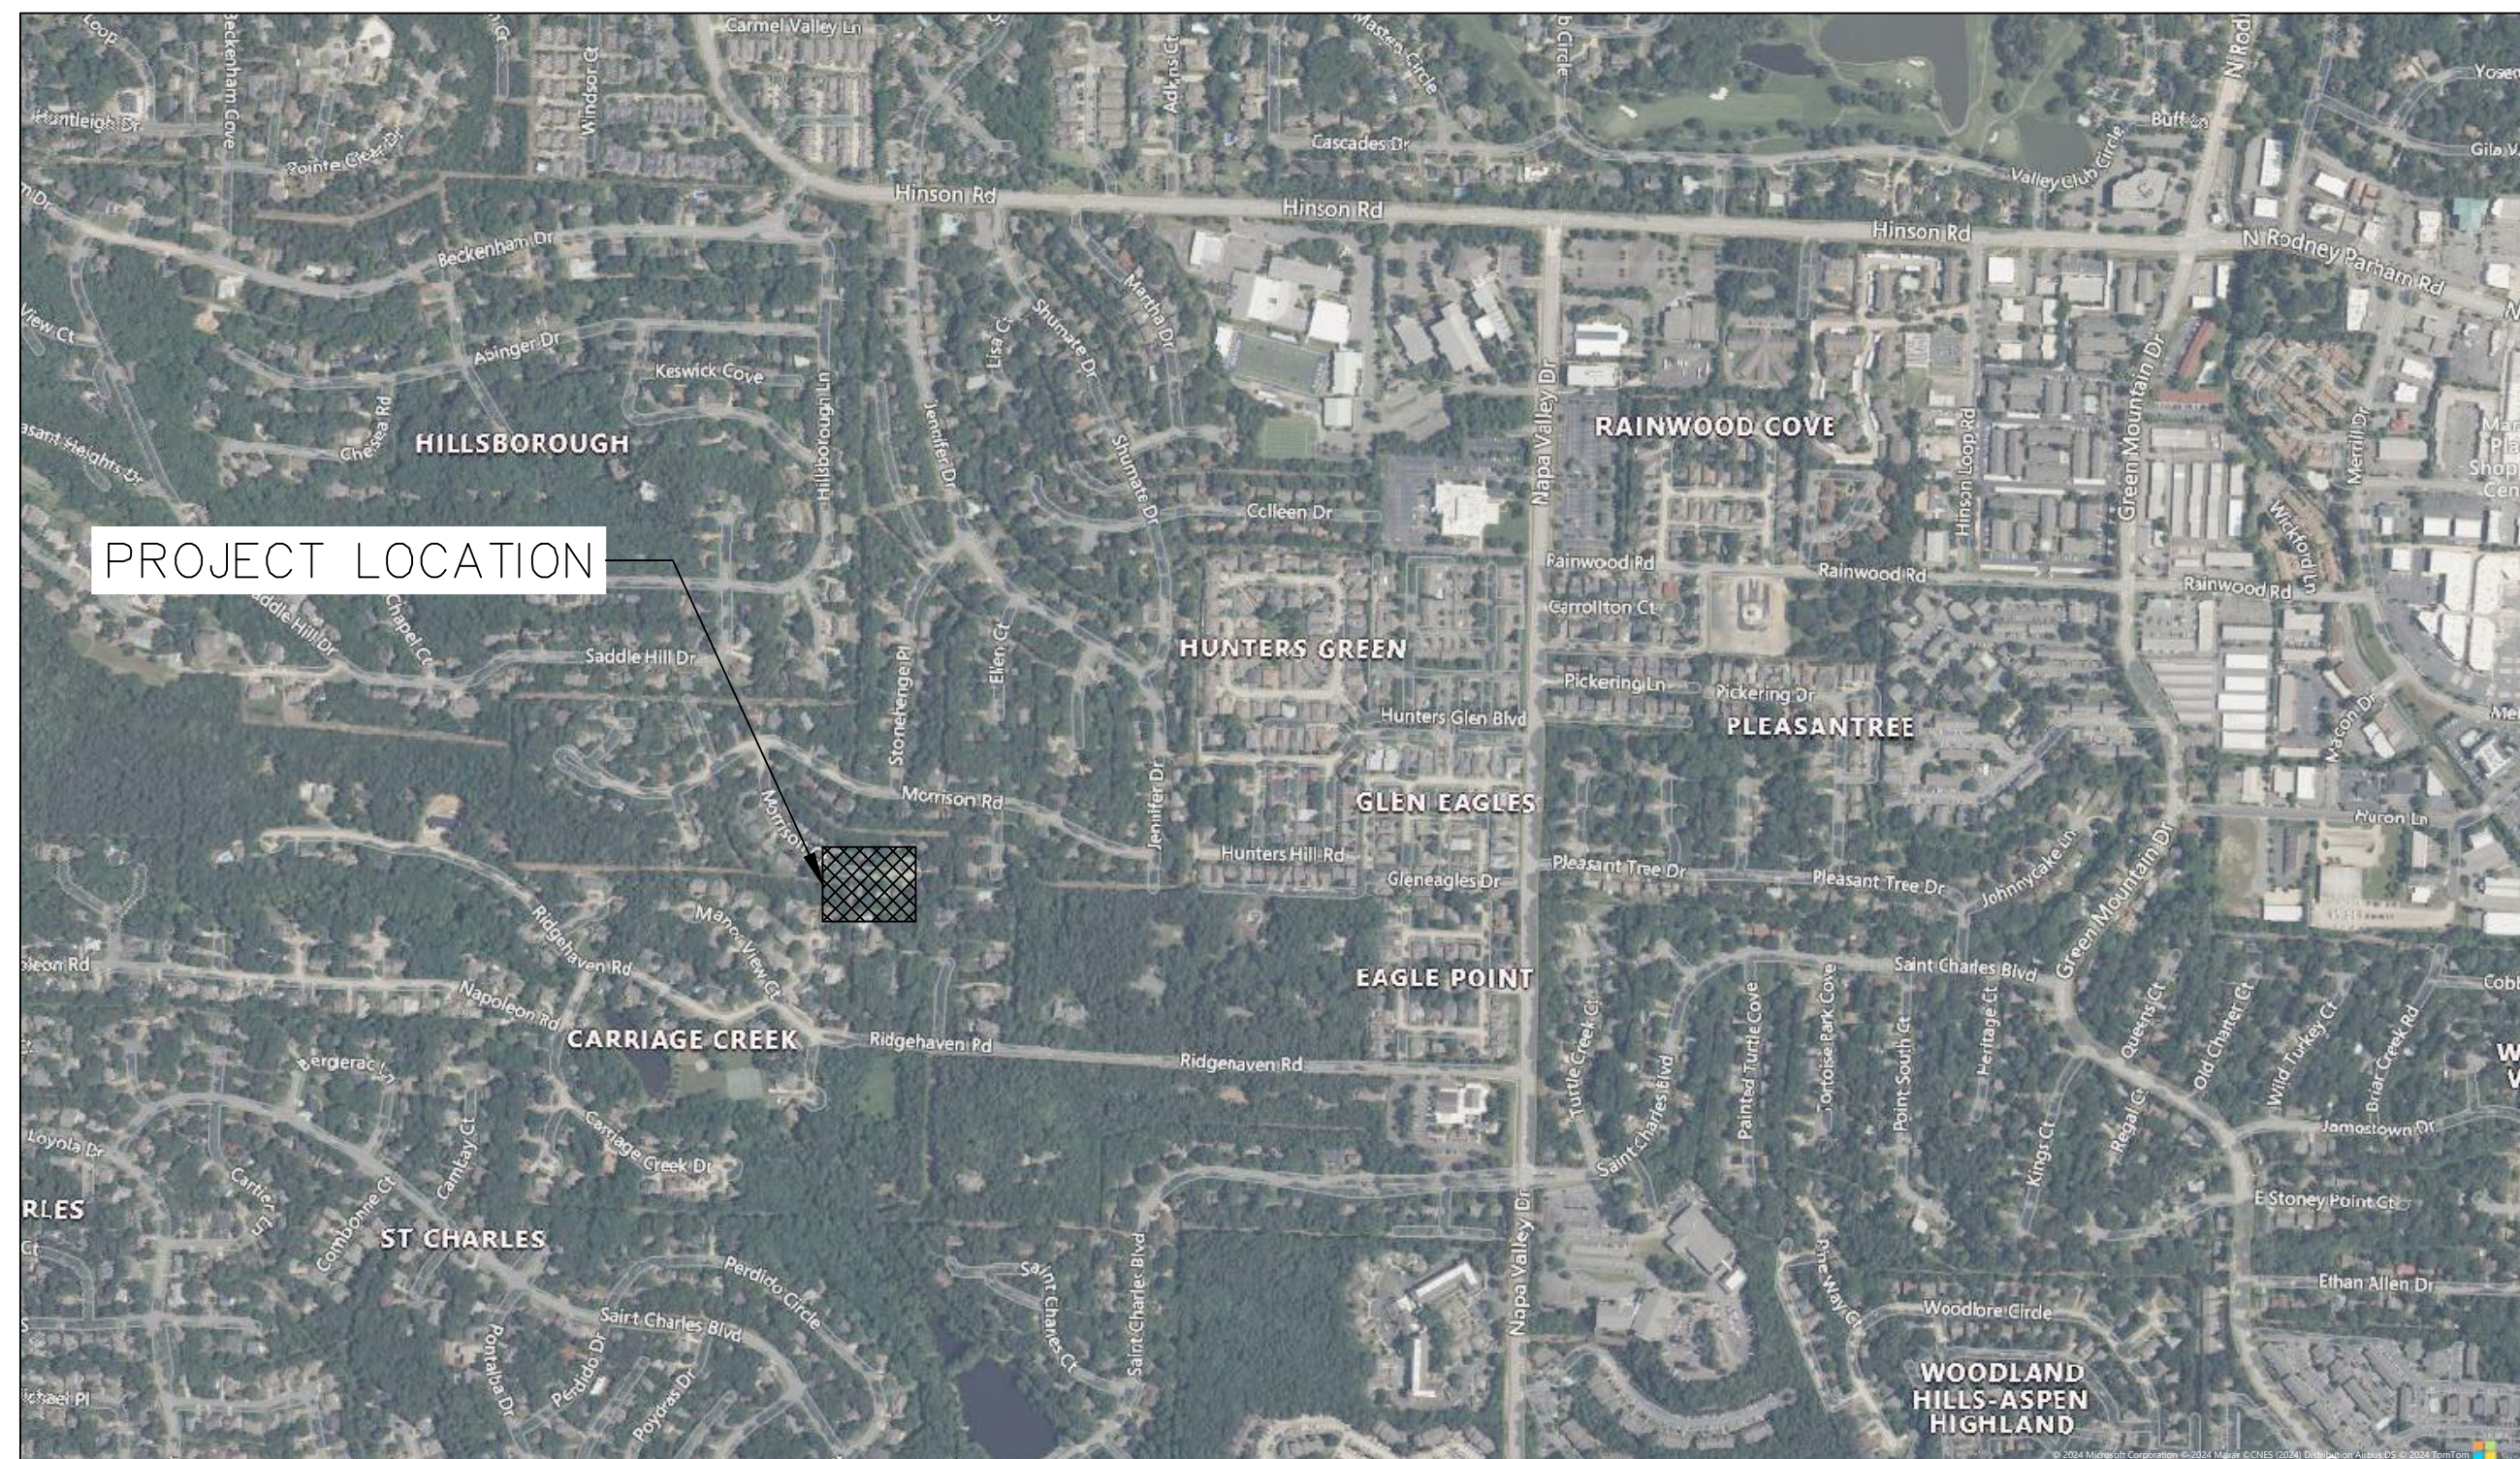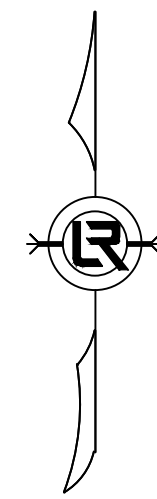

**2023-2025  
BOND PROGRAM**

**JANUARY 2025**

DEPARTMENT OF PUBLIC WORKS  
CIVIL ENGINEERING  
701 WEST MARKHAM STREET  
LITTLE ROCK, ARKANSAS 72201

#### TABLE OF CONTENTS


SHEET NO.	TITLE
C1	COVER SHEET
C2	GENERAL NOTES, LEGEND AND QUANTITIES
C3	EXISTING LAYOUT/DEMOLITION
C4	PROPOSED LAYOUT
C5	PLAN & PROFILE
C6	CROSS SECTIONS
C7	EROSION CONTROL PH 1
C8	EROSION CONTROL PH 2



10825 FINANCIAL CENTRE PKWY  
SUITE 212  
LITTLE ROCK, AR 72211  
501-435-3700

REVISIONS	DATE

CITY OF LITTLE ROCK, ARKANSAS  
MORRISON COURT DRAINAGE  
COVER SHEET

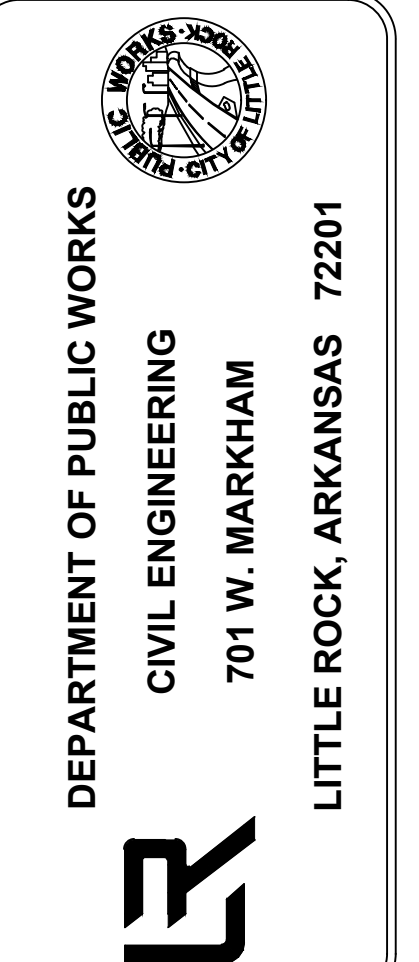

<b>DRAWN BY</b>	VSE
<b>DESIGNED</b>	VSE
<b>CHECKED</b>	JPC
<b>DATE</b>	1/20/2025
<b>SCALE</b>	NTS
<b>PROJECT NO.</b>	05-17-DR-208A
<b>SHEET NO.</b>	C1

<b>CLR PROJECT 05-17-DR-208A</b>			
MORRISON COURT DRAINAGE			
20-Jan-25			
ITEM #	ITEM DESCRIPTION	UNIT	QUANTITY
2.01	SITE PREPARATION (INCL. MOBILIZATION)	LS	1
3.01	UNCLASSIFIED EXCAVATION	CY	28
3.07	COMPACTED EMBACKMENT	CY	5
4.01	CLASS 7 AGGREGATE BASE	TON	12
10.01	JUNCTION BOX	EA	3
13.24	STORM DRAIN PIPES, 24"	LF	29
13.36	STORM DRAIN PIPES, 36"	LF	18
14.01	SOLID SODDING, MATCH EXISTING	SY	306
19.10	FINAL CLEANUP	LS	1
24.11	SILT FENCE - TYPE A (SFA)	LF	210
31.00	CONCRETE DITCH PAVING	SY	19.00

GENERAL NOTES:

1. ANY DEMOLITION OR REMOVAL ITEMS TO BE PAID FOR UNDER "SITE PREPARATION".
2. COST OF CONSTRUCTION ENTRANCE TO WORK SITE AND ANY REMOVAL AND REPAIR OF ENTRANCE TO PREVIOUS CONDITION TO BE PAID FOR UNDER "SITE PREPARATION".

EXISTING

IRON ROD	○ IR
PK NAIL	○ PK
R.R. SPIKE	○ RR(Sp)
CONC. MONUMENT	□ CM
WATER VALVE	⊗ WV
WATER METER	□ WM
FIRE HYDRANT	⊕ FH
GAS METER	⊗ GM
GAS VALVE	⊗ GV
CLEAN-OUT	○ CO
GUARD POST (BOLLARD)	● GP
SIGN POST	⊕
BENCHMARK	⊕
STORM SEWER MANHOLE	⊕
SANITARY SEWER MANHOLE	⊕
TELEPHONE MANHOLE	⊕
ELECTRIC MANHOLE	⊕
TELEPHONE BOX	⊕
ELECTRIC BOX	⊕
CABLE BOX	⊕
UTILITY POLE	⊕
GUY WIRE	⊕
LIGHT POLE	⊕
POST OR POLE (TYPE AS NOTED)	⊕
MAILBOX	⊕
DECIDUOUS TREE	⊕
EVERGREEN/CONIFEROUS TREE	⊕
BUSH	⊕
PROPERTY LINE	⊕
SETBACK LINE	⊕
EASEMENT LINE	⊕
CURB	⊕
FENCE	⊕
OVERHEAD ELECTRIC	⊕
OVERHEAD TELEPHONE	⊕
OVERHEAD CABLE	⊕
UNDERGROUND TELEPHONE	⊕
UNDERGROUND ELECTRIC	⊕
UNDERGROUND CABLE	⊕
WATER LINE	⊕
SEWER LINE	⊕
GAS LINE	⊕
STORM SEWER/CULVERT	⊕
EDGE OF WOODS	⊕
CONTOUR LINE	⊕

PROPOSED

PROPOSED CONTOUR	⊕
PROPOSED SPOT ELEVATION	⊕
PROPOSED SPOT CURB ELEVATION	⊕
STORM SEWER - PIPE	⊕
STORM SEWER - METERED END SECTION	⊕
STORM SEWER - GRATE INLET	⊕
STORM SEWER - JUNCTION BOX	⊕
STORM SEWER - FLARED END SECTION	⊕
STORM SEWER - HEADWALL	⊕
STORM SEWER - NO WING	⊕
STORM SEWER - SINGLE WING	⊕
STORM SEWER - DOUBLE WING	⊕
STORM SEWER - AREA INLET	⊕
GRADE BREAK LINE	⊕
HIGH POINT	⊕
LOW POINT	⊕
CUT LINE	⊕
FILL LINE	⊕
SANITARY SEWER PIPE	⊕
SANITARY SEWER MANHOLE	⊕
PROPOSED CURB	⊕
PROPOSED CONCRETE	⊕
CONSTRUCTION - ENTRANCE/EXIT	⊕
CHECK DAM	⊕
DIVERSION BERM	⊕
DOWNDRAIN STRUCTURE - TEMPORARY	⊕
ROCK DAM	⊕
SEDIMENT BARRIER - SILT FENCE	⊕
SEDIMENT BARRIER - GRAVEL RING	⊕
SEDIMENT BARRIER - BLOCK & GRAVEL	⊕
SEDIMENT BARRIER - BLOCK	⊕
TEMPORARY SEDIMENT BASIN	⊕
SILT FENCE - TYPE A	⊕
SILT FENCE - TYPE B	⊕
SILT FENCE - TYPE C	⊕
STORM DRAIN OUTLET PROTECTION	⊕
SURFACE ROUGHENING	⊕
DISTURBED AREA STABILIZATION - TEMPORARY STABILIZATION	⊕
DISTURBED AREA STABILIZATION - TEMPORARY GRASSING	⊕
DISTURBED AREA STABILIZATION - PERMANENT GRASSING	⊕
MATTING/BLANKETS	⊕

REVISIONS DATE


CITY OF LITTLE ROCK, ARKANSAS  
MORRISON COURT DRAINAGE  
GENERAL NOTES, LEGEND, AND QUANTITIES



DEPARTMENT OF PUBLIC WORKS  
CIVIL ENGINEERING  
701 W. MARKHAM  
LITTLE ROCK, ARKANSAS 72201

STATE OF ARKANSAS  
LICENSED PROFESSIONAL ENGINEER  
No. 18018  
JUSTIN D. CARMY  
DIGITALLY SIGNED 01-24-2025

DRAWN BY  
DESIGNED  
VSE  
CHECKED  
JPC  
DATE  
1/20/2025  
SCALE  
NTS  
PROJECT NO.  
05-17-DR-208A  
SHEET NO.  
C2

LEGEND:

- EXISTING STORM SEWER
- STORM SEWER DEMO

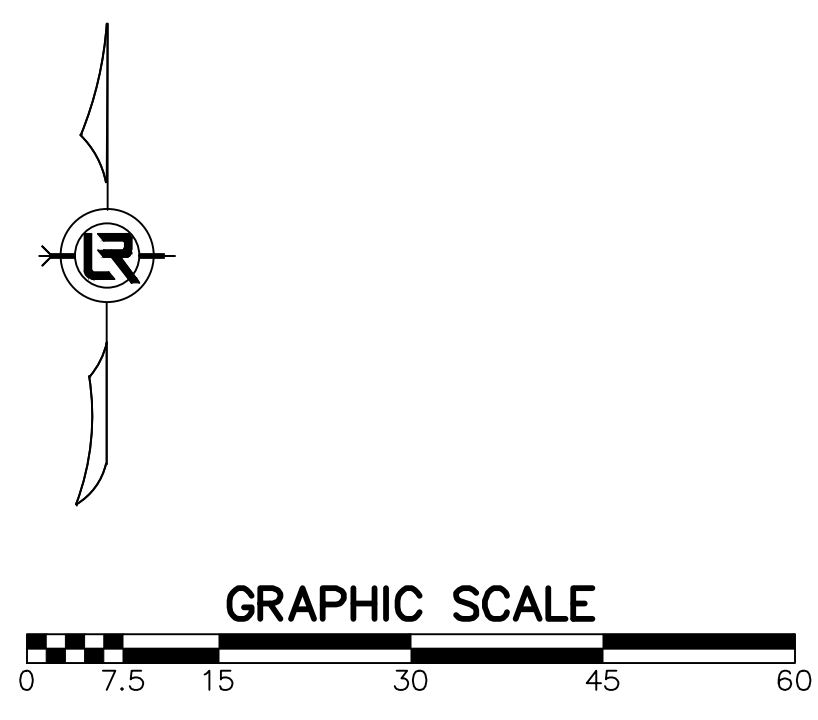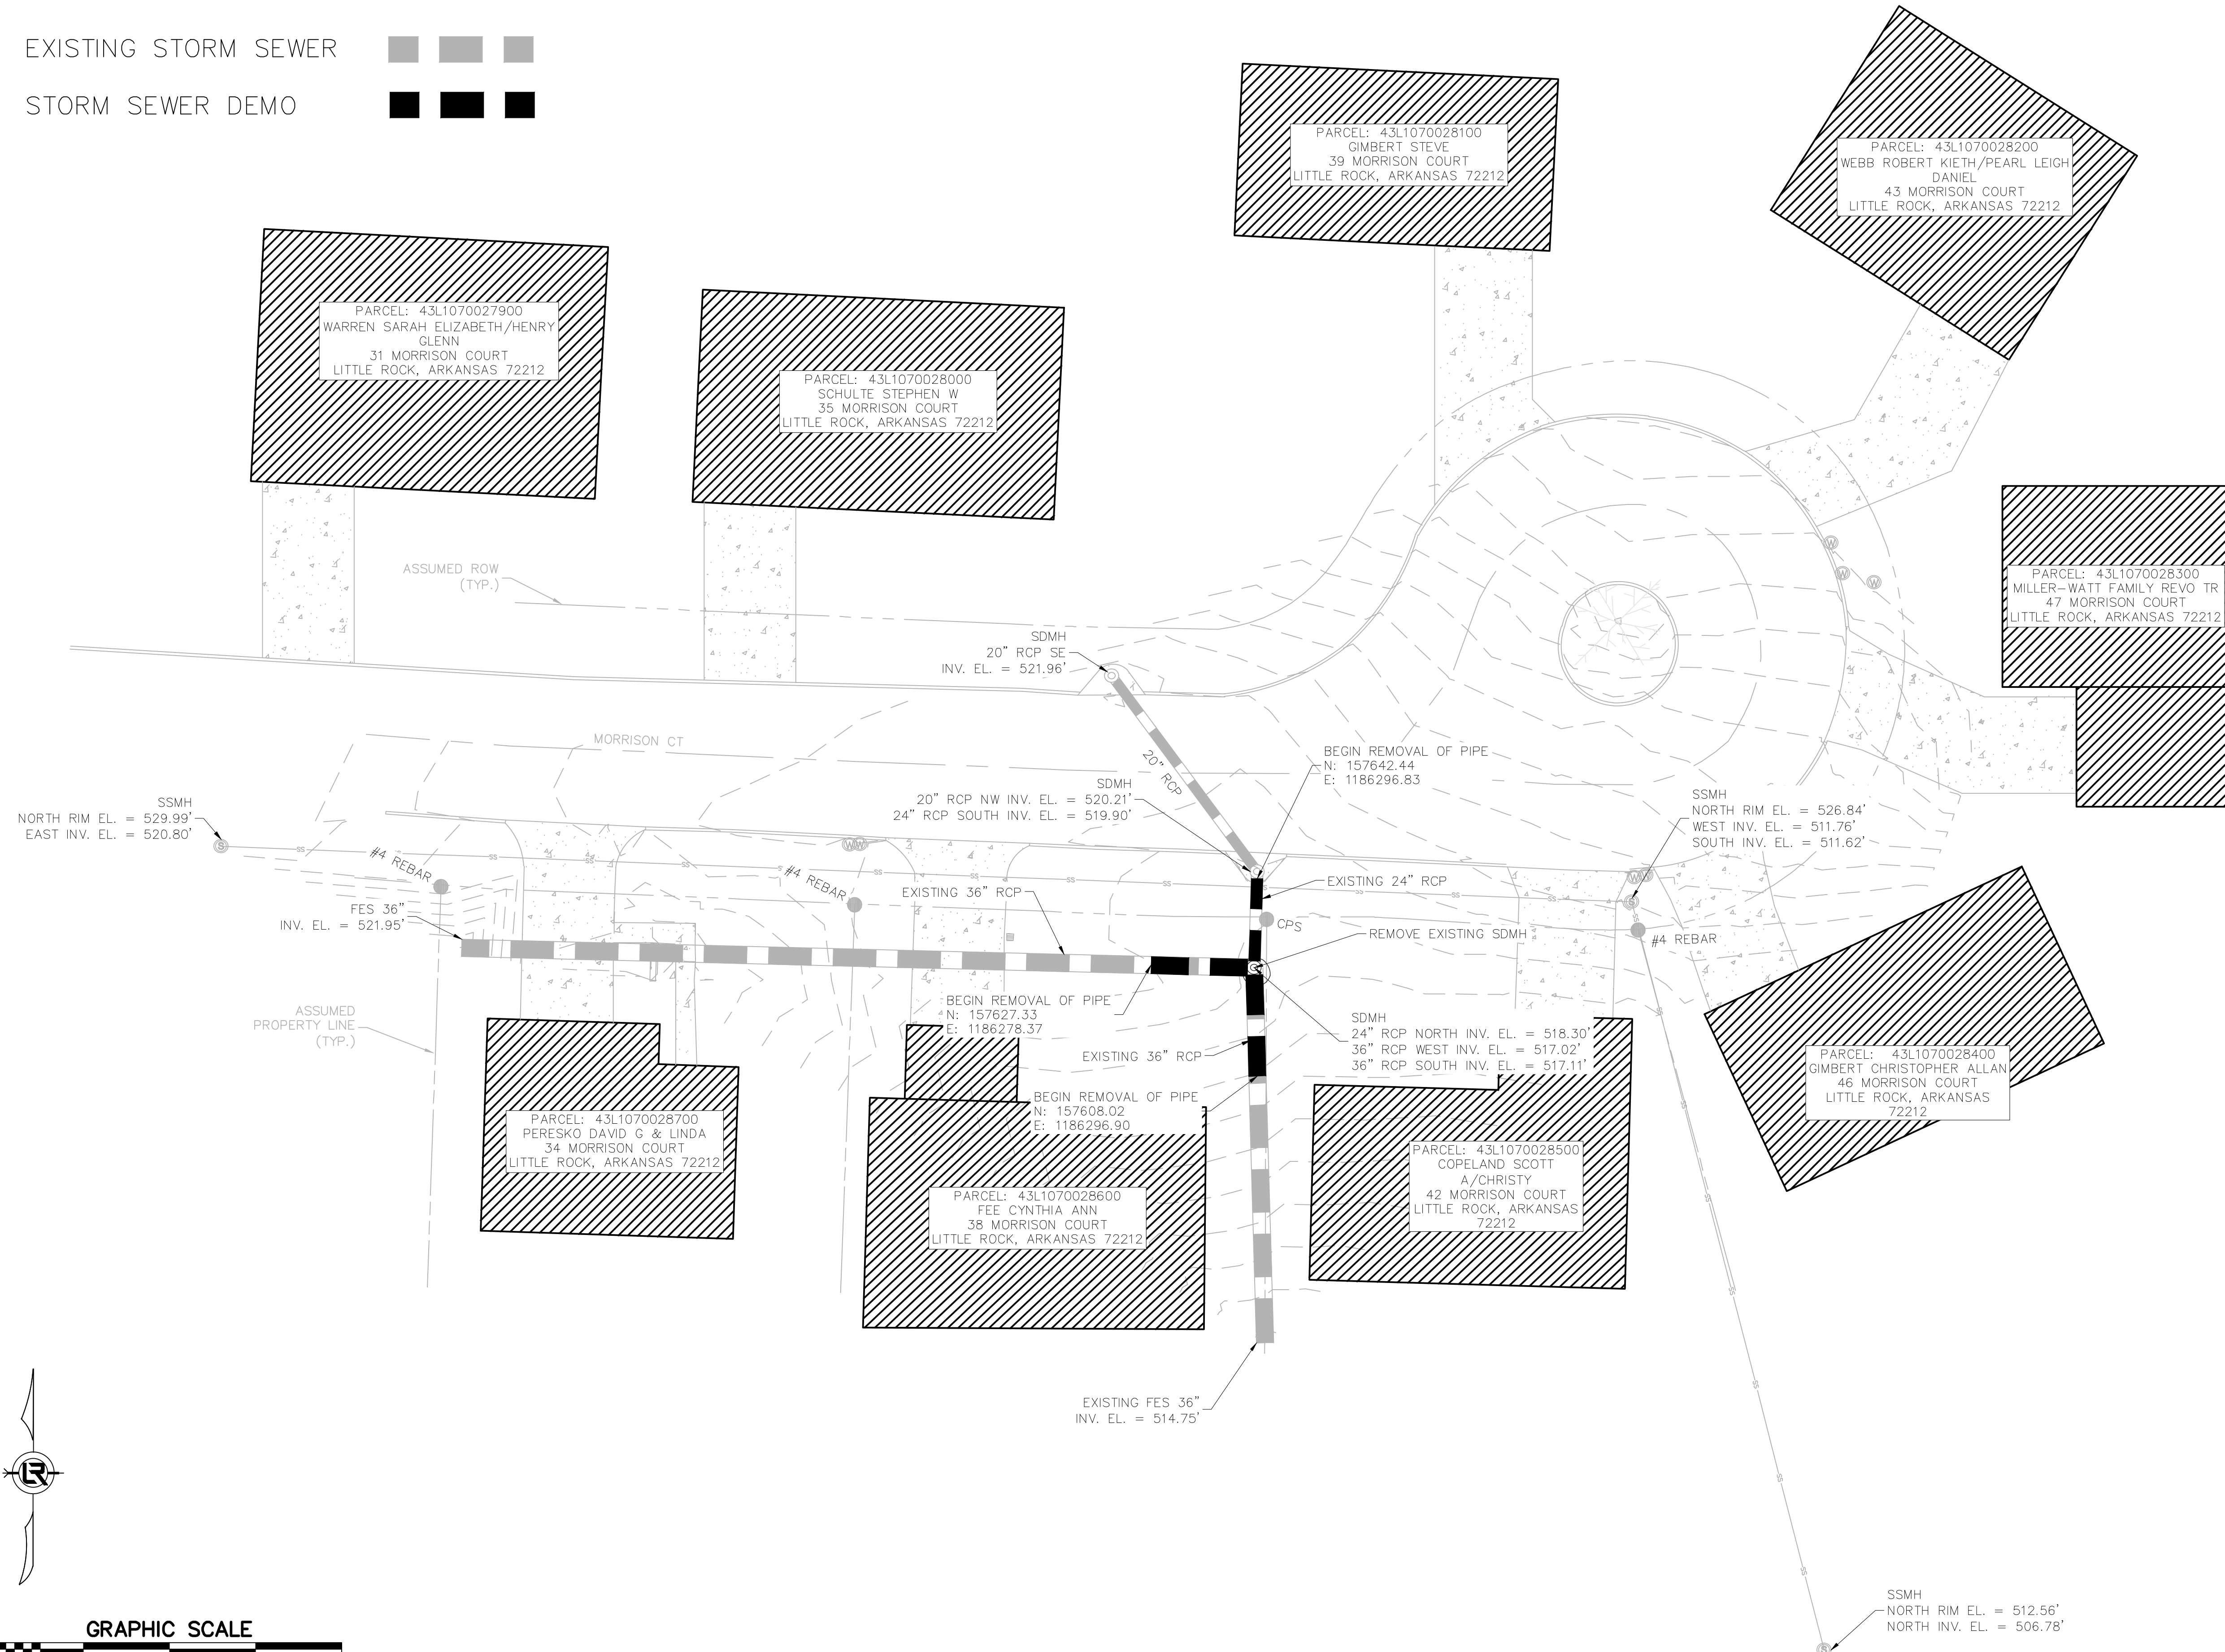

REVISIONS	DATE


CITY OF LITTLE ROCK, ARKANSAS  
MORRISON COURT DRAINAGE  
EXISTING LAYOUT/DEMOLITION

DEPARTMENT OF PUBLIC WORKS  
 CIVIL ENGINEERING  
 701 W. MARKHAM  
 LITTLE ROCK, ARKANSAS 72201

STATE OF ARKANSAS  
 LICENSED PROFESSIONAL ENGINEER  
 No. 18018  
 JUSTIN P. CARNEY  
DIGITALLY SIGNED 01-24-2025



DRAWN BY  
 VSE  
 DESIGNED  
 VSE  
 CHECKED  
 JPC  
 DATE  
 1/20/2025  
 SCALE  
 1" = 15'  
 PROJECT NO.  
 05-17-DR-208A  
 SHEET NO.  
 C3



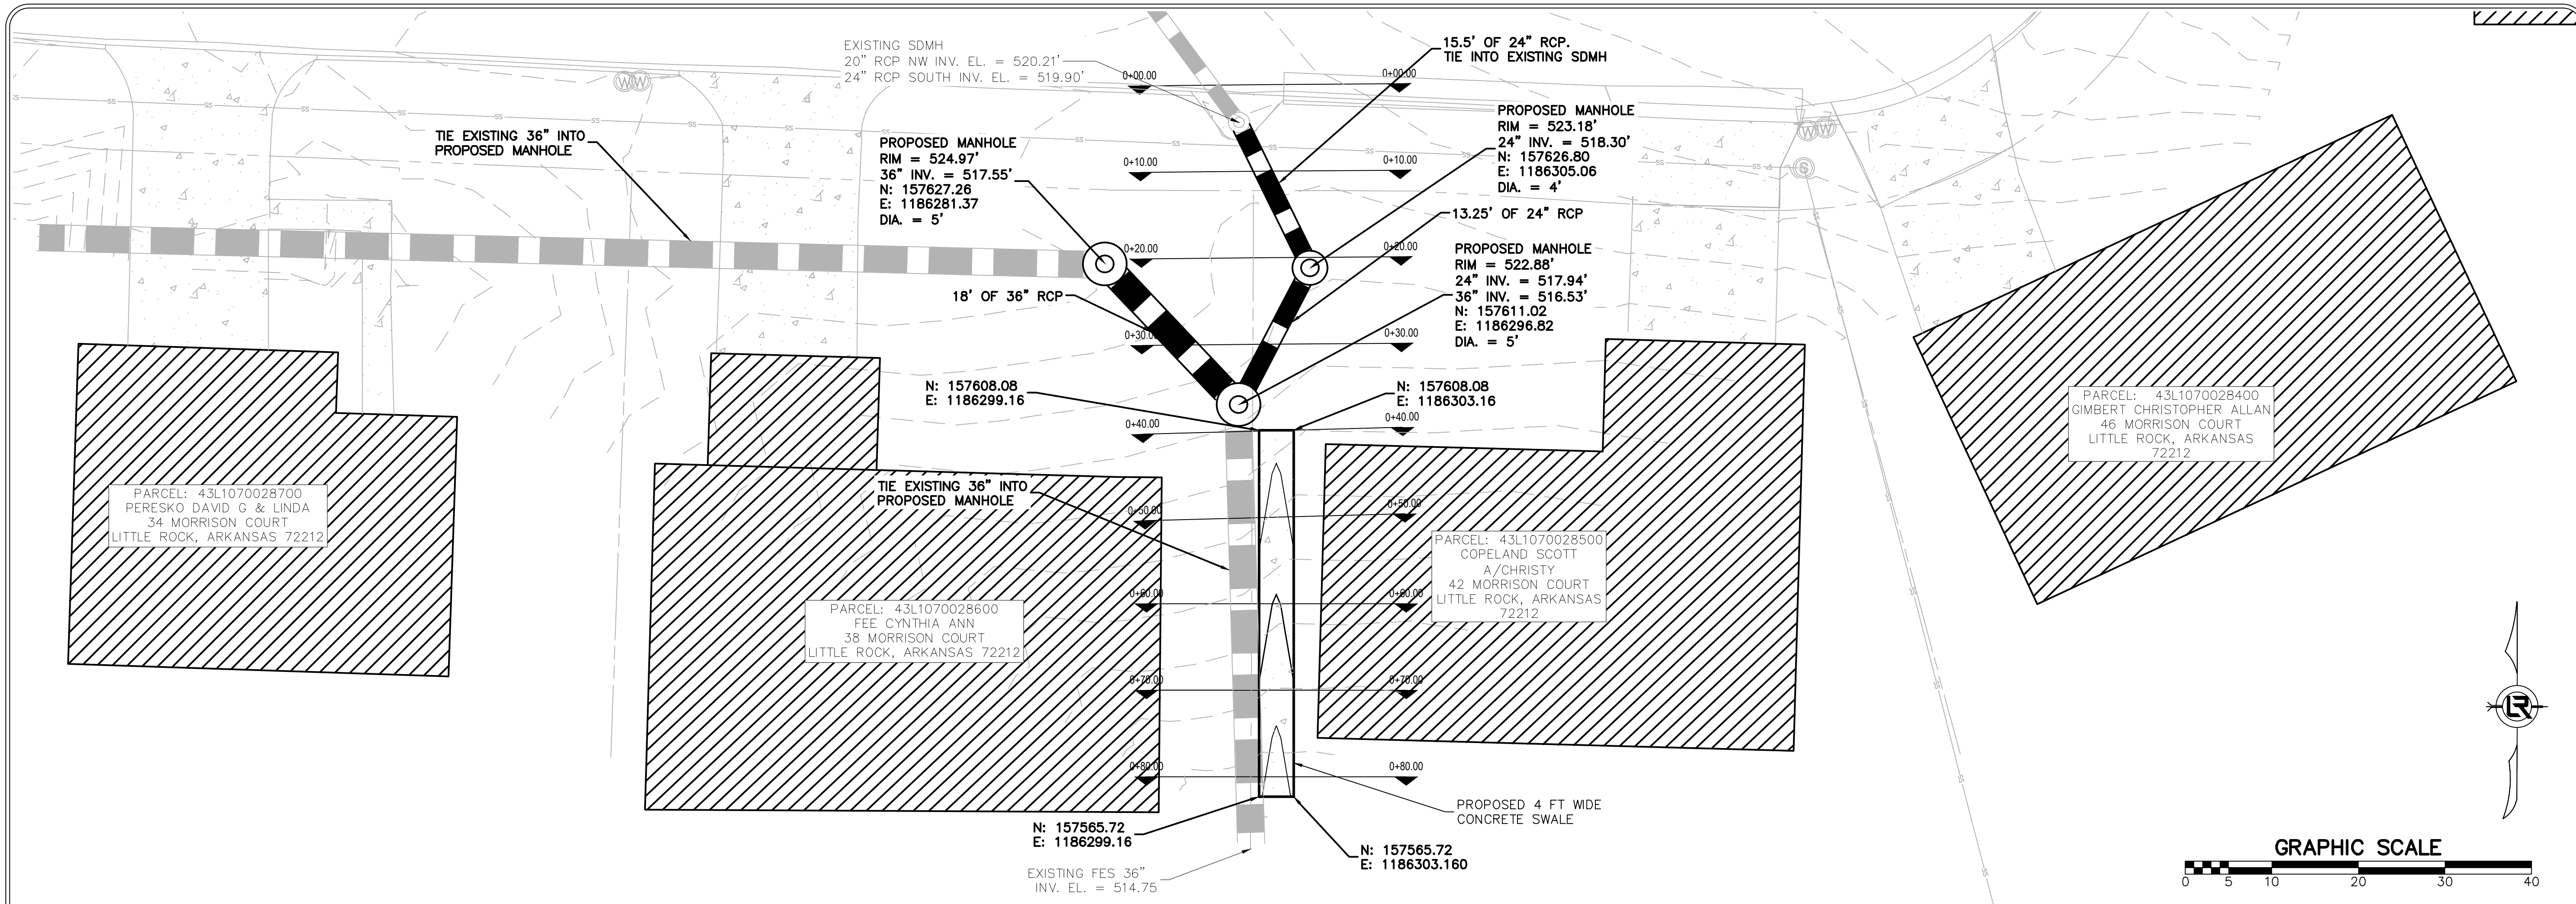


REVISIONS	DATE

**CITY OF LITTLE ROCK, ARKANSAS**  
**MORRISON COURT DRAINAGE**  
**PLAN & PROFILE**

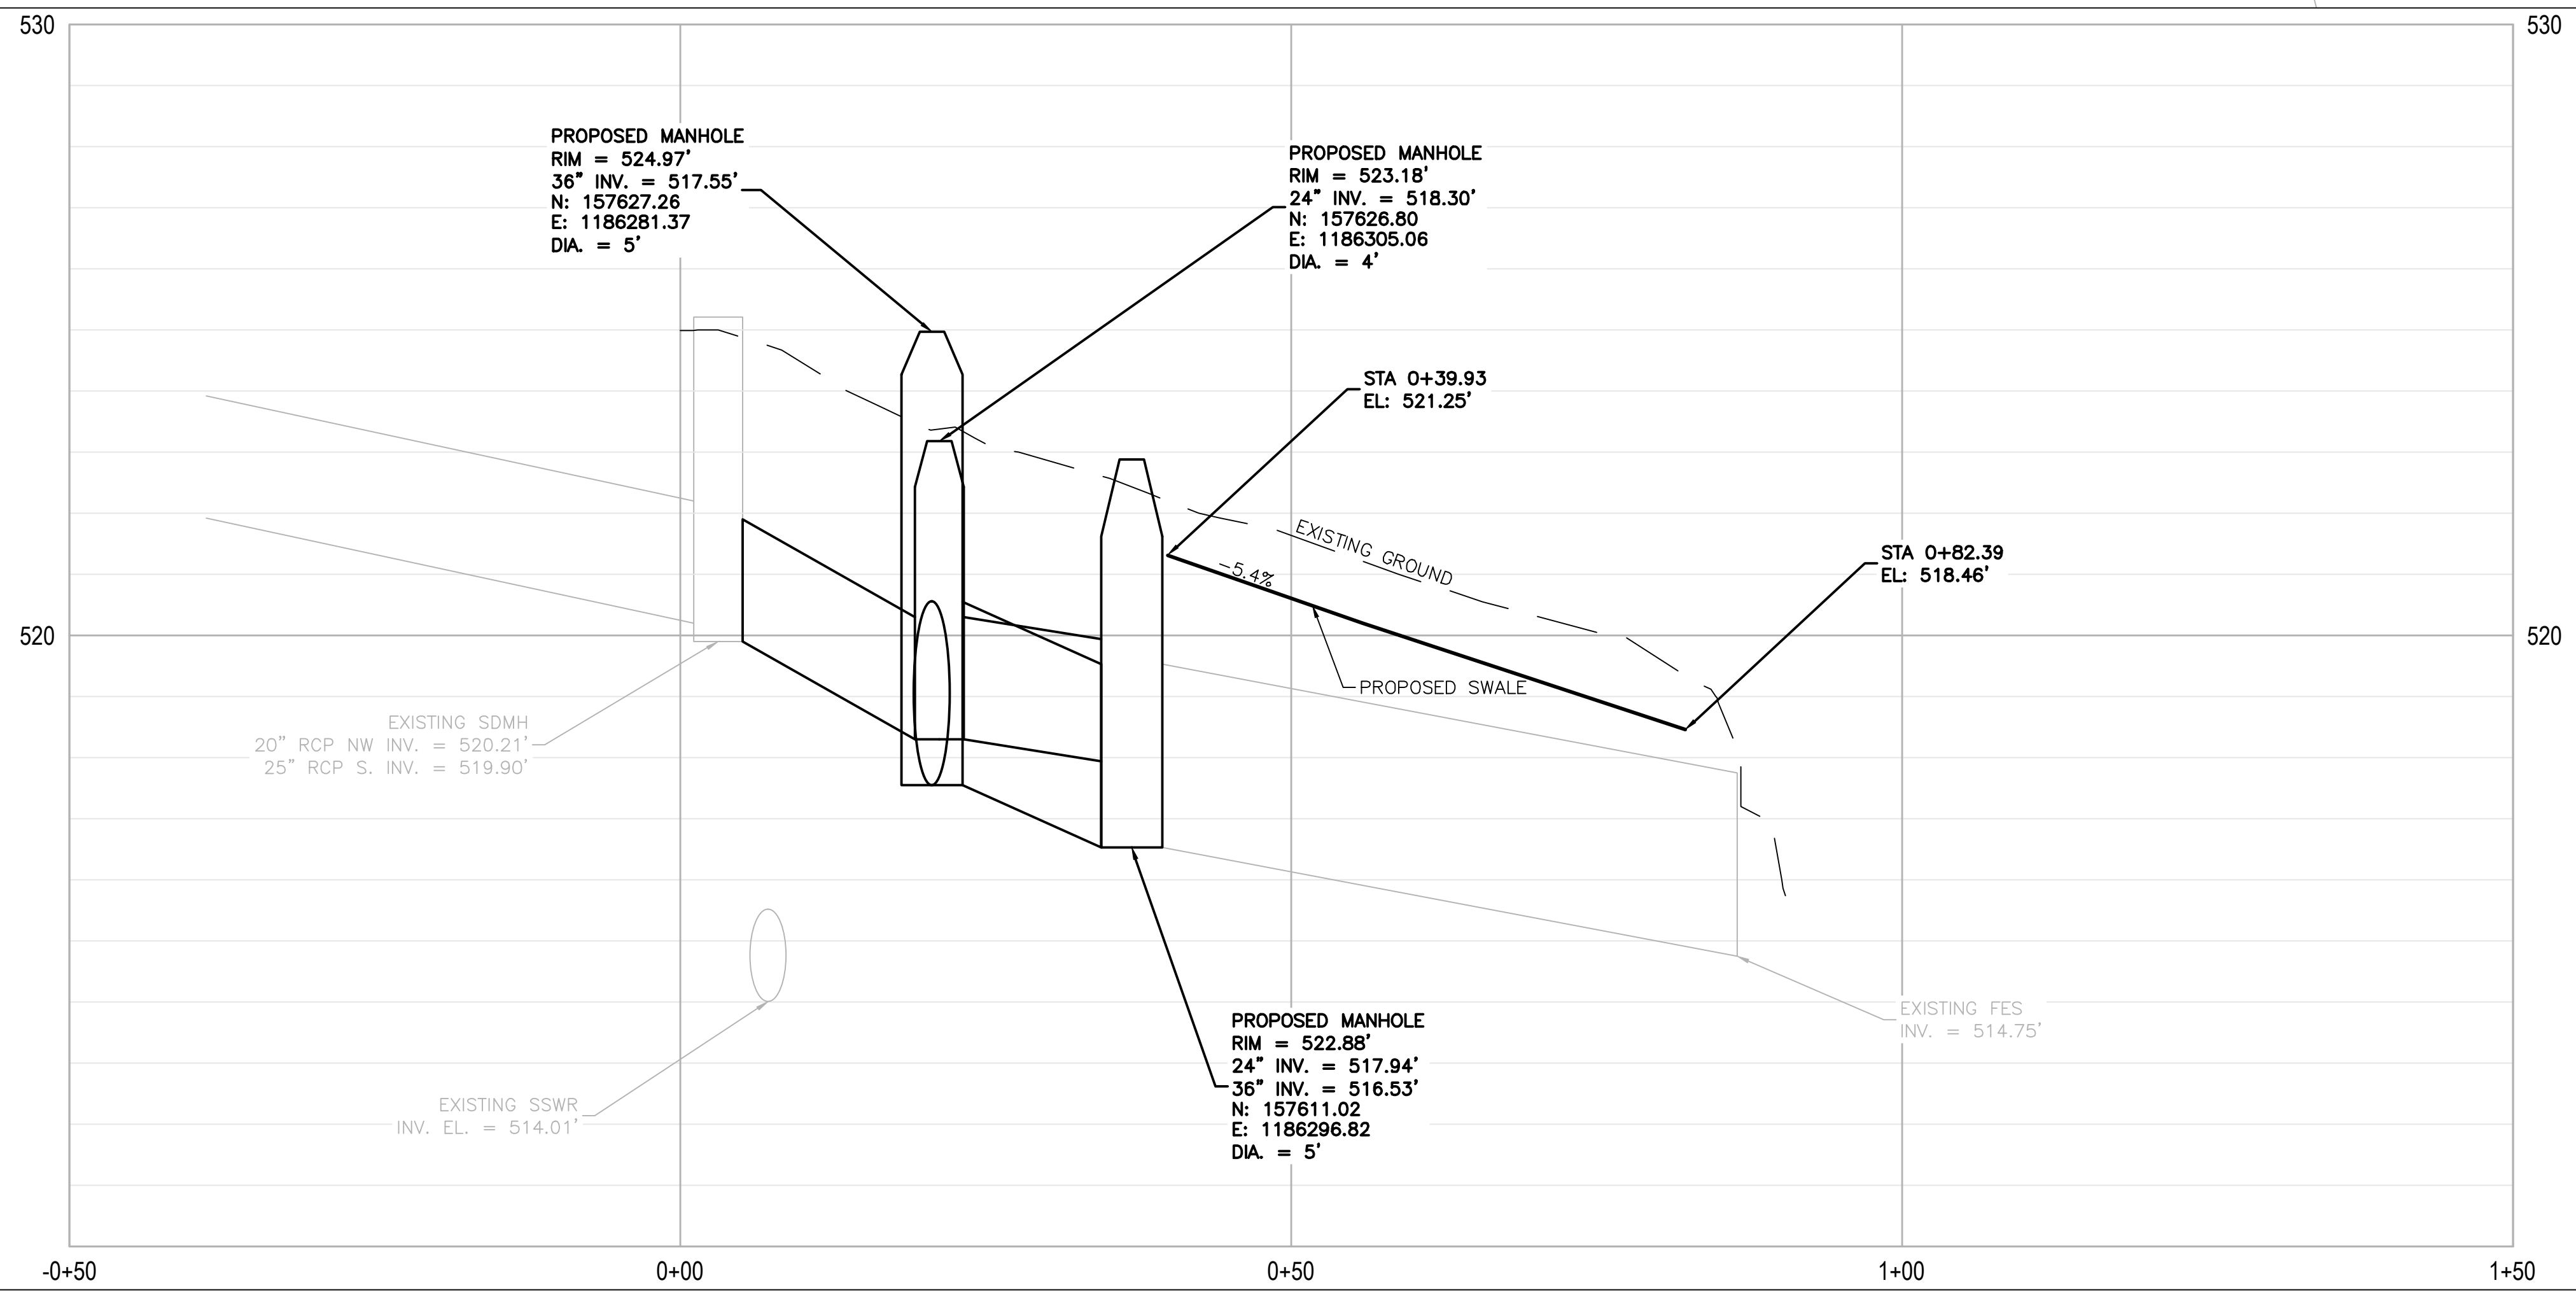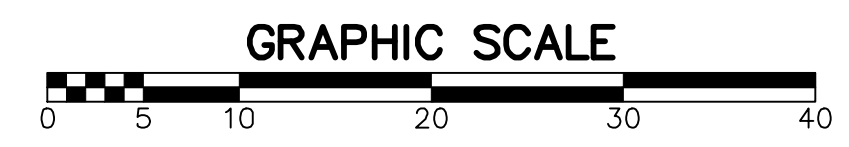




  
**DEPARTMENT OF PUBLIC WORKS**  
**CIVIL ENGINEERING**  
 701 W. MARKHAM  
 LITTLE ROCK, ARKANSAS 72201

  
 JUSTIN P. CARNEY  
 No. 18018  
DIGITALLY SIGNED 01-24-2025


**DRAWN BY**  
 JAA  
**DESIGNED**  
 VSE  
**CHECKED**  
 JPC  
**DATE**  
 1/20/2025  
**SCALE**  
 1" = 10'  
**PROJECT NO.**  
 05-17-DR-208A  
**SHEET NO.**  
 C5

REVISIONS	DATE

**CITY OF LITTLE ROCK, ARKANSAS**  
**MORRISON COURT DRAINAGE**  
**CROSS SECTIONS**

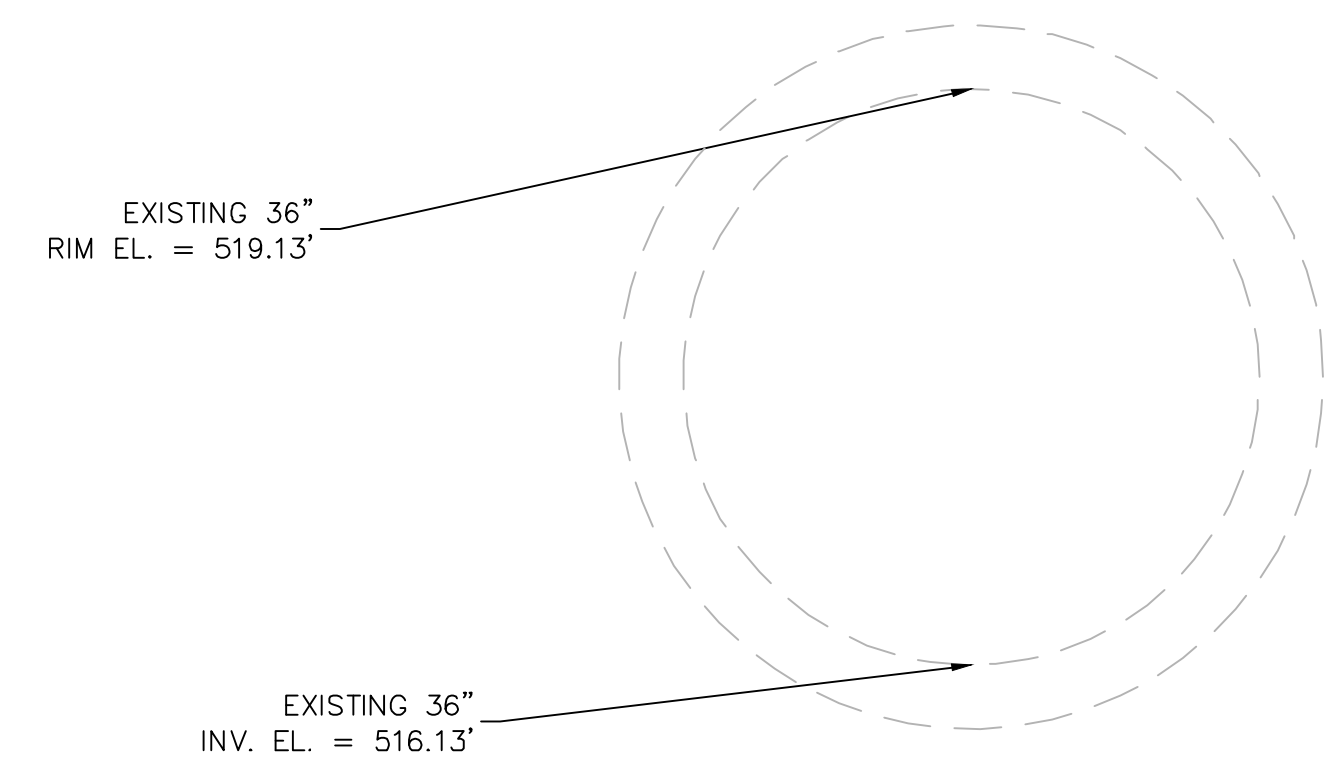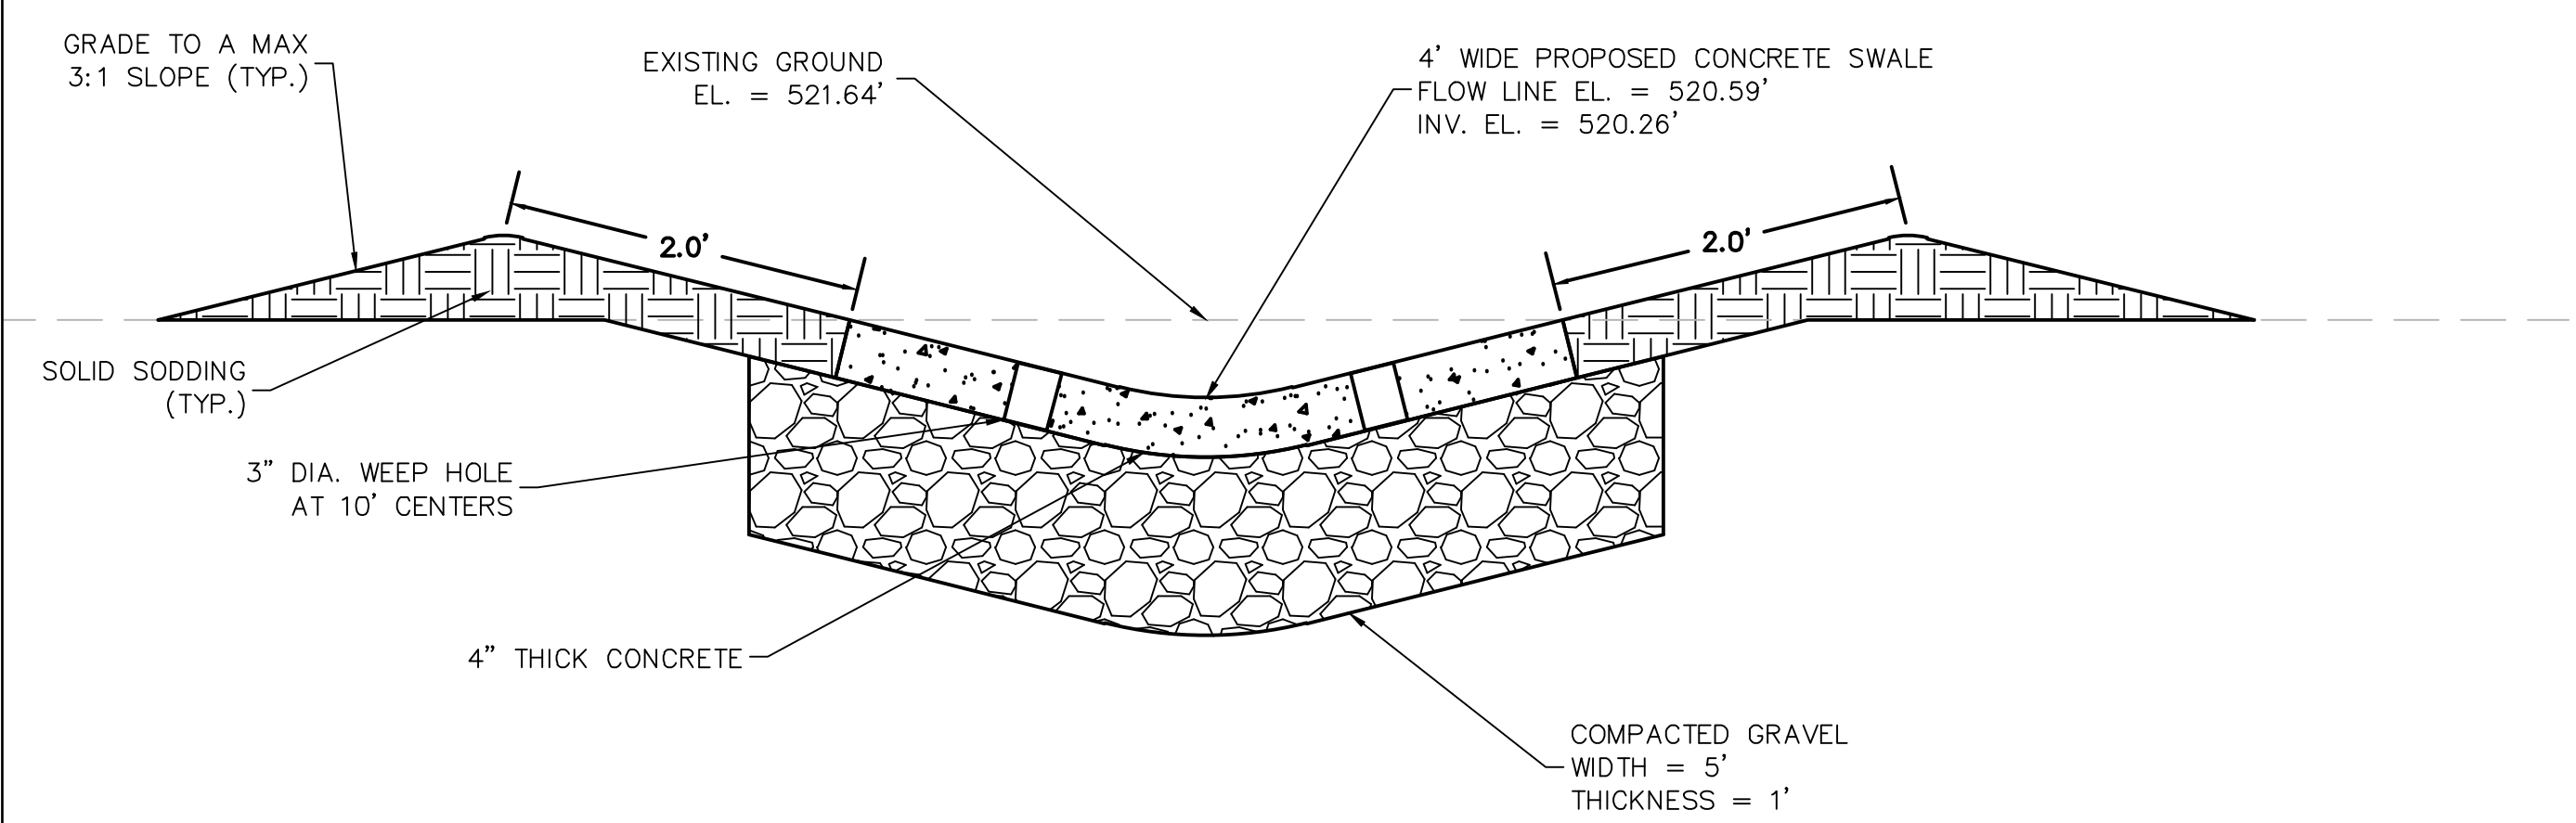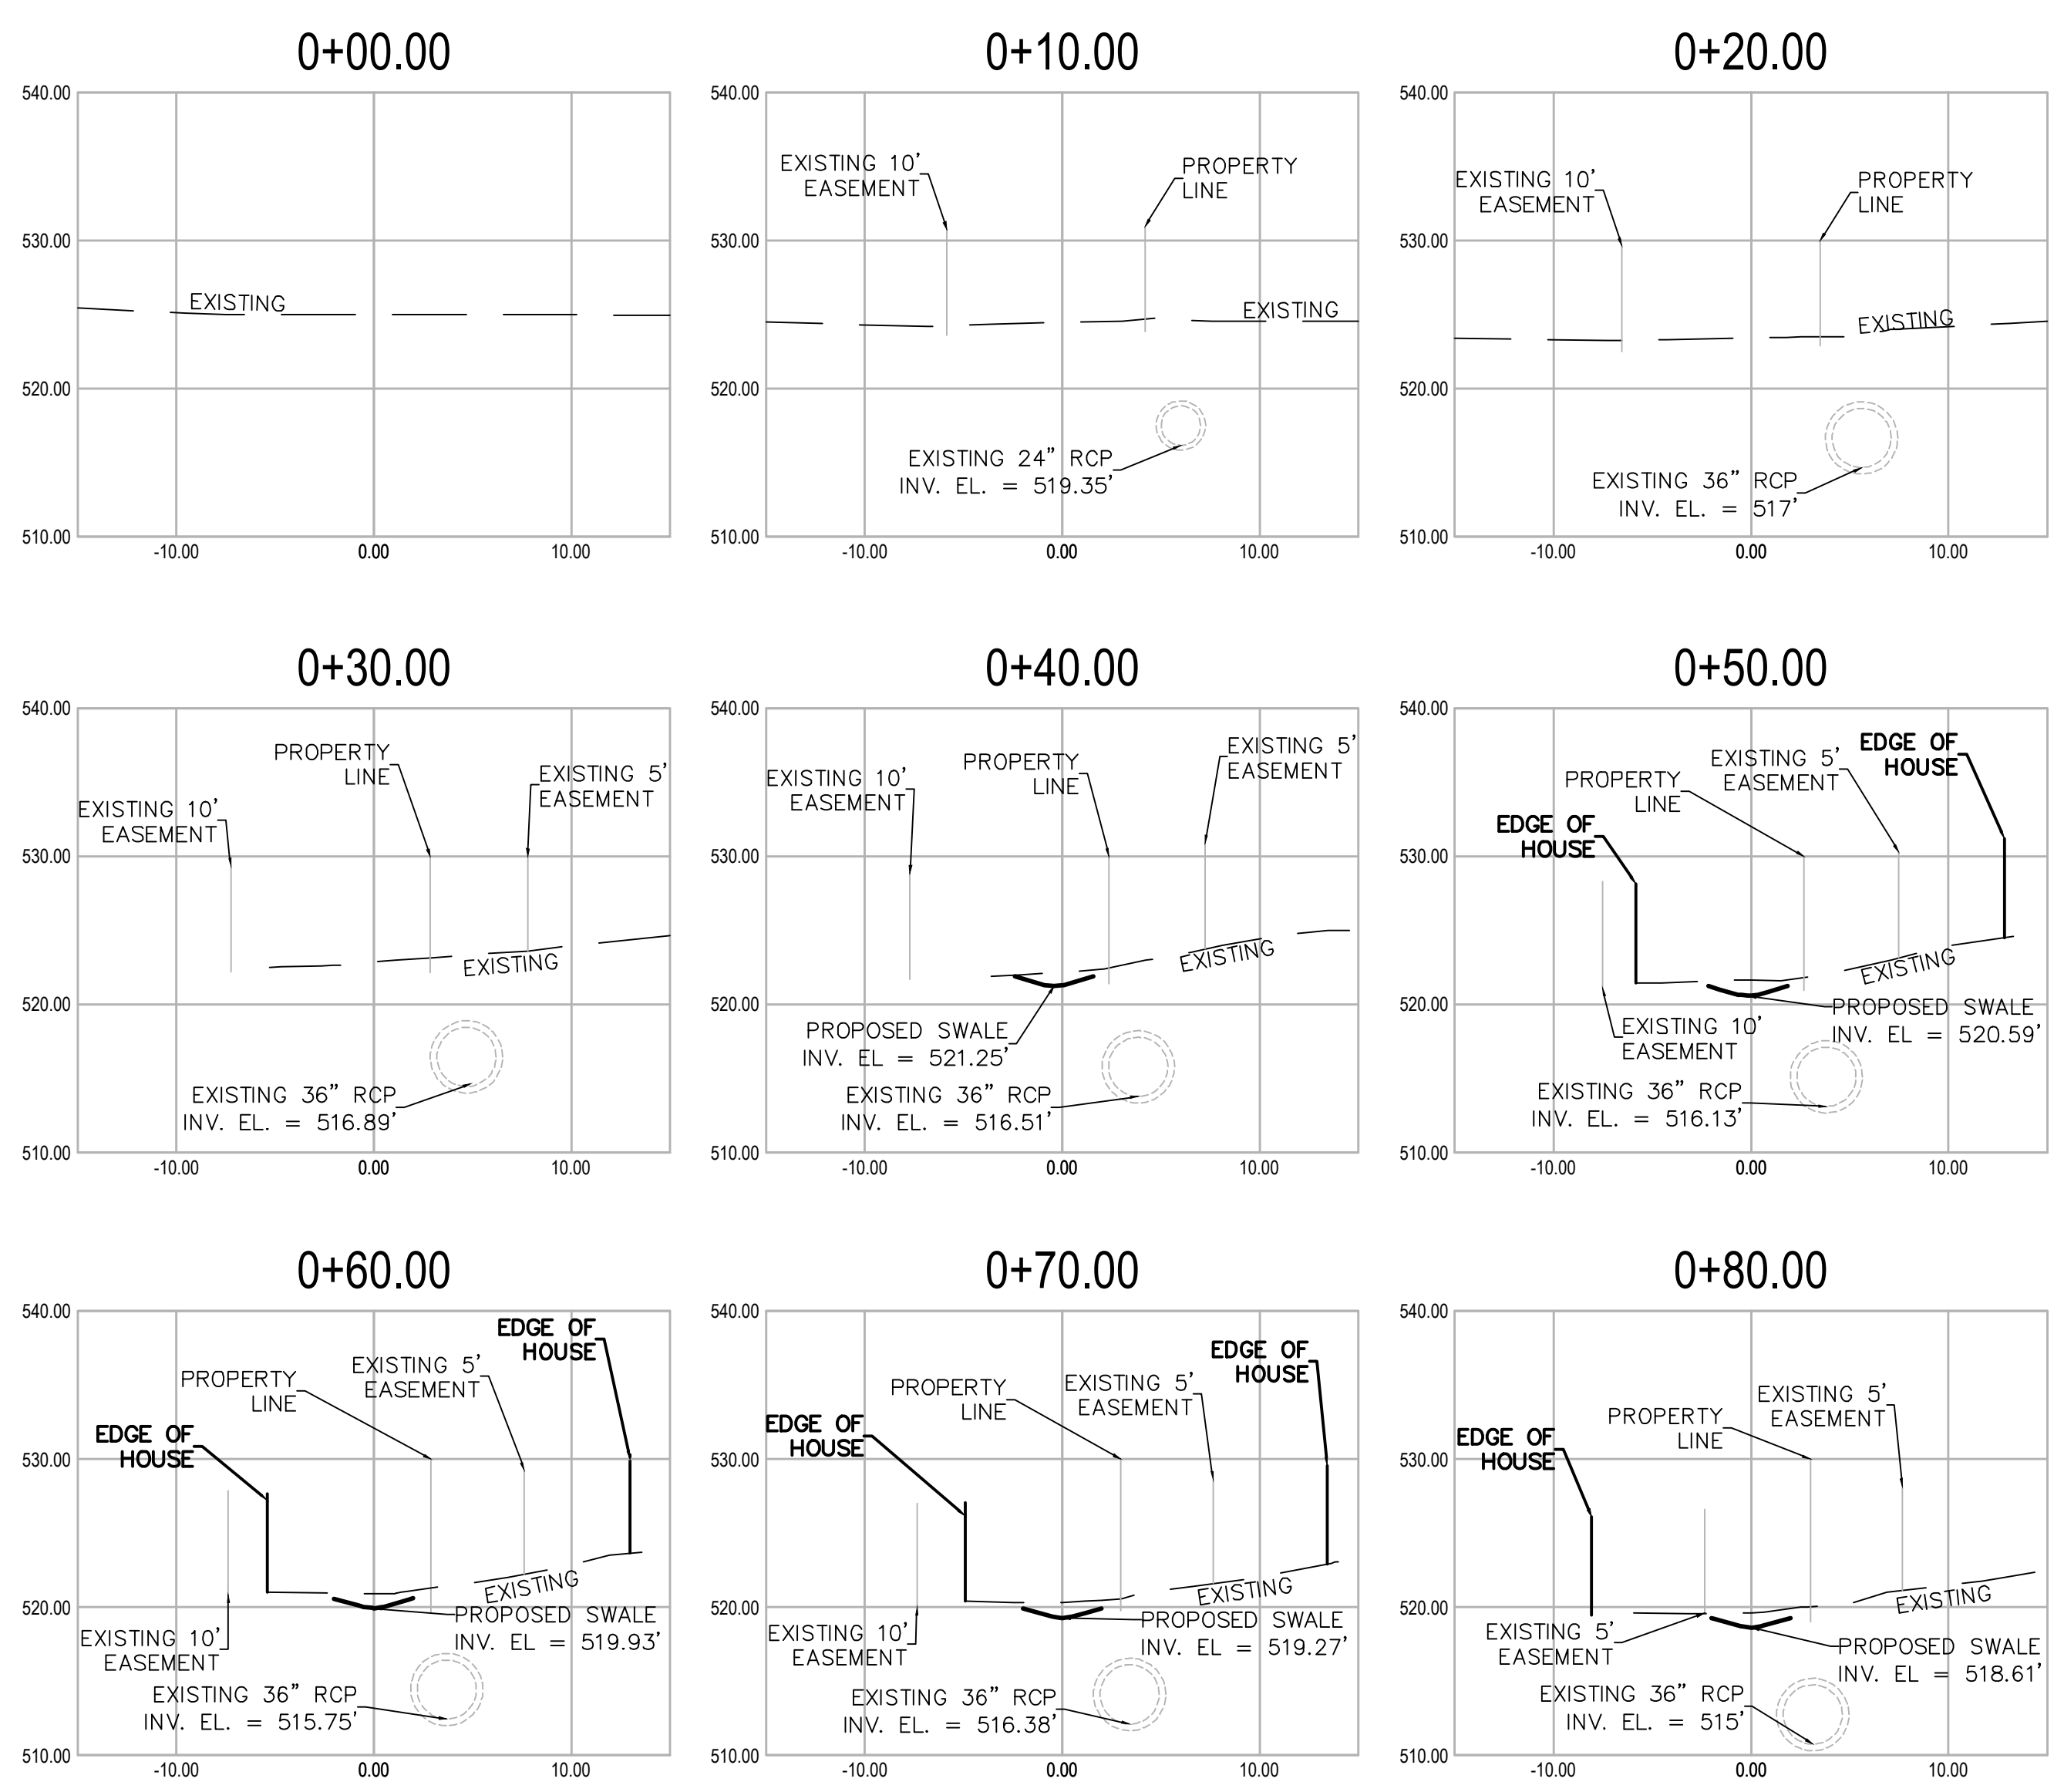


SECTION VIEW  
STATION 0+50.00

  
 DEPARTMENT OF PUBLIC WORKS  
 CIVIL ENGINEERING  
 701 W. MARKHAM  
 LITTLE ROCK, ARKANSAS 72201


  
DIGITALLY SIGNED 01-24-2025


**DRAWN BY**  
 JAA  
**DESIGNED**  
 VSE  
**CHECKED**  
 JPC  
**DATE**  
 1/20/2025  
**SCALE**  
 NTS  
**PROJECT NO.**  
 05-17-DR-208A  
**SHEET NO.**  
 C6

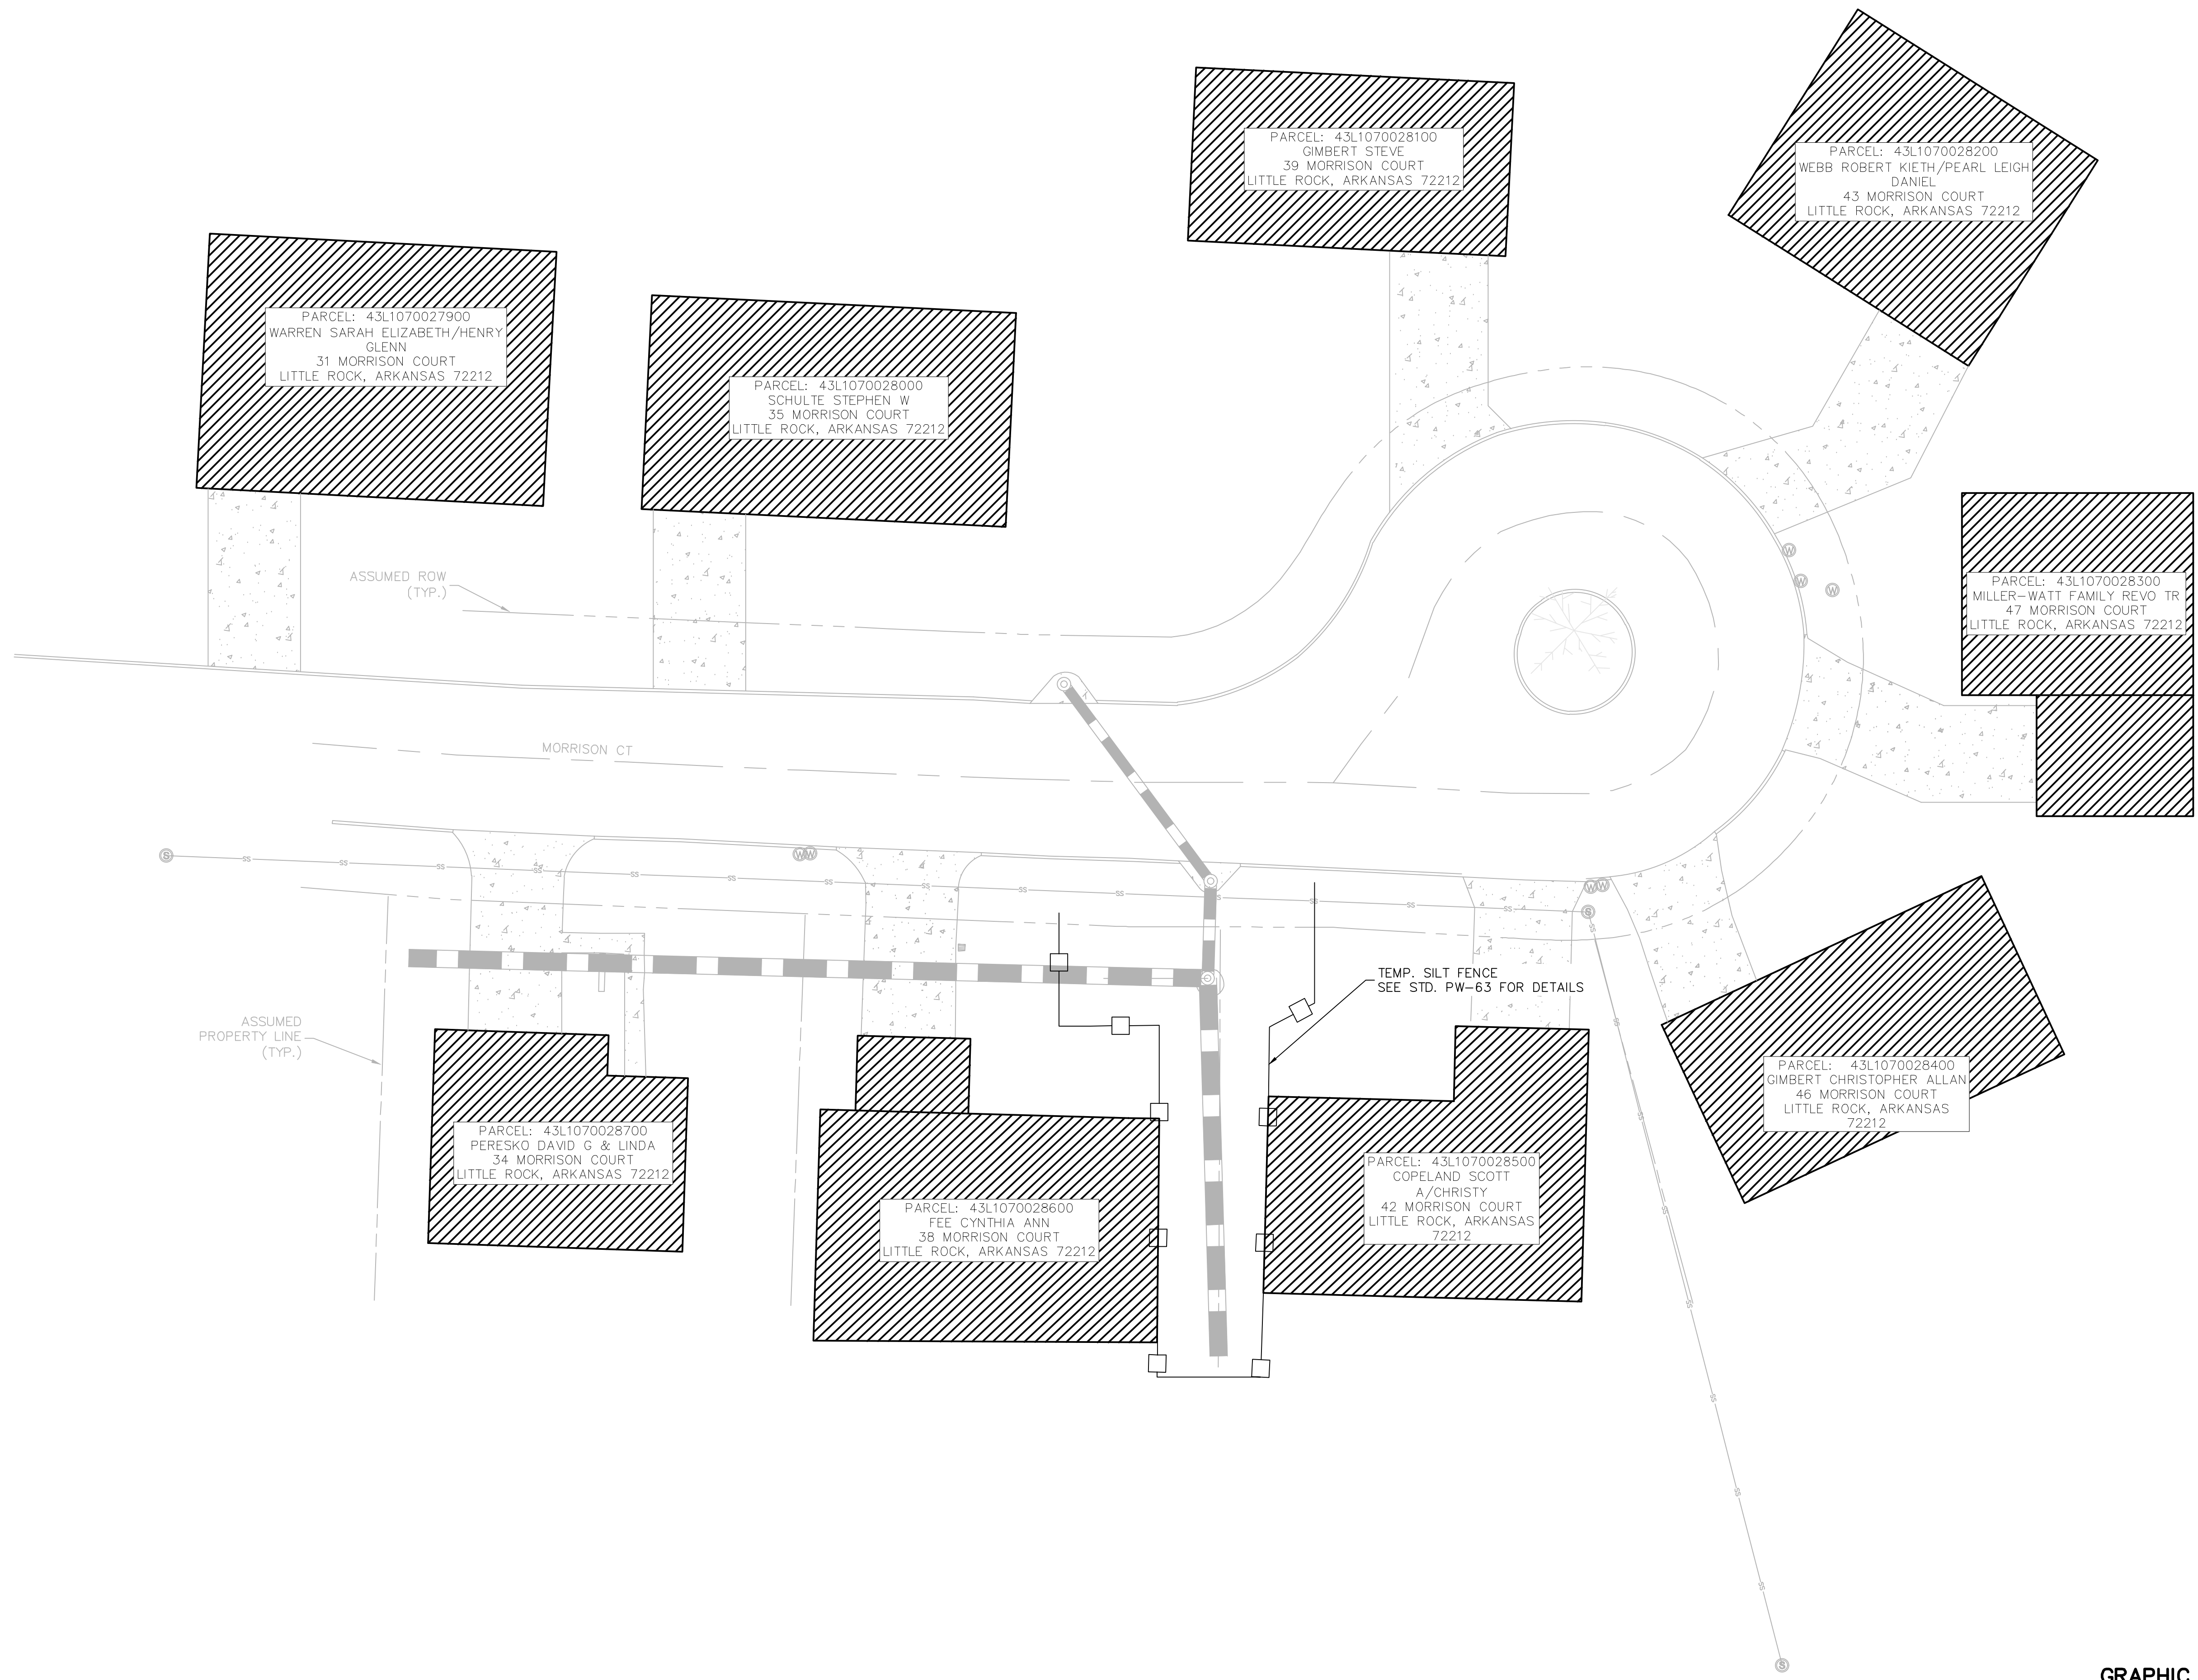

REVISIONS	DATE


**CITY OF LITTLE ROCK, ARKANSAS**  
**MORRISON COURT DRAINAGE**  
**EROSION CONTROL PHASE 1**

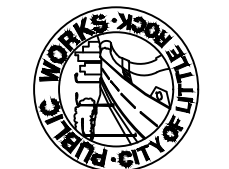
  
 DEPARTMENT OF PUBLIC WORKS  
 CIVIL ENGINEERING  
 701 W. MARKHAM  
 LITTLE ROCK, ARKANSAS 72201



  
DIGITALLY SIGNED 01-24-2025


**DRAWN BY**  
 JAA  
**DESIGNED**  
 VSE  
**CHECKED**  
 JPC  
**DATE**  
 1/20/2025  
**SCALE**  
 1" = 15'  
**PROJECT NO.**  
 05-17-DR-208A  
**SHEET NO.**  
 C7

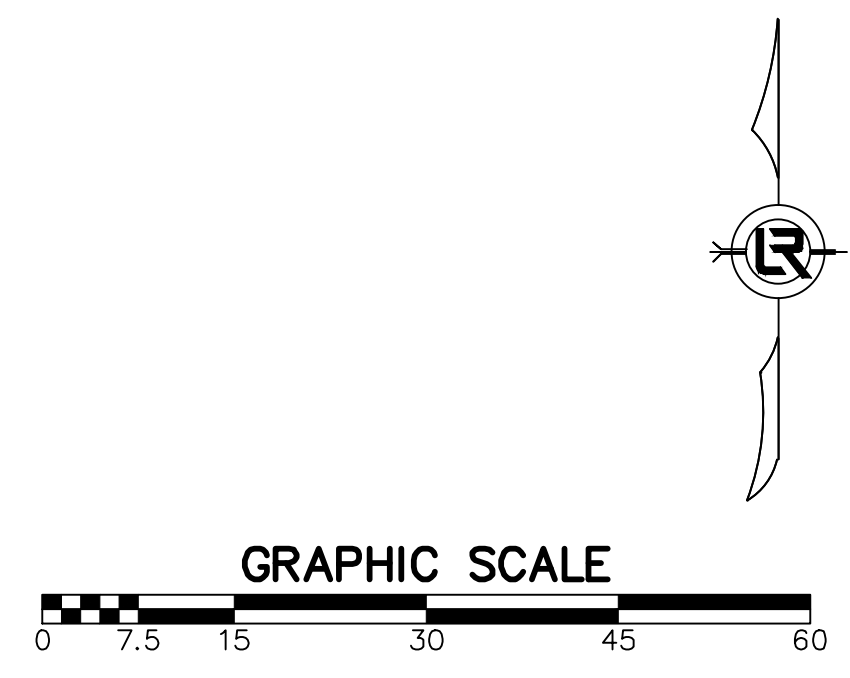

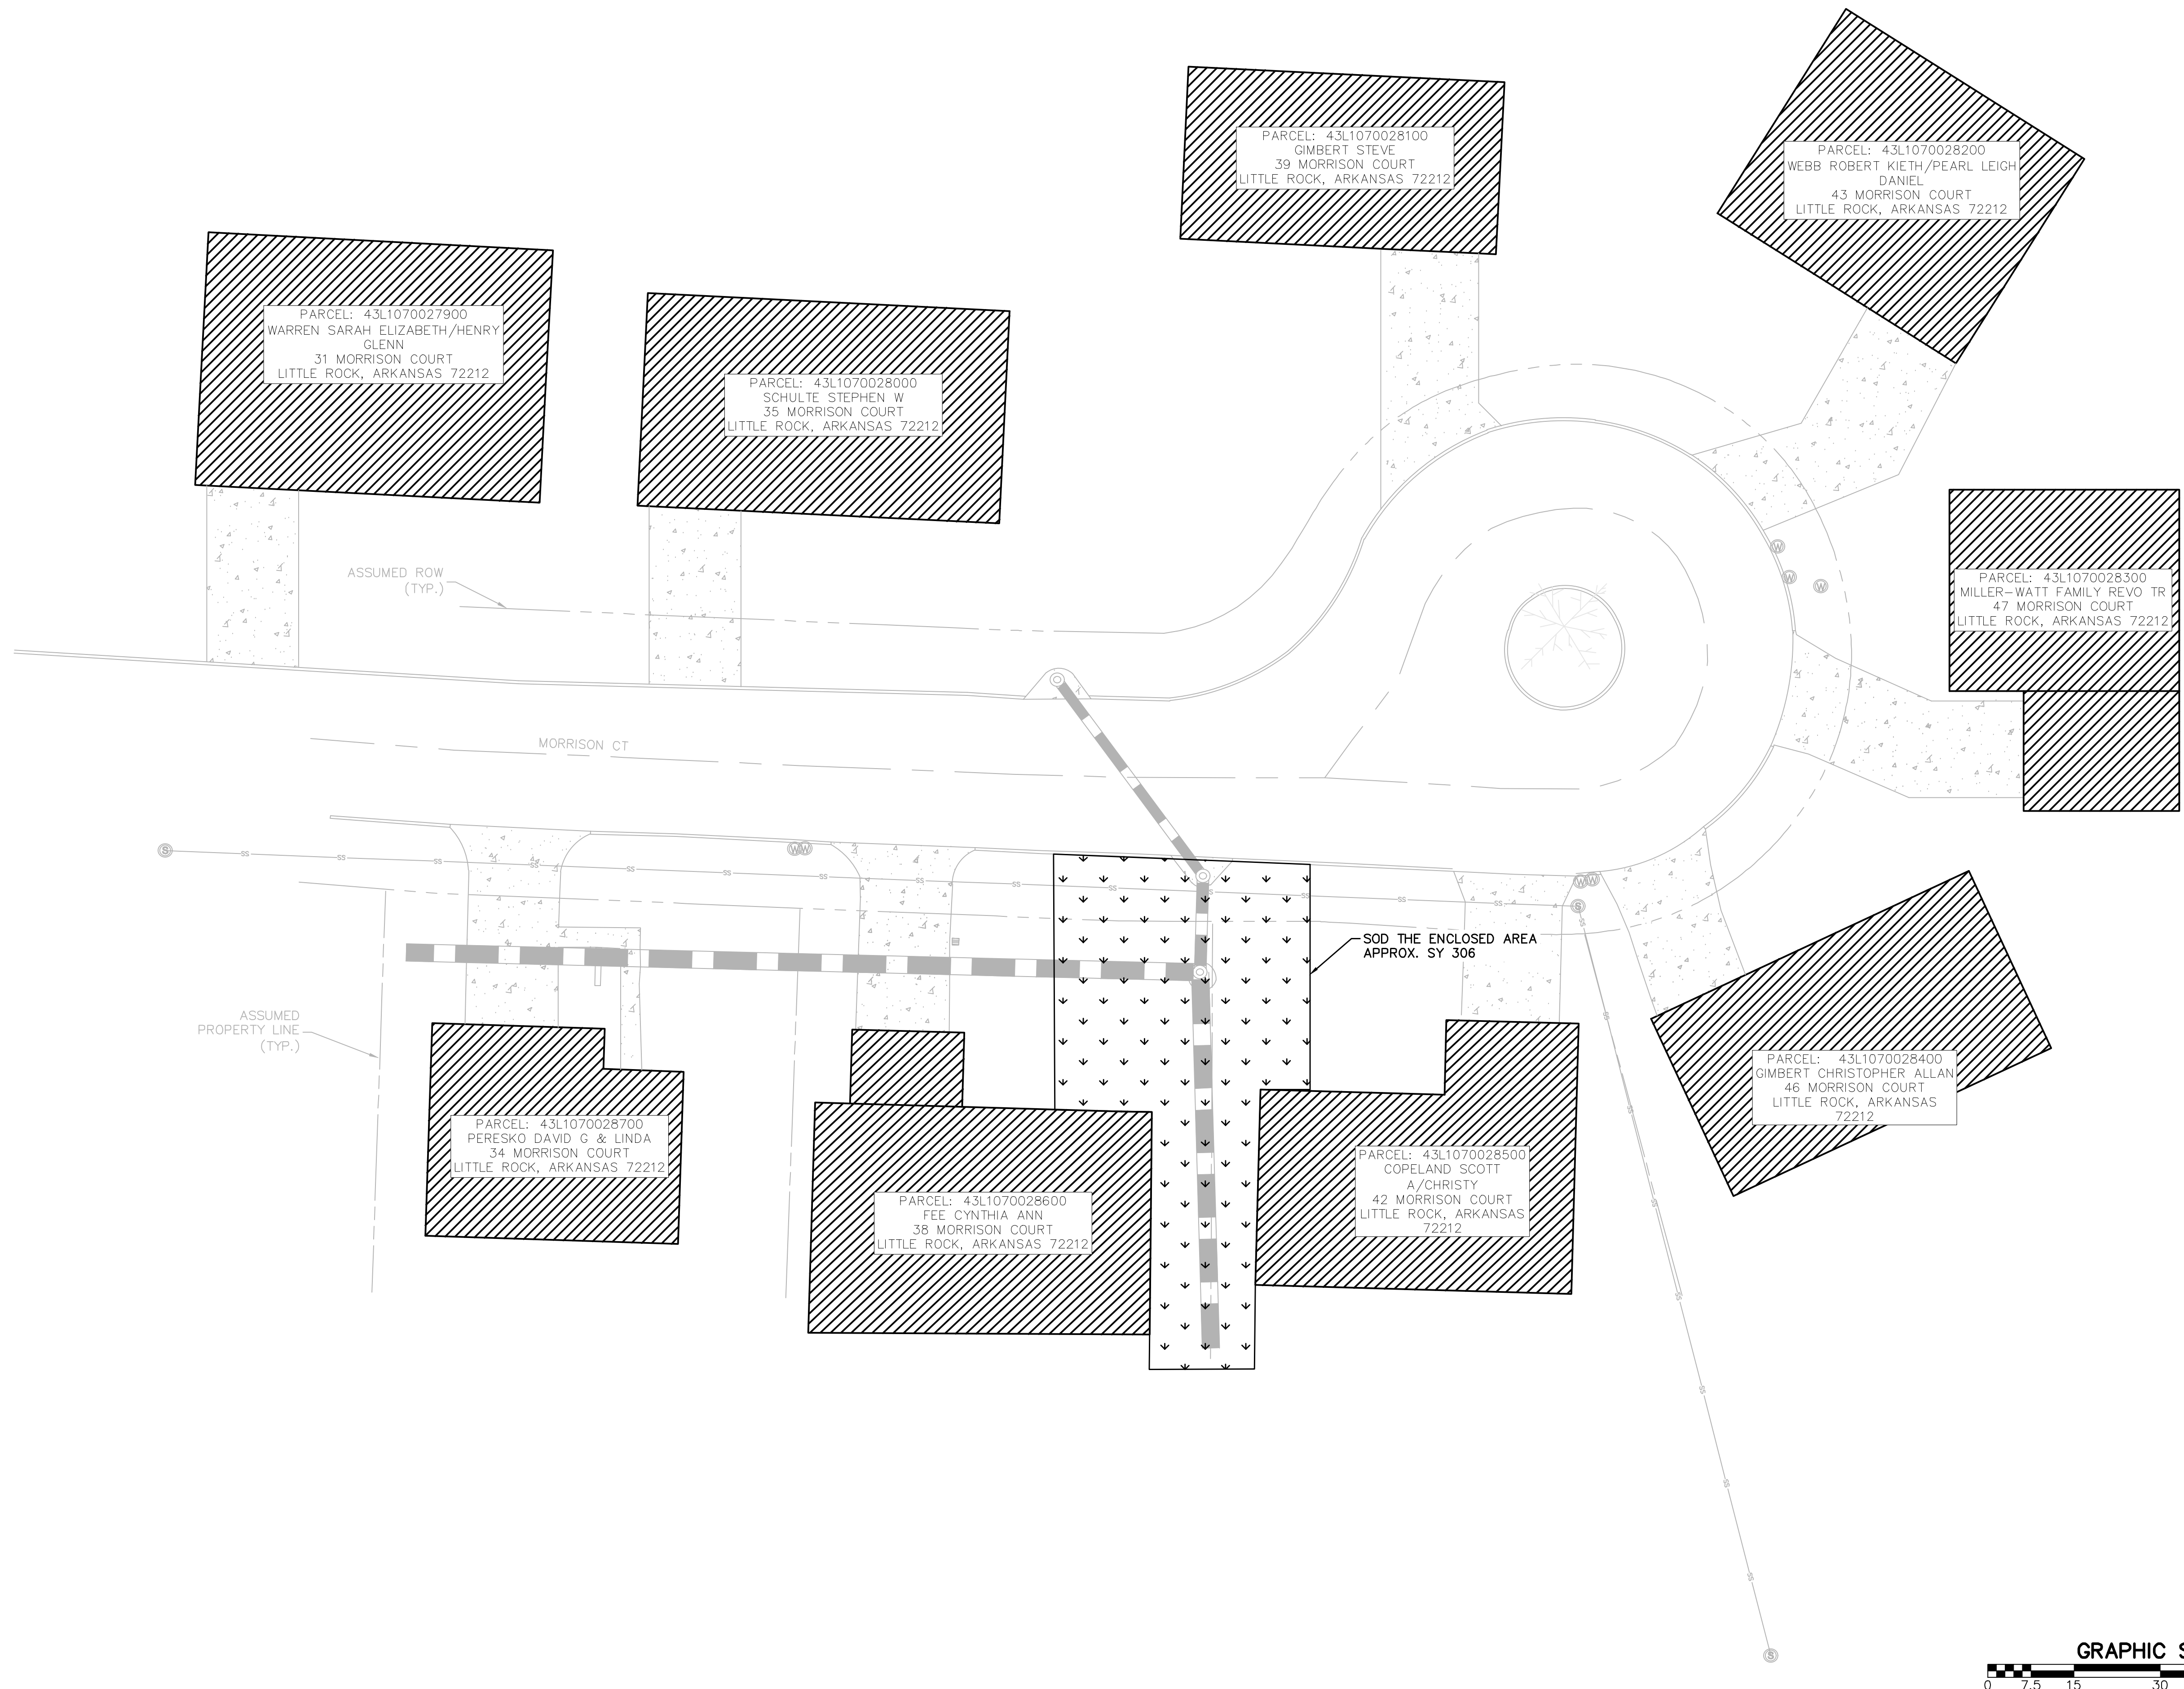

REVISIONS	DATE

**CITY OF LITTLE ROCK, ARKANSAS**  
**MORRISON COURT DRAINAGE**  
**EROSION CONTROL PHASE 2**

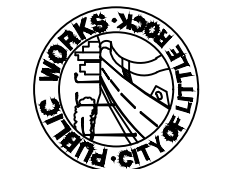  
 DEPARTMENT OF PUBLIC WORKS  
 CIVIL ENGINEERING  
 701 W. MARKHAM  
 LITTLE ROCK, ARKANSAS 72201

  
 DIGITALLY SIGNED 01-24-2025

**DRAWN BY**  
 JAA  
**DESIGNED**  
 VSE  
**CHECKED**  
 JPC  
**DATE**  
 1/20/2025  
**SCALE**  
 1" = 15'  
**PROJECT NO.**  
 05-17-DR-208A  
**SHEET NO.**  
 C8