


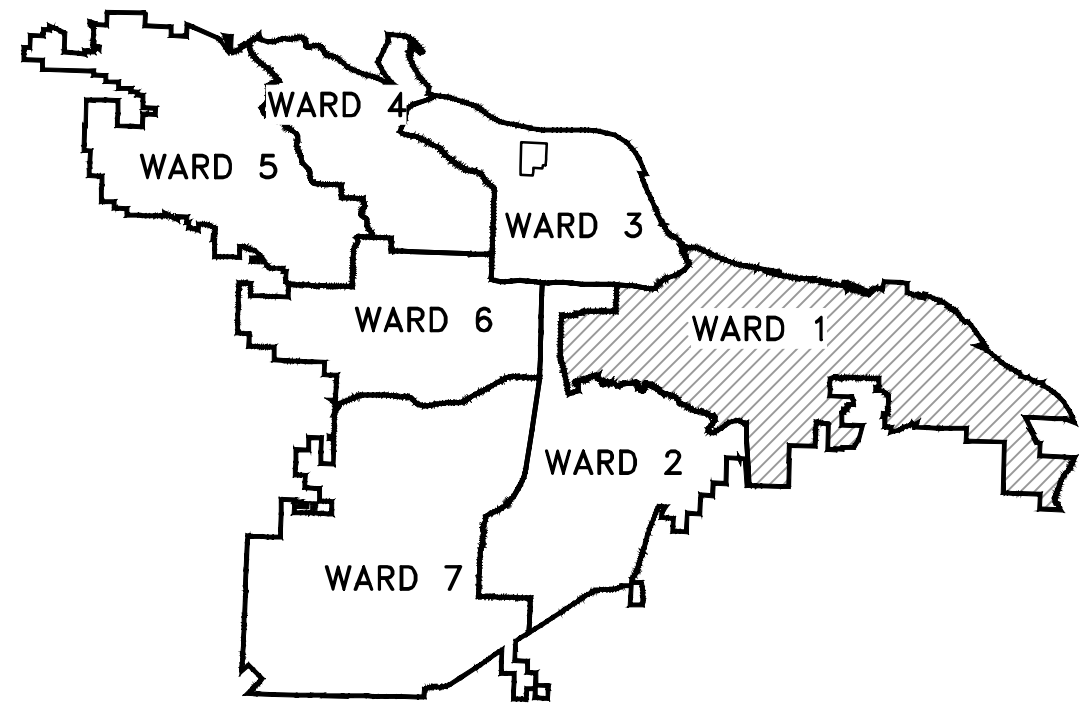


PROJECT LOCATION – WARD 1

ROSE CREEK TRAIL

(FROM 3RD ST. TO CANTRELL RD./
GILL STREET OVERPASS)

100% SUBMITTAL

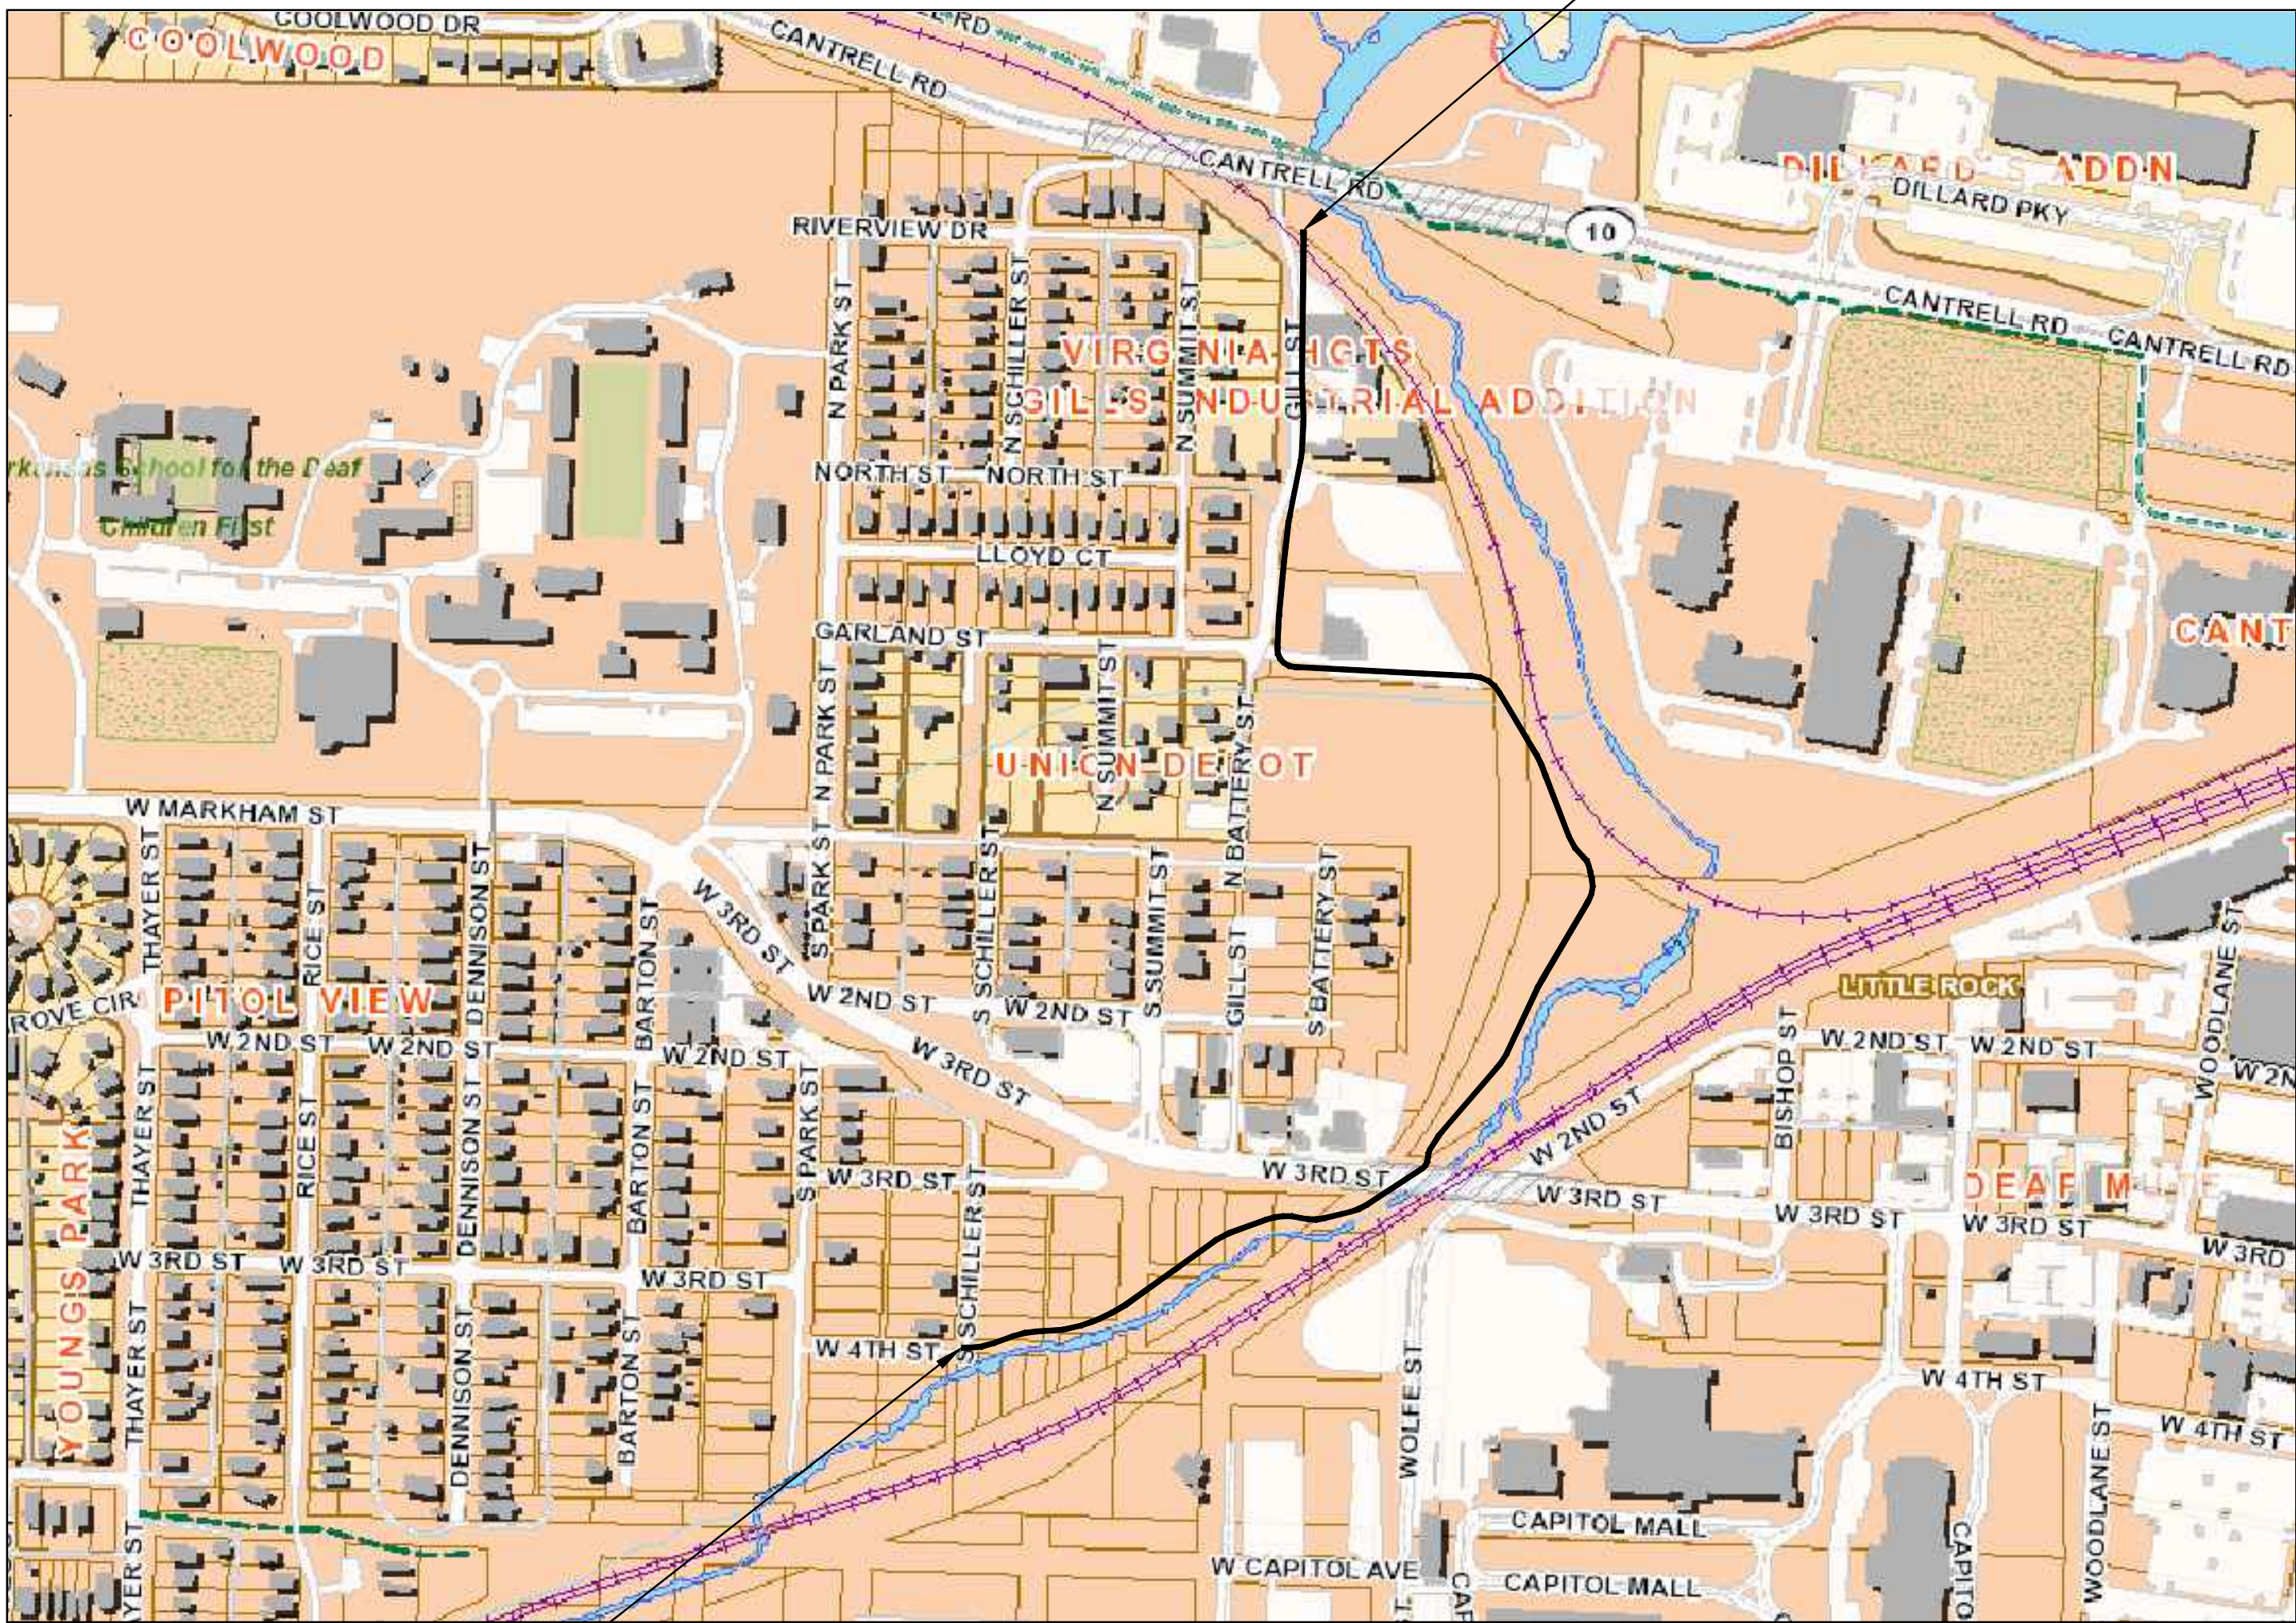

PROJECT END
STA. 43+53.86

PROJECT START
STA. 10+00.00

LOCATION

DEPARTMENT OF PUBLIC WORKS
CIVIL ENGINEERING
701 WEST MARKHAM STREET
LITTLE ROCK, ARKANSAS 72201

Sheet List Table	
Sheet Number	Sheet Title
C1	COVER SHEET
C2	LEGEND & QUANTITIES SHEET
C3 – C5	TYPICAL SECTIONS SHEET 1 – 3
C6	DETAIL
C7	OVERALL OWNERSHIP MAP
C8 – C10	OWNERSHIP MAP SHEET 1 – 3
C11	OVERALL SITE SHEET
C12 – C14	SITE ENLARGEMENT SHEET 1 – 3
C15	MAINTENANCE OF TRAFFIC
C16 – C19	STRIPING & SIGNAGE SHEET 1 – 4
C20 – C26	ROSE CREEK TRAIL PLAN & PROFILE SHEET 1–7
C27	DRIVEWAY PLAN
C28 – C33	CENTERLINE FIELD TIES SHEET 1 – 6
C34 – C37	EROSION CONTROL PH I SHEET 1 – 4
C38 – C41	EROSION CONTROL PH II SHEET 1 – 4
C42 – C45	EROSION CONTROL PH III SHEET 1 – 4
C46 – C49	LIGHTING PLAN SHEET 1 – 4
C50 – C64	CROSS SECTION SHEET 1 – 16




Know what's below.
Call before you dig.



10825 Financial Center Parkway, Suite 300
Little Rock, Arkansas 72211

501.664.3245 f 501.664.6704 f
www.craftontull.com

CERTIFICATE OF AUTHORIZATION:
JOB : 23805201

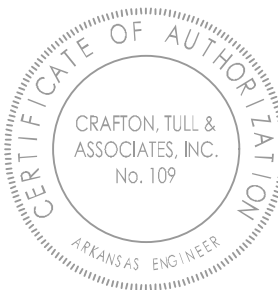

REVISIONS	DATE

CITY OF LITTLE ROCK, ARKANSAS
ROSE CREEK TRAIL
COVER SHEET

DEPARTMENT OF PUBLIC WORKS
CIVIL ENGINEERING
701 W. MARKHAM
LITTLE ROCK, ARKANSAS 72201



DRAWN BY AS
DESIGNED LC
CHECKED JM
DATE 05-01-2026
SCALE NO SCALE
PROJECT NO. 23805201
SHEET NO. C1

100% SUBMITTAL

ITEM	DESCRIPTION	QTY	UNIT
2.01	SITE PREPARATION	1	L.S.
3.01	UNCLASSIFIED EXCAVATION	1500	C.Y.
4.01	AGGREGATE BASE COURSE CLASS 7	1306	TON
6.01	ACHM SURFACE COURSE	392	TON
7.02	CONCRETE DRIVEWAY (8" THICK), STANDARD FINISH	3438	S.F.
8.03	CC CURB & GUTTER (CLASS 3)	508	L.F.
9.02	CONCRETE WALK (12' SECTIONS)	550	SQYD
10.03	4' x 4' GRATE INLET	3	EA.
11.02	CONCRETE REINFORCED BOX CULVERT (10'x5')	45	L.F.
11.06	REINFORCED CONCRETE HEADWALL	7	C.Y.
11.20	REINFORCED CONCRETE RETAINING WALL	3762	SF
13.18C	STORM DRAIN PIPE, 18" CROSS DRAIN	174	L.F.
14.01	SOLID SODDING (INCLUDES SEEDING AND MULCHING)	1	AC.
18.01	ACCESS RAMP (TYPE 3)	144	S.F.
18.07	HAND RAILING	160	L.F.
18.10	WATER FOR DUST CONTROL	5	MGAL
19.01	FINAL CLEAN UP	1	L.S.
24.01	CONSTRUCTION ENTRANCE (CO)	3	EA.
24.02	CHECK DAM	32	CY
24.02	SILT FENCE - TYPE A (SFA)	5229	L.F.
25.01	6' CHAIN-LINK FENCE	506	L.F.
606.18C	FLARED END SECTION, 18"	11	EA.
719.70	THERMOPLASTIC PAVEMENT STRIPING WHITE (12")	376	L.F.
719.70	THERMOPLASTIC PAVEMENT STRIPING YELLOW (4")	3340	L.F.
719.70	THERMOPLASTIC PAVEMENT STRIPING WHITE (4")	7341	L.F.
SP	LIGHT POLE ASSEMBLIES	30	EA.
SP	GATEWAY CONNECTOR	1	EA.
SP	CONTROLLING	1	EA.

EXISTING	PROPOSED
IRON ROD	PROPOSED CONTOUR
PK NAIL	PROPOSED SPOT ELEVATION
R.R. SPIKE	PROPOSED SPOT CURB ELEVATION
CONC. MONUMENT	STORM SEWER – PIPE
WATER VALVE	STORM SEWER – MITERED END SECTION
WATER METER	STORM SEWER – GRATE INLET
FIRE HYDRANT	STORM SEWER – JUNCTION BOX
GAS METER	STORM SEWER – FLARED END SECTION
GAS VALVE	STORM SEWER – HEADWALL
CLEAN-OUT	STORM SEWER – SINGLE WING
GUARD POST (BOLLARD)	STORM SEWER – DOUBLE WING
SIGN POST	STORM SEWER – AREA INLET
BENCHMARK	GRADE BREAK LINE
STORM SEWER MANHOLE	HIGH POINT
SANITARY SEWER MANHOLE	LOW POINT
TELEPHONE MANHOLE	CUT LINE
ELECTRIC MANHOLE	FILL LINE
TELEPHONE BOX	SANITARY SEWER PIPE
ELECTRIC BOX	SANITARY SEWER MANHOLE
CABLE BOX	PROPOSED CURB
UTILITY POLE	PROPOSED CONCRETE
GUY WIRE	CONSTRUCTION – ENTRANCE/EXIT
LIGHT POLE	CHECK DAM
POST OR POLE (TYPE AS NOTED)	DIVERSION BERM
MAILBOX	DOWNDRAIN STRUCTURE – TEMPORARY
DECIDUOUS TREE	ROCK DAM
EVERGREEN/CONIFEROUS TREE	SEDIMENT BARRIER – SILT FENCE
BUSH	SEDIMENT BARRIER – GRAVEL RING
PROPERTY LINE	SEDIMENT BARRIER – BLOCK & GRAVEL
SETBACK LINE	SEDIMENT BARRIER – BLOCK
EASEMENT LINE	TEMPORARY SEDIMENT BASIN
CURB	SILT FENCE – TYPE A
FENCE	SILT FENCE – TYPE B
OVERHEAD ELECTRIC	SILT FENCE – TYPE C
OVERHEAD TELEPHONE	STORM DRAIN OUTLET PROTECTION
OVERHEAD CABLE	SURFACE ROUGHENING
UNDERGROUND TELEPHONE	DISTURBED AREA STABILIZATION –TEMPORARY STABILIZATION
UNDERGROUND ELECTRIC	DISTURBED AREA STABILIZATION –TEMPORARY GRASSING
UNDERGROUND CABLE	DISTURBED AREA STABILIZATION –PERMANENT GRASSING
WATER LINE	MATTING/BLANKETS
SEWER LINE	
GAS LINE	
STORM SEWER/CULVERT	
EDGE OF WOODS	
CONTOUR LINE	

REVISIONS	DATE

CITY OF LITTLE ROCK, ARKANSAS	LEGEND & QUANTITIES SHEET
ROSE CREEK TRAIL	

DEPARTMENT OF PUBLIC WORKS	CIVIL ENGINEERING	701 W. MARKHAM	LITTLE ROCK, ARKANSAS 72201



DRAWN BY	AS
DESIGNED	LC
CHECKED	JM
DATE	05-01-2026
SCALE	NO SCALE
PROJECT NO.	23805201
SHEET NO.	C2

REVISIONS	DATE

CITY OF LITTLE ROCK, ARKANSAS

ROSE CREEK TRAIL

TYPICAL SECTIONS SHEET 1

DEPARTMENT OF PUBLIC WORKS

CIVIL ENGINEERING

701 W. MARKHAM

LITTLE ROCK, ARKANSAS 72201



STATE OF ARKANSAS

REGISTERED PROFESSIONAL ENGINEER

BRADLEY A. PETERSON

No. 13217

9/3/26

DRAWN BY

AS

DESIGNED

LC

CHECKED

JM

DATE

05-01-2026

SCALE


NO SCALE

PROJECT NO.

23805201

SHEET NO.

C3

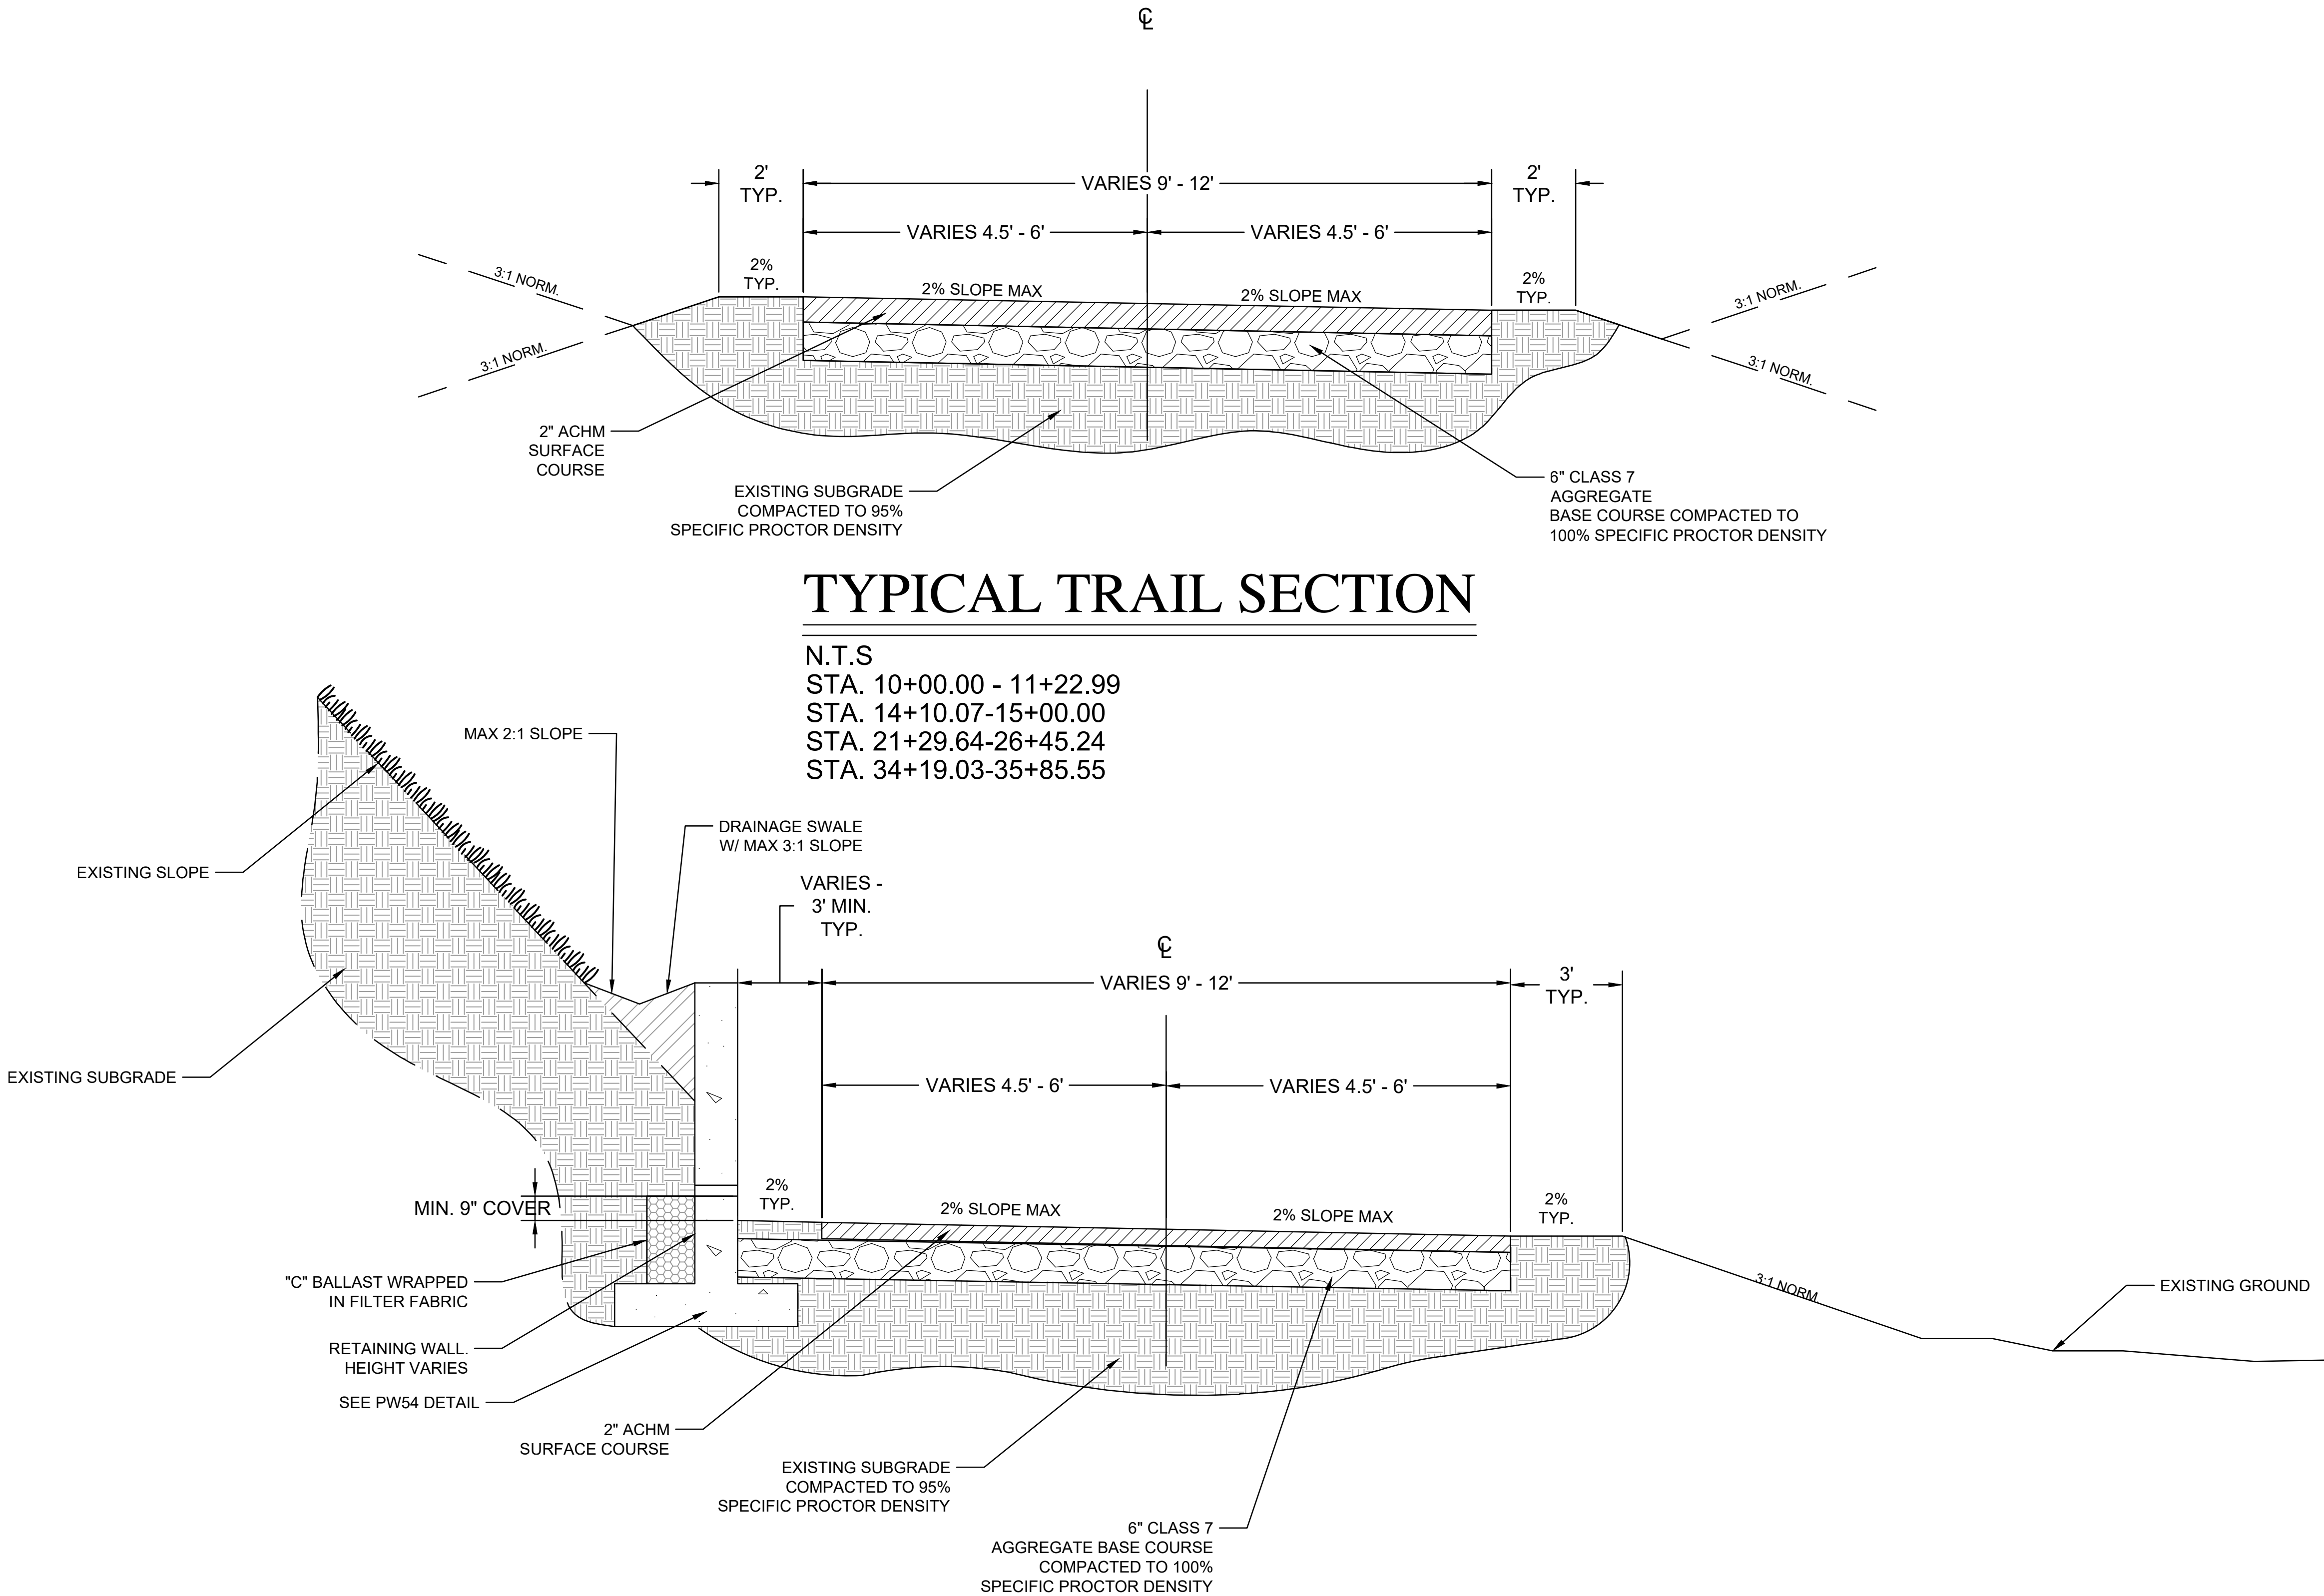


TYPICAL TRAIL SECTION

N.T.S
STA. 10+00.00 - 11+22.99
STA. 14+10.07-15+00.00
STA. 21+29.64-26+45.24
STA. 34+19.03-35+85.55

TRAIL SECTION W/ RETAINING WALL


N.T.S
STA. 15+00.00 - 18+56.21
STA. 20+11.79-21+29.64

100% SUBMITTAL

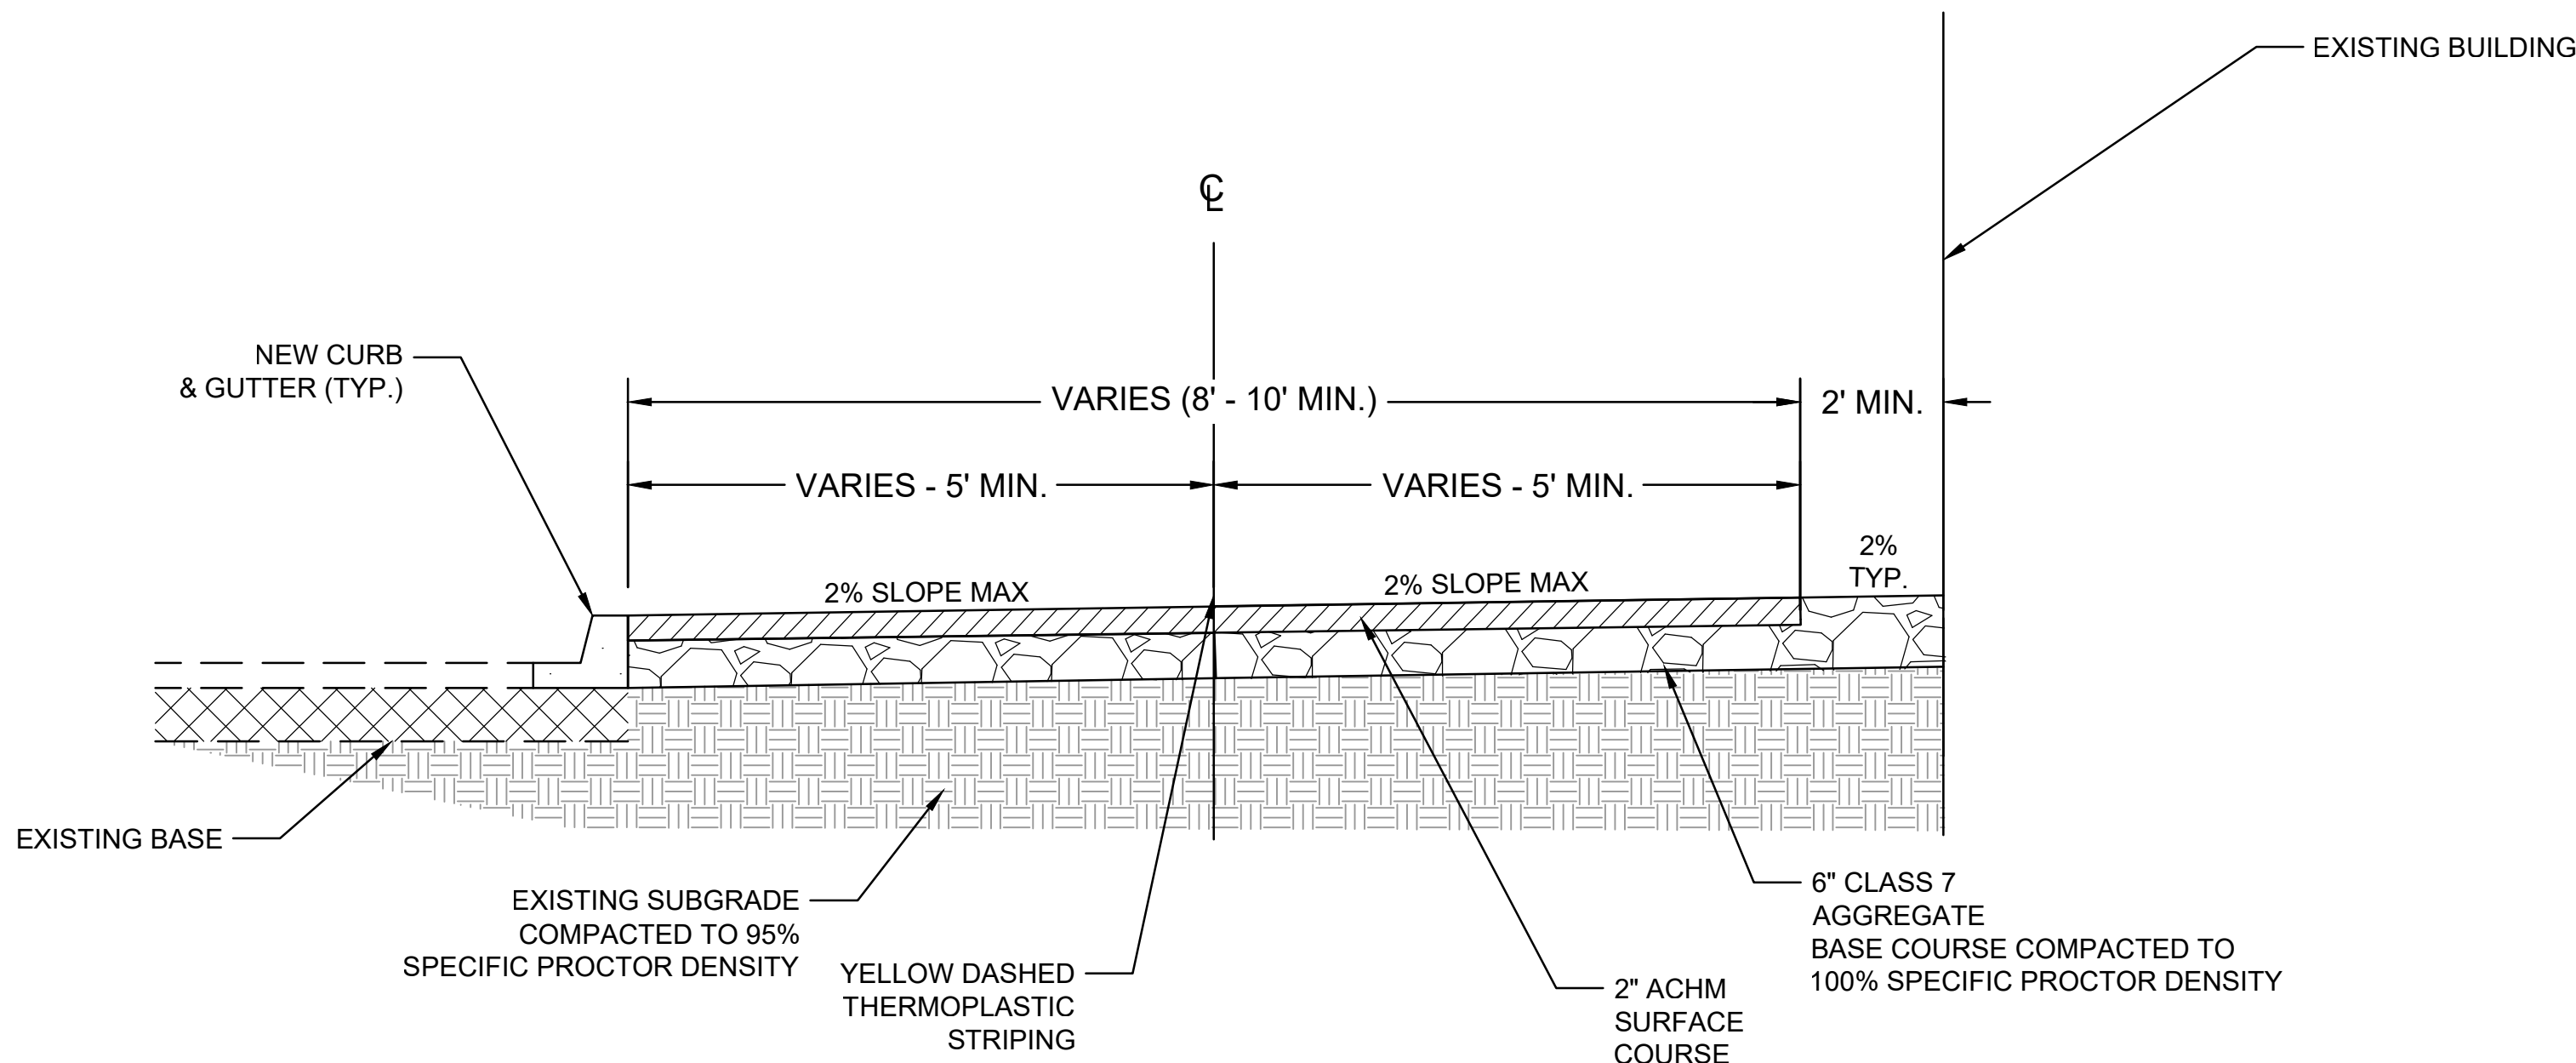

CYCLE TRACK SECTION

N.T.S
STA. 35+85.55 - STA. 43+38.21

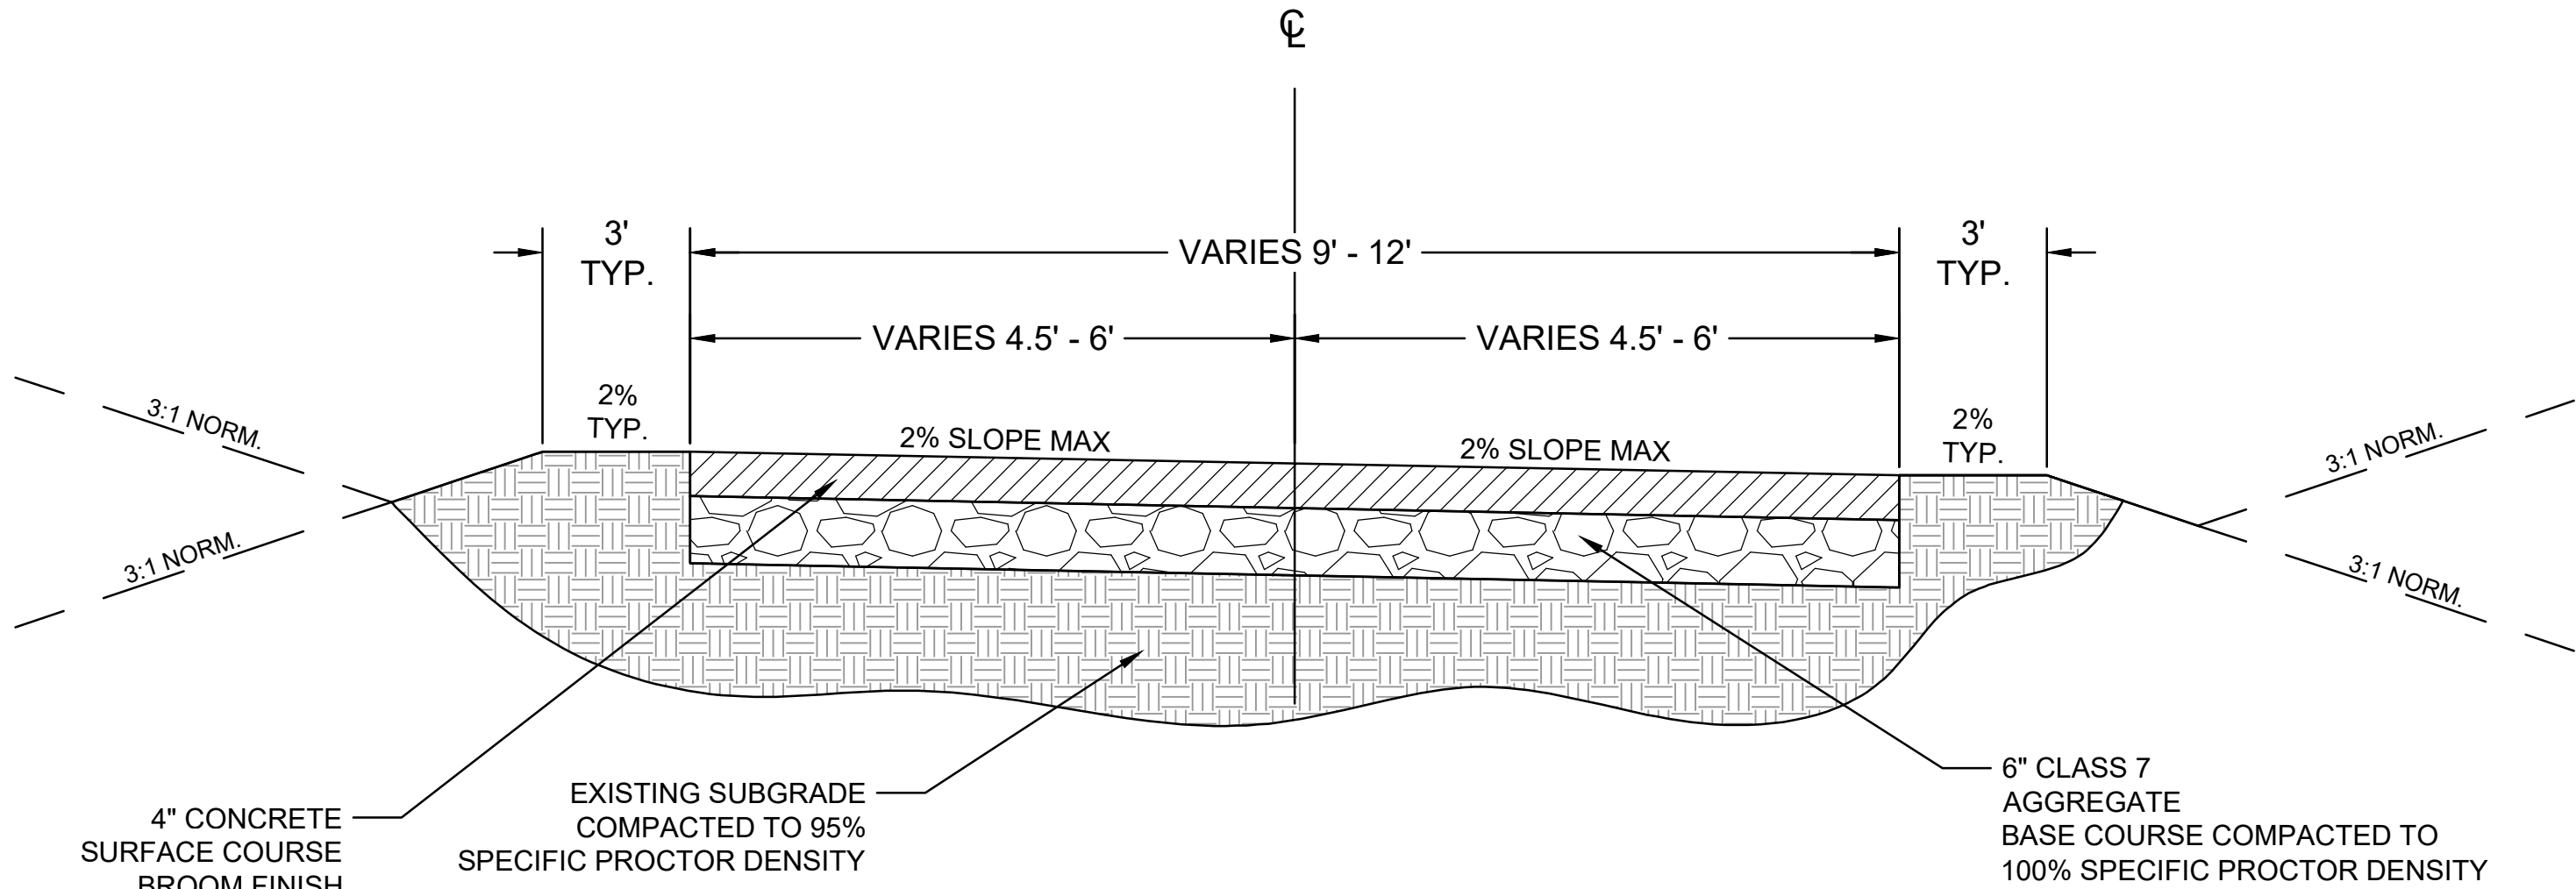

CONCRETE TRAIL SECTION

N.T.S
STA. 11+22.98 - 14+10.07
STA. 14+10.07-15+00.00
STA. 21+29.64-35+31.90
STA. 35+56.81-37+03.79

REVISIONS	DATE

CITY OF LITTLE ROCK, ARKANSAS

ROSE CREEK TRAIL

TYPICAL SECTIONS SHEET 2

DEPARTMENT OF PUBLIC WORKS

CIVIL ENGINEERING

701 W. MARKHAM

LITTLE ROCK, ARKANSAS 72201

ER

STATE OF ARKANSAS

REGISTERED PROFESSIONAL ENGINEER

BRADLEY A. PETERSON

No. 13217

9/3/26

DRAWN BY

AS

DESIGNED

LC

CHECKED

JM

DATE

05-01-2026

SCALE


NO SCALE

PROJECT NO.

23805201


SHEET NO.

C4

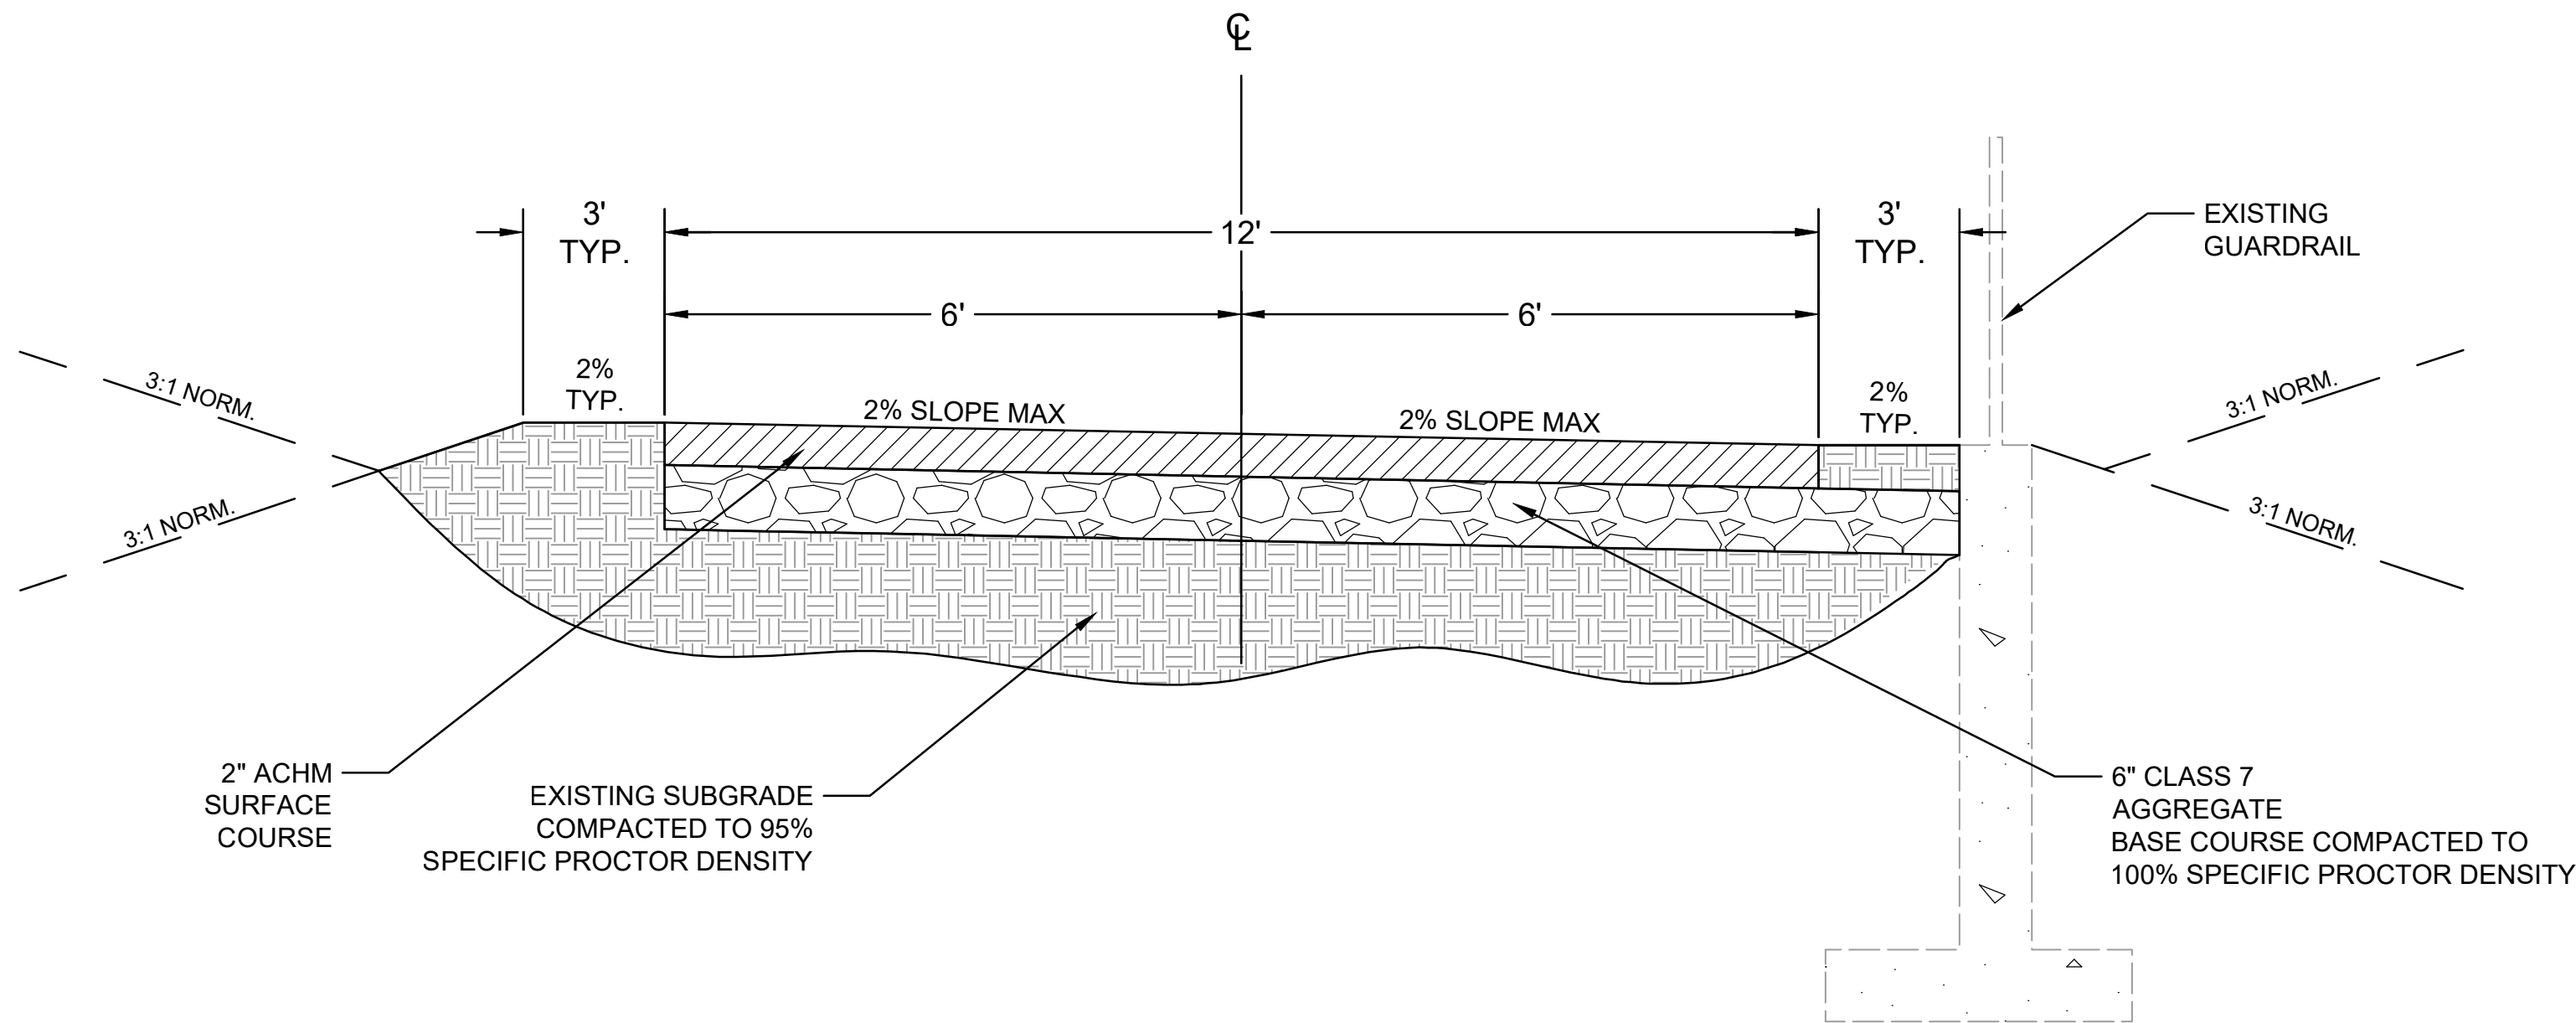

TYPICAL TRAIL SECTION W/
EXISTING GUARDRAIL

N.T.S
STA. 31+20.85 - 34+19.03

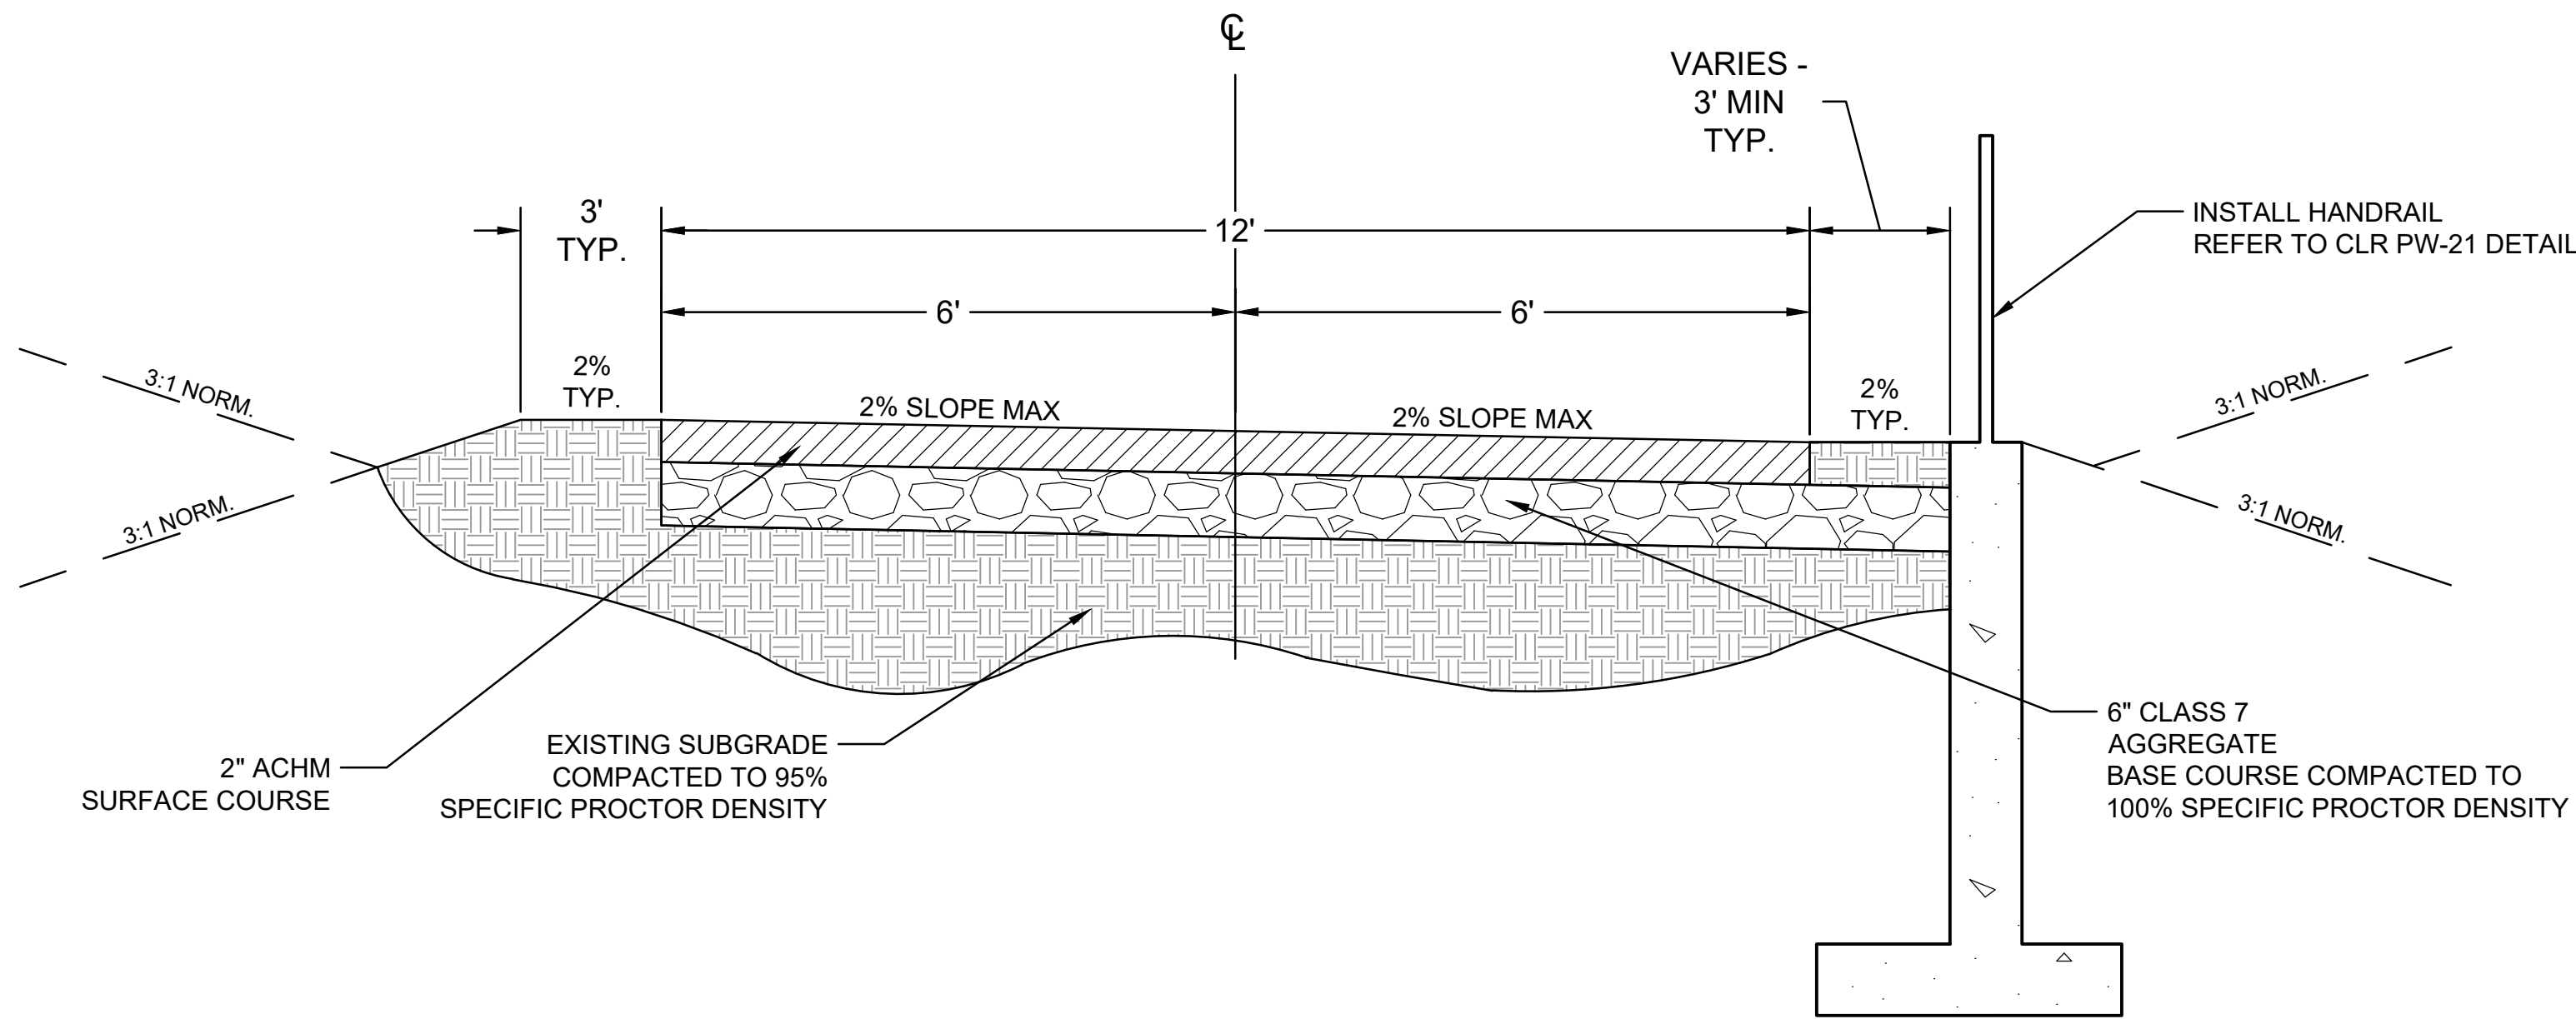

TYPICAL TRAIL SECTION W/ GUARDRAIL

N.T.S
STA. 26+45.24 - 24+19.03


REVISIONS	DATE

CITY OF LITTLE ROCK, ARKANSAS ROSE CREEK TRAIL	TYPICAL SECTIONS SHEET 3
---	--------------------------

DEPARTMENT OF PUBLIC WORKS CIVIL ENGINEERING 701 W. MARKHAM LITTLE ROCK, ARKANSAS 72201	
--	--




DRAWN BY AS
DESIGNED LC
CHECKED JM
DATE 05-01-2026
SCALE NO SCALE
PROJECT NO. 23805201
SHEET NO. C5

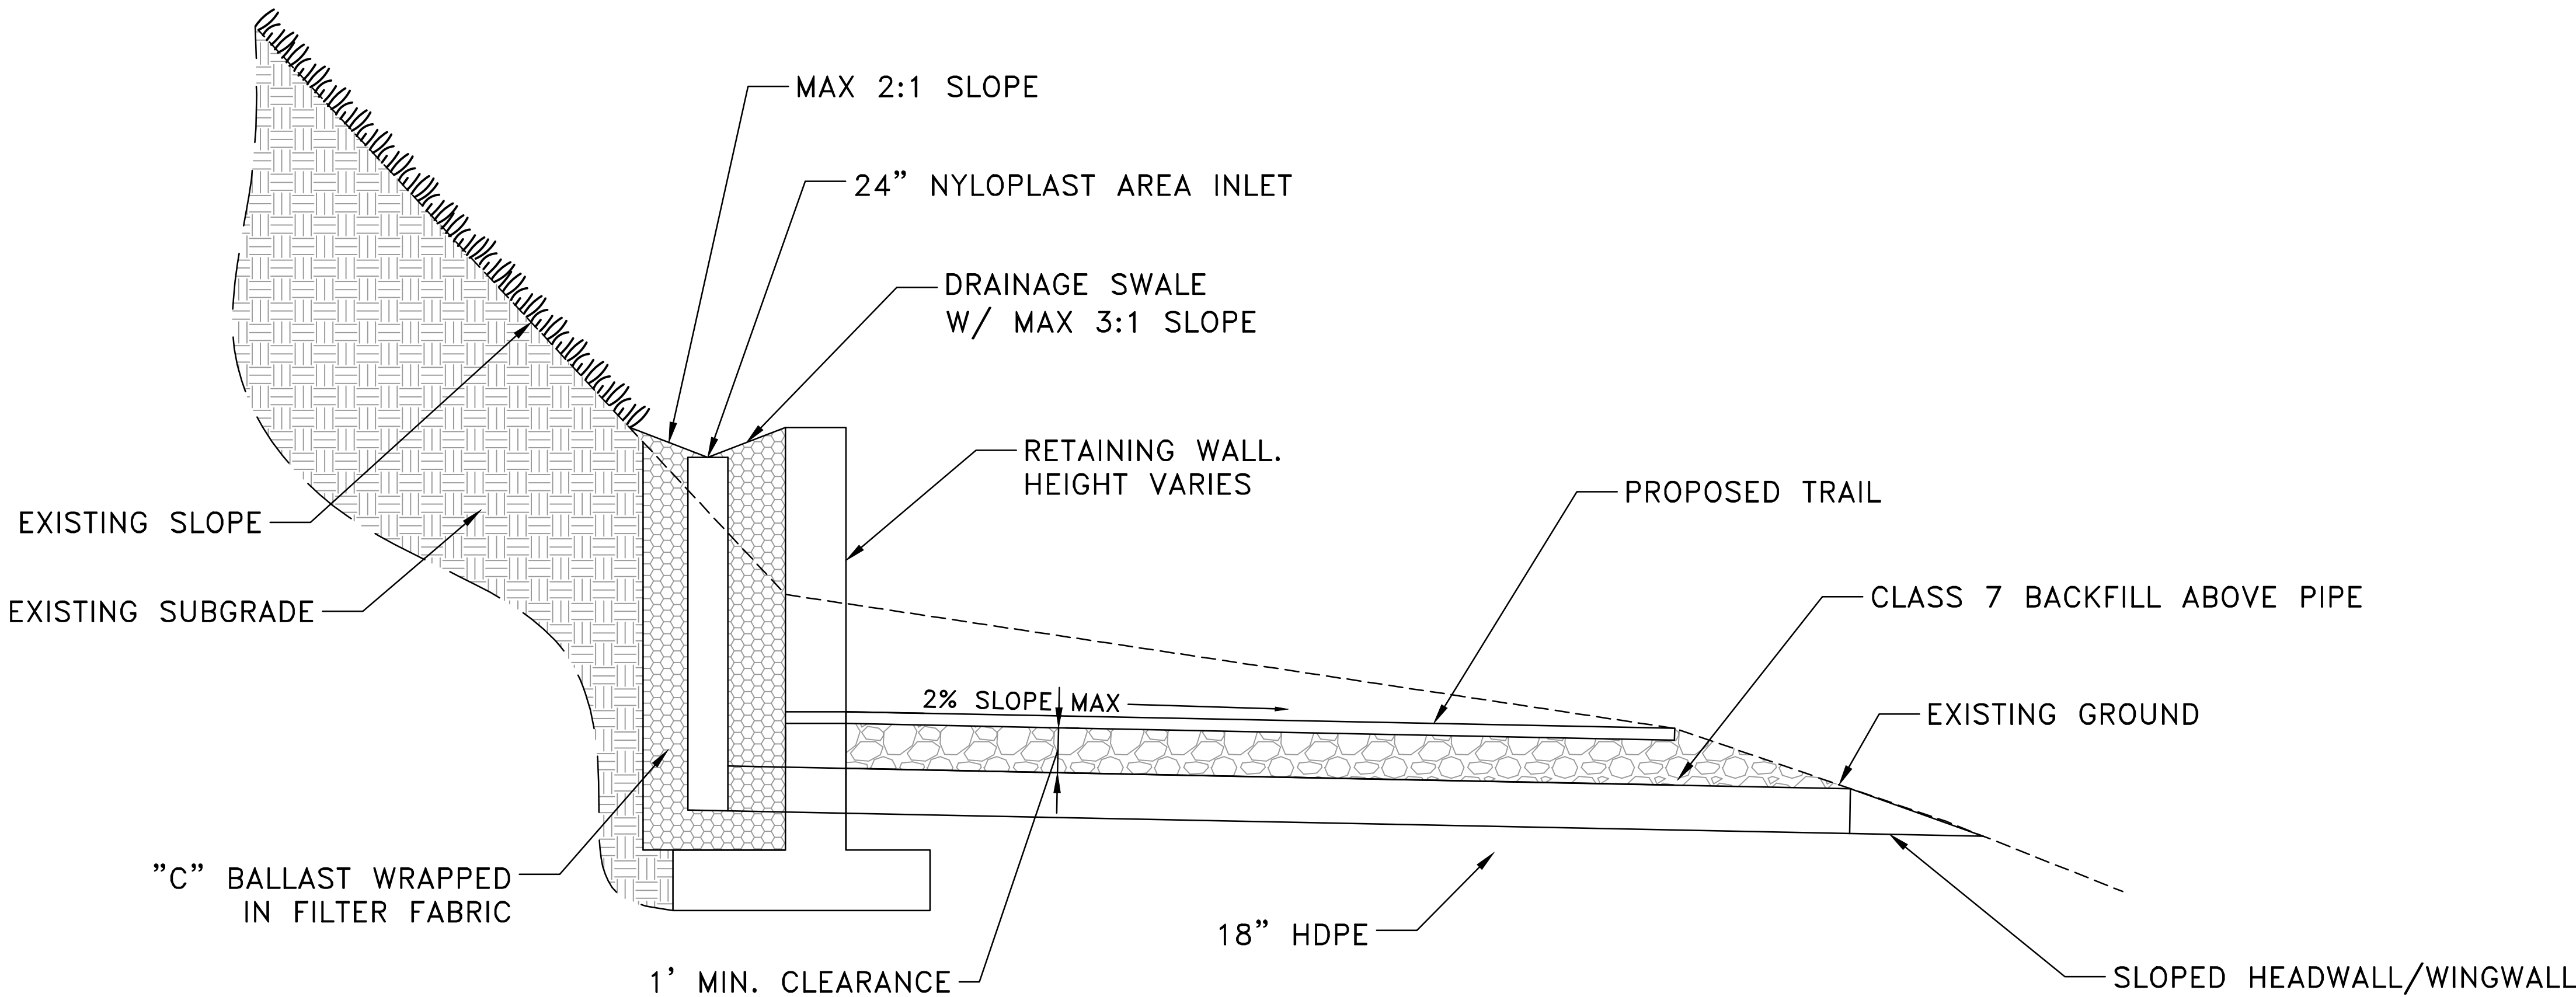

TRAIL SECTION WITH AREA INLET

N.T.S.

1. PROVIDE 3/4" CHAMFER ON ALL EXPOSED EDGES UNLESS ADJACENT TO SIDEWALKS OR OTHER CONCRETE SURFACES.
2. BASE AND INLET WALLS TO BE POURED MONOLITHICALLY.
3. PIPES MAY ENTER BOX FROM ANY ANGLE OR ELEVATION APPROVED BY THE ENGINEER.
4. ALL #4 & #5 REINFORCING BARS TO BE GRADE 60 AND HAVE 1-1/2" MINIMUM COVER. >#5, 2" COVER.
5. CONCRETE SHALL BE CLASS B, 3500#, 4%-7% A.E.
6. CONTRACTOR SHALL PROVIDE APPROVED PEDESTRIAN SAFETY RAILS AND VEHICULAR GUARD RAILS WHERE NECESSARY OR REQUIRED BY LOCAL, STATE AND FEDERAL CODES.

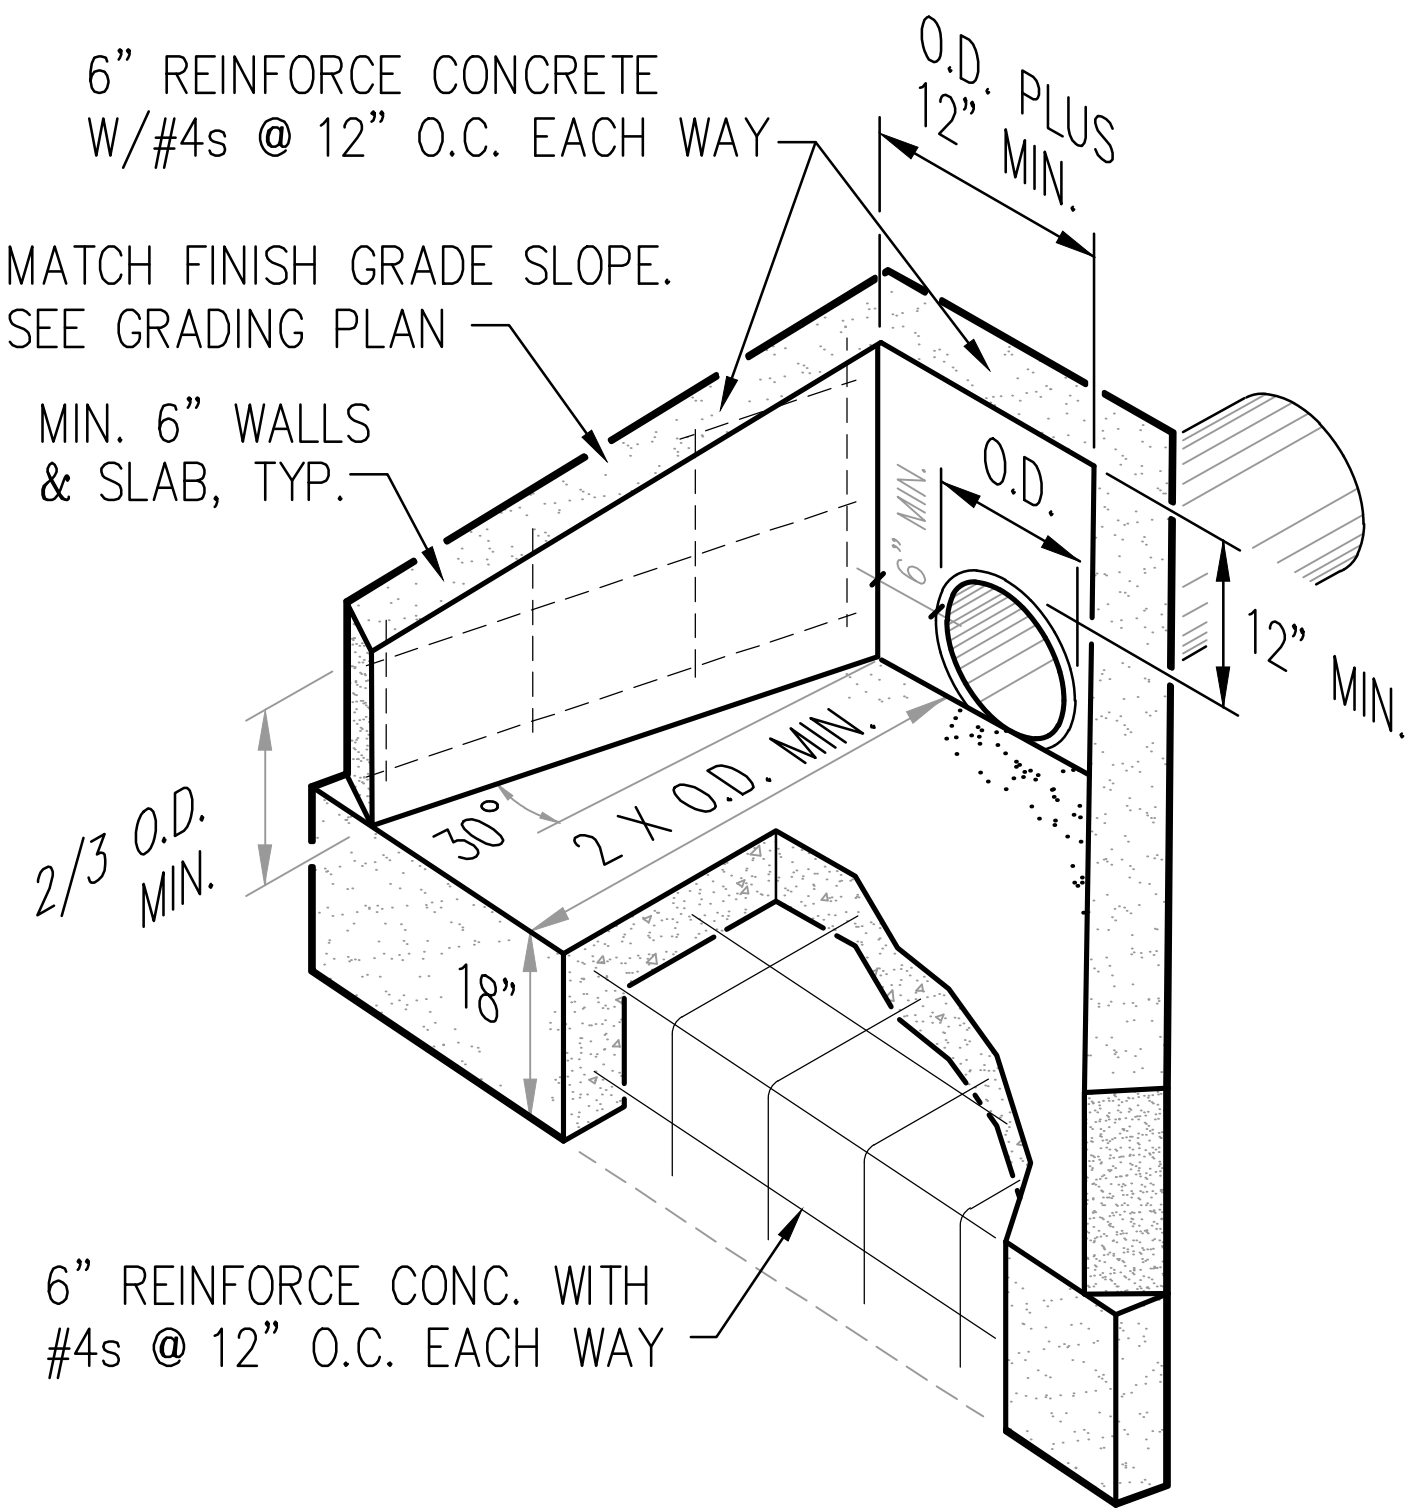

SINGLE PIPE HEADWALL /WINGWALL

N.T.S.

REVISIONS	DATE

CITY OF LITTLE ROCK, ARKANSAS ROSE CREEK TRAIL	DETAILS
---	---------

DEPARTMENT OF PUBLIC WORKS CIVIL ENGINEERING 701 W. MARKHAM LITTLE ROCK, ARKANSAS 72201	
--	--



DRAWN BY AS
DESIGNED LC
CHECKED JM
DATE 05-01-2026
SCALE NO SCALE
PROJECT NO. 23805201
SHEET NO. C6

REVISIONS	DATE

CITY OF LITTLE ROCK, ARKANSAS

ROSE CREEK TRAIL

OWNERSHIP MAP OVERALL

DEPARTMENT OF PUBLIC WORKS

CIVIL ENGINEERING

701 W. MARKHAM

LITTLE ROCK, ARKANSAS 72201

STATE OF ARKANSAS

REGISTERED PROFESSIONAL ENGINEER

BRADLEY A. PETERSON

No. 13217

9/3/26

DRAWN BY

AS

DESIGNED

LC

CHECKED

JM

DATE

05-01-2026

SCALE

1" = 100'

PROJECT NO.


23805201

SHEET NO.

C7

OWNERSHIP LEGEND

NO.	PARCEL NO.	OWNER
1	34L0380006300	CITY OF LITTLE ROCK
2	34L0380006200	FASON PROPERTIES LLC
3	34L0380006100	FASON PROPERTIES LLC
4	34L0380006000	FASON PROPERTIES LLC
5	34L0380005800	CITY OF LITTLE ROCK
6	34L0380005700	CITY OF LITTLE ROCK
7	34L0380006700	CITY OF LITTLE ROCK
8	34L0380006400	CITY OF LITTLE ROCK
9	34L0390001500	CITY OF LITTLE ROCK
10	34L0390001600	CITY OF LITTLE ROCK
11	34L0390001200	ARKANSAS POWER AND LIGHT
12	34L0390001400	CITY OF LITTLE ROCK
13	34L0390001300	CITY OF LITTLE ROCK
14	34L0390001100	CITY OF LITTLE ROCK
15	34L0370004900	TJM THIRD AND BISHOP PROPERTIES LLC
16	34L0330100100	TJM THIRD AND BISHOP PROPERTIES LLC
17	34L0320001101	TJM THIRD AND BISHOP PROPERTIES LLC
18	34L0330000201	CATHEDRAL MIDDLE SCHOOL
19	34L0330200200	COMCAST CABLE OF LITTLE ROCK
20	34L0330200100	KETCHER JOHN MORRELL FAMILY TRUST
21	34L0330200100	KETCHER JOHN MORRELL FAMILY TRUST
22	34L0350000200	KETCHER JOHN MORRELL FAMILY TRUST
23	34L0350000100	THE HARTSELL FAMILY
24		ABANDONED RAILROAD RIGHT OF WAY

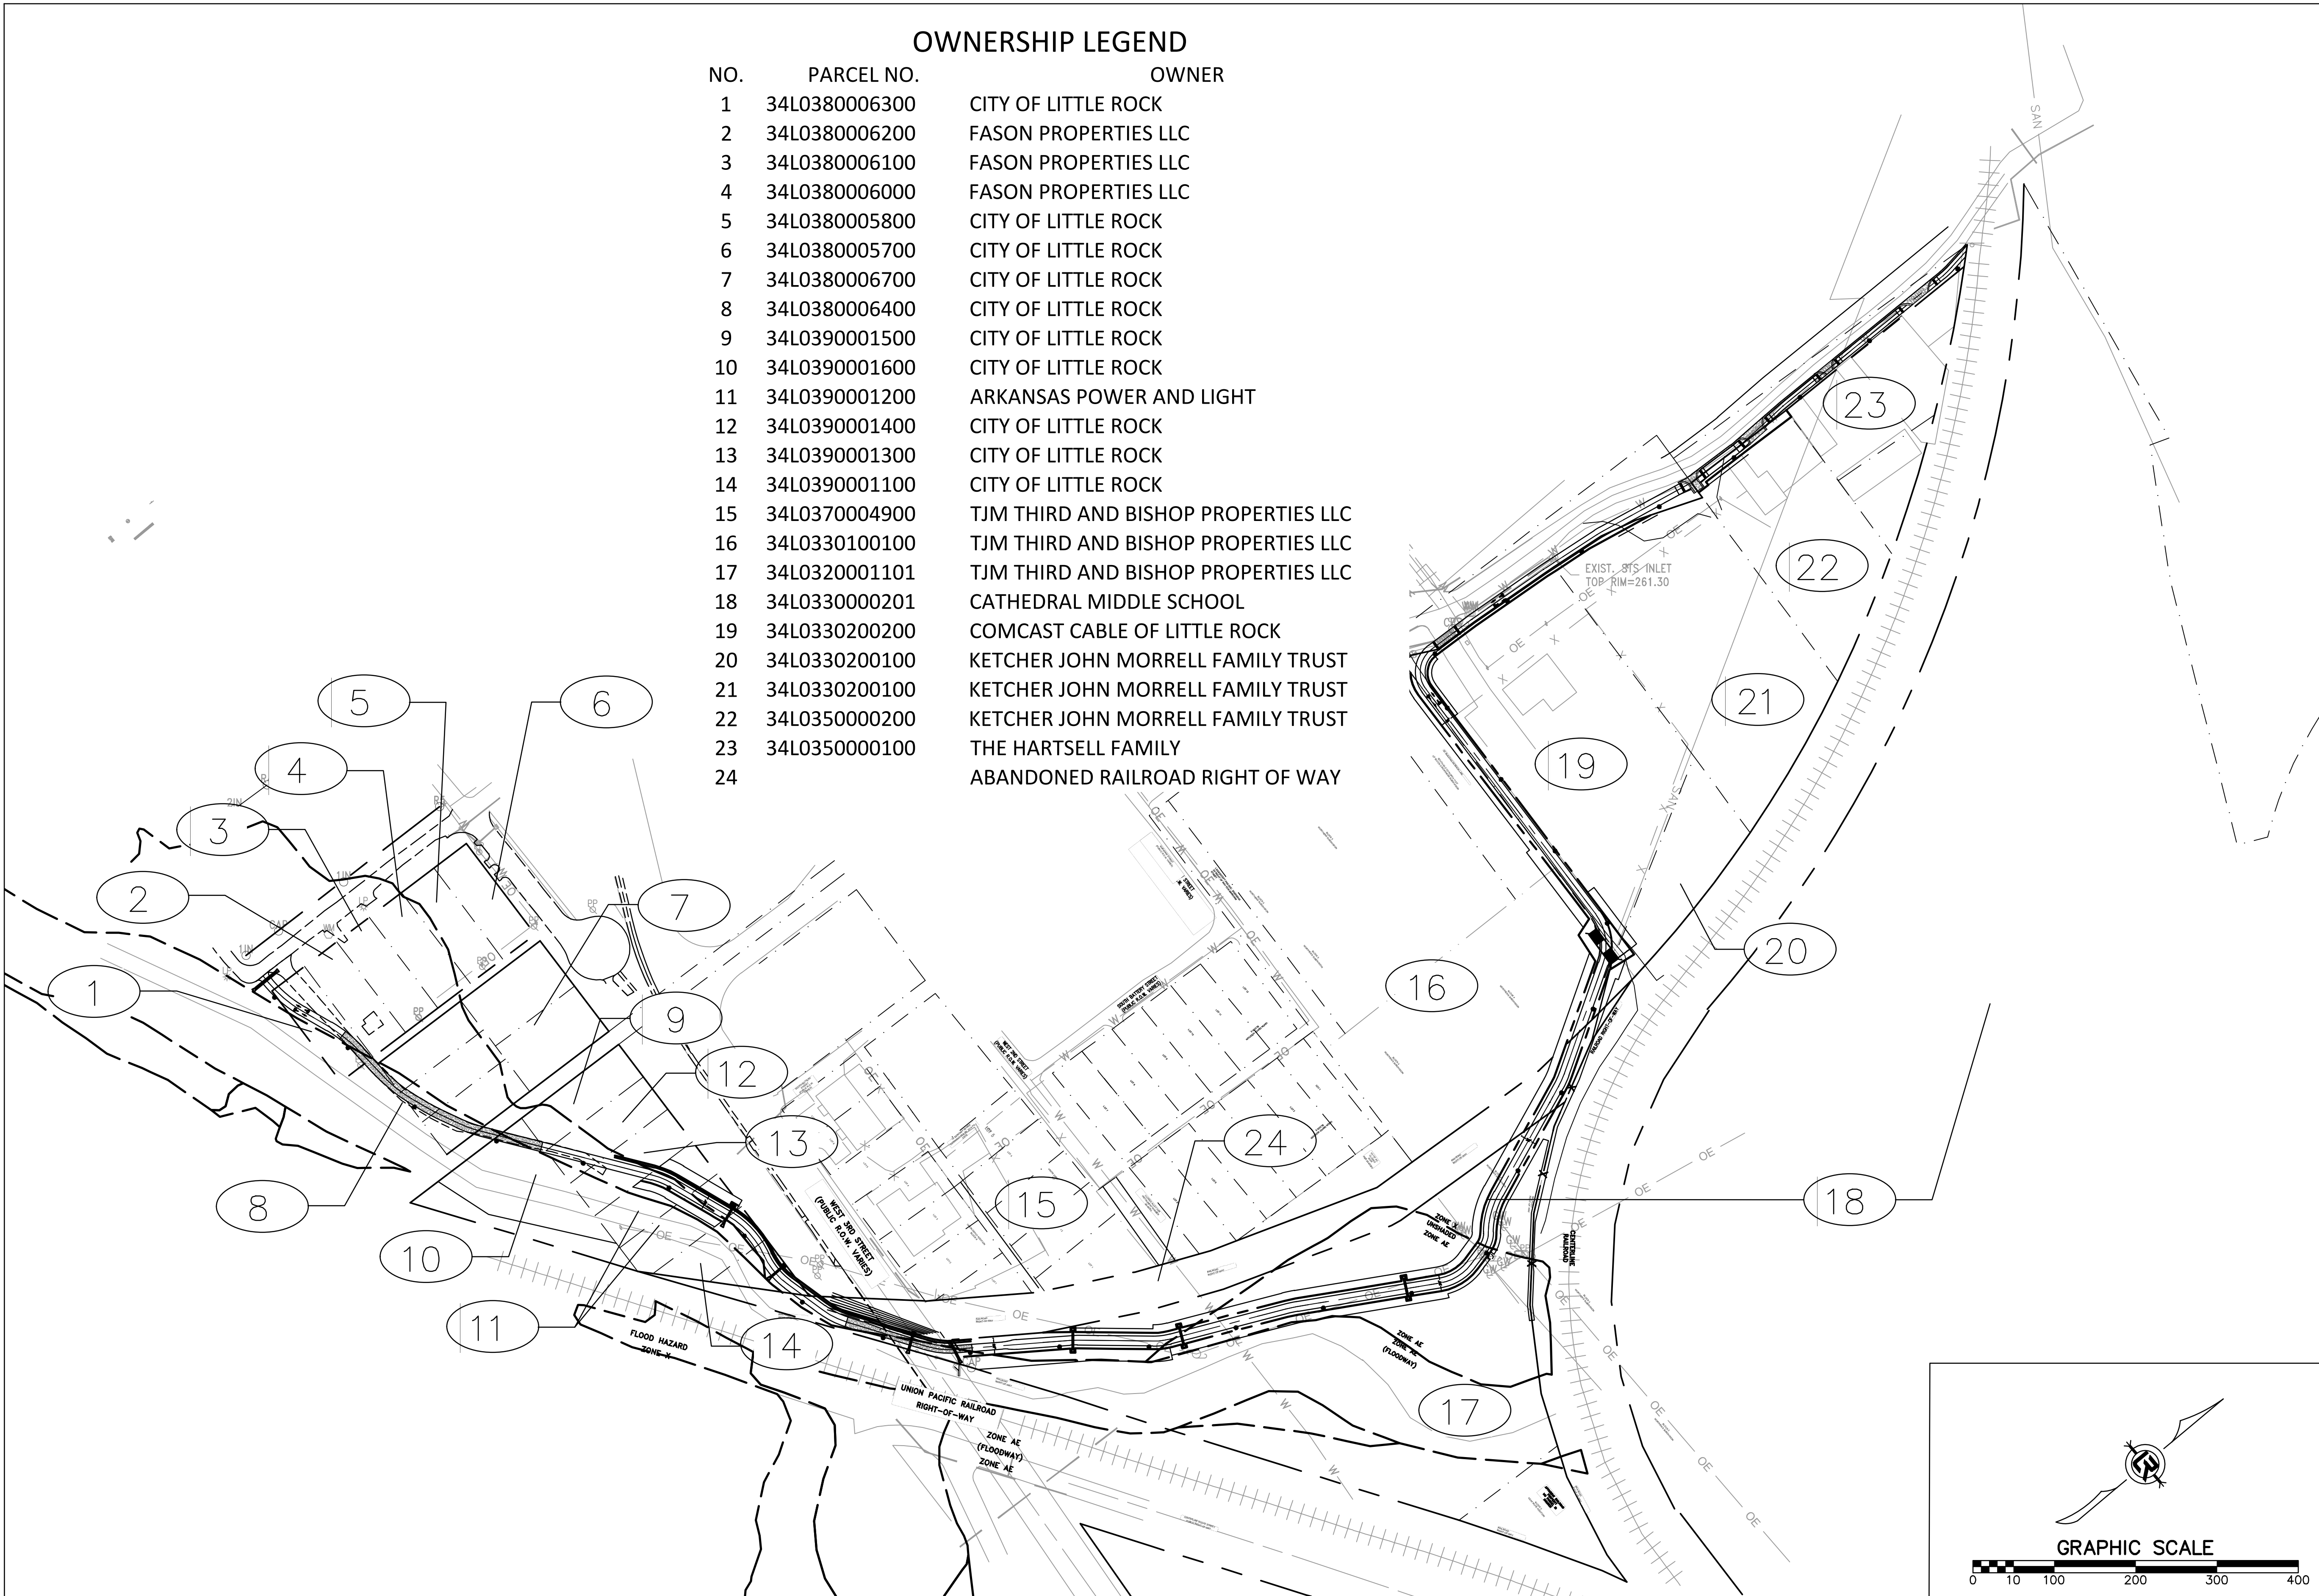


REVISIONS	DATE

CITY OF LITTLE ROCK, ARKANSAS
ROSE CREEK TRAIL
OWNERSHIP MAP SHEET 1

DEPARTMENT OF PUBLIC WORKS
CIVIL ENGINEERING
701 W. MARKHAM
LITTLE ROCK, ARKANSAS 72201



DRAWN BY	AS
DESIGNED	LC
CHECKED	JM
DATE	05-01-2026
SCALE	1" = 40'
PROJECT NO.	23805201
SHEET NO.	C8

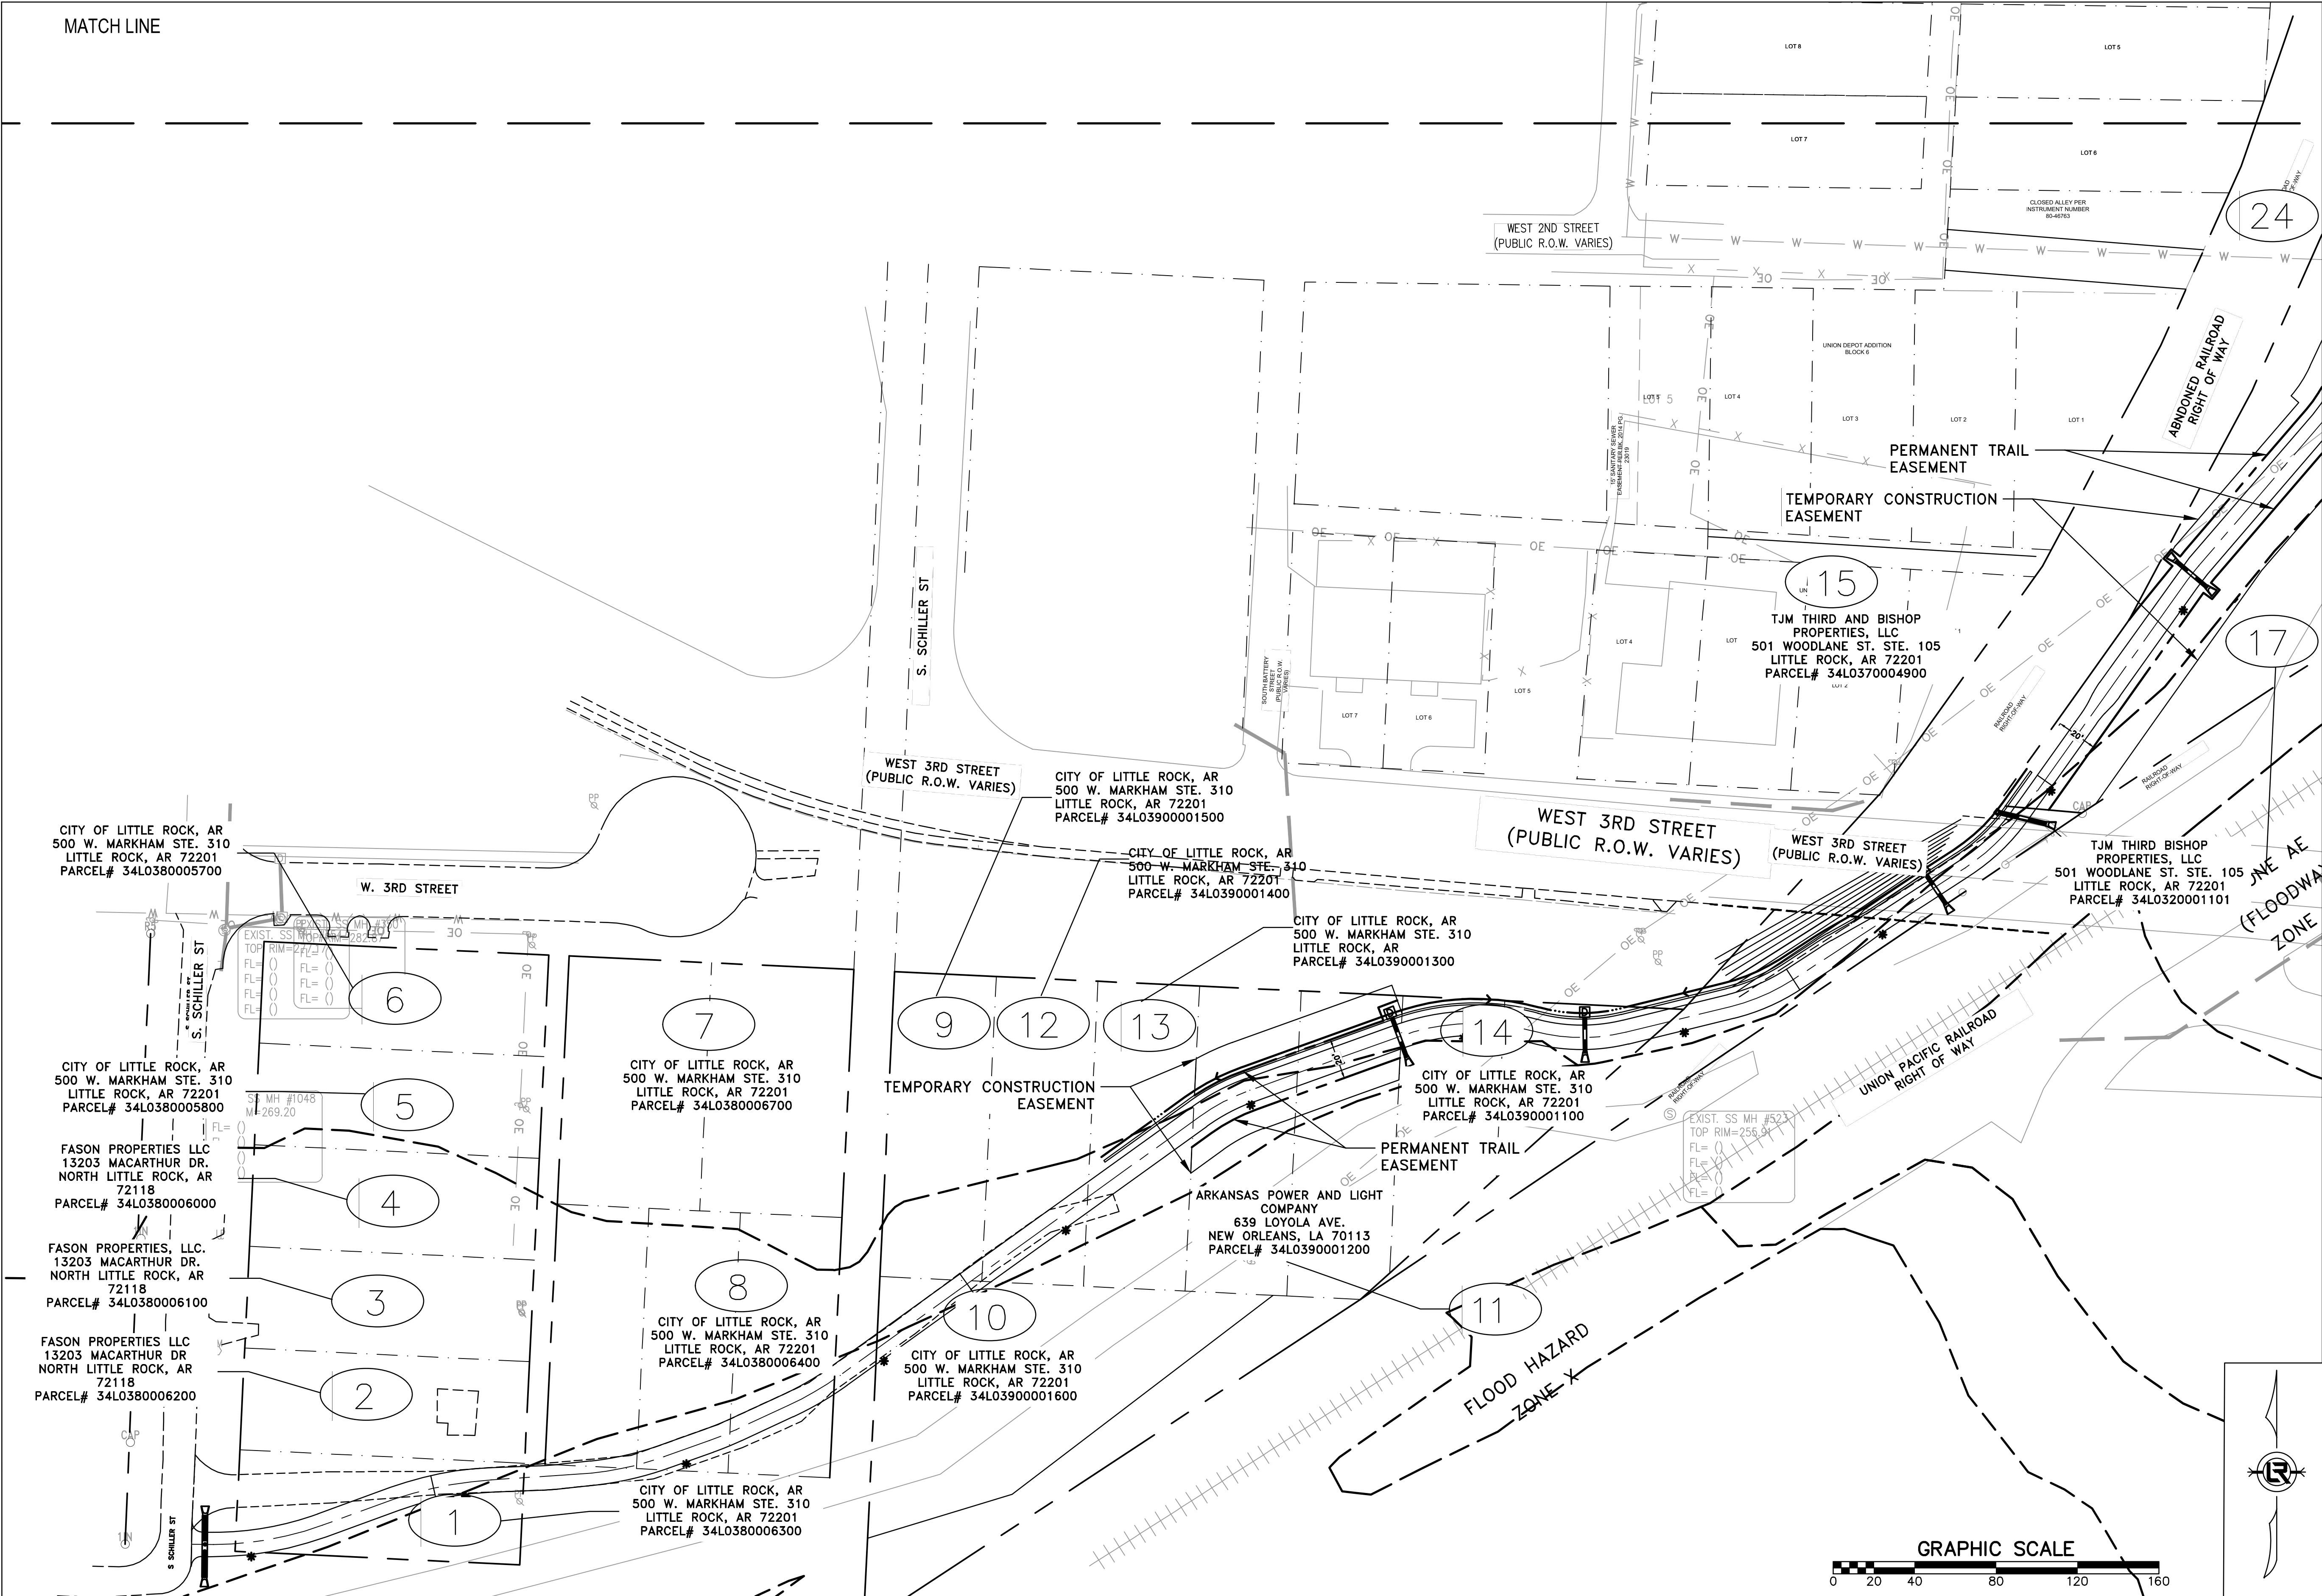

REVISIONS	DATE

CITY OF LITTLE ROCK, ARKANSAS

ROSE CREEK TRAIL

OWNERSHIP MAP SHEET 2

DEPARTMENT OF PUBLIC WORKS

CIVIL ENGINEERING

701 W. MARKHAM

LITTLE ROCK, ARKANSAS 72201



STATE OF ARKANSAS

REGISTERED PROFESSIONAL ENGINEER

BRADLEY A. PETERSON

No. 13217

9/3/26

DRAWN BY

AS

DESIGNED

LC

CHECKED

JM

DATE

05-01-2026

SCALE


1" = 40'

PROJECT NO.

23805201

SHEET NO.

C9

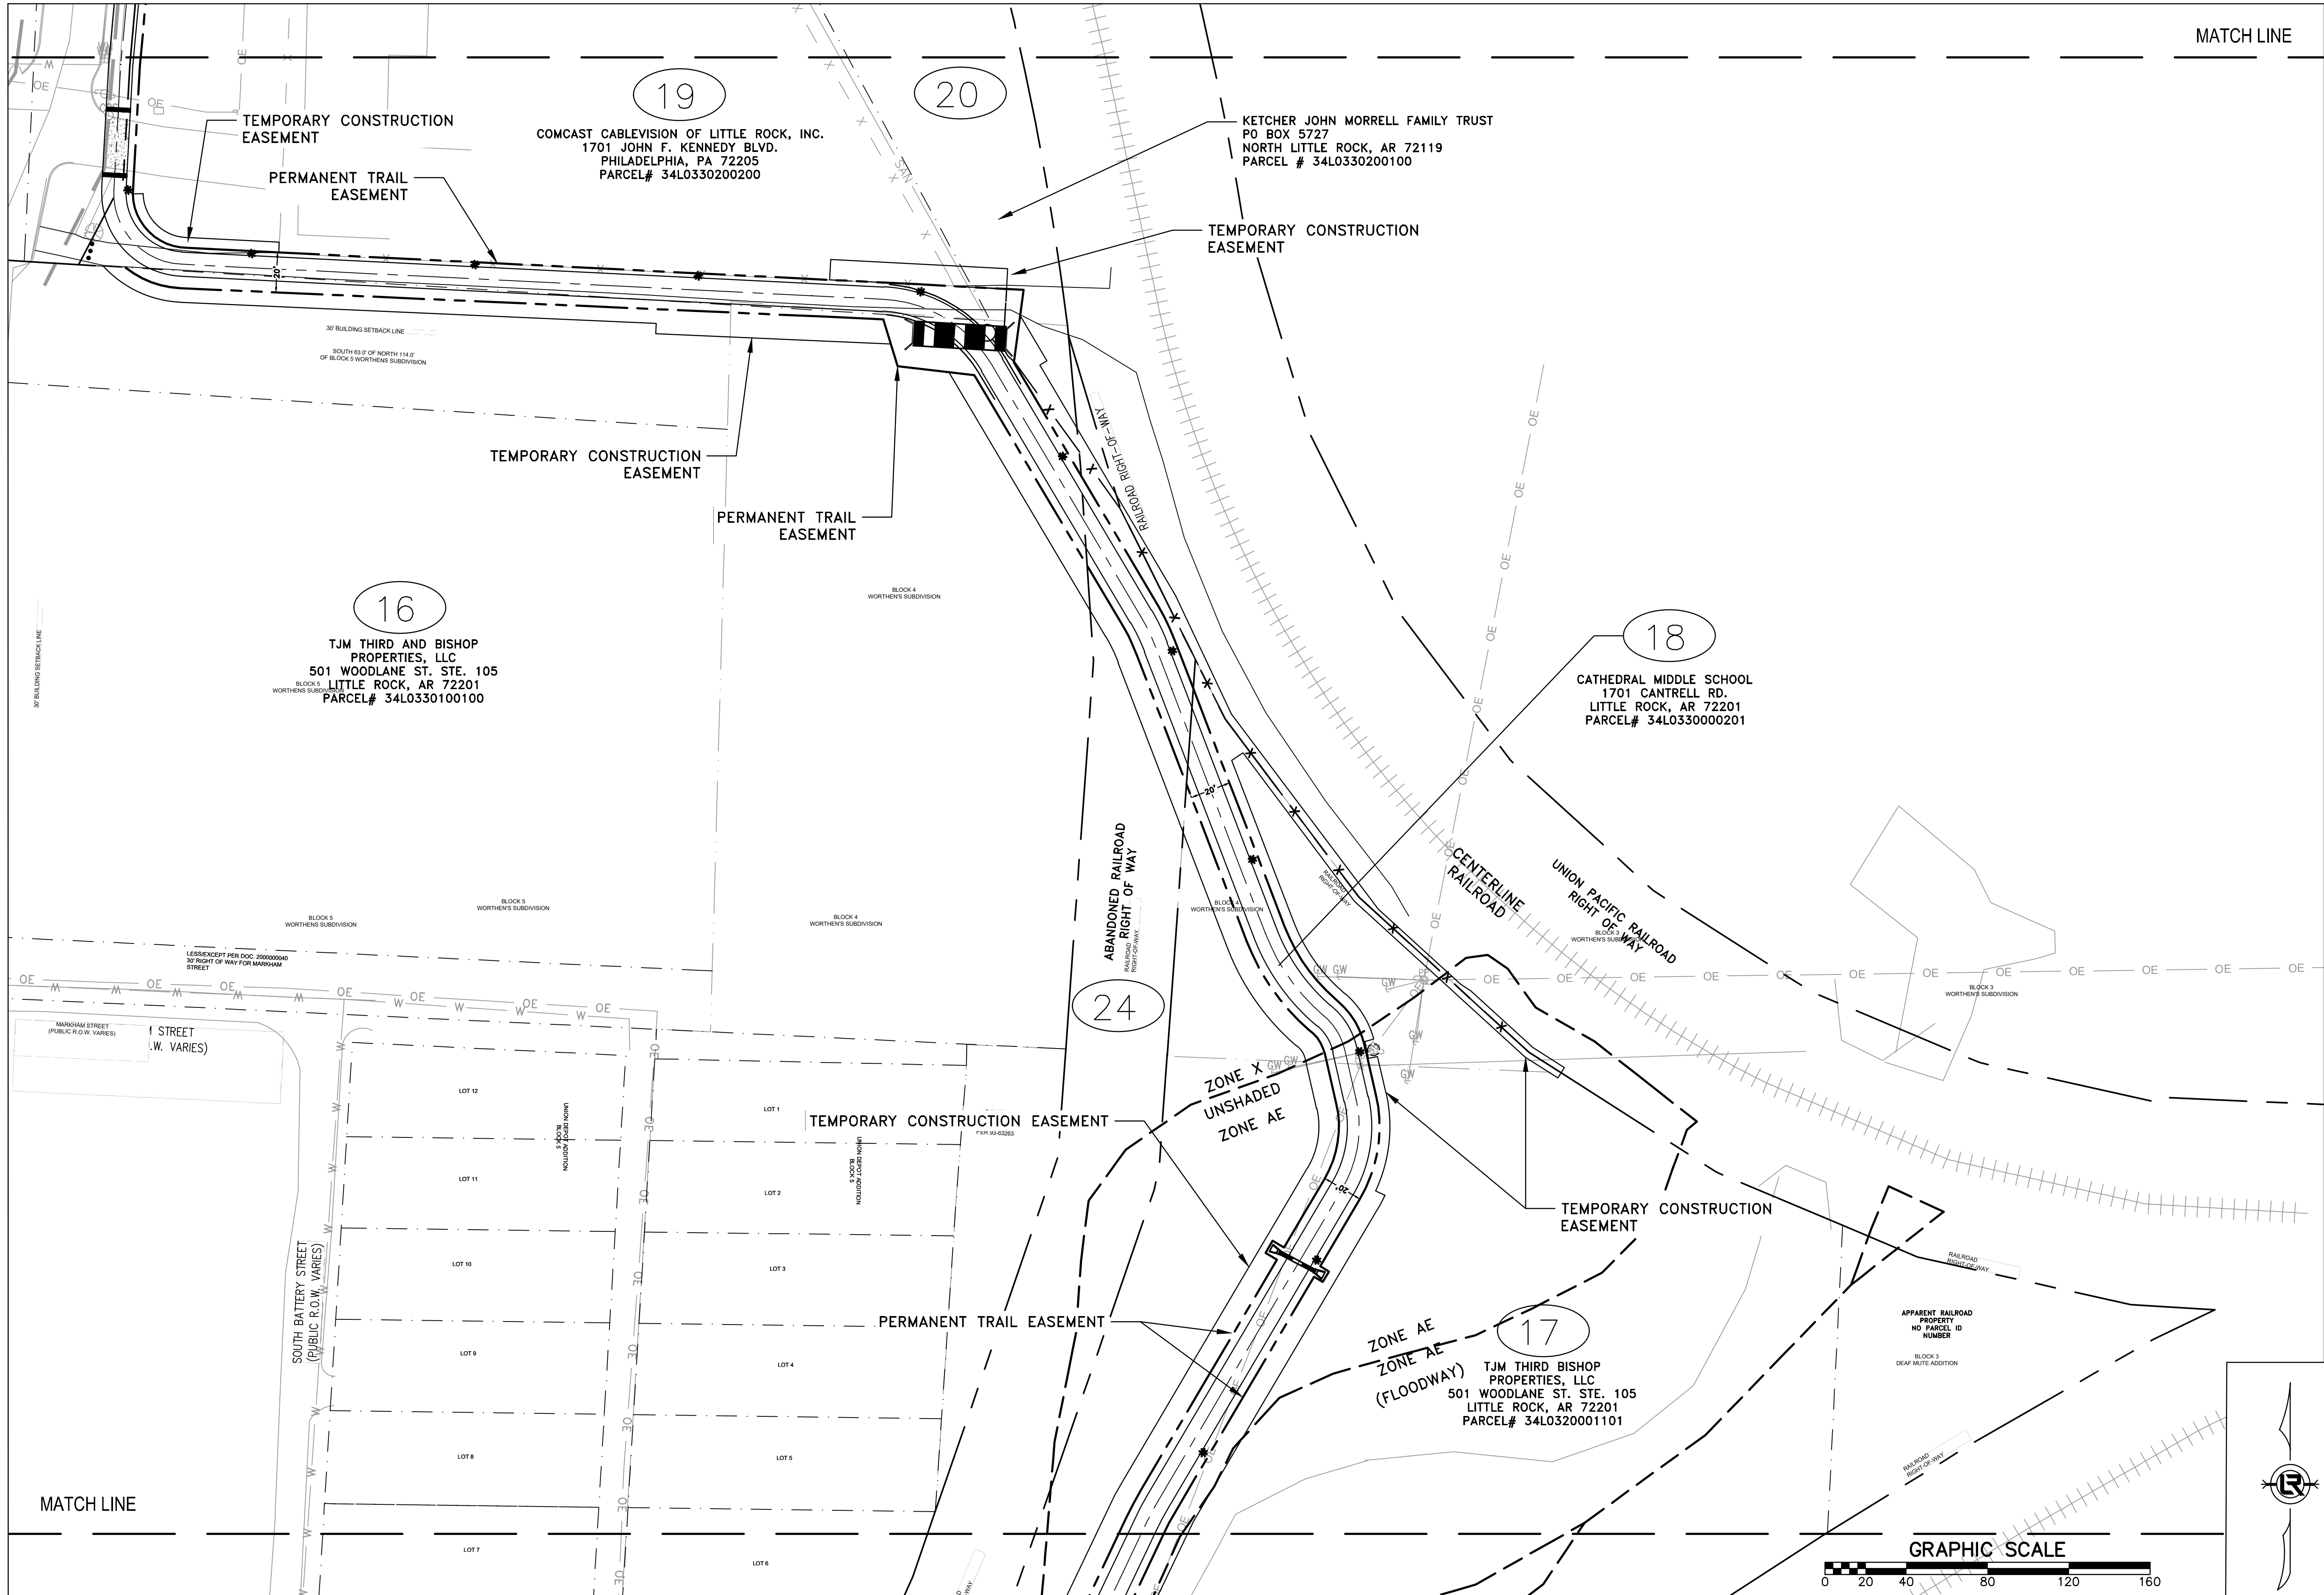

REVISIONS	DATE

CITY OF LITTLE ROCK, ARKANSAS

ROSE CREEK TRAIL

OWNERSHIP MAP SHEET 3

DEPARTMENT OF PUBLIC WORKS

CIVIL ENGINEERING

701 W. MARKHAM

LITTLE ROCK, ARKANSAS 72201

STATE OF ARKANSAS

REGISTERED PROFESSIONAL ENGINEER

BRADLEY A. PETERSON

No. 13217

9/3/26

DRAWN BY

AS

DESIGNED

LC

CHECKED

JM

DATE

05-01-2026

SCALE


1" = 40'

PROJECT NO.

23805201

SHEET NO.

C10

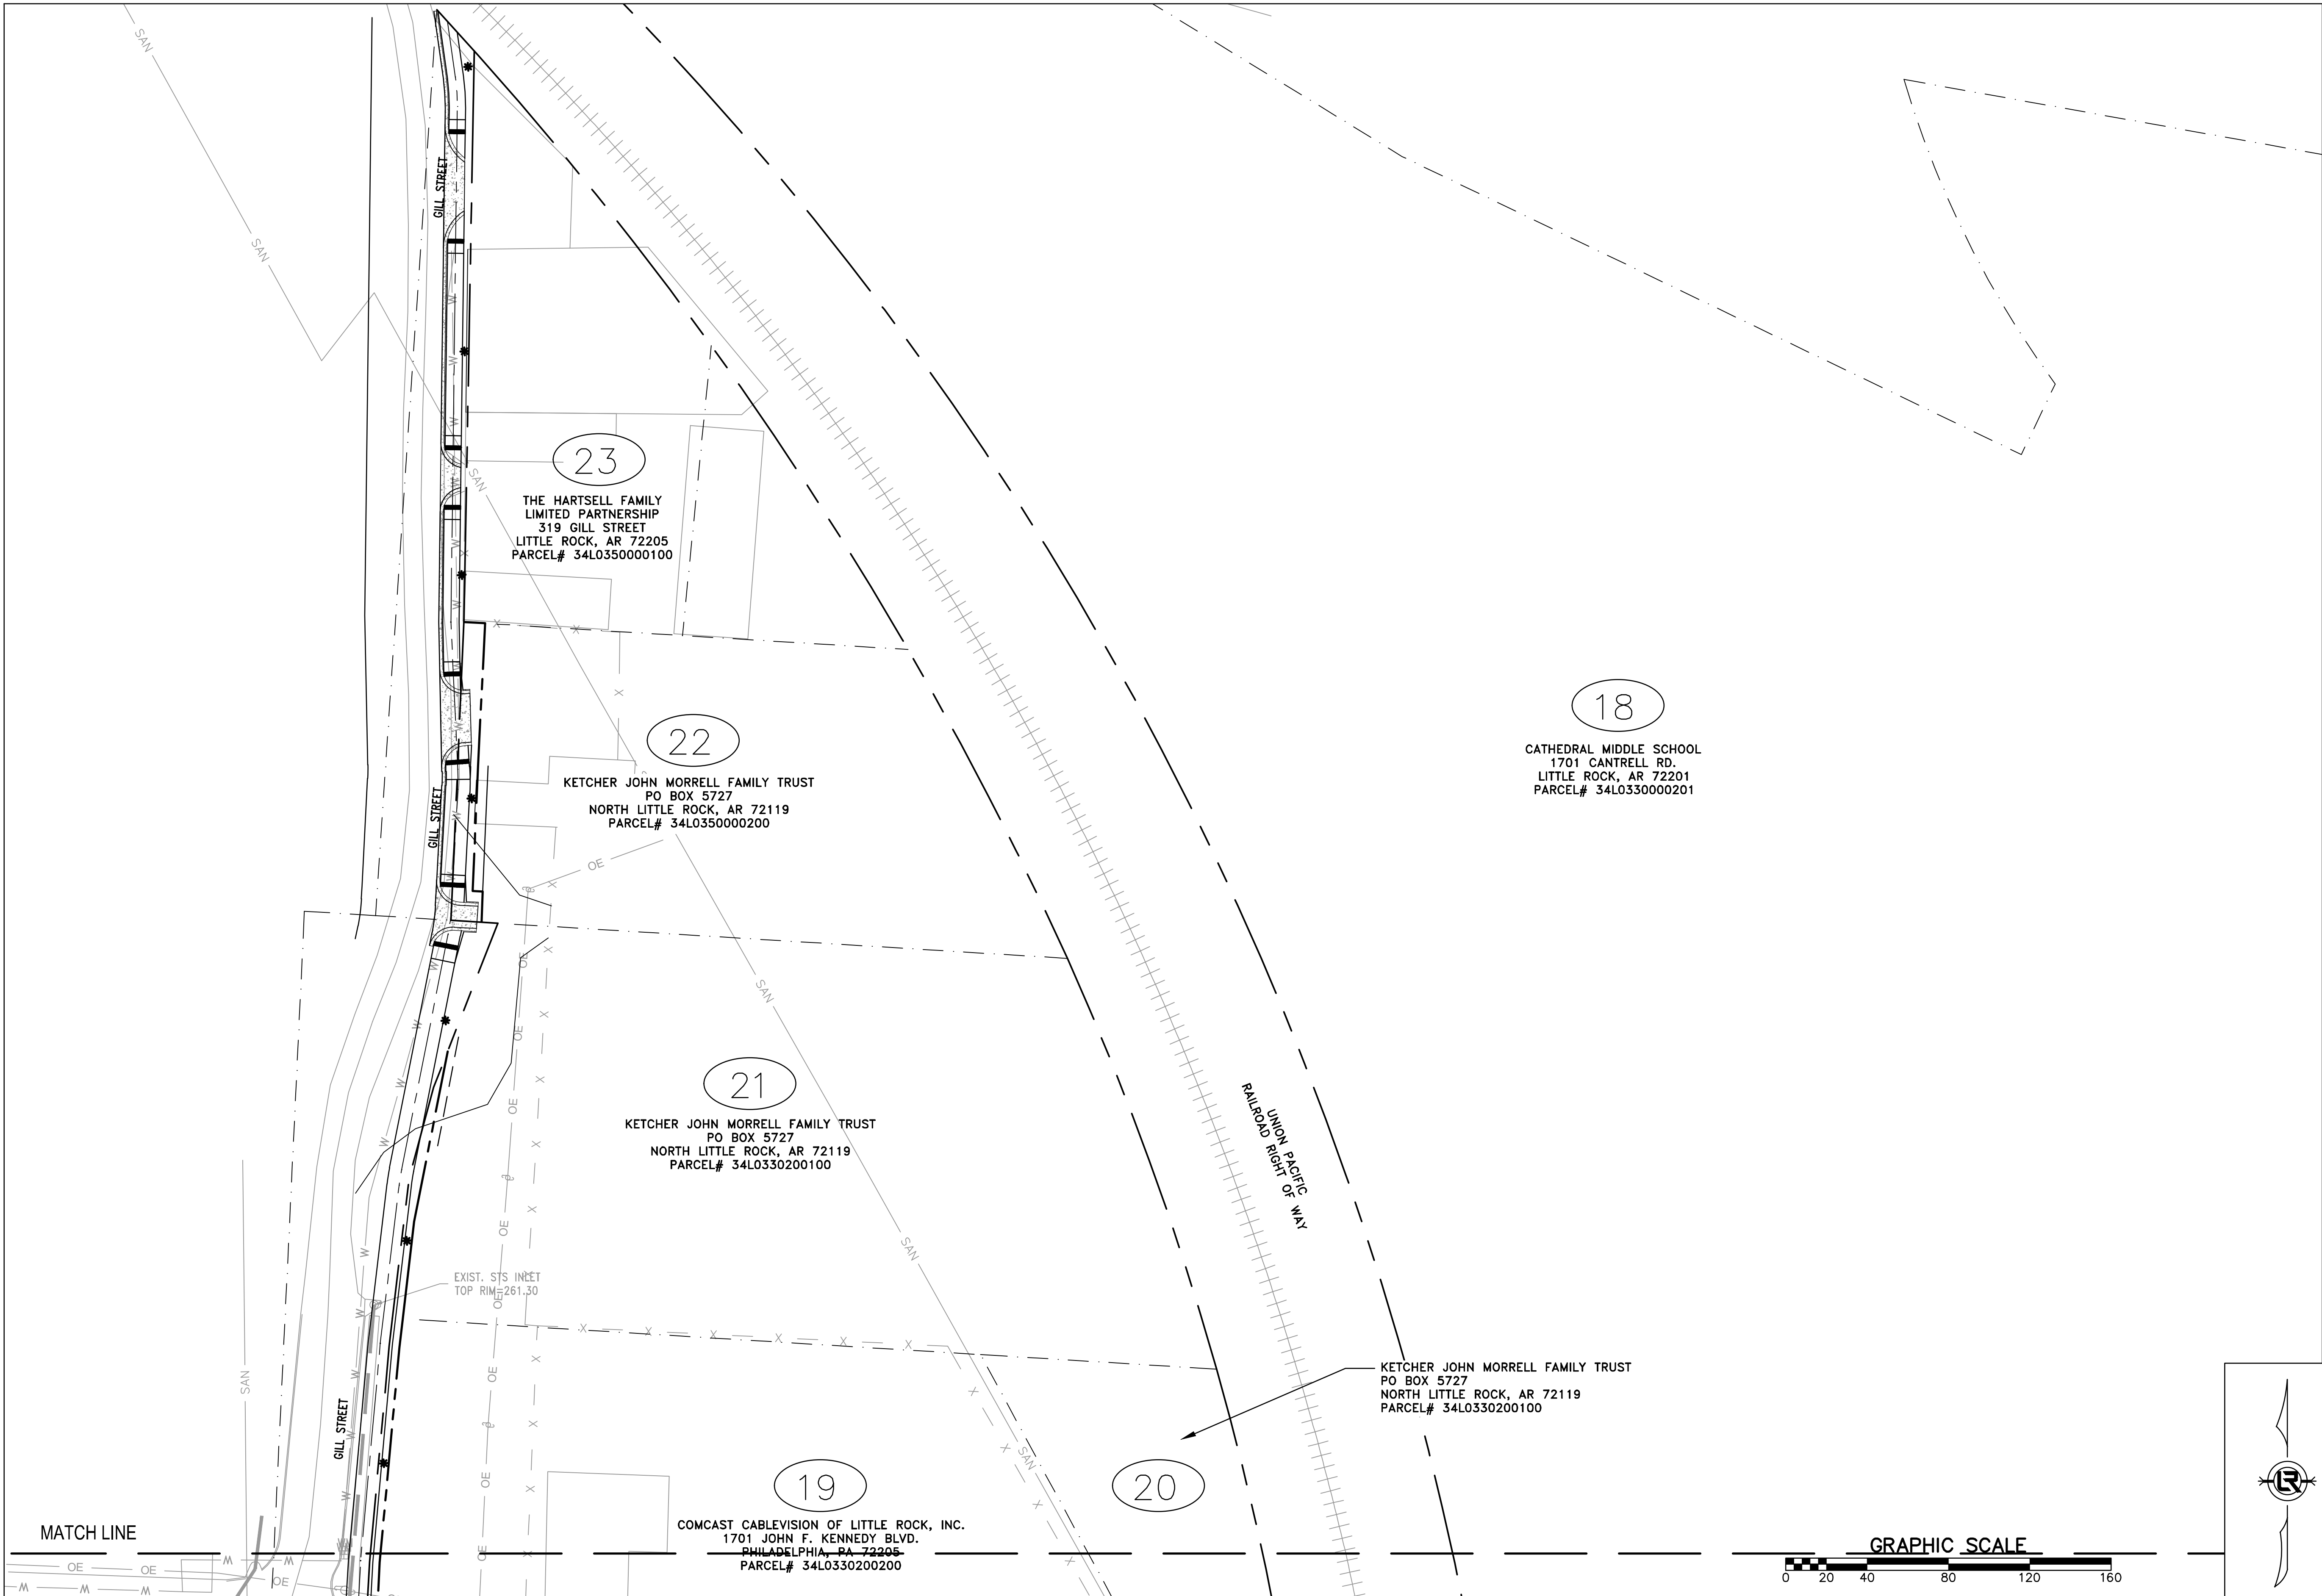

REVISIONS	DATE

CITY OF LITTLE ROCK, ARKANSAS

ROSE CREEK TRAIL

OVERALL SITE SHEET

DEPARTMENT OF PUBLIC WORKS

CIVIL ENGINEERING

701 W. MARKHAM

LITTLE ROCK, ARKANSAS 72201



STATE OF ARKANSAS

REGISTERED PROFESSIONAL ENGINEER

BRADLEY A. PETERSON

No. 13217

9/3/26

DRAWN BY

AS

DESIGNED

LC

CHECKED

JM

DATE

05-01-2026

SCALE

H: 1"=20'


V: 1"=120'

PROJECT NO.

23805201

SHEET NO.

C11

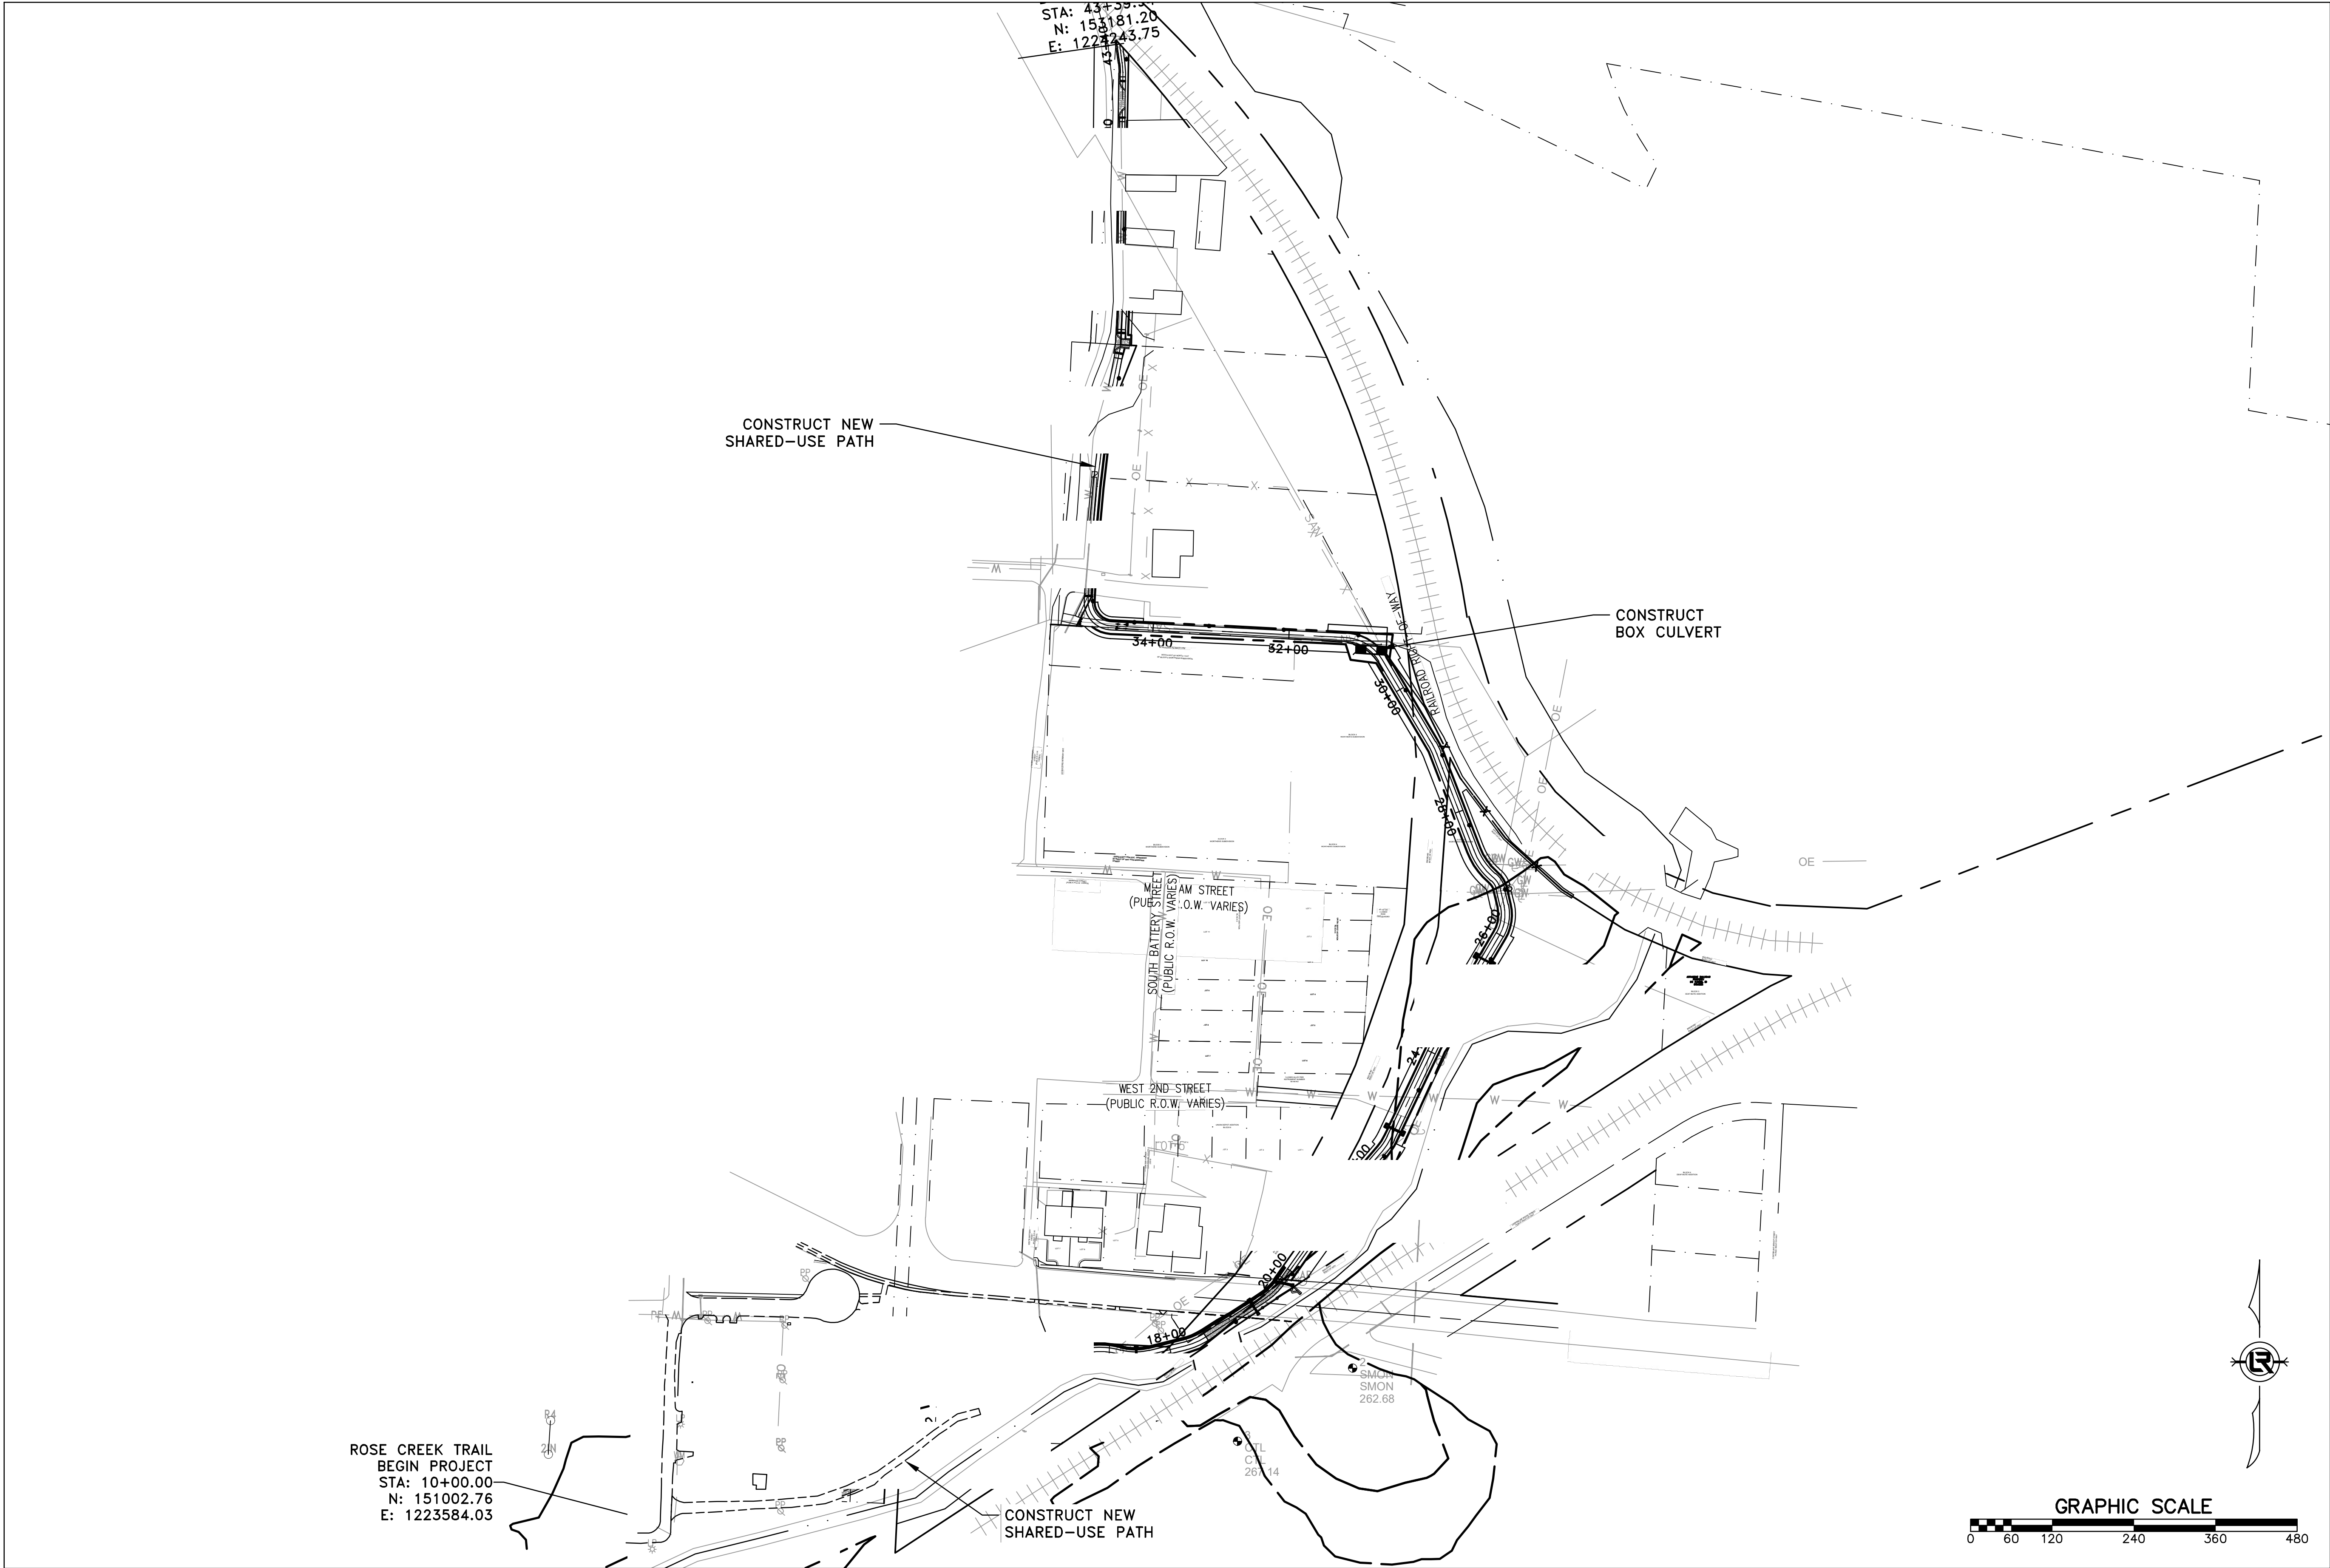

REVISIONS	DATE


CITY OF LITTLE ROCK, ARKANSAS
ROSE CREEK TRAIL
SITE ENLARGEMENT SHEET 1

DEPARTMENT OF PUBLIC WORKS
CIVIL ENGINEERING
701 W. MARKHAM
LITTLE ROCK, ARKANSAS 72201

ARK
REGISTERED PROFESSIONAL ENGINEER
No. 13217
BRADLEY A. PETERSON
9/3/26



DRAWN BY	AS
DESIGNED	LC
CHECKED	JM
DATE	05-01-2026
SCALE	1"=50'
PROJECT NO.	23805201
SHEET NO.	C12

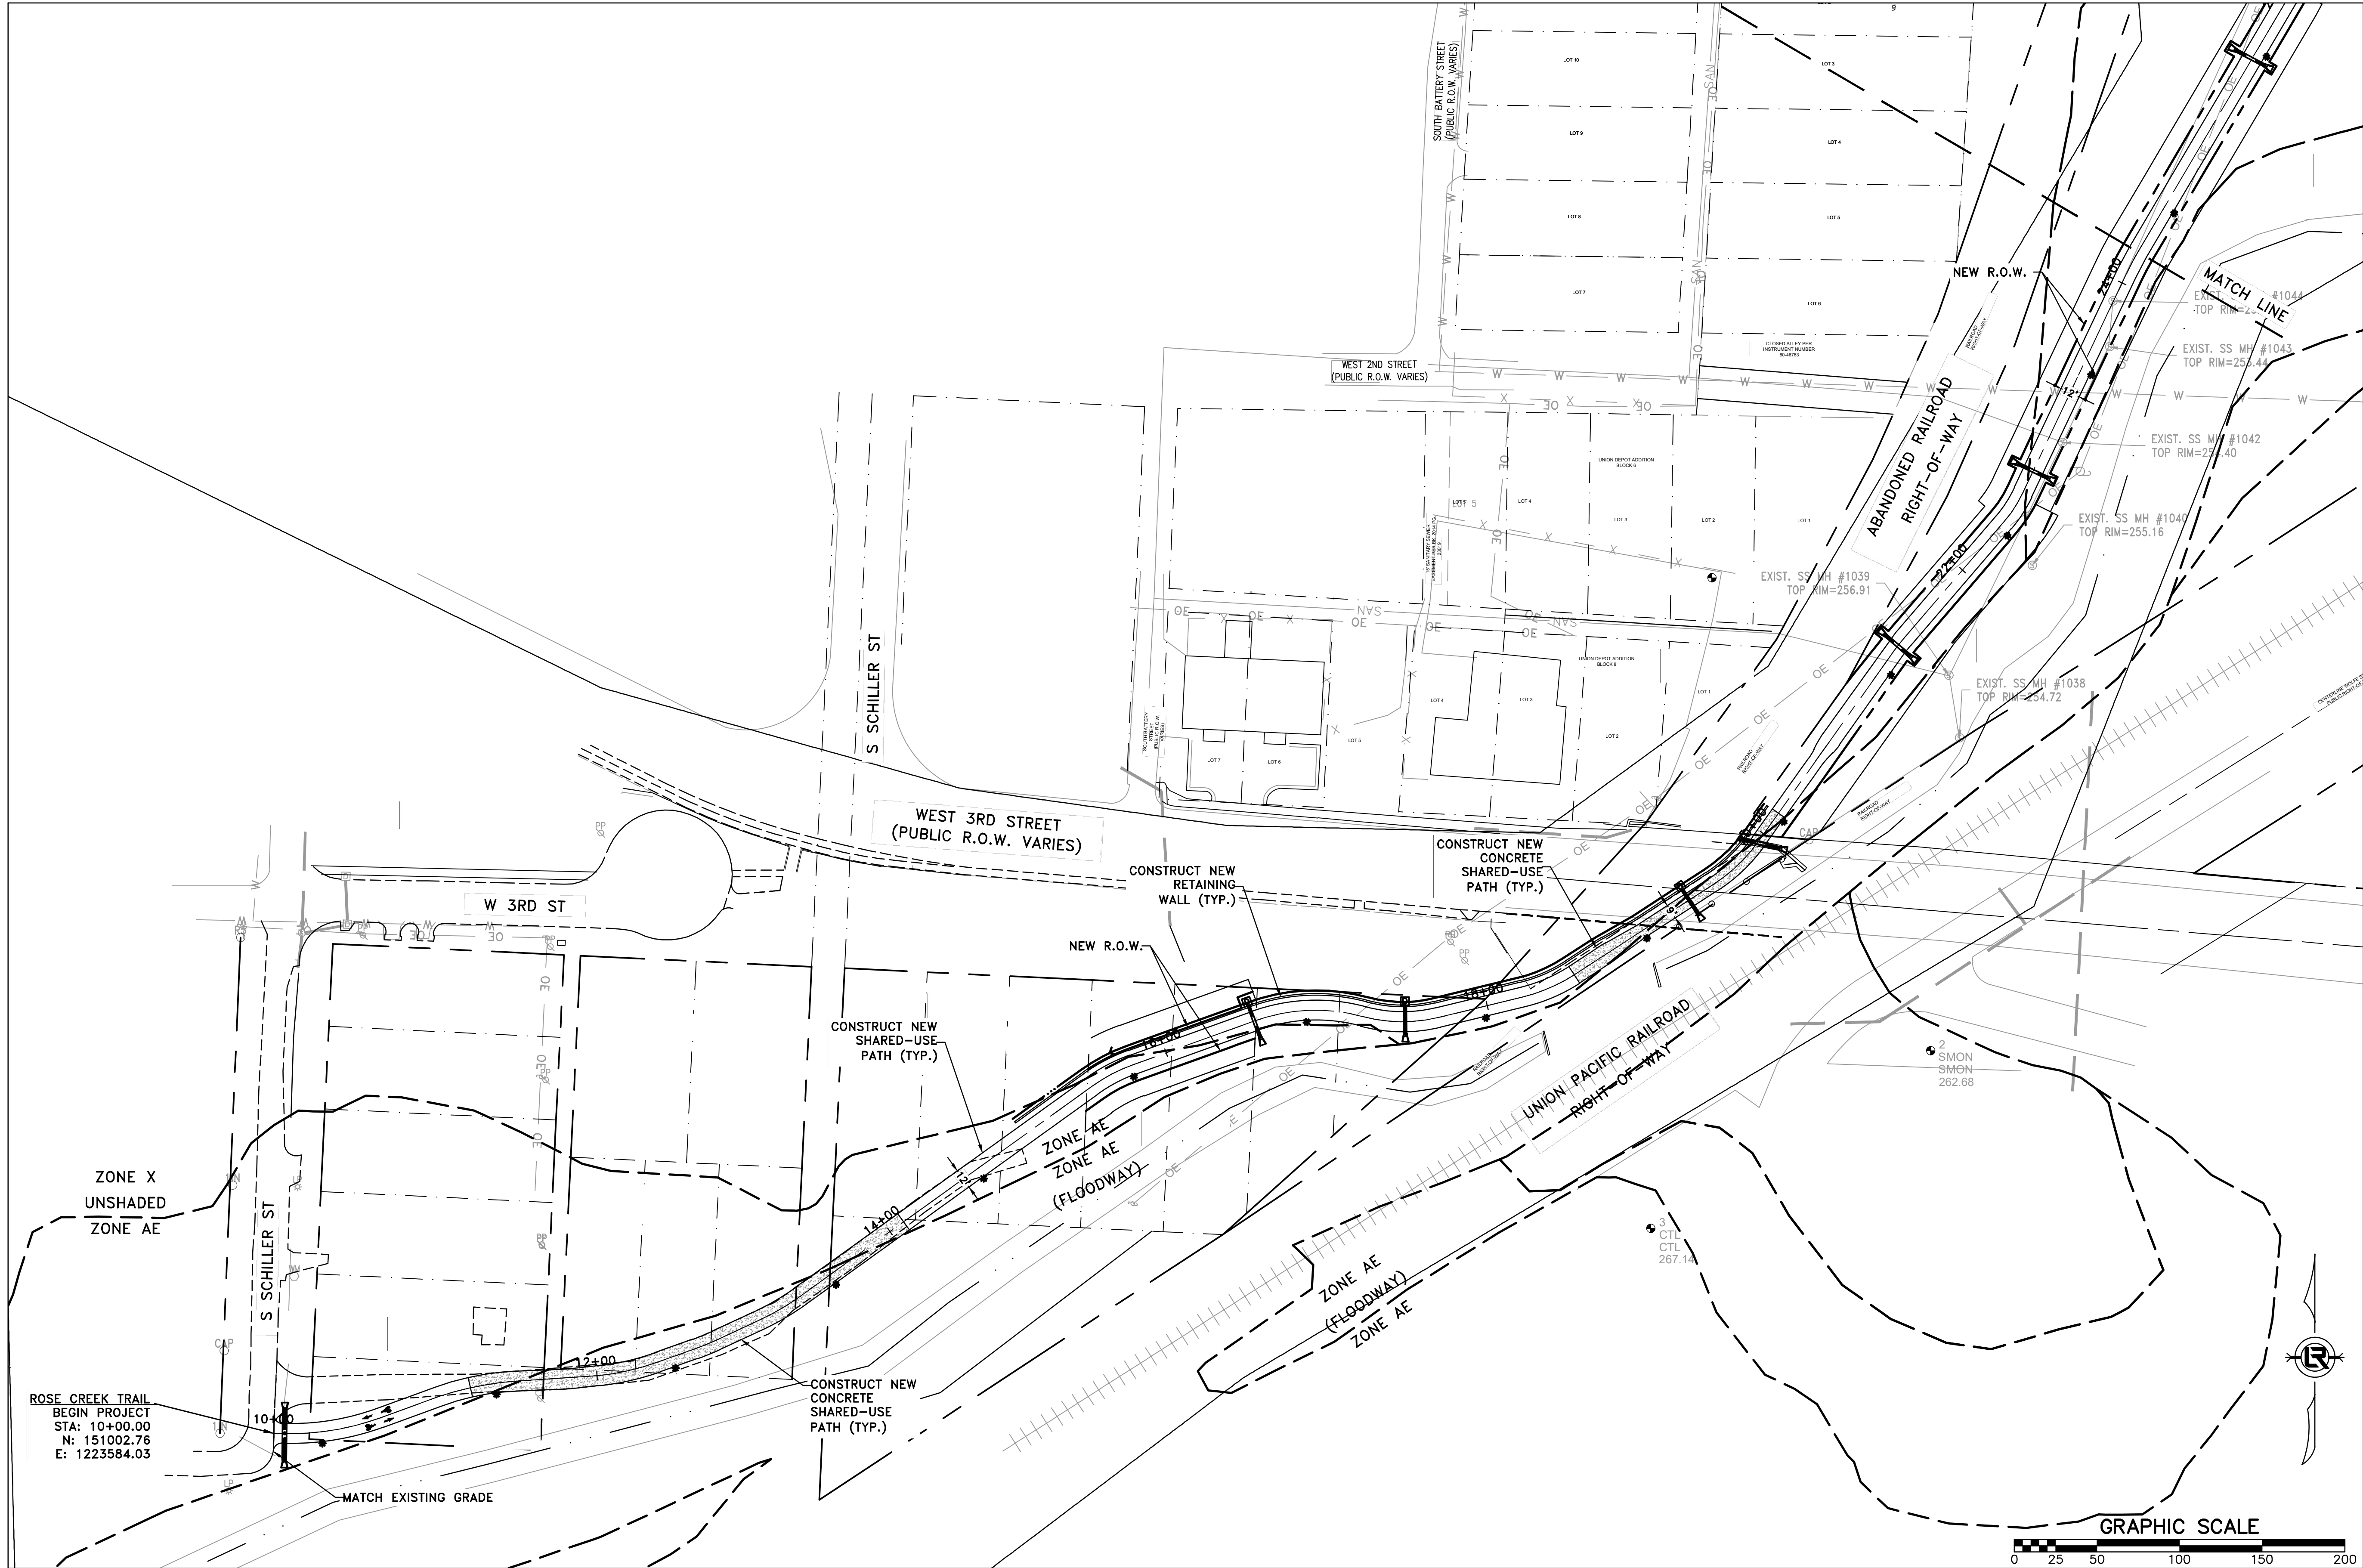

REVISIONS	DATE

CITY OF LITTLE ROCK, ARKANSAS
ROSE CREEK TRAIL
SITE ENLARGEMENT SHEET 2


DEPARTMENT OF PUBLIC WORKS
CIVIL ENGINEERING
701 W. MARKHAM
LITTLE ROCK, ARKANSAS 72201



STATE OF ARKANSAS
REGISTERED PROFESSIONAL ENGINEER
No. 13217
BRADLEY A. PETERSON
9/3/26



DRAWN BY	AS
DESIGNED	LC
CHECKED	JM
DATE	05-01-2026
SCALE	1"=50'
PROJECT NO.	23805201
SHEET NO.	C13

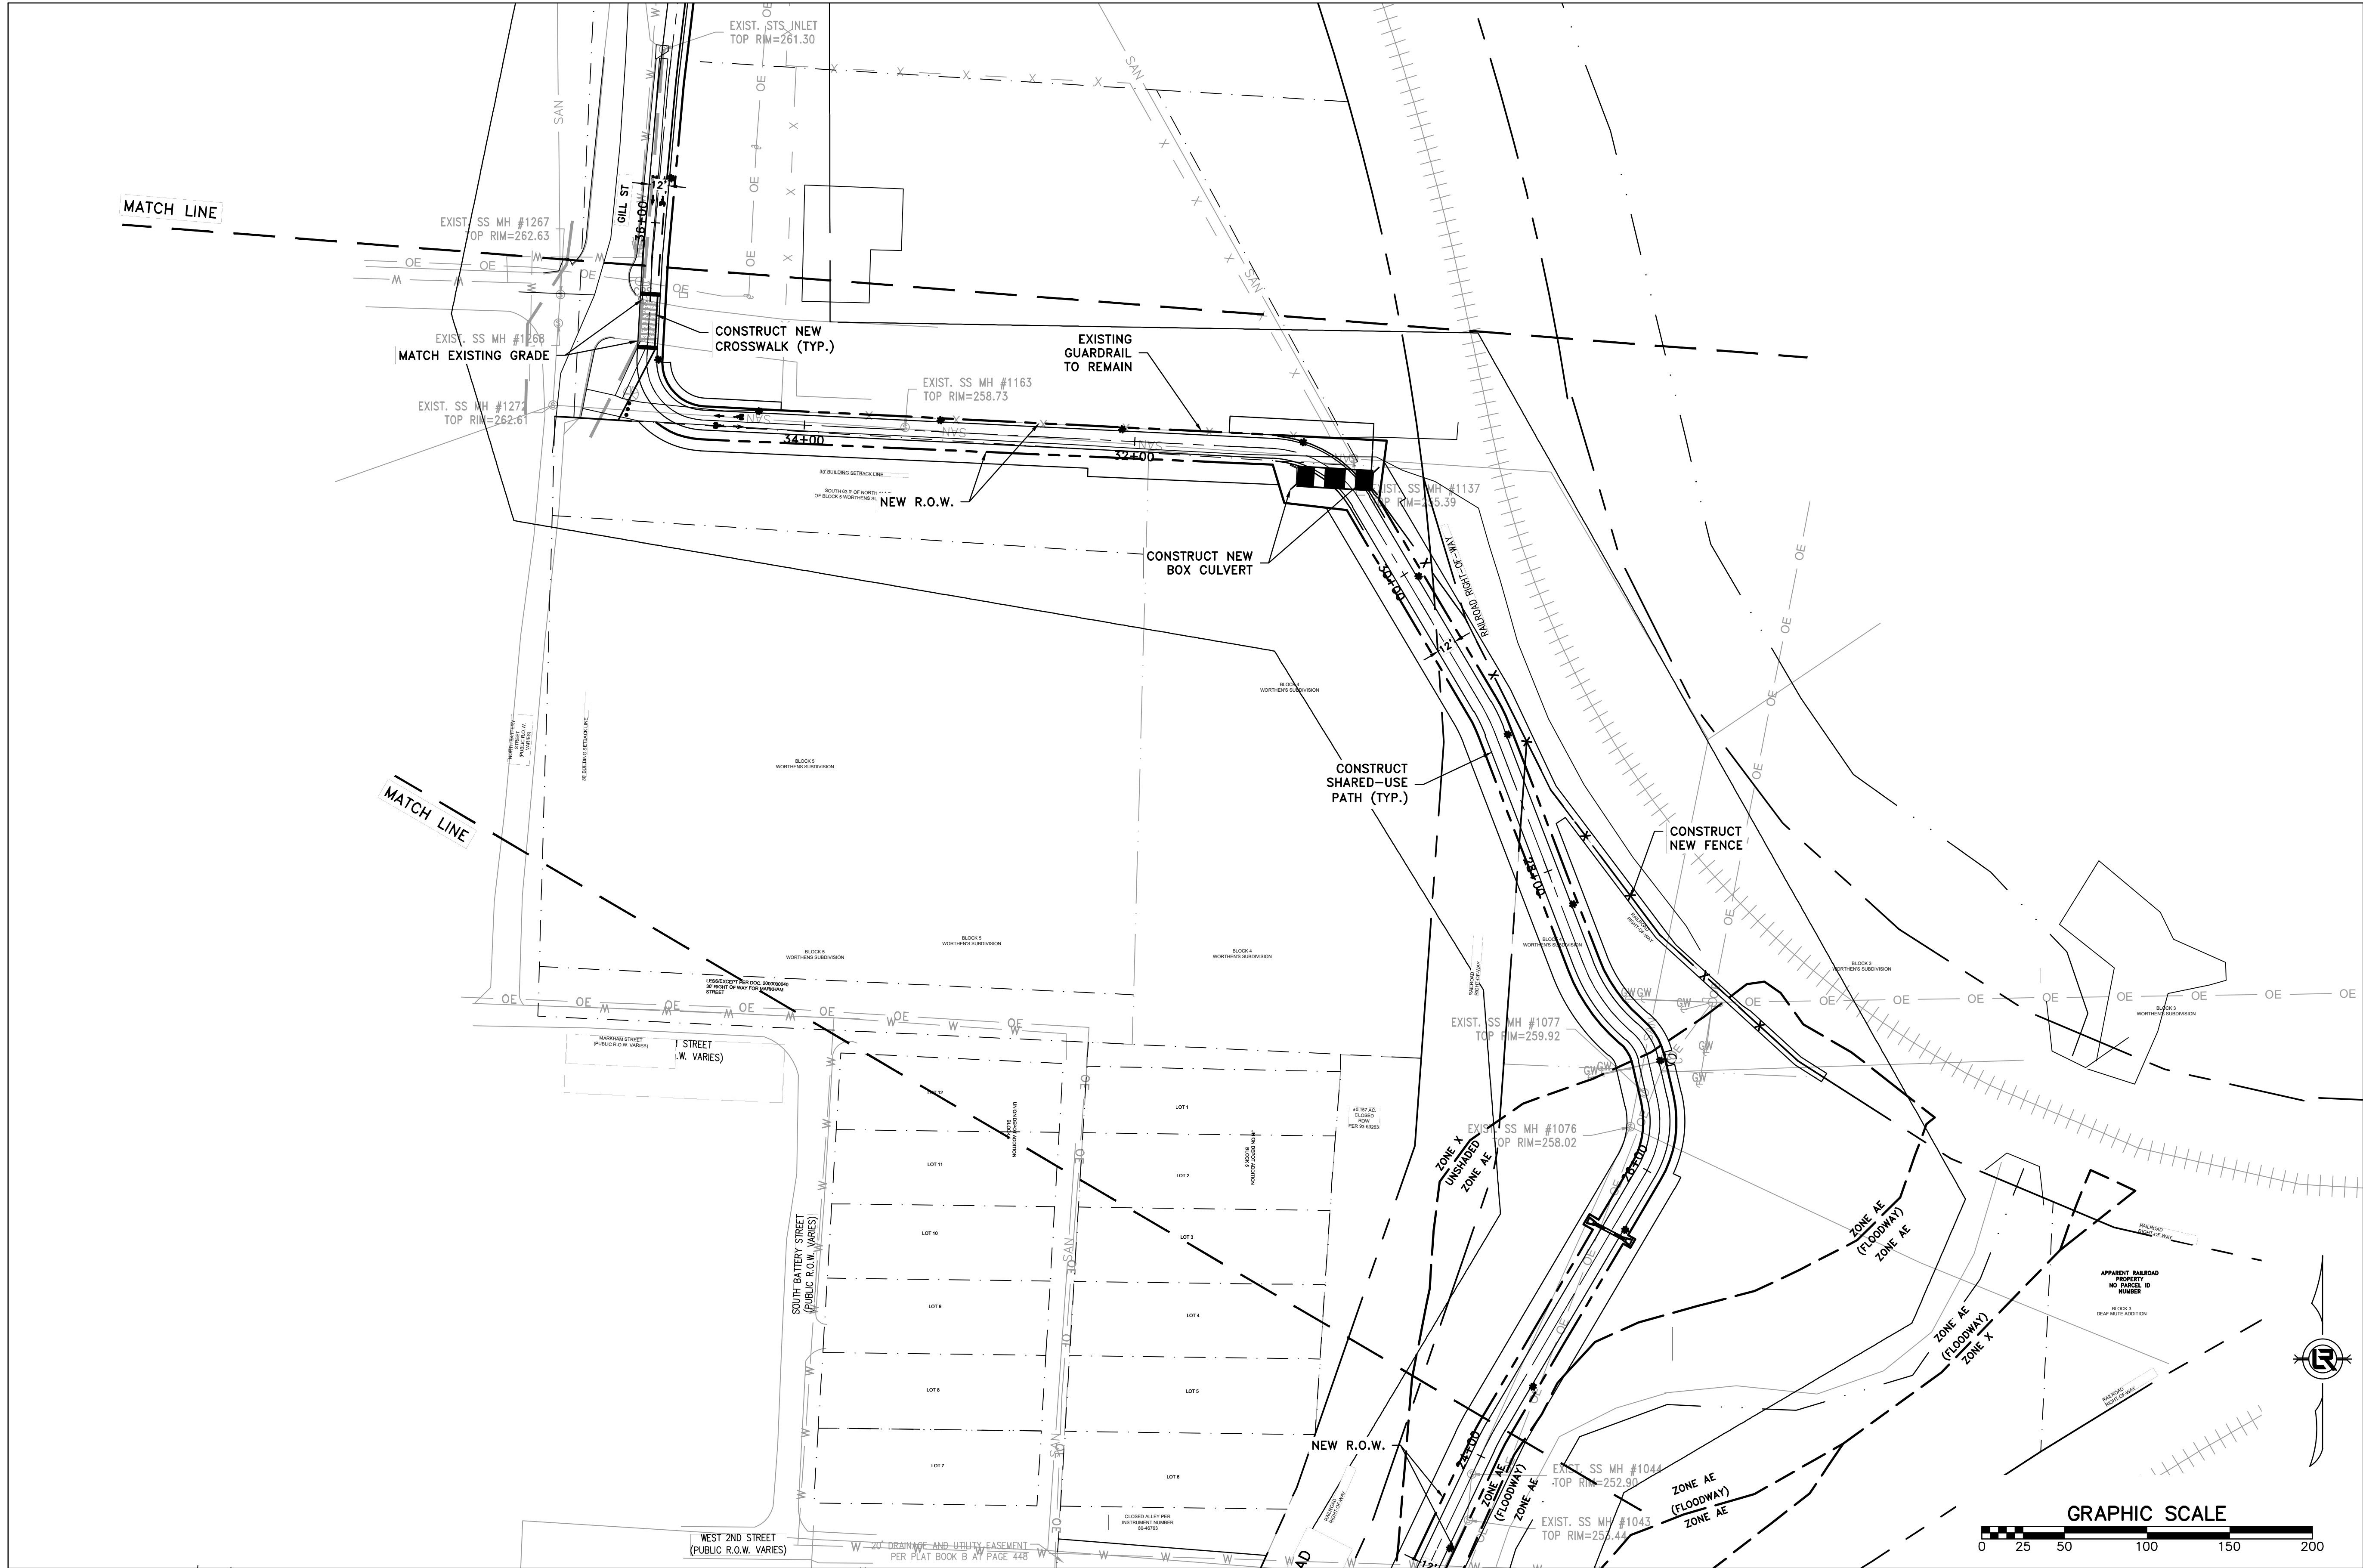

REVISIONS	DATE

CITY OF LITTLE ROCK, ARKANSAS

ROSE CREEK TRAIL

SITE ENLARGEMENT SHEET 3

DEPARTMENT OF PUBLIC WORKS

CIVIL ENGINEERING

701 W. MARKHAM

LITTLE ROCK, ARKANSAS 72201



STATE OF ARKANSAS

REGISTERED PROFESSIONAL ENGINEER

BRADLEY A. PETERSON

No. 13217

9/3/26

DRAWN BY

AS

DESIGNED

LC

CHECKED

JM

DATE

05-01-2026

SCALE


1"=50'



PROJECT NO.

23805201

SHEET NO.

C14

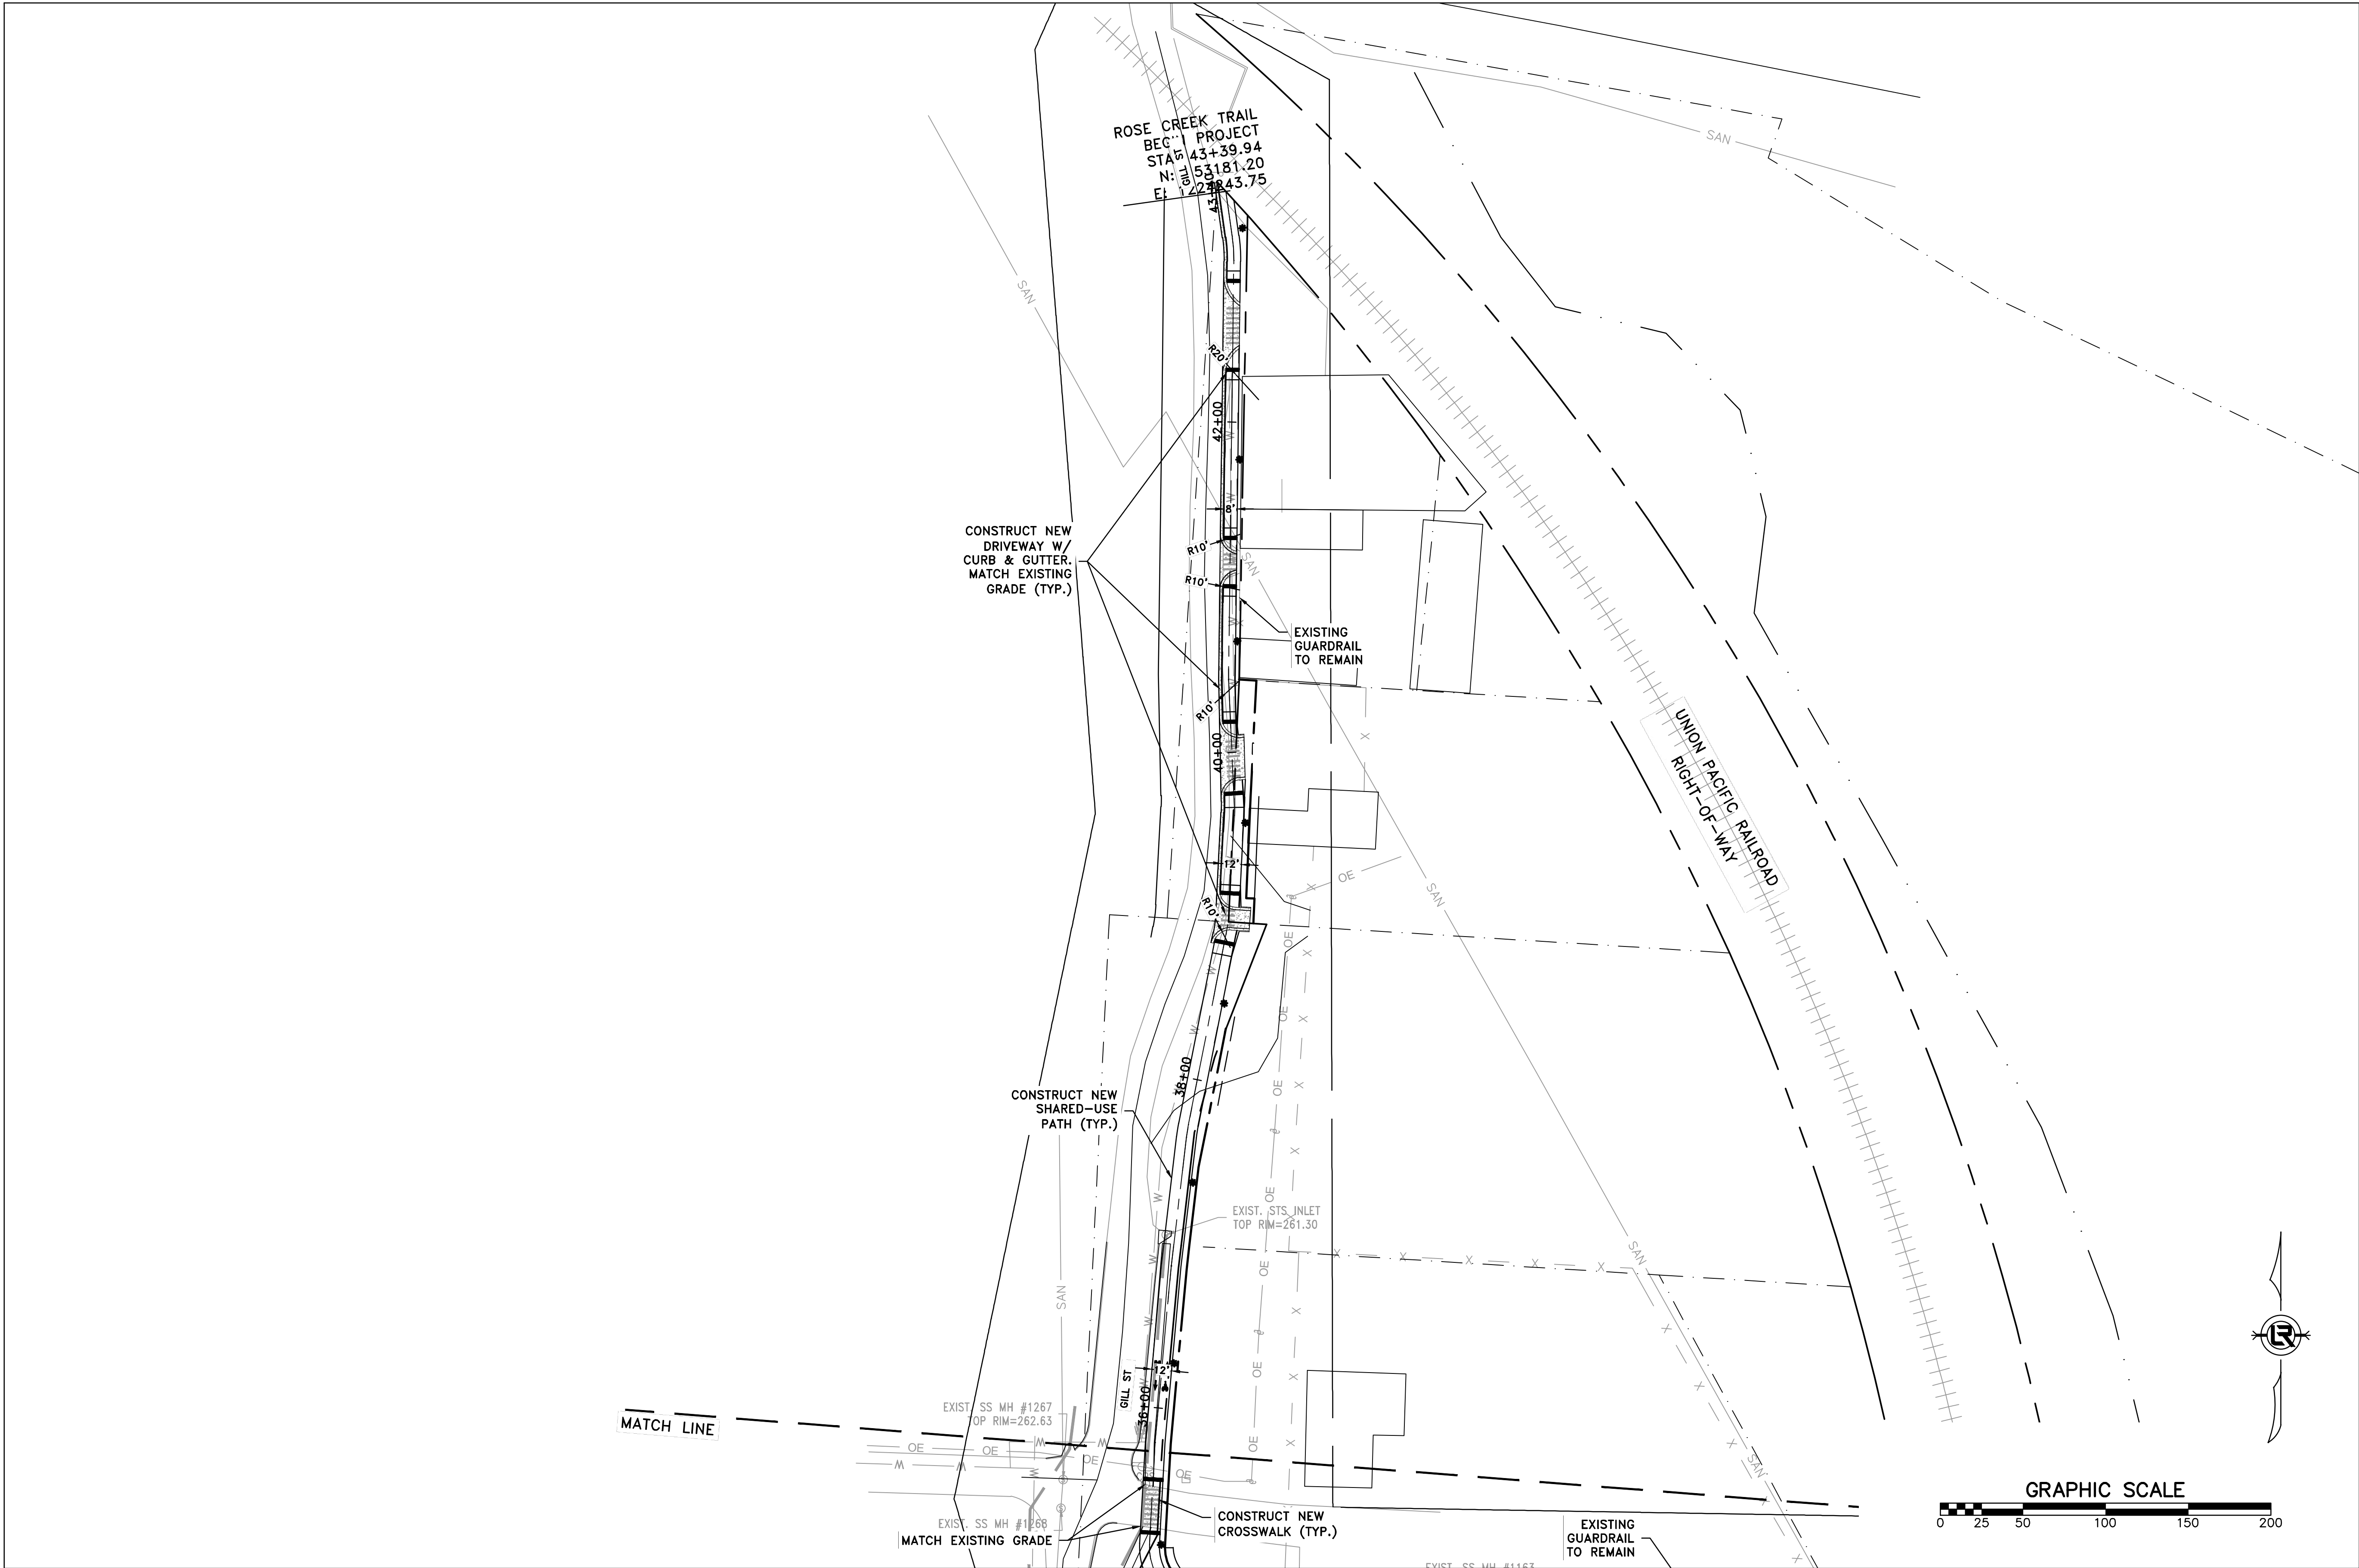

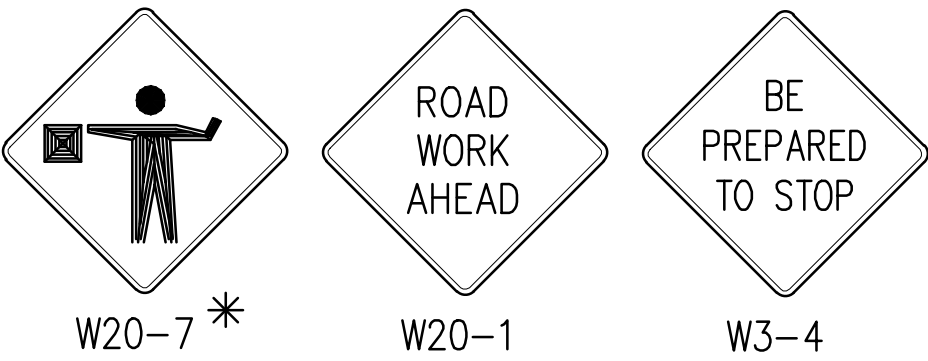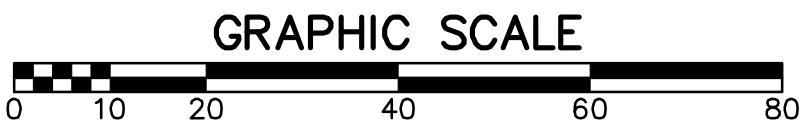

END
ROAD WORK
G20-2


FURNISH & INSTALL TRAFFIC
BARRELS @ 10' O.C. FOR
LANE CLOSURE DURING
WORKING HOURS

END
ROAD WORK
G20-2

KATHERINE ELIZABETH LITWA
PO BOX 5727
NORTH LITTLE ROCK, AR 72119
PARCEL# 34L0350000200

DIRECTIONAL ARROW SHOWN
FOR INFORMATION ONLY NOT
TO BE INSTALLED (TYP.)

THE HARTSELL FAMILY
LIMITED PARTNERSHIP
319 GILL STREET
LITTLE ROCK, AR 72205
PARCEL# 34L0350000100

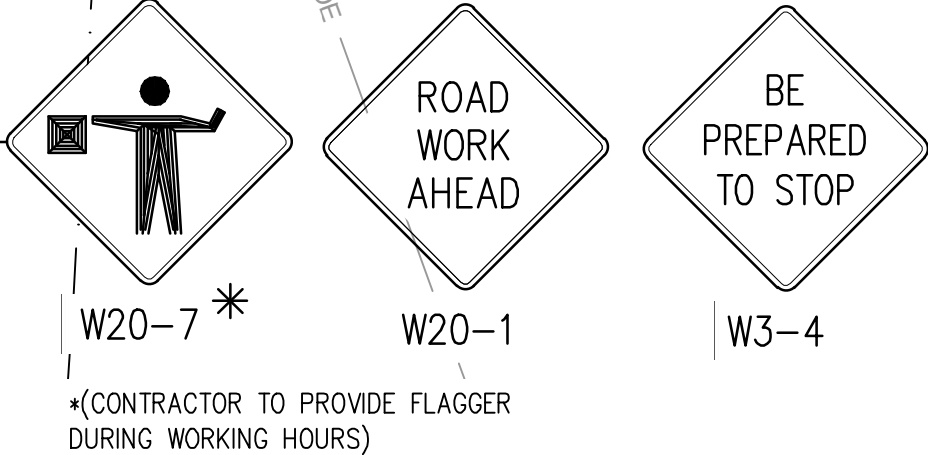

PHASE I CONSTRUCTION

REVISIONS	DATE

CITY OF LITTLE ROCK, ARKANSAS	MAINTENANCE OF TRAFFIC
ROSE CREEK TRAIL	

DEPARTMENT OF PUBLIC WORKS	CIVIL ENGINEERING 701 W. MARKHAM LITTLE ROCK, ARKANSAS 72201
CIVIL ENGINEERING	



DRAWN BY	AS
DESIGNED	LC
CHECKED	JM
DATE	05-01-2026
SCALE	1"=20'
PROJECT NO.	23805201
SHEET NO.	C15

REVISIONS	DATE

CITY OF LITTLE ROCK, ARKANSAS

ROSE CREEK TRAIL

STRIPING & SIGNAGE SHEET 1

DEPARTMENT OF PUBLIC WORKS

CIVIL ENGINEERING

701 W. MARKHAM

LITTLE ROCK, ARKANSAS 72201



STATE OF ARKANSAS

REGISTERED PROFESSIONAL ENGINEER

BRADLEY A. PETERSON

9/3/26

DRAWN BY AS

DESIGNED LC



CHECKED JM

DATE 05-01-2026

SCALE H: 1"=20' L: 1"=50'

PROJECT NO. 23805201

SHEET NO. C16

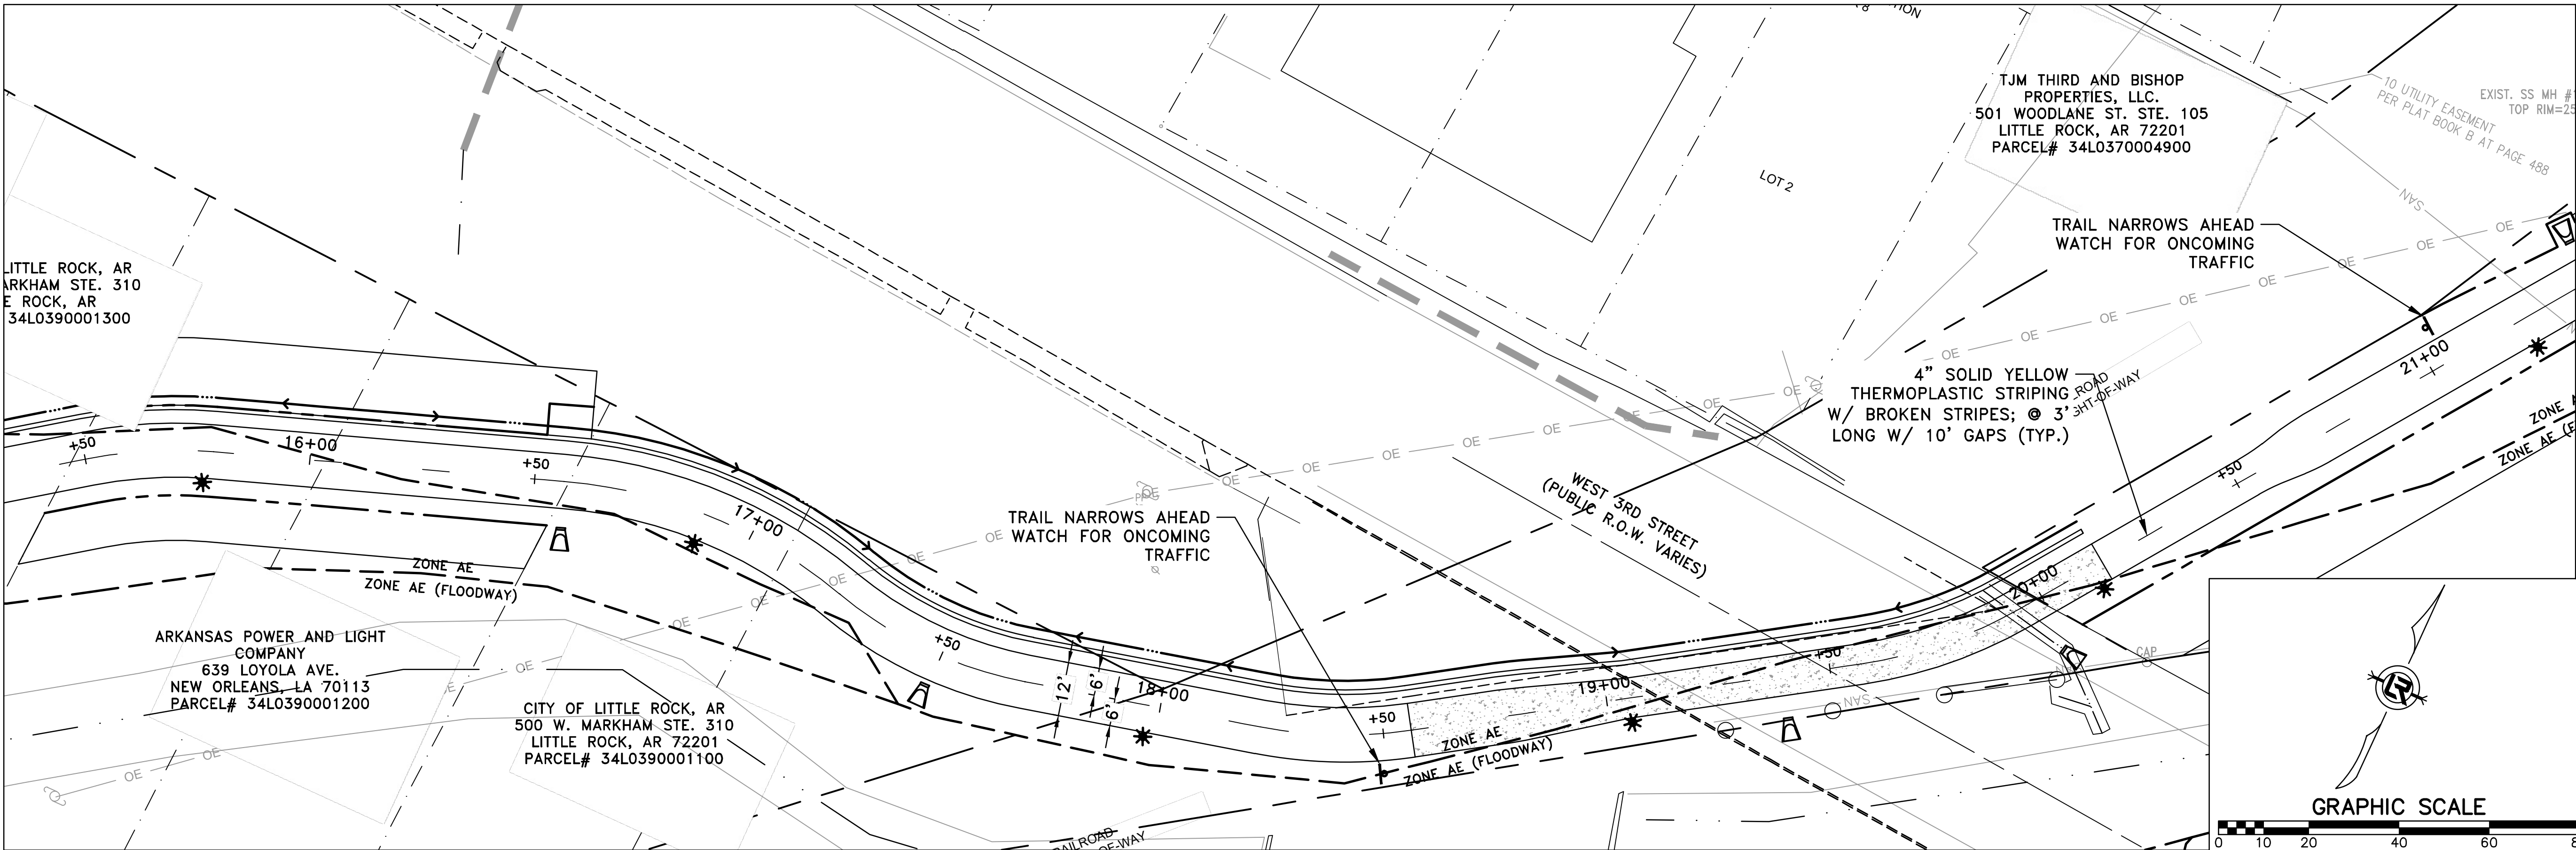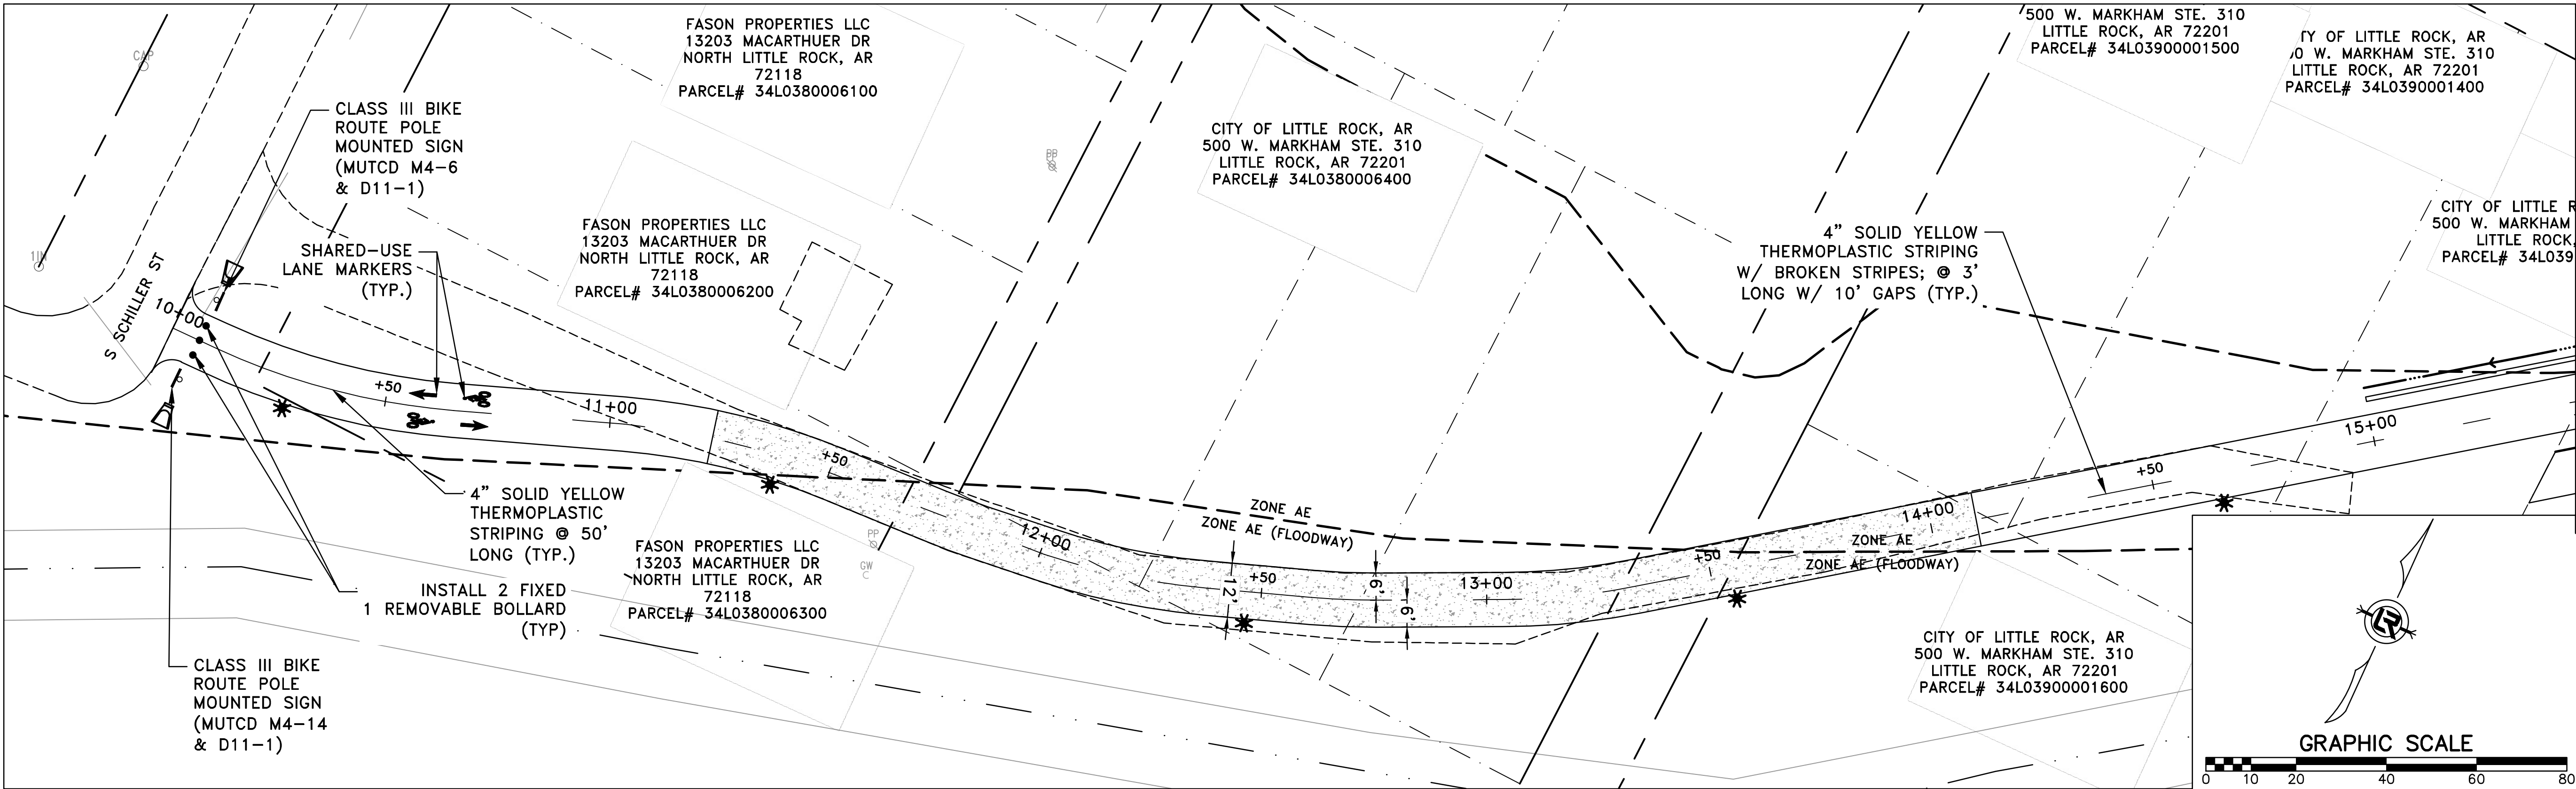

100% SUBMITTAL

REVISIONS	DATE



CITY OF LITTLE ROCK, ARKANSAS
ROSE CREEK TRAIL
STRIPING & SIGNAGE SHEET 2

DEPARTMENT OF PUBLIC WORKS
CIVIL ENGINEERING
701 W. MARKHAM
LITTLE ROCK, ARKANSAS 72201





DRAWN BY	AS
DESIGNED	LC
CHECKED	JM
DATE	05-01-2026
SCALE	H: 1"=20' V: 1"=5'
PROJECT NO.	23805201
SHEET NO.	C17

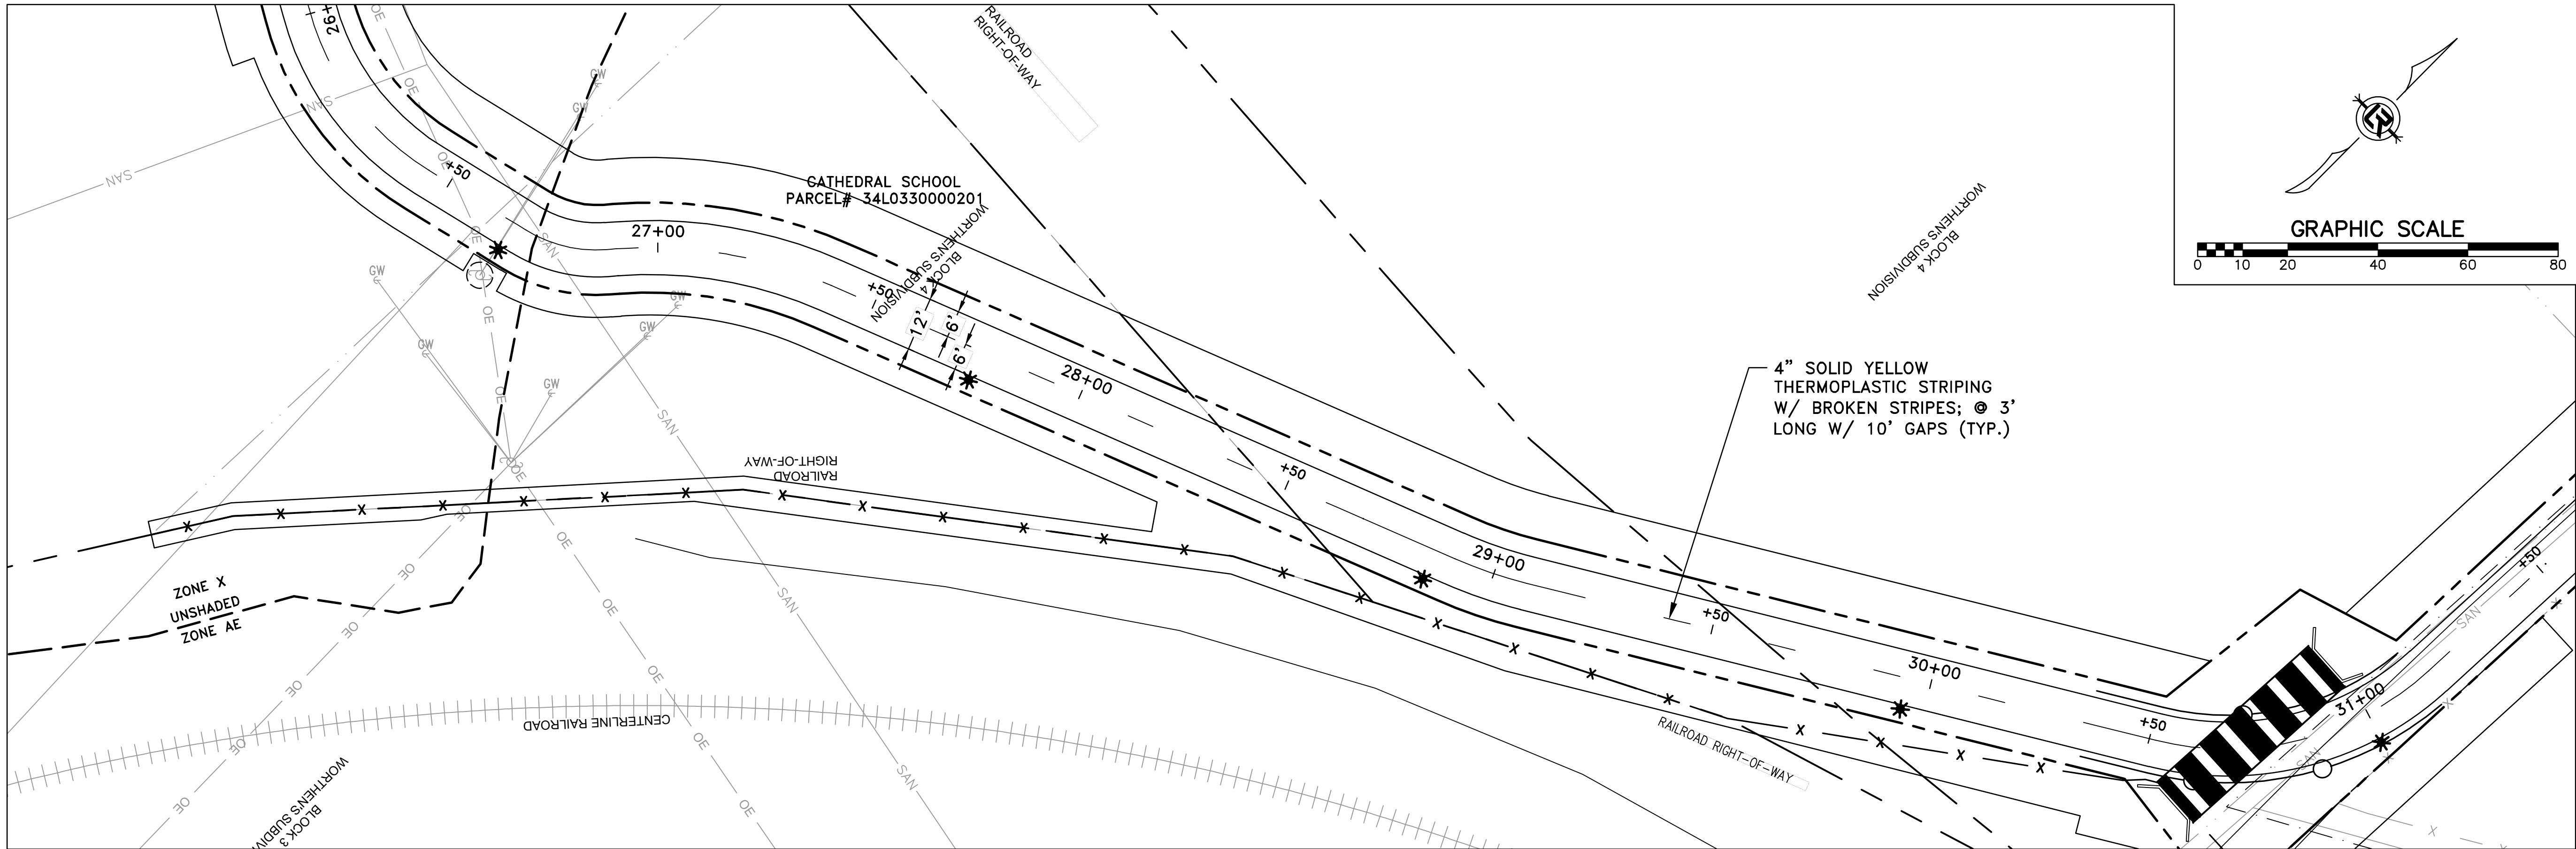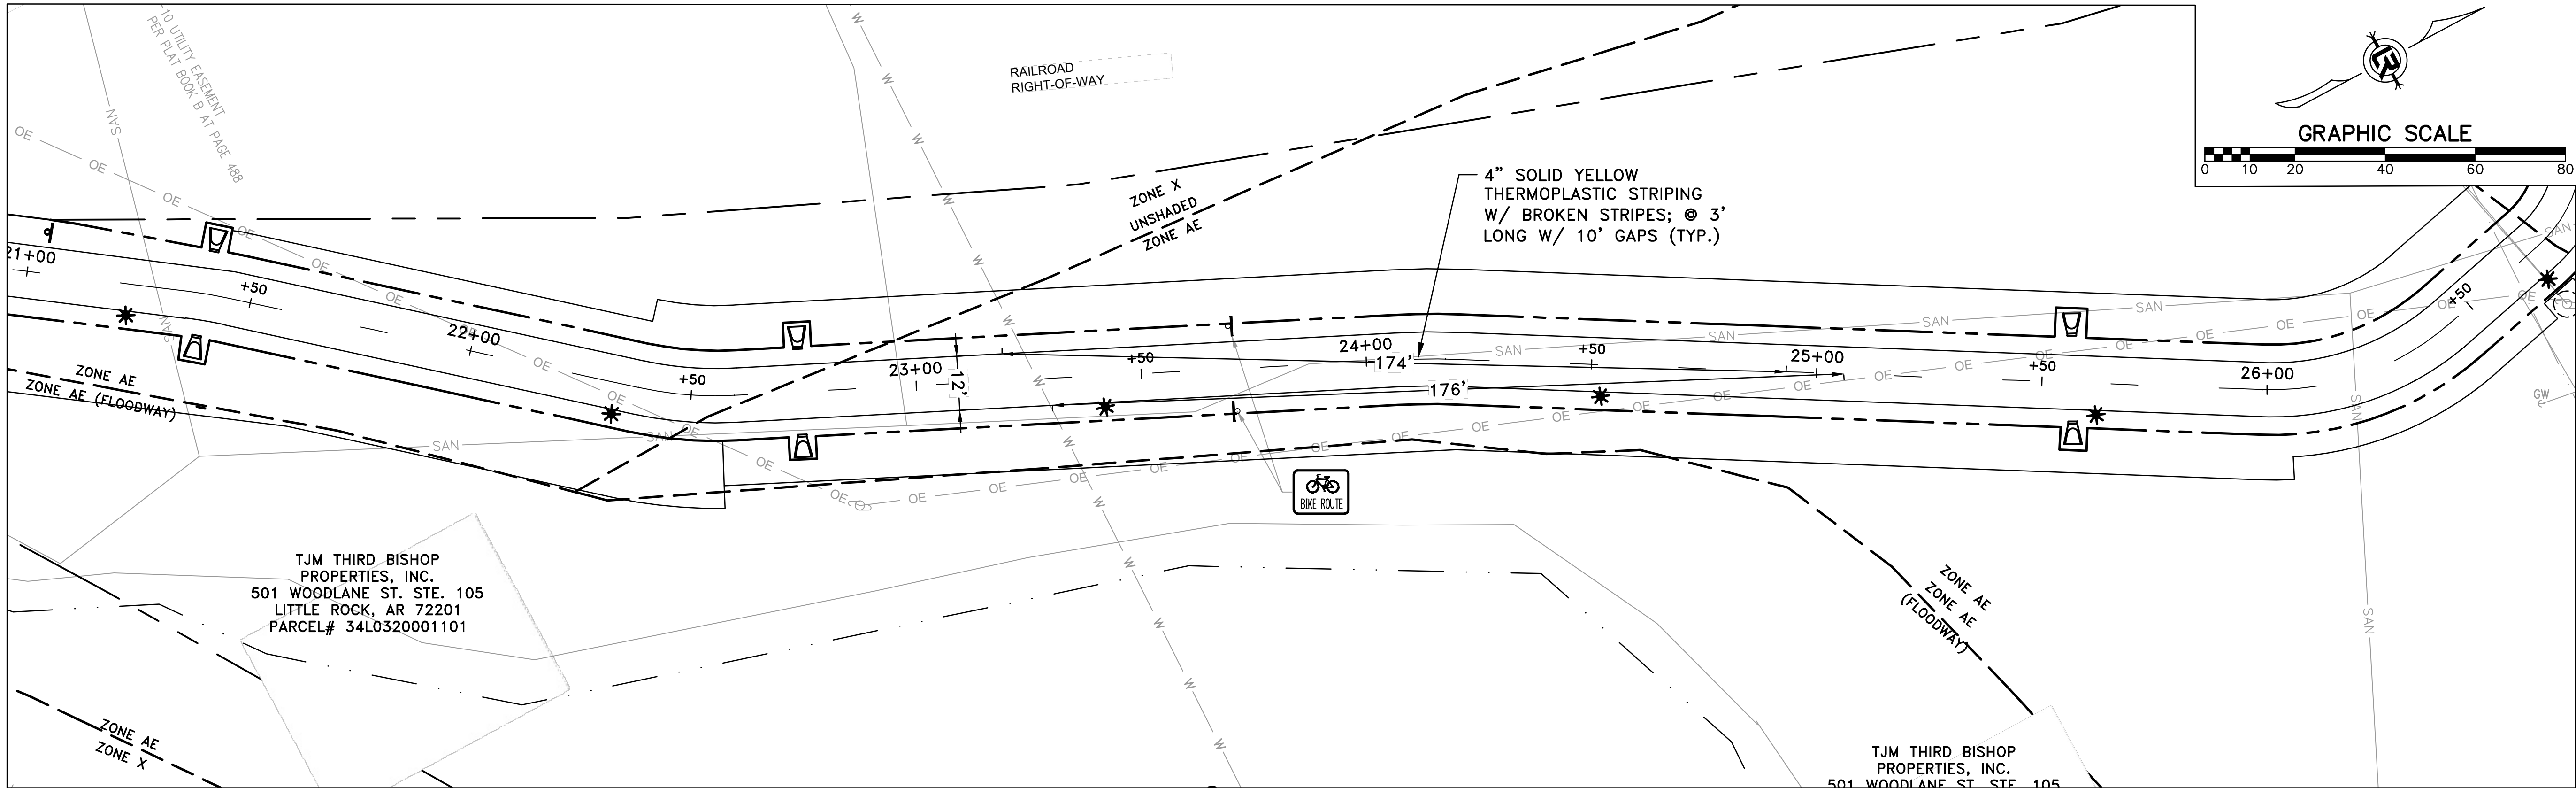

REVISIONS	DATE



CITY OF LITTLE ROCK, ARKANSAS
ROSE CREEK TRAIL
STRIPING & SIGNAGE SHEET 3

DEPARTMENT OF PUBLIC WORKS
CIVIL ENGINEERING
701 W. MARKHAM
LITTLE ROCK, ARKANSAS 72201



STATE OF ARKANSAS
REGISTERED PROFESSIONAL ENGINEER
No. 13217
BRADLEY A. PETERSON
9/3/26

DRAWN BY
AS
DESIGNED
LC
CHECKED
JM
DATE
05-01-2026
SCALE
H: 1"=20'
V: 1"=5'
PROJECT NO.
23805201
SHEET NO.
C18

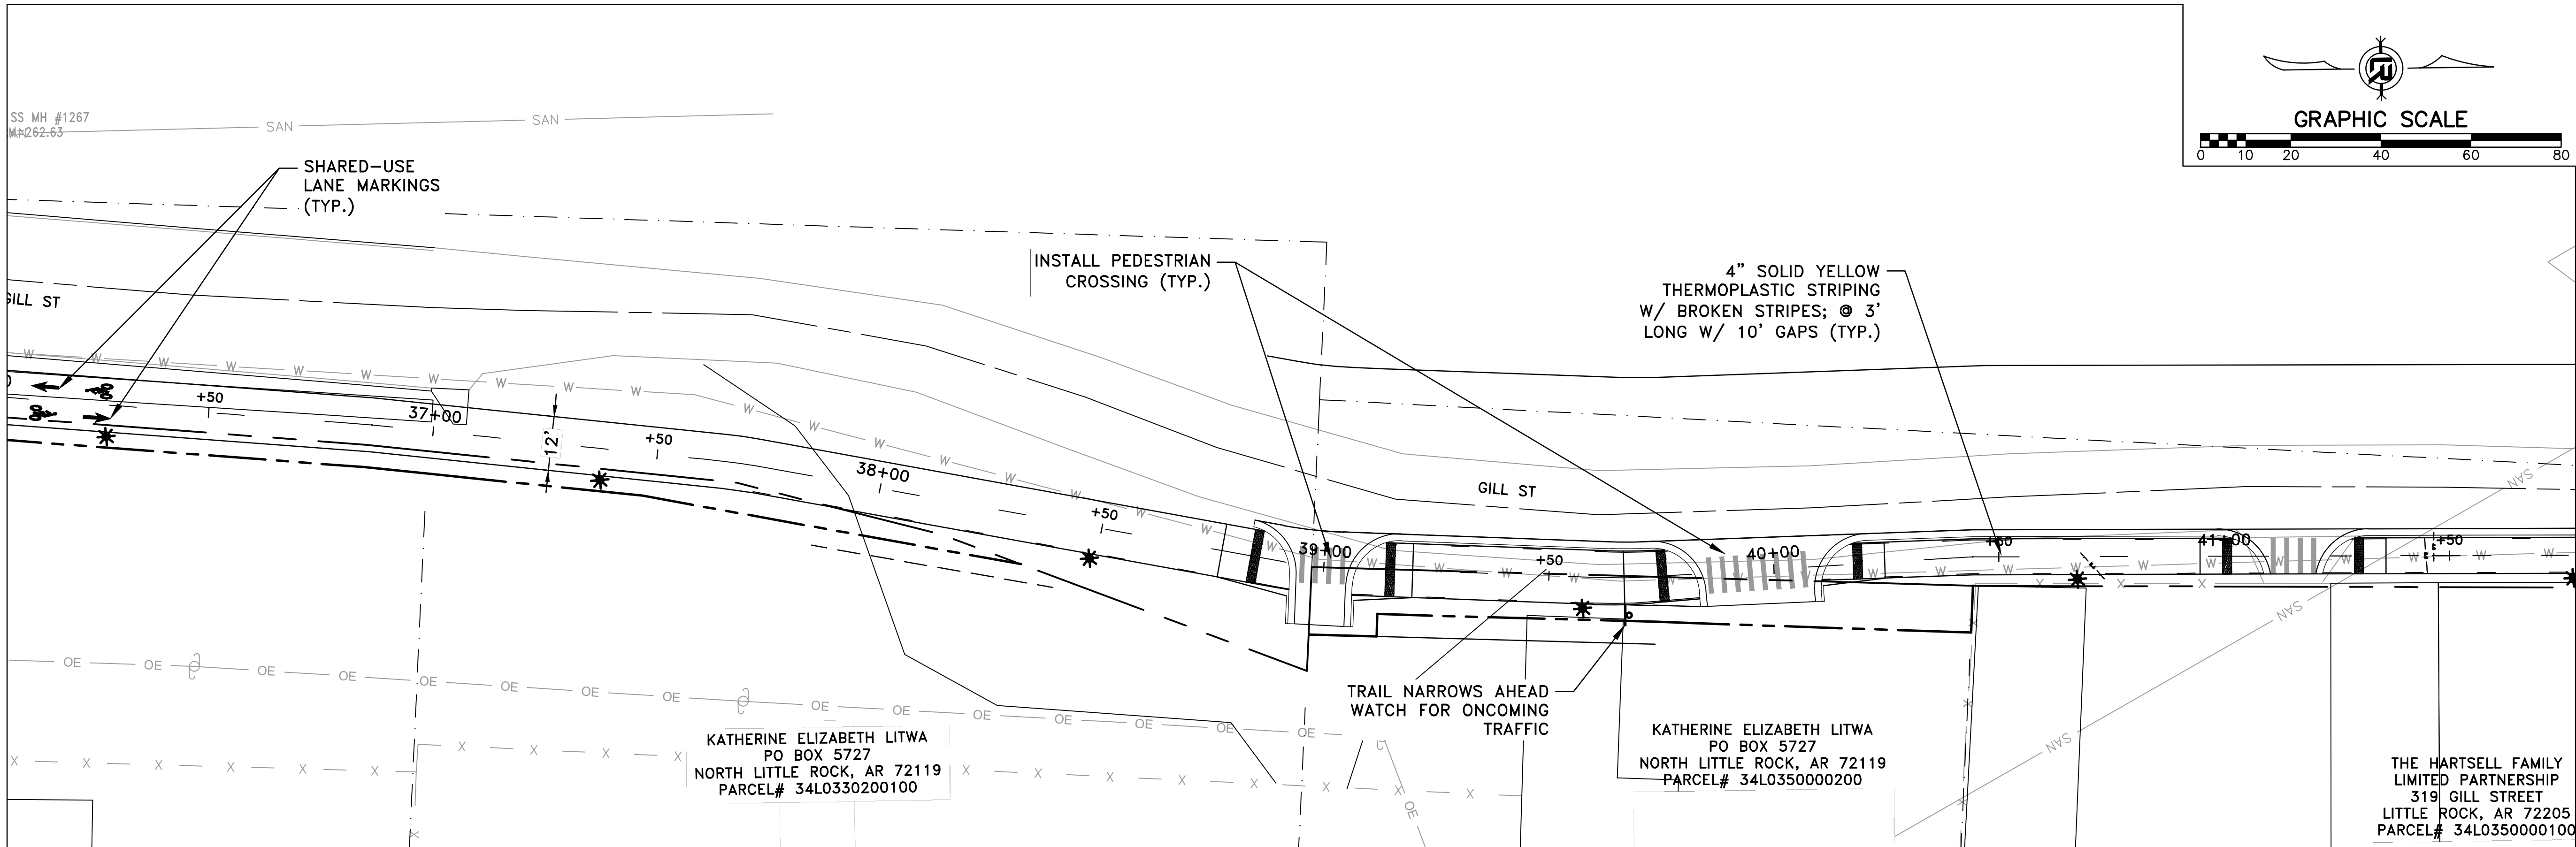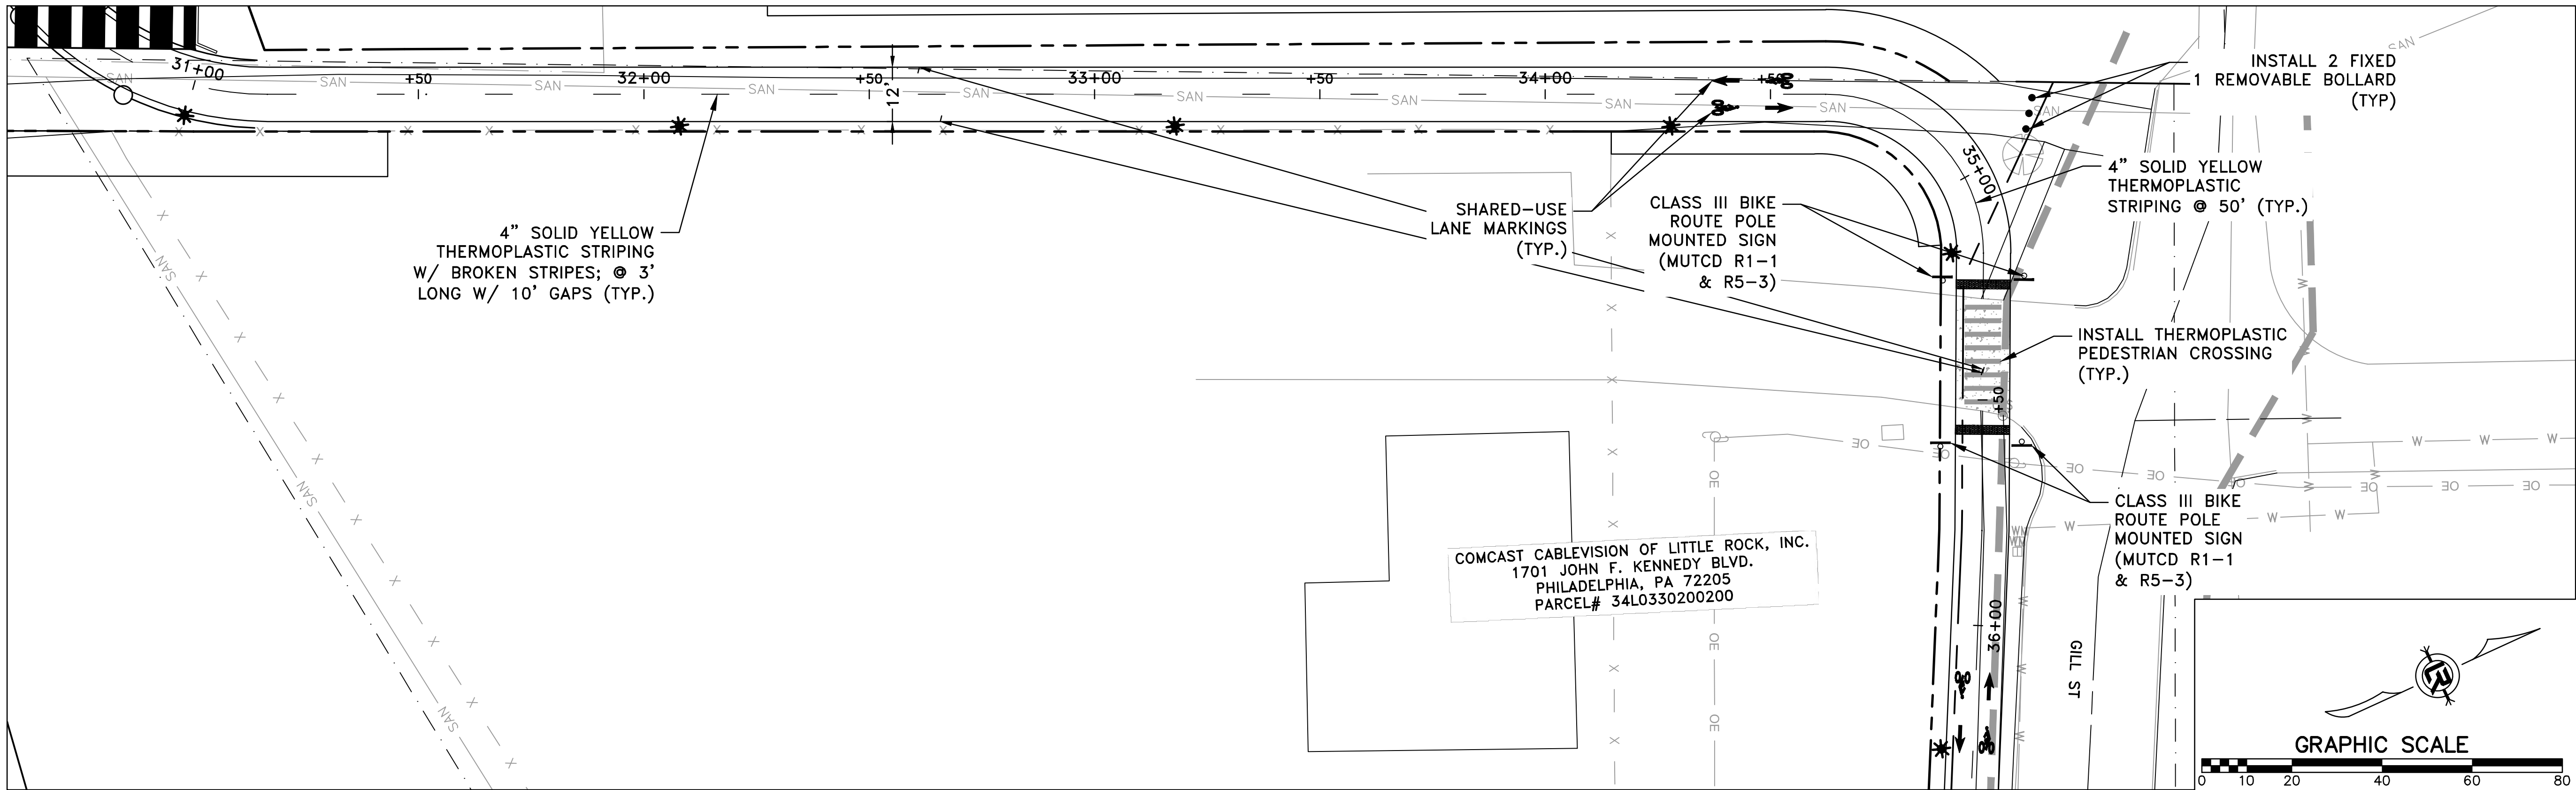

REVISIONS	DATE

CITY OF LITTLE ROCK, ARKANSAS

ROSE CREEK TRAIL

STRIPING & SIGNAGE SHEET 4

DEPARTMENT OF PUBLIC WORKS

CIVIL ENGINEERING

701 W. MARKHAM

LITTLE ROCK, ARKANSAS 72201

STATE OF ARKANSAS

REGISTERED PROFESSIONAL ENGINEER

BRADLEY A. PETERSON

No. 13217

9/3/26

DRAWN BY

AS

DESIGNED

LC

CHECKED

JM

DATE

05-01-2026

SCALE

H: 1"=20'


V: 1"=5'

PROJECT NO.

23805201

SHEET NO.

C19

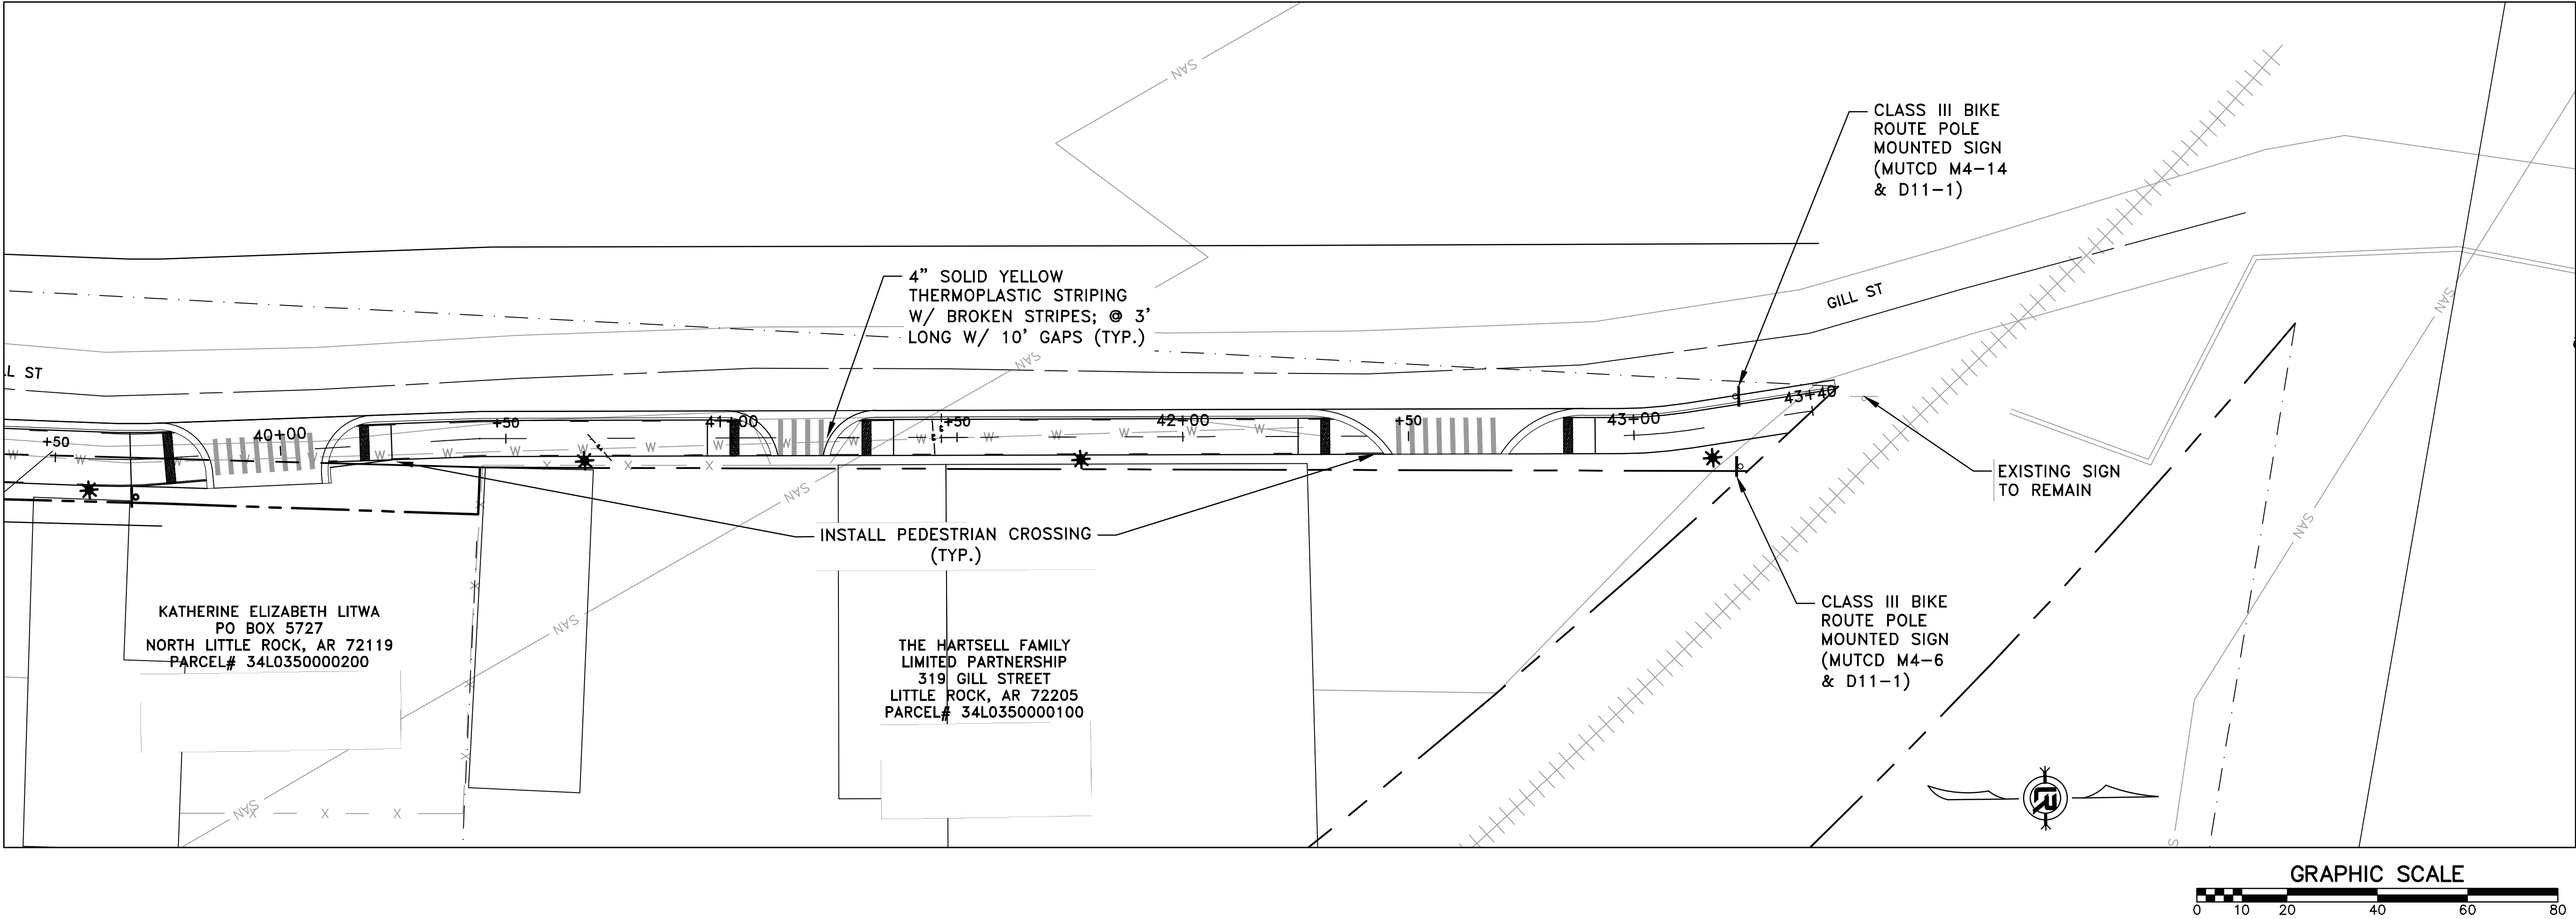

REVISIONS DATE




CITY OF LITTLE ROCK, ARKANSAS
ROSE CREEK TRAIL
ROSE CREEK TRAIL PLAN & PROFILE SHEET 1

DEPARTMENT OF PUBLIC WORKS
CIVIL ENGINEERING
701 W. MARKHAM
LITTLE ROCK, ARKANSAS 72201



DRAWN BY
AS
DESIGNED
LC
CHECKED
JM
DATE
05-01-2026
SCALE
H: 1"=20'
V: 1"=5'
PROJECT NO.
23805201
SHEET NO.
C20

100% SUBMITTAL

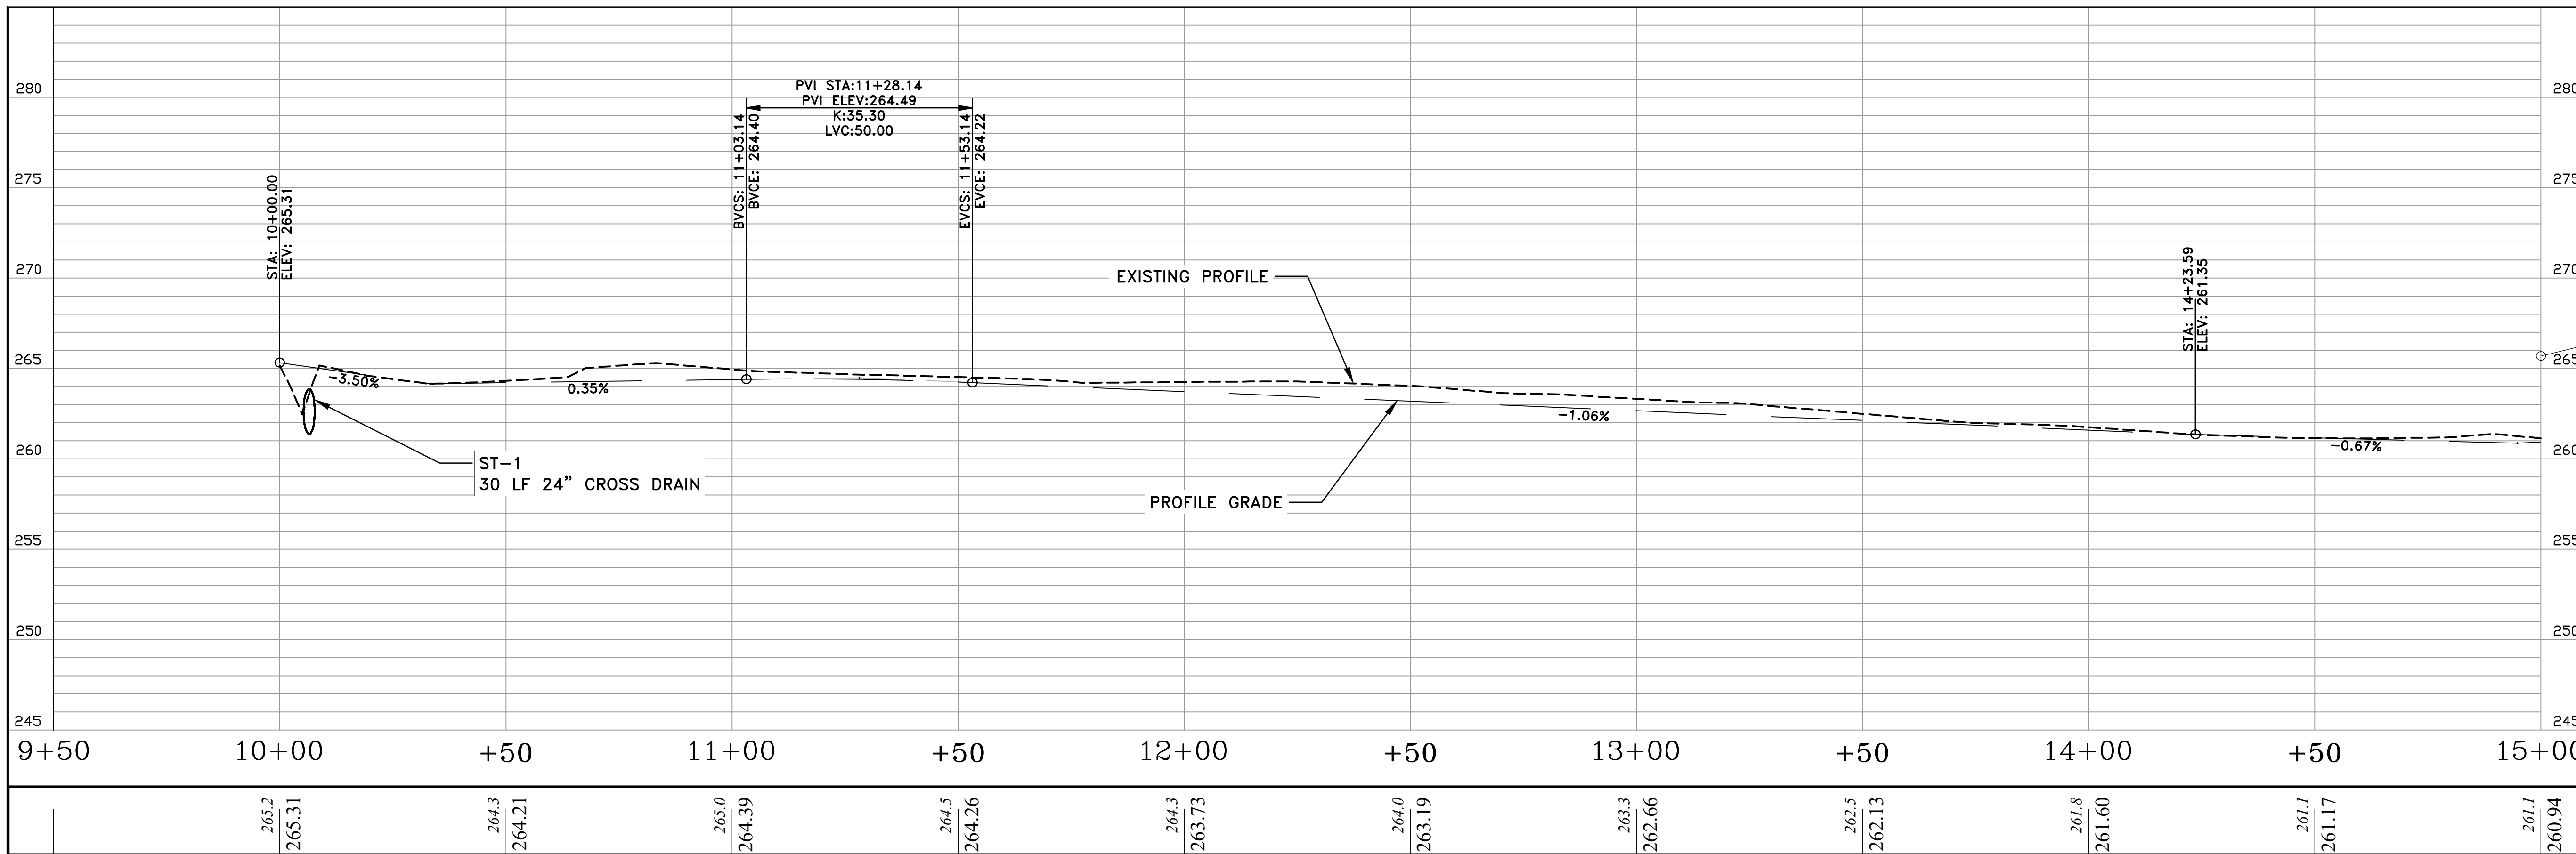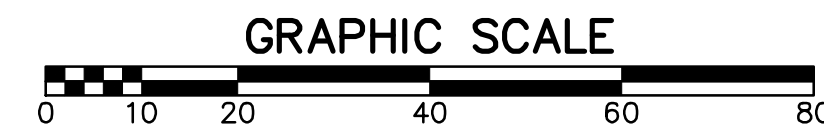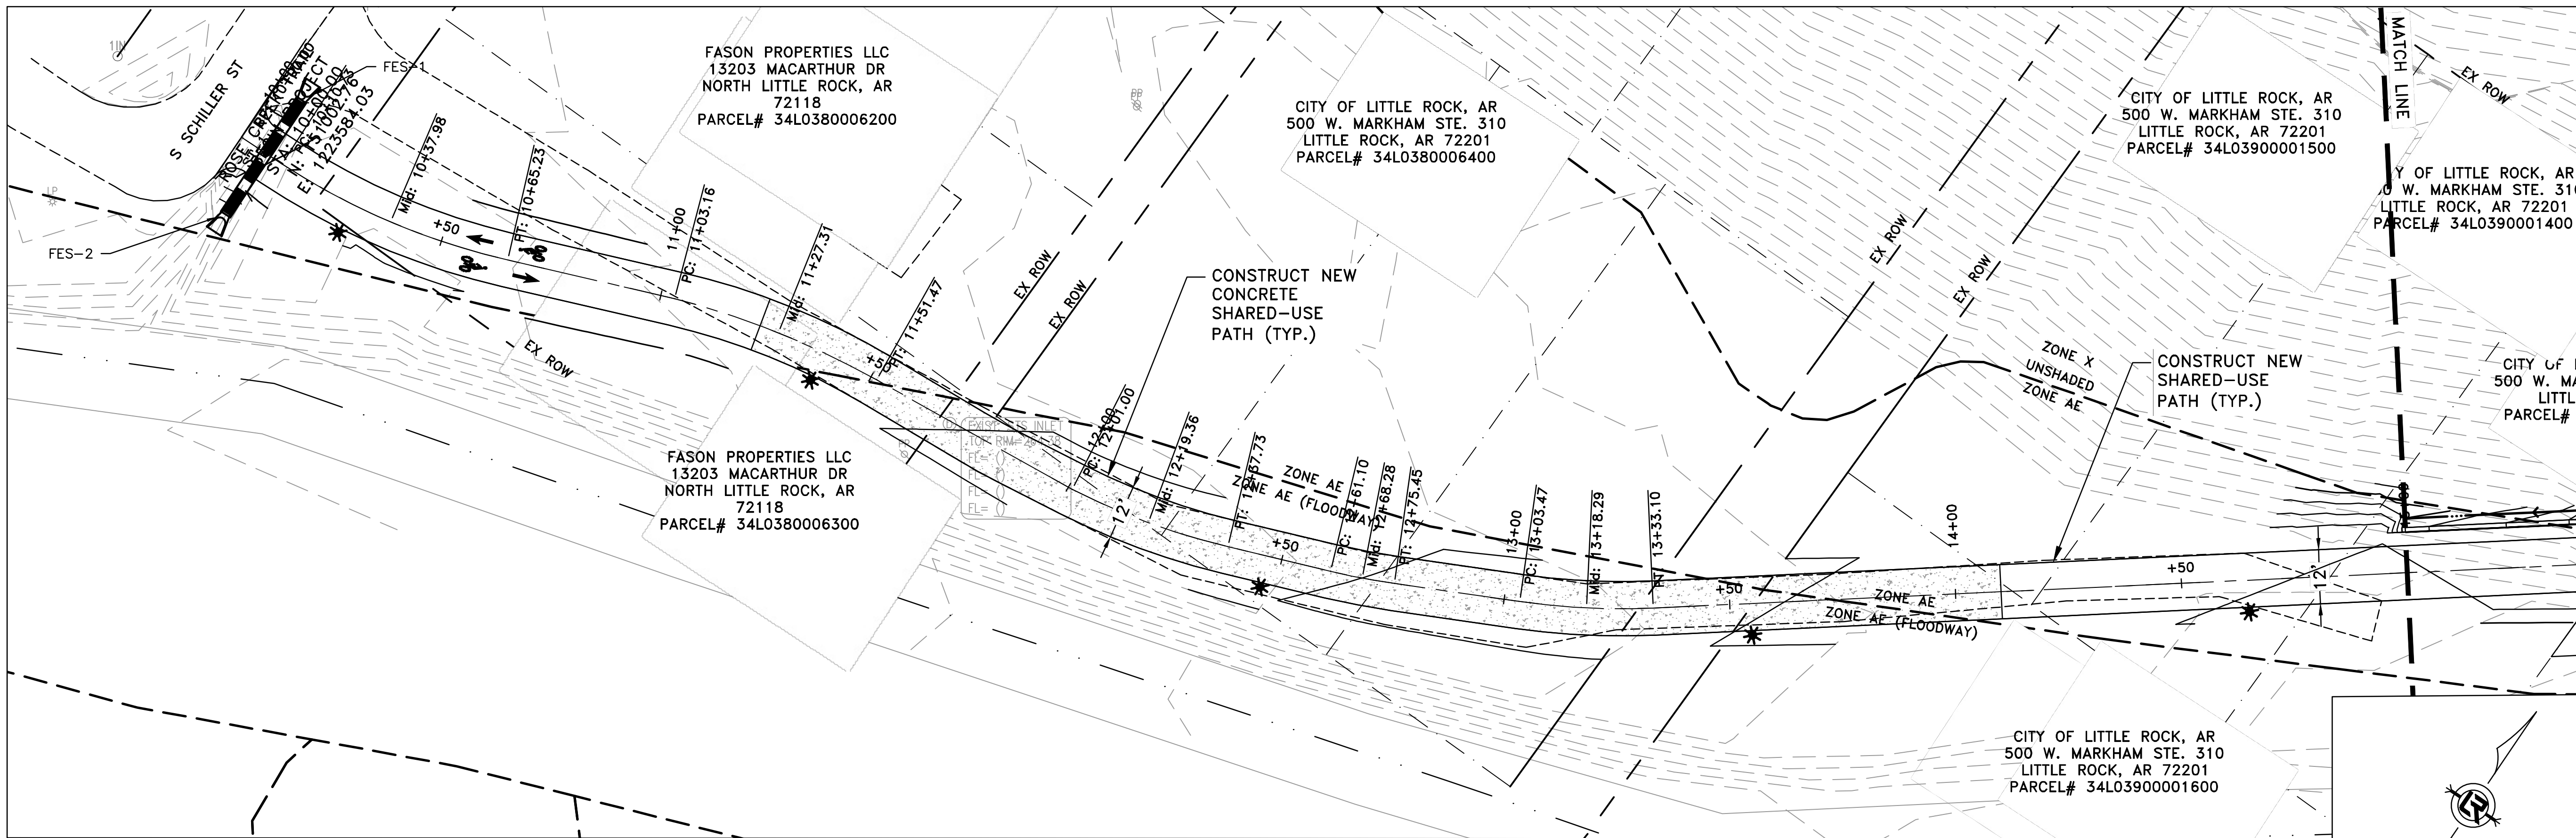

100% SUBMITTAL



CITY OF LITTLE ROCK, ARKANSAS
ROSE CREEK TRAIL

ROSE CREEK TRAIL PLAN & PROFILE SHEET 2

DEPARTMENT OF PUBLIC WORKS



DRAWN BY
AS
DESIGNED
LC
CHECKED
JM
DATE
05-01-2026
SCALE
H: 1"=20'
V: 1"=5'
PROJECT NO.
23805201
SHEET NO
C21

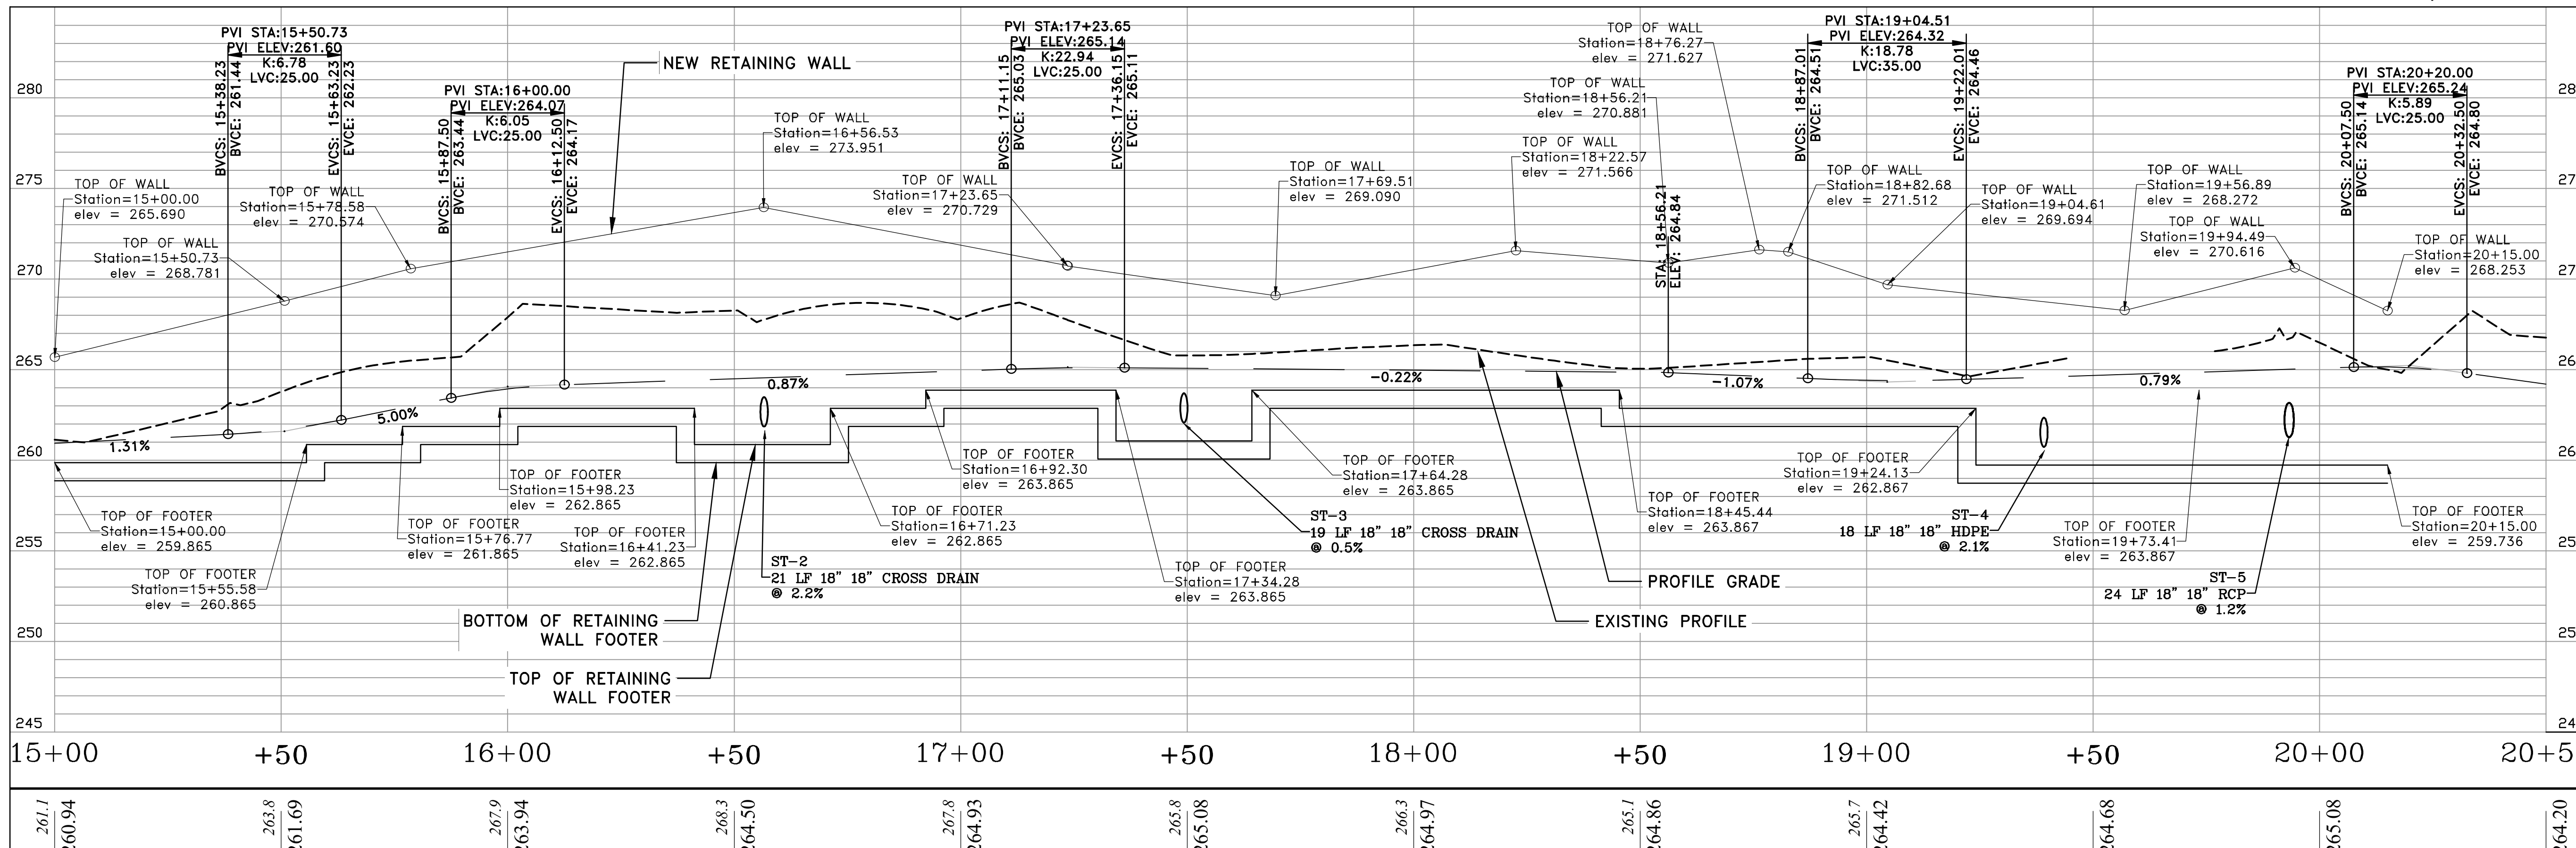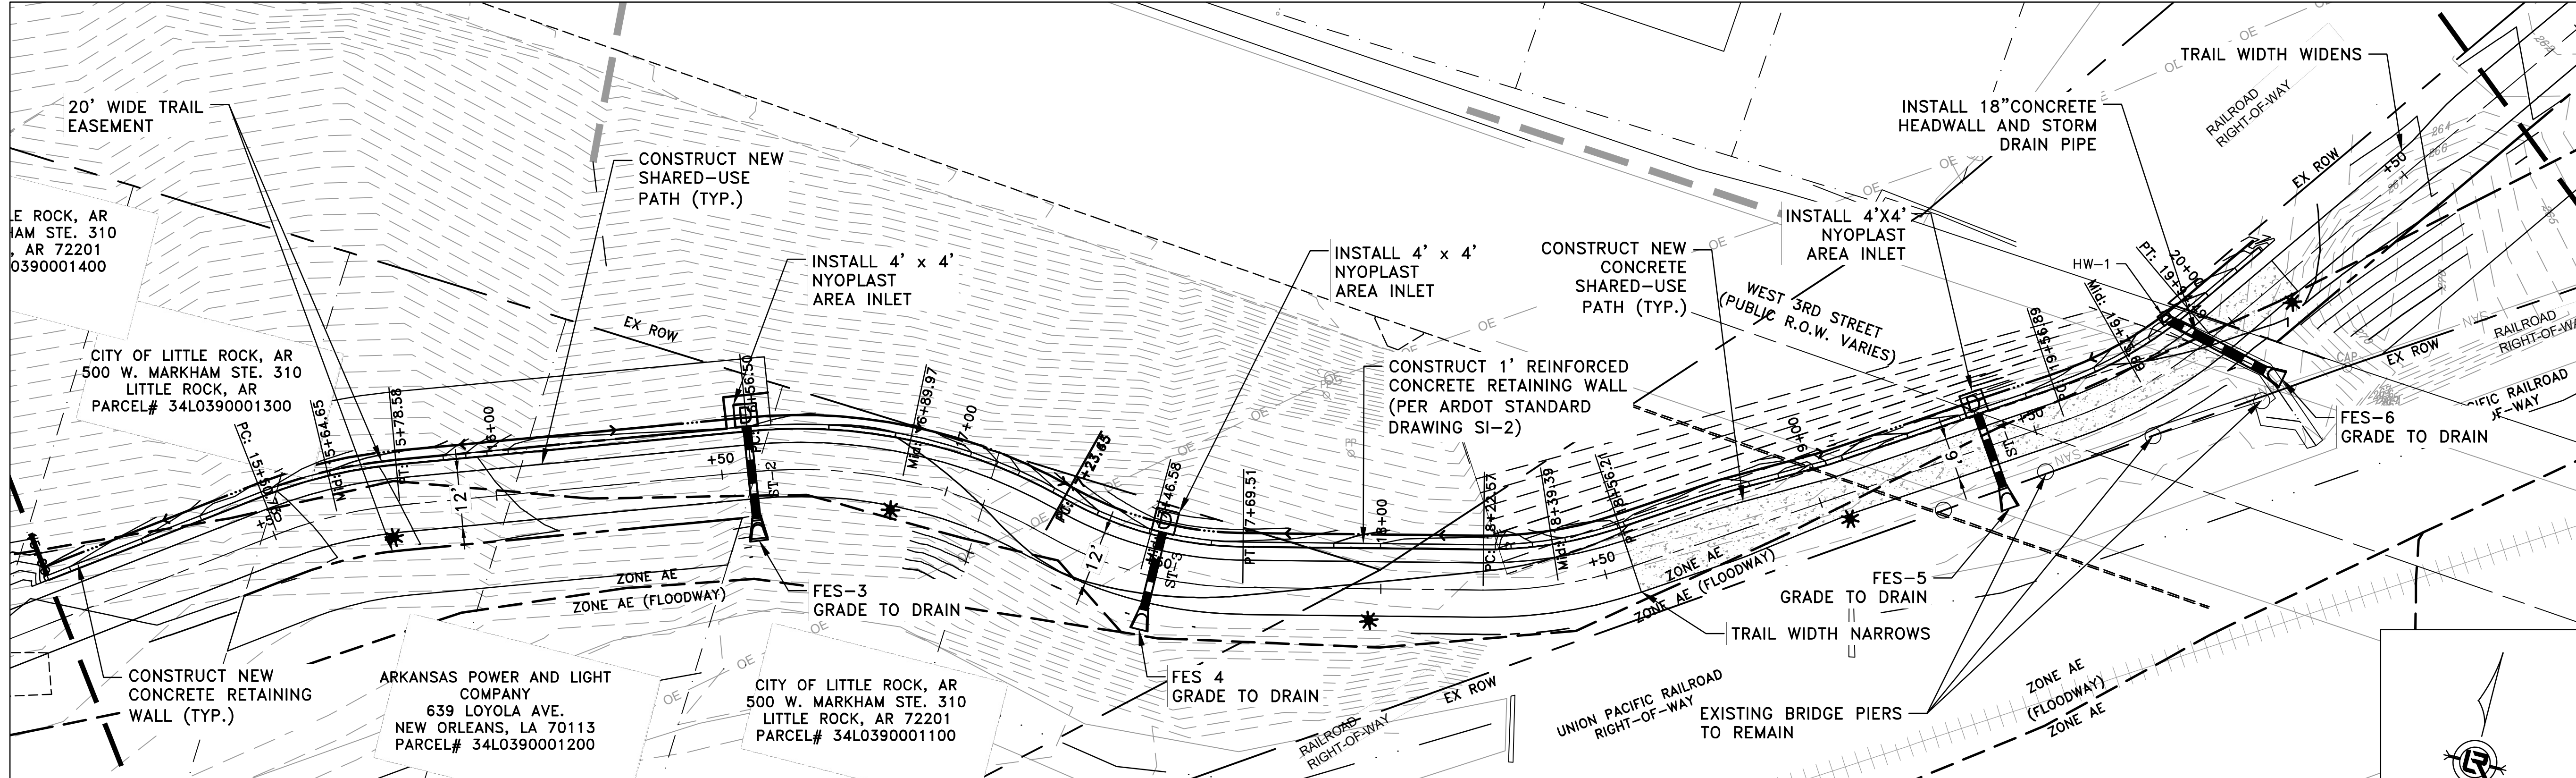




REVISIONS	DATE

CITY OF LITTLE ROCK, ARKANSAS
ROSE CREEK TRAIL
ROSE CREEK TRAIL PLAN & PROFILE SHEET 3

DEPARTMENT OF PUBLIC WORKS
CIVIL ENGINEERING
701 W. MARKHAM
LITTLE ROCK, ARKANSAS 72201



DRAWN BY
AS
DESIGNED
LC
CHECKED
JM
DATE
05-01-2026
SCALE
H: 1"=20'
V: 1"=5'
PROJECT NO.
23805201
SHEET NO.
C22

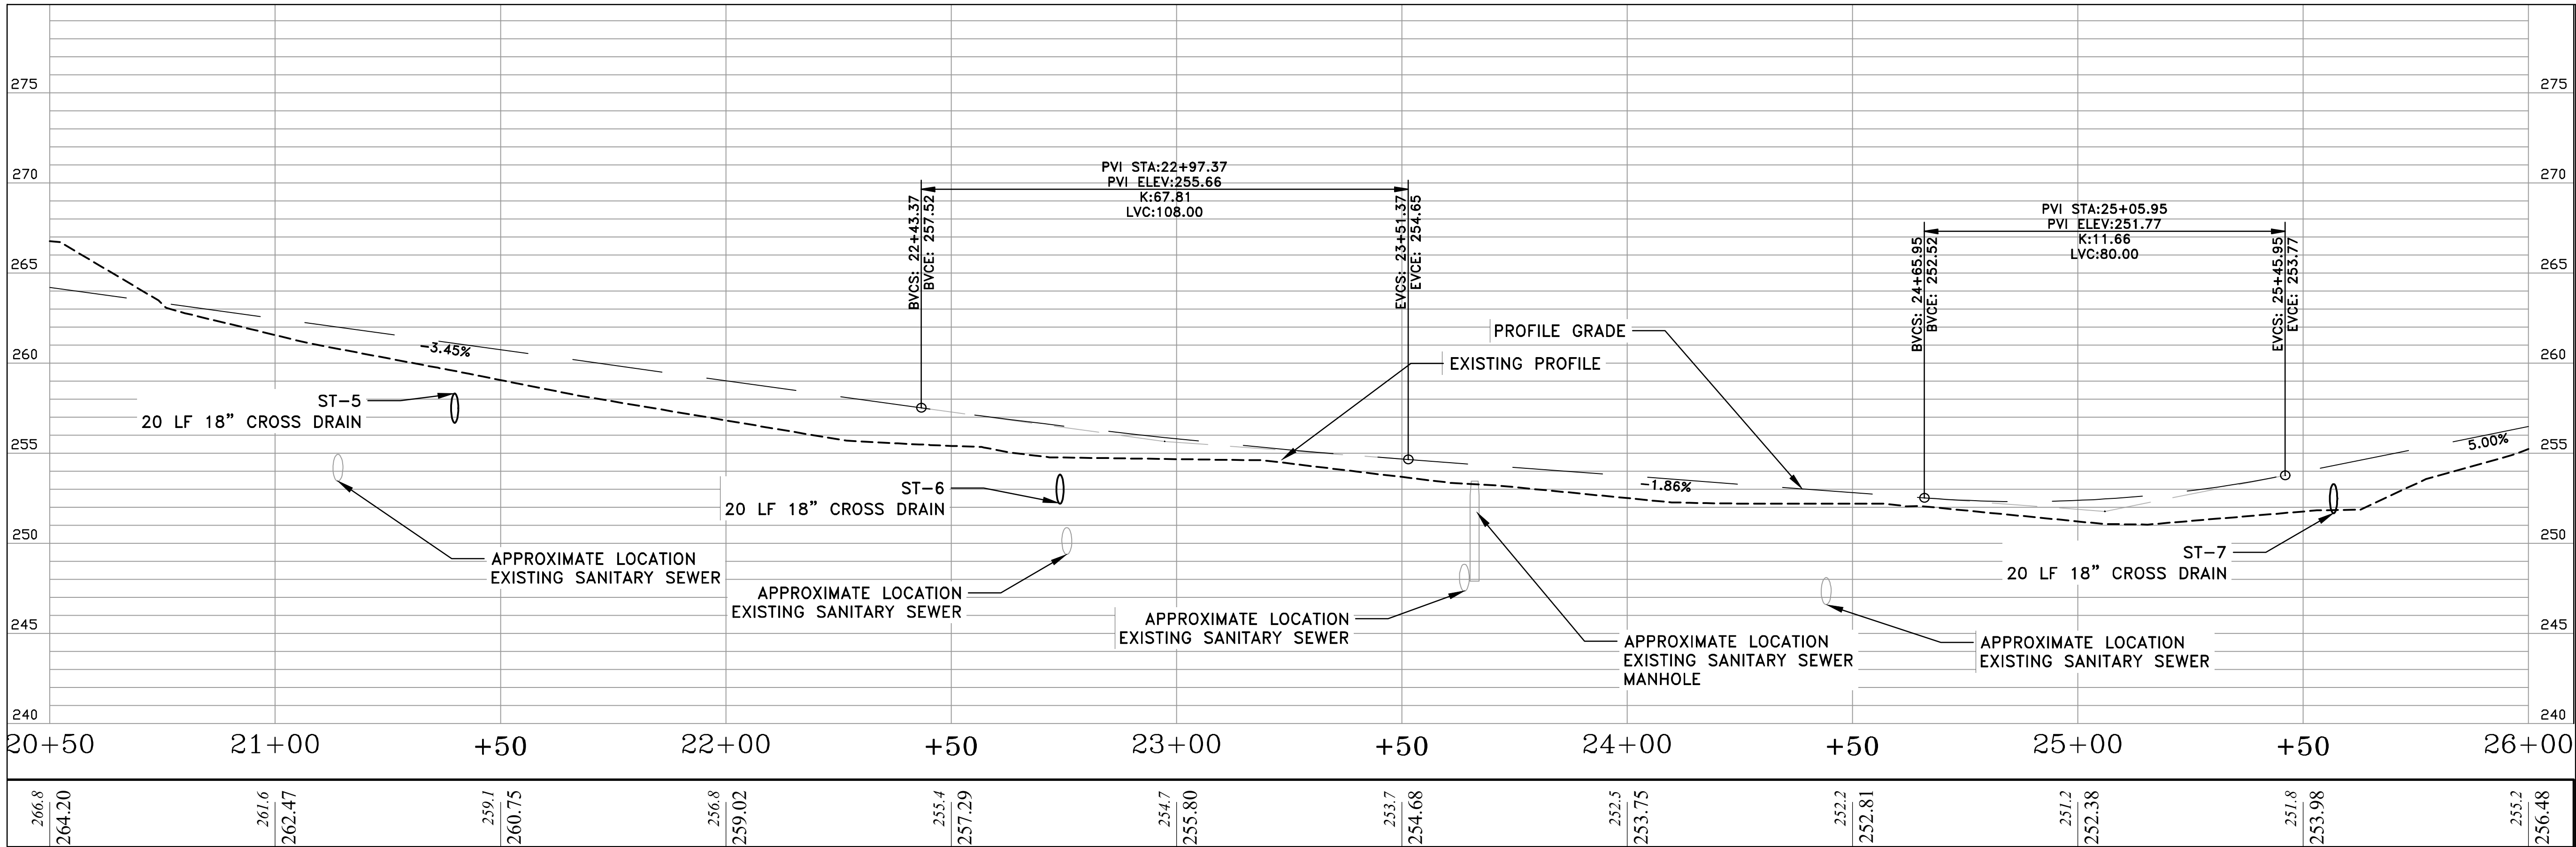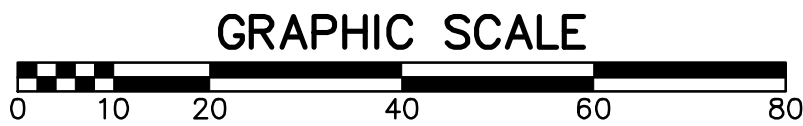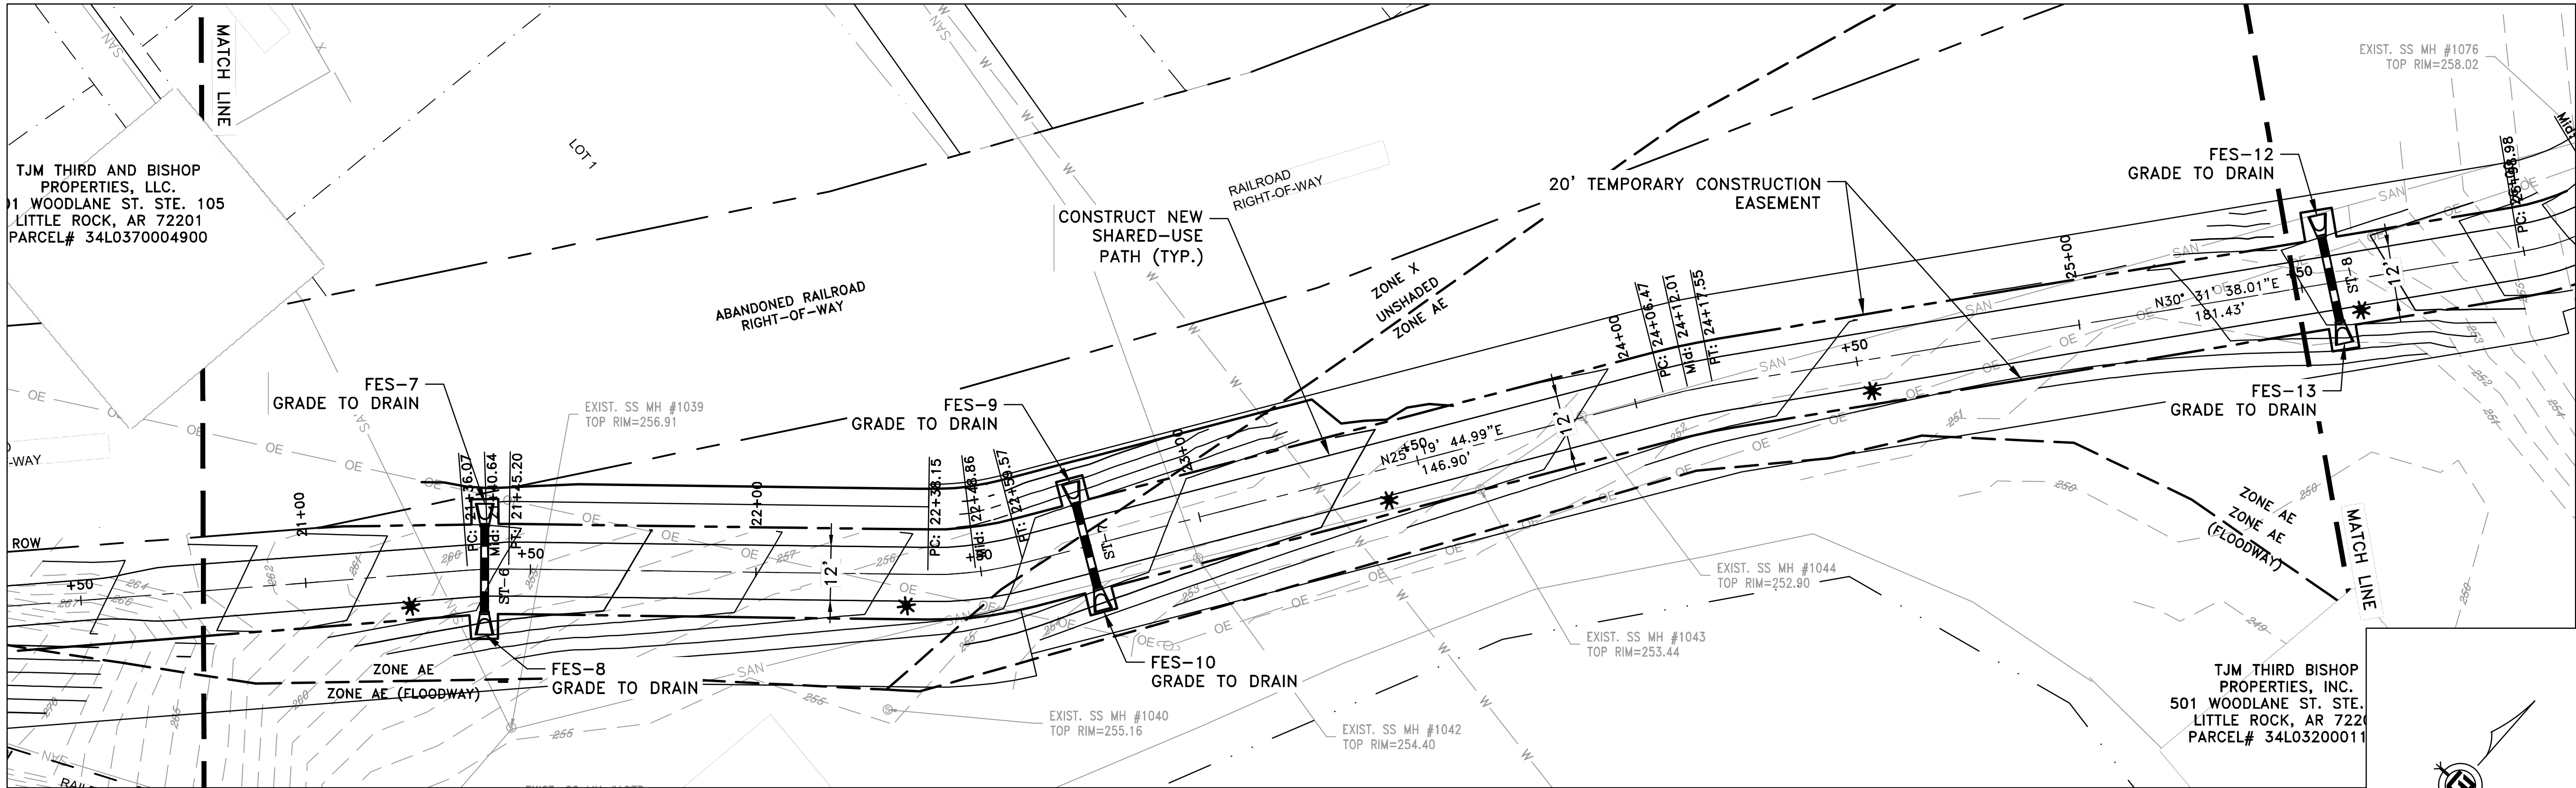

100% SUBMITTAL




REVISIONS	DATE

CITY OF LITTLE ROCK, ARKANSAS
ROSE CREEK TRAIL
ROSE CREEK TRAIL PLAN & PROFILE SHEET 4

DEPARTMENT OF PUBLIC WORKS
CIVIL ENGINEERING
701 W. MARKHAM
LITTLE ROCK, ARKANSAS 72201



DRAWN BY
AS
DESIGNED
LC
CHECKED
JM
DATE
05-01-2026
SCALE
H: 1"=20'
V: 1"=5'
PROJECT NO.
23805201
SHEET NO.
C23

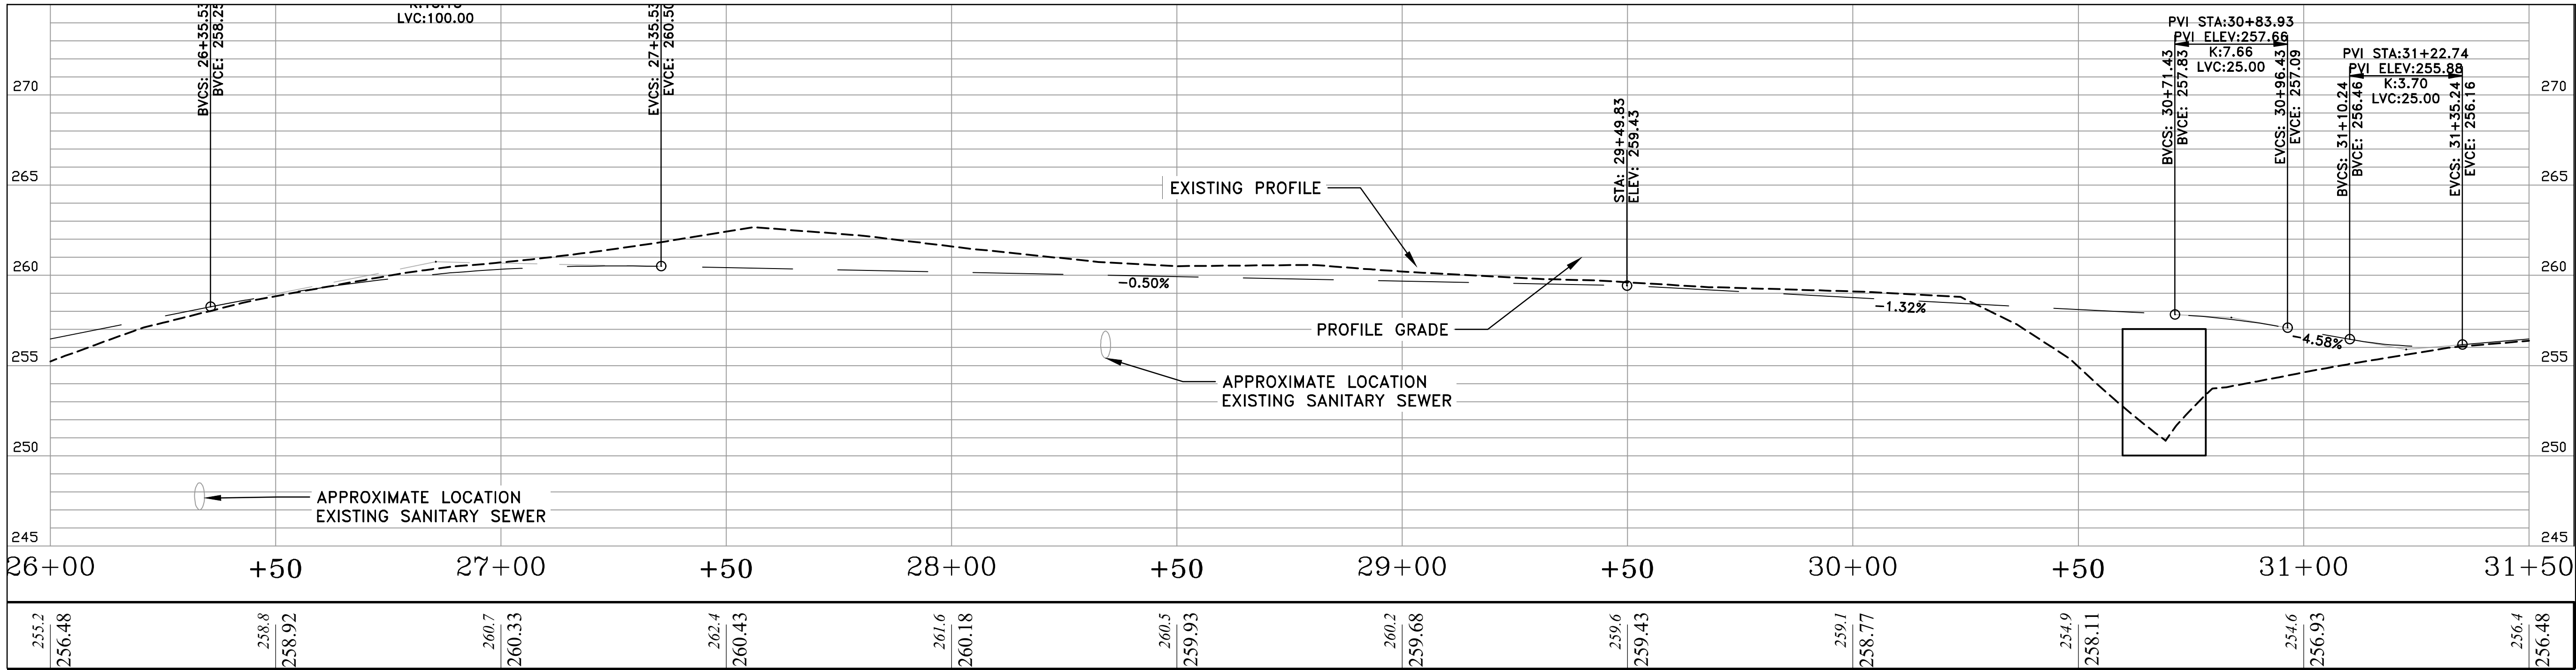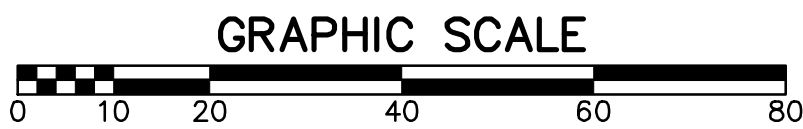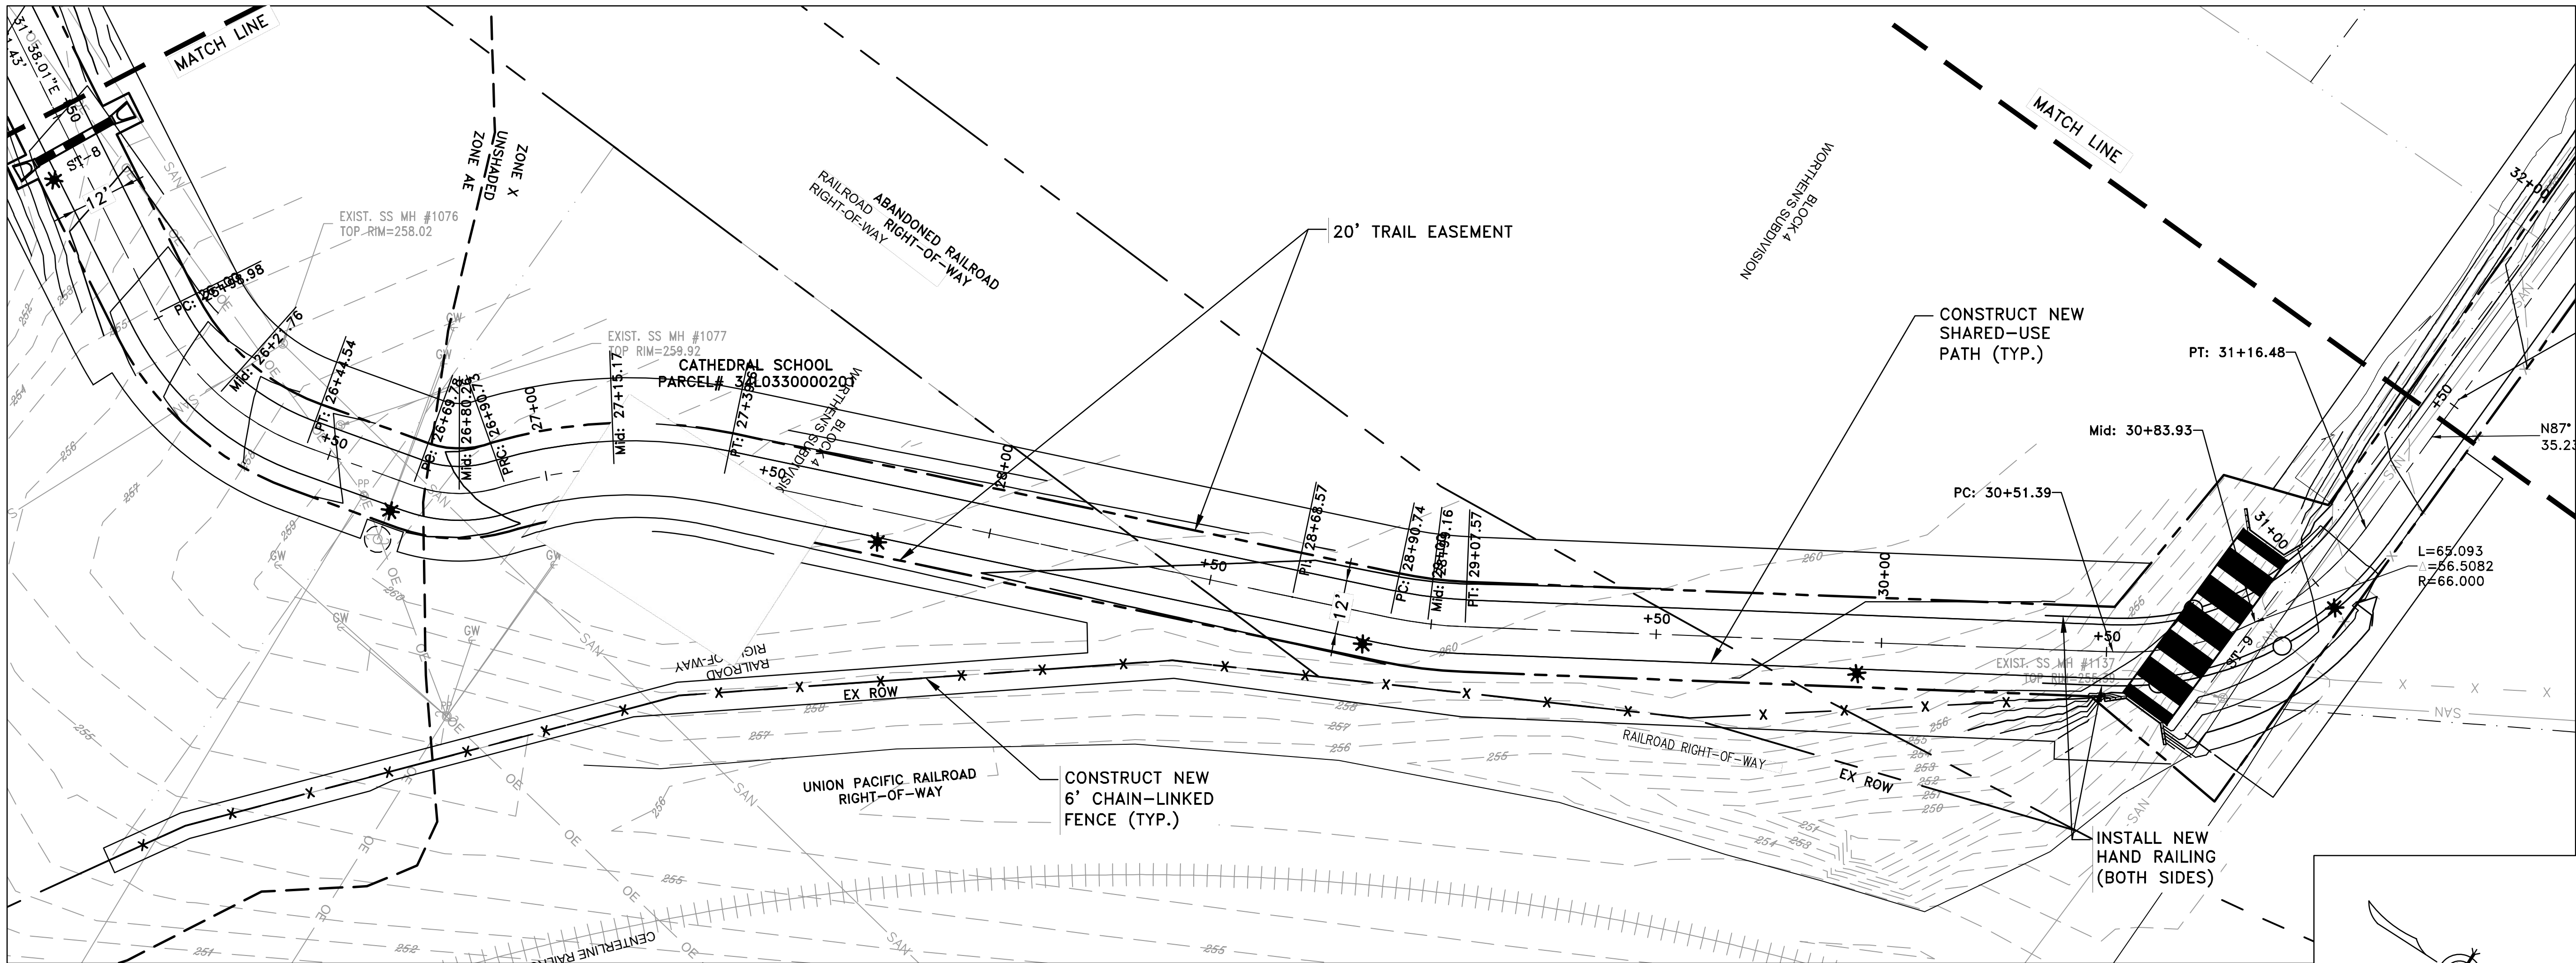

REVISIONS	DATE

CITY OF LITTLE ROCK, ARKANSAS

ROSE CREEK TRAIL

ROSE CREEK TRAIL PLAN & PROFILE SHEET 5

DEPARTMENT OF PUBLIC WORKS

CIVIL ENGINEERING

701 W. MARKHAM

LITTLE ROCK, ARKANSAS 72201

STATE OF ARKANSAS

REGISTERED PROFESSIONAL ENGINEER

BRADLEY A. PETERSON

9/3/26

DRAWN BY

AS

DESIGNED

LC

CHECKED

JM

DATE

05-01-2026

SCALE

H: 1"=20'



V: 1"=5'

PROJECT NO.

23805201

SHEET NO.

C24

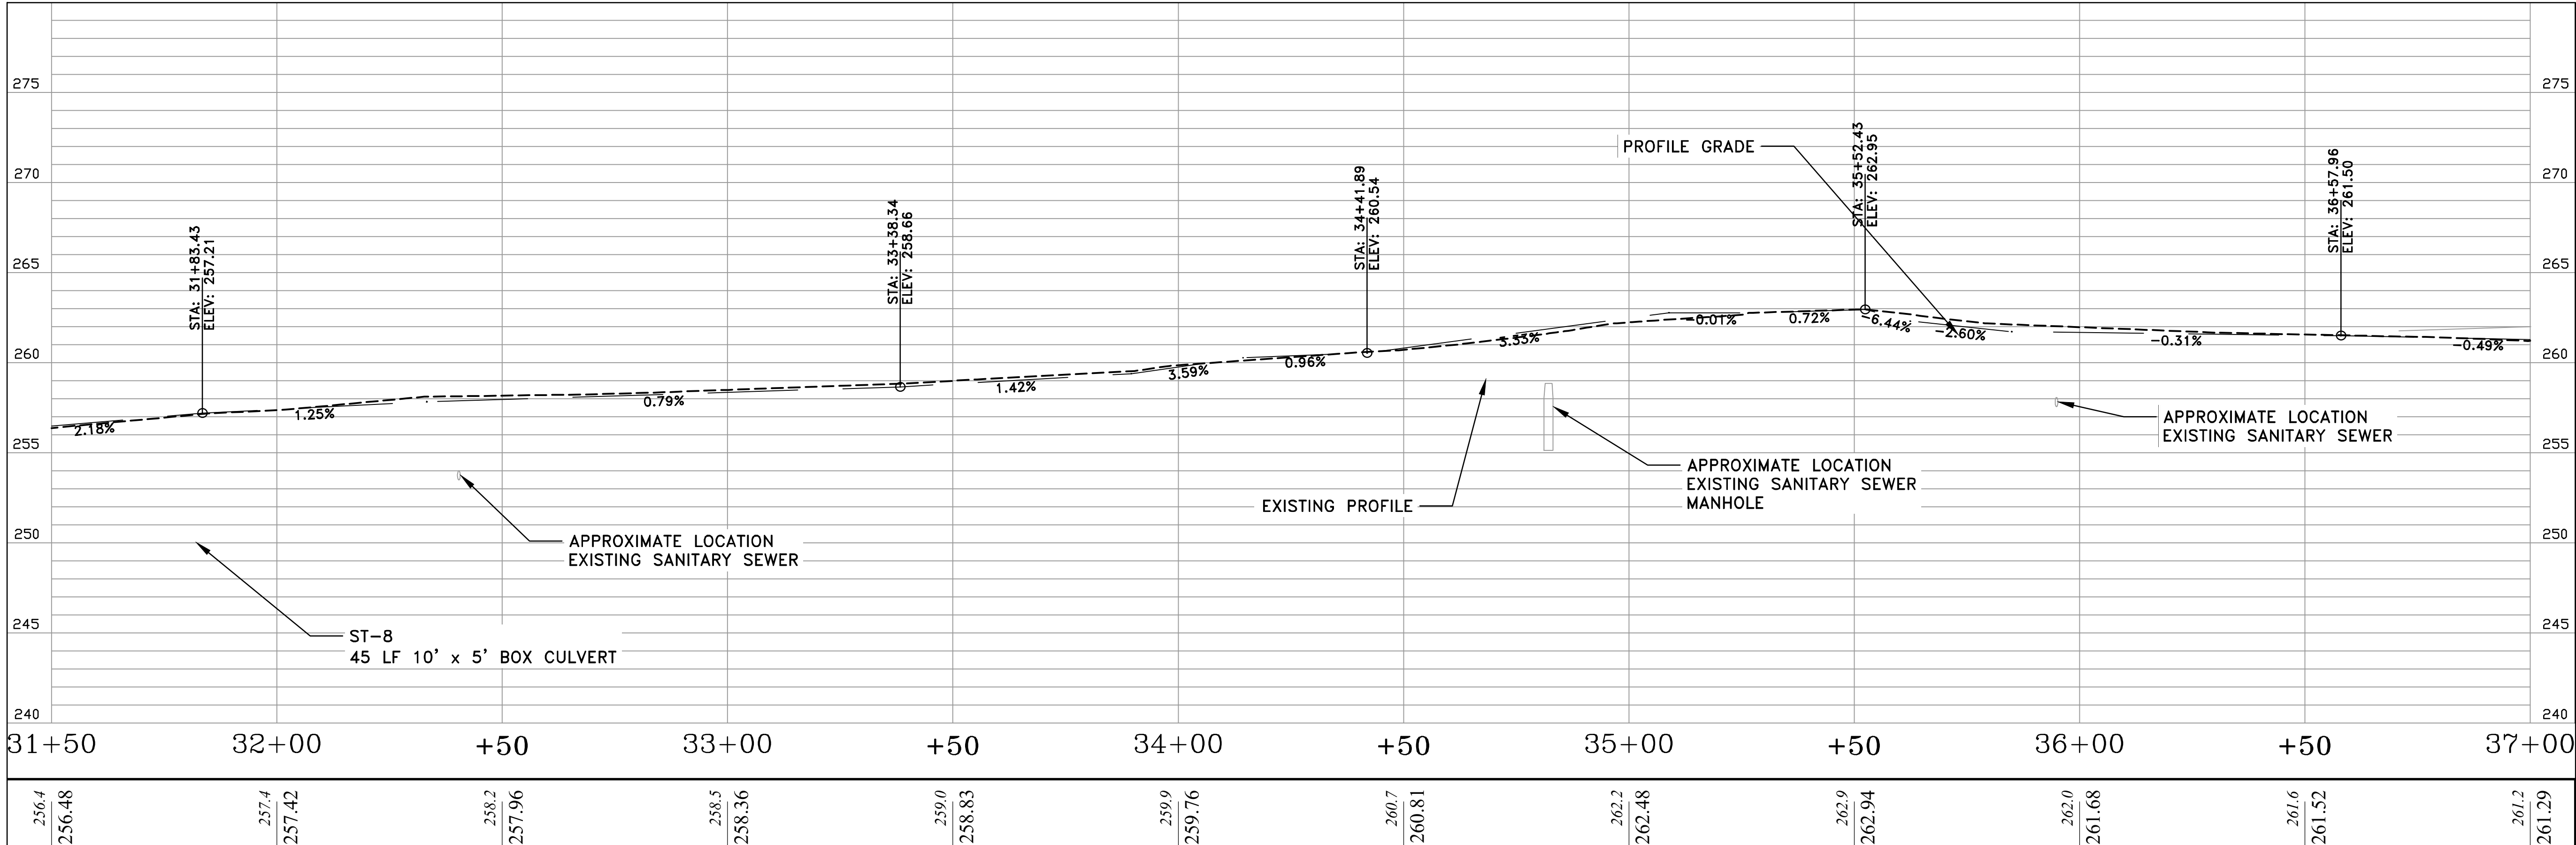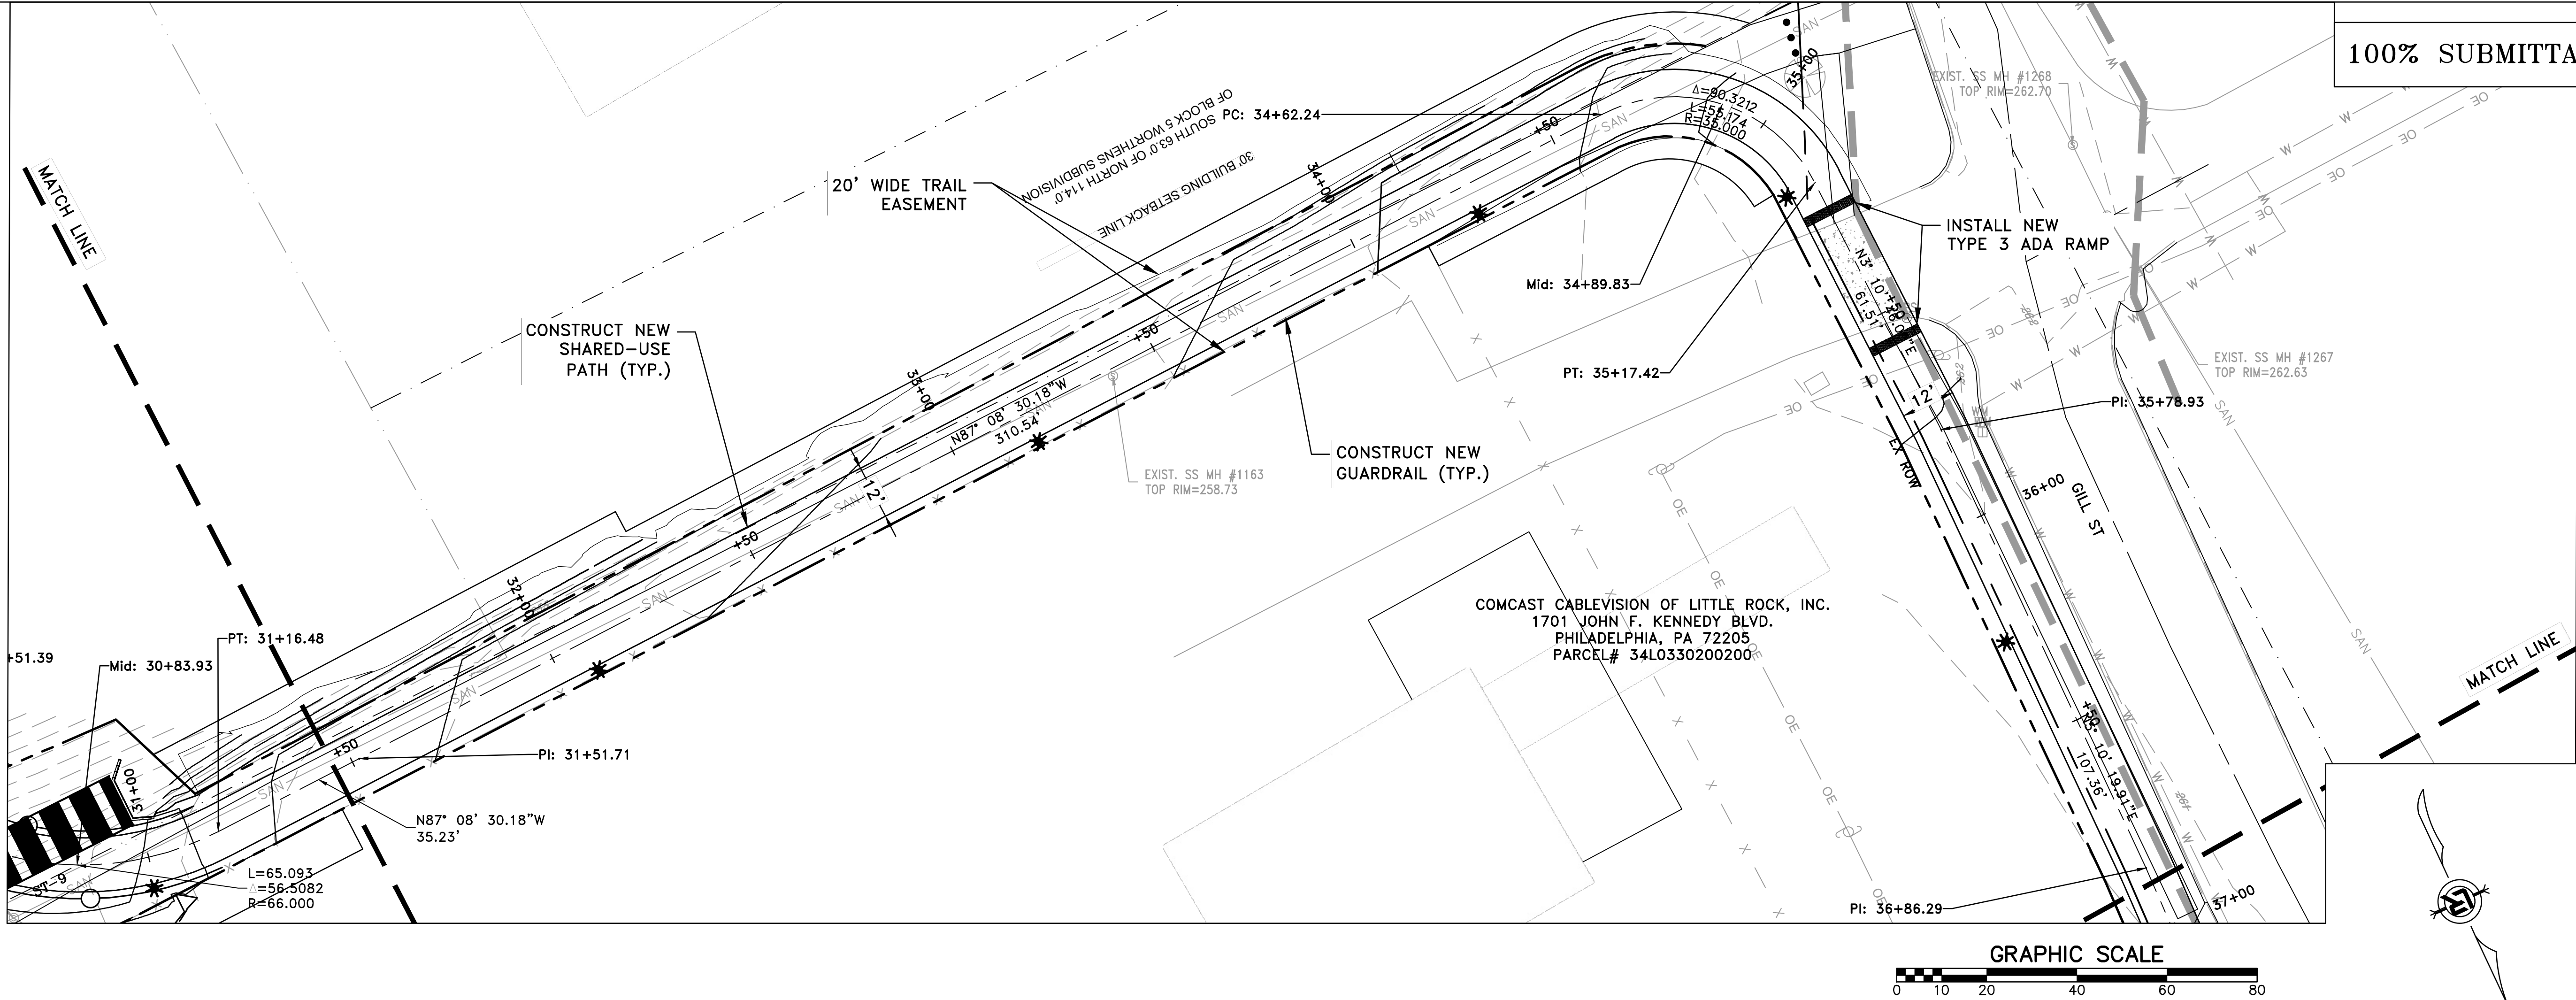

REVISIONS	DATE

CITY OF LITTLE ROCK, ARKANSAS

ROSE CREEK TRAIL

ROSE CREEK TRAIL PLAN & PROFILE SHEET 6

DEPARTMENT OF PUBLIC WORKS

CIVIL ENGINEERING

701 W. MARKHAM

LITTLE ROCK, ARKANSAS 72201



STATE OF ARKANSAS

REGISTERED PROFESSIONAL ENGINEER

BRADLEY A. PETERSON

9/3/26

DRAWN BY

AS

DESIGNED

LC

CHECKED

JM

DATE

05-01-2026

SCALE

H: 1"=20'




V: 1"=5'

PROJECT NO.

23805201

SHEET NO.

C25

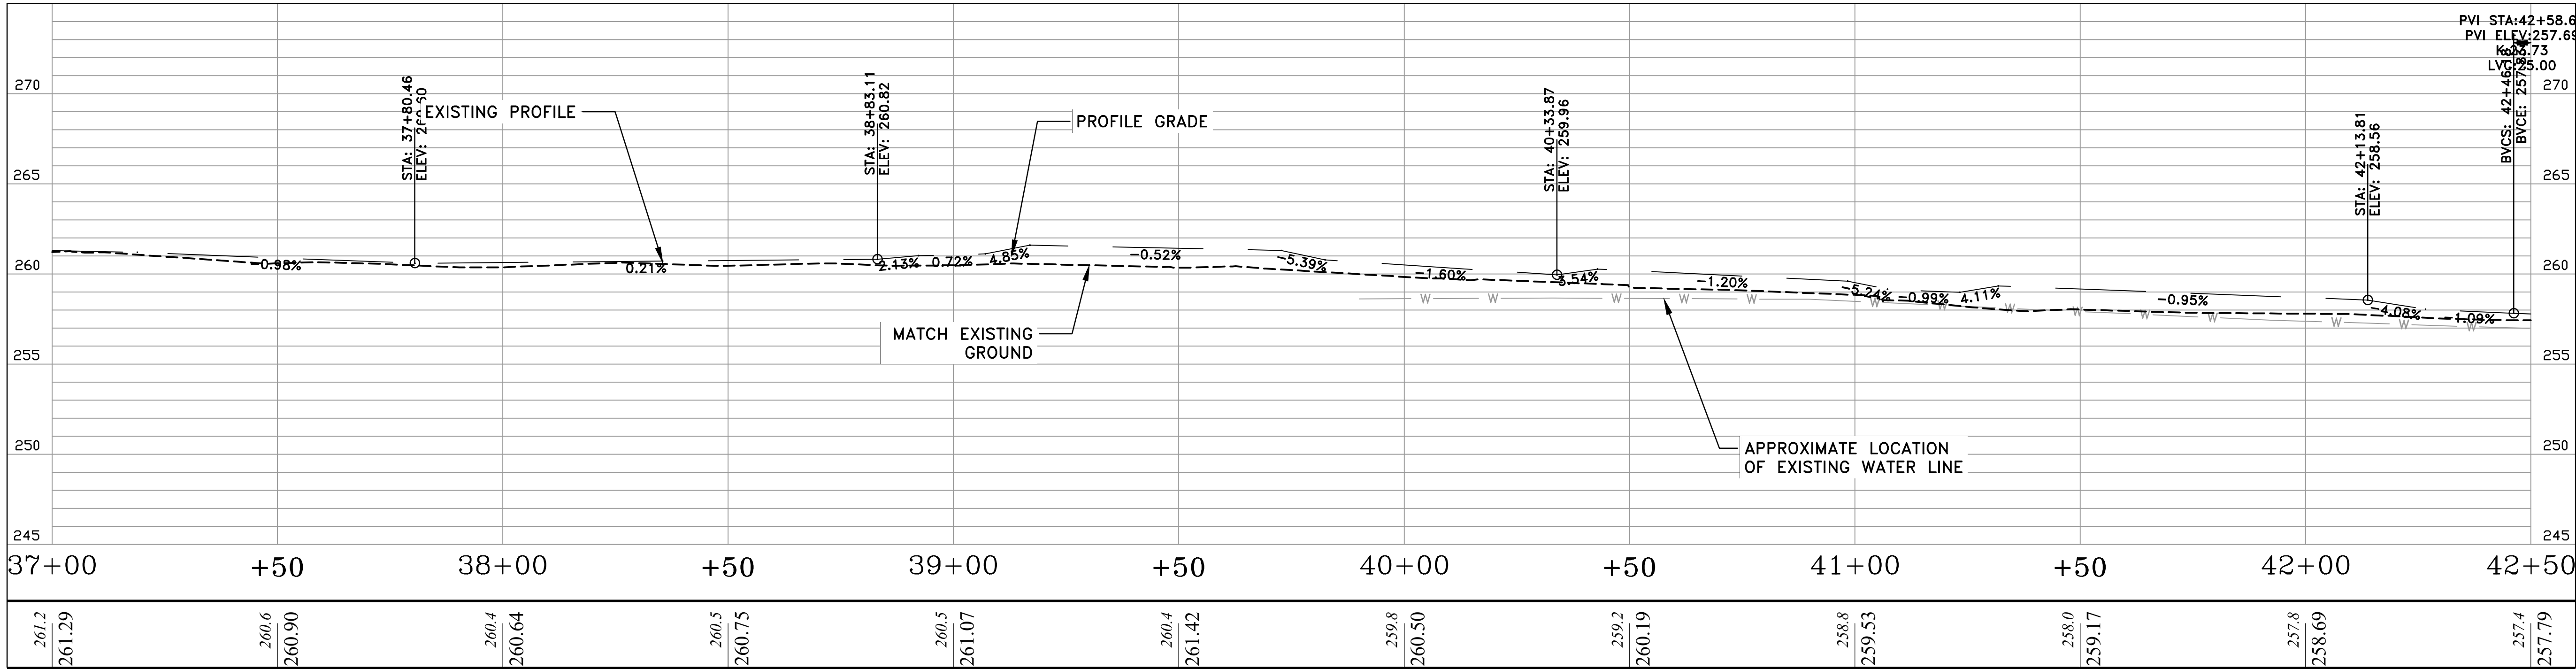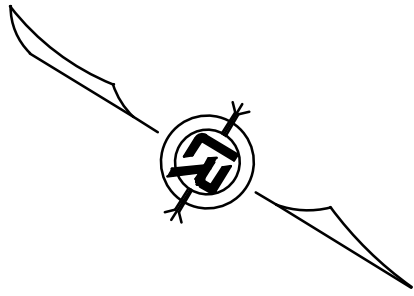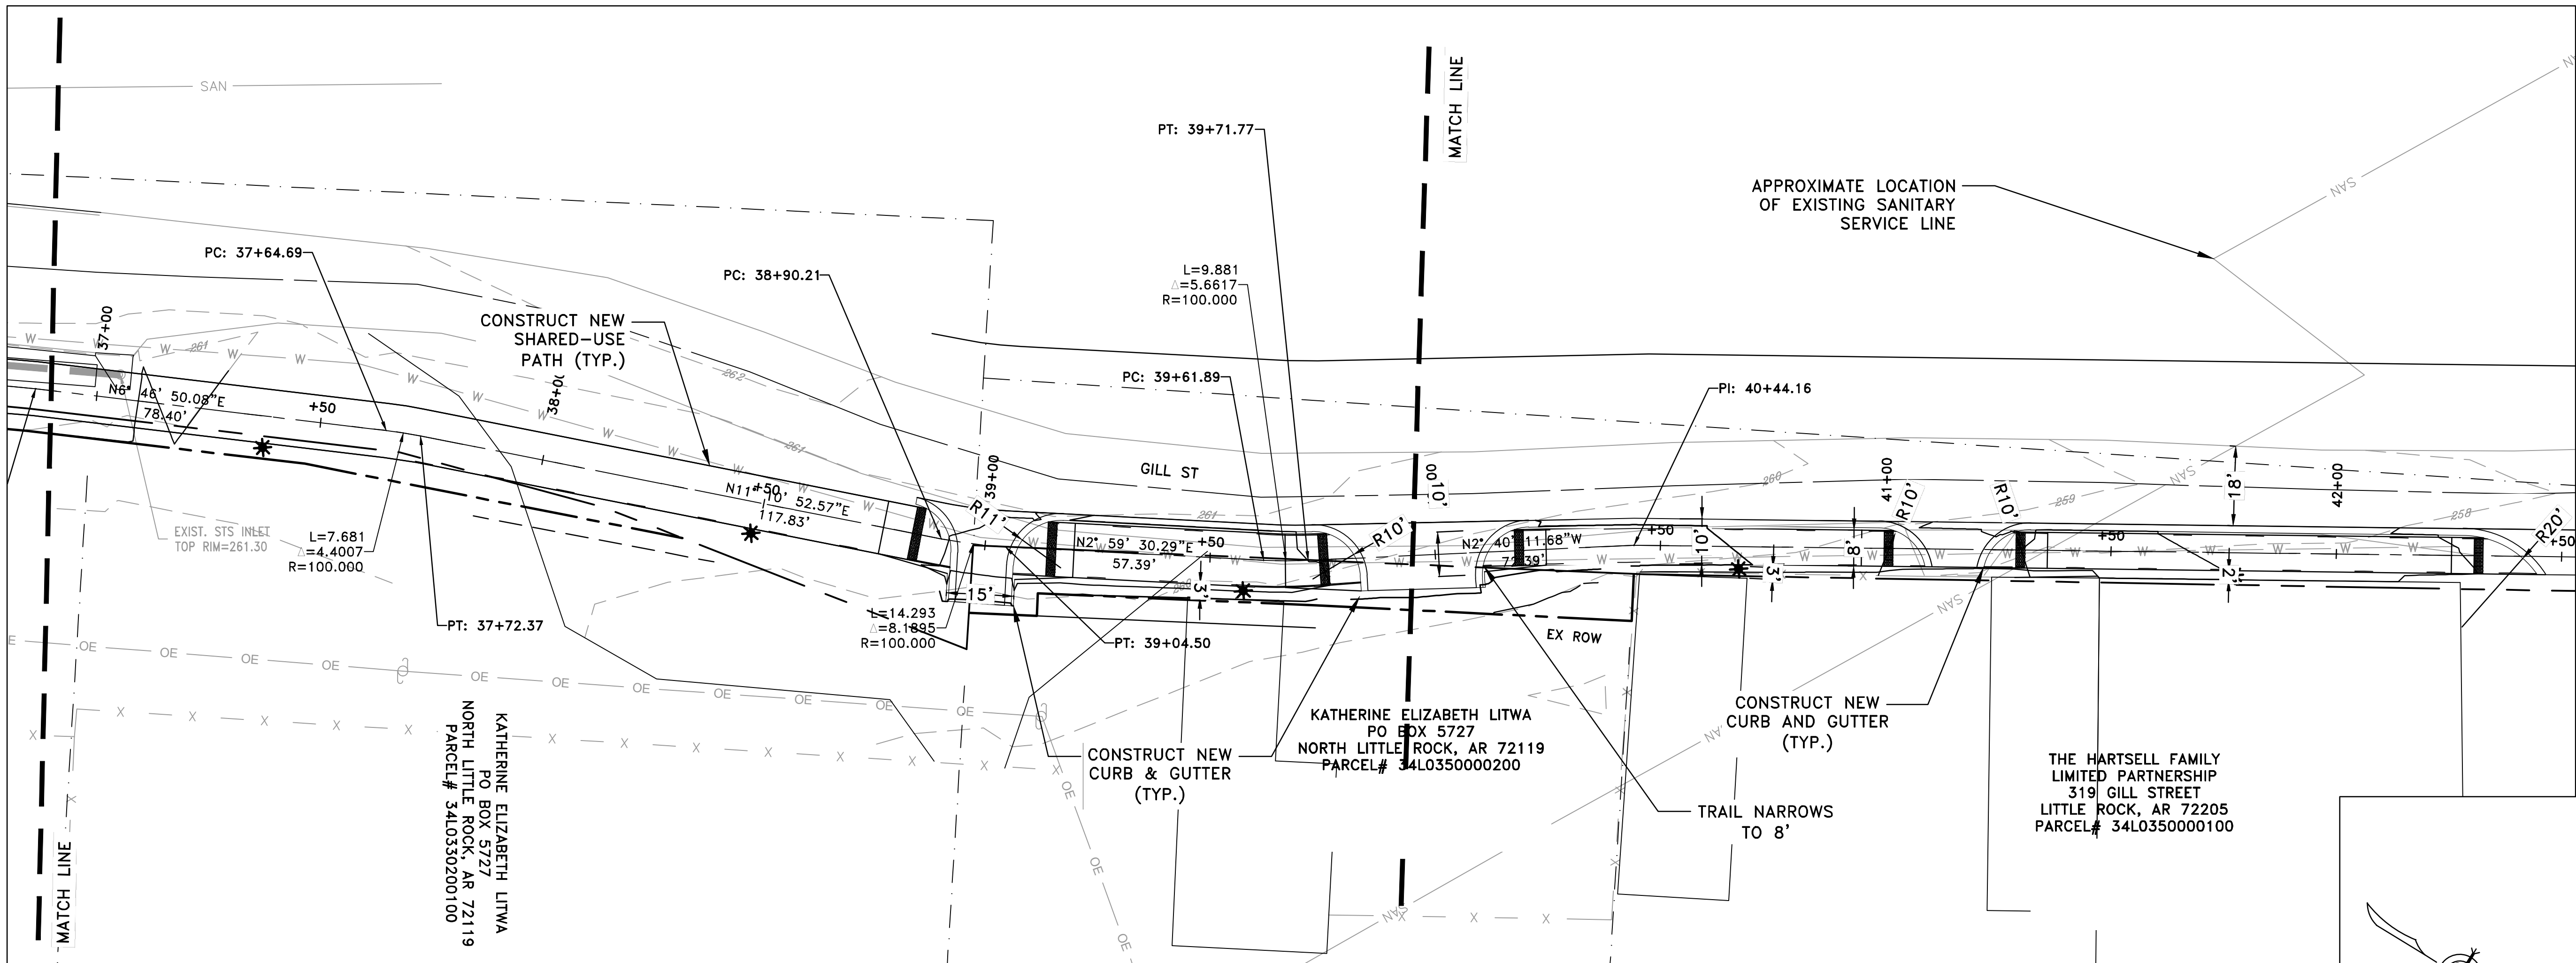

REVISIONS	DATE

CITY OF LITTLE ROCK, ARKANSAS

ROSE CREEK TRAIL

ROSE CREEK TRAIL PLAN & PROFILE SHEET 7

DEPARTMENT OF PUBLIC WORKS

CIVIL ENGINEERING

701 W. MARKHAM

LITTLE ROCK, ARKANSAS 72201



DRAWN BY
AS

DESIGNED
LC



CHECKED
JM

DATE
05-01-2026






SCALE
H: 1"=20'
V: 1"=5'

PROJECT NO.
23805201

SHEET NO.
C26

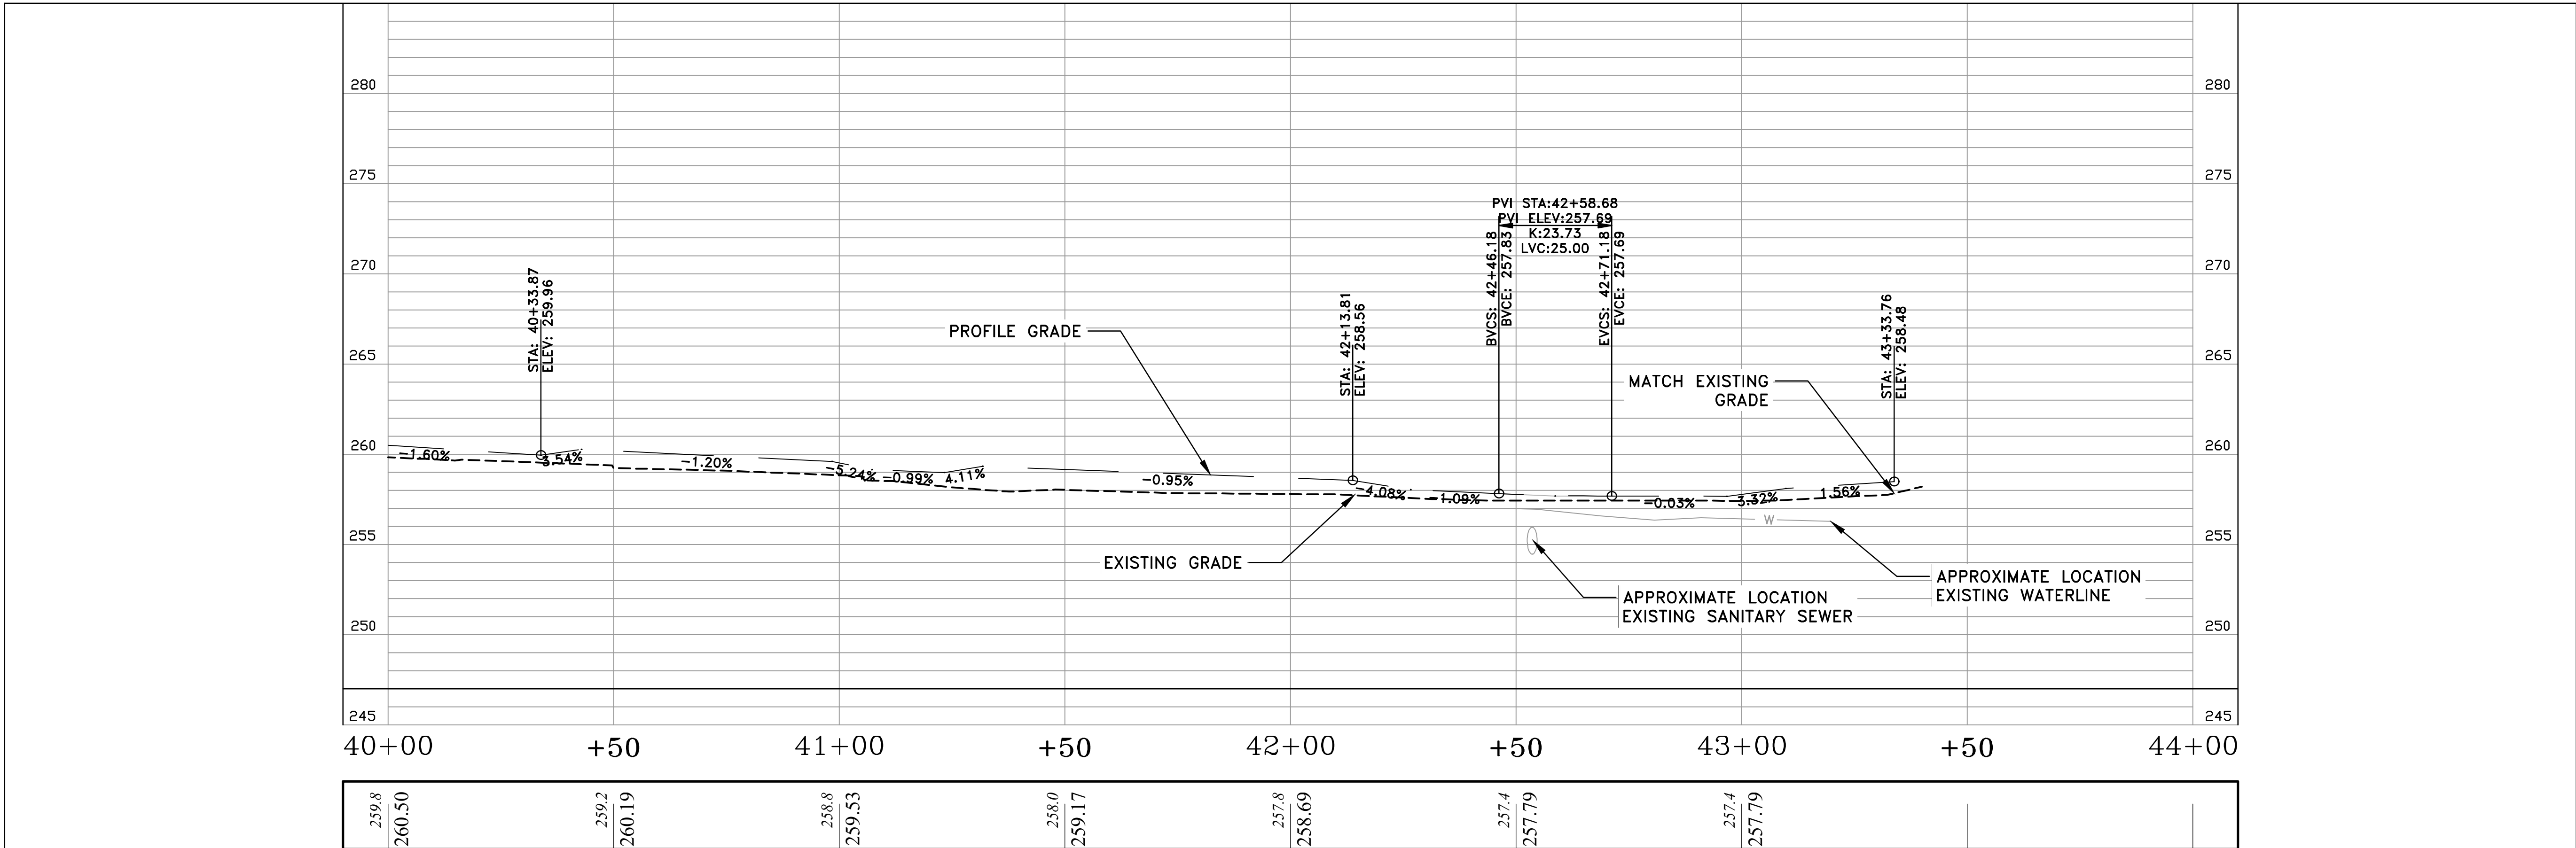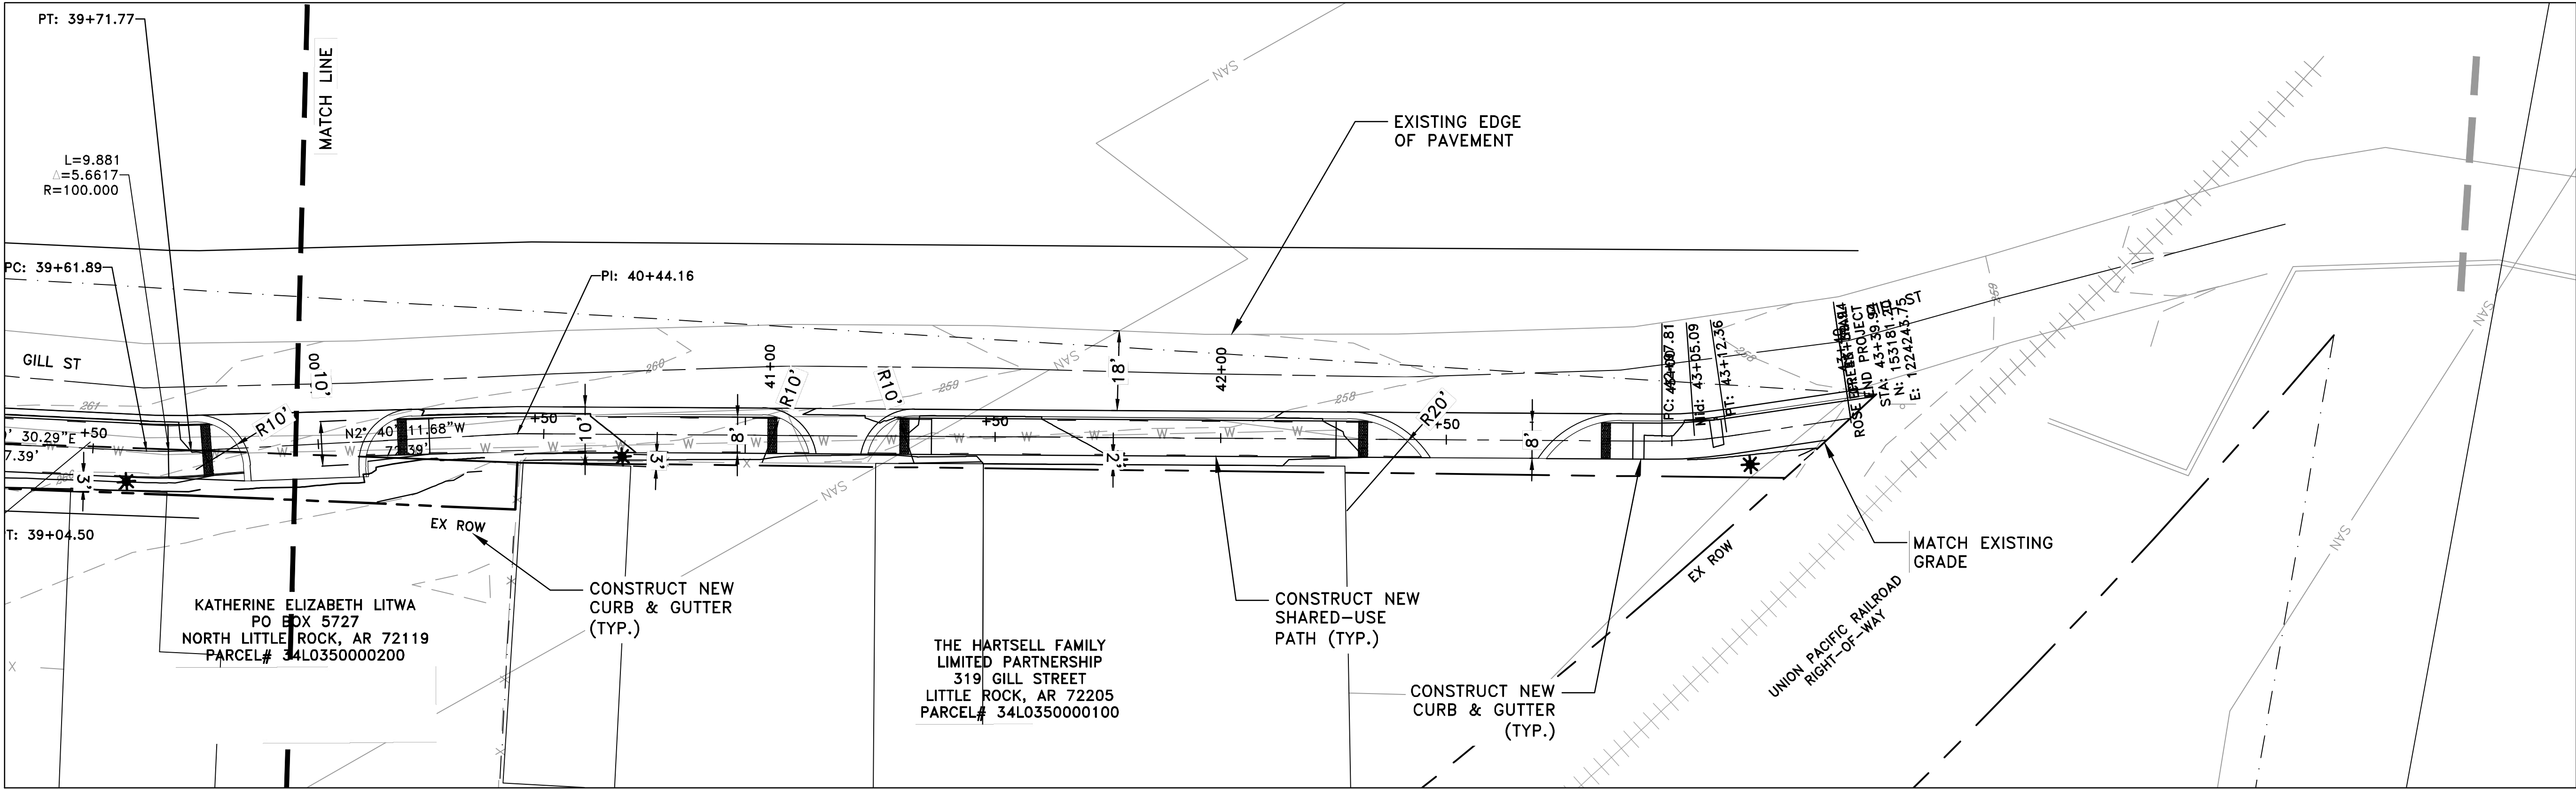

100% SUBMITTAL

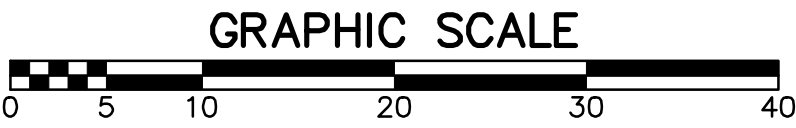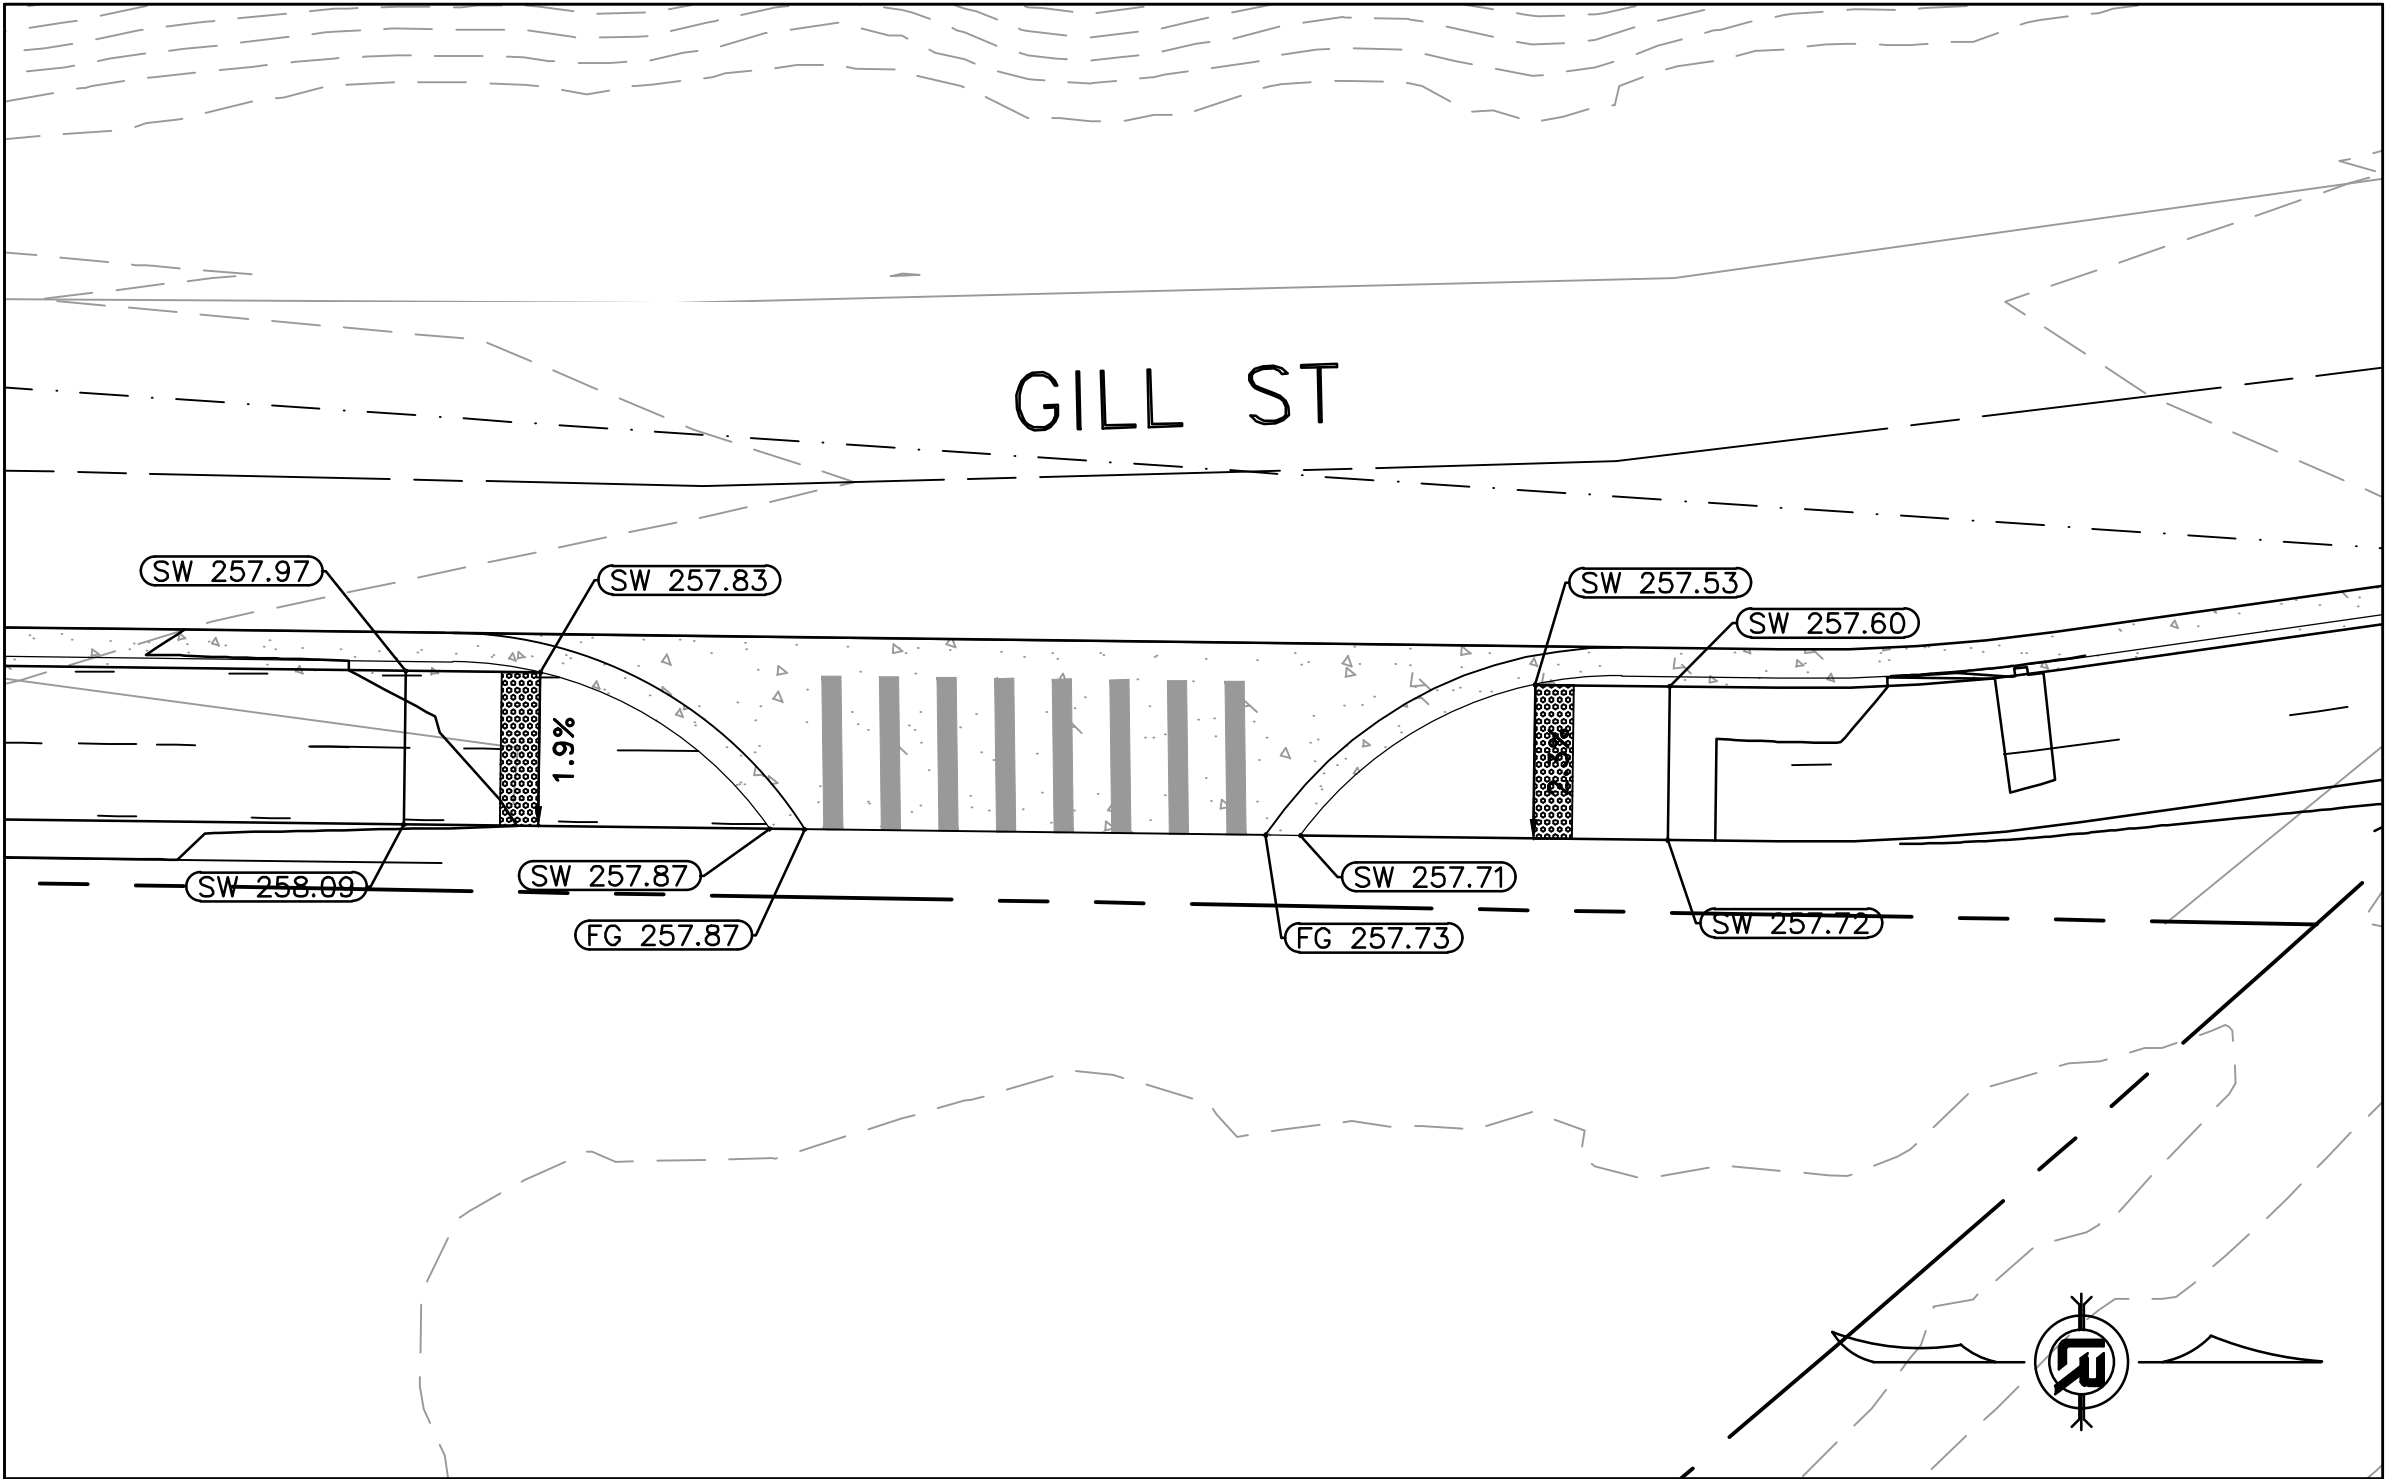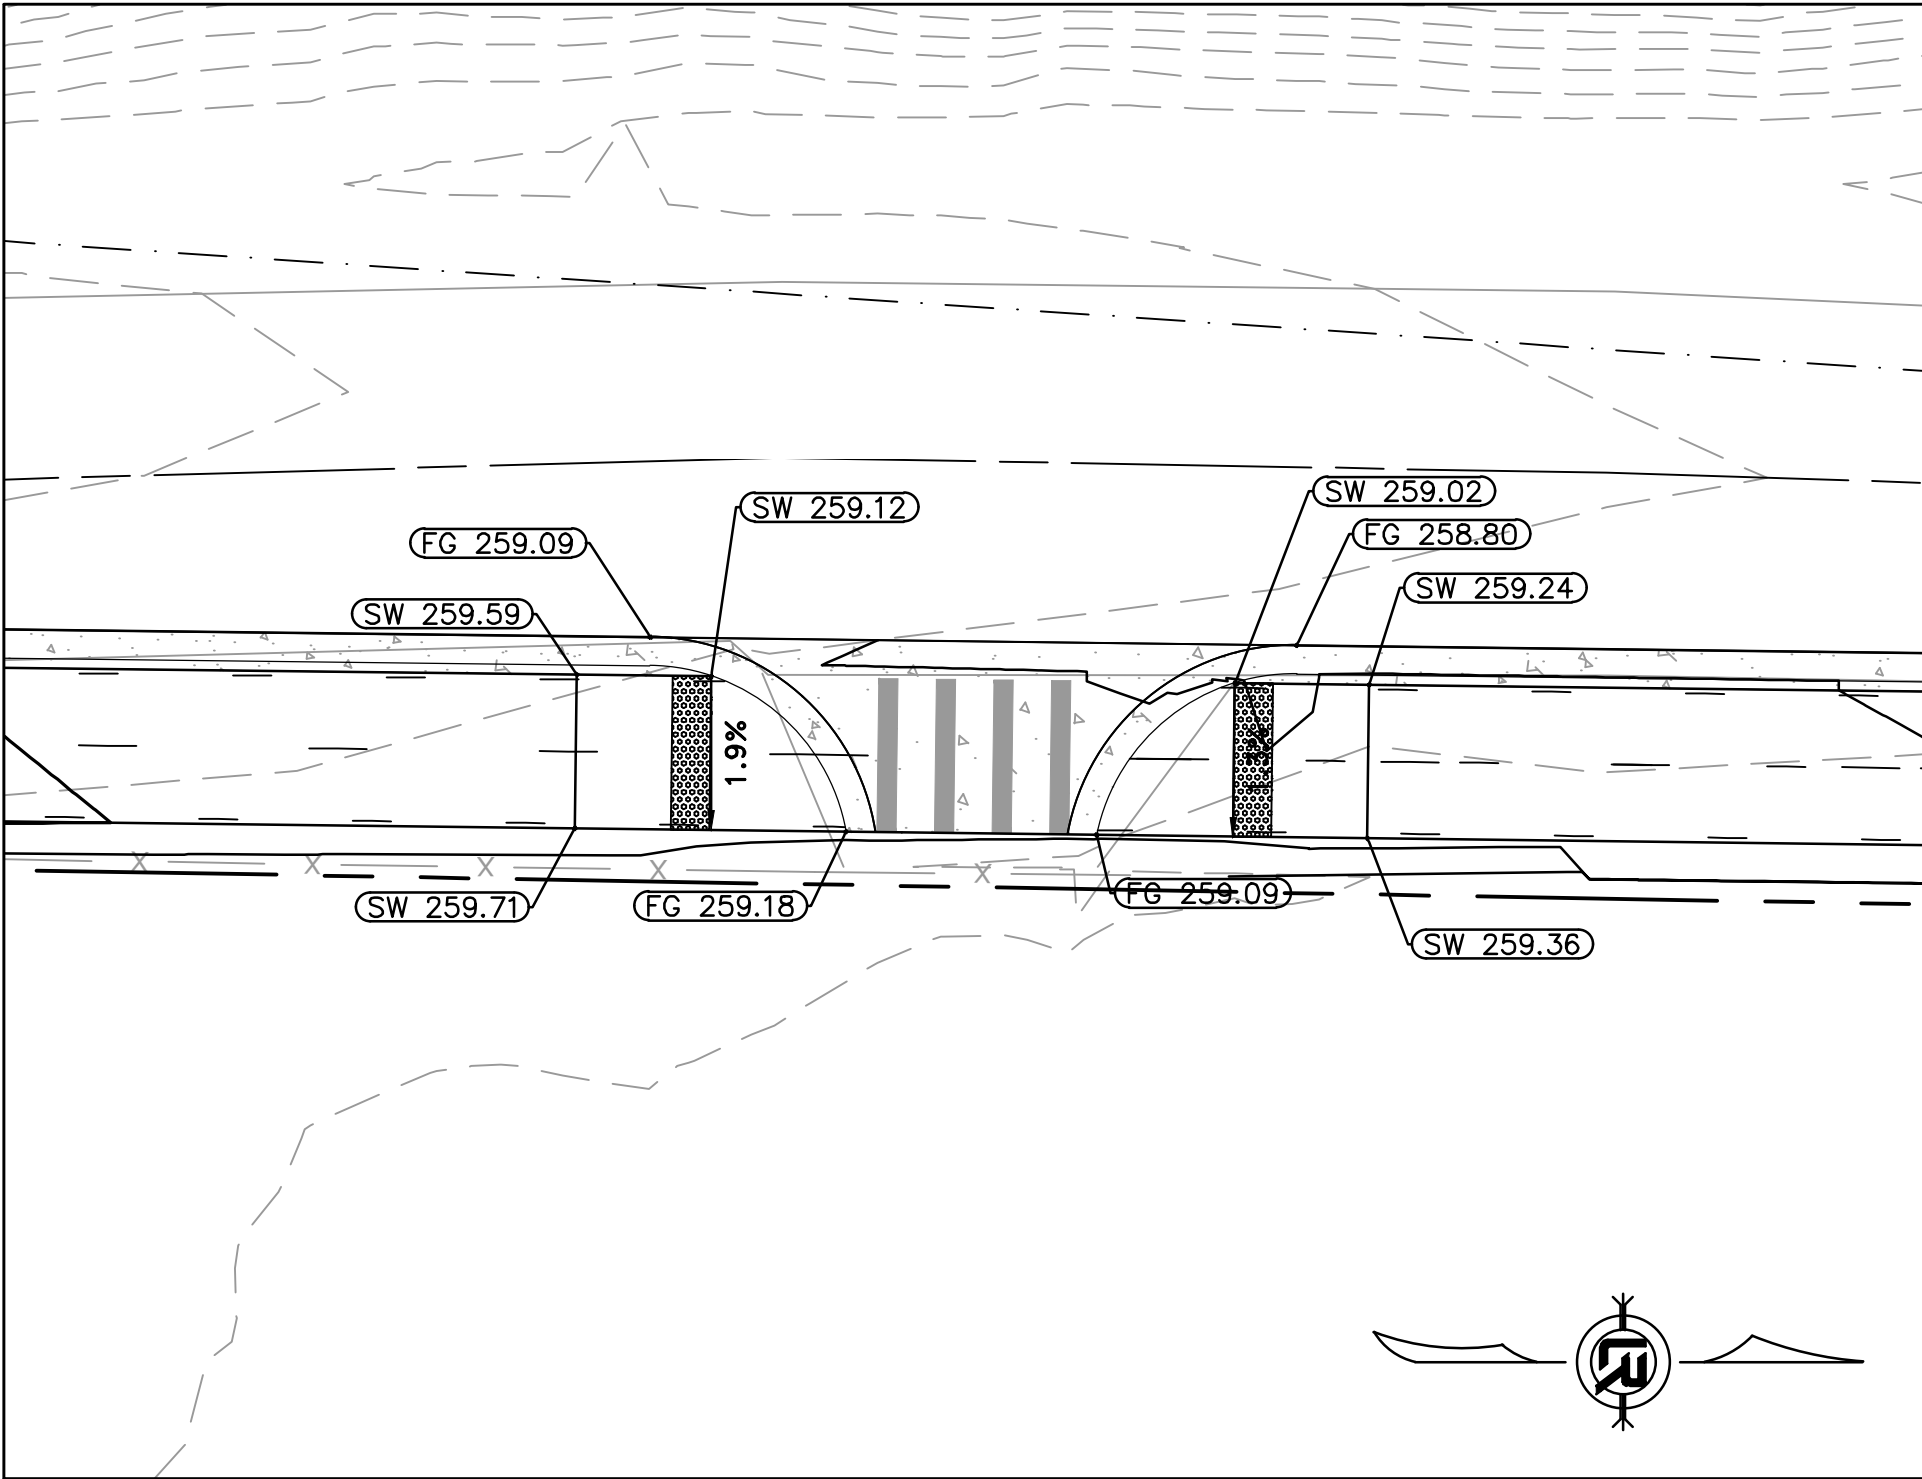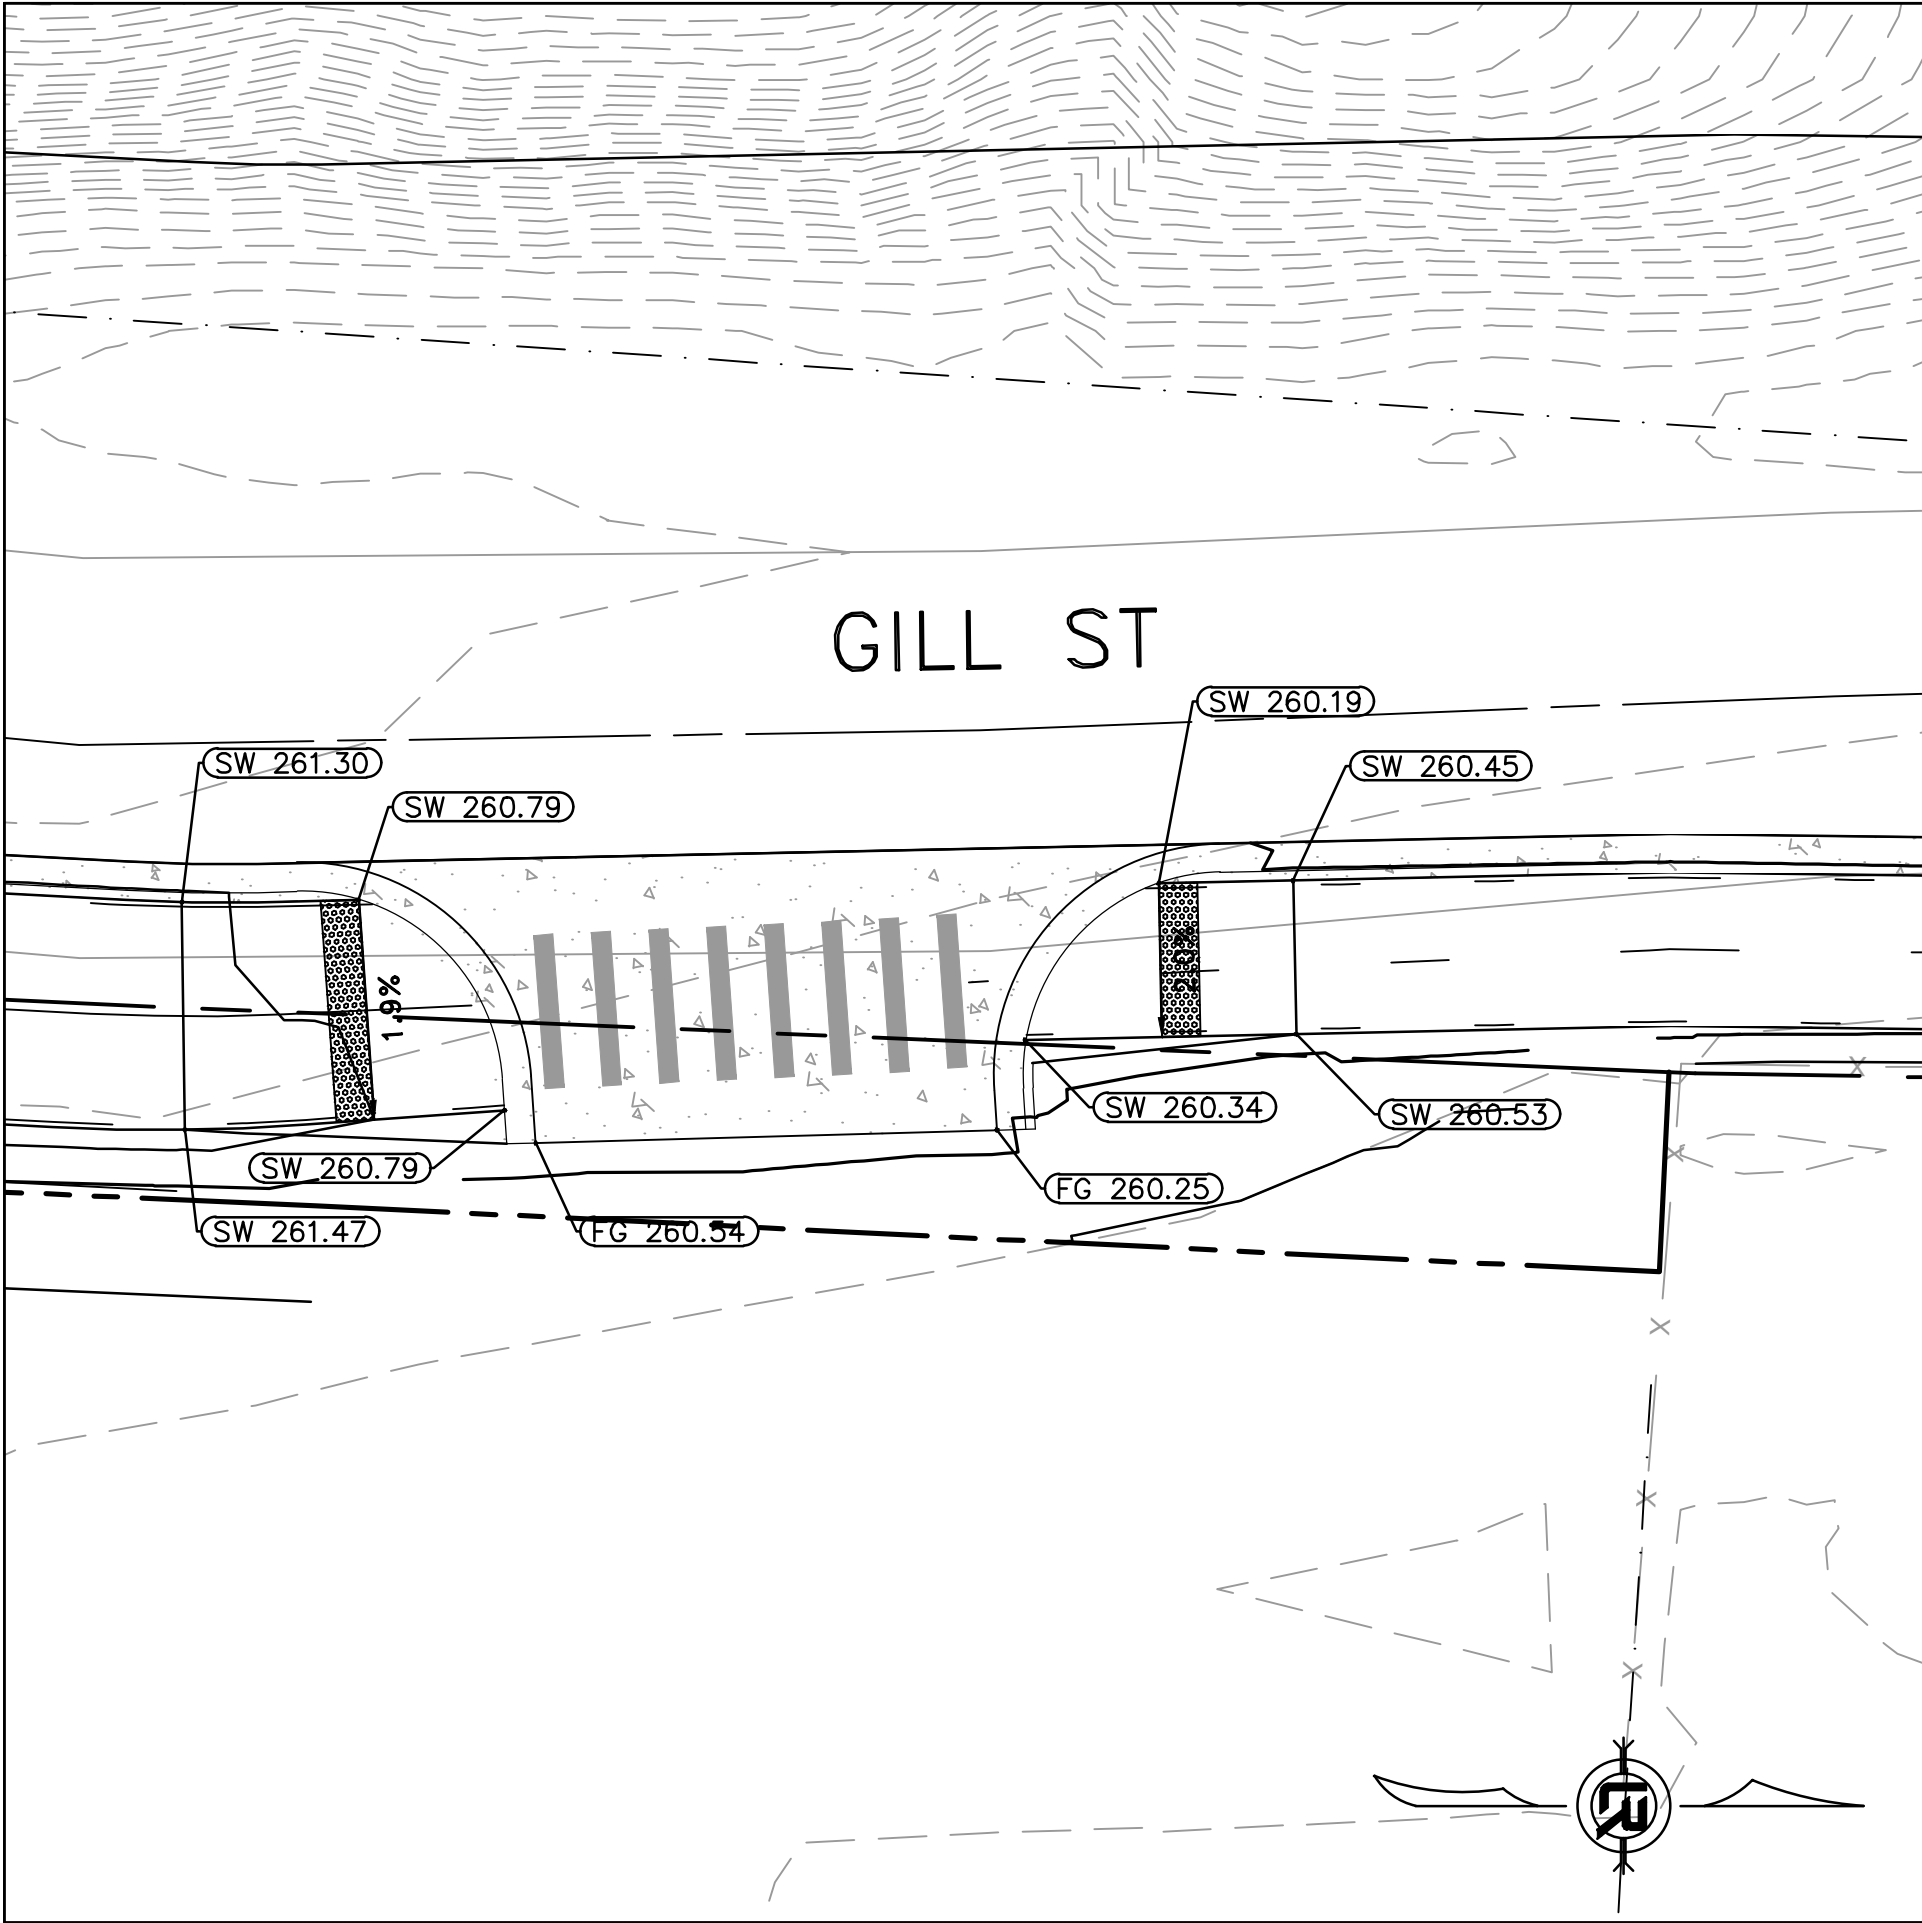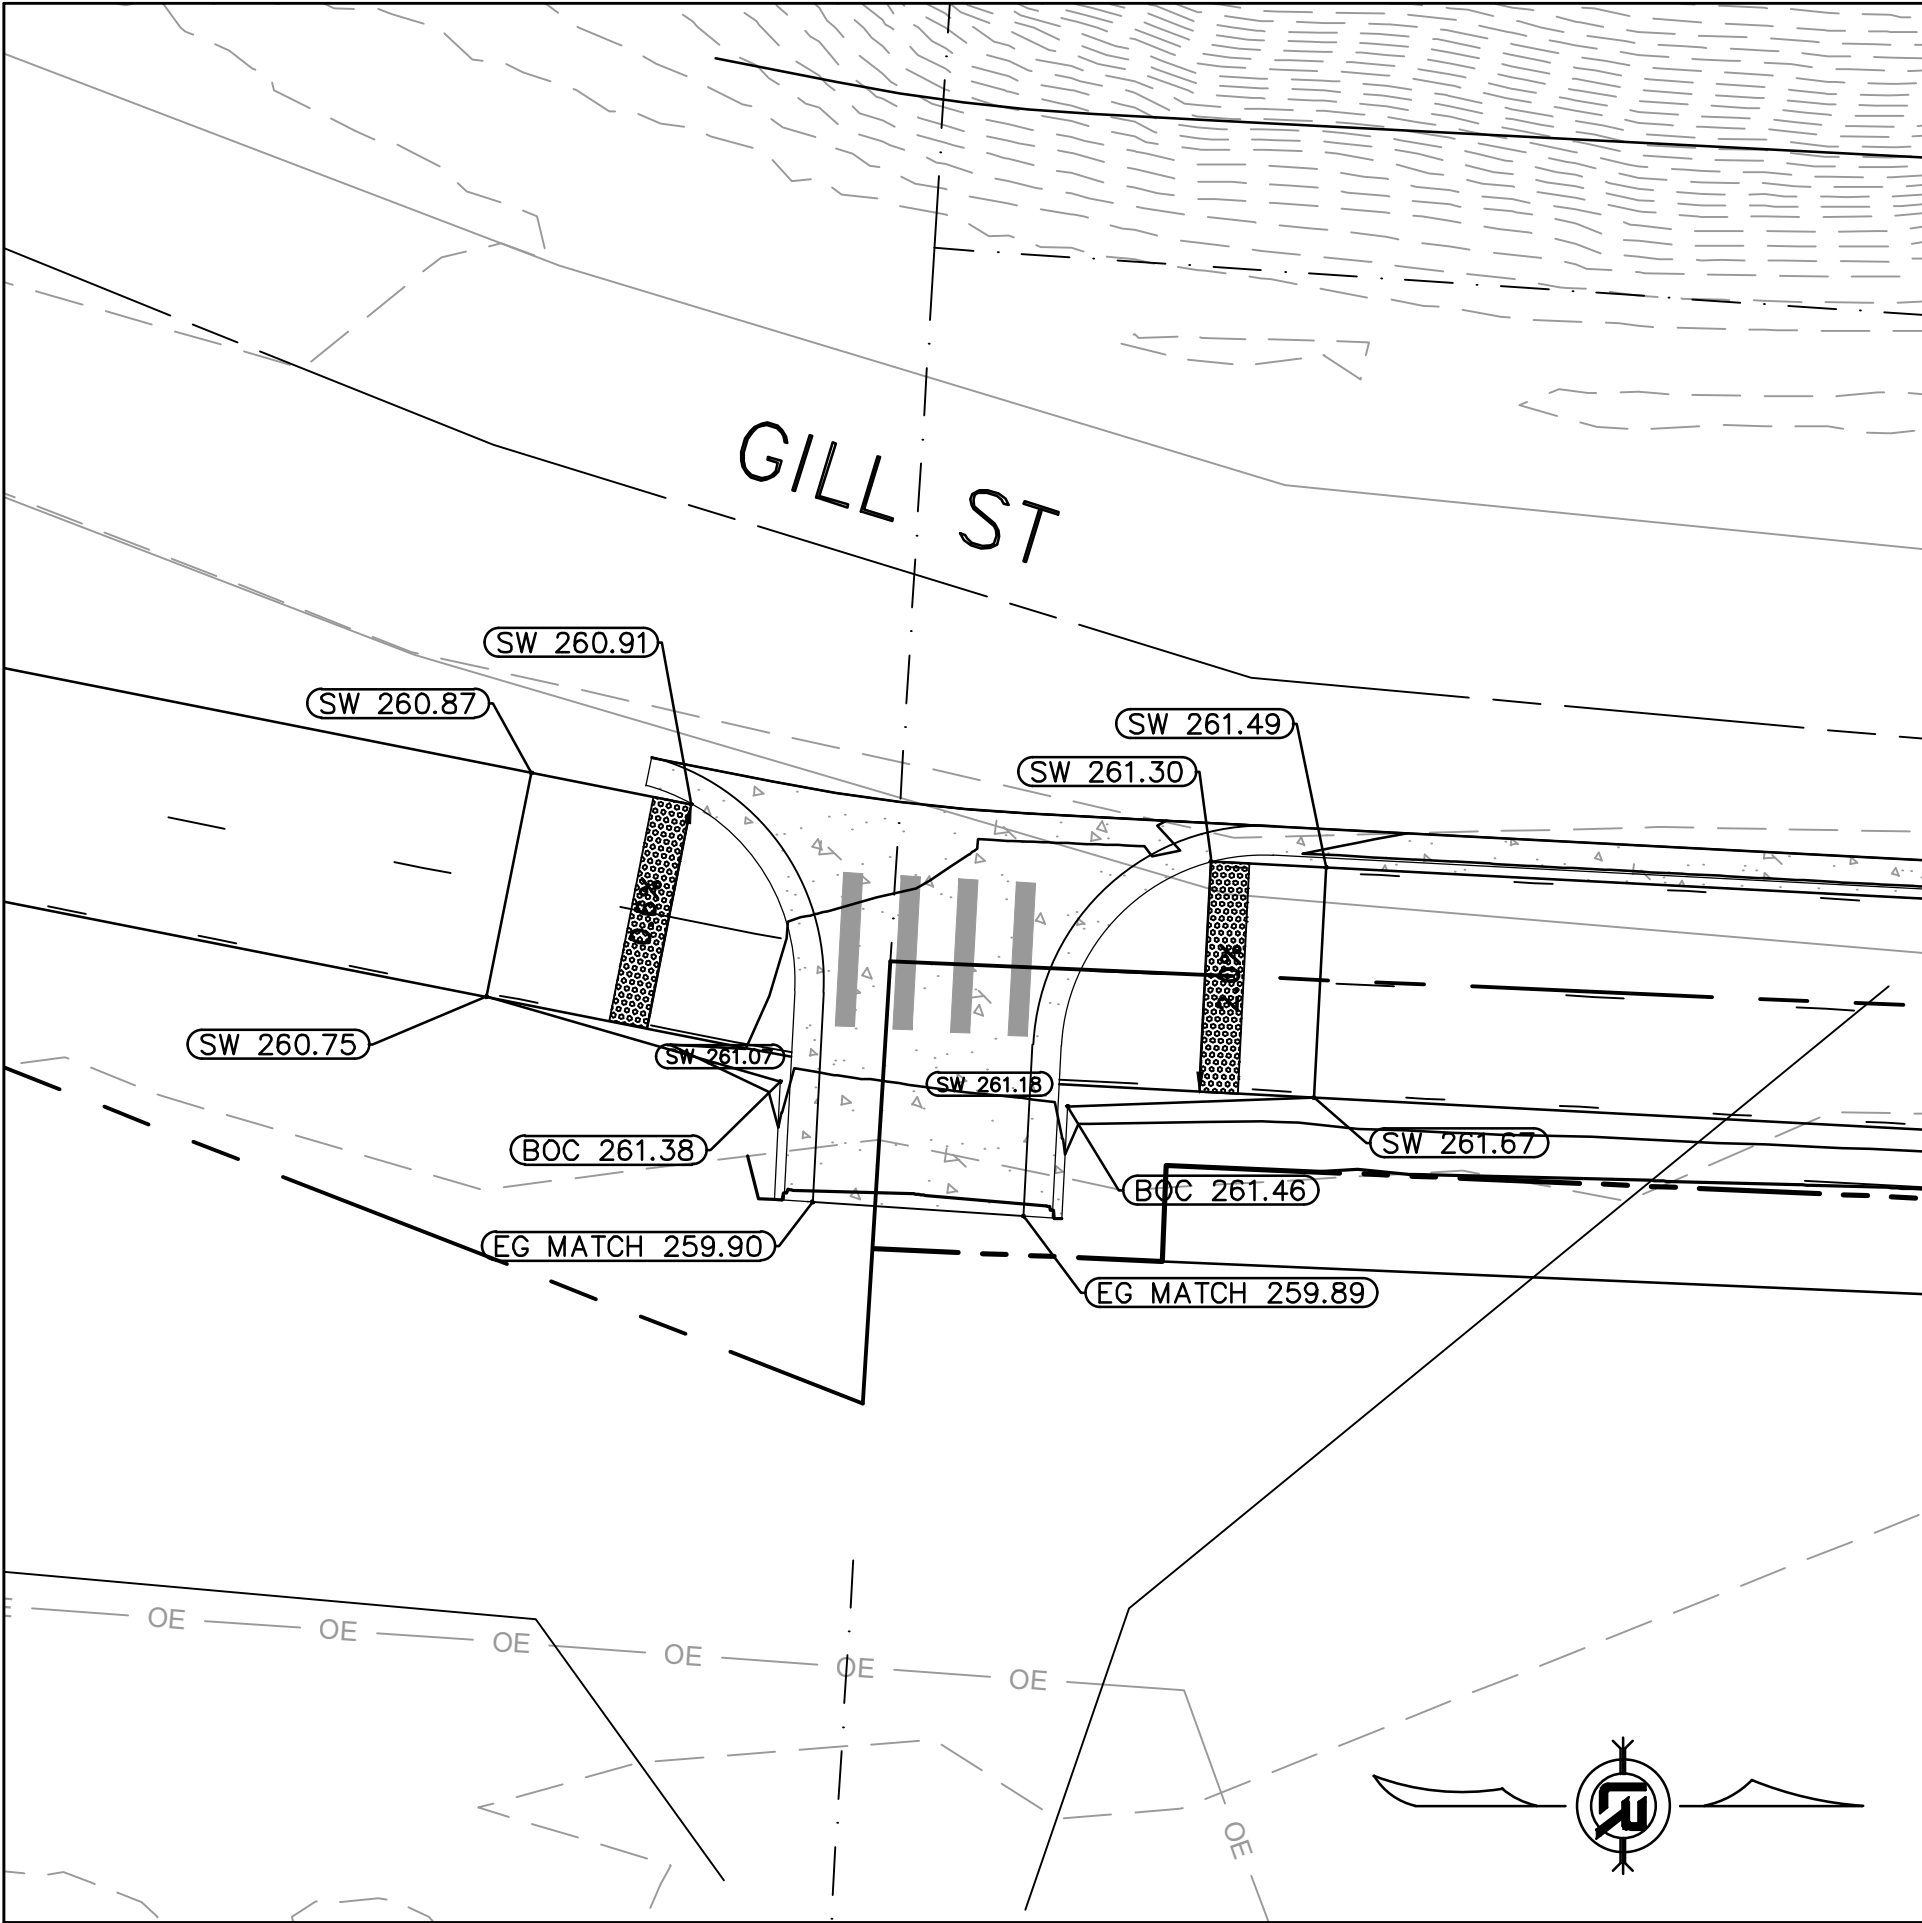

REVISIONS	DATE

CITY OF LITTLE ROCK, ARKANSAS
ROSE CREEK TRAIL
DRIVEWAY PLAN

DEPARTMENT OF PUBLIC WORKS
CIVIL ENGINEERING
701 W. MARKHAM
LITTLE ROCK, ARKANSAS 72201



DRAWN BY	AS
DESIGNED	LC
CHECKED	JM
DATE	05-01-2026
SCALE	1"=10'
PROJECT NO.	23805201
SHEET NO.	C27

REVISIONS	DATE

CITY OF LITTLE ROCK, ARKANSAS

ROSE CREEK TRAIL

CENTERLINE FIELD TIES SHEET 1

DEPARTMENT OF PUBLIC WORKS

CIVIL ENGINEERING

701 W. MARKHAM

LITTLE ROCK, ARKANSAS 72201



STATE OF ARKANSAS

REGISTERED PROFESSIONAL ENGINEER

BRADLEY A. PETERSON

9/3/26

DRAWN BY

AS

DESIGNED

LC

CHECKED

JM

DATE

05-01-2026

SCALE

H: 1"=20'




V: 1"=5'

PROJECT NO.


23805201

SHEET NO.

C28

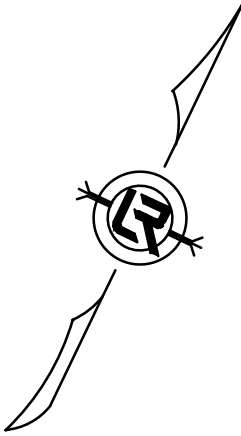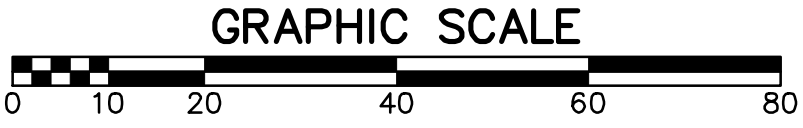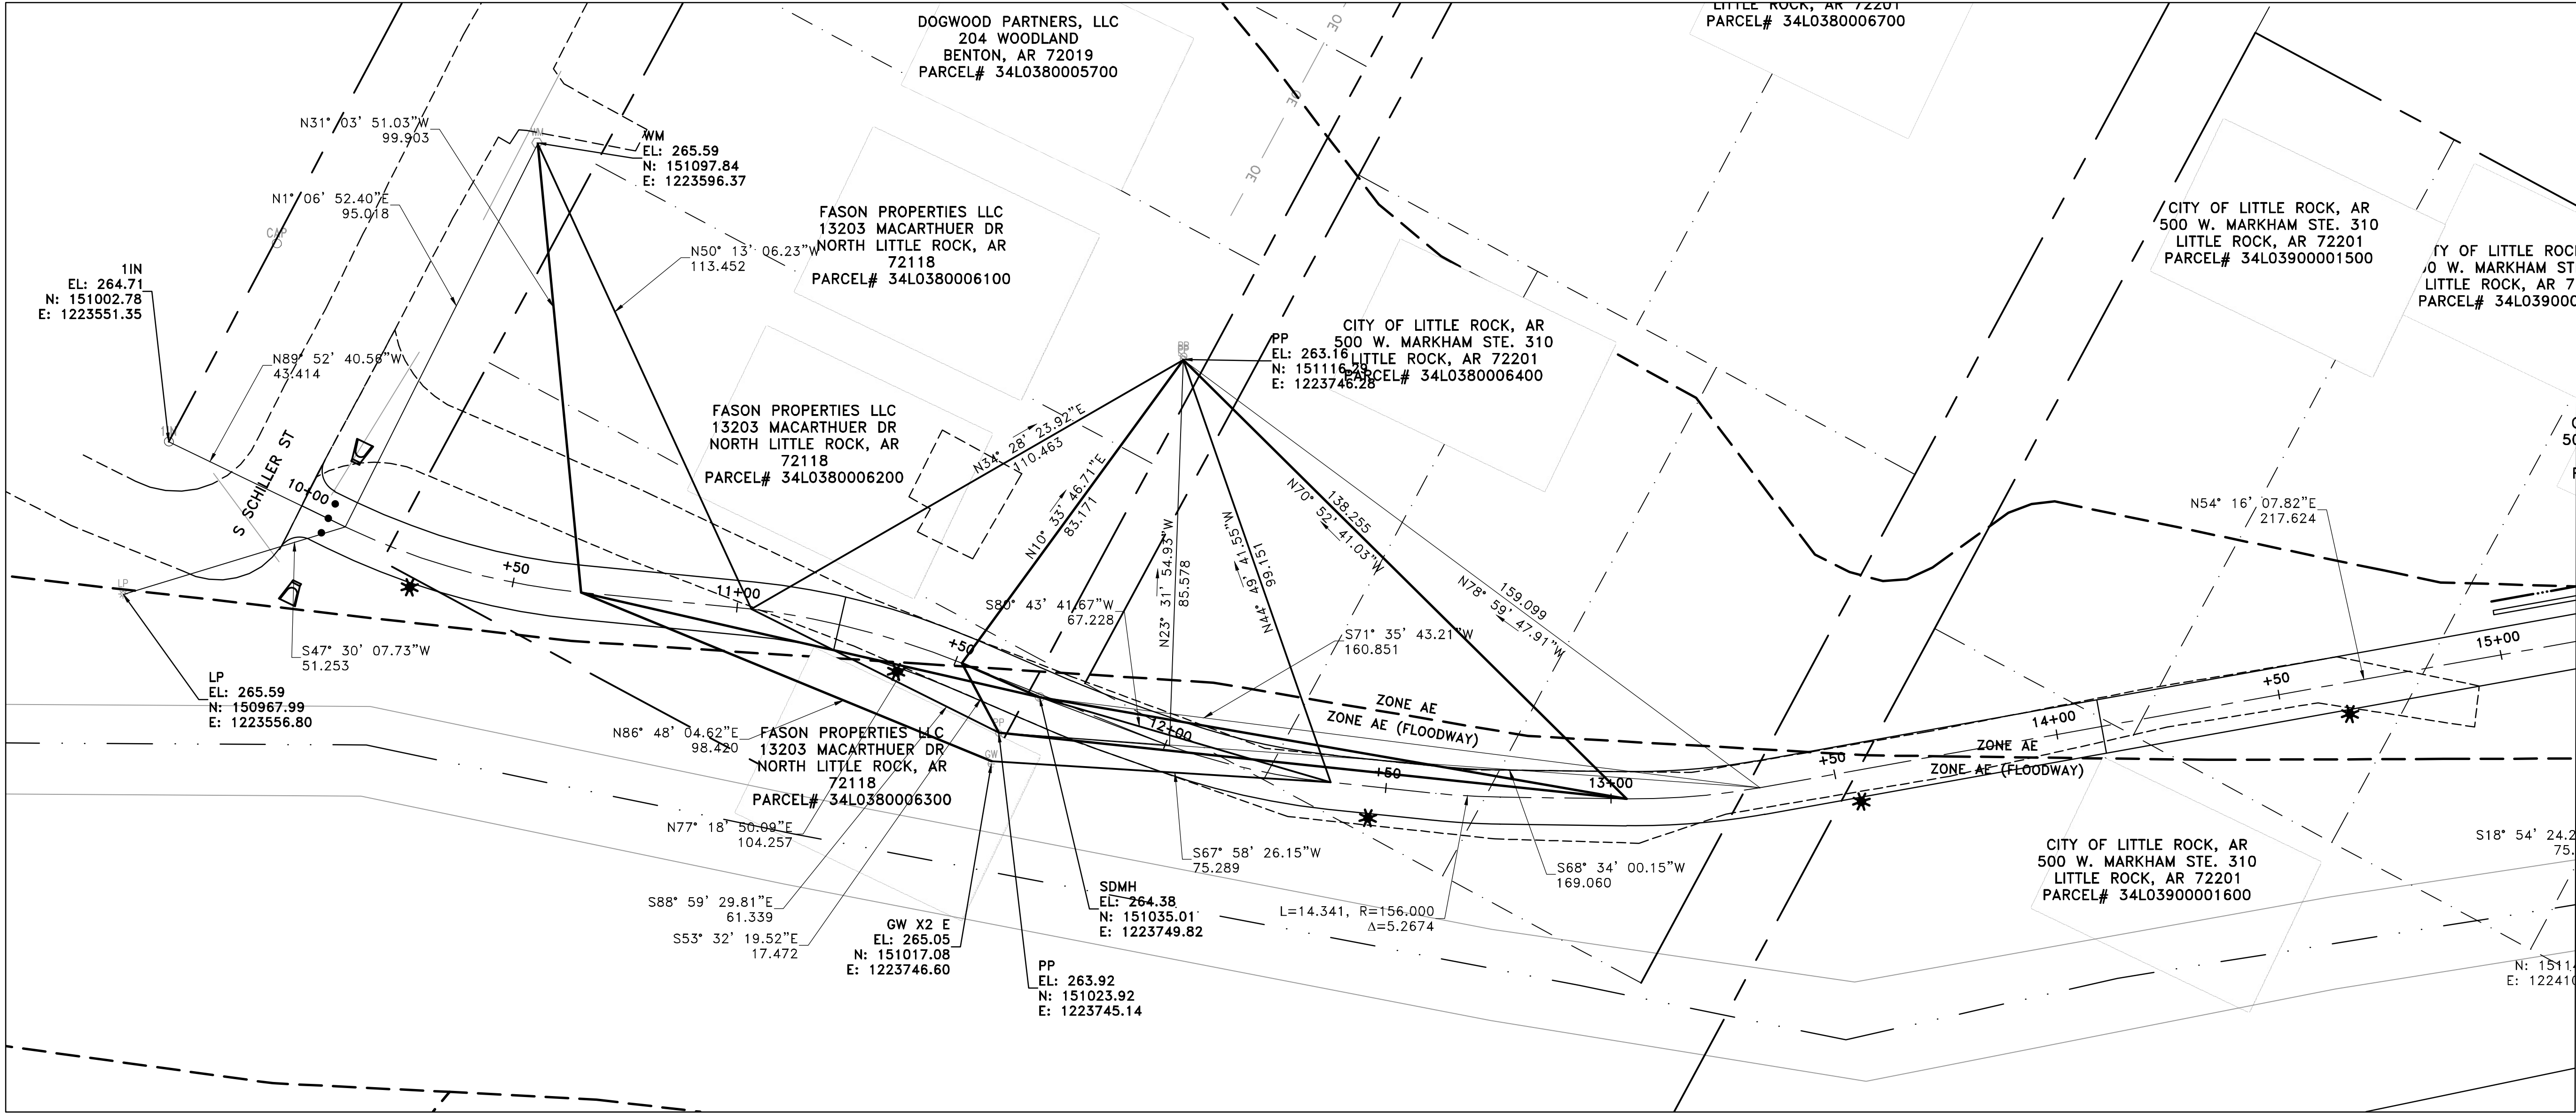

100% SUBMITTAL

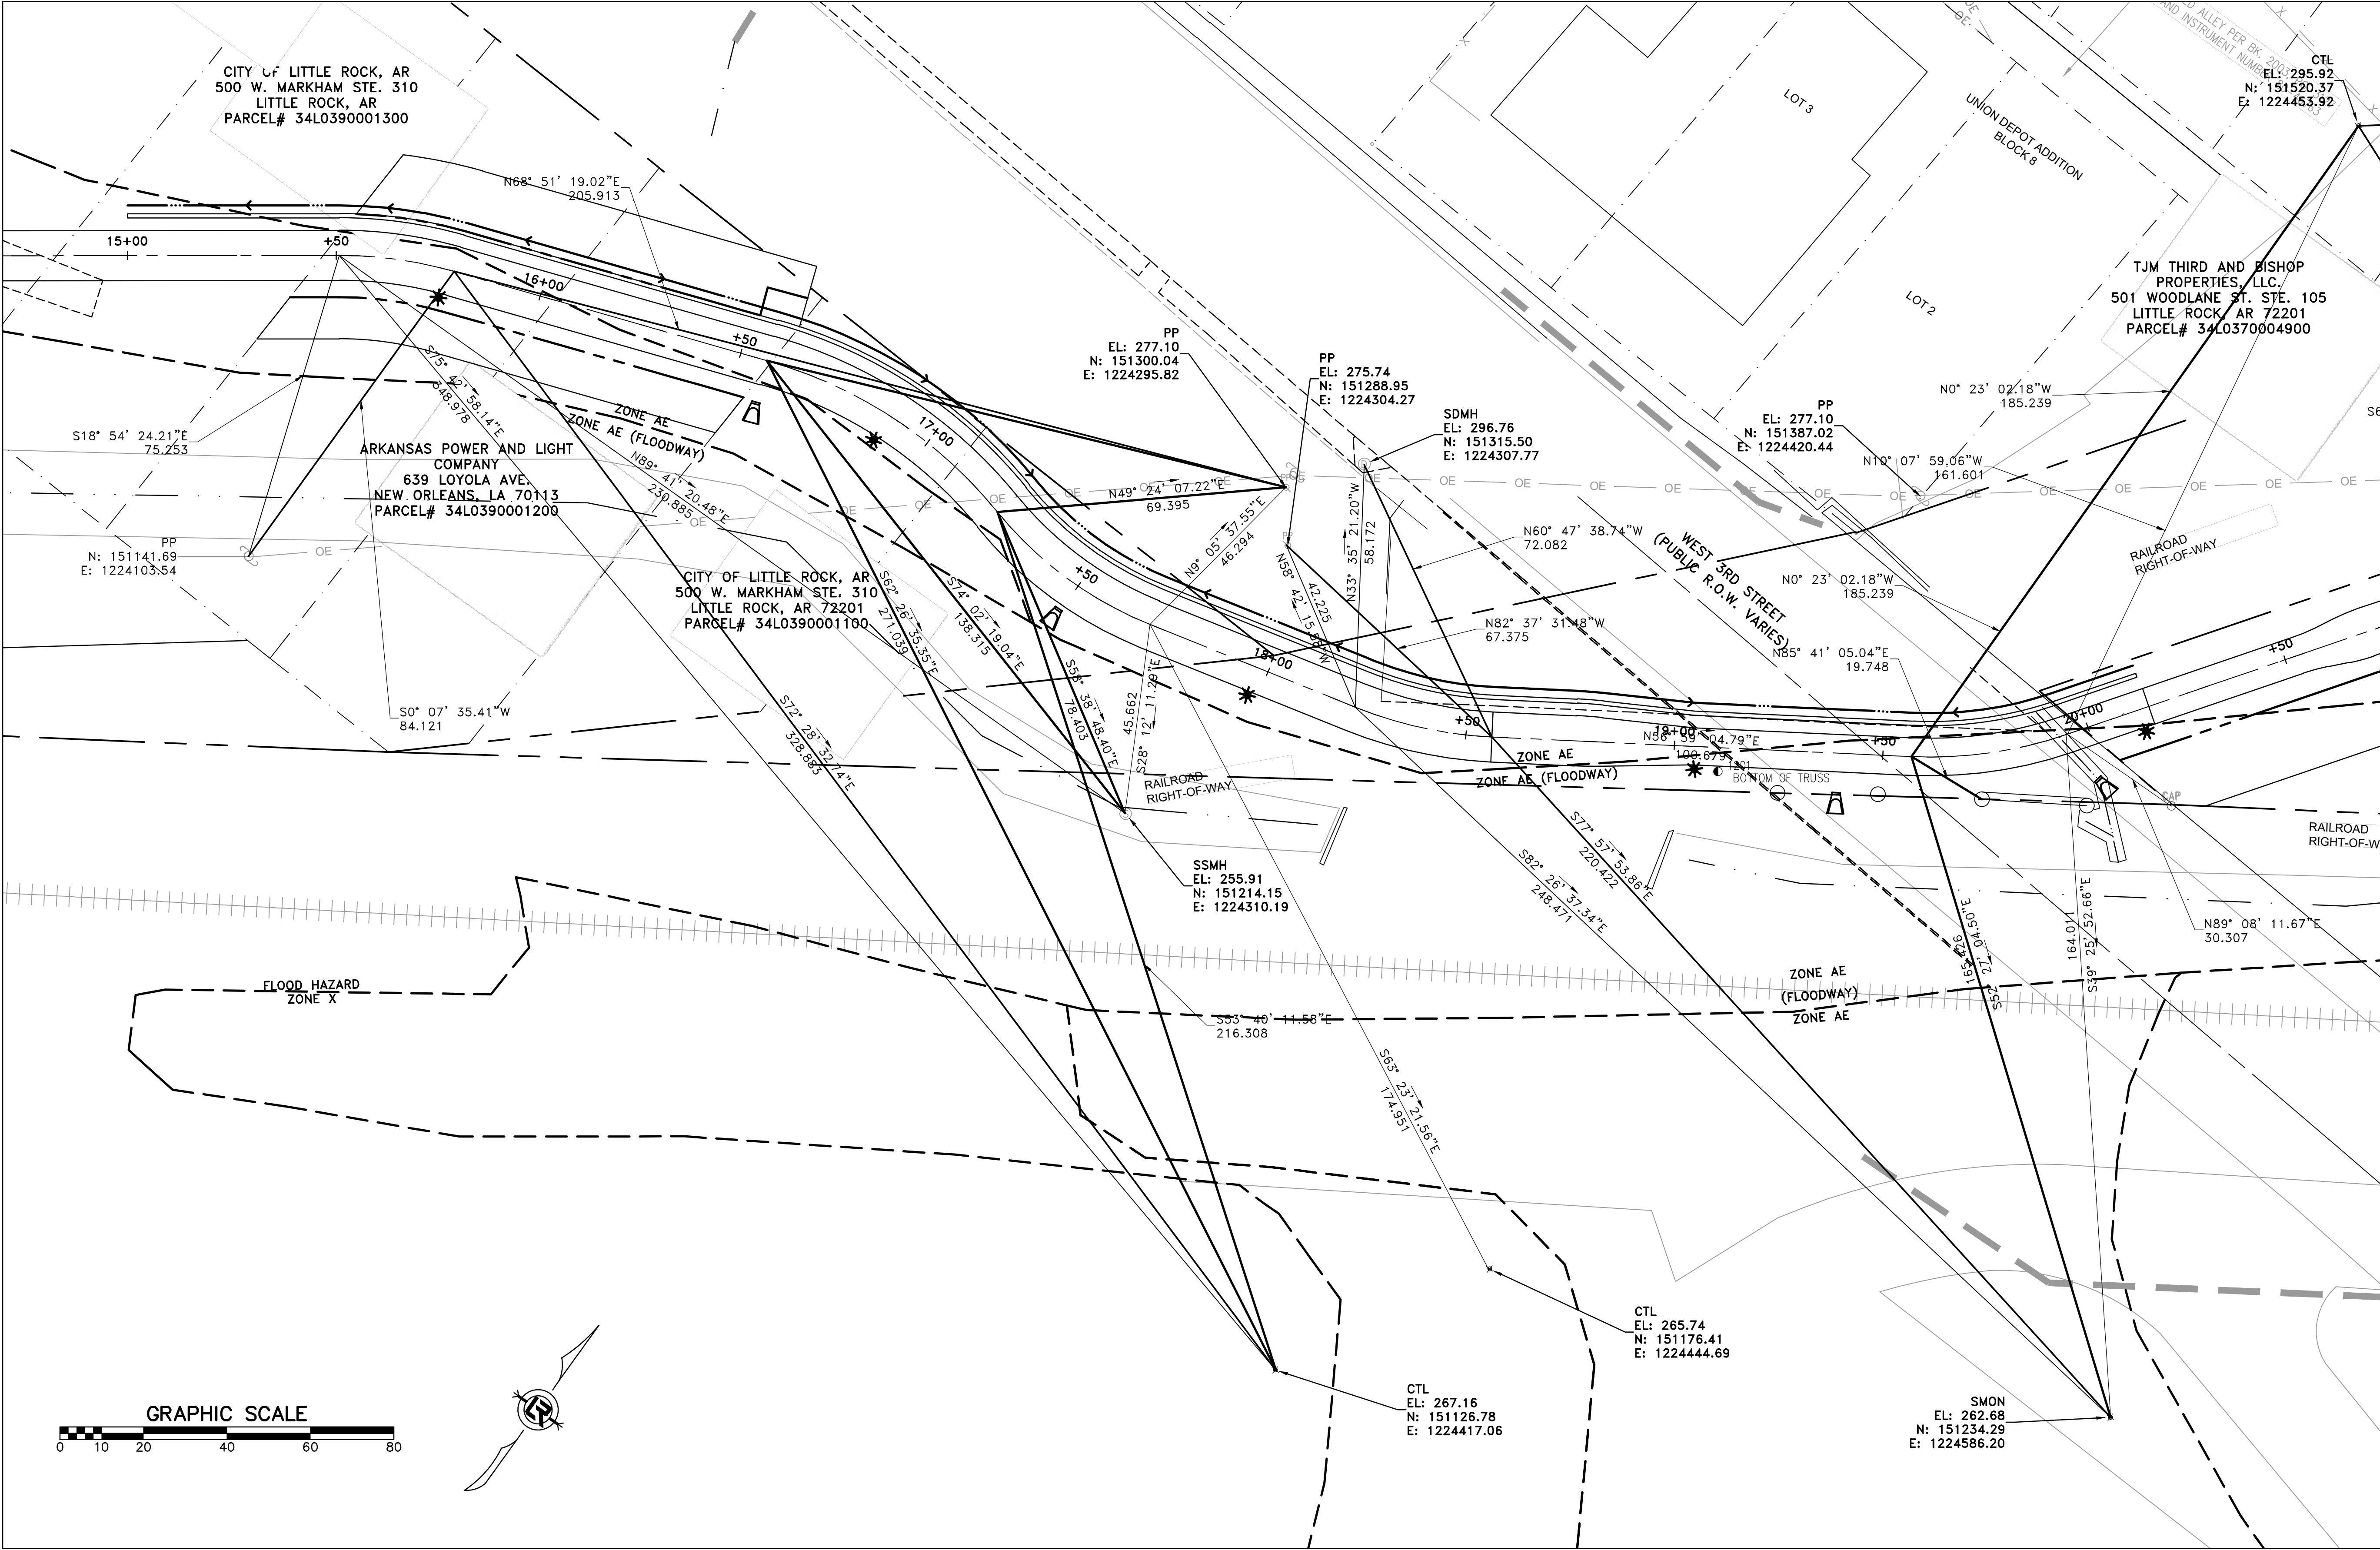

REVISIONS	DATE

CITY OF LITTLE ROCK, ARKANSAS
ROSE CREEK TRAIL
CENTERLINE FIELD TIES SHEET 2

DEPARTMENT OF PUBLIC WORKS
CIVIL ENGINEERING
701 W. MARKHAM
LITTLE ROCK, ARKANSAS 72201



DRAWN BY	AS
DESIGNED	LC
CHECKED	JM
DATE	05-01-2026
SCALE	H: 1"=20' V: 1"=5'
PROJECT NO.	23805201
SHEET NO.	C29

100% SUBMITTAL




REVISIONS	DATE

CITY OF LITTLE ROCK, ARKANSAS
ROSE CREEK TRAIL
CENTERLINE FIELD TIES SHEET 3

DEPARTMENT OF PUBLIC WORKS
CIVIL ENGINEERING
701 W. MARKHAM
LITTLE ROCK, ARKANSAS 72201



DRAWN BY	AS
DESIGNED	LC
CHECKED	JM
DATE	05-01-2026
SCALE	H: 1"=20' V: 1"=5'
PROJECT NO.	23805201
SHEET NO.	C30

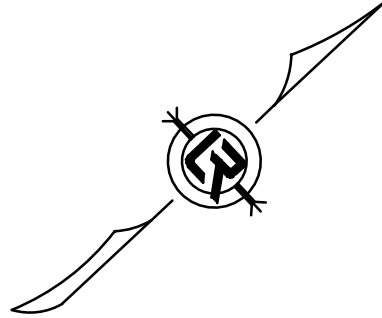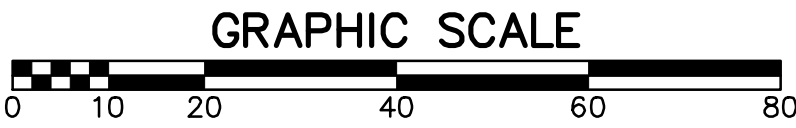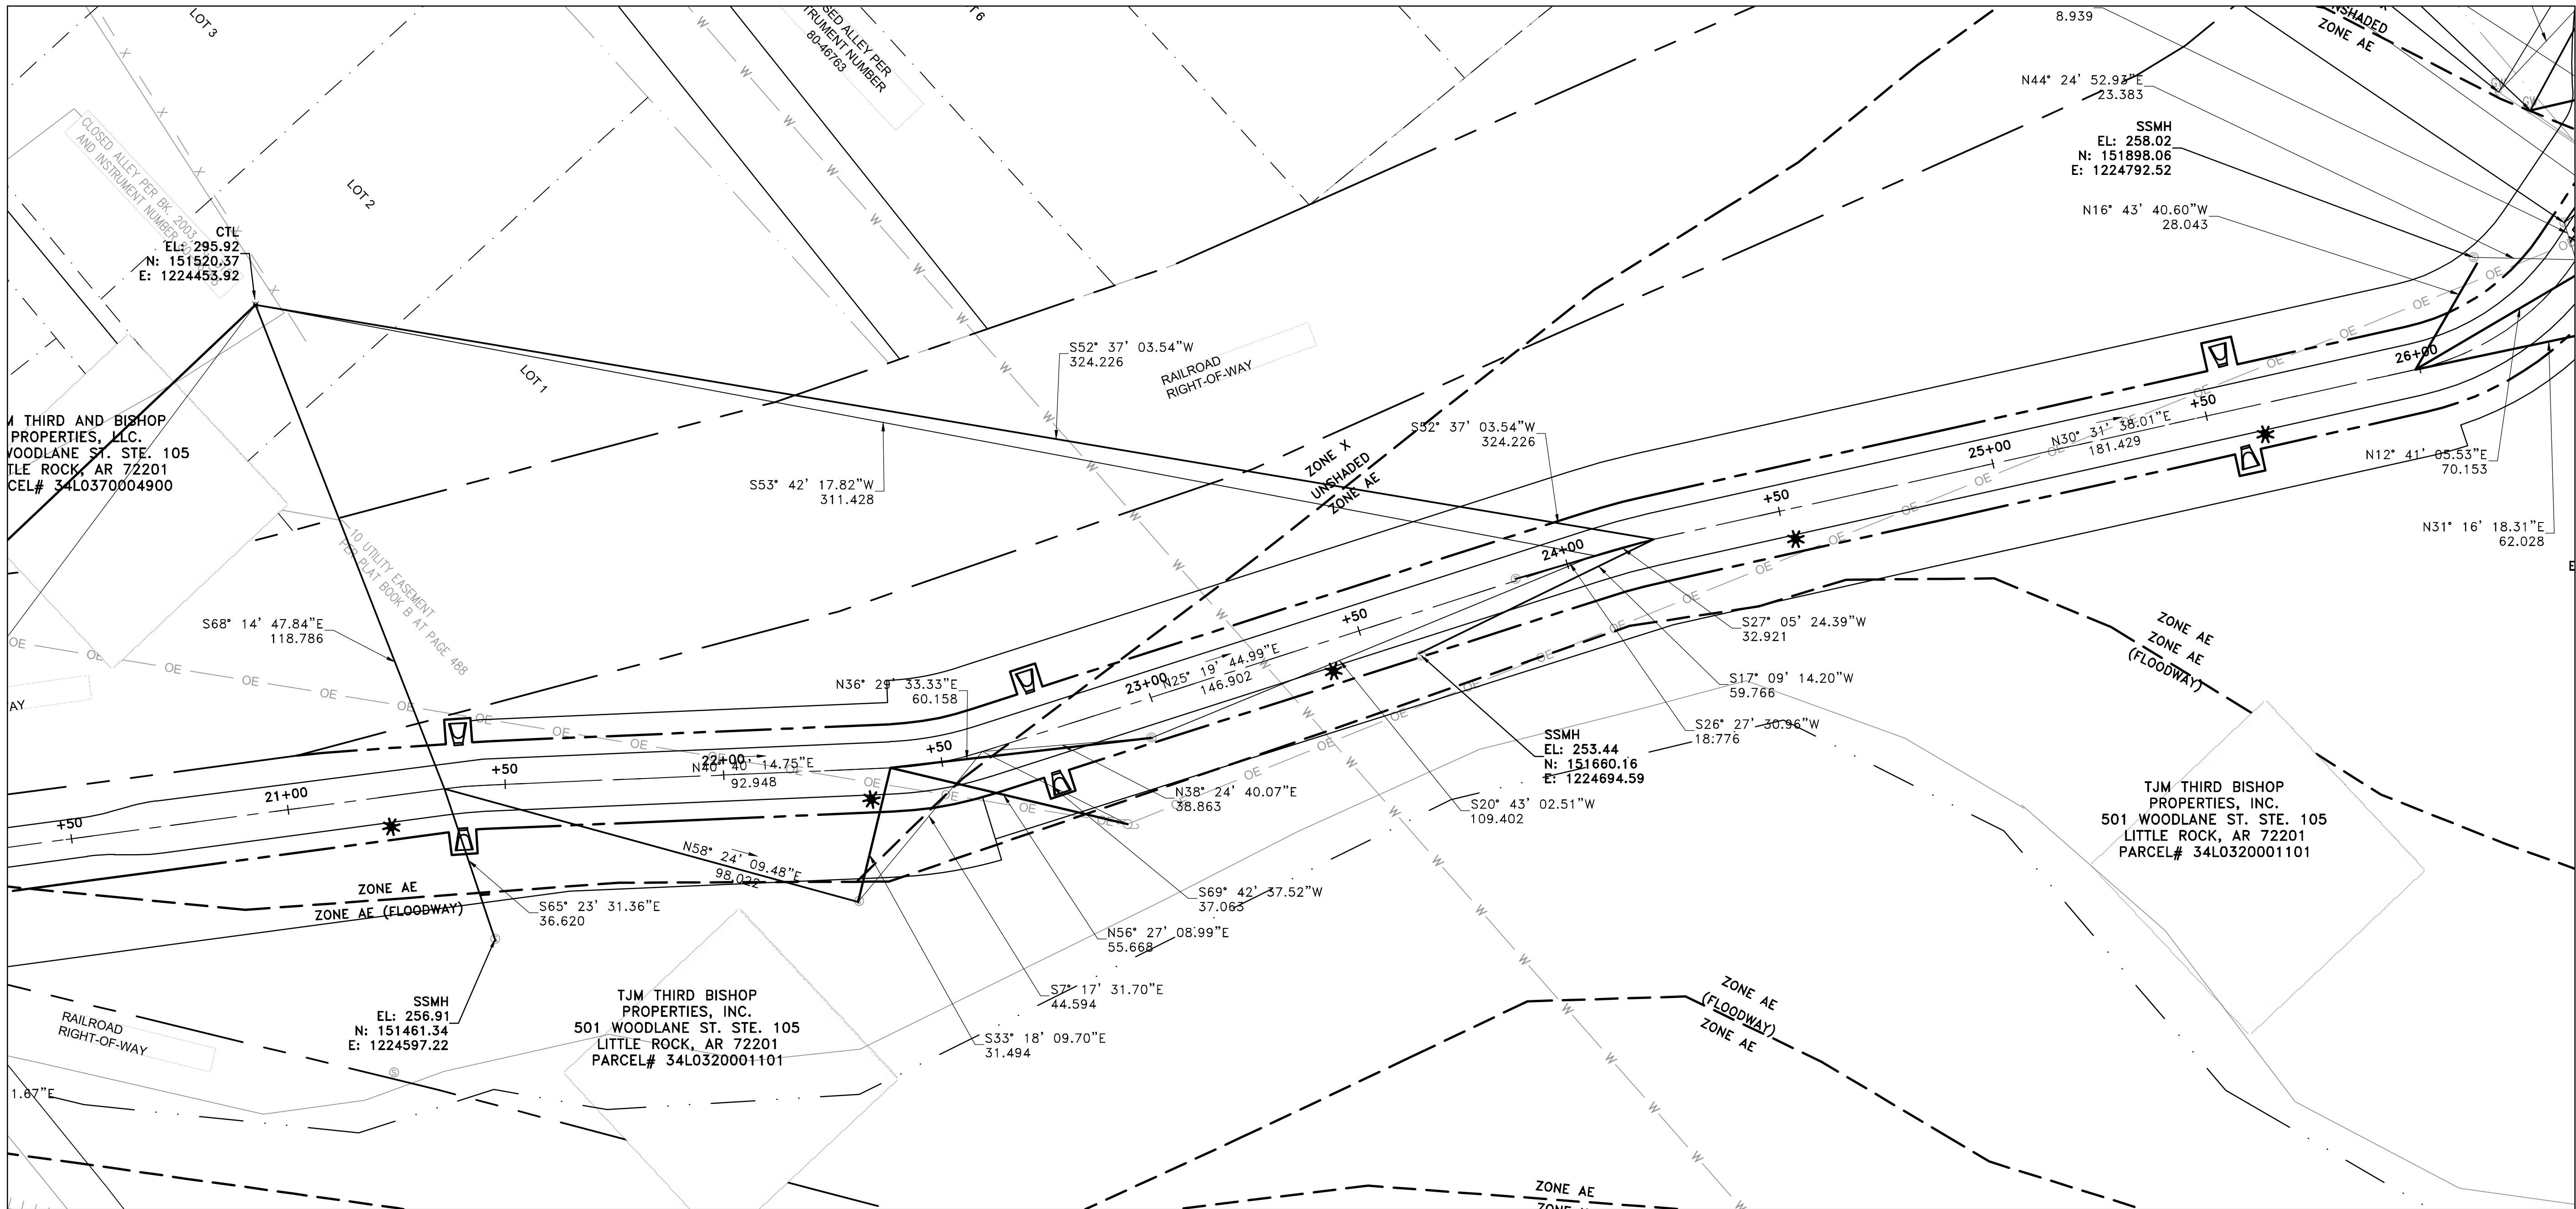

100% SUBMITTAL




REVISIONS	DATE

CITY OF LITTLE ROCK, ARKANSAS
ROSE CREEK TRAIL
CENTERLINE FIELD TIES SHEET 4

DEPARTMENT OF PUBLIC WORKS
CIVIL ENGINEERING
701 W. MARKHAM
LITTLE ROCK, ARKANSAS 72201



DRAWN BY	AS
DESIGNED	LC
CHECKED	JM
DATE	05-01-2026
SCALE	H: 1"=20' V: 1"=5'
PROJECT NO.	23805201
SHEET NO.	C31

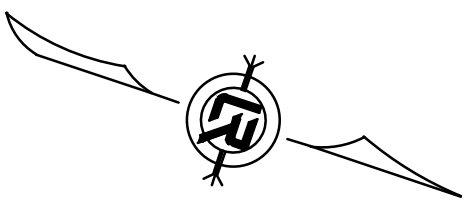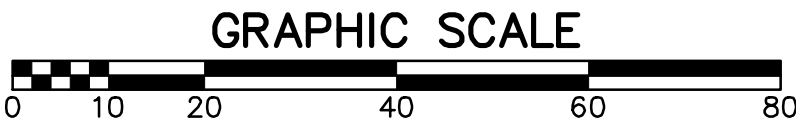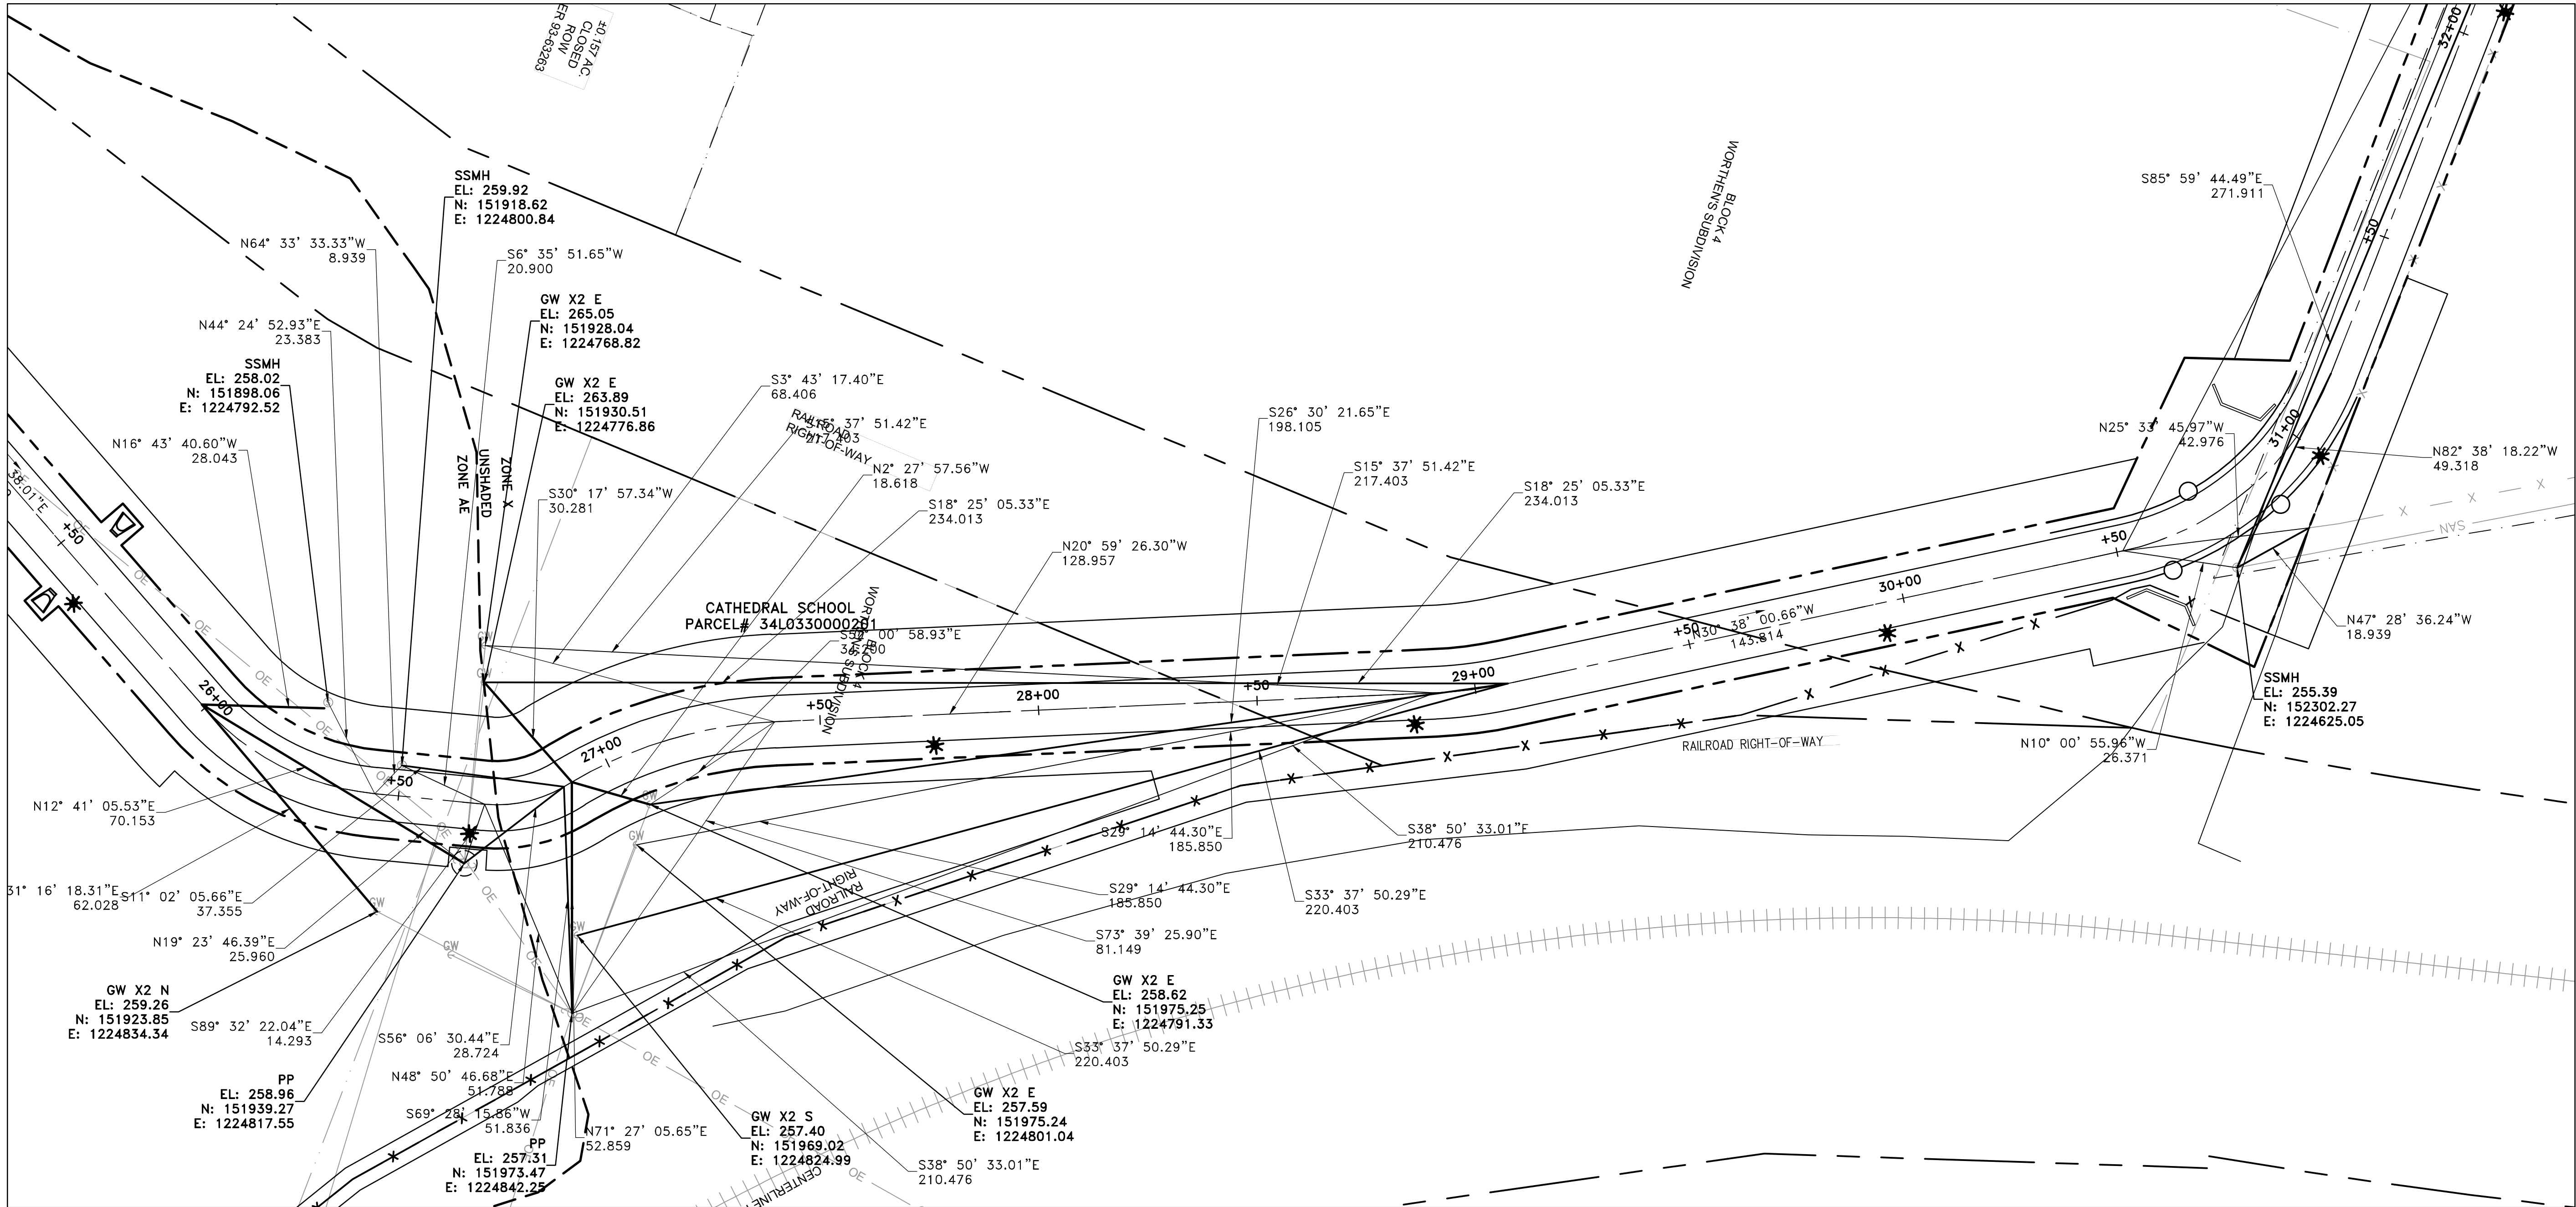




REVISIONS	DATE

CITY OF LITTLE ROCK, ARKANSAS
ROSE CREEK TRAIL
CENTERLINE FIELD TIES SHEET 5

DEPARTMENT OF PUBLIC WORKS
CIVIL ENGINEERING
701 W. MARKHAM
LITTLE ROCK, ARKANSAS 72201



DRAWN BY	AS
DESIGNED	LC
CHECKED	JM
DATE	05-01-2026
SCALE	H: 1"=20' V: 1"=5'
PROJECT NO.	23805201
SHEET NO.	C32

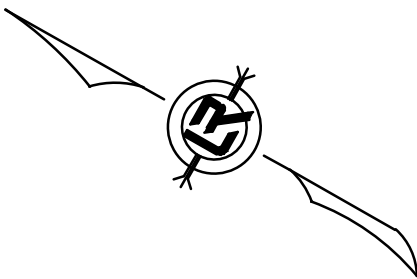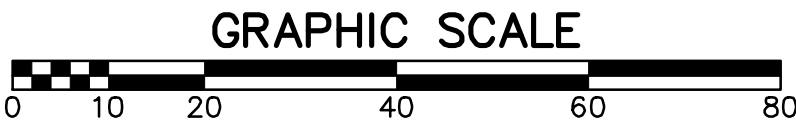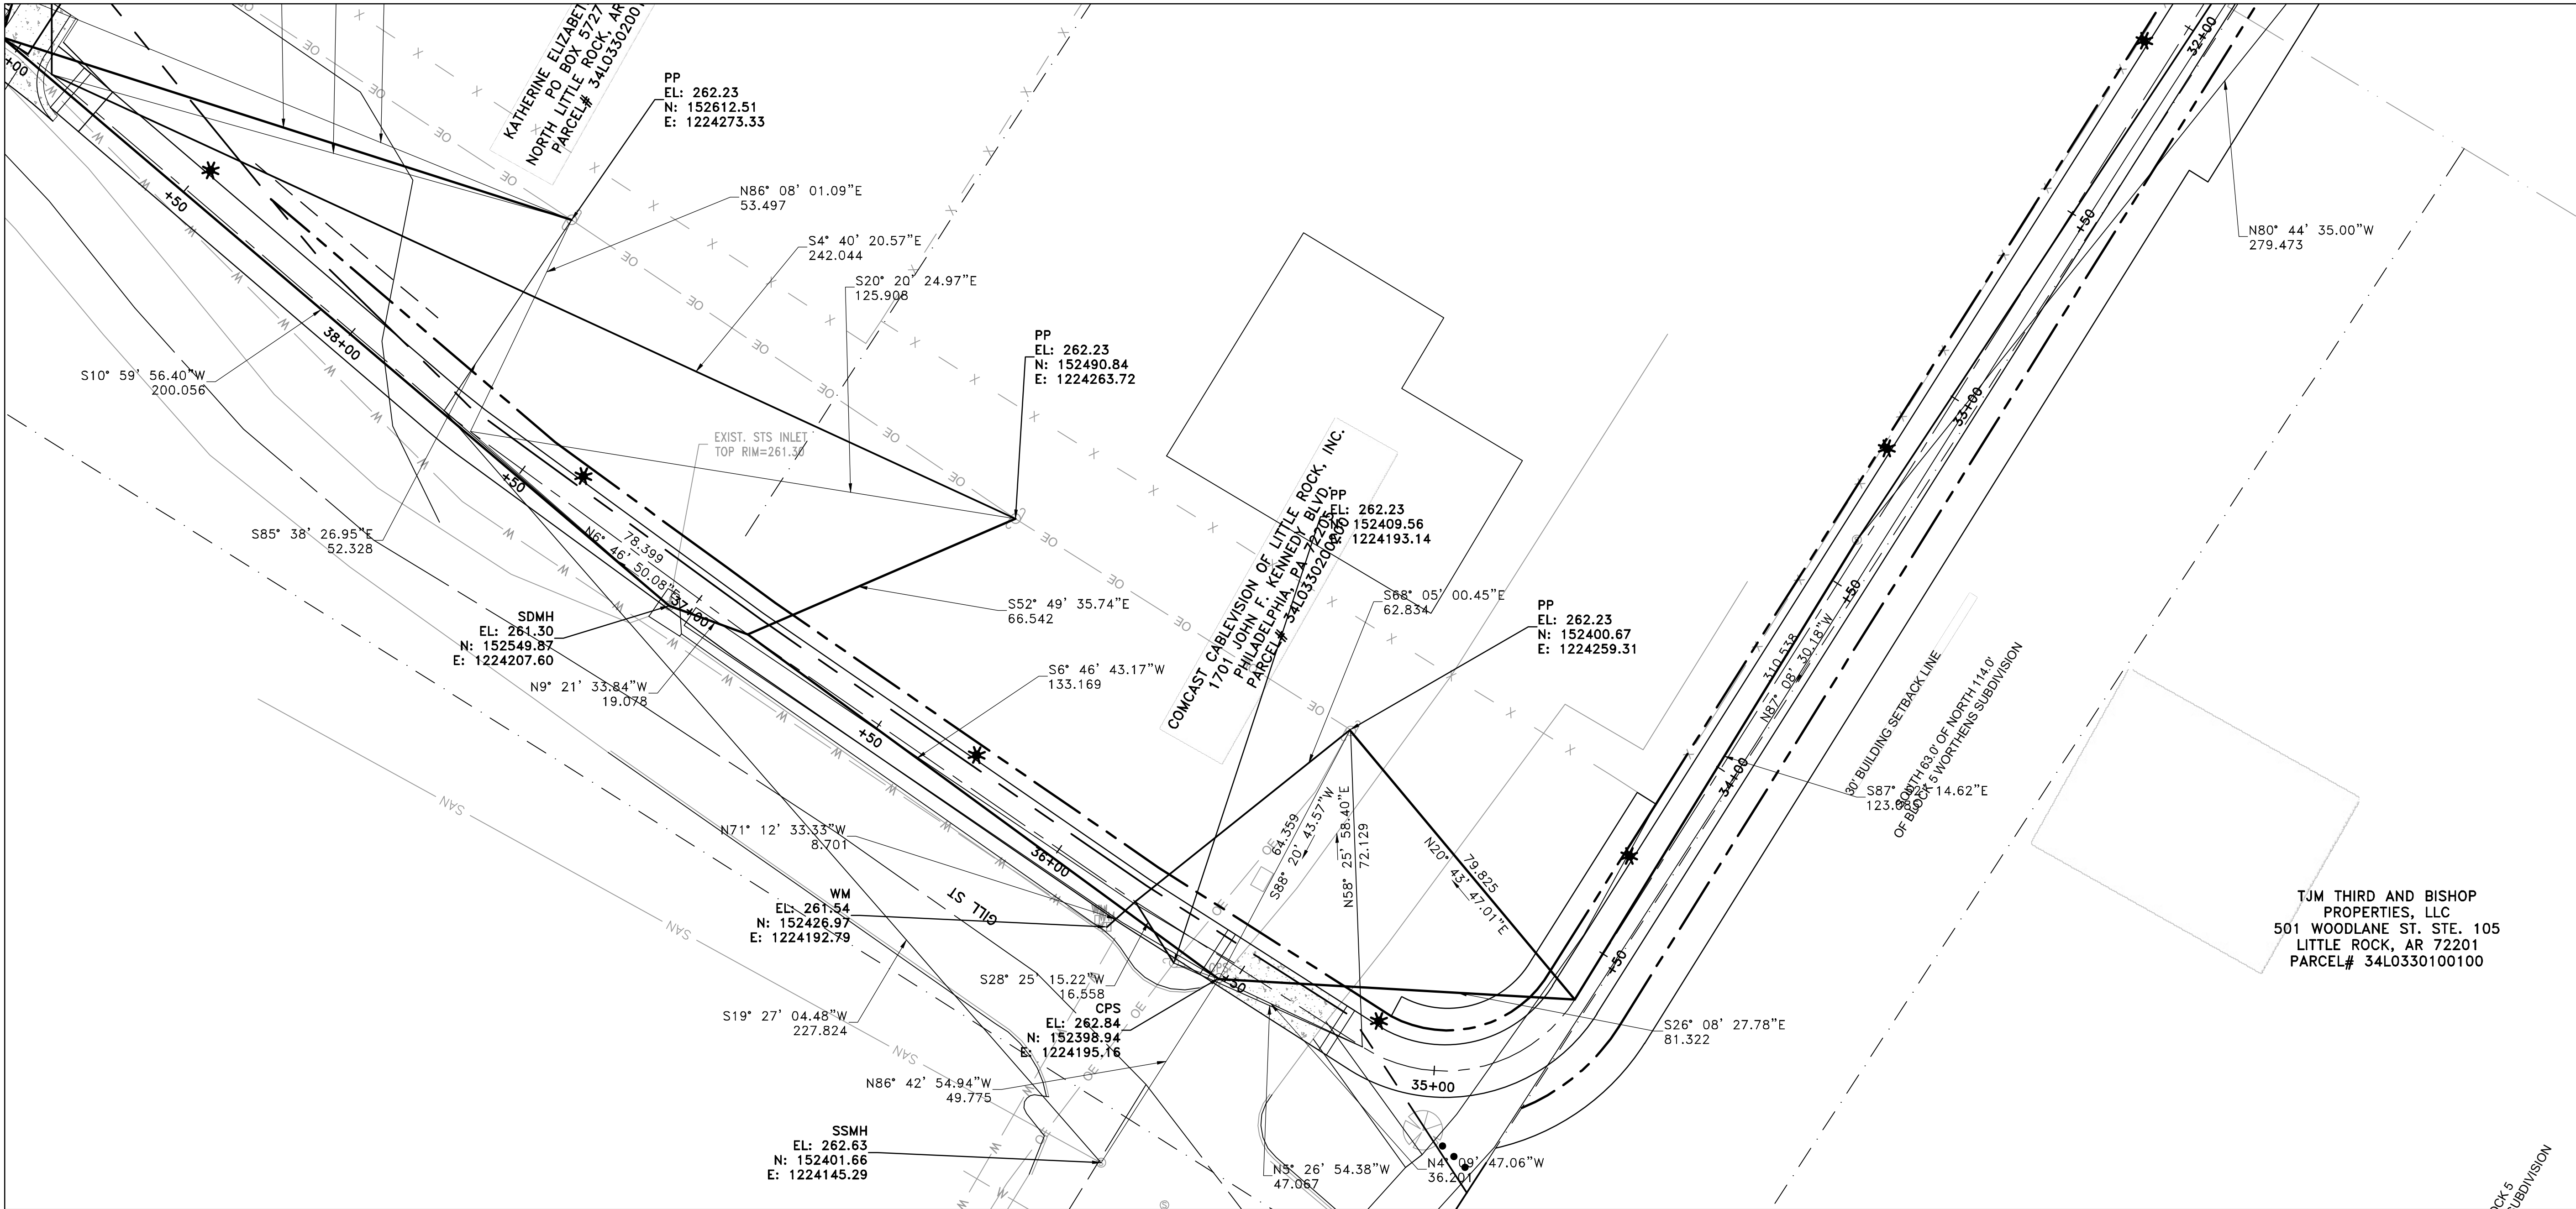

100% SUBMITTAL

REVISIONS	DATE

CITY OF LITTLE ROCK, ARKANSAS

ROSE CREEK TRAIL

CENTERLINE FIELD TIES SHEET 6

DEPARTMENT OF PUBLIC WORKS

CIVIL ENGINEERING

701 W. MARKHAM

LITTLE ROCK, ARKANSAS 72201



DRAWN BY
AS

DESIGNED
LC




CHECKED
JM

DATE
05-01-2026

SCALE
H: 1"=20'
V: 1"=5'

PROJECT NO.
23805201

SHEET NO.
C33

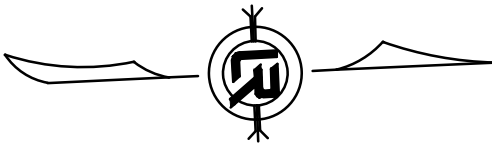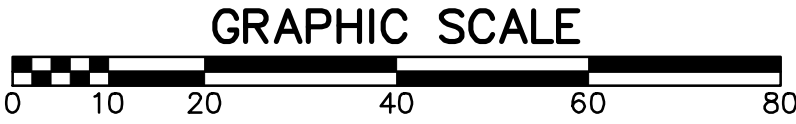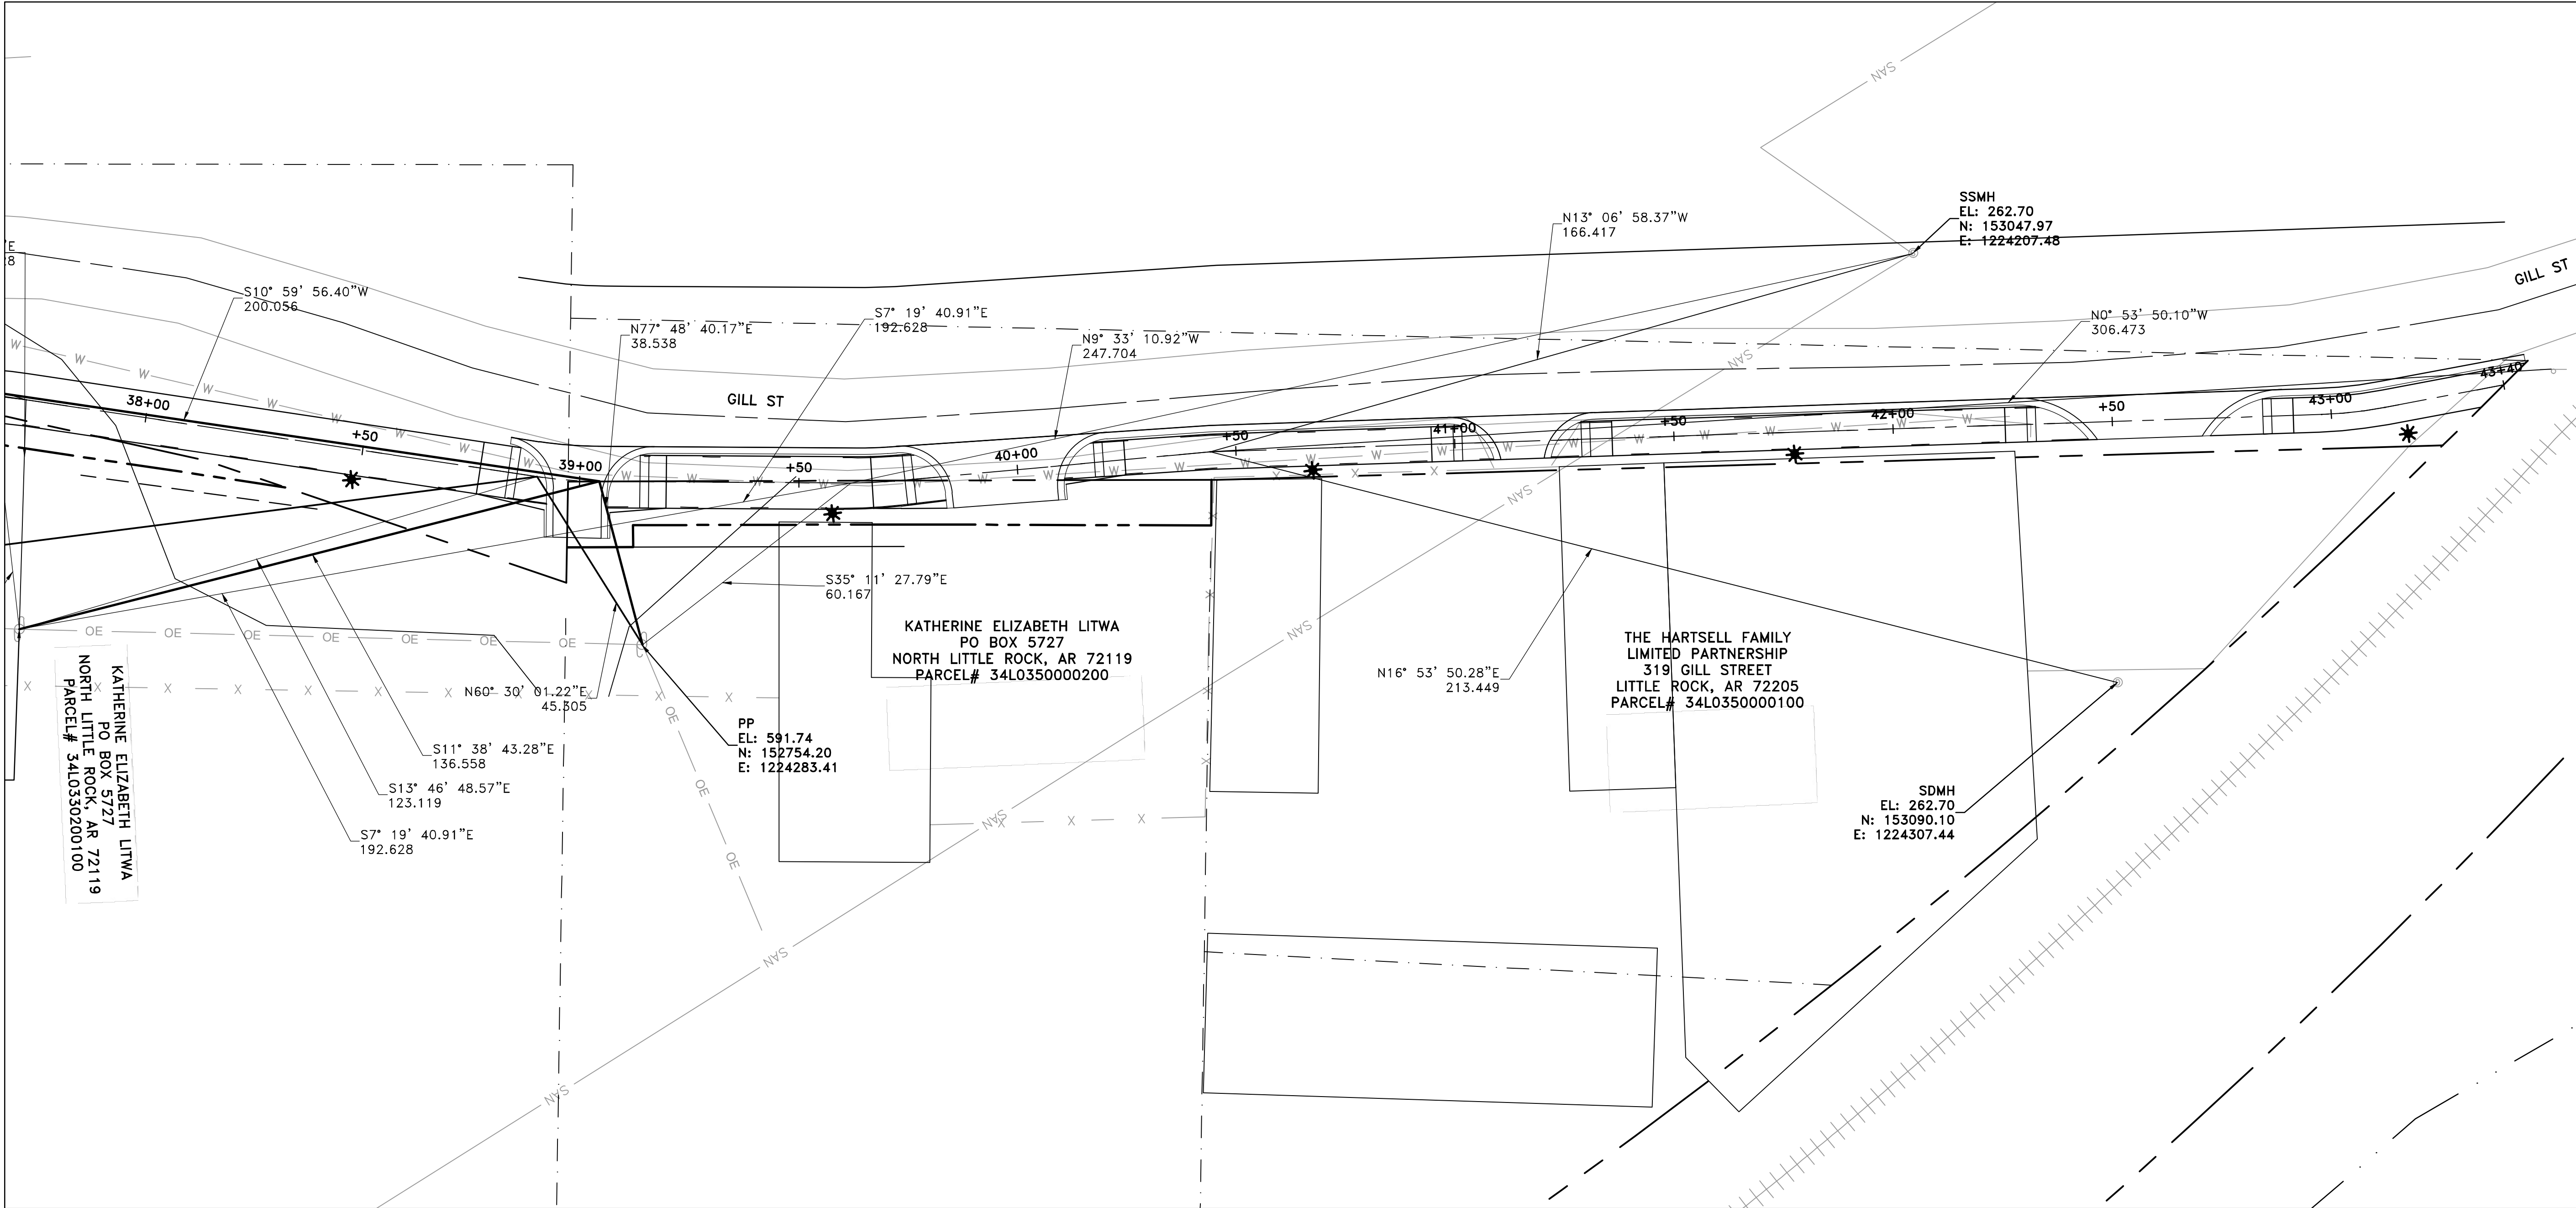



REVISIONS	DATE

CITY OF LITTLE ROCK, ARKANSAS
ROSE CREEK TRAIL
EROSION CONTROL PH I SHEET 1

DEPARTMENT OF PUBLIC WORKS
CIVIL ENGINEERING
701 W. MARKHAM
LITTLE ROCK, ARKANSAS 72201



DRAWN BY
AS
DESIGNED
LC
CHECKED
JM
DATE
05-01-2026
SCALE
H: 1"=20'
V: 1"=5'
PROJECT NO.
23805201
SHEET NO.
C34

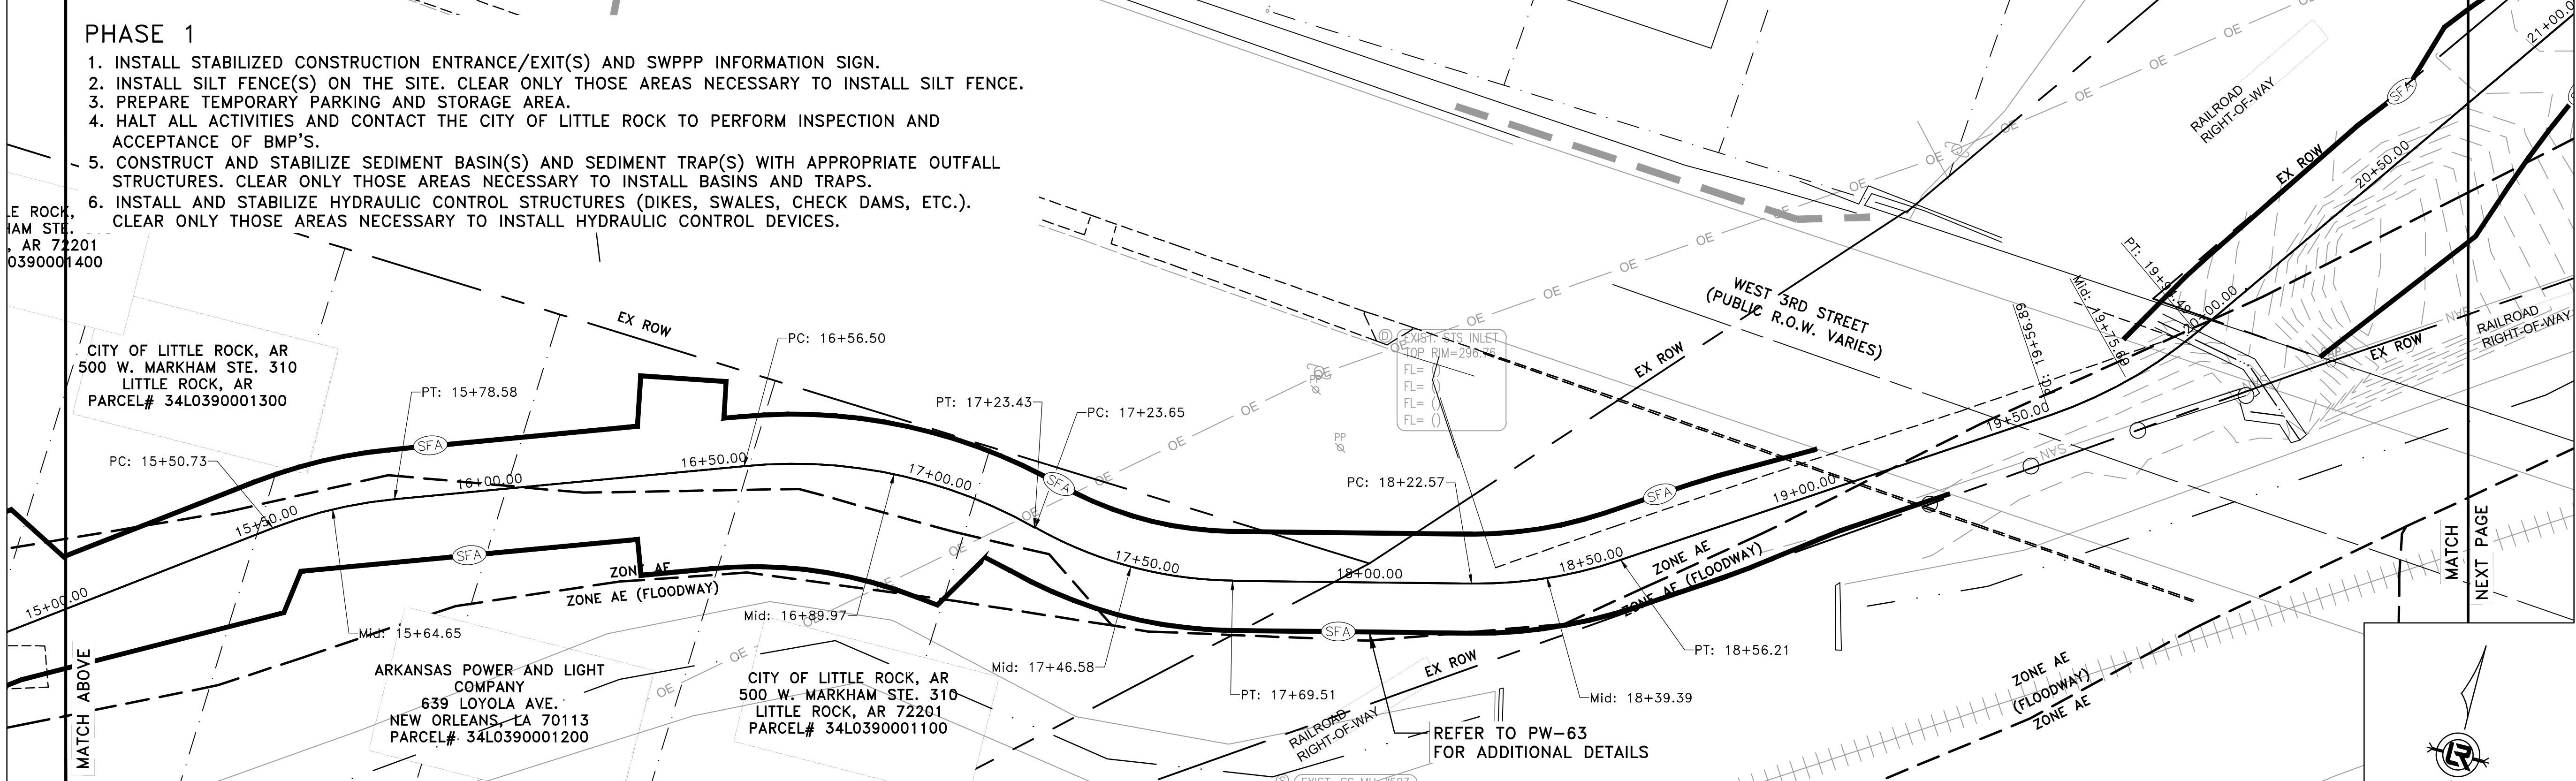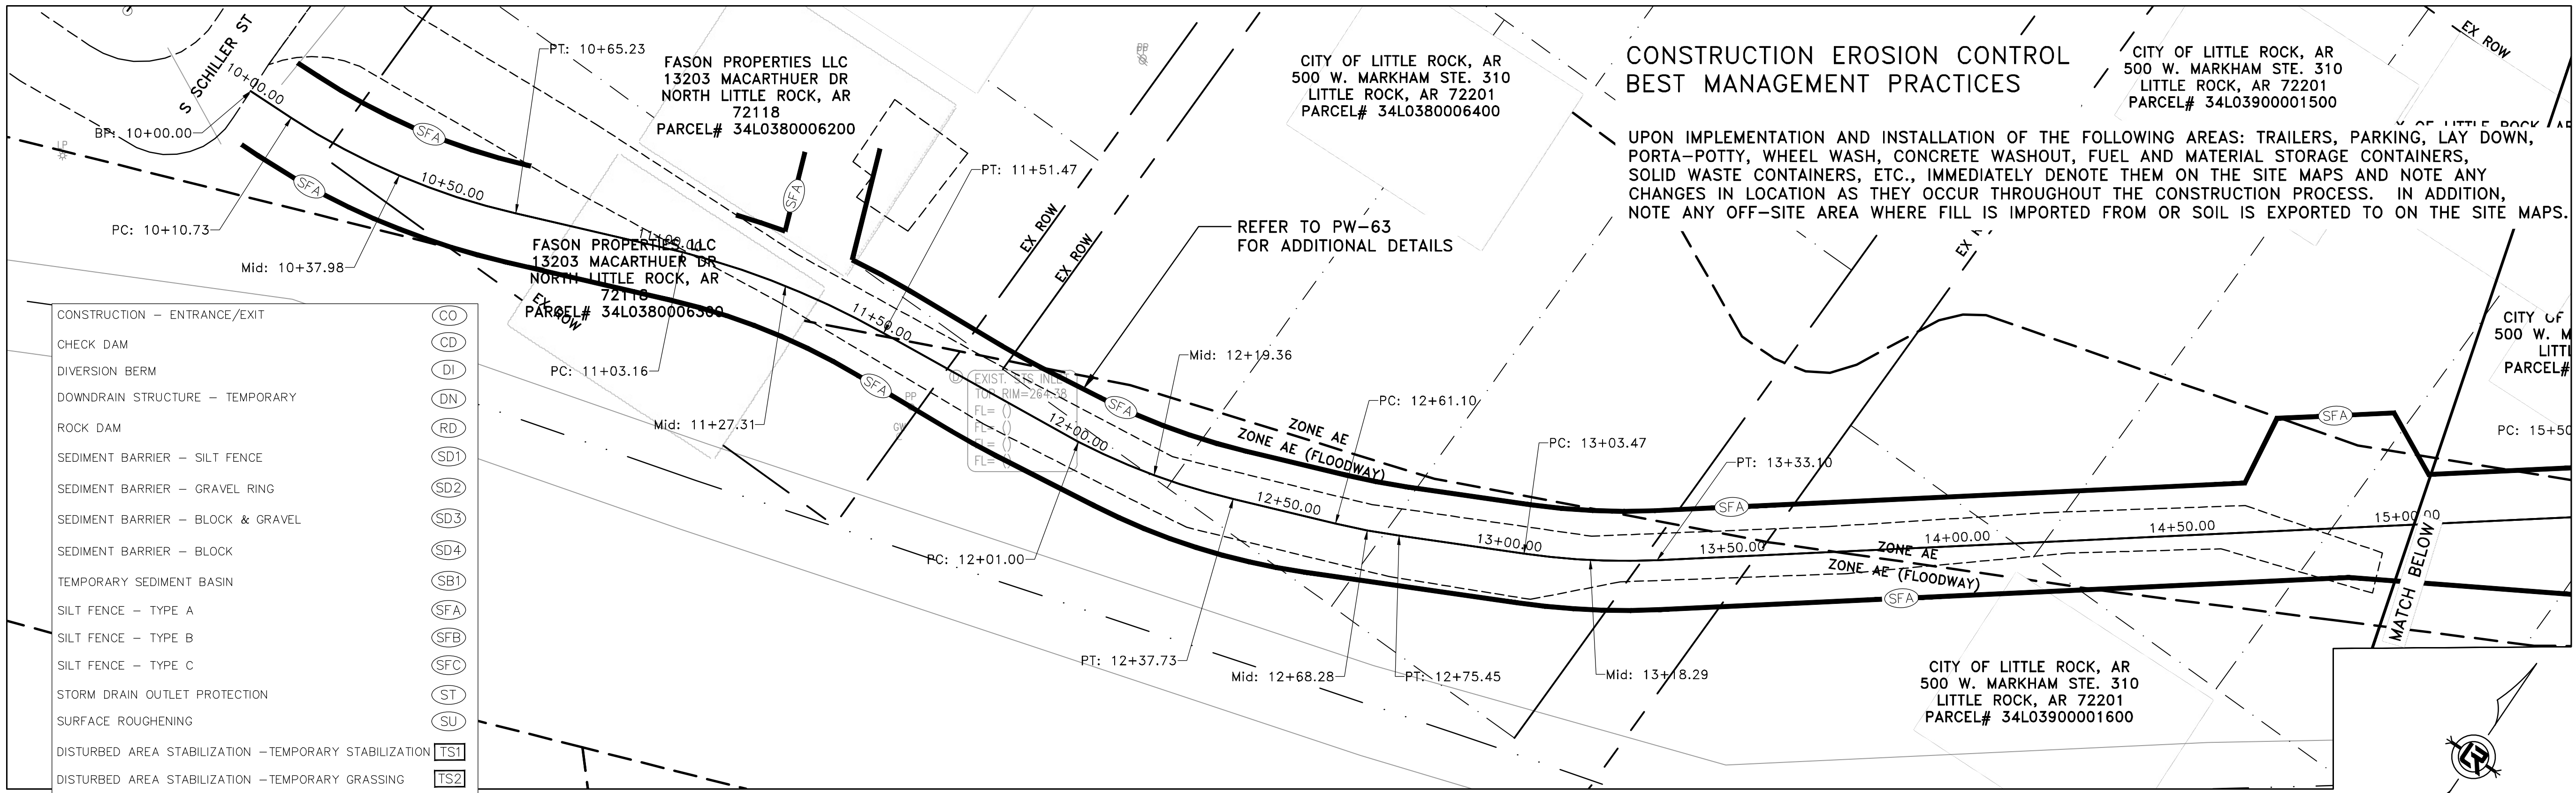

CONSTRUCTION - ENTRANCE/EXIT	(CO)
CHECK DAM	(CD)
DIVERSION BERM	(DI)
DOWNDRAIN STRUCTURE - TEMPORARY	(DN)
ROCK DAM	(RD)
SEDIMENT BARRIER - SILT FENCE	(SD1)
SEDIMENT BARRIER - GRAVEL RING	(SD2)
SEDIMENT BARRIER - BLOCK & GRAVEL	(SD3)
SEDIMENT BARRIER - BLOCK	(SD4)
TEMPORARY SEDIMENT BASIN	(SB1)
SILT FENCE - TYPE A	(SFA)
SILT FENCE - TYPE B	(SFB)
SILT FENCE - TYPE C	(SFC)
STORM DRAIN OUTLET PROTECTION	(ST)
SURFACE ROUGHENING	(SU)
DISTURBED AREA STABILIZATION - TEMPORARY STABILIZATION	(TS1)
DISTURBED AREA STABILIZATION - TEMPORARY GRASSING	(TS2)
DISTURBED AREA STABILIZATION - PERMANENT GRASSING	(TS3)
MATTING/BLANKETS	(Mb)

- PHASE 1
1. INSTALL STABILIZED CONSTRUCTION ENTRANCE/EXIT(S) AND SWPPP INFORMATION SIGN.
 2. INSTALL SILT FENCE(S) ON THE SITE. CLEAR ONLY THOSE AREAS NECESSARY TO INSTALL SILT FENCE.
 3. PREPARE TEMPORARY PARKING AND STORAGE AREA.
 4. HALT ALL ACTIVITIES AND CONTACT THE CITY OF LITTLE ROCK TO PERFORM INSPECTION AND ACCEPTANCE OF BMP'S.
 5. CONSTRUCT AND STABILIZE SEDIMENT BASIN(S) AND SEDIMENT TRAP(S) WITH APPROPRIATE OUTFALL STRUCTURES. CLEAR ONLY THOSE AREAS NECESSARY TO INSTALL BASINS AND TRAPS.
 6. INSTALL AND STABILIZE HYDRAULIC CONTROL STRUCTURES (DIKES, SWALES, CHECK DAMS, ETC.). CLEAR ONLY THOSE AREAS NECESSARY TO INSTALL HYDRAULIC CONTROL DEVICES.

REVISIONS DATE

CITY OF LITTLE ROCK, ARKANSAS
ROSE CREEK TRAIL
EROSION CONTROL PH I SHEET 2

DEPARTMENT OF PUBLIC WORKS
CIVIL ENGINEERING
701 W. MARKHAM
LITTLE ROCK, ARKANSAS 72201



DRAWN BY
AS
DESIGNED
LC
CHECKED
JM
DATE
05-01-2026
SCALE
H: 1"=20'
V: 1"=5'
PROJECT NO.
23805201


SHEET NO.
C35

100% SUBMITTAL

CONSTRUCTION EROSION CONTROL BEST MANAGEMENT PRACTICES


UPON IMPLEMENTATION AND INSTALLATION OF THE FOLLOWING AREAS: TRAILERS, PARKING, LAY DOWN, PORTA-POTTY, WHEEL WASH, CONCRETE WASHOUT, FUEL AND MATERIAL STORAGE CONTAINERS, SOLID WASTE CONTAINERS, ETC., IMMEDIATELY DENOTE THEM ON THE SITE MAPS AND NOTE ANY CHANGES IN LOCATION AS THEY OCCUR THROUGHOUT THE CONSTRUCTION PROCESS. IN ADDITION, NOTE ANY OFF-SITE AREA WHERE FILL IS IMPORTED FROM OR SOIL IS EXPORTED TO ON THE SITE MAPS.



CONSTRUCTION - ENTRANCE/EXIT	(CO)
CHECK DAM	(CD)
DIVERSION BERM	(DI)
DOWNDRAIN STRUCTURE - TEMPORARY	(DN)
ROCK DAM	(RD)
SEDIMENT BARRIER - SILT FENCE	(SD1)
SEDIMENT BARRIER - GRAVEL RING	(SD2)
SEDIMENT BARRIER - BLOCK & GRAVEL	(SD3)
SEDIMENT BARRIER - BLOCK	(SD4)
TEMPORARY SEDIMENT BASIN	(SB1)
SILT FENCE - TYPE A	(SFA)
SILT FENCE - TYPE B	(SFB)
SILT FENCE - TYPE C	(SFC)
STORM DRAIN OUTLET PROTECTION	(ST)
SURFACE ROUGHENING	(SU)
DISTURBED AREA STABILIZATION -TEMPORARY STABILIZATION	(TS1)
DISTURBED AREA STABILIZATION -TEMPORARY GRASSING	(TS2)
DISTURBED AREA STABILIZATION -PERMANENT GRASSING	(TS3)
MATTING/BLANKETS	(Mb)

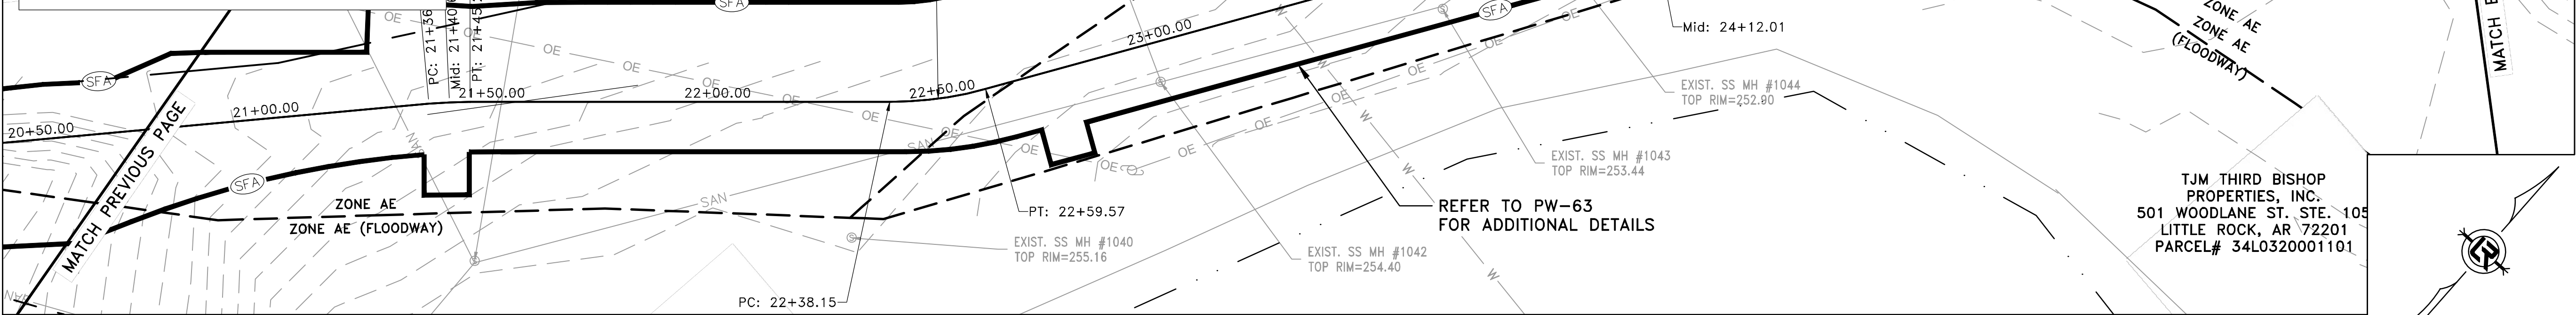

PHASE 1

1. INSTALL STABILIZED CONSTRUCTION ENTRANCE/EXIT(S) AND SWPPP INFORMATION SIGN.
2. INSTALL SILT FENCE(S) ON THE SITE. CLEAR ONLY THOSE AREAS NECESSARY TO INSTALL SILT FENCE.
3. PREPARE TEMPORARY PARKING AND STORAGE AREA.
4. HALT ALL ACTIVITIES AND CONTACT THE CITY OF LITTLE ROCK TO PERFORM INSPECTION AND ACCEPTANCE OF BMP'S.
5. CONSTRUCT AND STABILIZE SEDIMENT BASIN(S) AND SEDIMENT TRAP(S) WITH APPROPRIATE OUTFALL STRUCTURES. CLEAR ONLY THOSE AREAS NECESSARY TO INSTALL BASINS AND TRAPS.
6. INSTALL AND STABILIZE HYDRAULIC CONTROL STRUCTURES (DIKES, SWALES, CHECK DAMS, ETC.). CLEAR ONLY THOSE AREAS NECESSARY TO INSTALL HYDRAULIC CONTROL DEVICES.

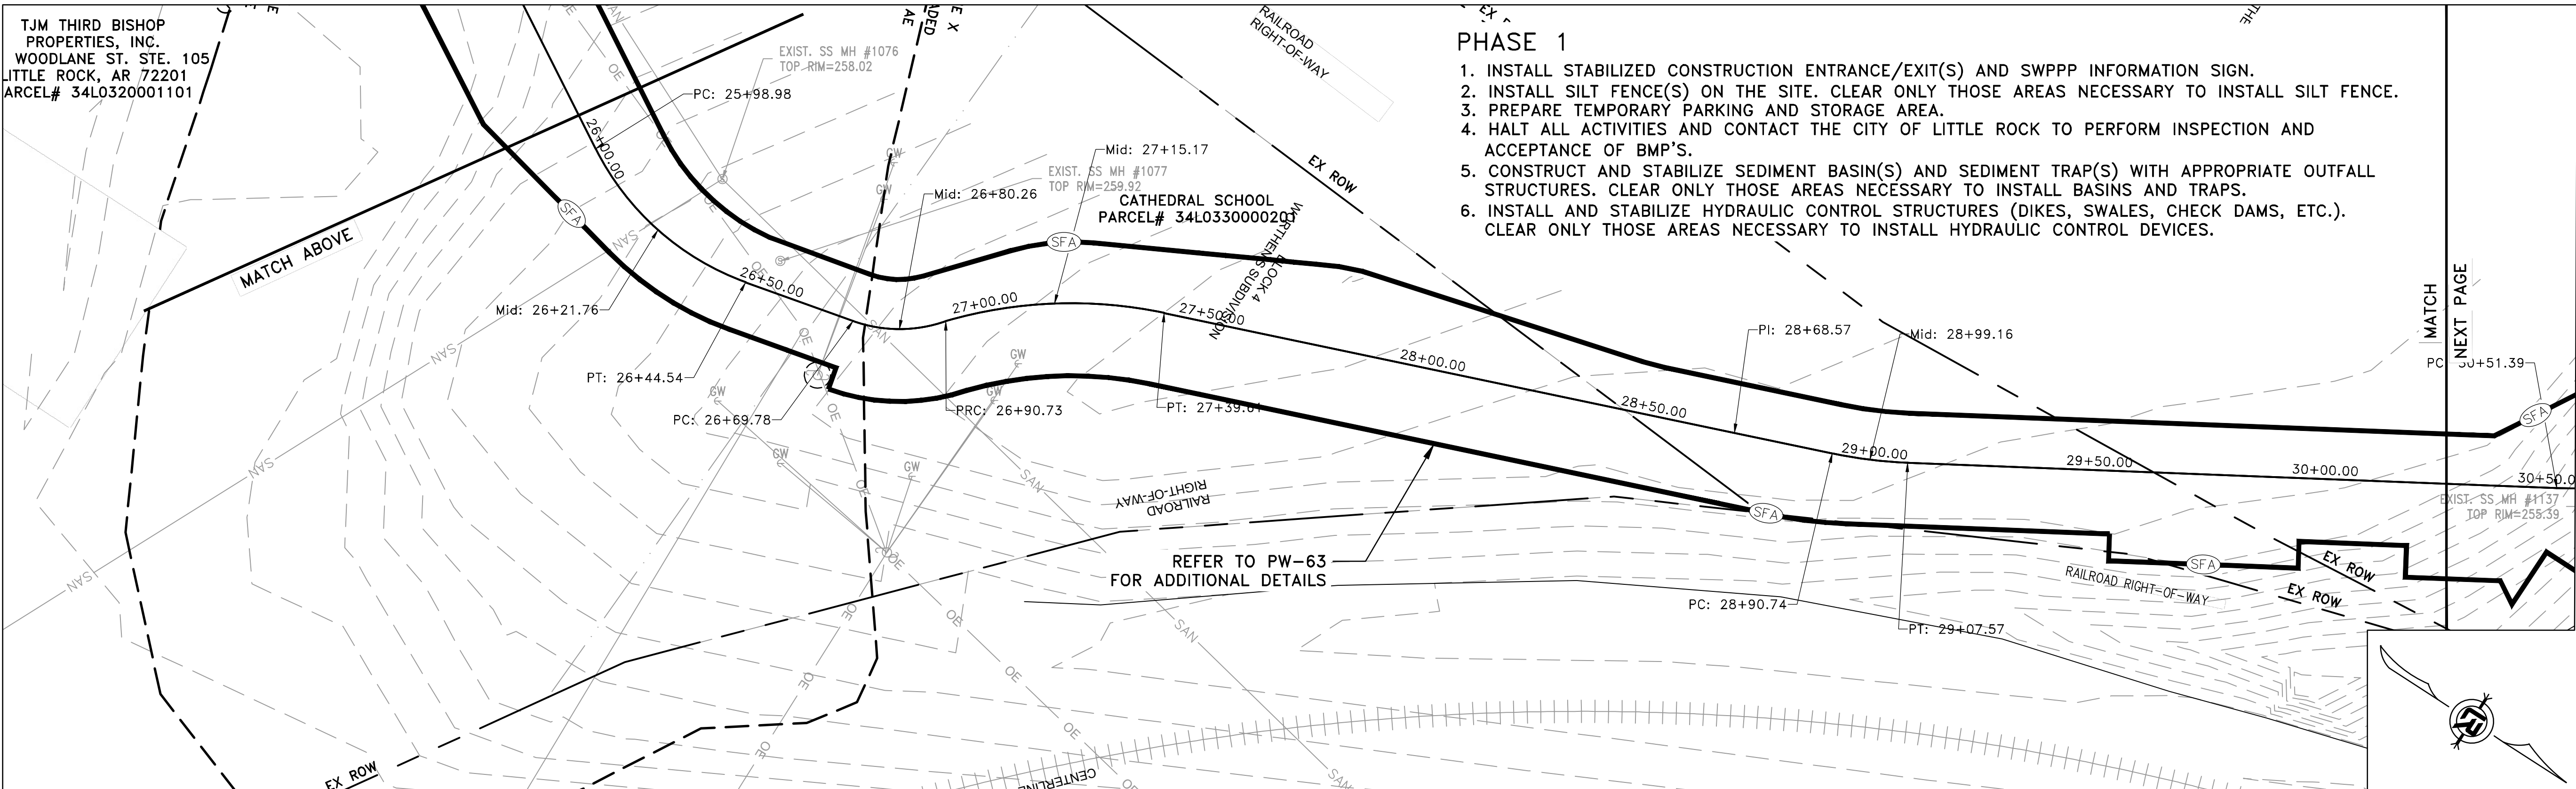

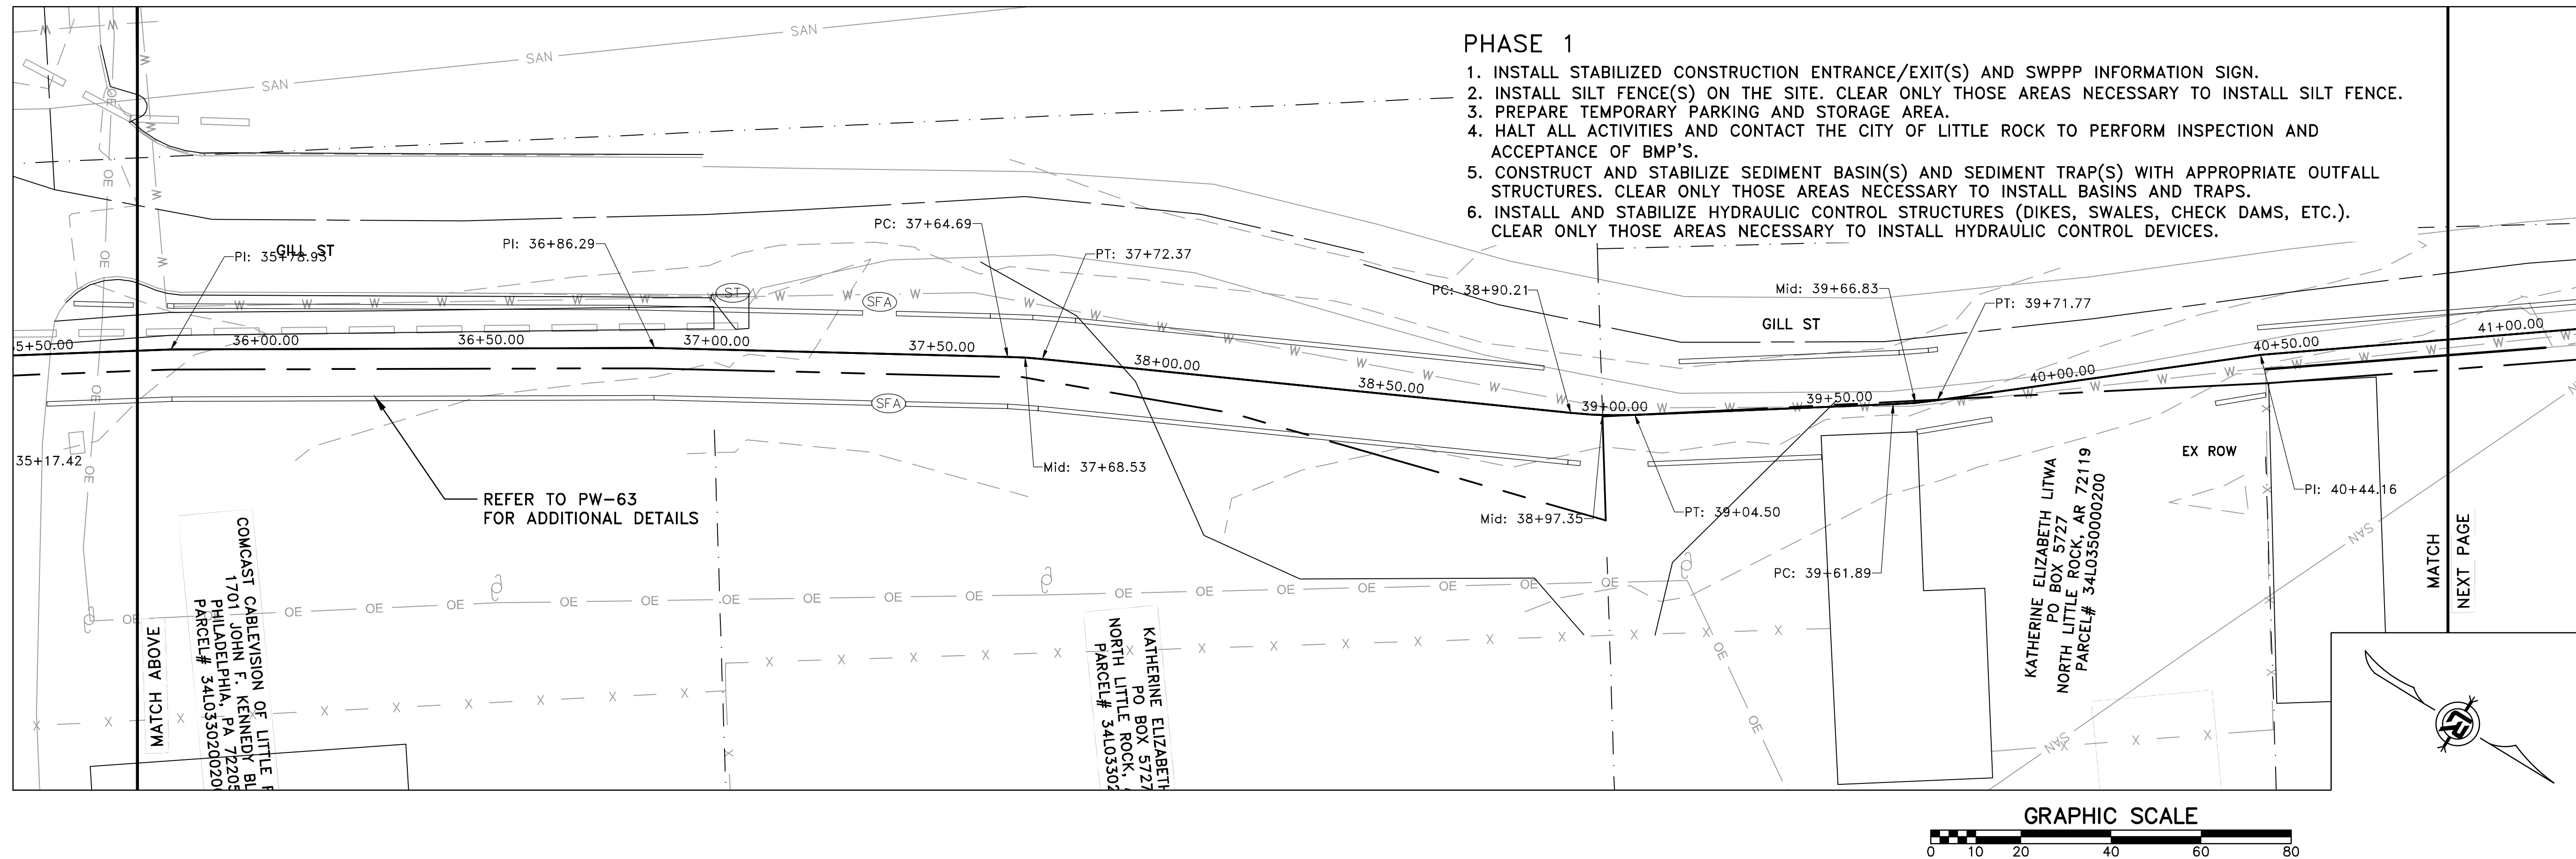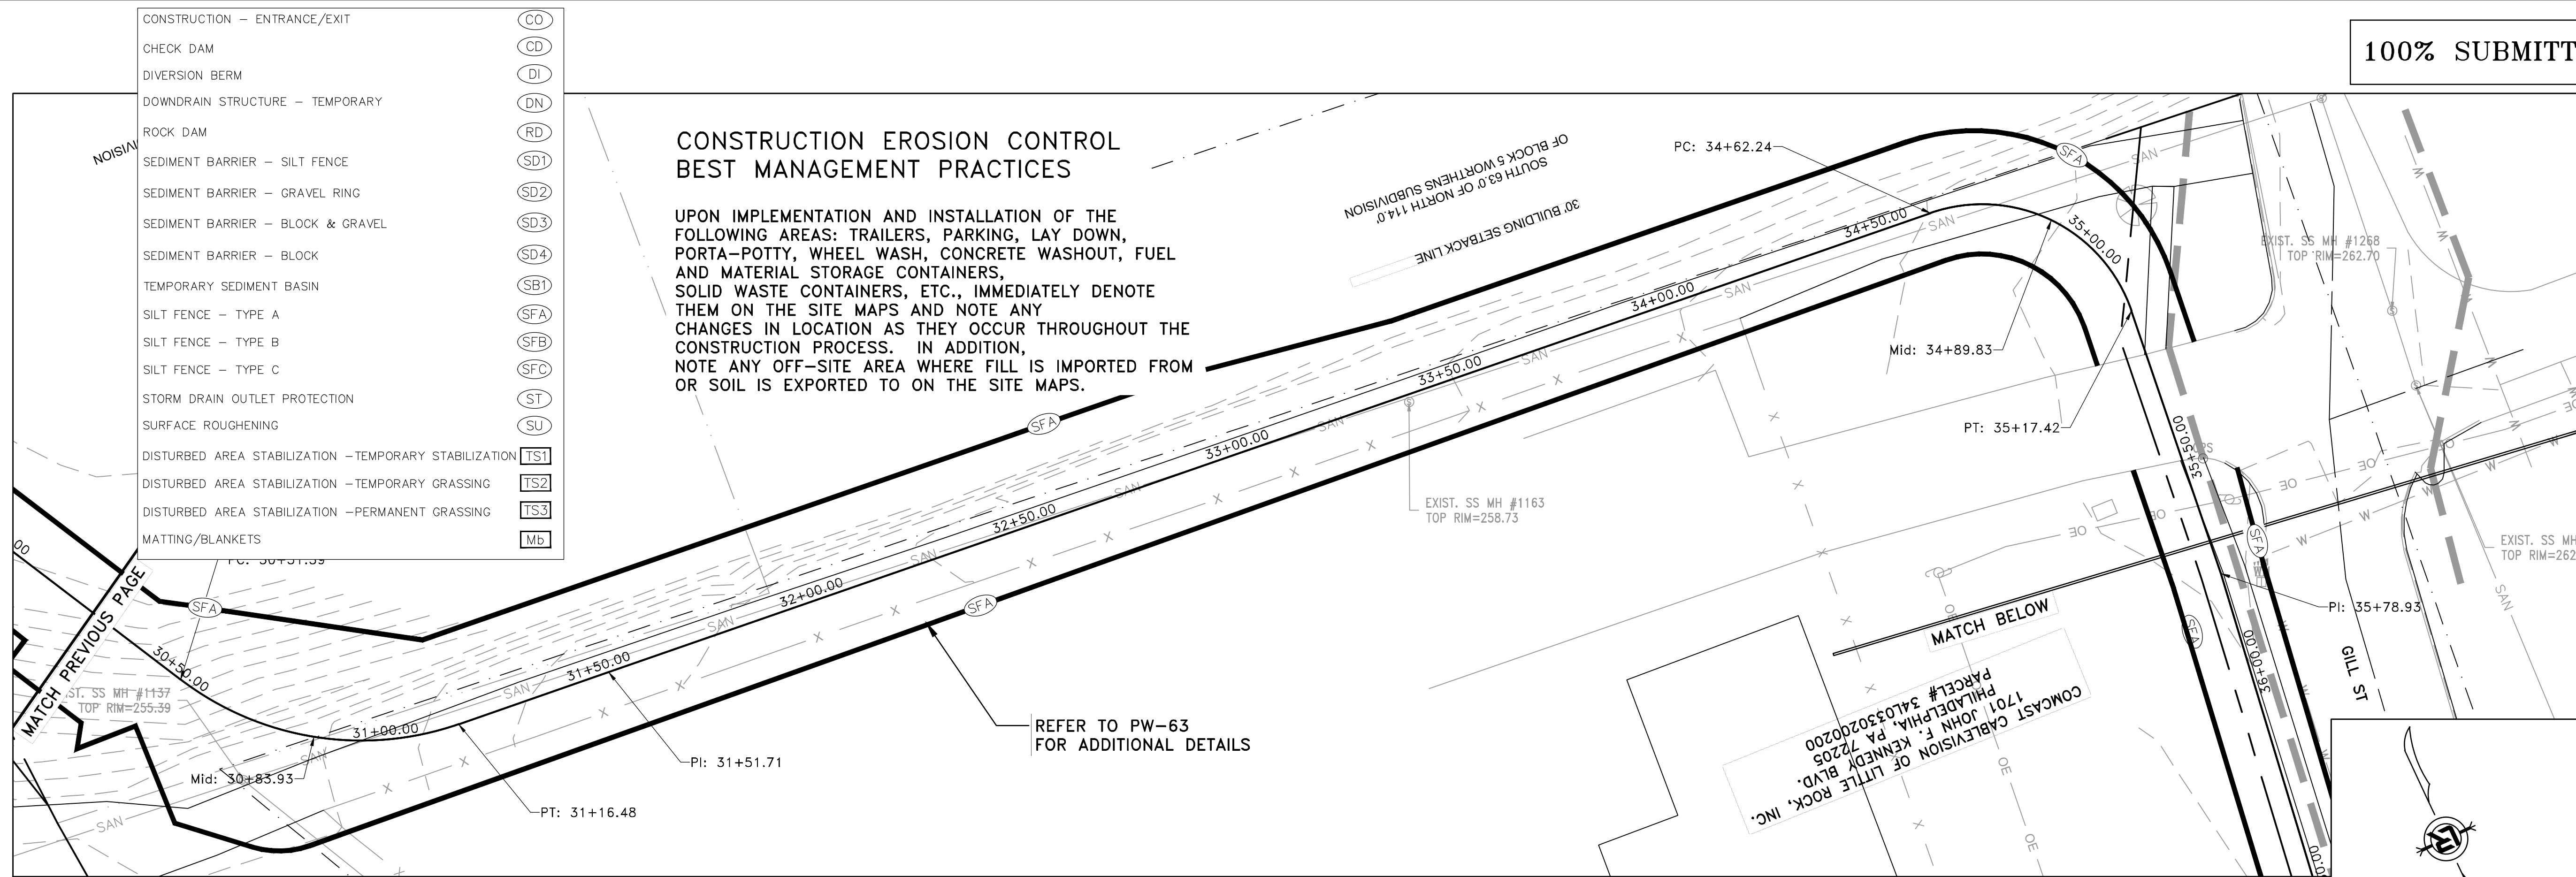

REVISIONS	DATE

CITY OF LITTLE ROCK, ARKANSAS ROSE CREEK TRAIL EROSION CONTROL PH I SHEET 3

DEPARTMENT OF PUBLIC WORKS CIVIL ENGINEERING 701 W. MARKHAM LITTLE ROCK, ARKANSAS 72201
--



DRAWN BY AS
DESIGNED LC
CHECKED JM
DATE 05-01-2026
SCALE H: 1"=20' V: 1"=5'
PROJECT NO. 23805201
SHEET NO. C36

REVISIONS	DATE

CITY OF LITTLE ROCK, ARKANSAS

ROSE CREEK TRAIL

EROSION CONTROL PH I SHEET 4

DEPARTMENT OF PUBLIC WORKS

CIVIL ENGINEERING

701 W. MARKHAM

LITTLE ROCK, ARKANSAS 72201

STATE OF ARKANSAS

REGISTERED PROFESSIONAL ENGINEER

No. 13217

BRADLEY A. PETERSON

9/3/26

DRAWN BY

AS

DESIGNED

LC

CHECKED

JM

DATE

05-01-2026

SCALE

H: 1"=20'


V: 1"=5'

PROJECT NO.

23805201

SHEET NO.

C37

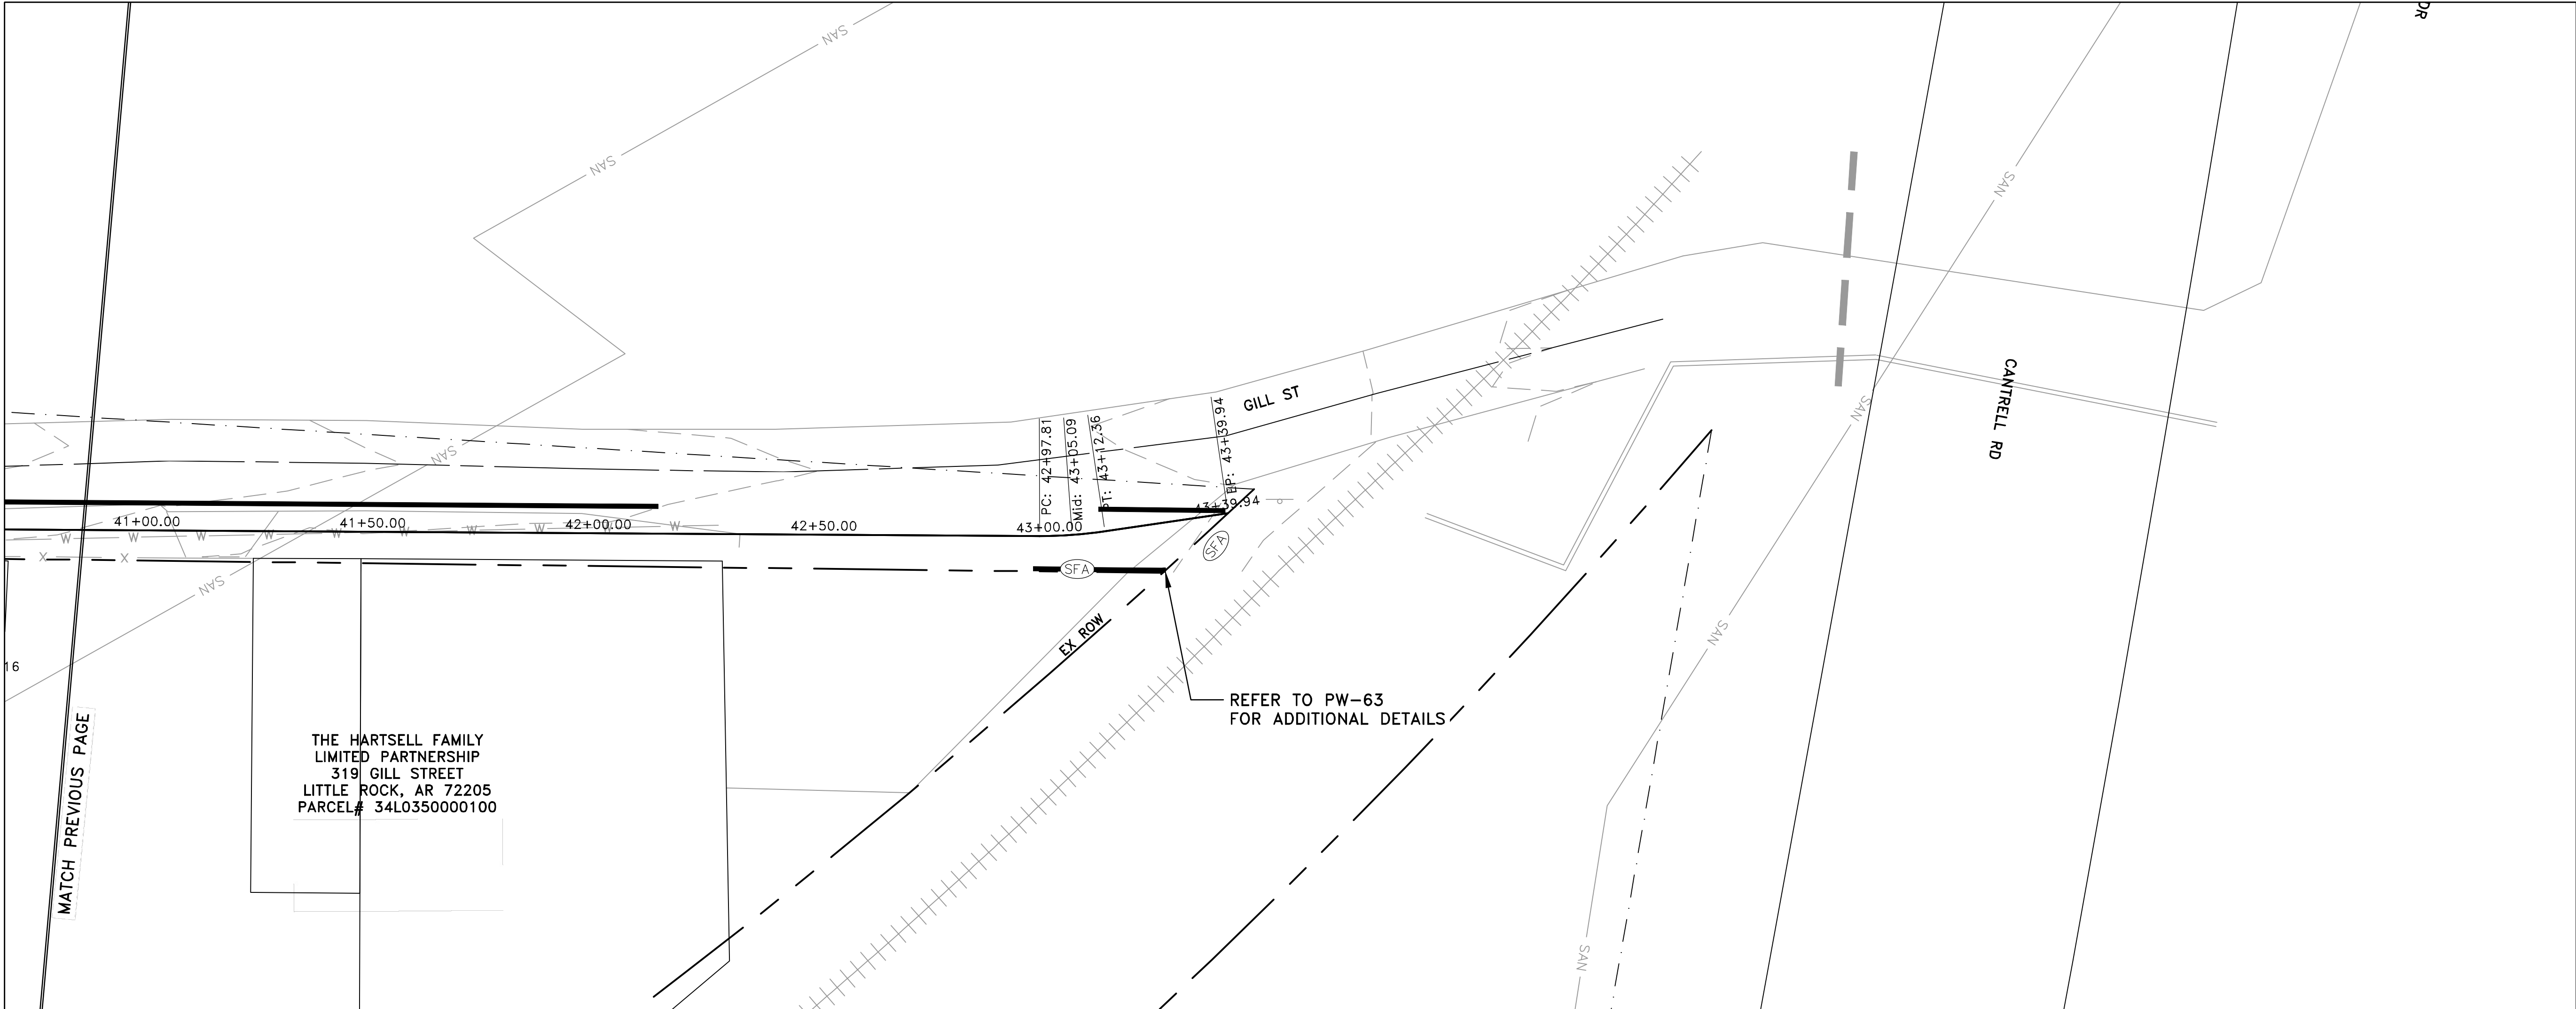


CONSTRUCTION - ENTRANCE/EXIT	(CO)
CHECK DAM	(CD)
DIVERSION BERM	(DI)
DOWNDRAIN STRUCTURE - TEMPORARY	(DN)
ROCK DAM	(RD)
SEDIMENT BARRIER - SILT FENCE	(SD1)
SEDIMENT BARRIER - GRAVEL RING	(SD2)
SEDIMENT BARRIER - BLOCK & GRAVEL	(SD3)
SEDIMENT BARRIER - BLOCK	(SD4)
TEMPORARY SEDIMENT BASIN	(SB1)
SILT FENCE - TYPE A	(SFA)
SILT FENCE - TYPE B	(SFB)
SILT FENCE - TYPE C	(SFC)
STORM DRAIN OUTLET PROTECTION	(ST)
SURFACE ROUGHENING	(SU)
DISTURBED AREA STABILIZATION -TEMPORARY STABILIZATION	(TS1)
DISTURBED AREA STABILIZATION -TEMPORARY GRASSING	(TS2)
DISTURBED AREA STABILIZATION -PERMANENT GRASSING	(TS3)
MATTING/BLANKETS	(Mb)

CONSTRUCTION EROSION CONTROL
BEST MANAGEMENT PRACTICES

UPON IMPLEMENTATION AND INSTALLATION OF THE FOLLOWING AREAS: TRAILERS, PARKING, LAY DOWN, PORTA-POTTY, WHEEL WASH, CONCRETE WASHOUT, FUEL AND MATERIAL STORAGE CONTAINERS, SOLID WASTE CONTAINERS, ETC., IMMEDIATELY DENOTE THEM ON THE SITE MAPS AND NOTE ANY CHANGES IN LOCATION AS THEY OCCUR THROUGHOUT THE CONSTRUCTION PROCESS. IN ADDITION, NOTE ANY OFF-SITE AREA WHERE FILL IS IMPORTED FROM OR SOIL IS EXPORTED TO ON THE SITE MAPS.

PHASE 1

1. INSTALL STABILIZED CONSTRUCTION ENTRANCE/EXIT(S) AND SWPPP INFORMATION SIGN.
2. INSTALL SILT FENCE(S) ON THE SITE. CLEAR ONLY THOSE AREAS NECESSARY TO INSTALL SILT FENCE.
3. PREPARE TEMPORARY PARKING AND STORAGE AREA.
4. HALT ALL ACTIVITIES AND CONTACT THE CITY OF LITTLE ROCK TO PERFORM INSPECTION AND ACCEPTANCE OF BMP'S.
5. CONSTRUCT AND STABILIZE SEDIMENT BASIN(S) AND SEDIMENT TRAP(S) WITH APPROPRIATE OUTFALL STRUCTURES. CLEAR ONLY THOSE AREAS NECESSARY TO INSTALL BASINS AND TRAPS.
6. INSTALL AND STABILIZE HYDRAULIC CONTROL STRUCTURES (DIKES, SWALES, CHECK DAMS, ETC.). CLEAR ONLY THOSE AREAS NECESSARY TO INSTALL HYDRAULIC CONTROL DEVICES.

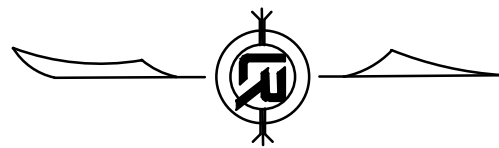

100% SUBMITTAL

REVISIONS	DATE



CITY OF LITTLE ROCK, ARKANSAS ROSE CREEK TRAIL	EROSION CONTROL PH II SHEET 1
---	---



DEPARTMENT OF PUBLIC WORKS
CIVIL ENGINEERING
701 W. MARKHAM
LITTLE ROCK, ARKANSAS 72201



DRAWN BY AS
DESIGNED LC
CHECKED JM
DATE 05-01-2026
SCALE H: 1"=20' V: 1"=5'
PROJECT NO. 23805201
SHEET NO. C38

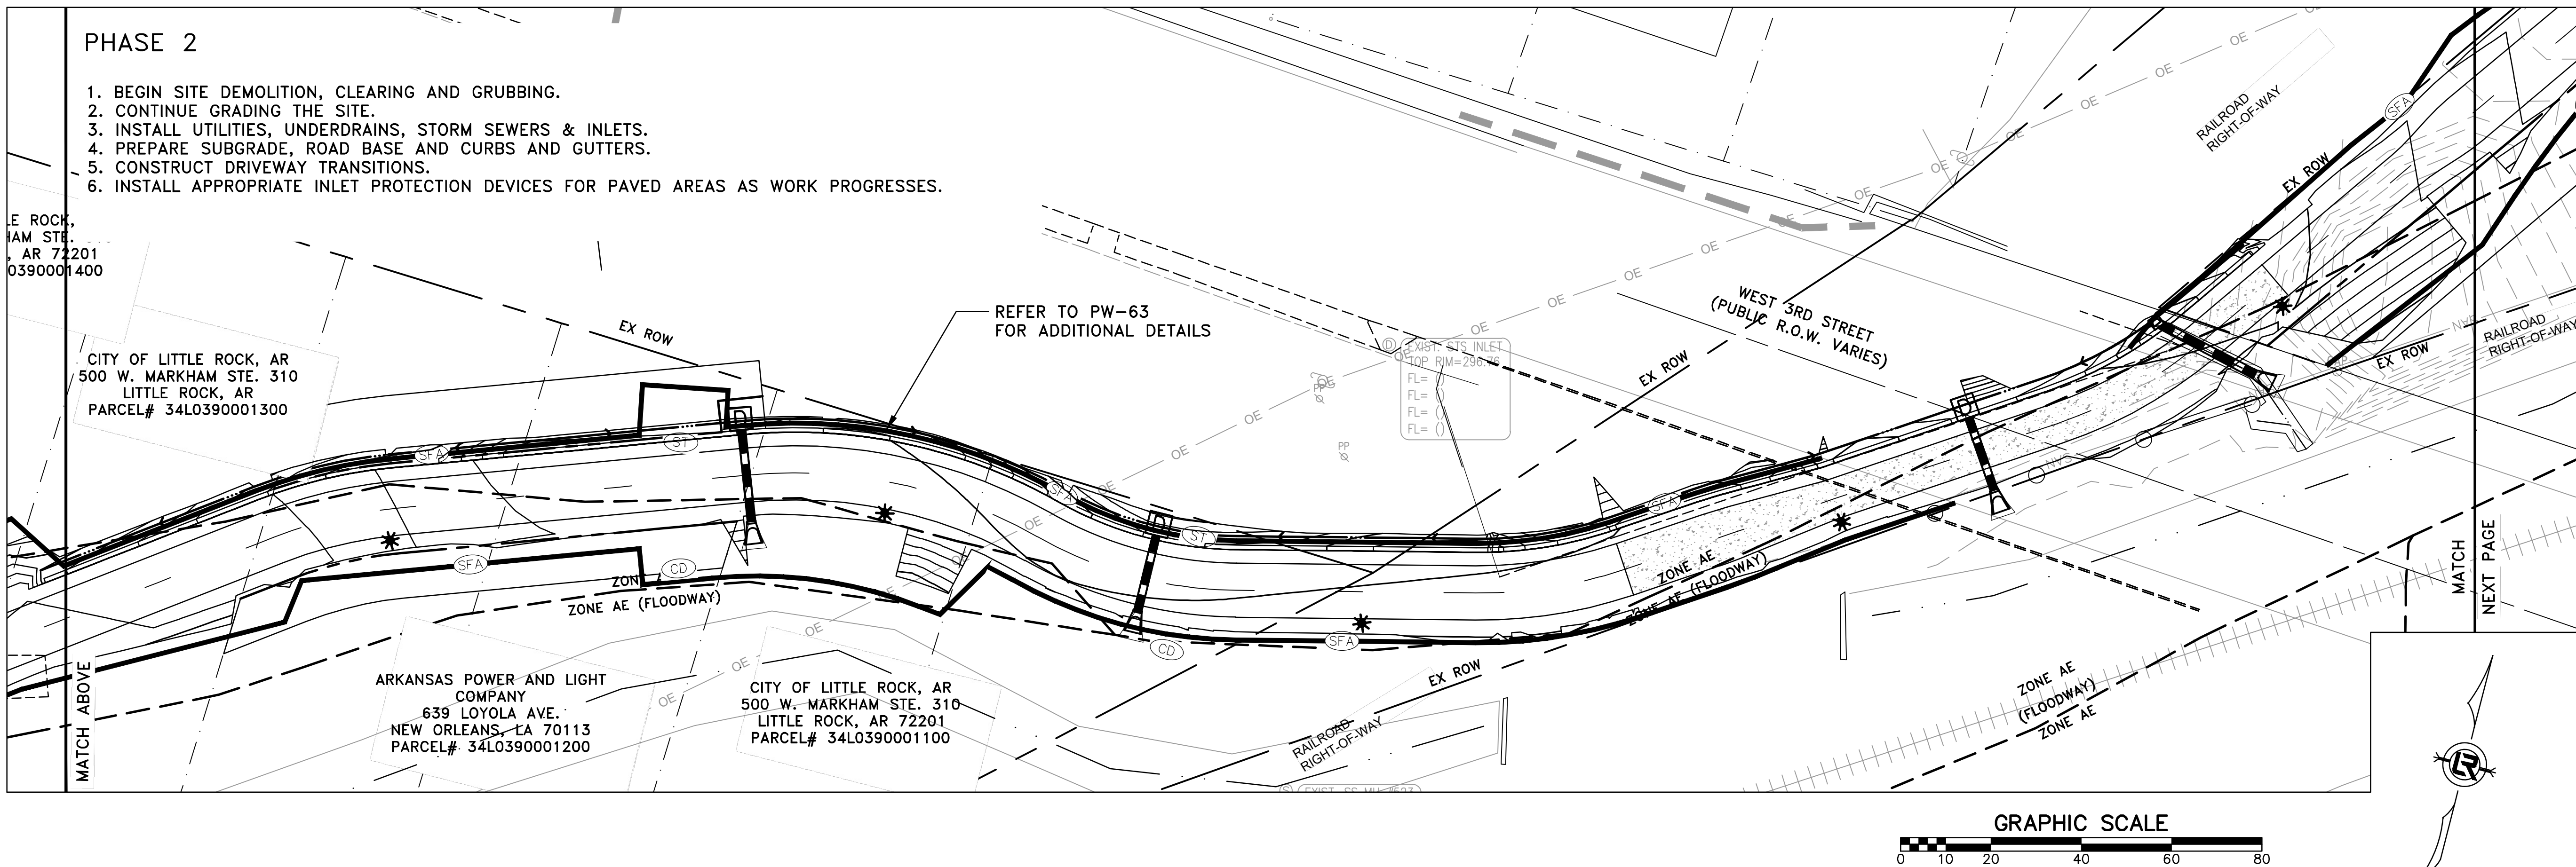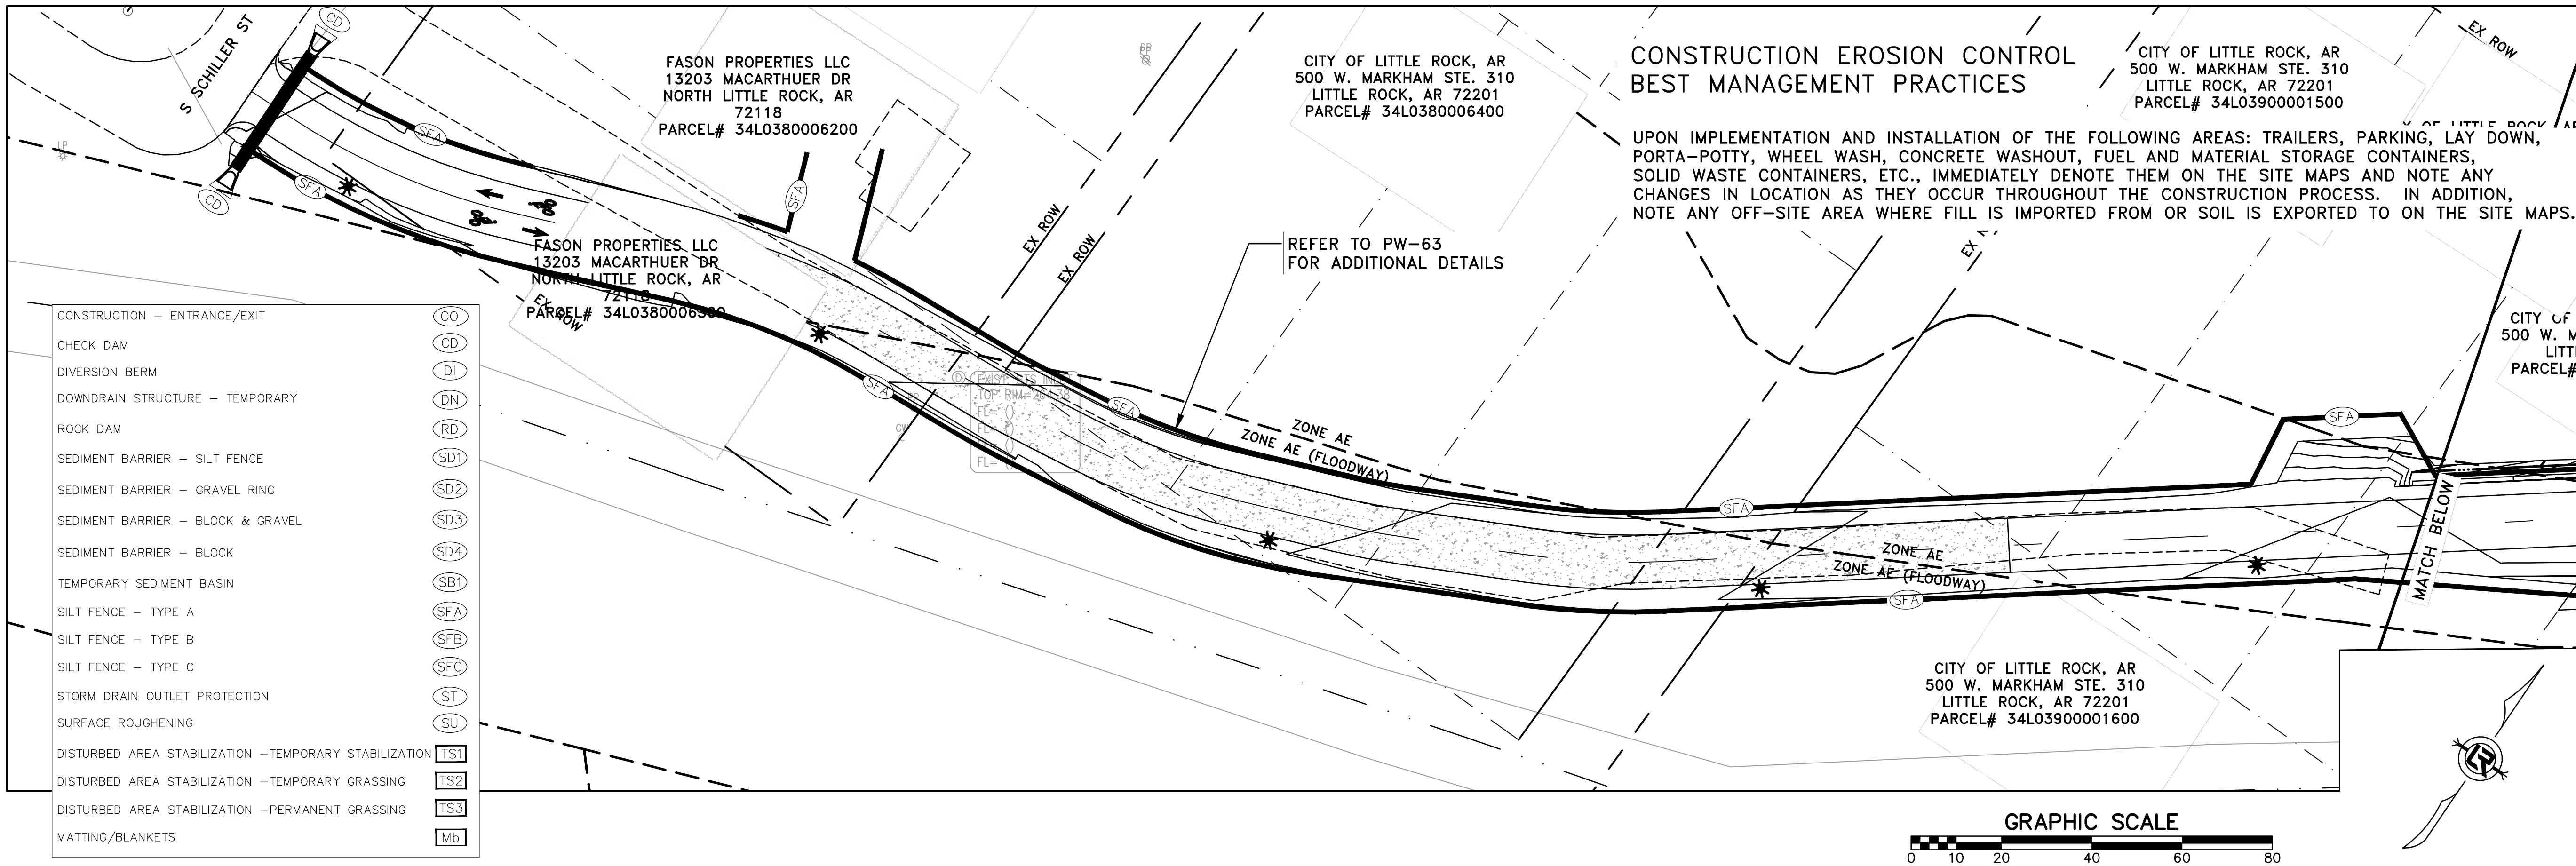


100% SUBMITTAL

REVISIONS DATE

CITY OF LITTLE ROCK, ARKANSAS
ROSE CREEK TRAIL
EROSION CONTROL PH II SHEET 2

DEPARTMENT OF PUBLIC WORKS
CIVIL ENGINEERING
701 W. MARKHAM
LITTLE ROCK, ARKANSAS 72201


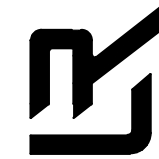


DRAWN BY
AS
DESIGNED
LC
CHECKED
JM
DATE
05-01-2026
SCALE
H: 1"=20'
V: 1"=5'
PROJECT NO.
23805201
SHEET NO.
C39

CONSTRUCTION EROSION CONTROL BEST MANAGEMENT PRACTICES

UPON IMPLEMENTATION AND INSTALLATION OF THE FOLLOWING AREAS: TRAILERS, PARKING, LAY DOWN, PORTA-POTTY, WHEEL WASH, CONCRETE WASHOUT, FUEL AND MATERIAL STORAGE CONTAINERS, SOLID WASTE CONTAINERS, ETC., IMMEDIATELY DENOTE THEM ON THE SITE MAPS AND NOTE ANY CHANGES IN LOCATION AS THEY OCCUR THROUGHOUT THE CONSTRUCTION PROCESS. IN ADDITION, NOTE ANY OFF-SITE AREA WHERE FILL IS IMPORTED FROM OR SOIL IS EXPORTED TO ON THE SITE MAPS.



CONSTRUCTION - ENTRANCE/EXIT	(CO)
CHECK DAM	(CD)
DIVERSION BERM	(DI)
DOWNDRAIN STRUCTURE - TEMPORARY	(DN)
ROCK DAM	(RD)
SEDIMENT BARRIER - SILT FENCE	(SD1)
SEDIMENT BARRIER - GRAVEL RING	(SD2)
SEDIMENT BARRIER - BLOCK & GRAVEL	(SD3)
SEDIMENT BARRIER - BLOCK	(SD4)
TEMPORARY SEDIMENT BASIN	(SB1)
SILT FENCE - TYPE A	(SFA)
SILT FENCE - TYPE B	(SFB)
SILT FENCE - TYPE C	(SFC)
STORM DRAIN OUTLET PROTECTION	(ST)
SURFACE ROUGHENING	(SU)
DISTURBED AREA STABILIZATION - TEMPORARY STABILIZATION	(TS1)
DISTURBED AREA STABILIZATION - TEMPORARY GRASSING	(TS2)
DISTURBED AREA STABILIZATION - PERMANENT GRASSING	(TS3)
MATTING/BLANKETS	(Mb)

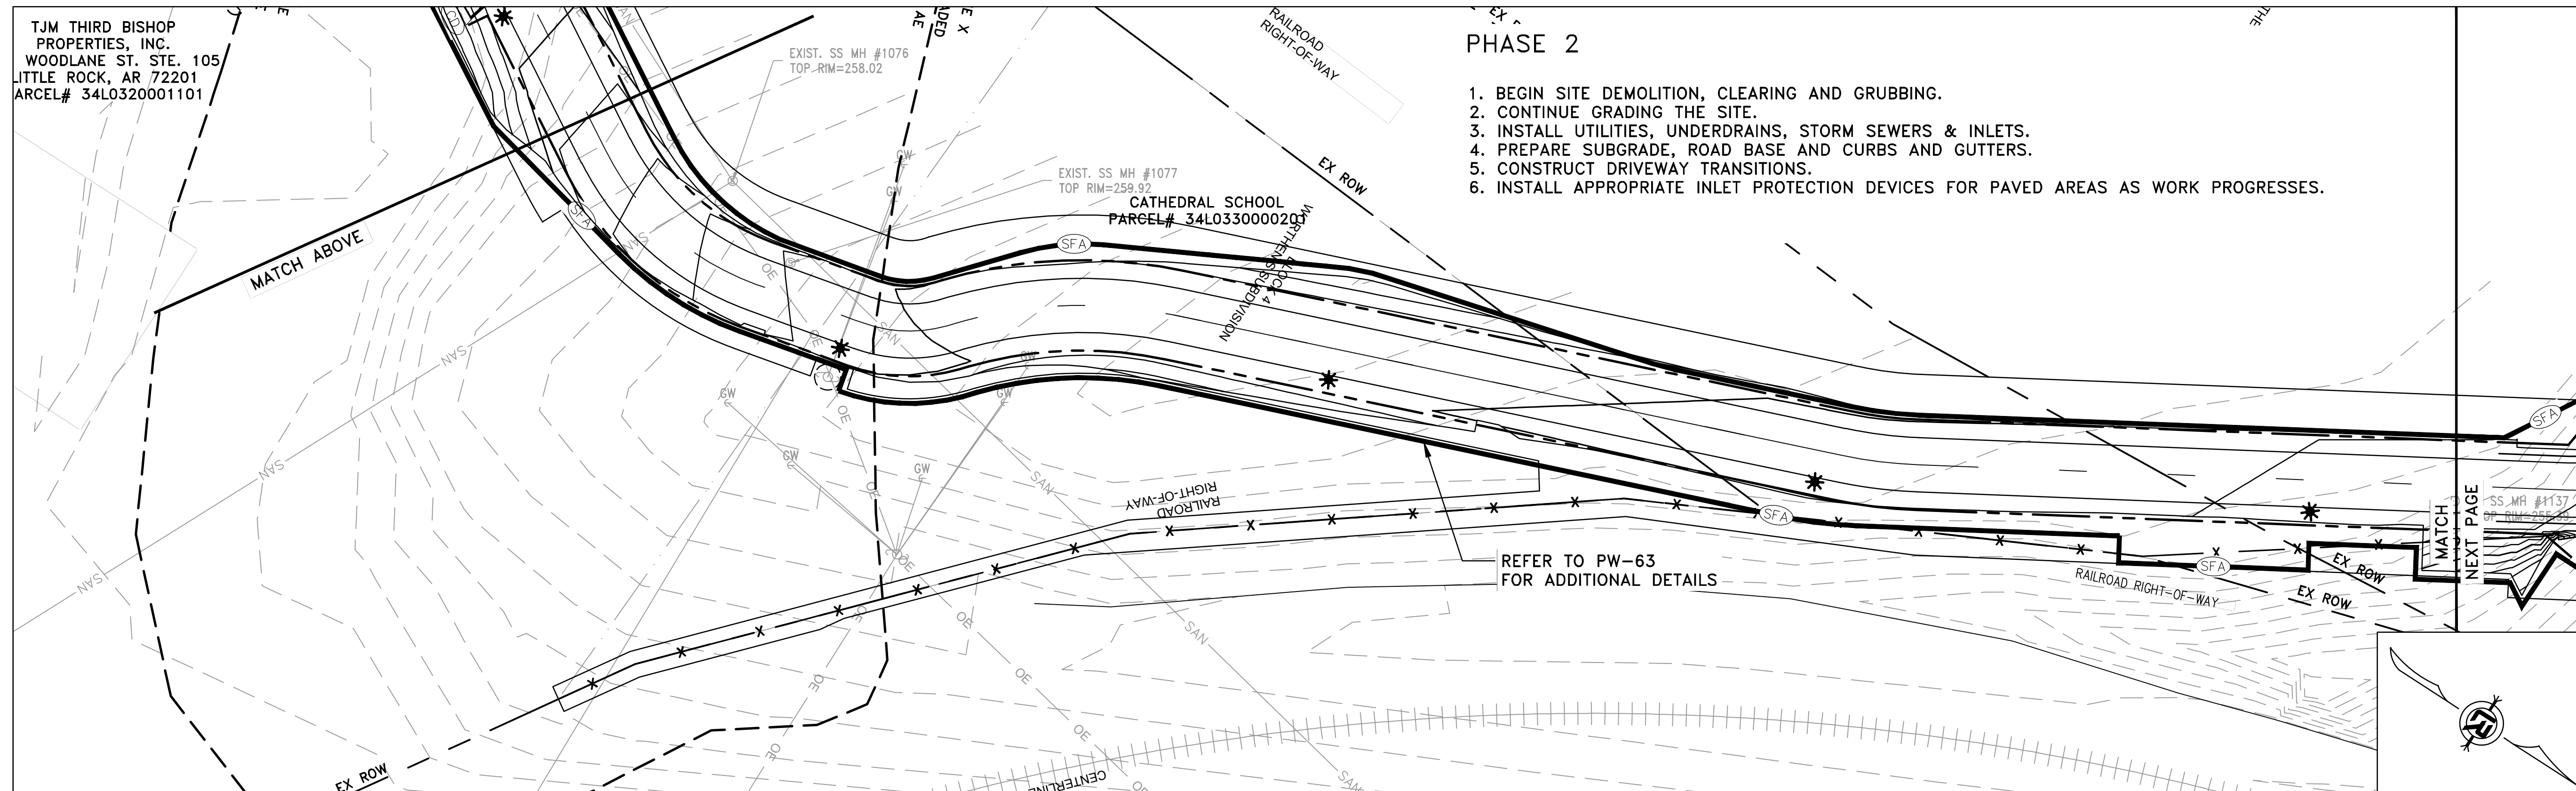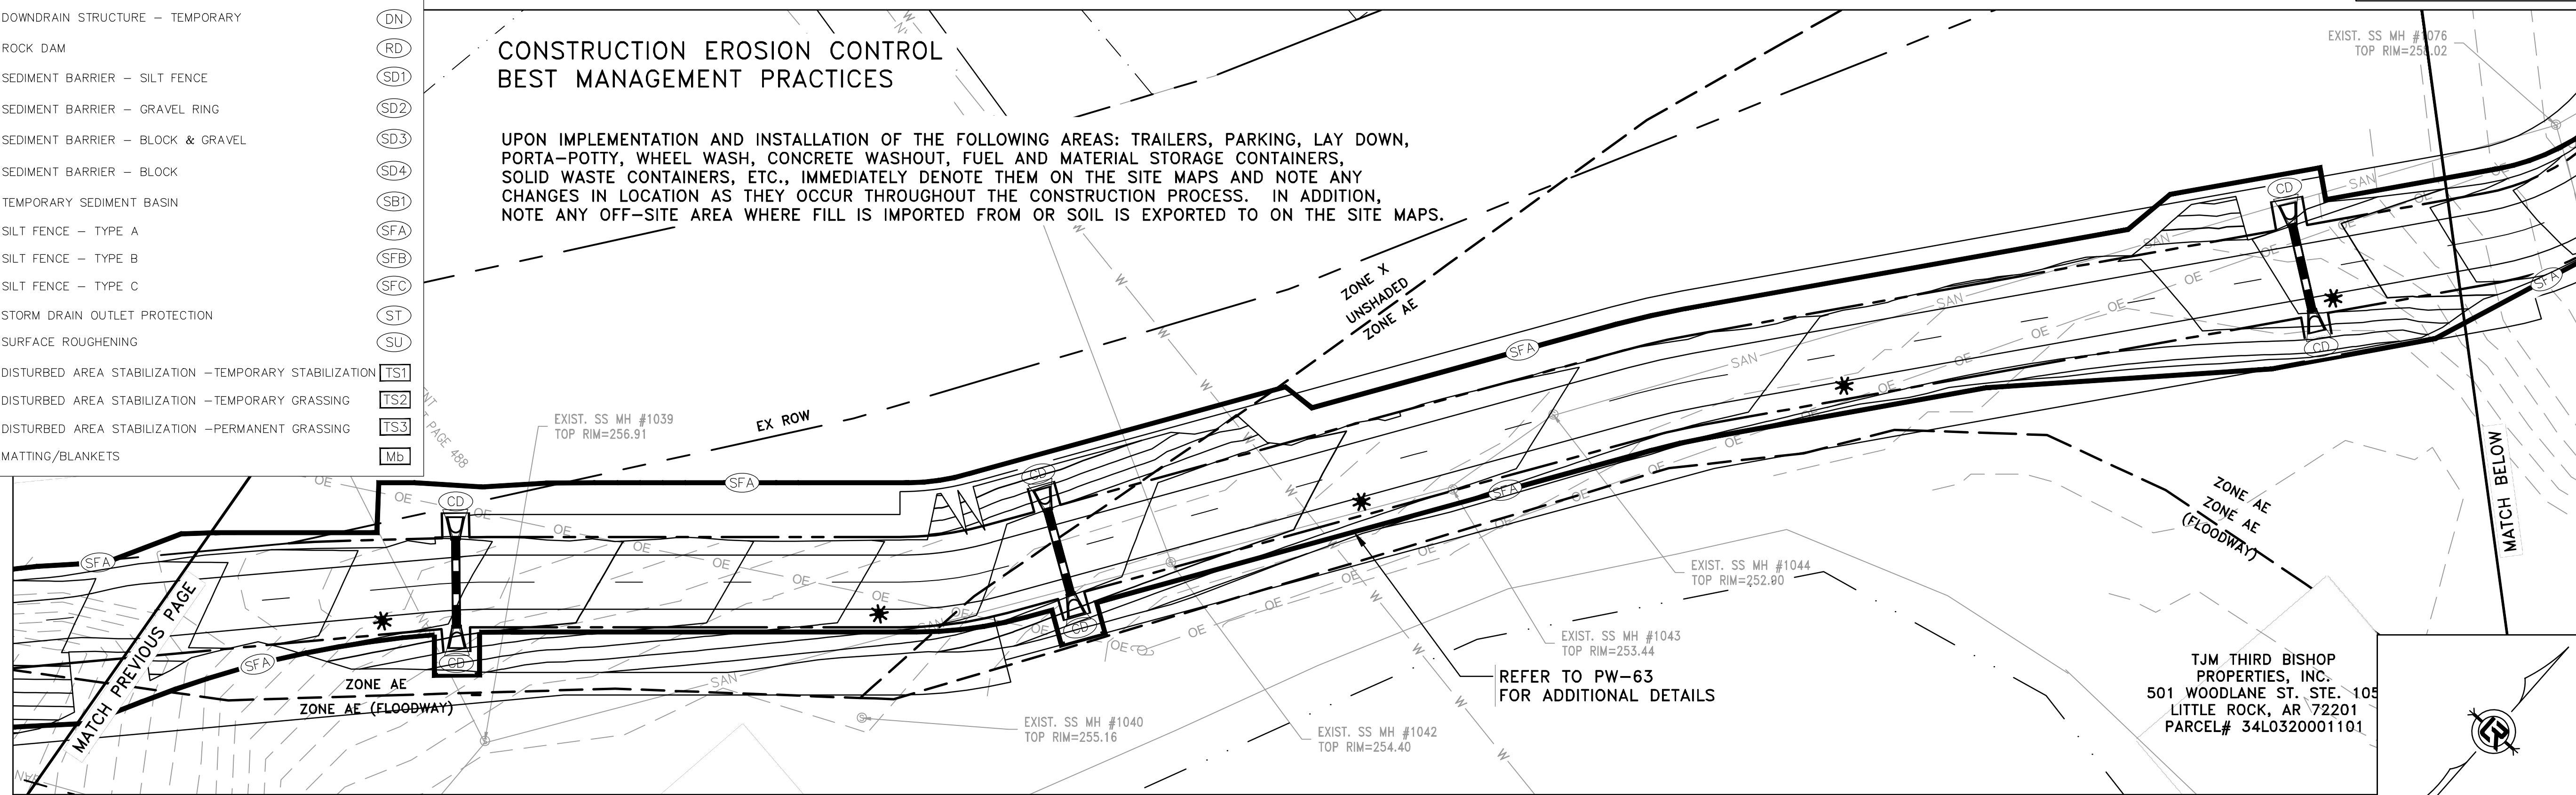

PHASE 2

1. BEGIN SITE DEMOLITION, CLEARING AND GRUBBING.
2. CONTINUE GRADING THE SITE.
3. INSTALL UTILITIES, UNDERDRAINS, STORM SEWERS & INLETS.
4. PREPARE SUBGRADE, ROAD BASE AND CURBS AND GUTTERS.
5. CONSTRUCT DRIVEWAY TRANSITIONS.
6. INSTALL APPROPRIATE INLET PROTECTION DEVICES FOR PAVED AREAS AS WORK PROGRESSES.

REFER TO PW-63
FOR ADDITIONAL DETAILS

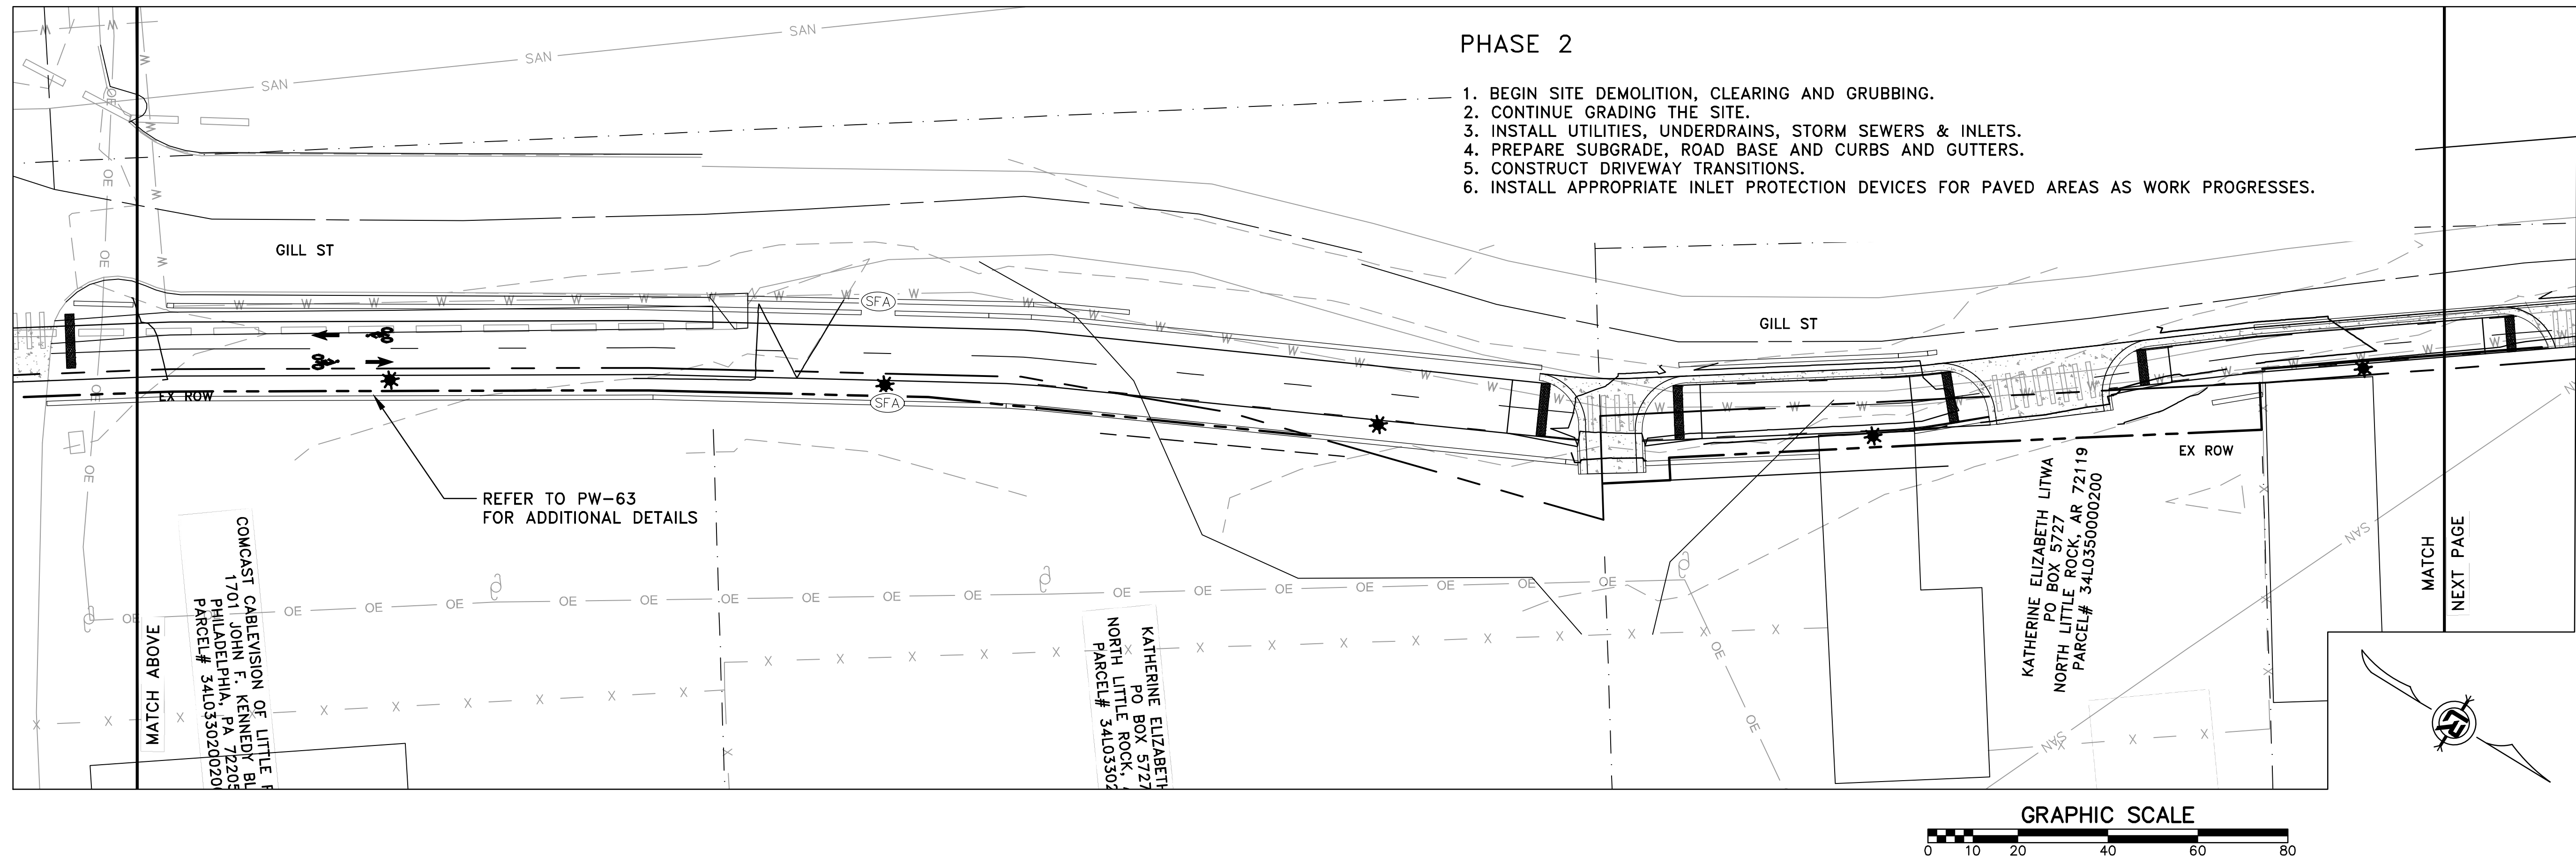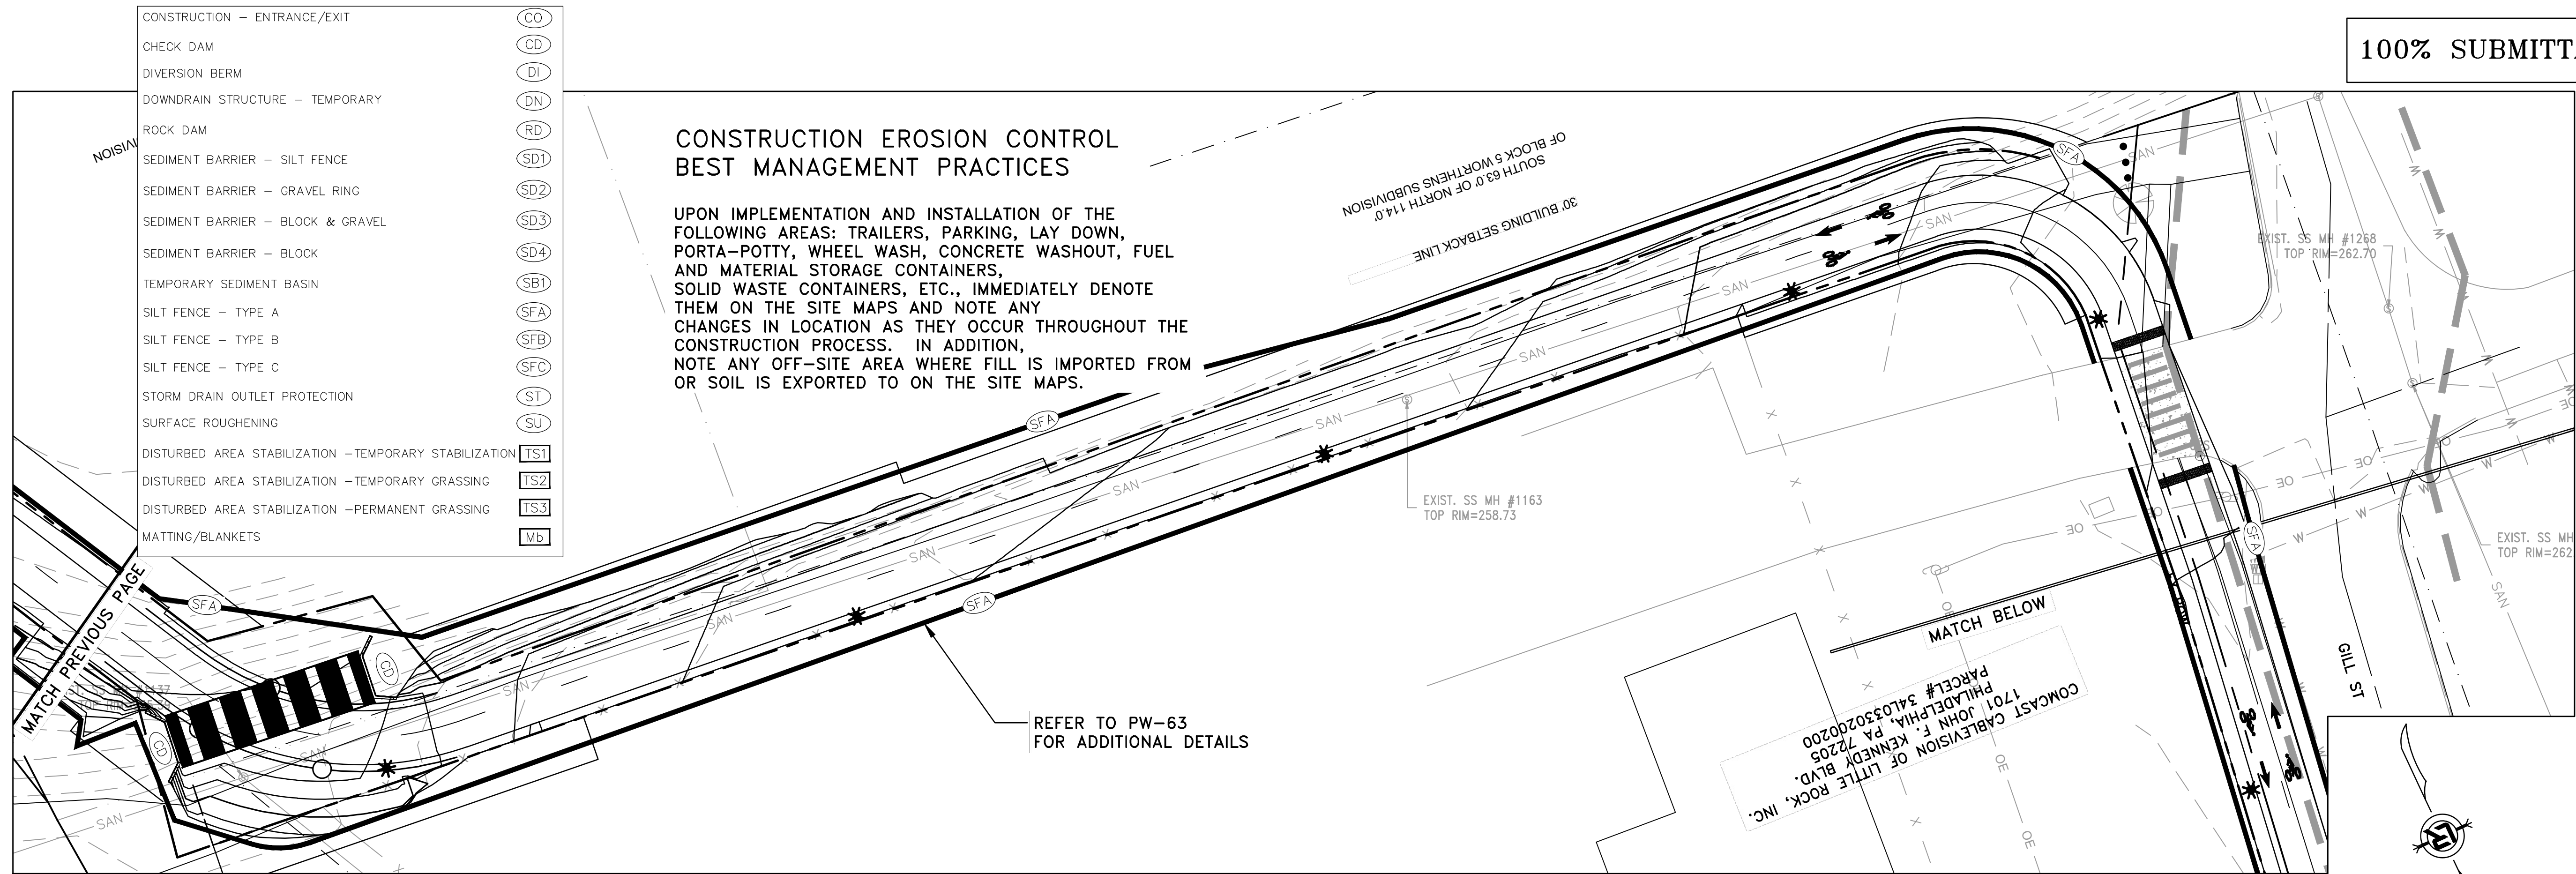

100% SUBMITTAL

REVISIONS	DATE

CITY OF LITTLE ROCK, ARKANSAS
ROSE CREEK TRAIL
EROSION CONTROL PH II SHEET 3

DEPARTMENT OF PUBLIC WORKS
CIVIL ENGINEERING
701 W. MARKHAM
LITTLE ROCK, ARKANSAS 72201



DRAWN BY AS
DESIGNED LC
CHECKED JM
DATE 05-01-2026
SCALE H: 1"=20' V: 1"=5'
PROJECT NO. 23805201
SHEET NO. C40

REVISIONS	DATE

CITY OF LITTLE ROCK, ARKANSAS

ROSE CREEK TRAIL

EROSION CONTROL PH II SHEET 4

DEPARTMENT OF PUBLIC WORKS

CIVIL ENGINEERING

701 W. MARKHAM

LITTLE ROCK, ARKANSAS 72201

STATE OF ARKANSAS

REGISTERED PROFESSIONAL ENGINEER

No. 13217

BRADLEY A. PETERSON

9/3/26

DRAWN BY

AS

DESIGNED

LC

CHECKED

JM

DATE

05-01-2026

SCALE

H: 1"=20'


V: 1"=5'

PROJECT NO.

23805201

SHEET NO.

C41

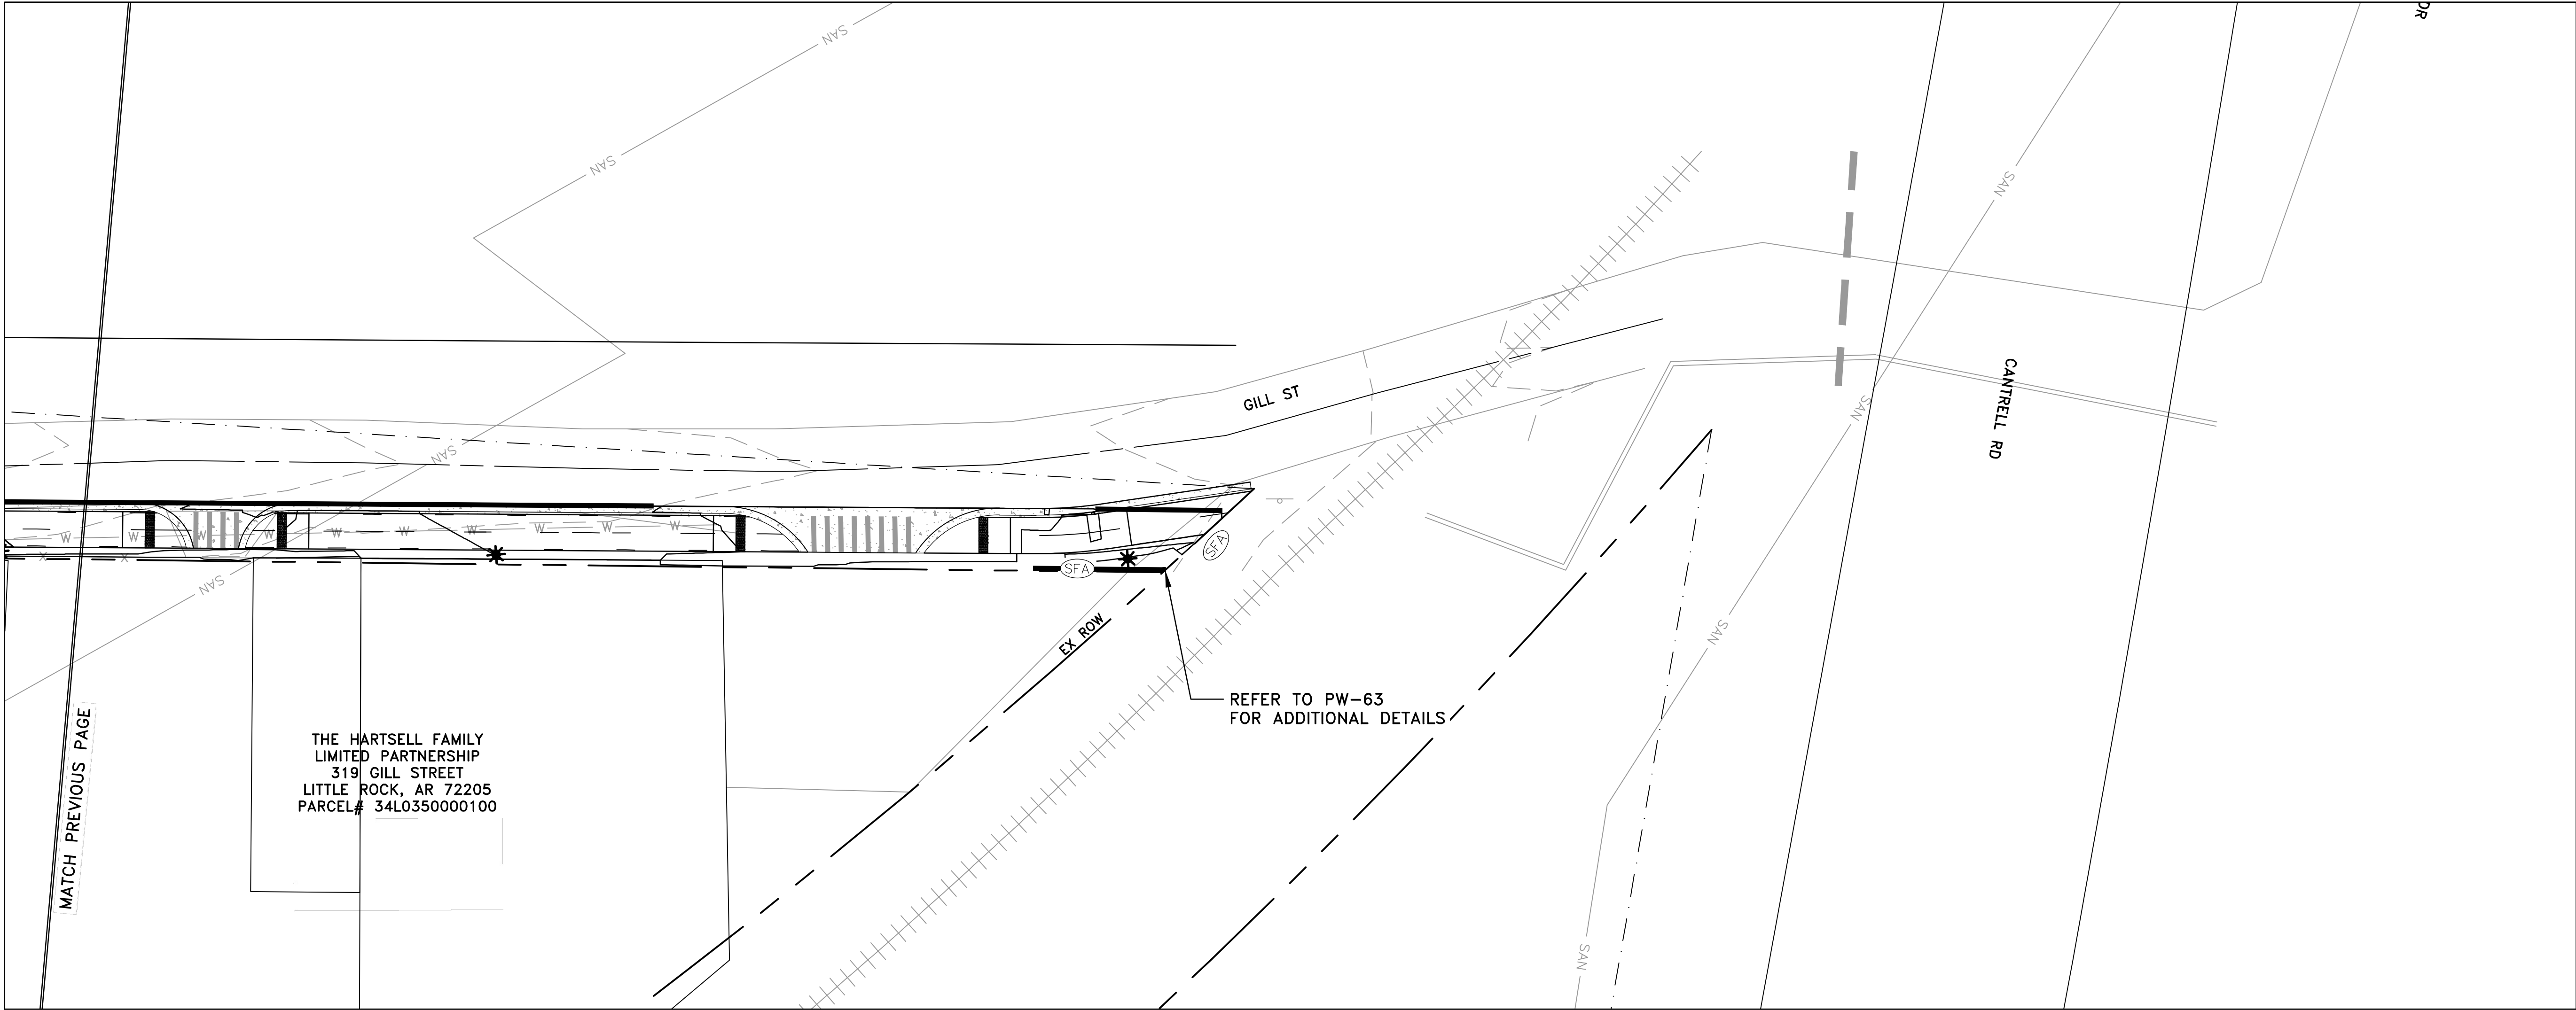


CONSTRUCTION – ENTRANCE/EXIT	(CO)
CHECK DAM	(CD)
DIVERSION BERM	(DI)
DOWNDRAIN STRUCTURE – TEMPORARY	(DN)
ROCK DAM	(RD)
SEDIMENT BARRIER – SILT FENCE	(SD1)
SEDIMENT BARRIER – GRAVEL RING	(SD2)
SEDIMENT BARRIER – BLOCK & GRAVEL	(SD3)
SEDIMENT BARRIER – BLOCK	(SD4)
TEMPORARY SEDIMENT BASIN	(SB1)
SILT FENCE – TYPE A	(SFA)
SILT FENCE – TYPE B	(SFB)
SILT FENCE – TYPE C	(SFC)
STORM DRAIN OUTLET PROTECTION	(ST)
SURFACE ROUGHENING	(SU)
DISTURBED AREA STABILIZATION –TEMPORARY STABILIZATION	(TS1)
DISTURBED AREA STABILIZATION –TEMPORARY GRASSING	(TS2)
DISTURBED AREA STABILIZATION –PERMANENT GRASSING	(TS3)
MATTING/BLANKETS	(Mb)

CONSTRUCTION EROSION CONTROL
BEST MANAGEMENT PRACTICES

UPON IMPLEMENTATION AND INSTALLATION OF THE FOLLOWING AREAS: TRAILERS, PARKING, LAY DOWN, PORTA-POTTY, WHEEL WASH, CONCRETE WASHOUT, FUEL AND MATERIAL STORAGE CONTAINERS, SOLID WASTE CONTAINERS, ETC., IMMEDIATELY DENOTE THEM ON THE SITE MAPS AND NOTE ANY CHANGES IN LOCATION AS THEY OCCUR THROUGHOUT THE CONSTRUCTION PROCESS. IN ADDITION, NOTE ANY OFF-SITE AREA WHERE FILL IS IMPORTED FROM OR SOIL IS EXPORTED TO ON THE SITE MAPS.

PHASE 2

1. BEGIN SITE DEMOLITION, CLEARING AND GRUBBING.
2. CONTINUE GRADING THE SITE.
3. INSTALL UTILITIES, UNDERDRAINS, STORM SEWERS & INLETS.
4. PREPARE SUBGRADE, ROAD BASE AND CURBS AND GUTTERS.
5. CONSTRUCT DRIVEWAY TRANSITIONS.
6. INSTALL APPROPRIATE INLET PROTECTION DEVICES FOR PAVED AREAS AS WORK PROGRESSES.

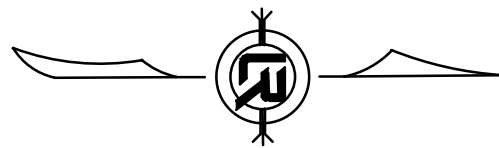


REVISIONS	DATE

CITY OF LITTLE ROCK, ARKANSAS
ROSE CREEK TRAIL
EROSION CONTROL PH III SHEET 1

DEPARTMENT OF PUBLIC WORKS
CIVIL ENGINEERING
701 W. MARKHAM
LITTLE ROCK, ARKANSAS 72201



DRAWN BY	AS
DESIGNED	LC
CHECKED	JM
DATE	05-01-2026
SCALE	H: 1"=20' V: 1"=5'
PROJECT NO.	23805201
SHEET NO.	C42

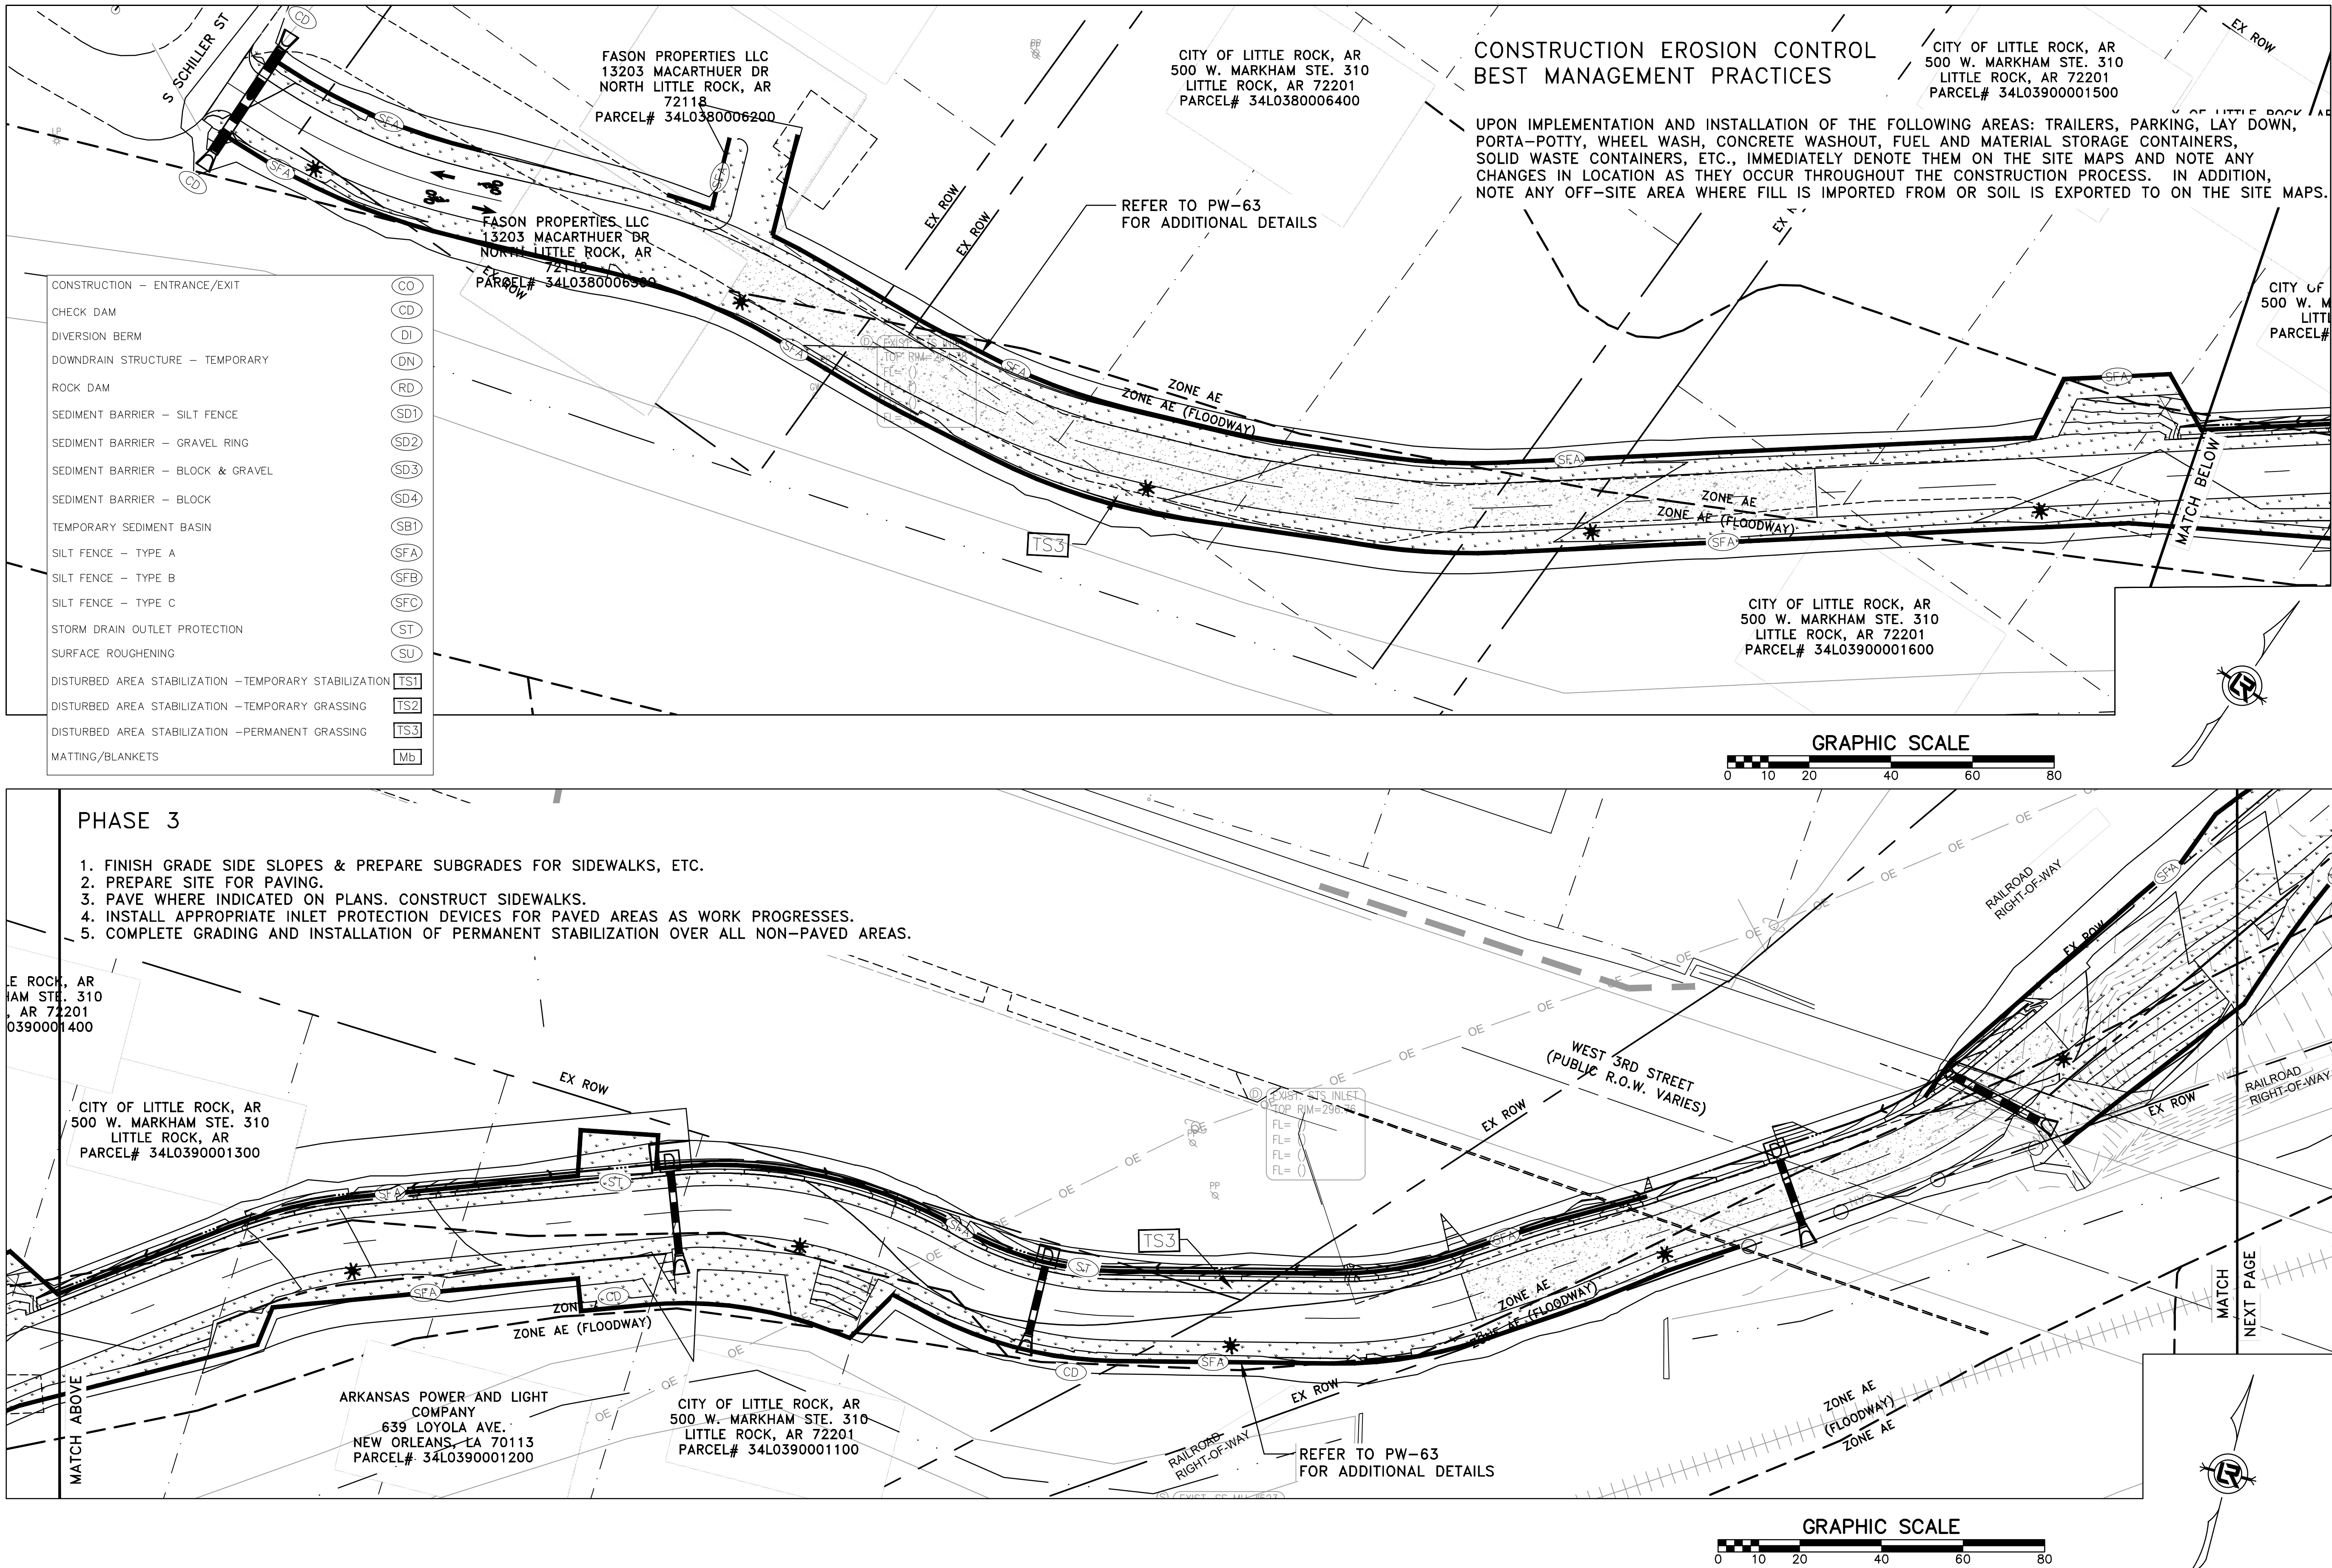


100% SUBMITTAL

REVISIONS DATE

CITY OF LITTLE ROCK, ARKANSAS
ROSE CREEK TRAIL
EROSION CONTROL PH III SHEET 2

DEPARTMENT OF PUBLIC WORKS
CIVIL ENGINEERING
701 W. MARKHAM
LITTLE ROCK, ARKANSAS 72201

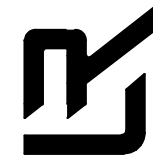

DRAWN BY
AS
DESIGNED
LC
CHECKED
JM
DATE
05-01-2026
SCALE
H: 1"=20'
V: 1"=5'
PROJECT NO.
23805201


SHEET NO.

C43

CONSTRUCTION EROSION CONTROL BEST MANAGEMENT PRACTICES


UPON IMPLEMENTATION AND INSTALLATION OF THE FOLLOWING AREAS: TRAILERS, PARKING, LAY DOWN, PORTA-POTTY, WHEEL WASH, CONCRETE WASHOUT, FUEL AND MATERIAL STORAGE CONTAINERS, SOLID WASTE CONTAINERS, ETC., IMMEDIATELY DENOTE THEM ON THE SITE MAPS AND NOTE ANY CHANGES IN LOCATION AS THEY OCCUR THROUGHOUT THE CONSTRUCTION PROCESS. IN ADDITION, NOTE ANY OFF-SITE AREA WHERE FILL IS IMPORTED FROM OR SOIL IS EXPORTED TO ON THE SITE MAPS.



CONSTRUCTION - ENTRANCE/EXIT	(CO)
CHECK DAM	(CD)
DIVERSION BERM	(DI)
DOWNDRAIN STRUCTURE - TEMPORARY	(DN)
ROCK DAM	(RD)
SEDIMENT BARRIER - SILT FENCE	(SD1)
SEDIMENT BARRIER - GRAVEL RING	(SD2)
SEDIMENT BARRIER - BLOCK & GRAVEL	(SD3)
SEDIMENT BARRIER - BLOCK	(SD4)
TEMPORARY SEDIMENT BASIN	(SB1)
SILT FENCE - TYPE A	(SFA)
SILT FENCE - TYPE B	(SFB)
SILT FENCE - TYPE C	(SFC)
STORM DRAIN OUTLET PROTECTION	(ST)
SURFACE ROUGHENING	(SU)
DISTURBED AREA STABILIZATION - TEMPORARY STABILIZATION	(TS1)
DISTURBED AREA STABILIZATION - TEMPORARY GRASSING	(TS2)
DISTURBED AREA STABILIZATION - PERMANENT GRASSING	(TS3)
MATTING/BLANKETS	(Mb)

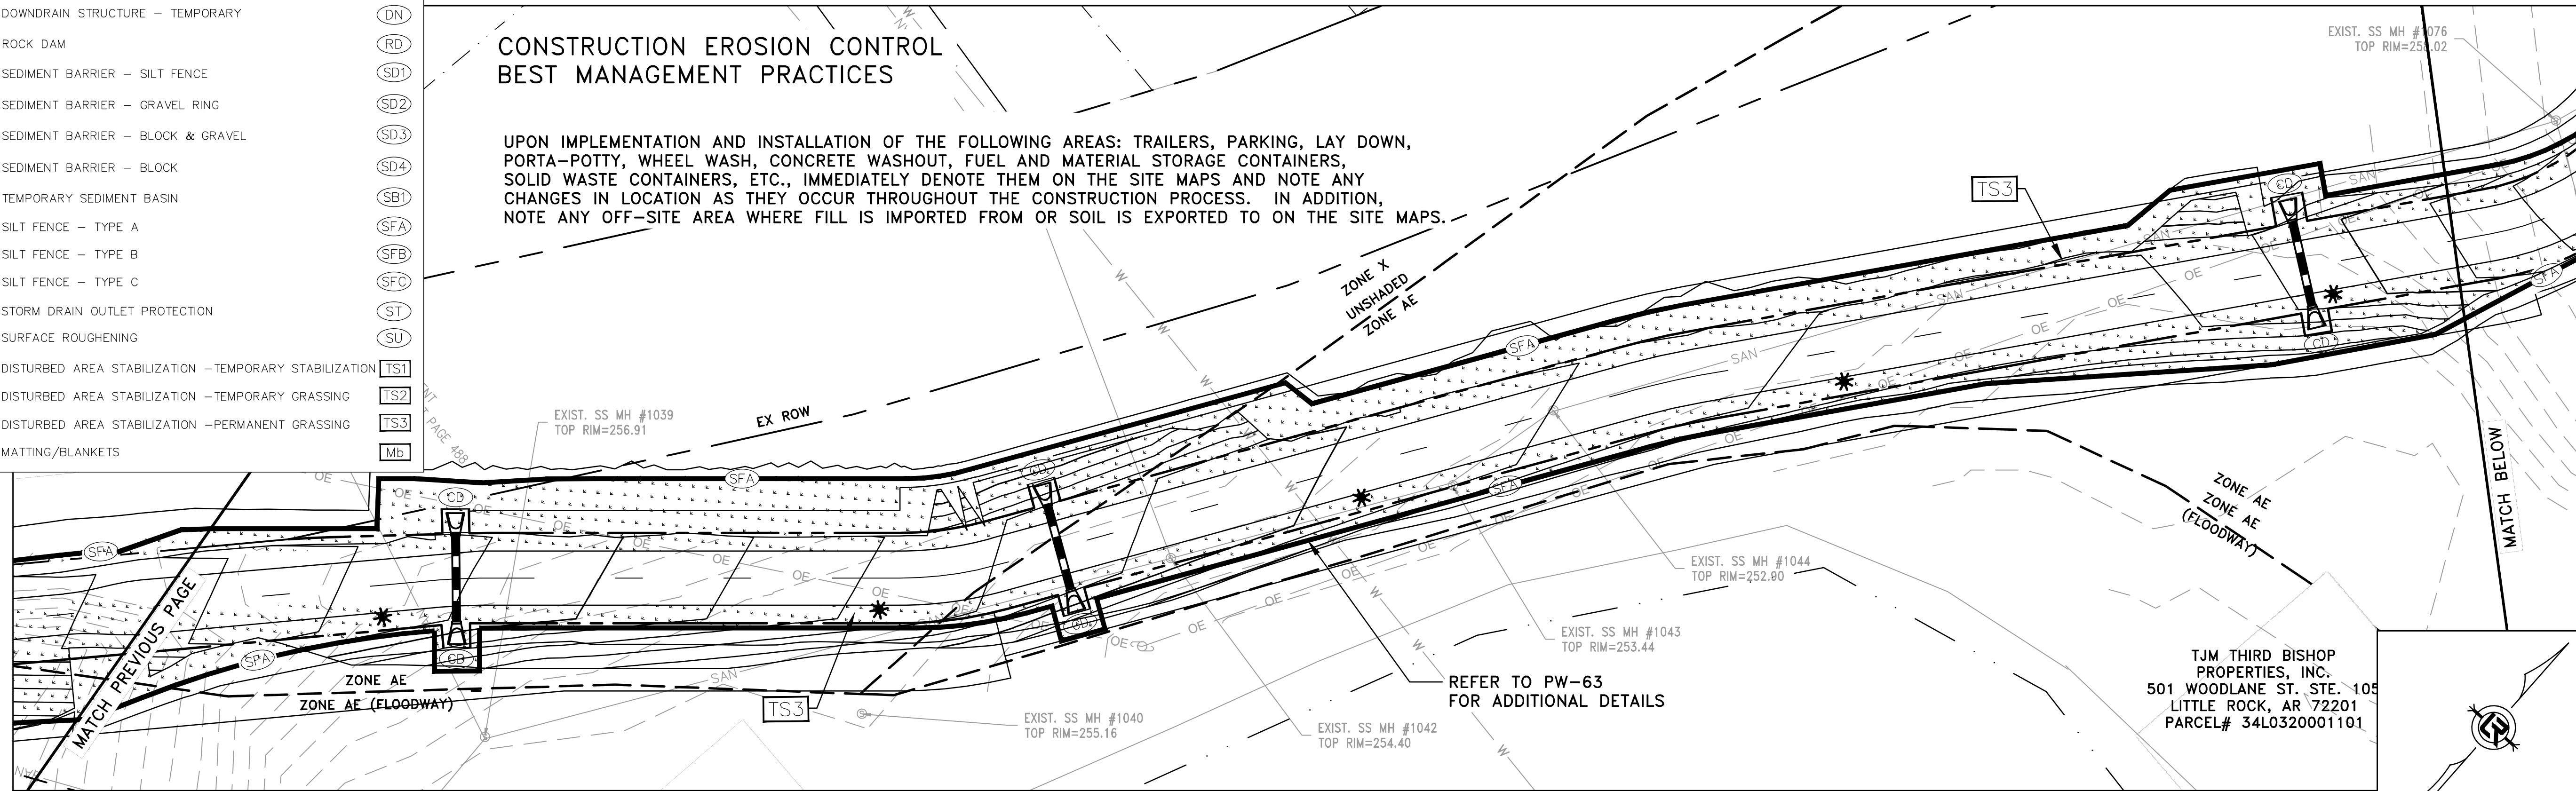

PHASE 3

1. FINISH GRADE SIDE SLOPES & PREPARE SUBGRADES FOR SIDEWALKS, ETC.
2. PREPARE SITE FOR PAVING.
3. PAVE WHERE INDICATED ON PLANS. CONSTRUCT SIDEWALKS.
4. INSTALL APPROPRIATE INLET PROTECTION DEVICES FOR PAVED AREAS AS WORK PROGRESSES.
5. COMPLETE GRADING AND INSTALLATION OF PERMANENT STABILIZATION OVER ALL NON-PAVED AREAS.

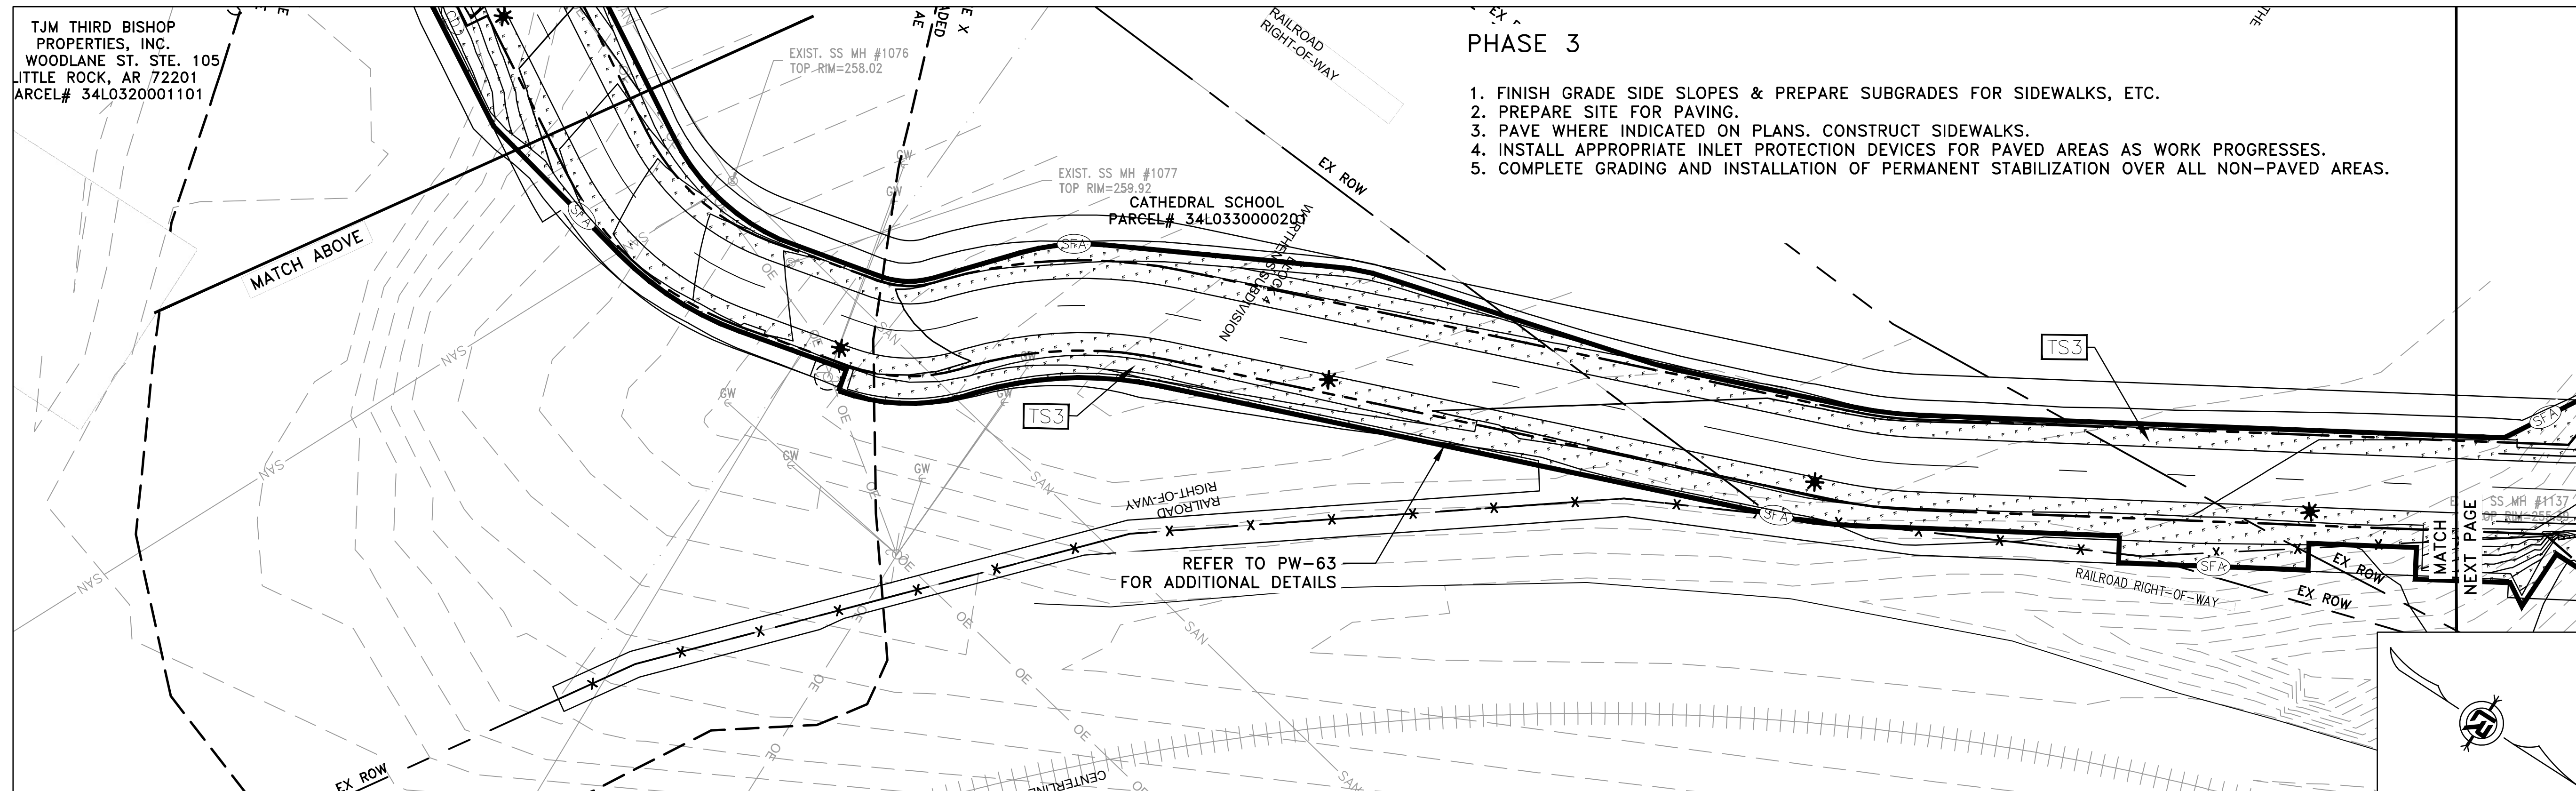

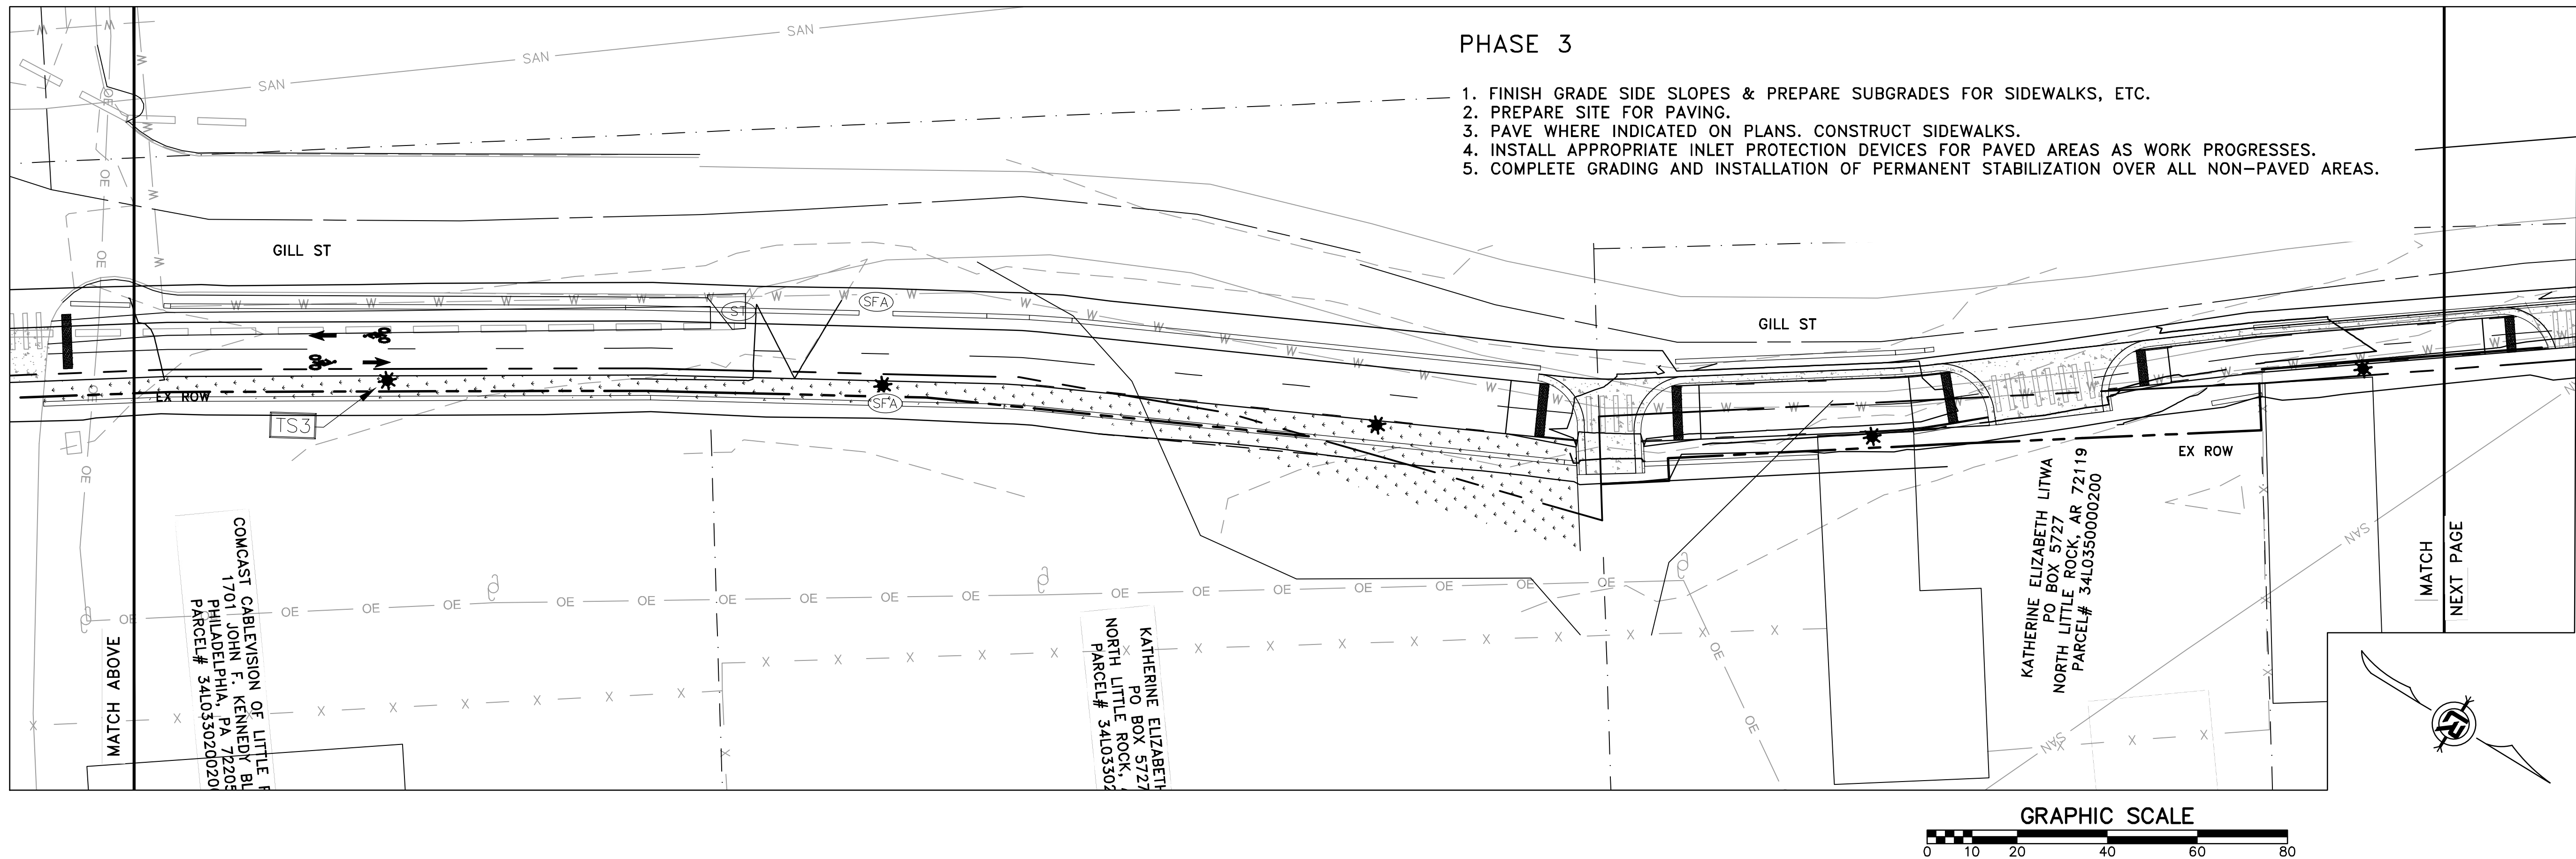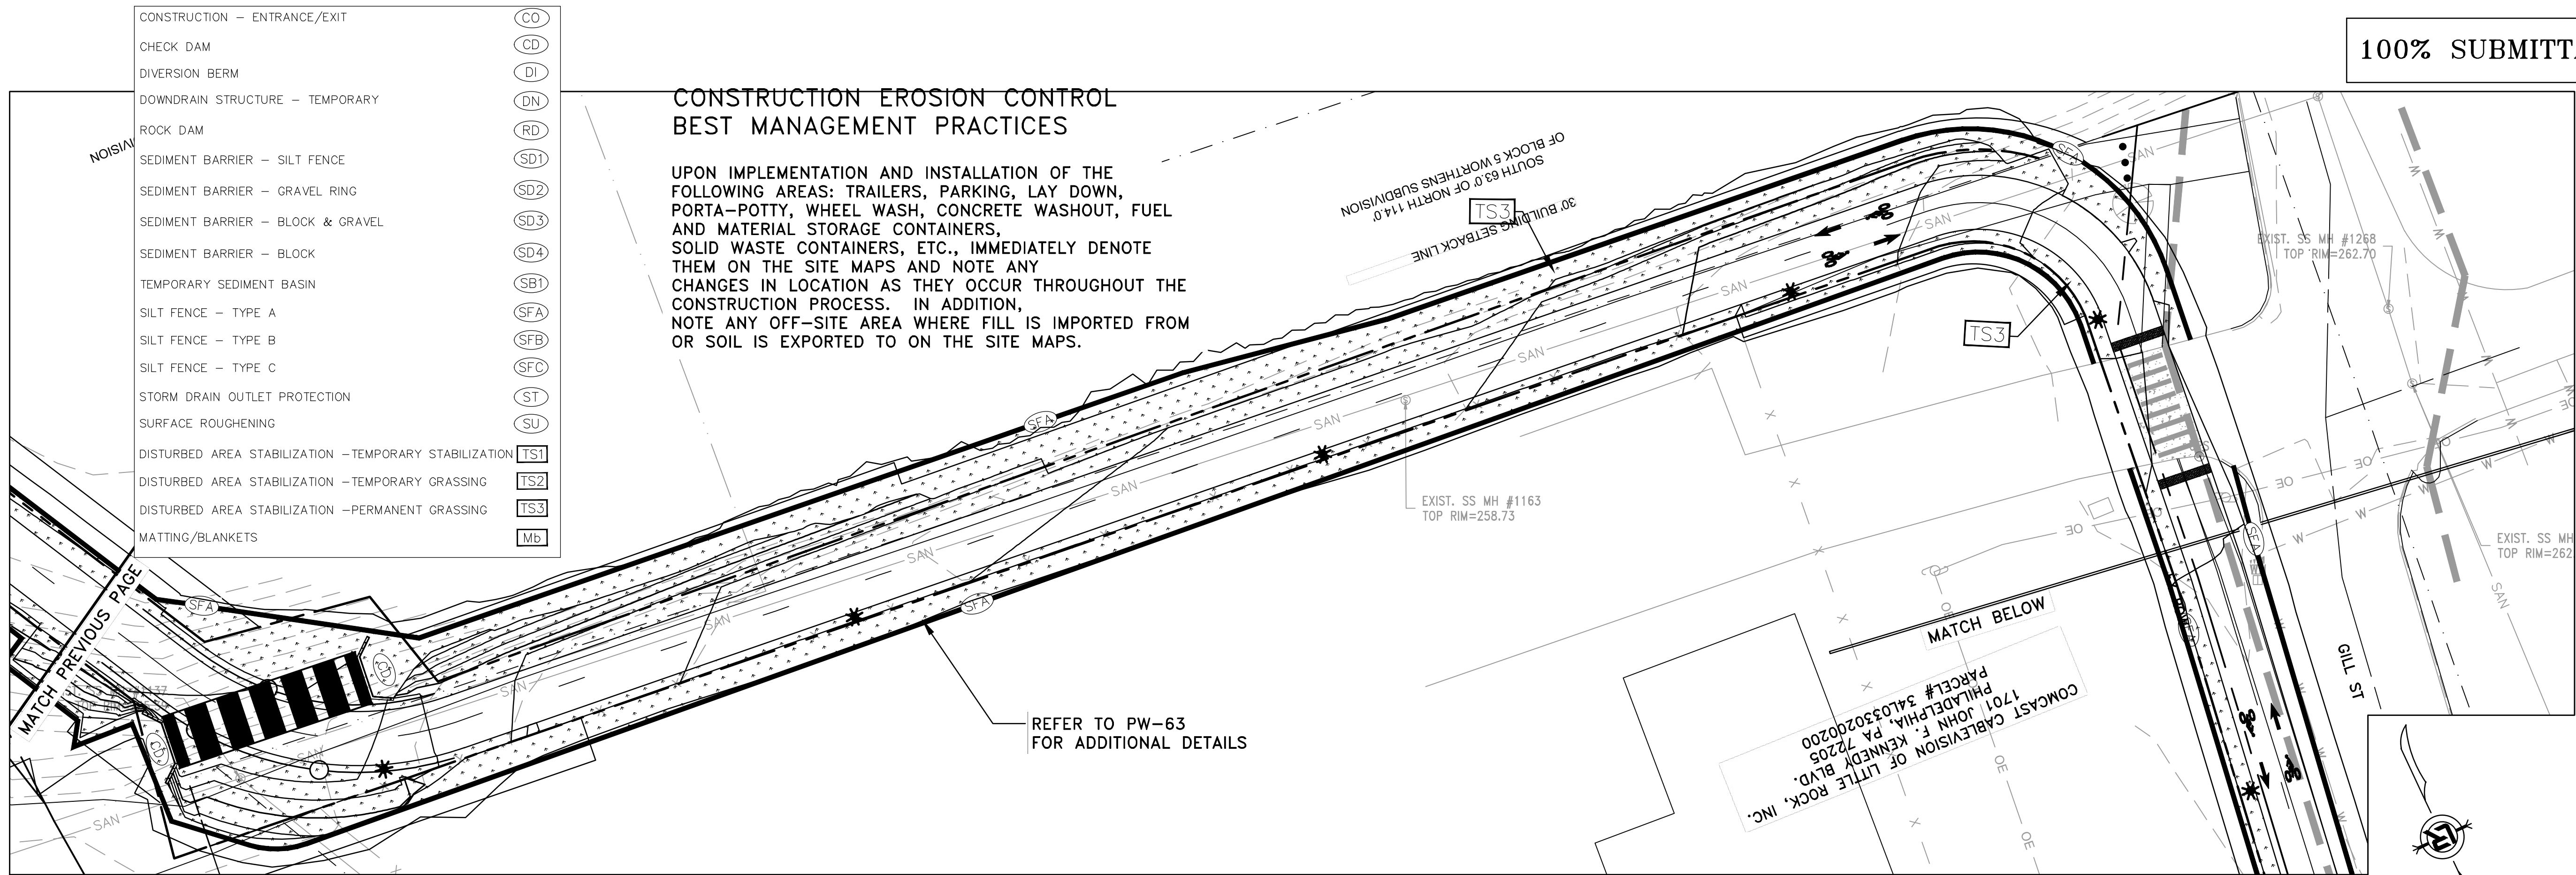

REVISIONS	DATE

CITY OF LITTLE ROCK, ARKANSAS ROSE CREEK TRAIL	EROSION CONTROL PH III SHEET 3
---	--------------------------------

DEPARTMENT OF PUBLIC WORKS
CIVIL ENGINEERING
701 W. MARKHAM
LITTLE ROCK, ARKANSAS 72201

ER



DRAWN BY AS
DESIGNED LC
CHECKED JM
DATE 05-01-2026
SCALE H: 1"=20' V: 1"=5'
PROJECT NO. 23805201
SHEET NO. C44

REVISIONS	DATE

CITY OF LITTLE ROCK, ARKANSAS
ROSE CREEK TRAIL

EROSION CONTROL PH III SHEET 4

DEPARTMENT OF PUBLIC WORKS
CIVIL ENGINEERING
701 W. MARKHAM
LITTLE ROCK, ARKANSAS 72201

STATE OF ARKANSAS
REGISTERED PROFESSIONAL ENGINEER
No. 13217
BRADLEY A. PETERSON
9/3/26

DRAWN BY
AS

DESIGNED
LC


CHECKED
JM

DATE
05-01-2026

SCALE
H: 1"=20'
V: 1"=5'

PROJECT NO.
23805201

SHEET NO.
C45

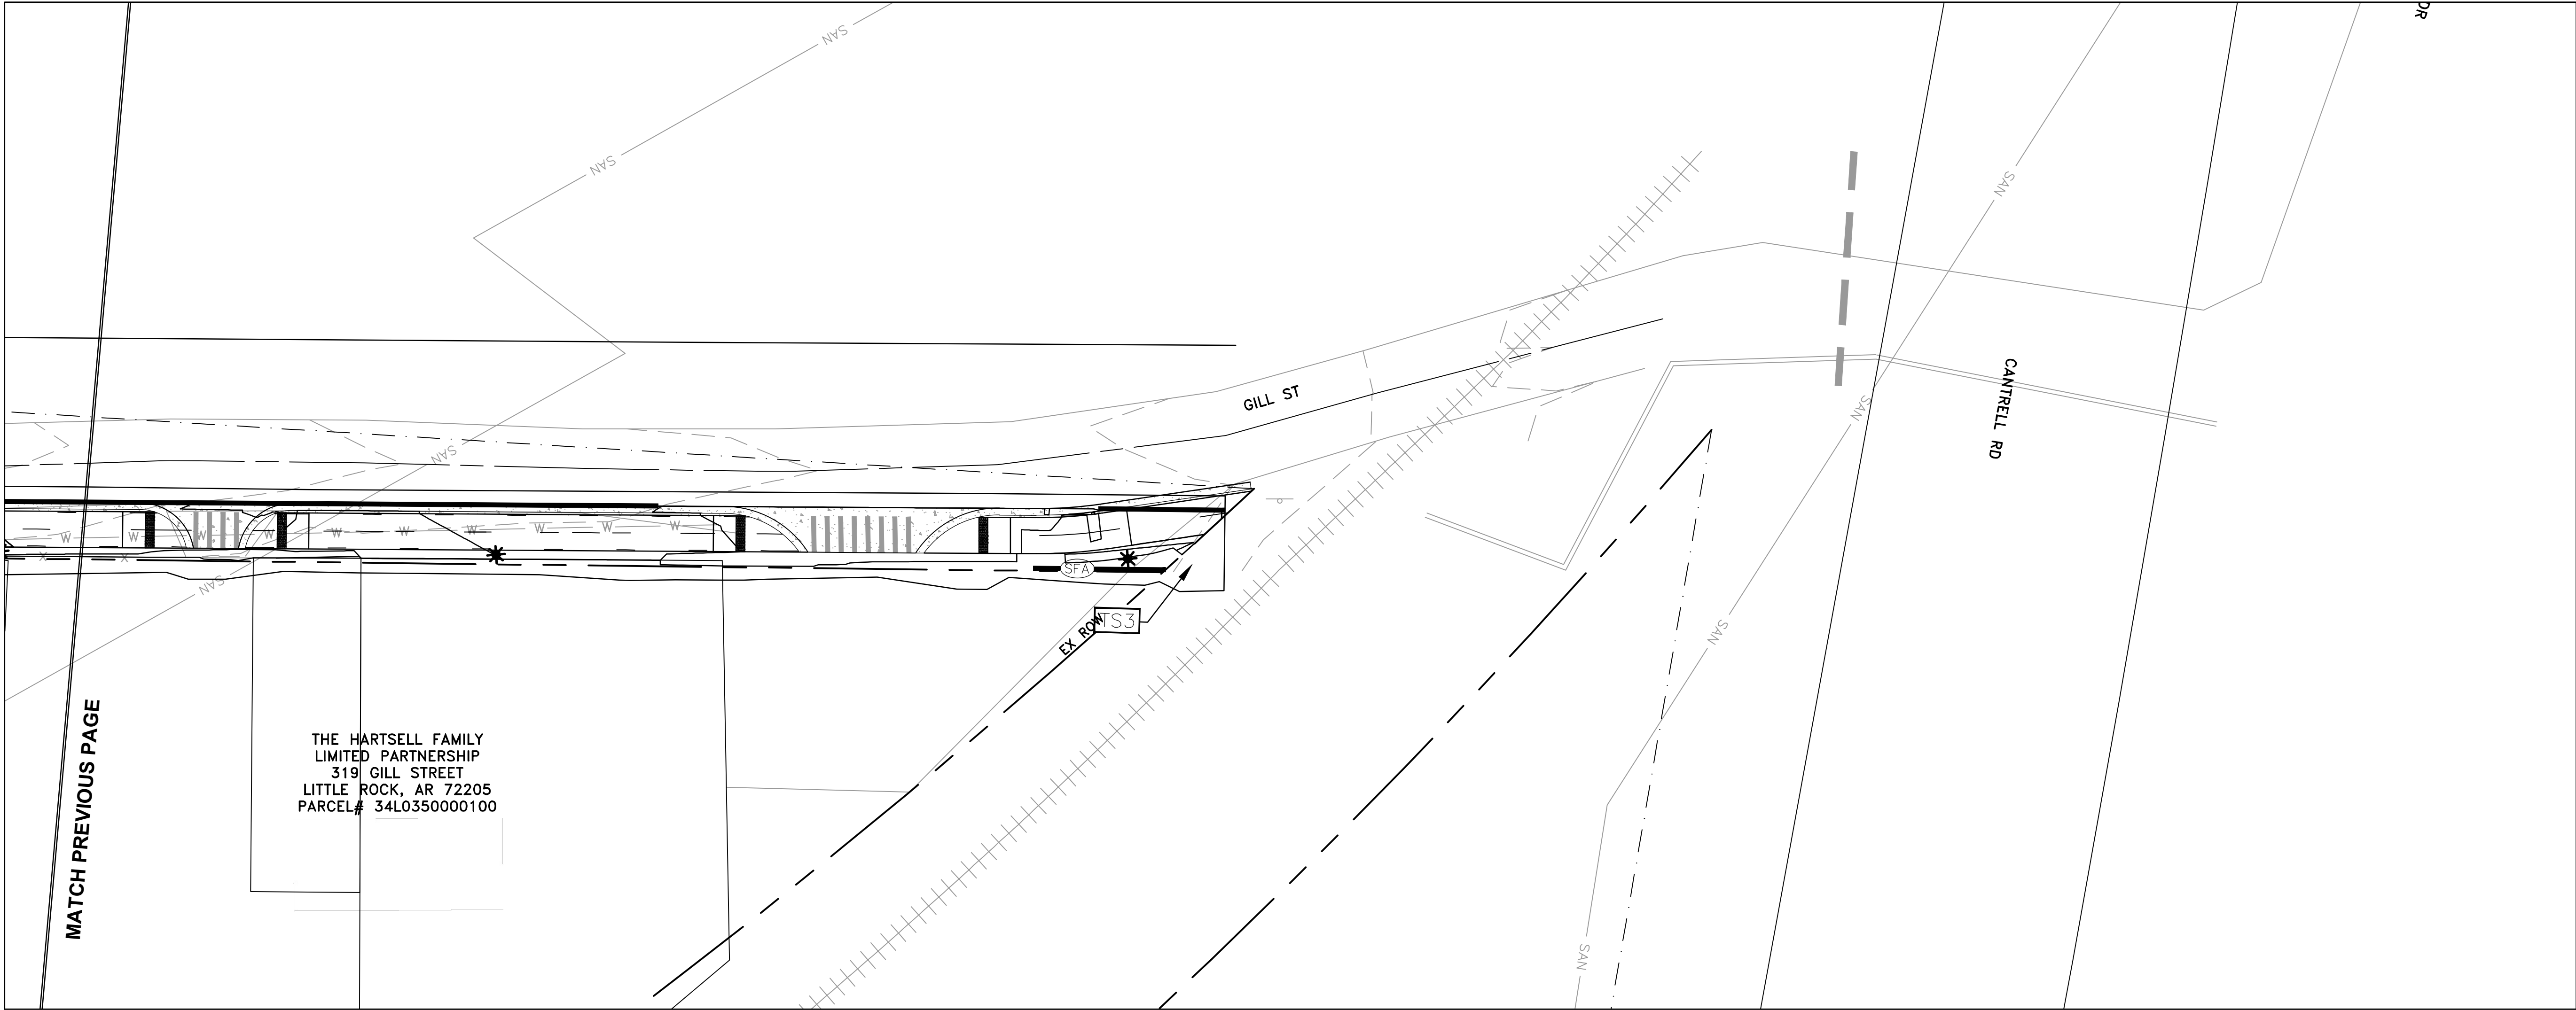

CONSTRUCTION - ENTRANCE/EXIT	(CO)
CHECK DAM	(CD)
DIVERSION BERM	(DI)
DOWNDRAIN STRUCTURE - TEMPORARY	(DN)
ROCK DAM	(RD)
SEDIMENT BARRIER - SILT FENCE	(SD1)
SEDIMENT BARRIER - GRAVEL RING	(SD2)
SEDIMENT BARRIER - BLOCK & GRAVEL	(SD3)
SEDIMENT BARRIER - BLOCK	(SD4)
TEMPORARY SEDIMENT BASIN	(SB1)
SILT FENCE - TYPE A	(SFA)
SILT FENCE - TYPE B	(SFB)
SILT FENCE - TYPE C	(SFC)
STORM DRAIN OUTLET PROTECTION	(ST)
SURFACE ROUGHENING	(SU)
DISTURBED AREA STABILIZATION -TEMPORARY STABILIZATION	(TS1)
DISTURBED AREA STABILIZATION -TEMPORARY GRASSING	(TS2)
DISTURBED AREA STABILIZATION -PERMANENT GRASSING	(TS3)
MATTING/BLANKETS	(Mb)

CONSTRUCTION EROSION CONTROL
BEST MANAGEMENT PRACTICES

UPON IMPLEMENTATION AND INSTALLATION OF THE FOLLOWING AREAS: TRAILERS, PARKING, LAY DOWN, PORTA-POTTY, WHEEL WASH, CONCRETE WASHOUT, FUEL AND MATERIAL STORAGE CONTAINERS, SOLID WASTE CONTAINERS, ETC., IMMEDIATELY DENOTE THEM ON THE SITE MAPS AND NOTE ANY CHANGES IN LOCATION AS THEY OCCUR THROUGHOUT THE CONSTRUCTION PROCESS. IN ADDITION, NOTE ANY OFF-SITE AREA WHERE FILL IS IMPORTED FROM OR SOIL IS EXPORTED TO ON THE SITE MAPS.

PHASE 3

1. FINISH GRADE SIDE SLOPES & PREPARE SUBGRADES FOR SIDEWALKS, ETC.
2. PREPARE SITE FOR PAVING.
3. PAVE WHERE INDICATED ON PLANS. CONSTRUCT SIDEWALKS.
4. INSTALL APPROPRIATE INLET PROTECTION DEVICES FOR PAVED AREAS AS WORK PROGRESSES.
5. COMPLETE GRADING AND INSTALLATION OF PERMANENT STABILIZATION OVER ALL NON-PAVED AREAS.

REVISIONS	DATE

CITY OF LITTLE ROCK, ARKANSAS

ROSE CREEK TRAIL

LIGHTING PLAN SHEET 1

DEPARTMENT OF PUBLIC WORKS

CIVIL ENGINEERING

701 W. MARKHAM

LITTLE ROCK, ARKANSAS 72201



STATE OF ARKANSAS

REGISTERED PROFESSIONAL ENGINEER

BRADLEY A. PETERSON

No. 13217

9/3/26

DRAWN BY

AS

DESIGNED

LC

CHECKED

JM

DATE

05-01-2026

SCALE

H: 1"=20'


V: 1"=5'

PROJECT NO.

23805201


SHEET NO.

C46

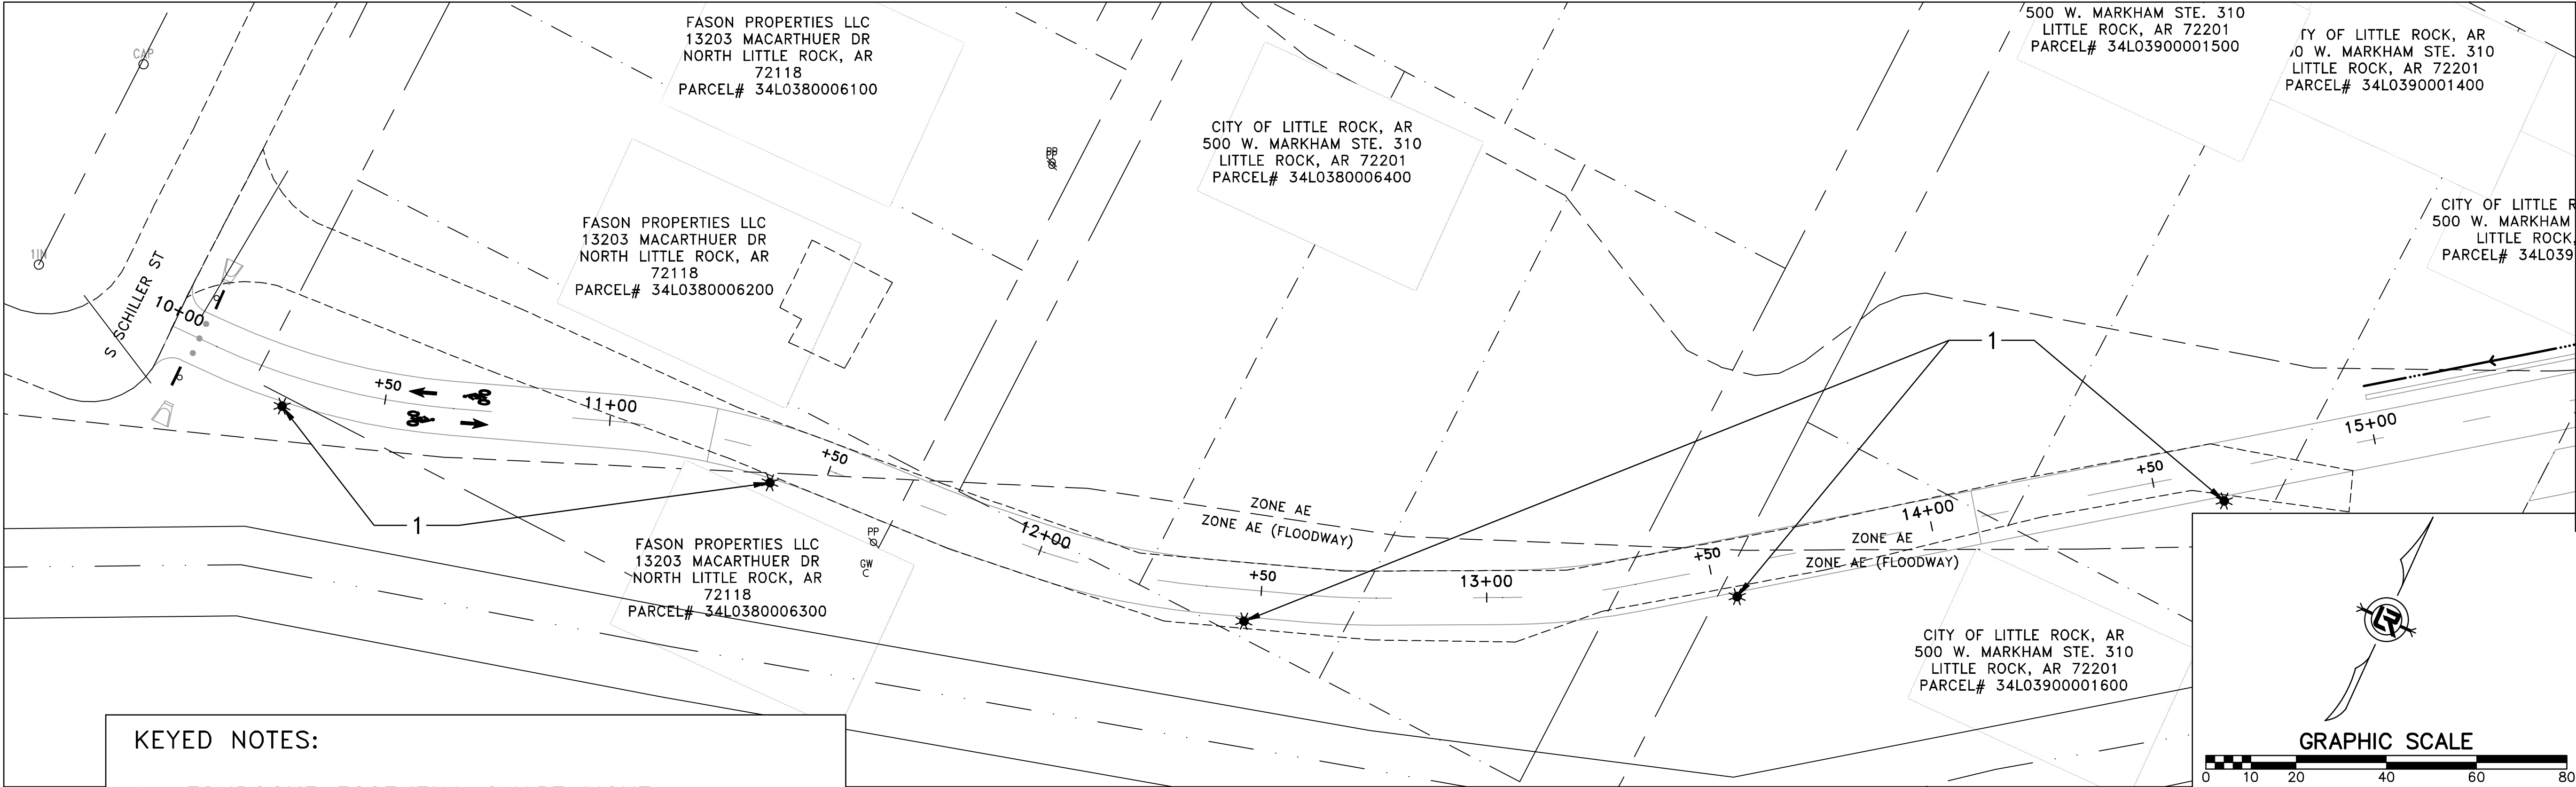

KEYED NOTES:

1= FONROCHE ESSENTIAL SMART LIGHT
[T54-CK16B-3K-GEN3] [P190F-2P]HW-MC-FIXTURE
W/ 14' ROUND-DIRECT BURIAL POLE
& 4' MAST ARM

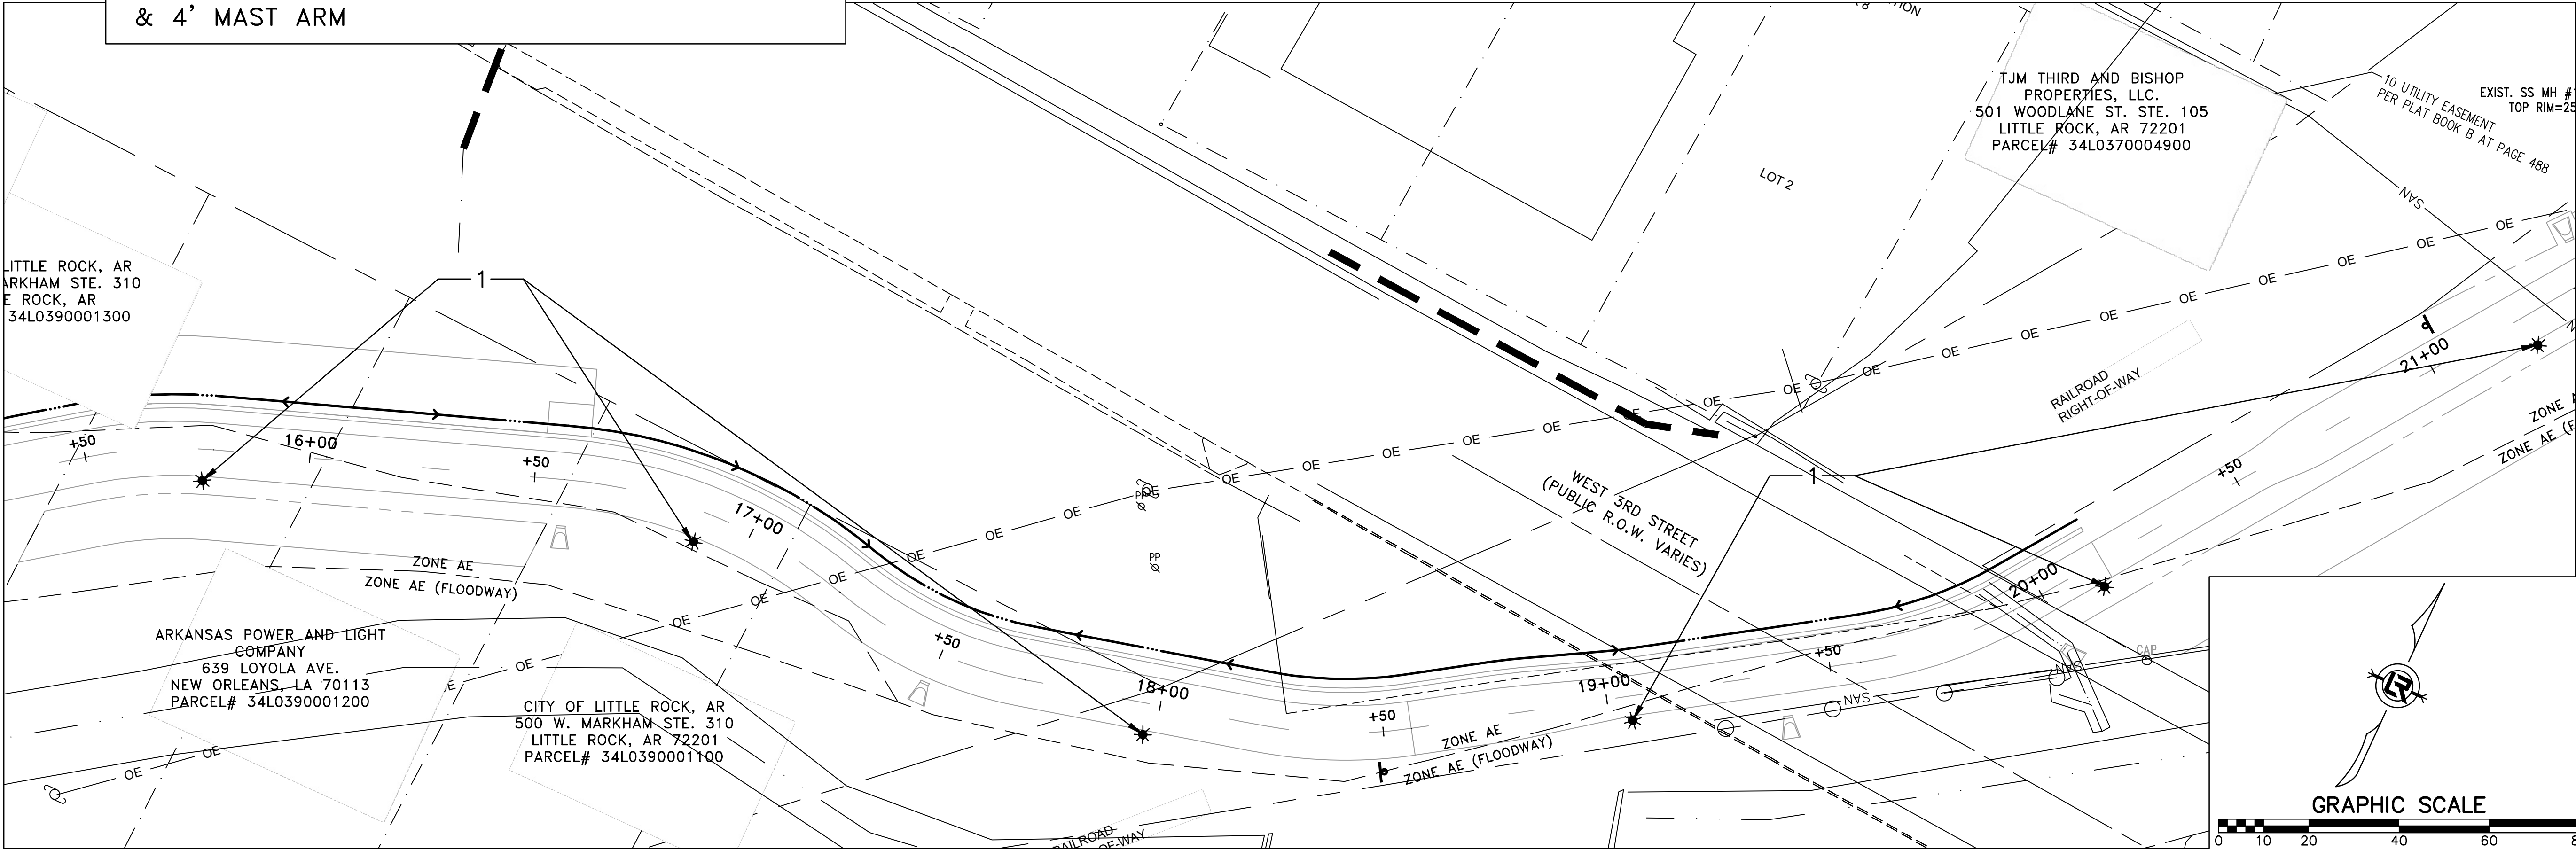

100% SUBMITTAL

REVISIONS	DATE


CITY OF LITTLE ROCK, ARKANSAS
ROSE CREEK TRAIL
LIGHTING PLAN SHEET 2

DEPARTMENT OF PUBLIC WORKS
CIVIL ENGINEERING
701 W. MARKHAM
LITTLE ROCK, ARKANSAS 72201






DRAWN BY	AS
DESIGNED	LC
CHECKED	JM
DATE	05-01-2026
SCALE	H: 1"=20' V: 1"=5'
PROJECT NO.	23805201
SHEET NO.	C47

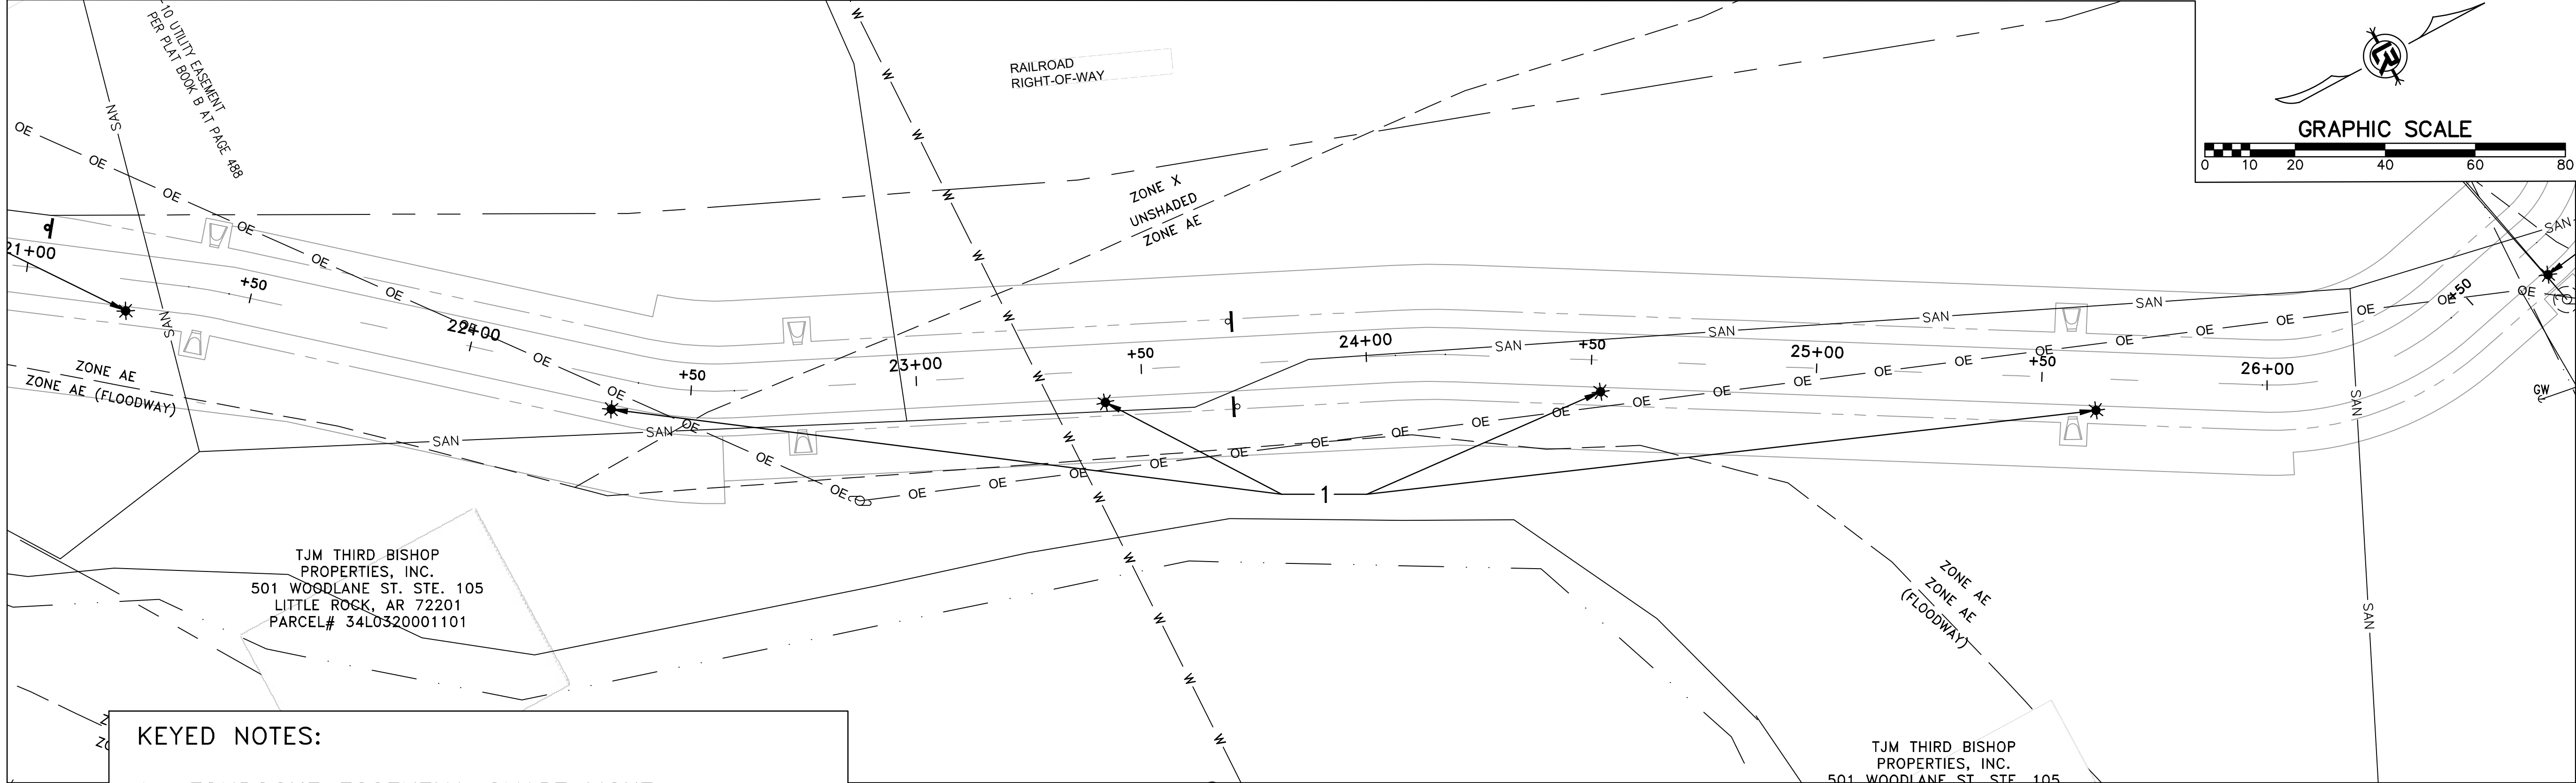

KEYED NOTES:
1= FONROCHE ESSENTIAL SMART LIGHT
[T54-CK16B-3K-GEN3] [P190F-2P]HW-MC-FIXTURE
W/ 14' ROUND-DIRECT BURIAL POLE
& 4' MAST ARM

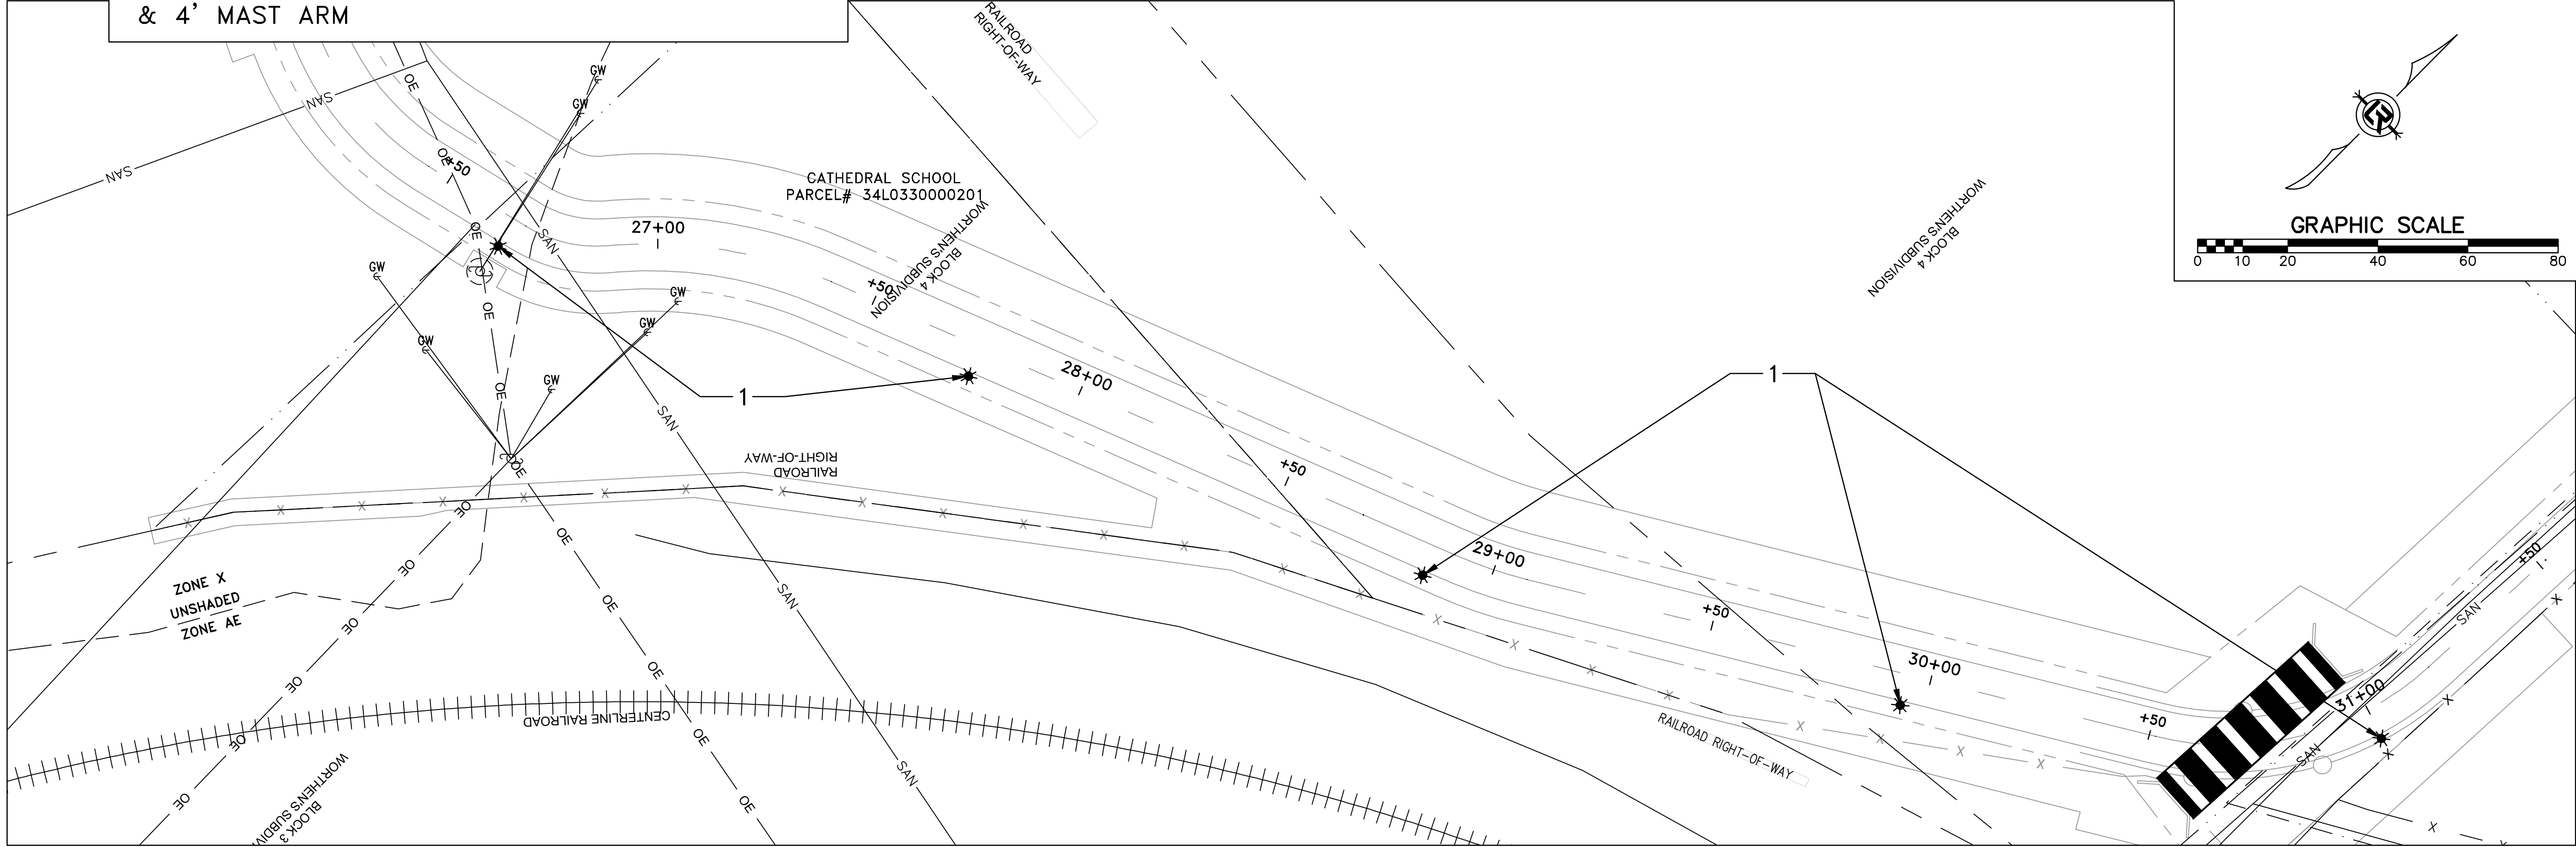

REVISIONS	DATE

CITY OF LITTLE ROCK, ARKANSAS

ROSE CREEK TRAIL

LIGHTING PLAN SHEET 3

DEPARTMENT OF PUBLIC WORKS

CIVIL ENGINEERING

701 W. MARKHAM

LITTLE ROCK, ARKANSAS 72201

STATE OF ARKANSAS

REGISTERED PROFESSIONAL ENGINEER

Bradley A. Peterson

No. 13217

9/3/26

DRAWN BY

AS

DESIGNED

LC

CHECKED

JM

DATE

05-01-2026

SCALE

H: 1"=20'


V: 1"=5'

PROJECT NO.

23805201


SHEET NO.

C48

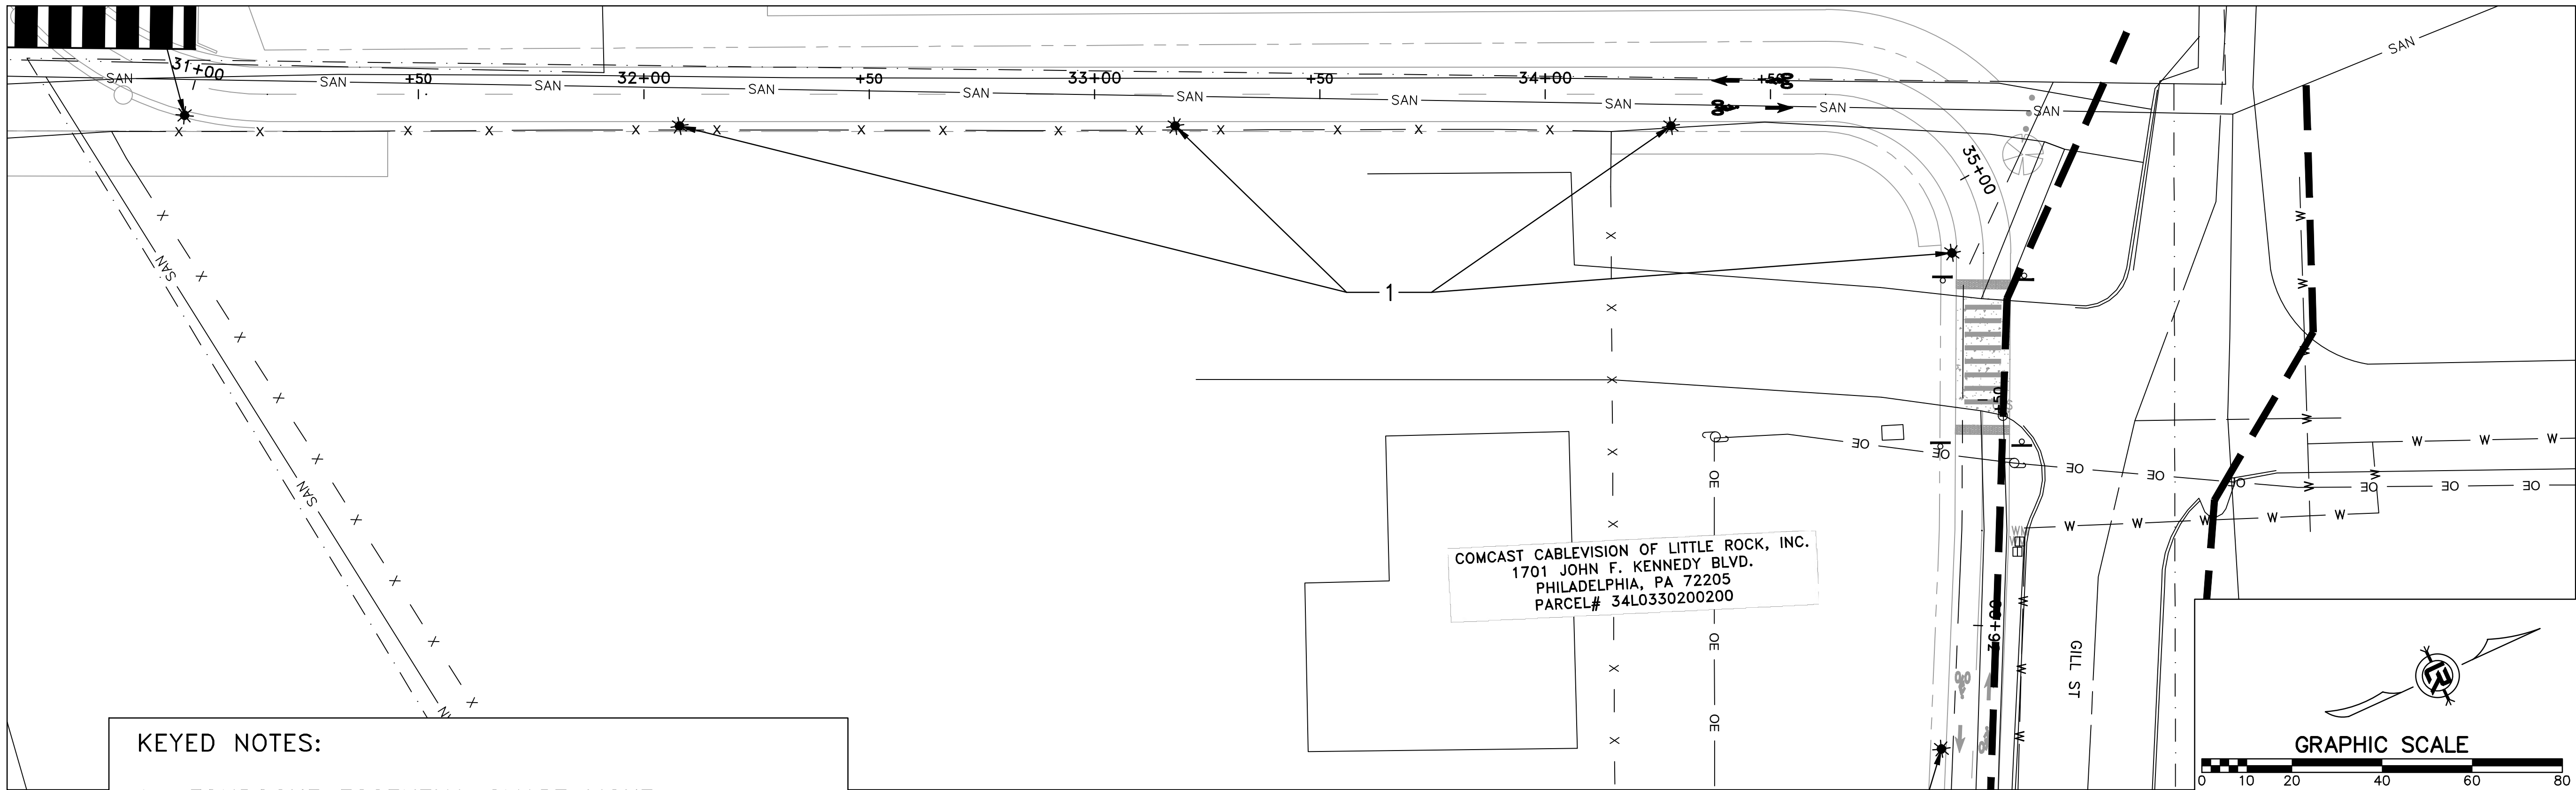

KEYED NOTES:

1= FONROCHE ESSENTIAL SMART LIGHT
[T54-CK16B-3K-GEN3] [P190F-2P]HW-MC-FIXTURE
W/ 14' ROUND-DIRECT BURIAL POLE
& 4' MAST ARM

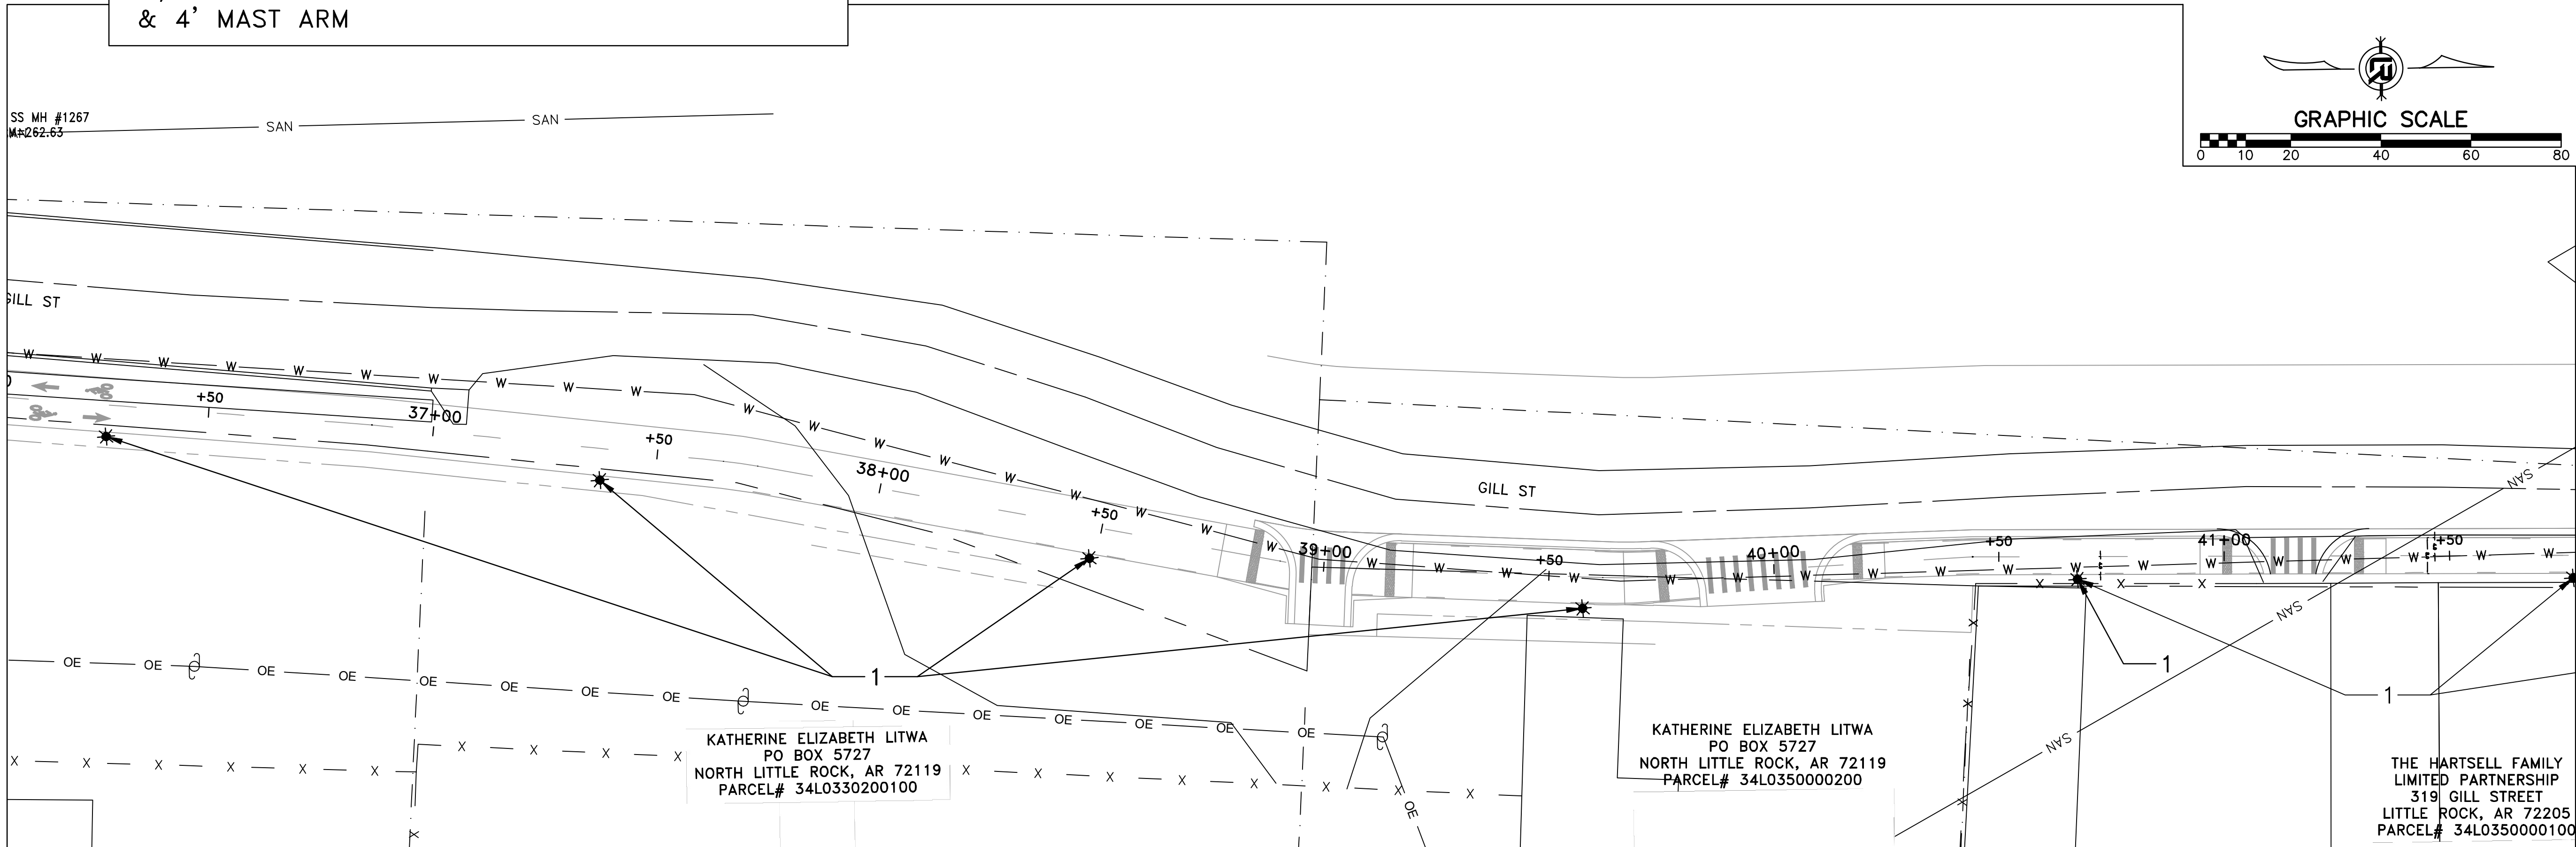

REVISIONS	DATE

CITY OF LITTLE ROCK, ARKANSAS

ROSE CREEK TRAIL

LIGHTING PLAN SHEET 4

DEPARTMENT OF PUBLIC WORKS

CIVIL ENGINEERING

701 W. MARKHAM

LITTLE ROCK, ARKANSAS 72201

STATE OF ARKANSAS

REGISTERED PROFESSIONAL ENGINEER

Bradley A. Peterson

No. 13217

9/3/26

DRAWN BY

AS

DESIGNED

LC

CHECKED

JM

DATE

05-01-2026

SCALE

H: 1"=20'


V: 1"=5'

PROJECT NO.

23805201

SHEET NO.










C49

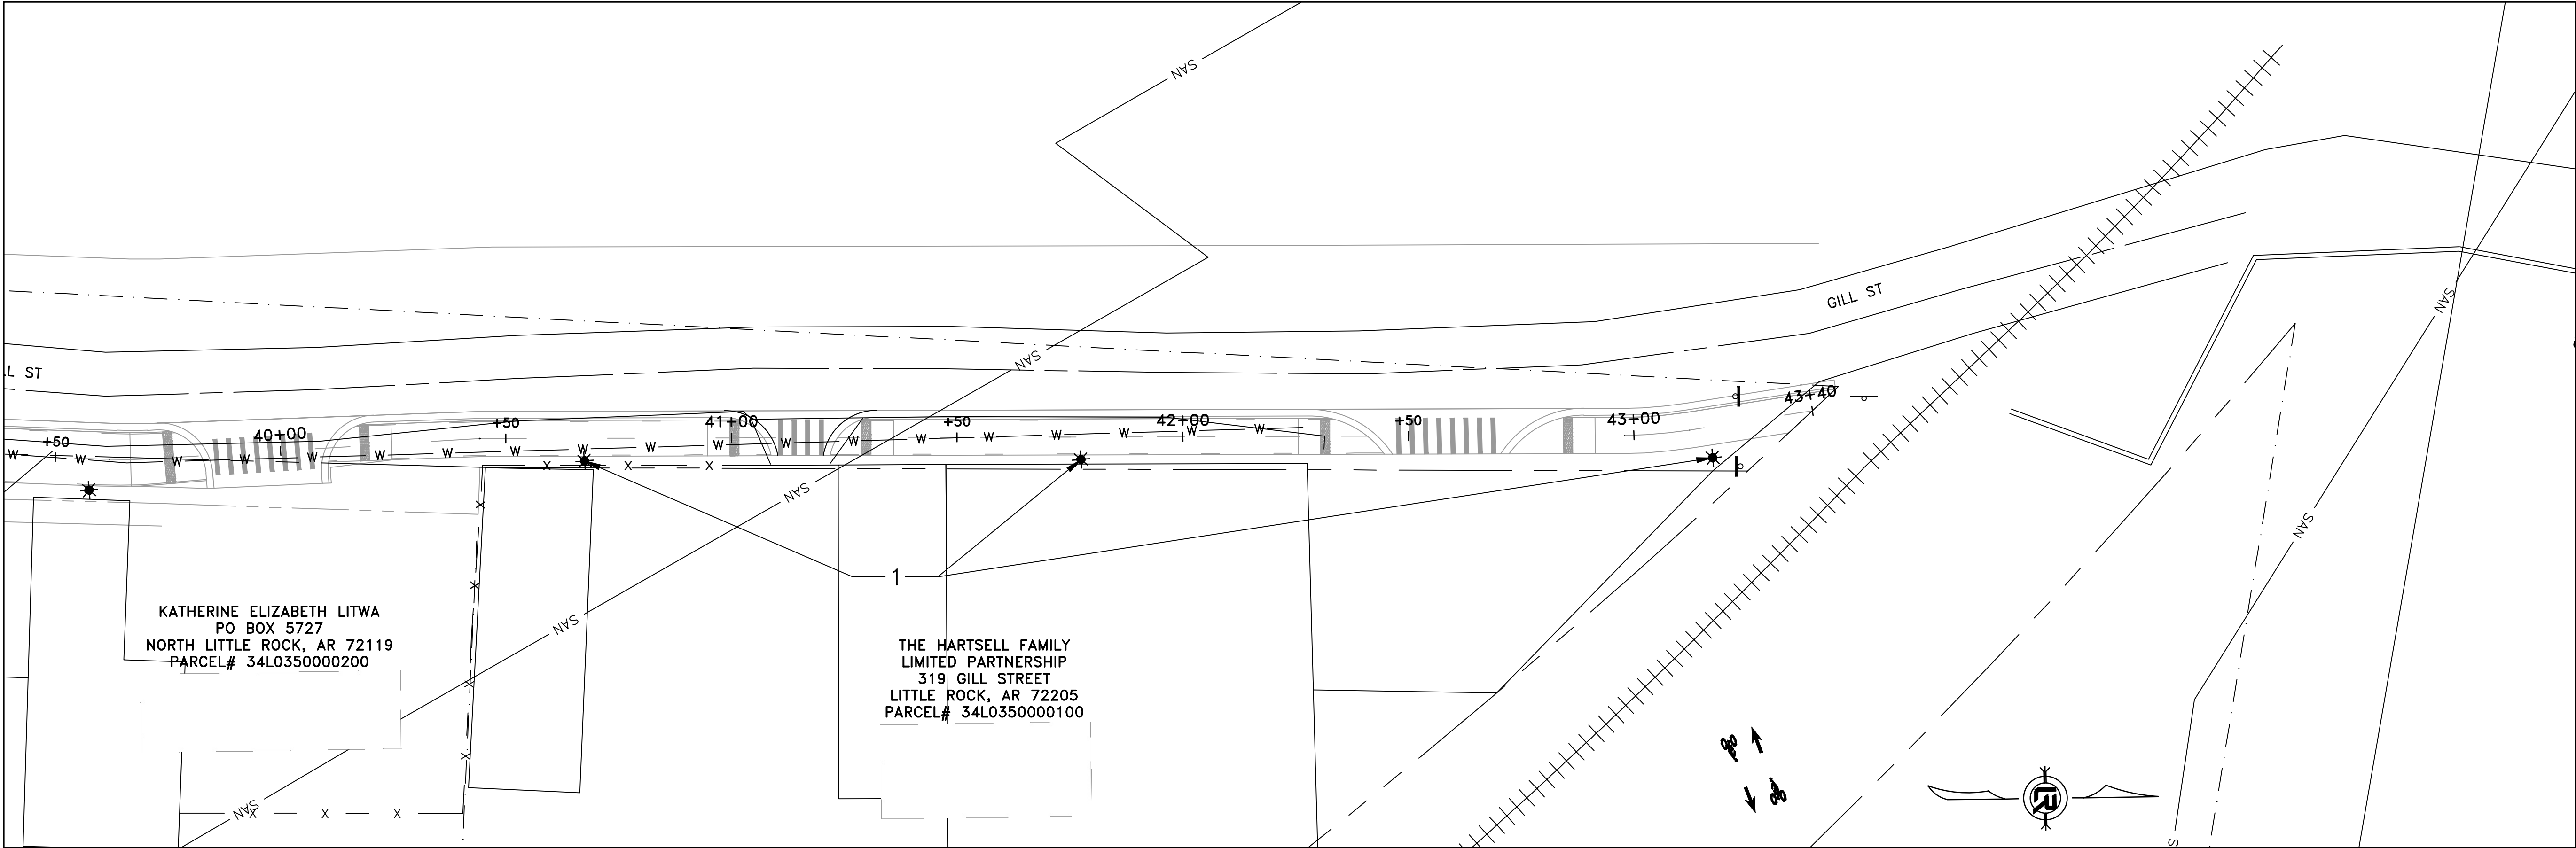

KEYED NOTES:

1= FONROCHE ESSENTIAL SMART LIGHT
[T54-CK16B-3K-GEN3] [P190F-2P]HW-MC-FIXTURE
W/ 14' ROUND-DIRECT BURIAL POLE
& 4' MAST ARM

100% SUBMITTAL

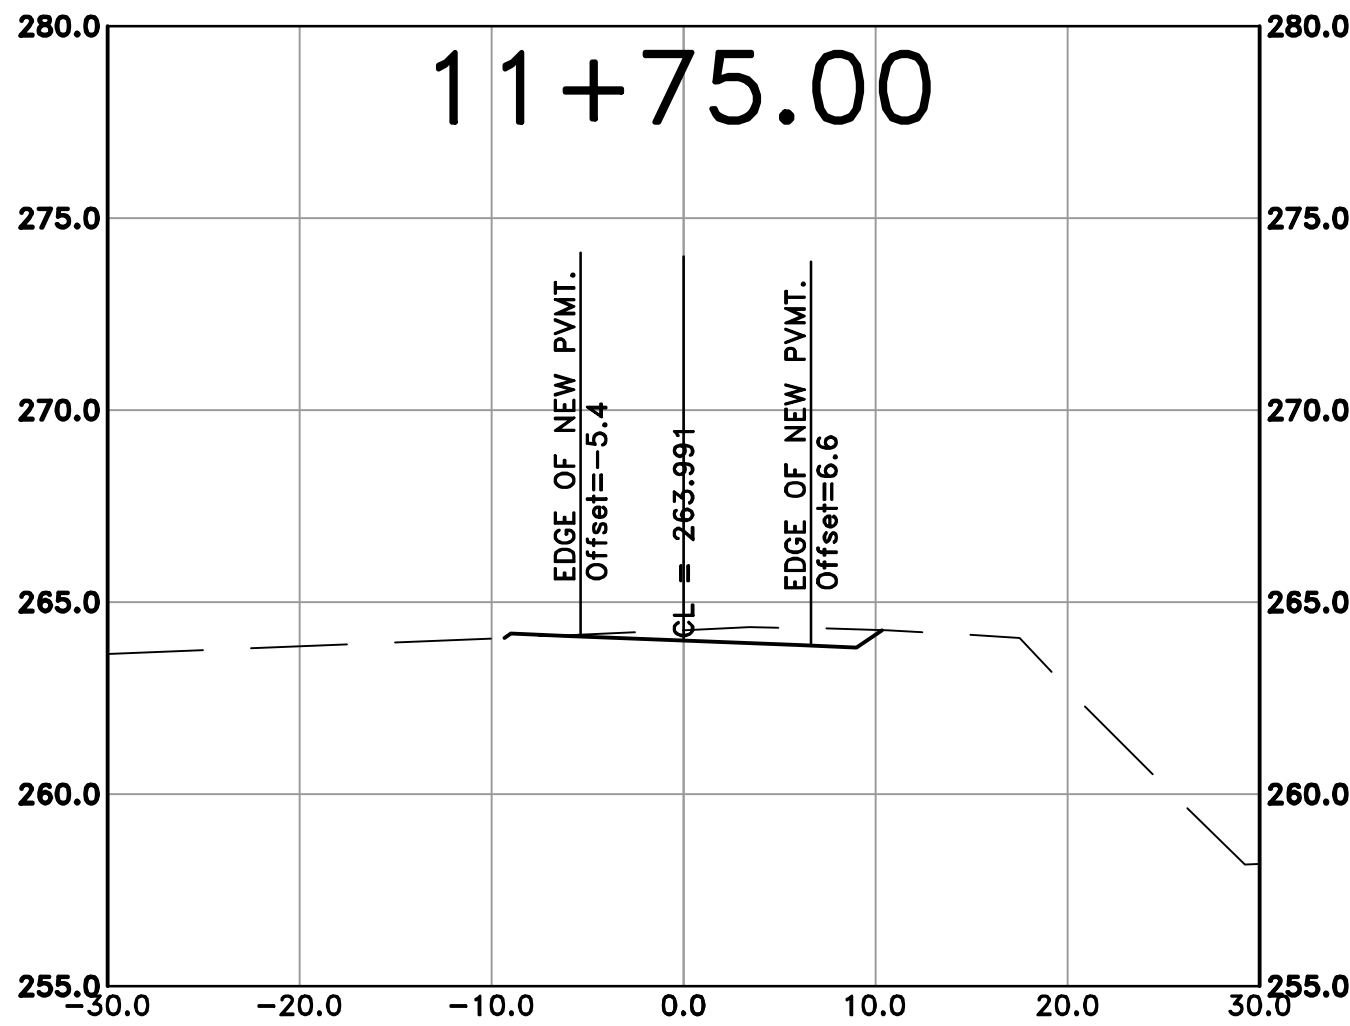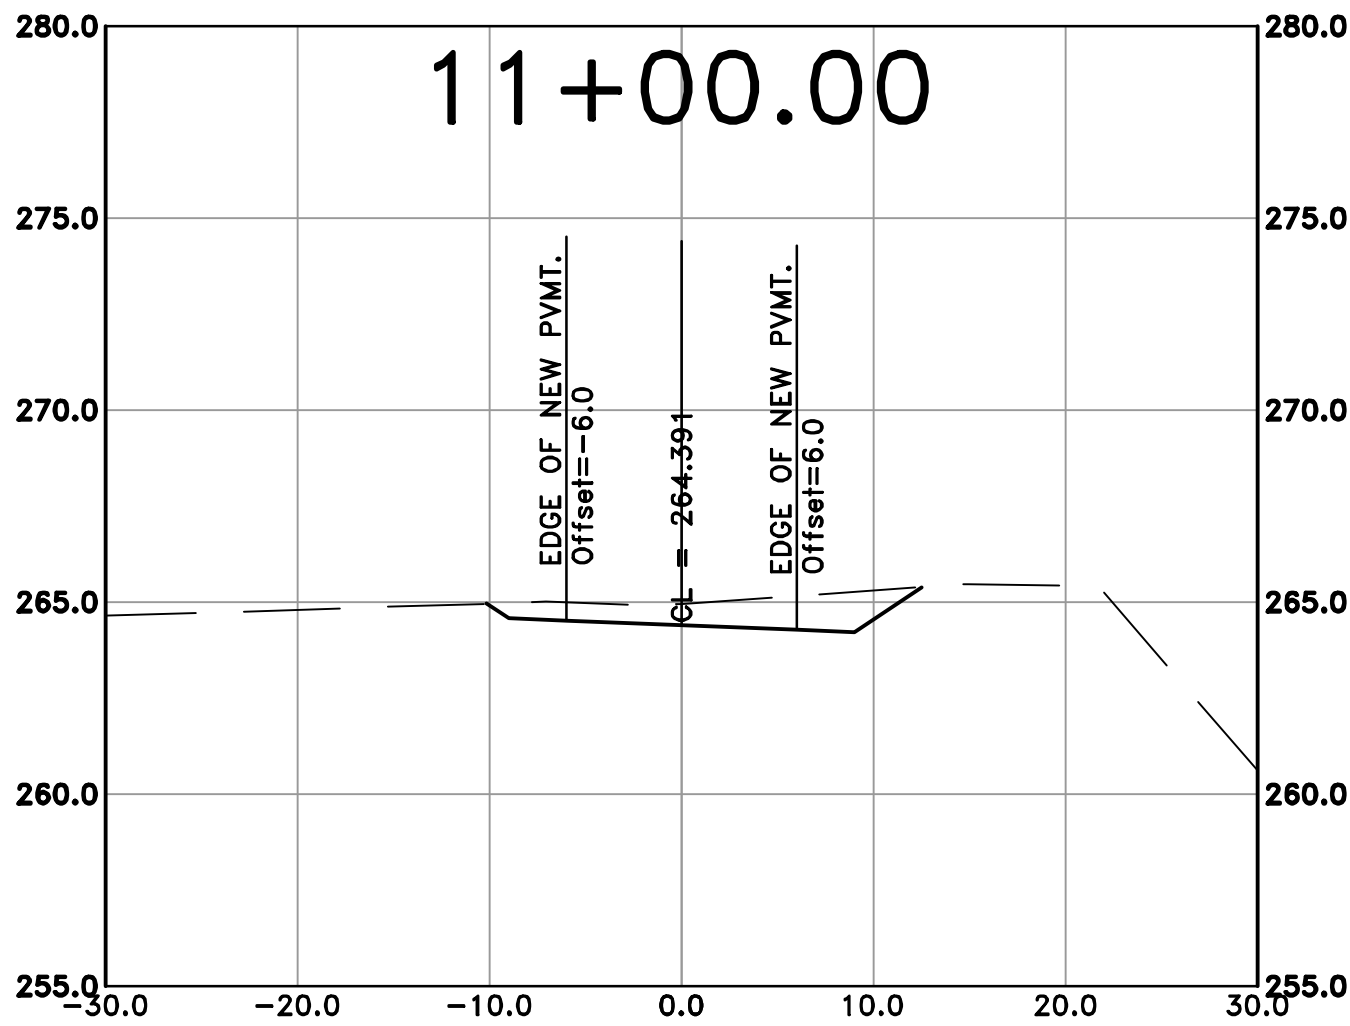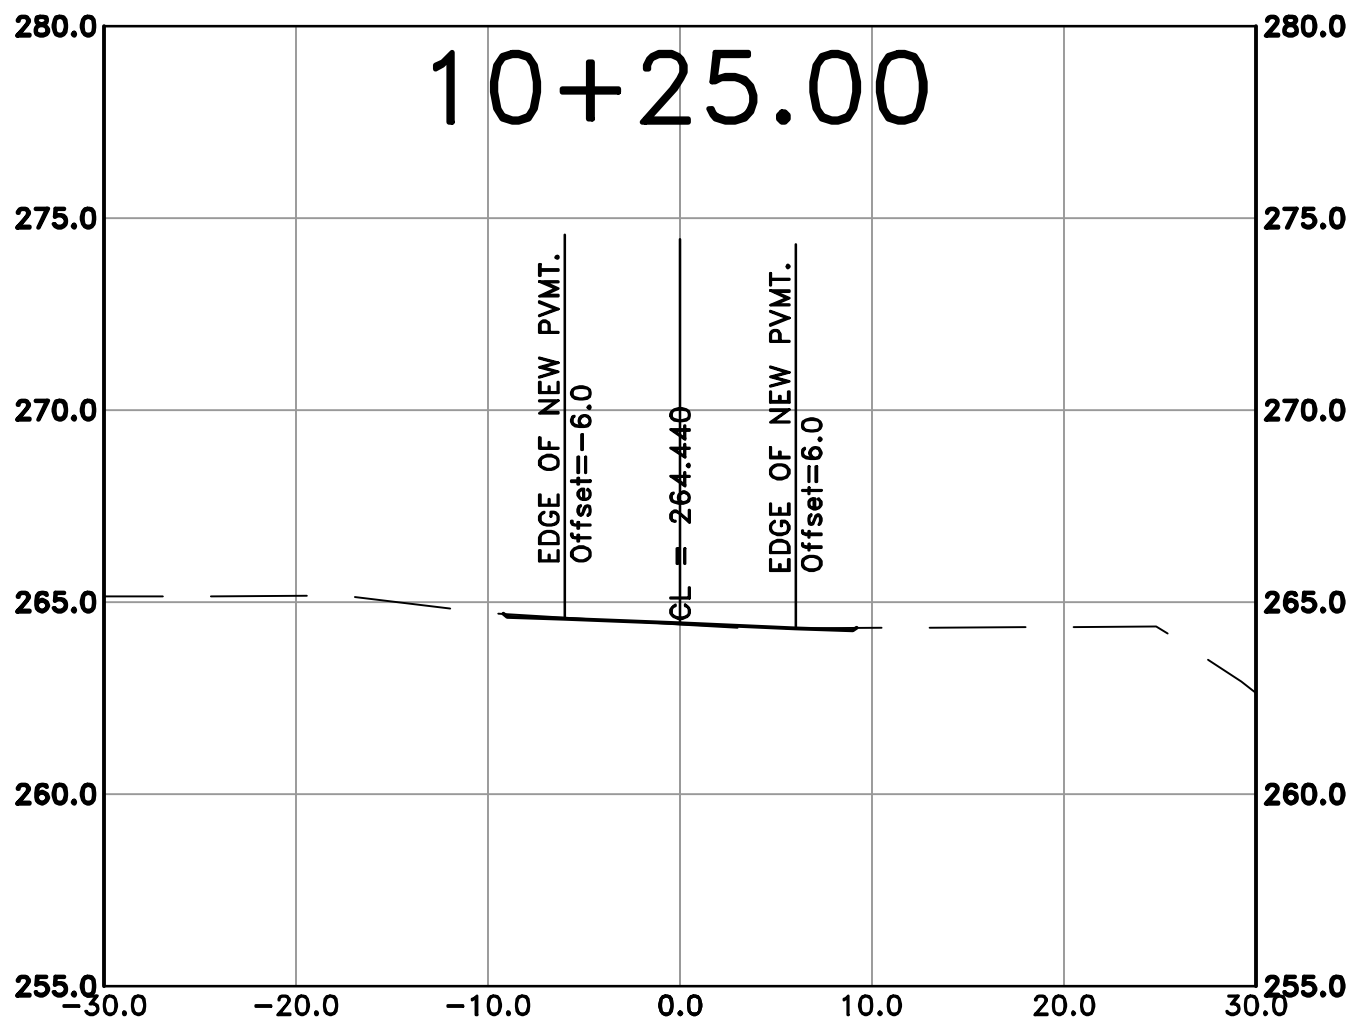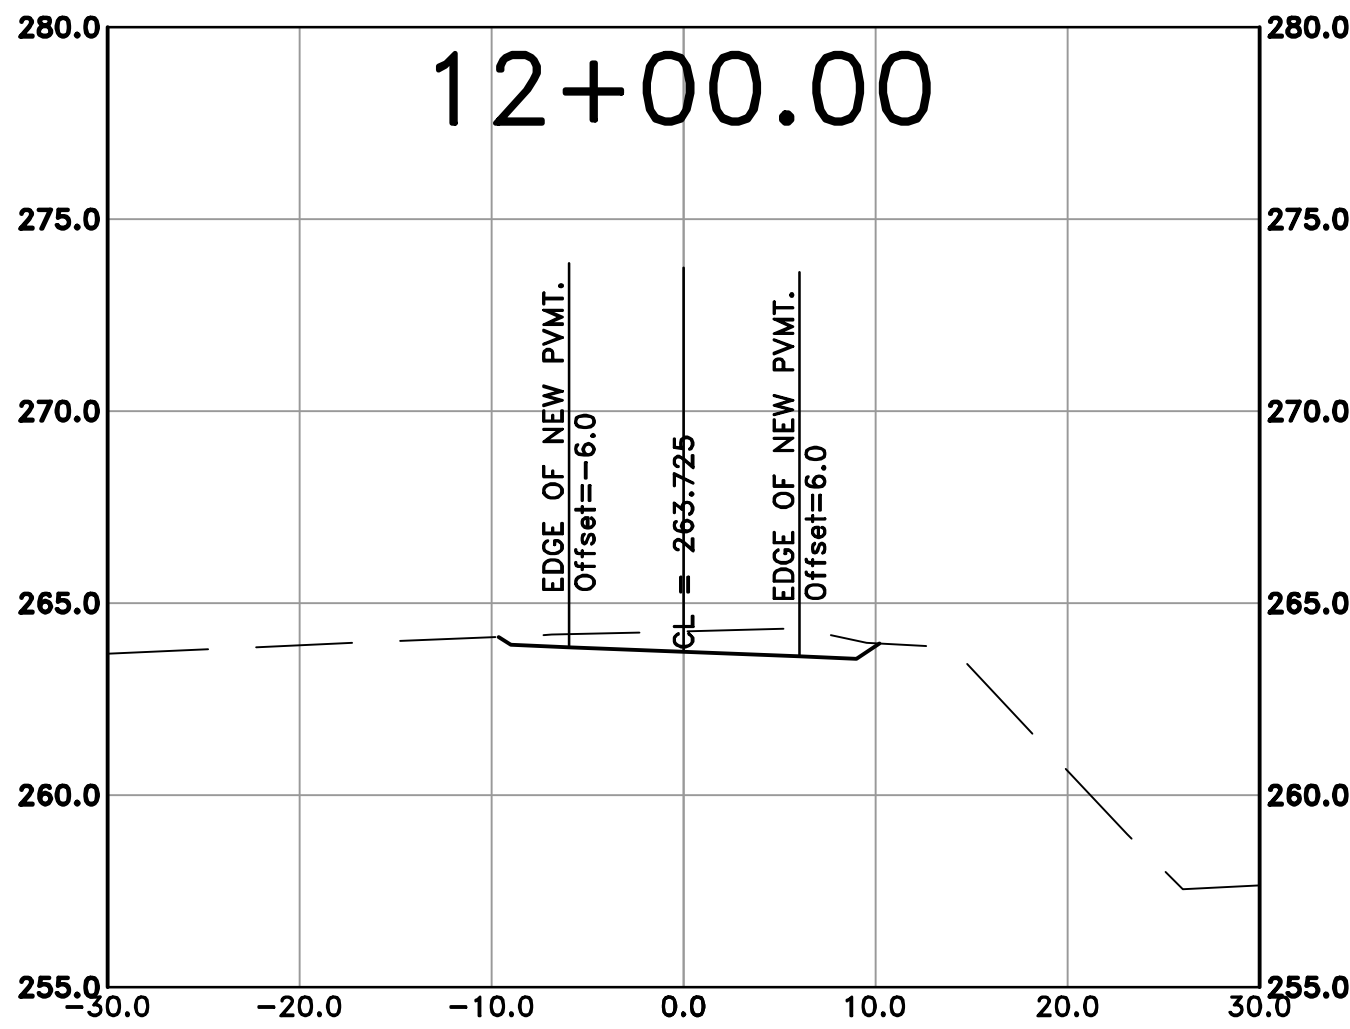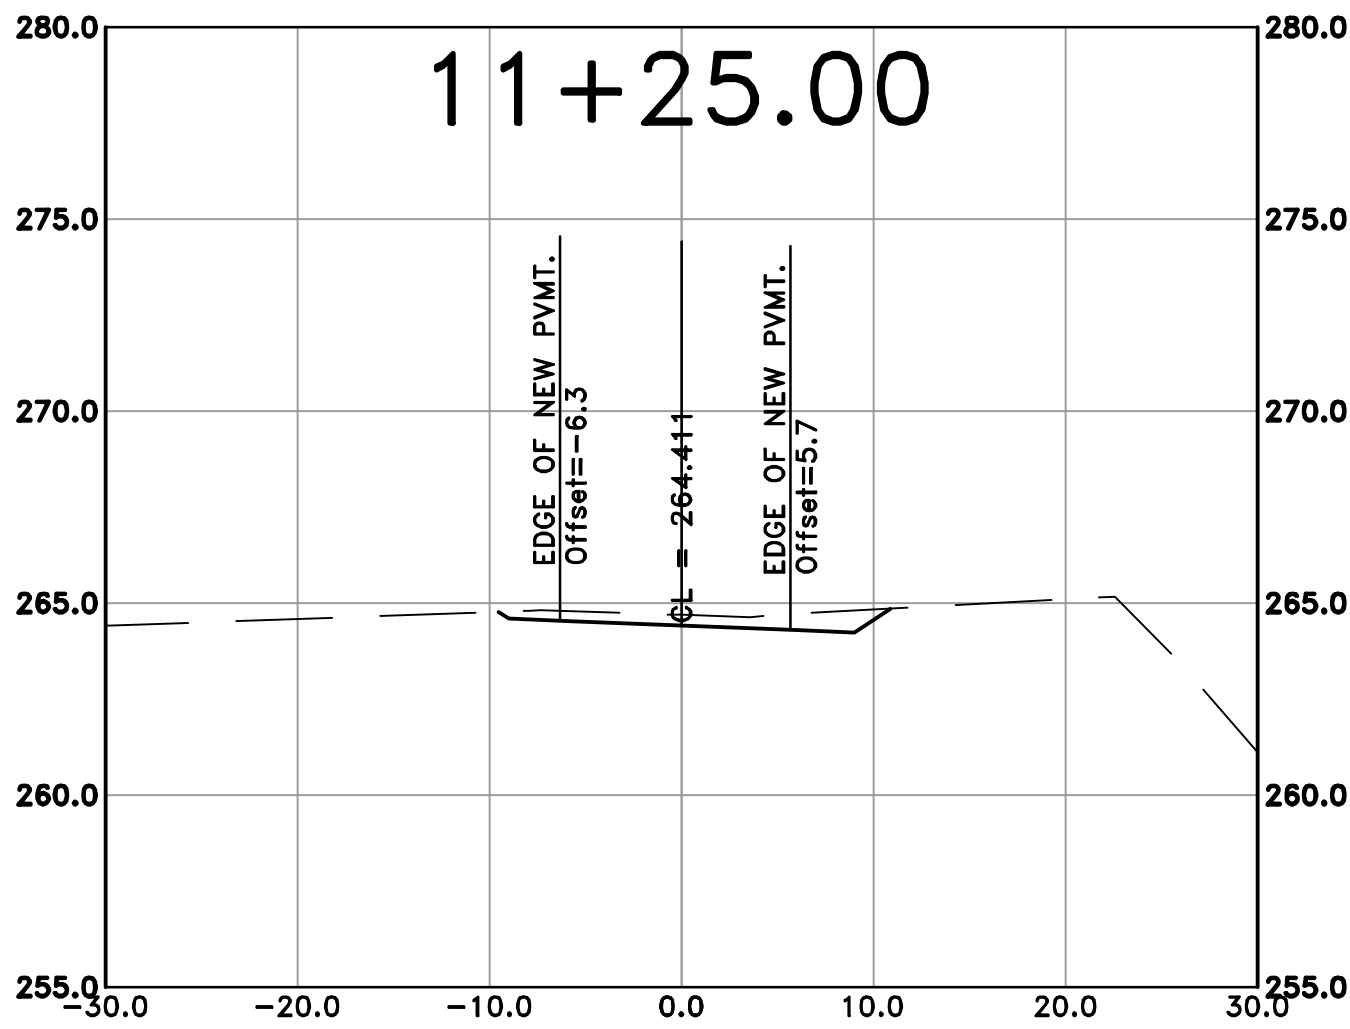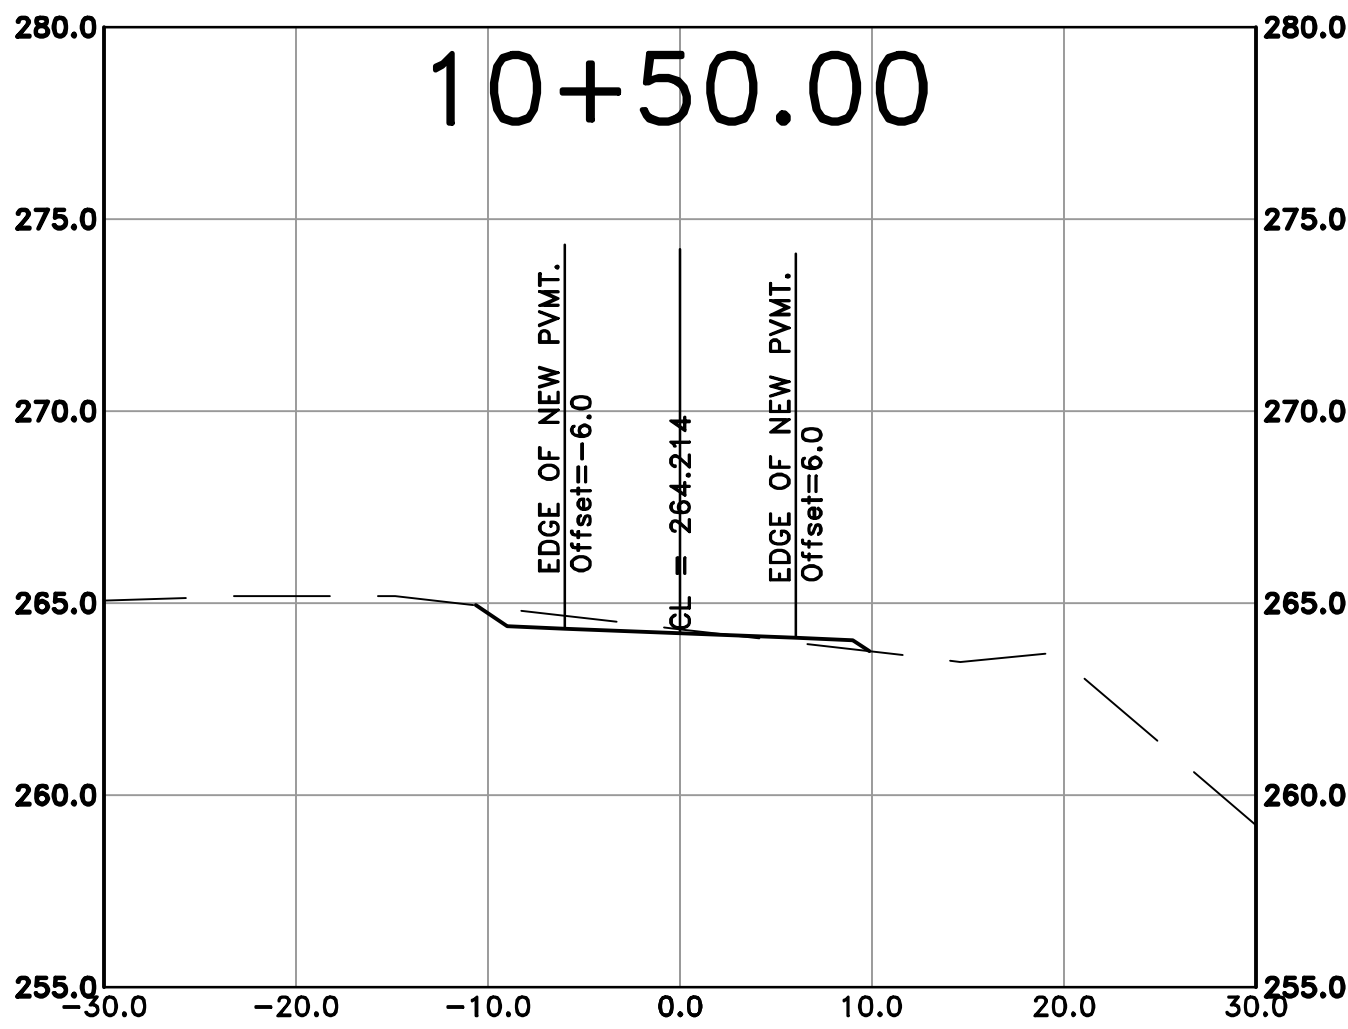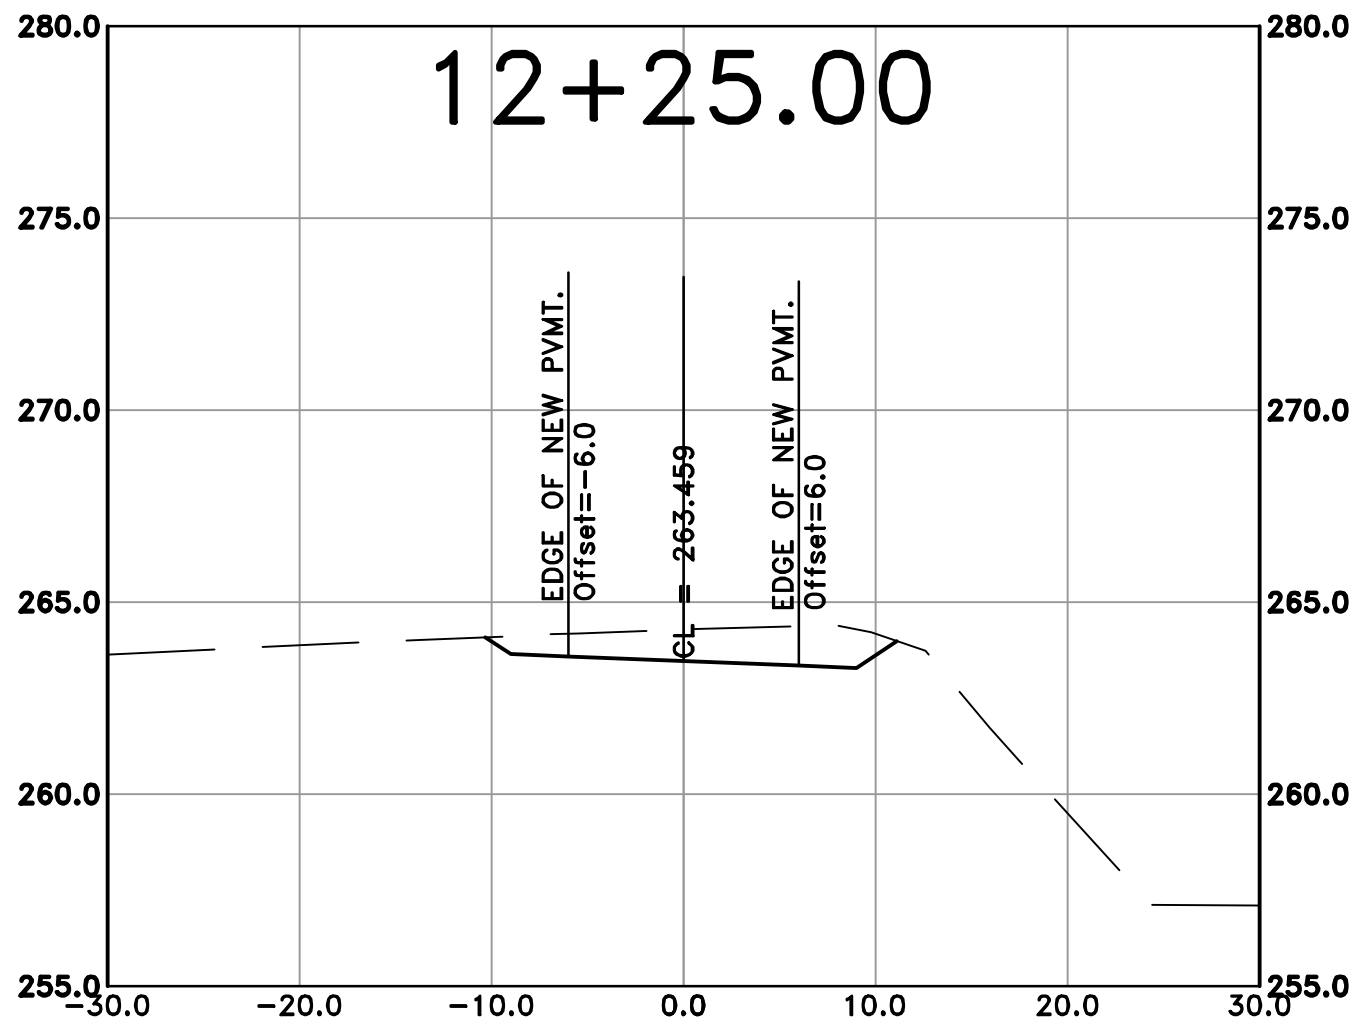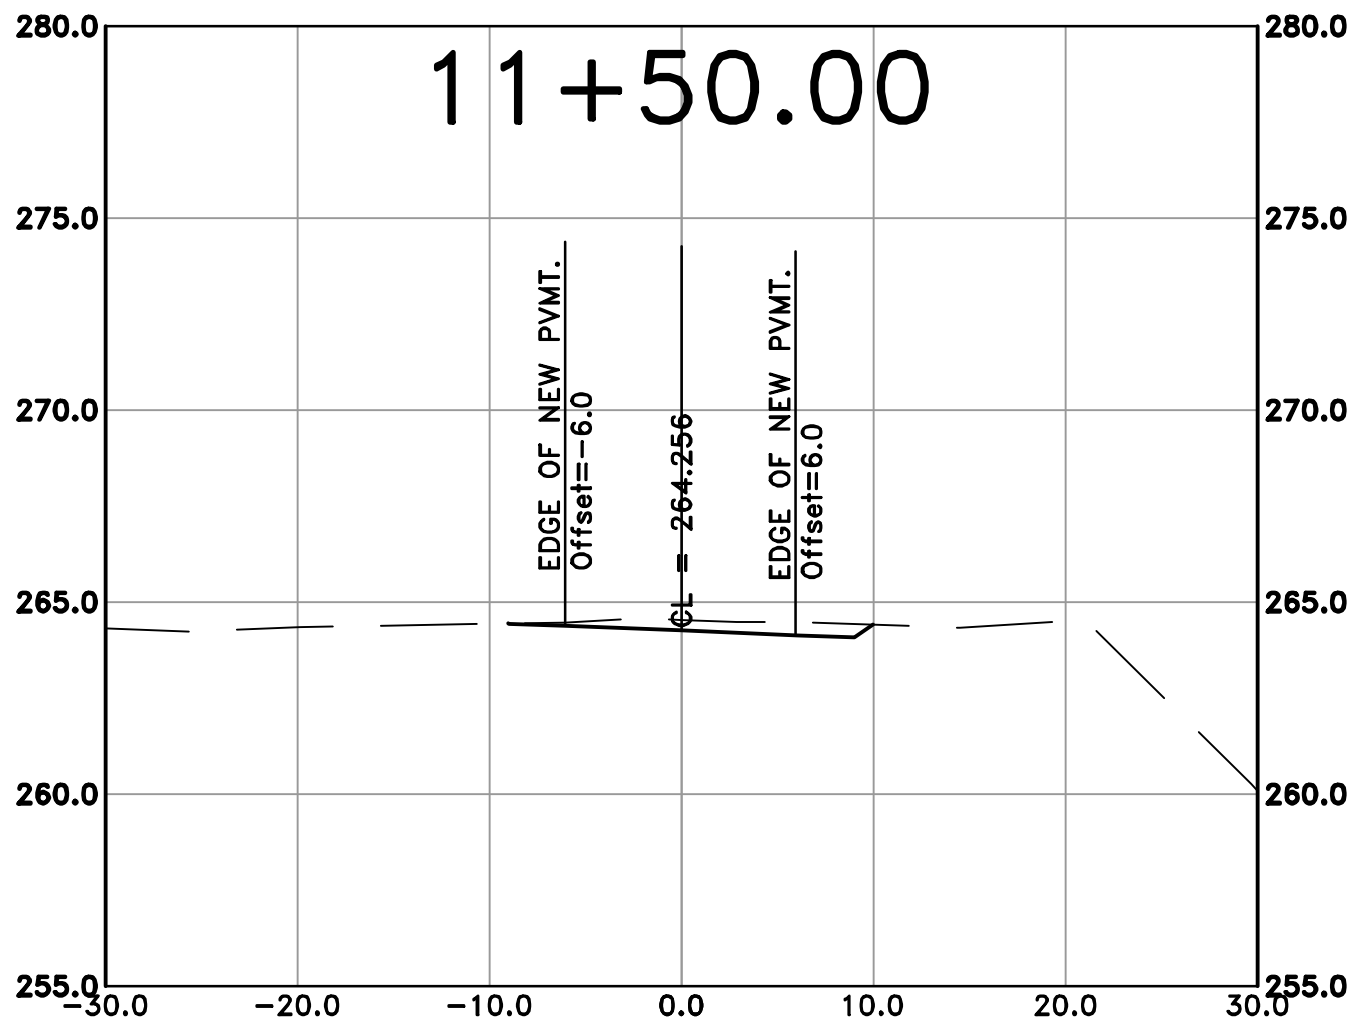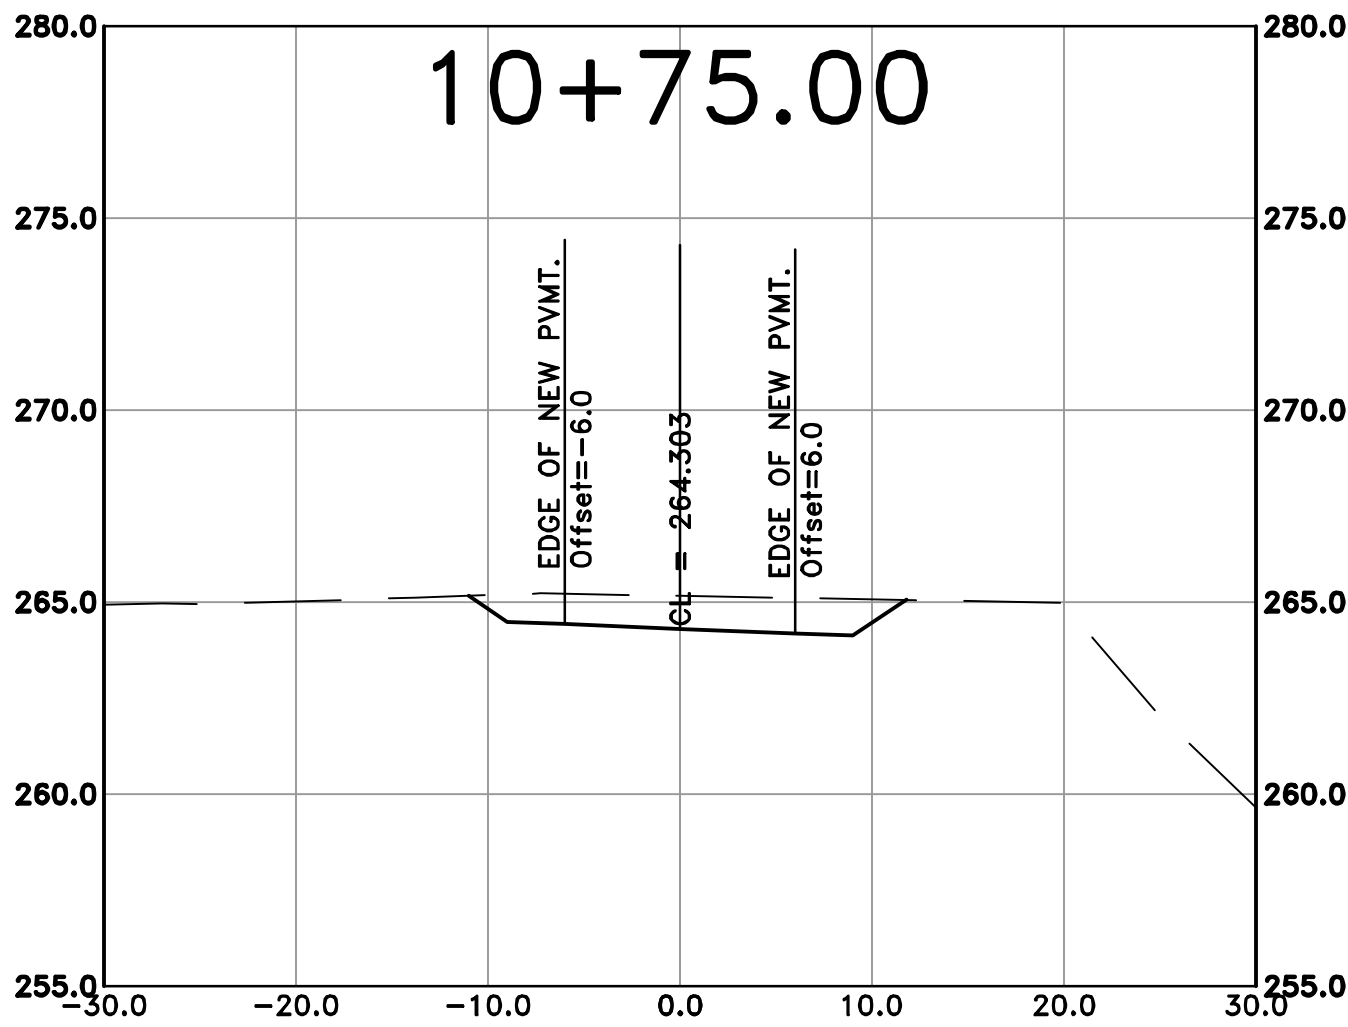

REVISIONS	DATE

CITY OF LITTLE ROCK, ARKANSAS

ROSE CREEK TRAIL

CROSS SECTION SHEET 1

DEPARTMENT OF PUBLIC WORKS

CIVIL ENGINEERING

701 W. MARKHAM

LITTLE ROCK, ARKANSAS 72201

STATE OF ARKANSAS

REGISTERED PROFESSIONAL ENGINEER

BRADLEY A. PETERSON

No. 13217

9/3/26

DRAWN BY

AS

DESIGNED

LC

CHECKED

JM

DATE

05-01-2026

SCALE

H: 1"=40'

V: 1"=10'










PROJECT NO.

23805201

SHEET NO.

C50

100% SUBMITTAL

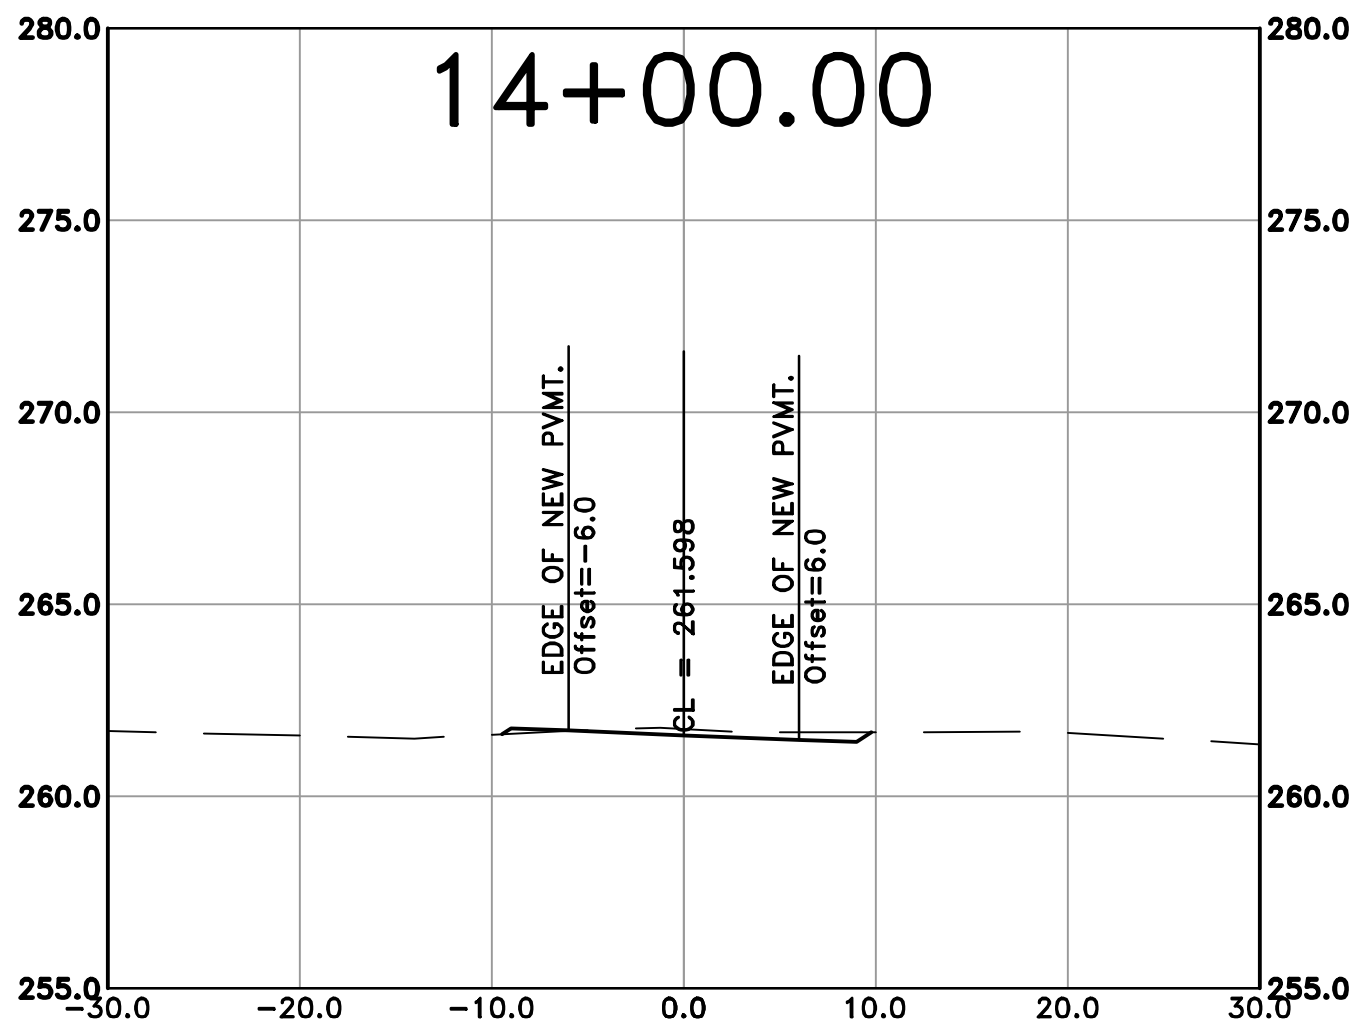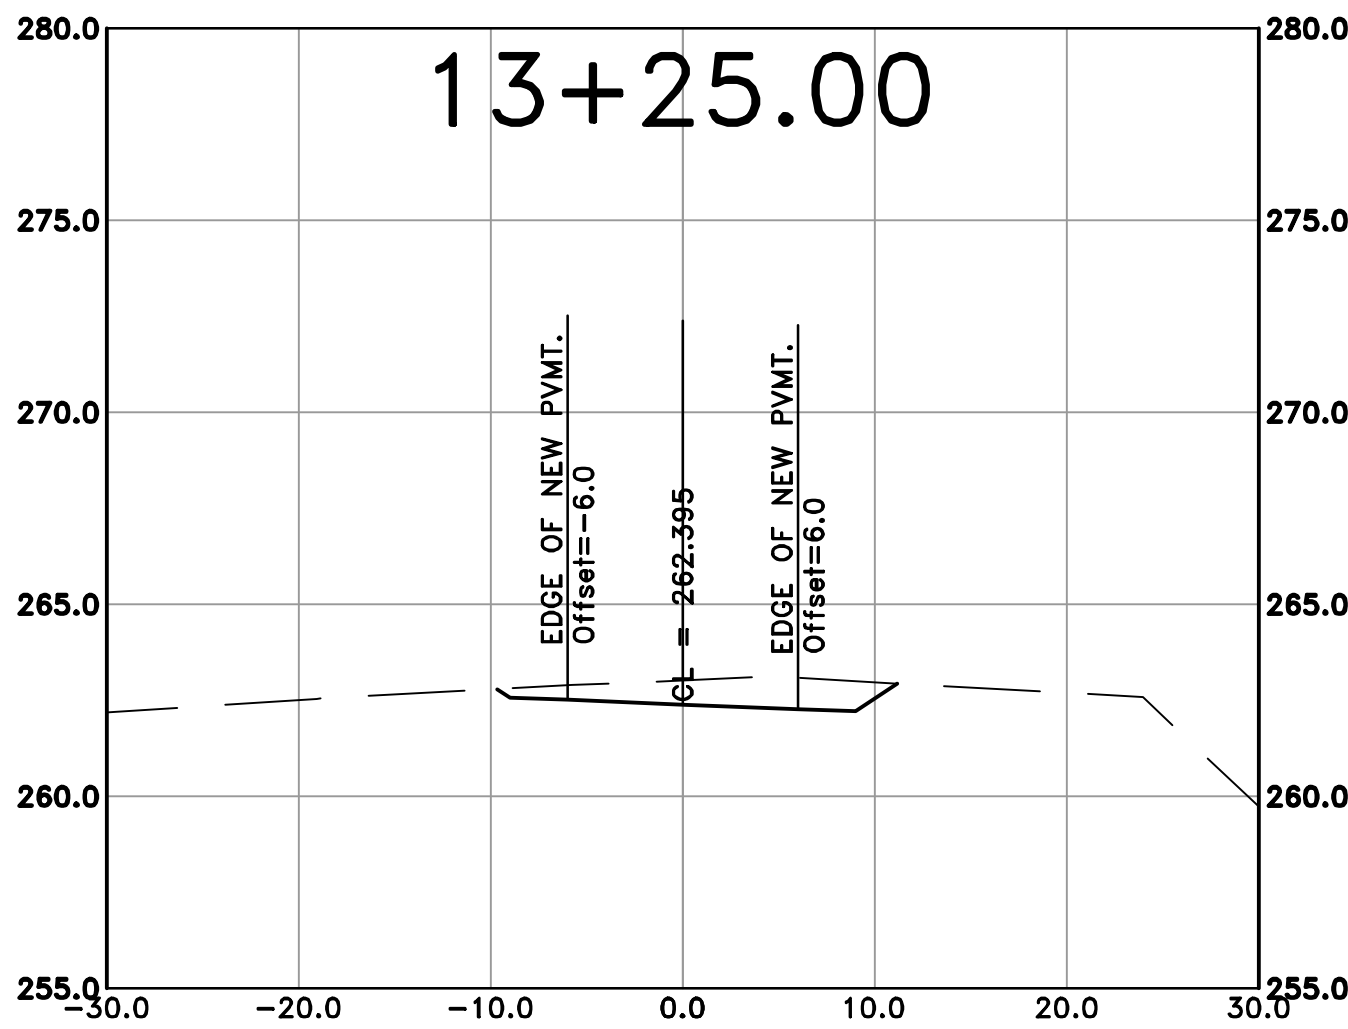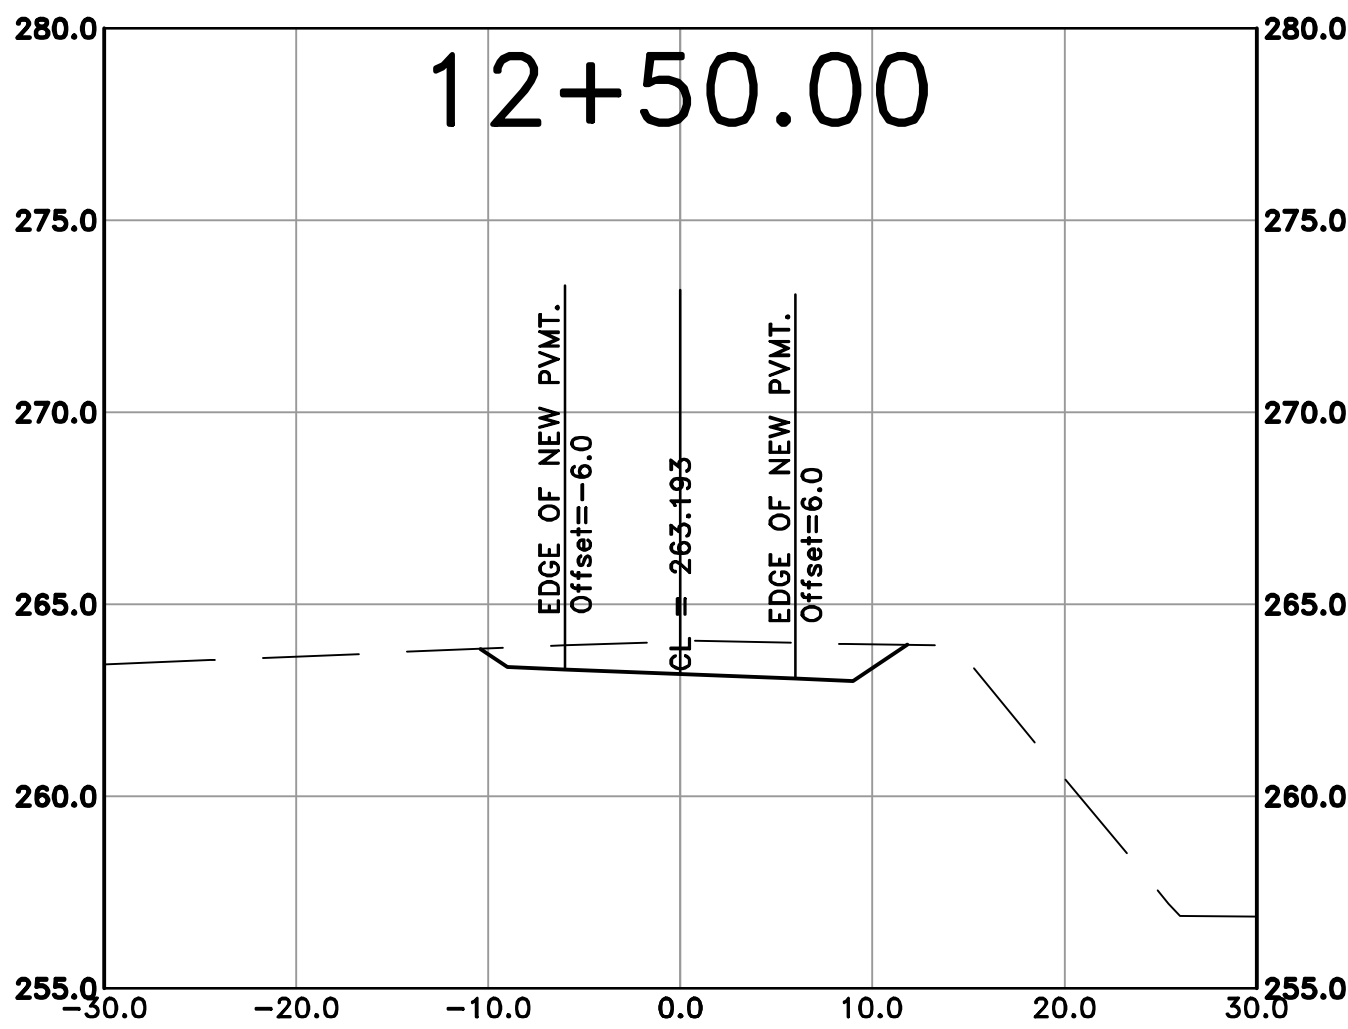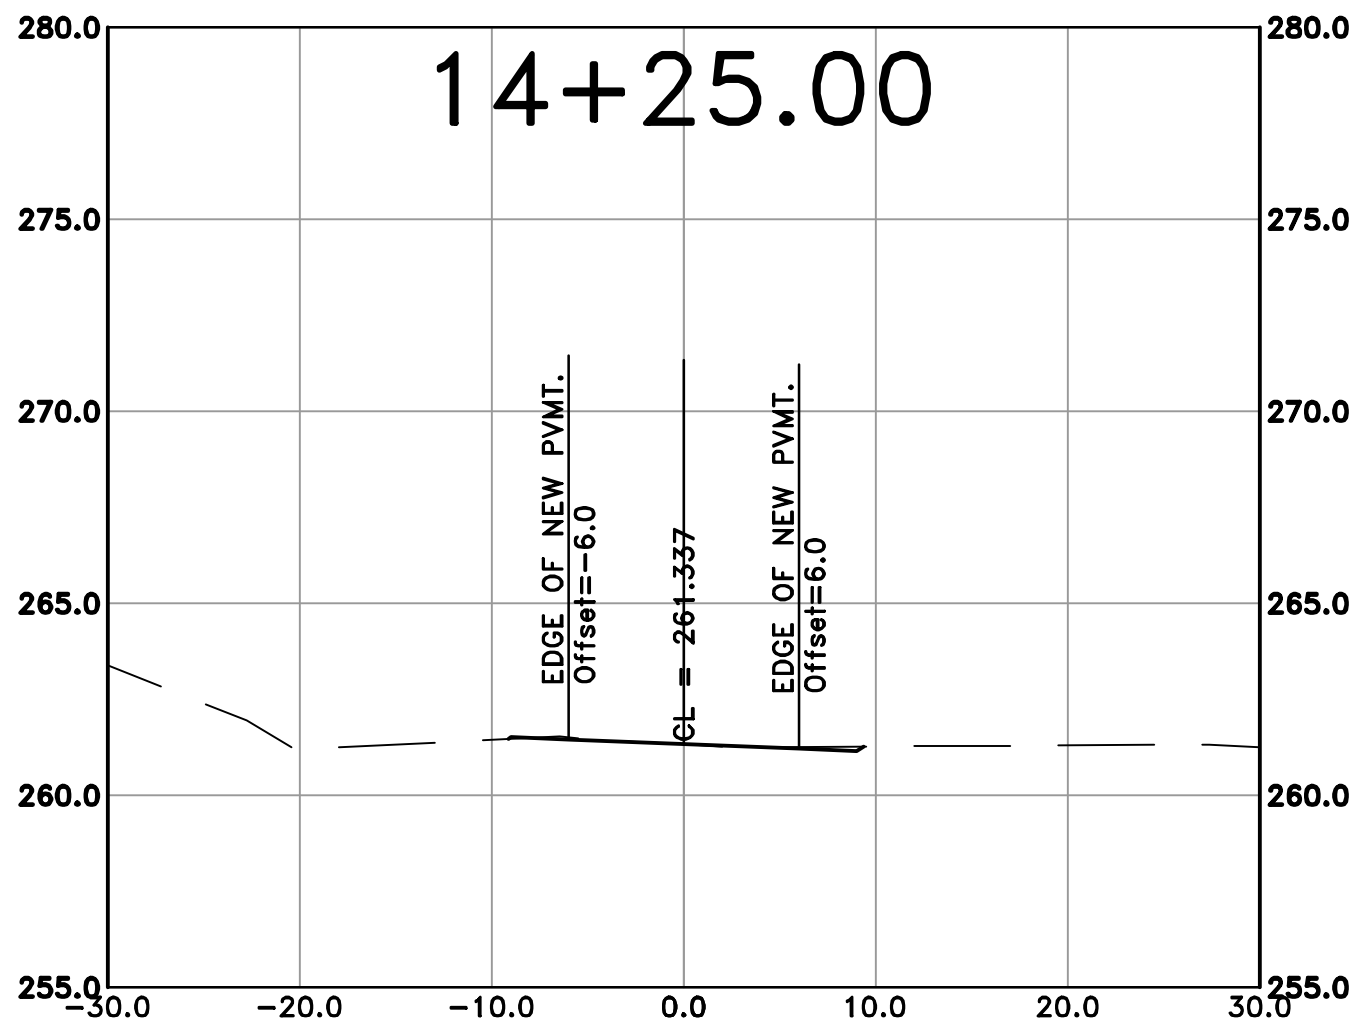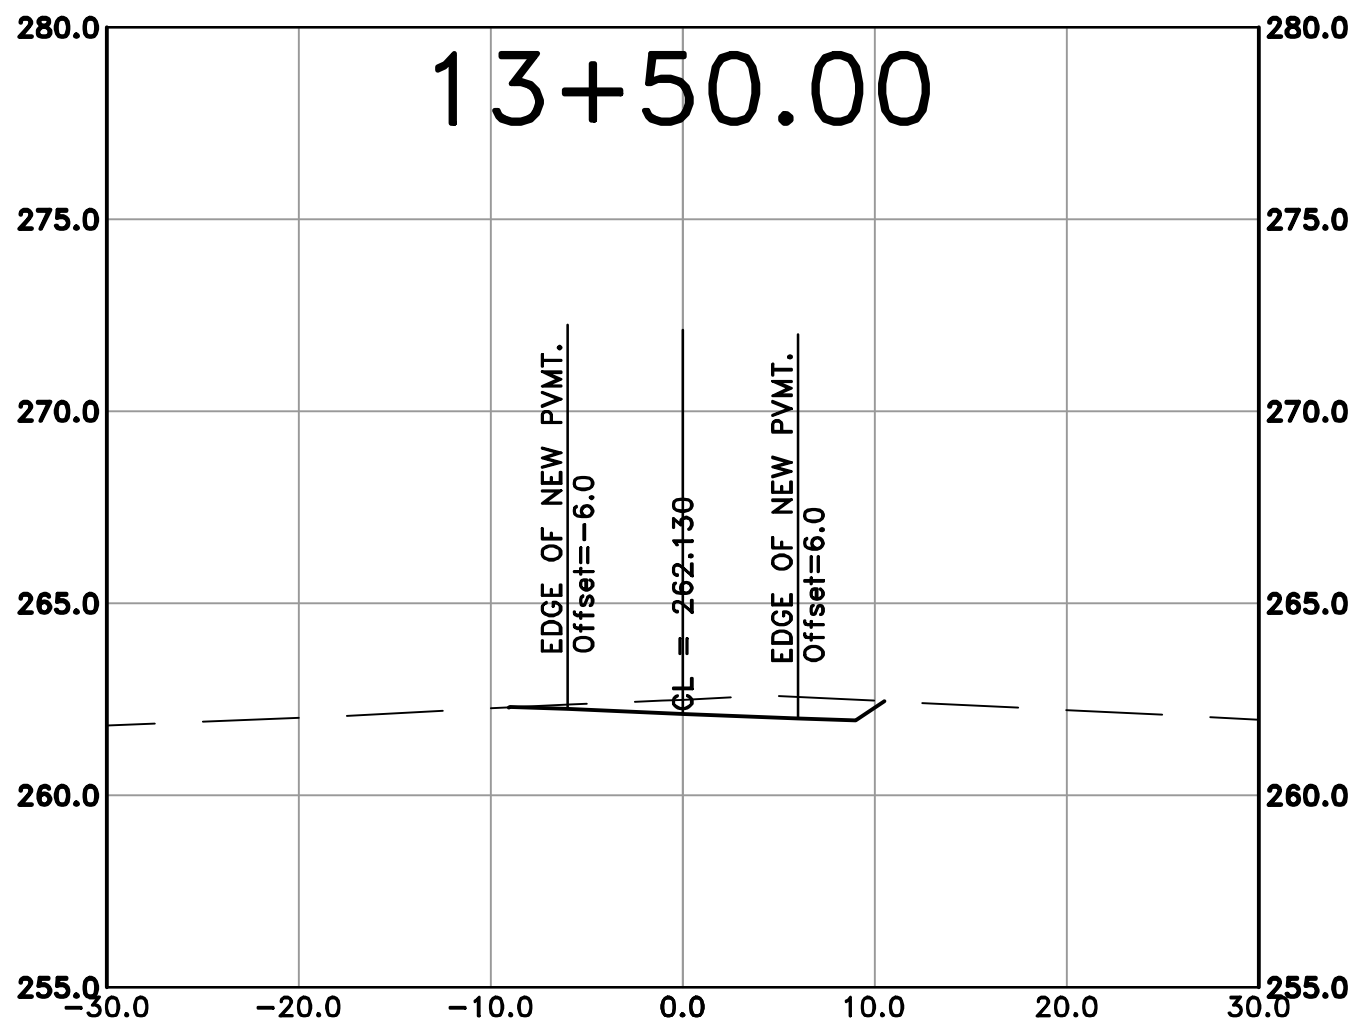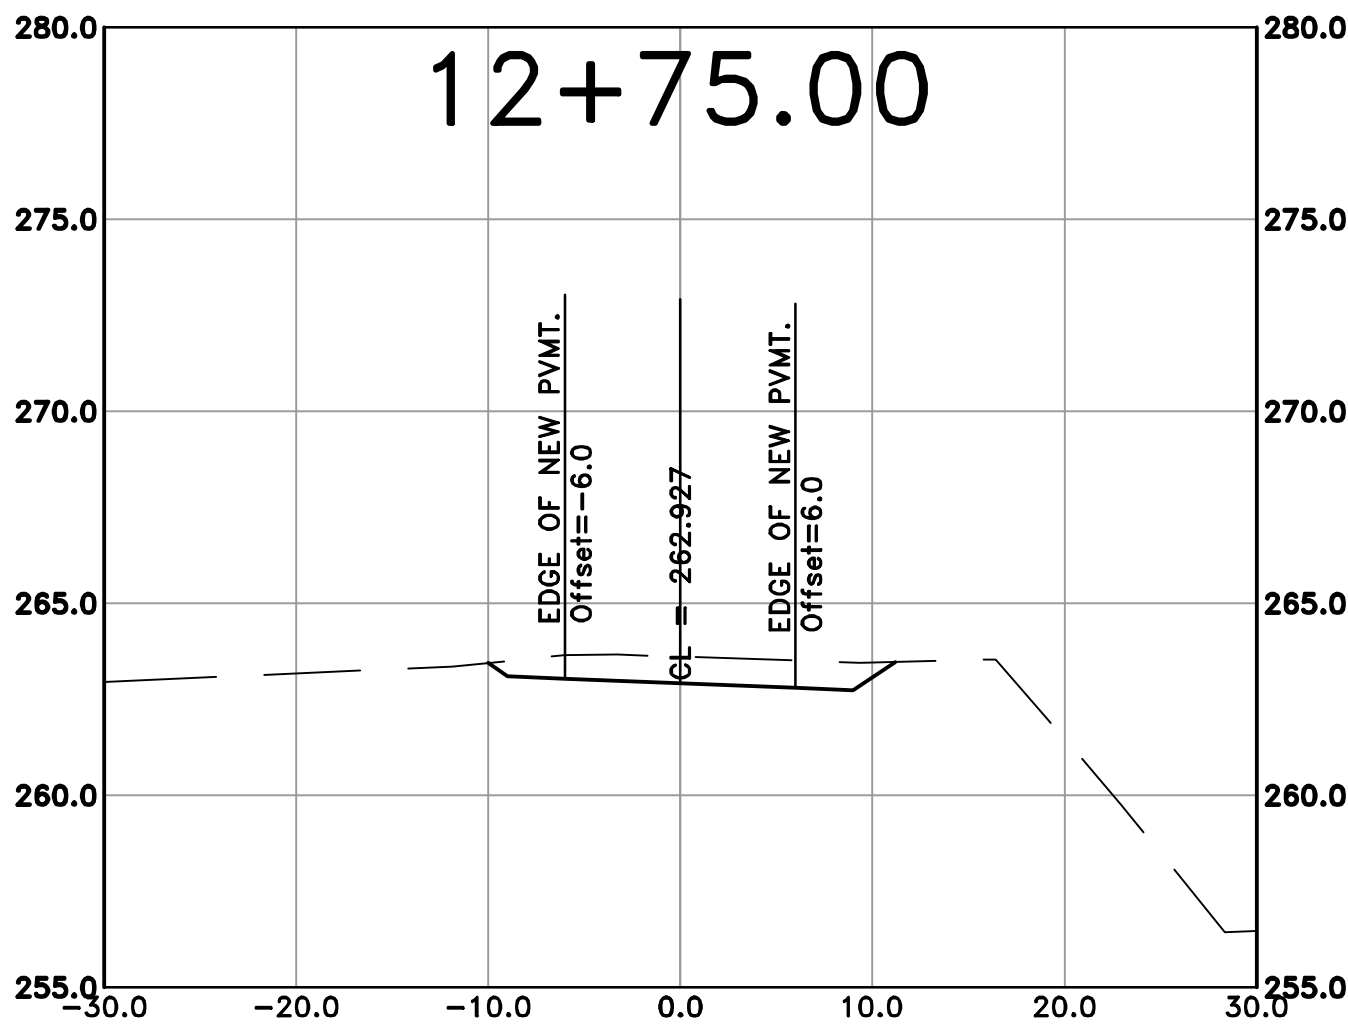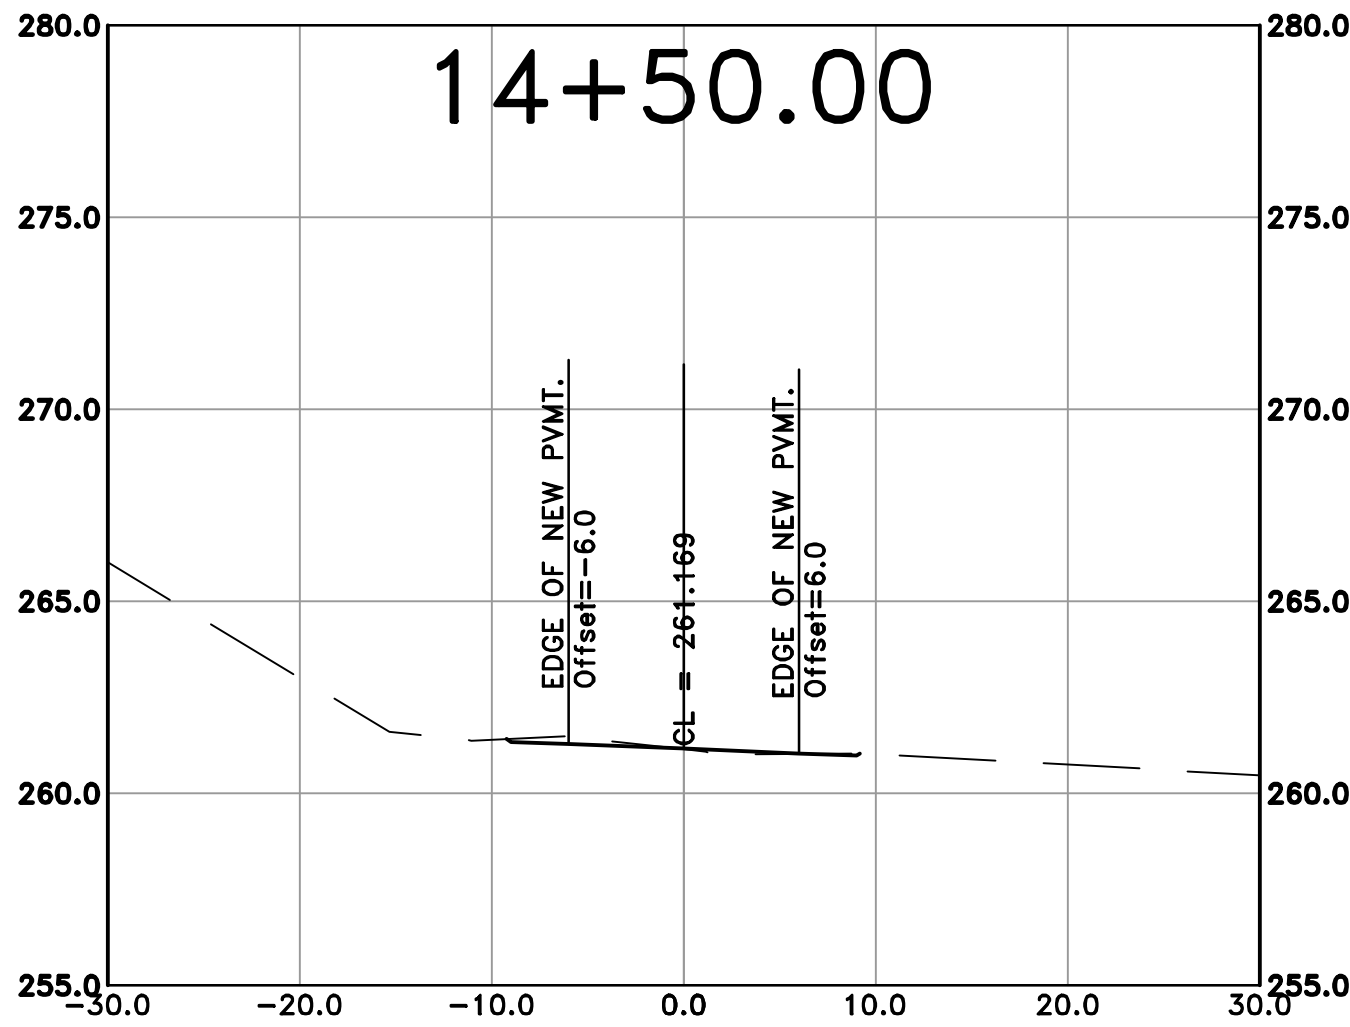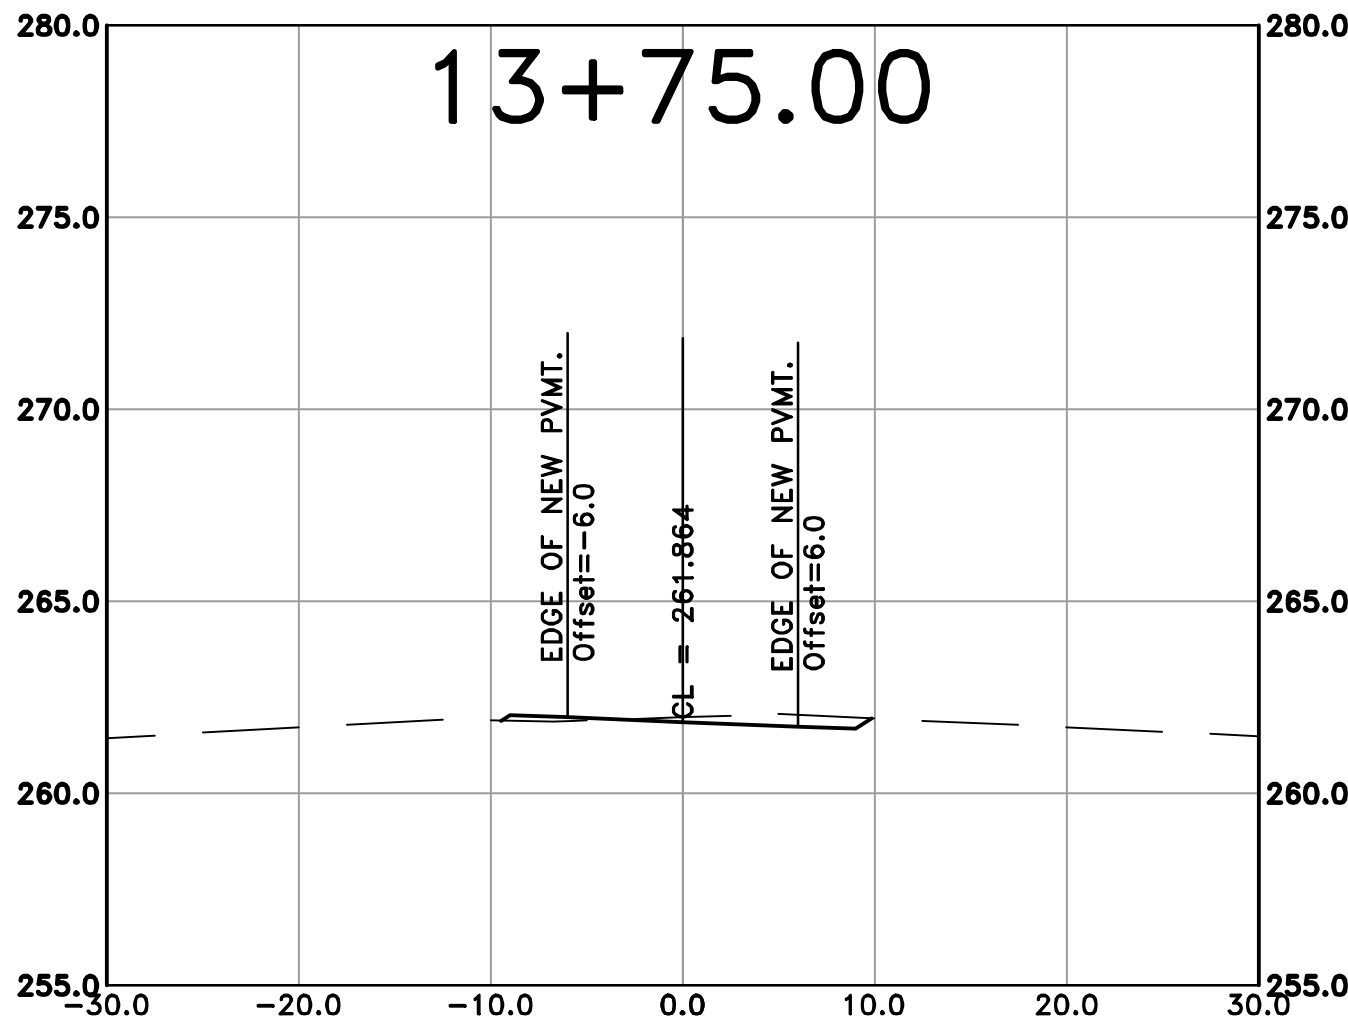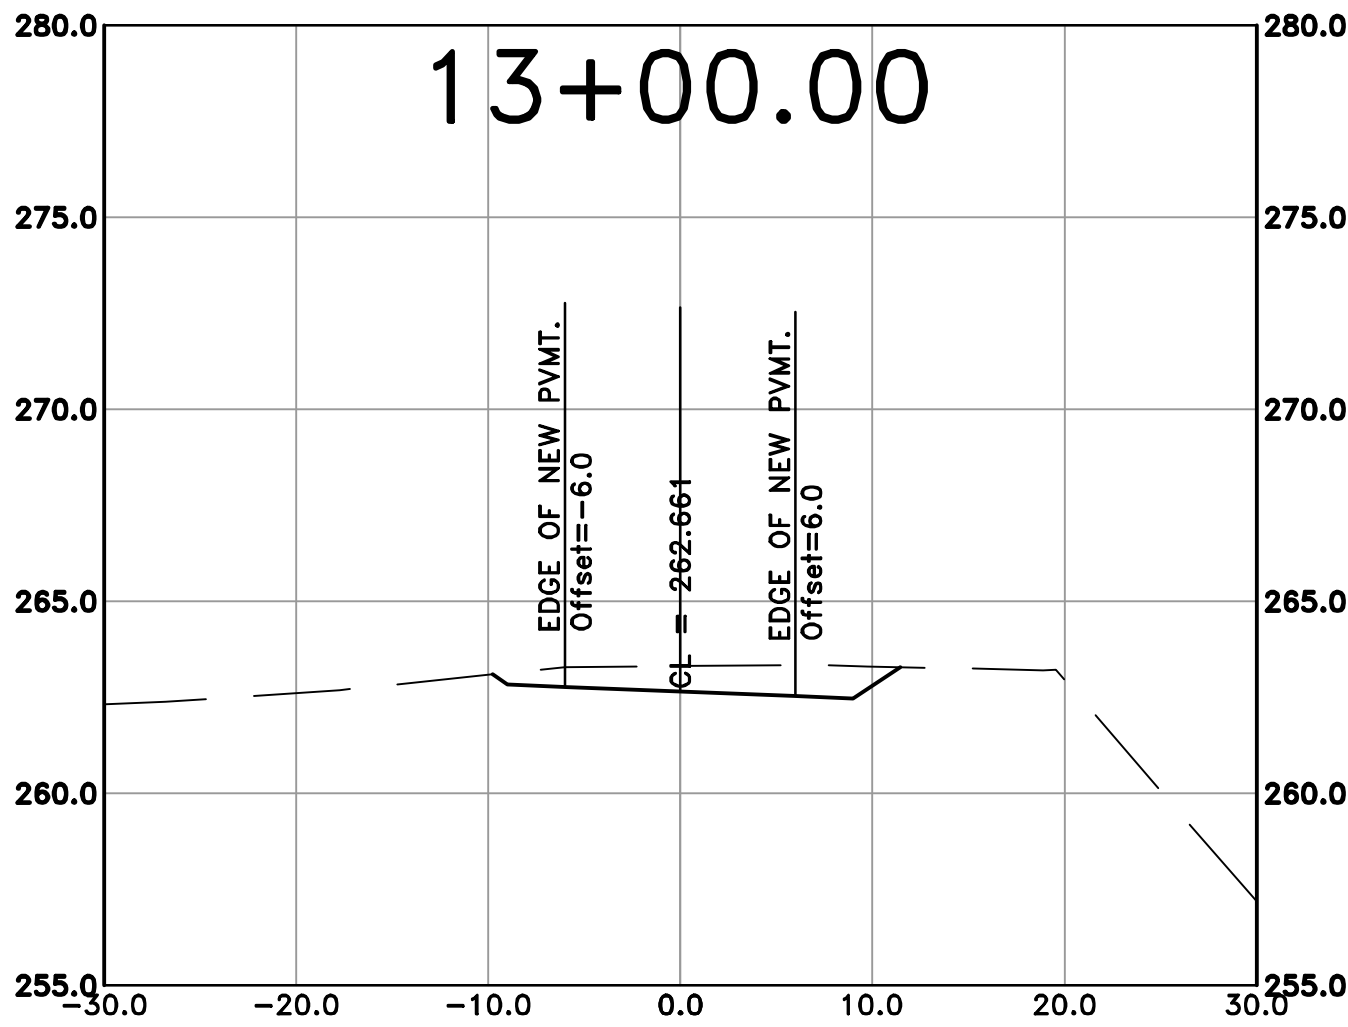

REVISIONS	DATE










CITY OF LITTLE ROCK, ARKANSAS
ROSE CREEK TRAIL
CROSS SECTION SHEET 2

DEPARTMENT OF PUBLIC WORKS
CIVIL ENGINEERING
701 W. MARKHAM
LITTLE ROCK, ARKANSAS 72201



DRAWN BY	AS
DESIGNED	LC
CHECKED	JM
DATE	05-01-2026
SCALE	H: 1"=40' V: 1"=10'
PROJECT NO.	23805201
SHEET NO.	C51

100% SUBMITTAL

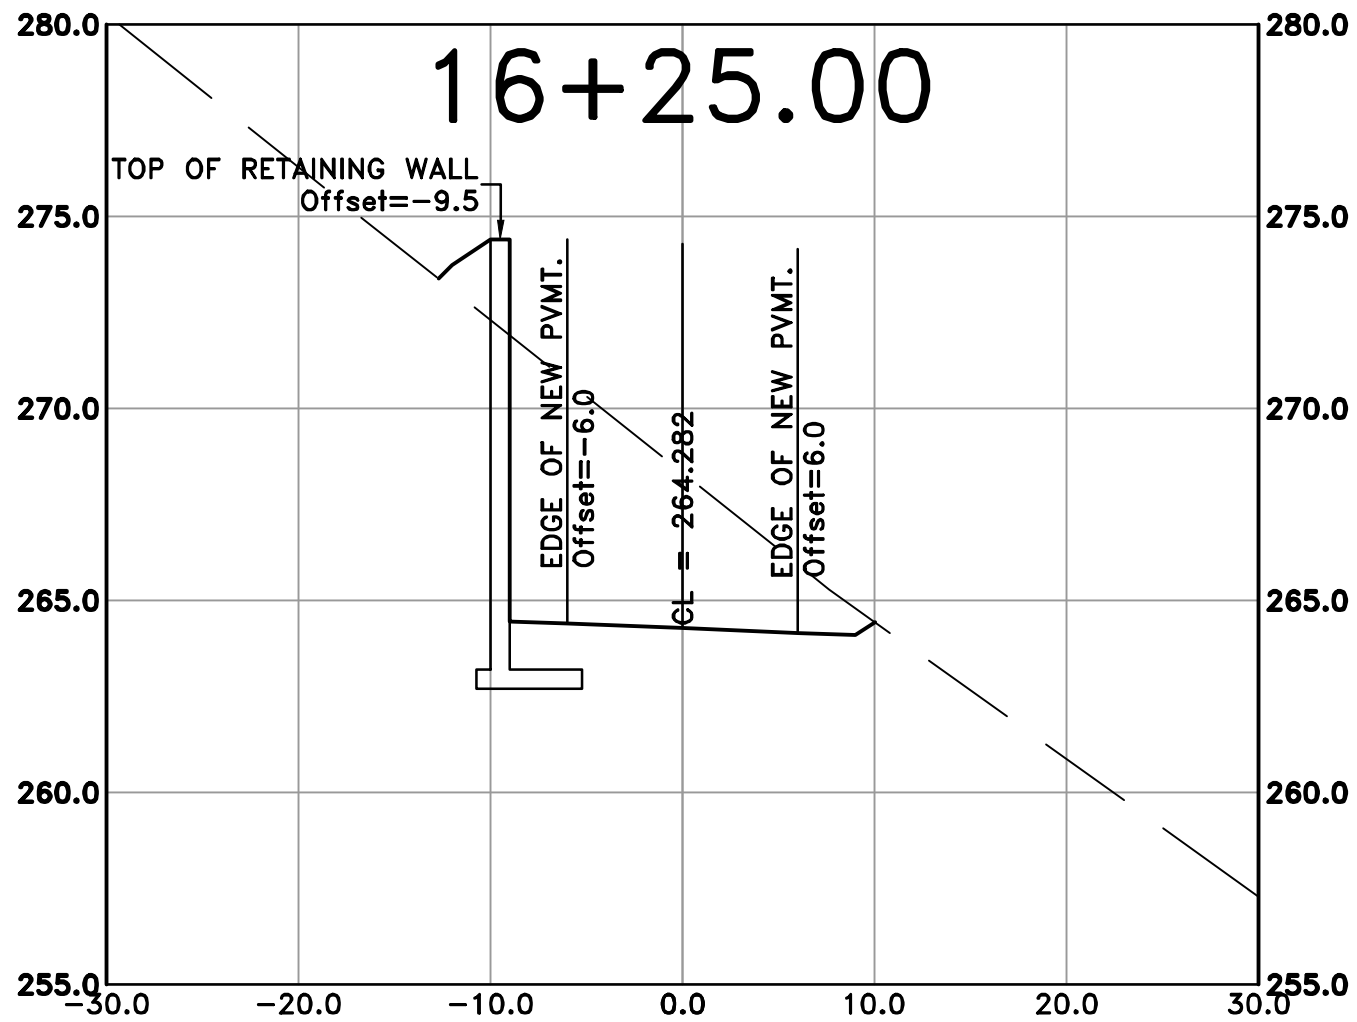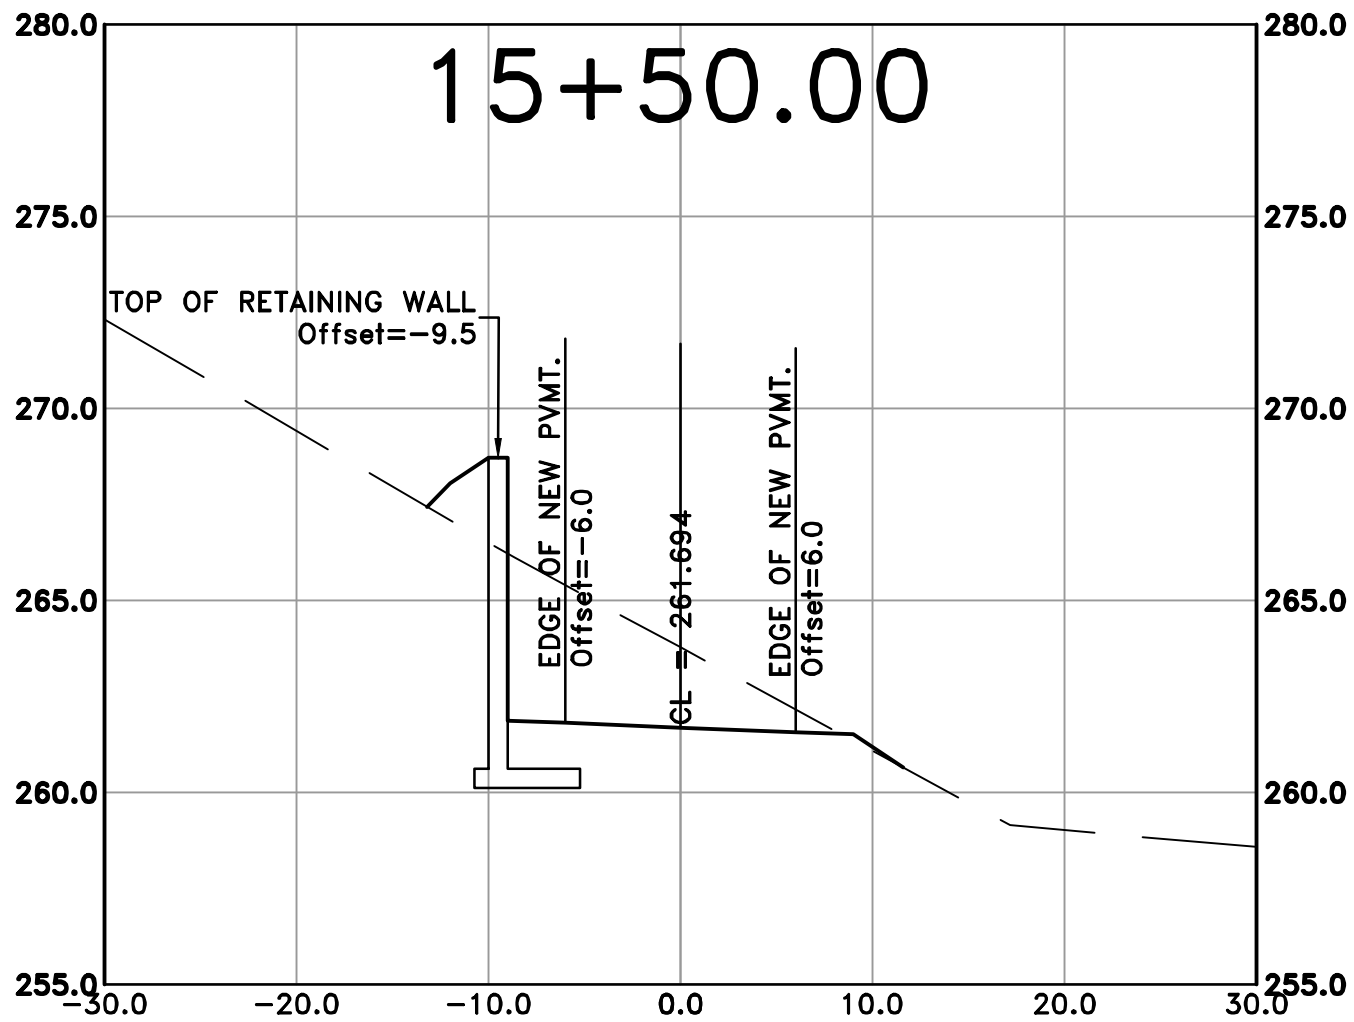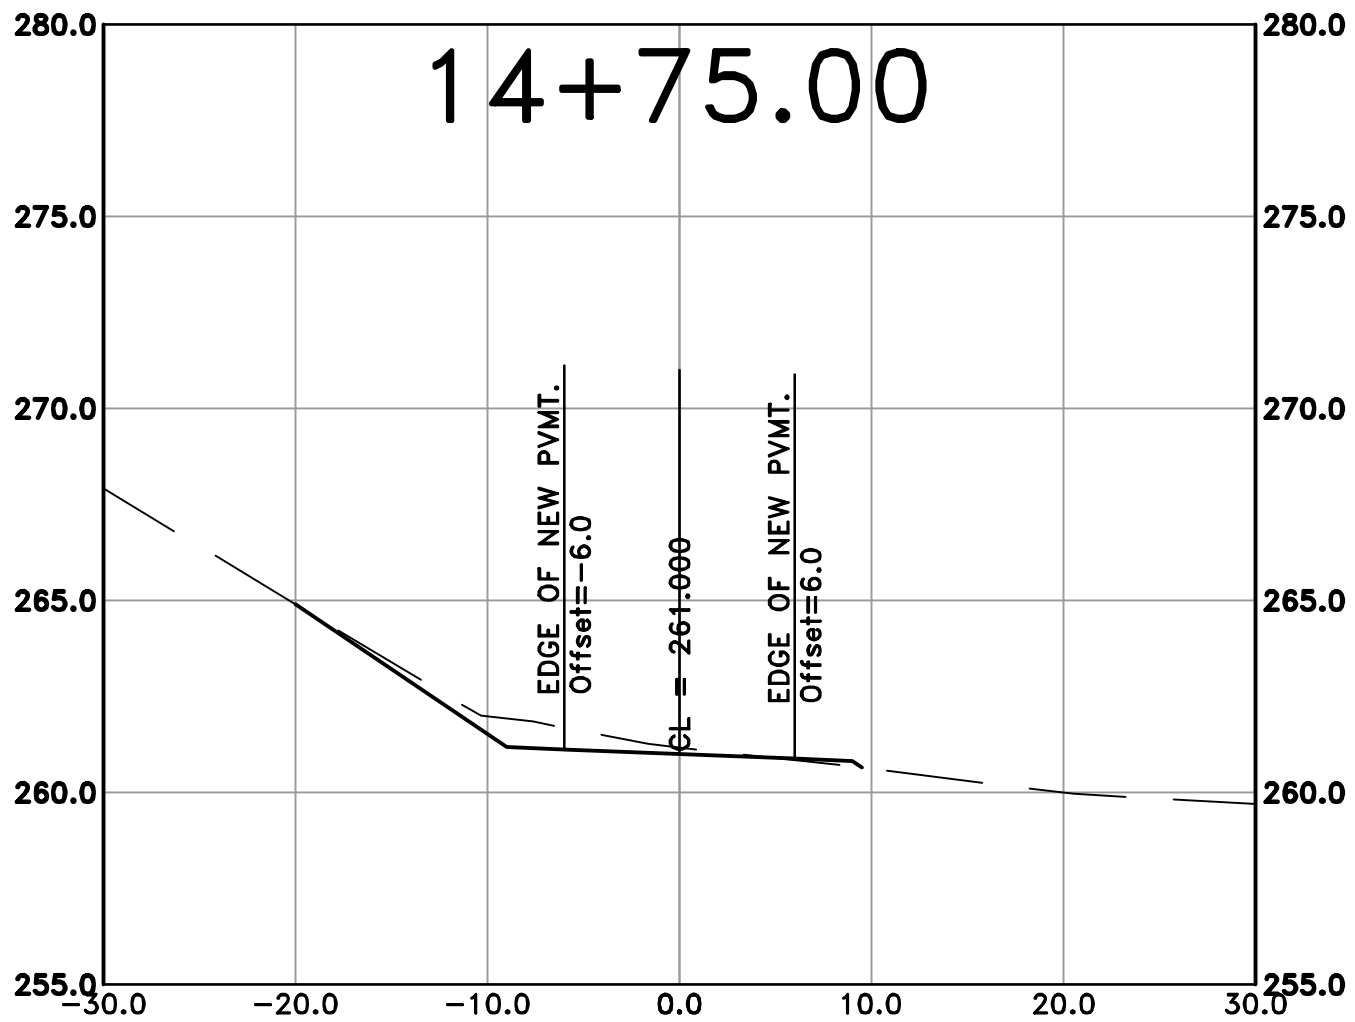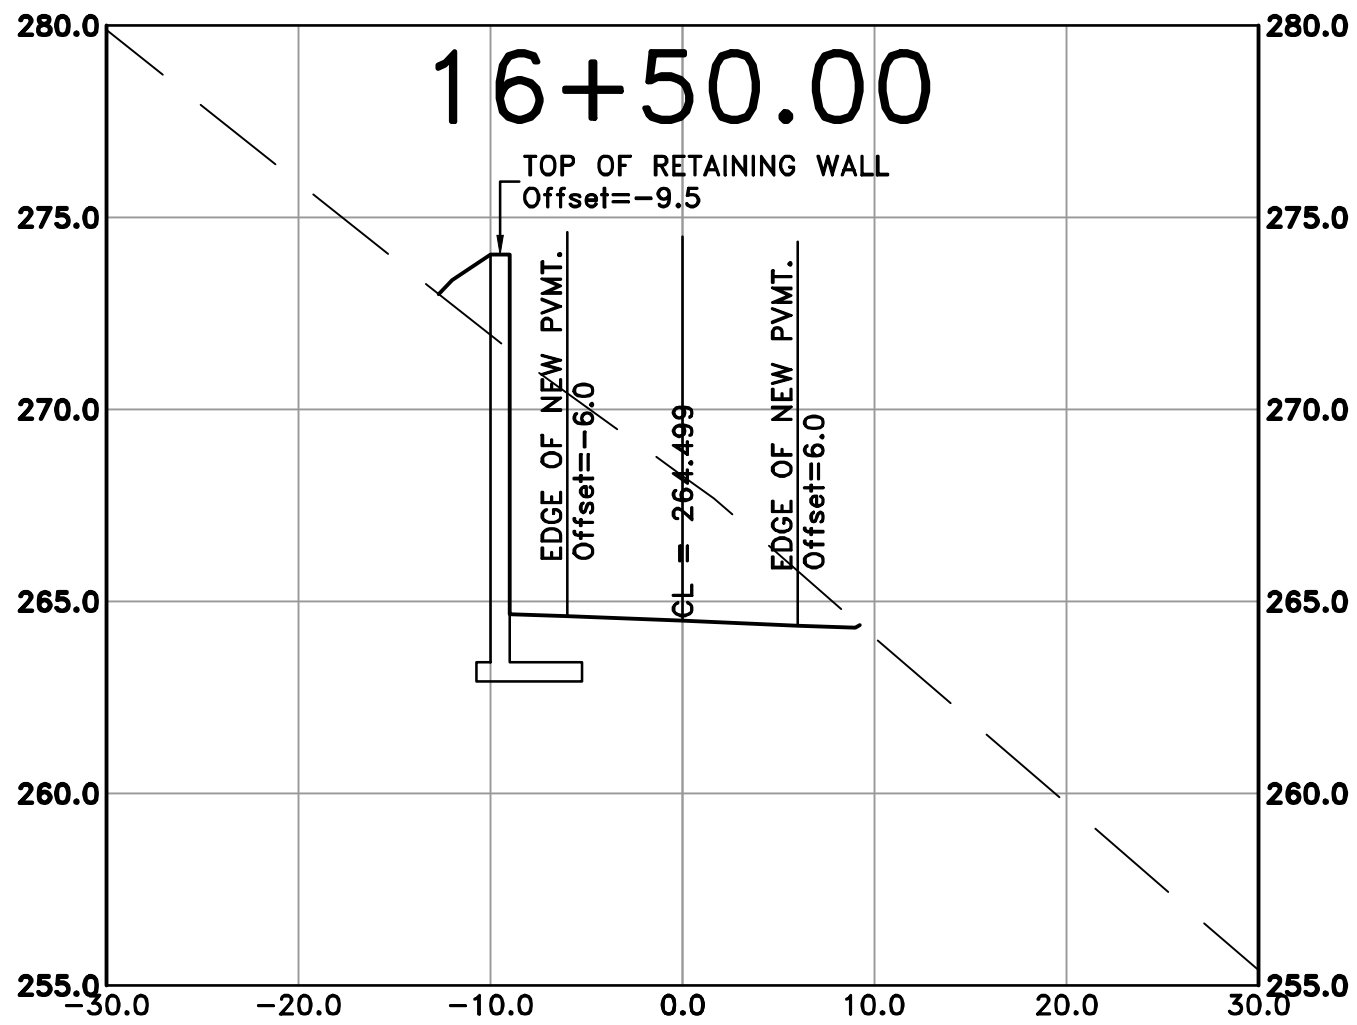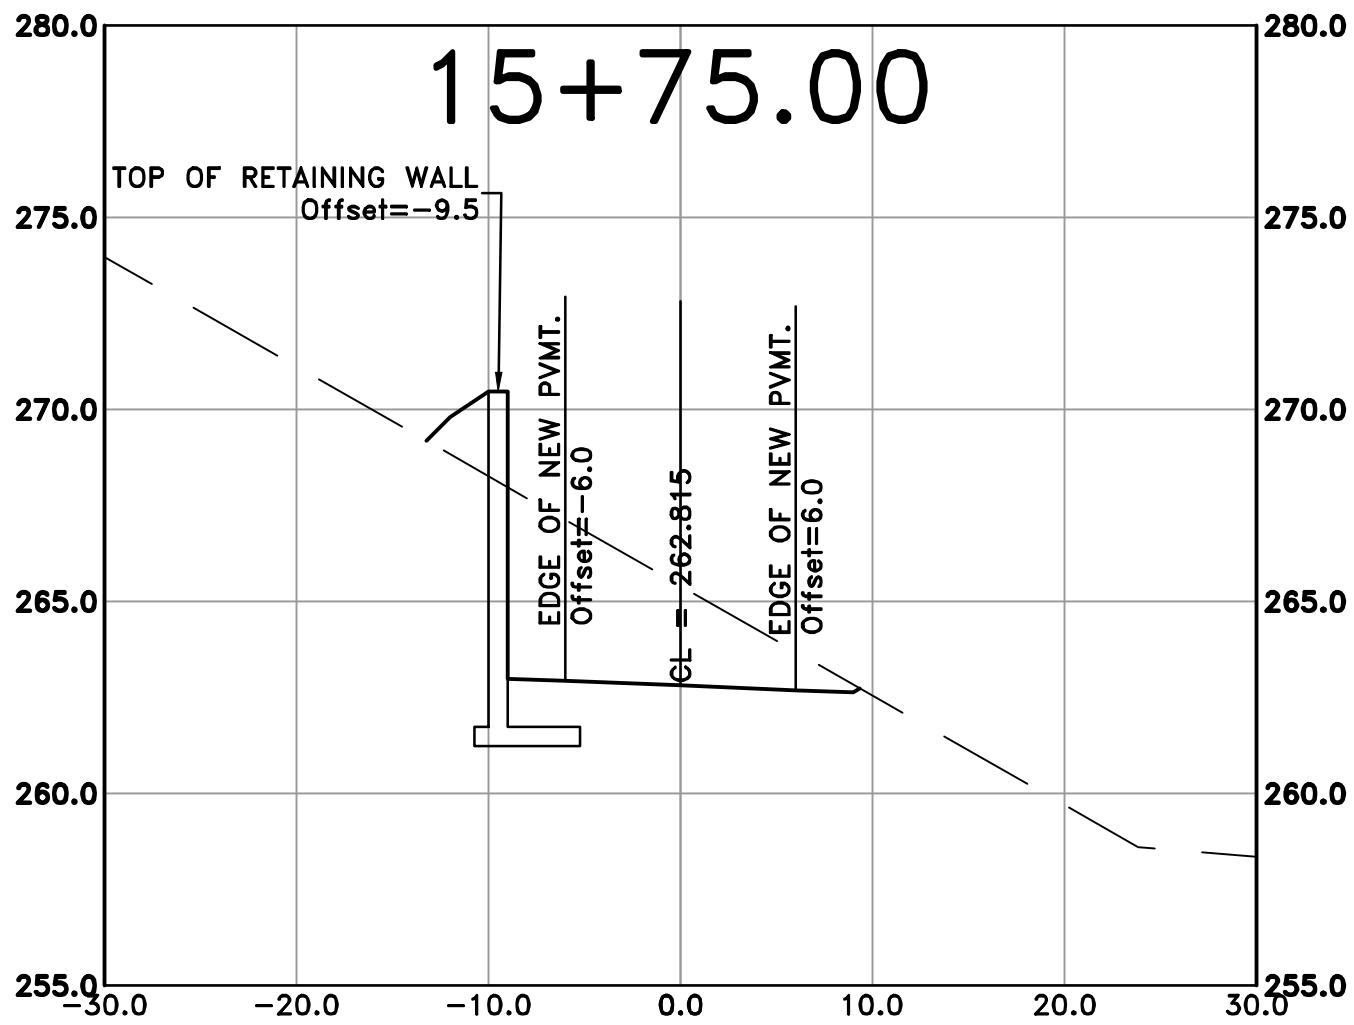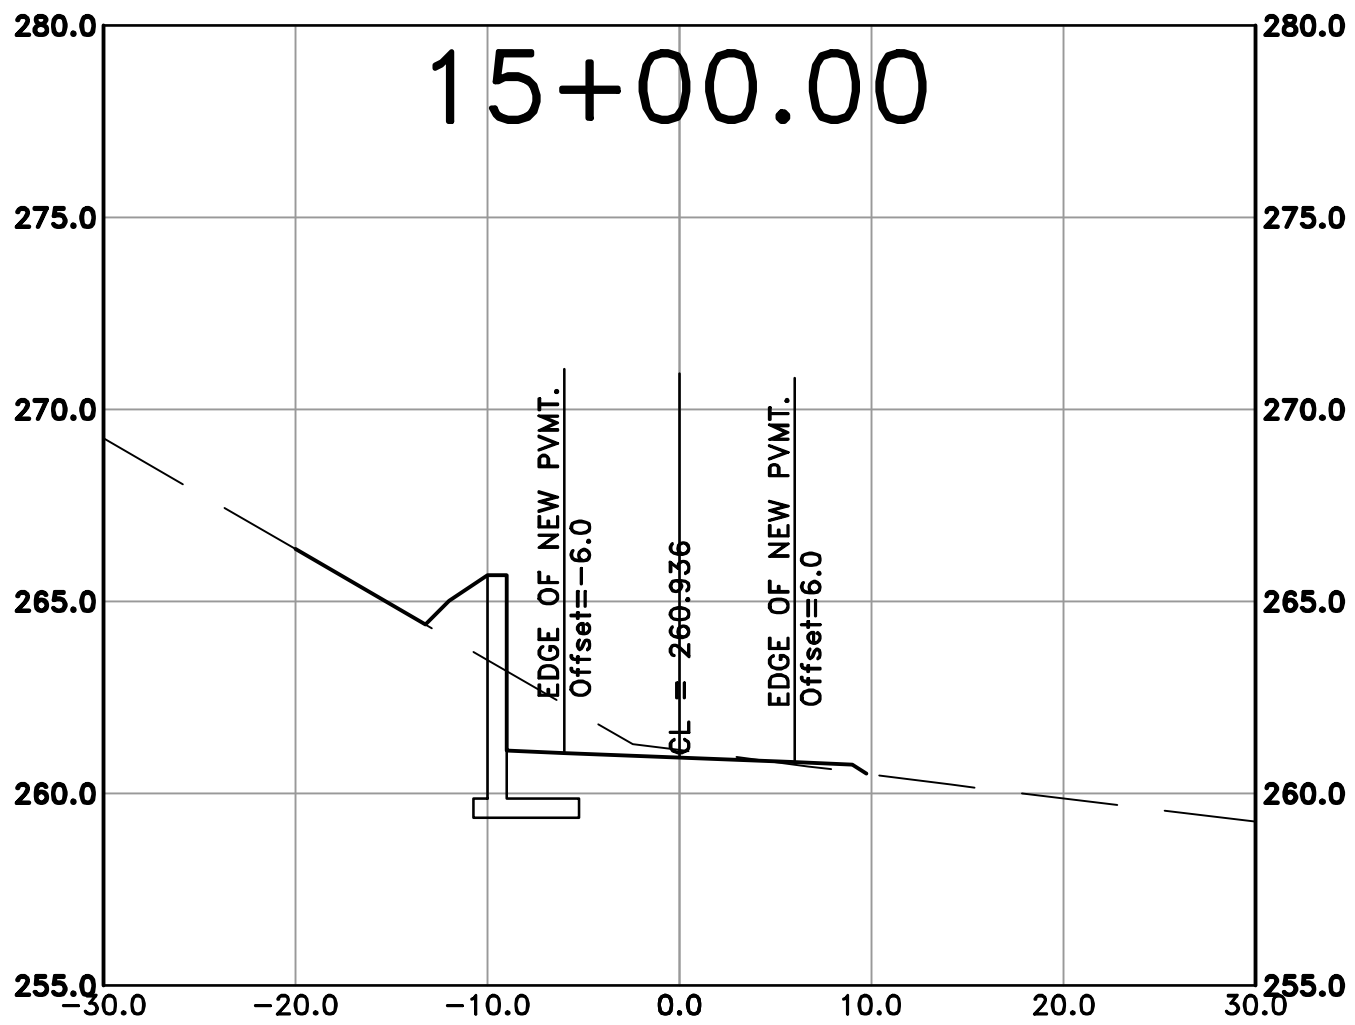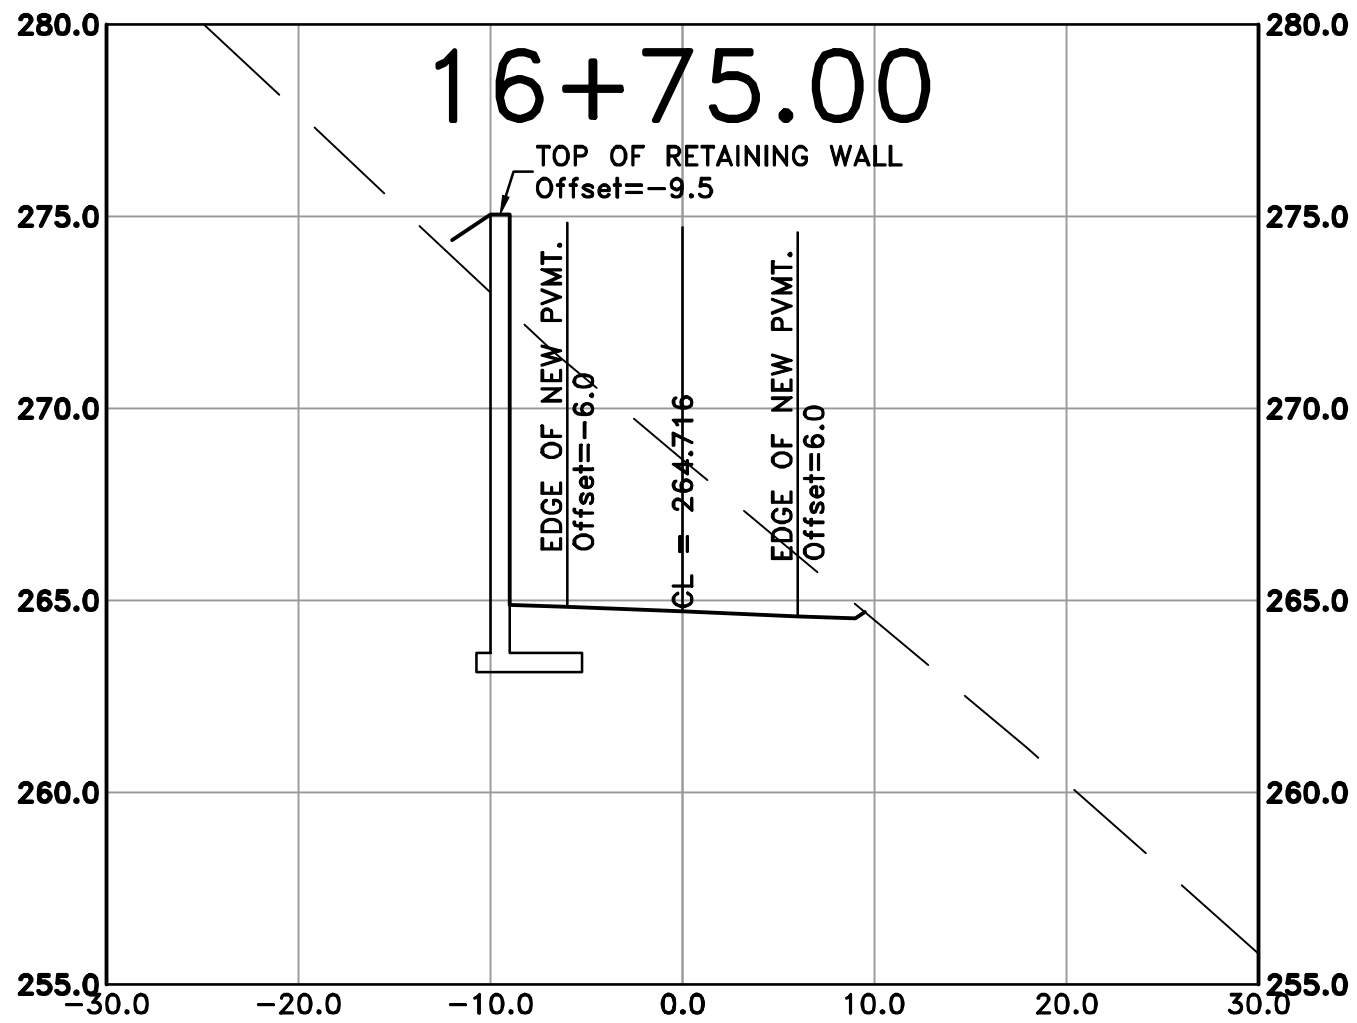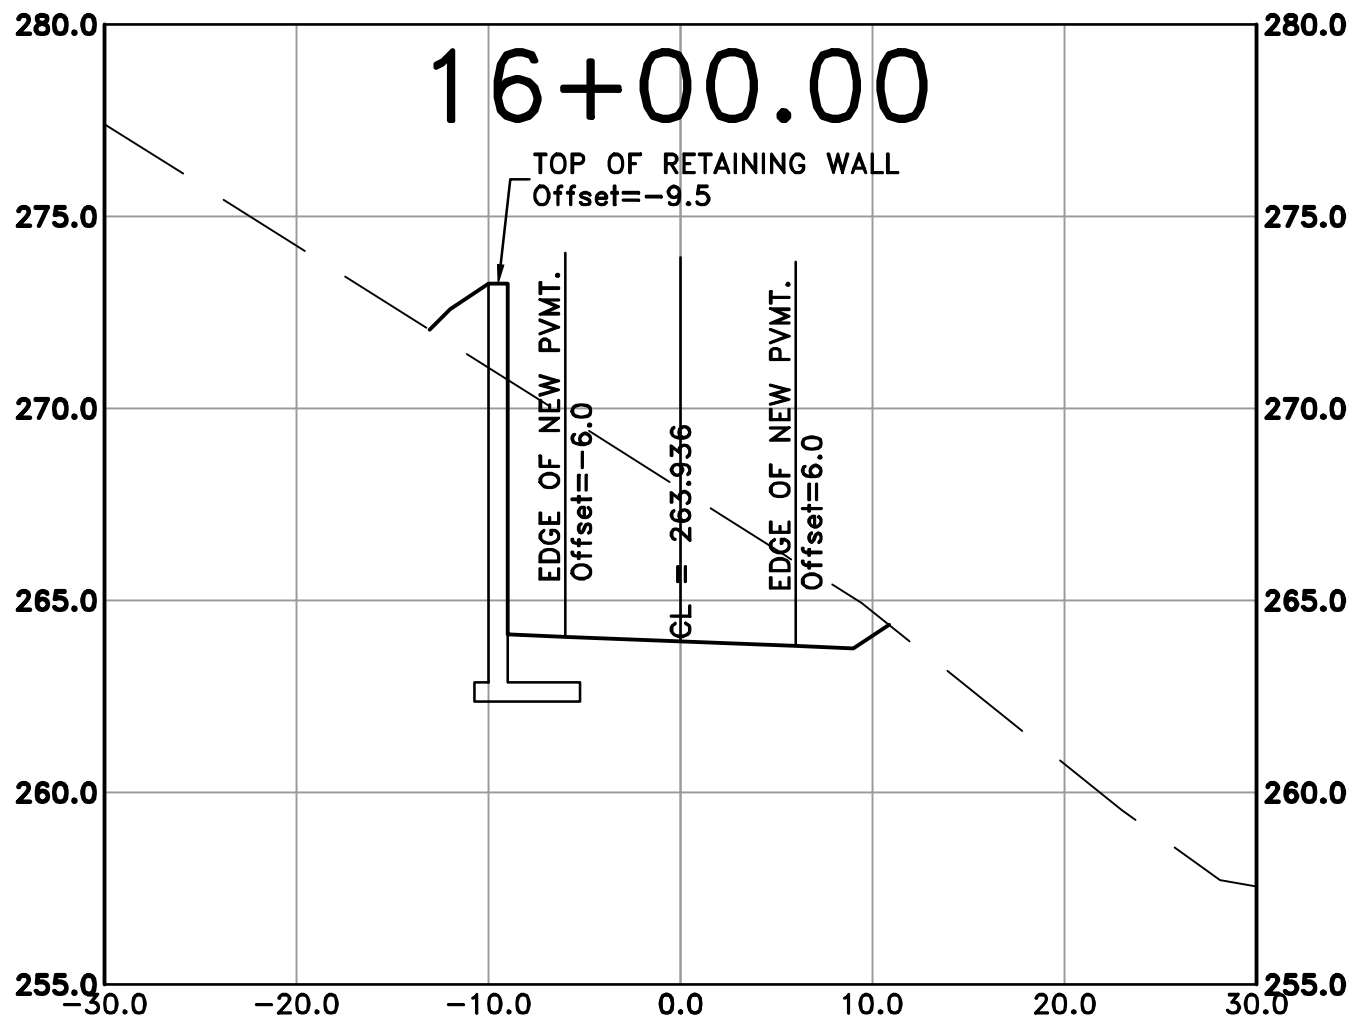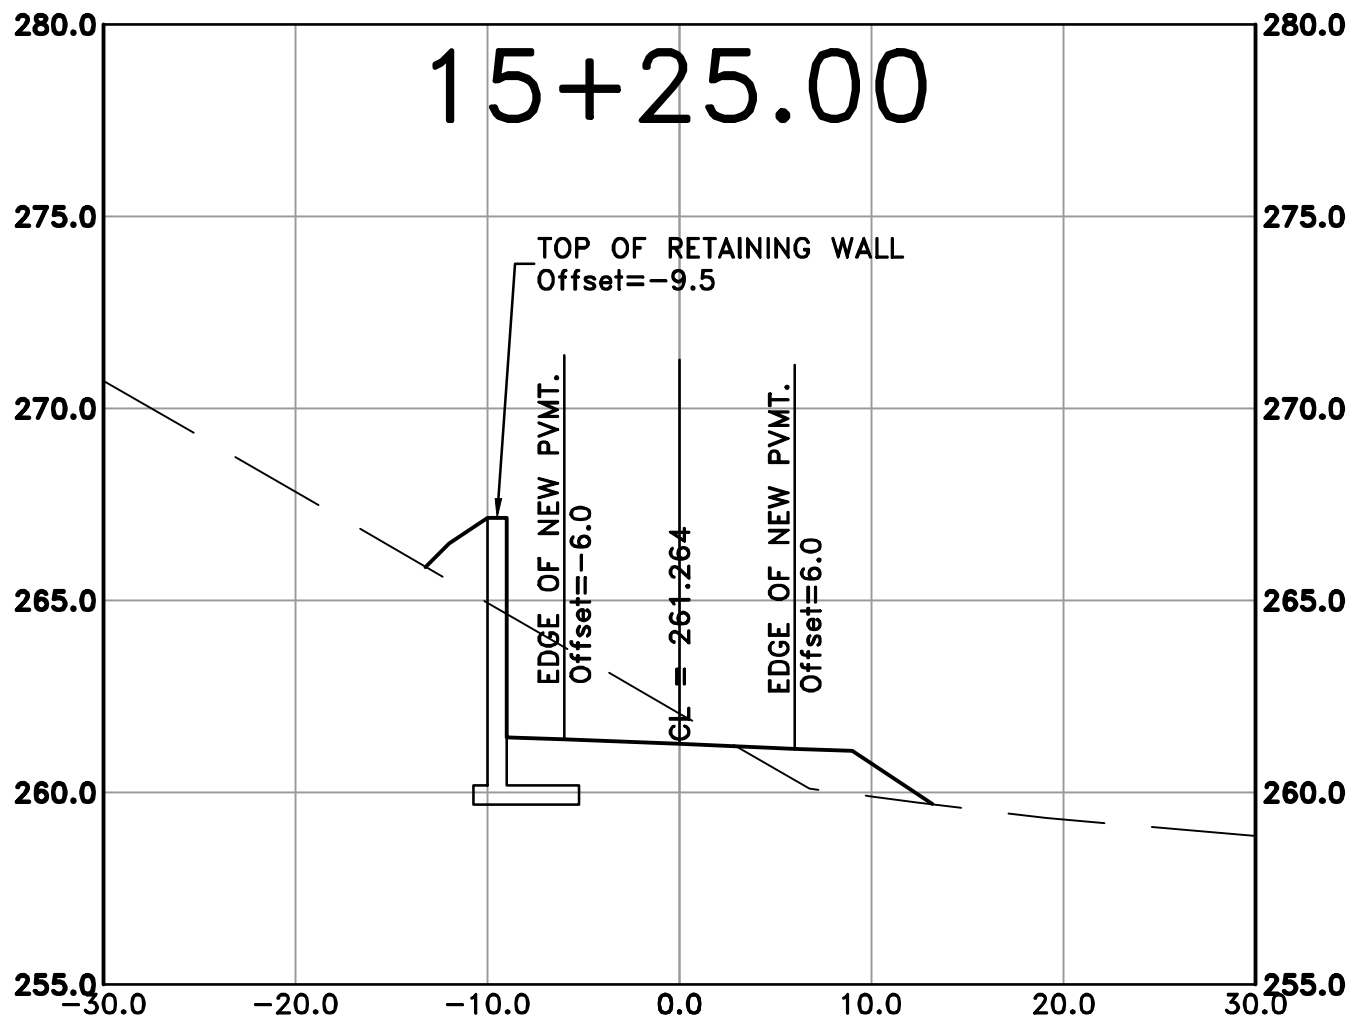

REVISIONS	DATE










CITY OF LITTLE ROCK, ARKANSAS
ROSE CREEK TRAIL
CROSS SECTION SHEET 3

DEPARTMENT OF PUBLIC WORKS
CIVIL ENGINEERING
701 W. MARKHAM
LITTLE ROCK, ARKANSAS 72201



DRAWN BY	AS
DESIGNED	LC
CHECKED	JM
DATE	05-01-2026
SCALE	H: 1"=40' V: 1"=10'
PROJECT NO.	23805201
SHEET NO.	C52

100% SUBMITTAL

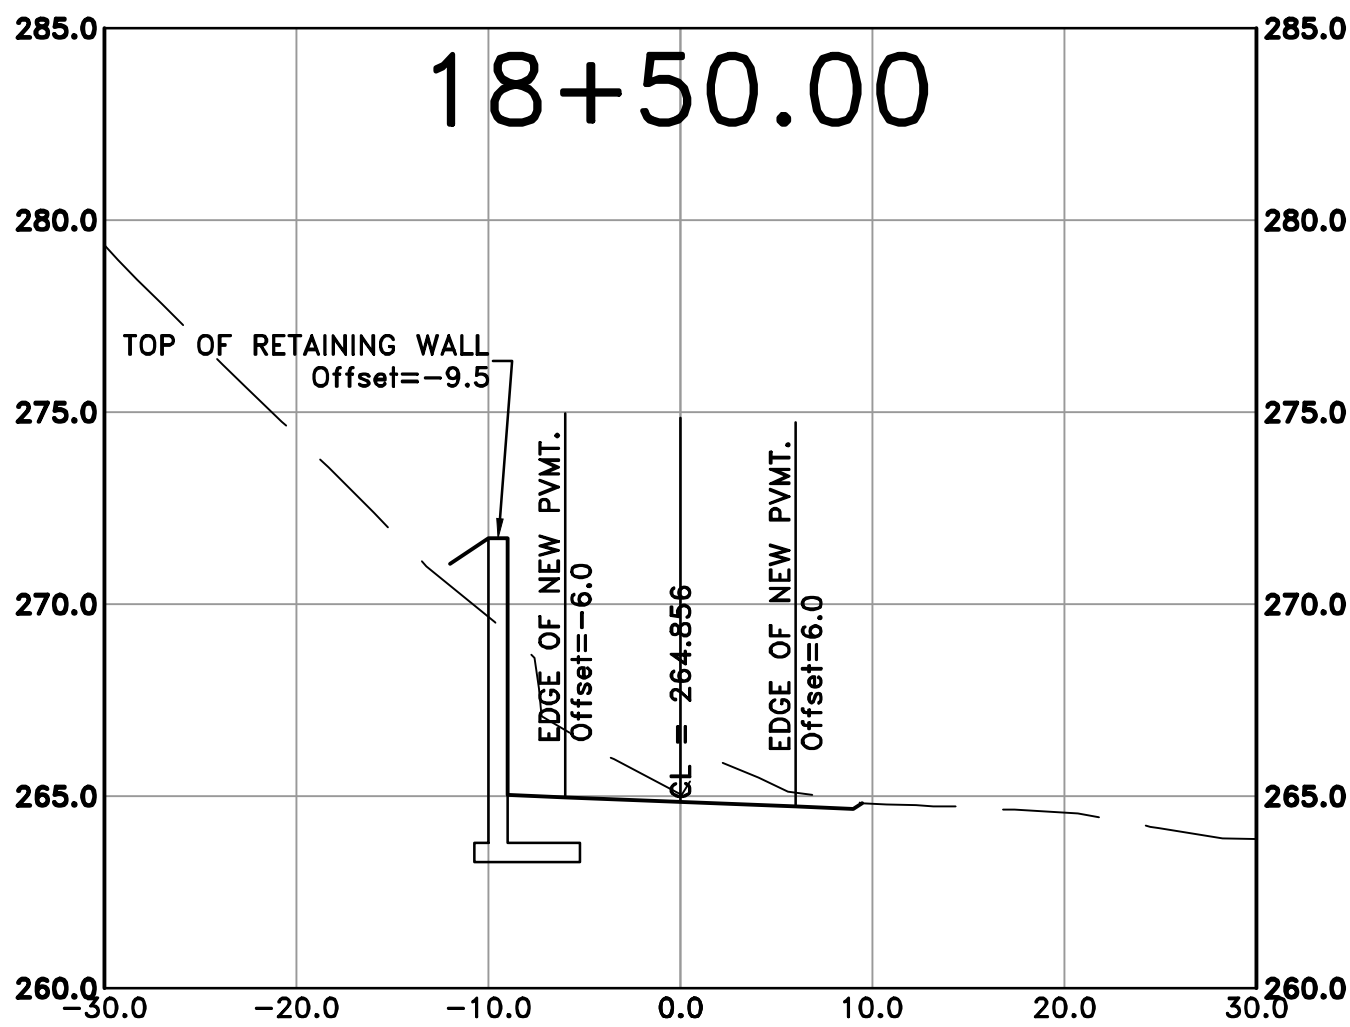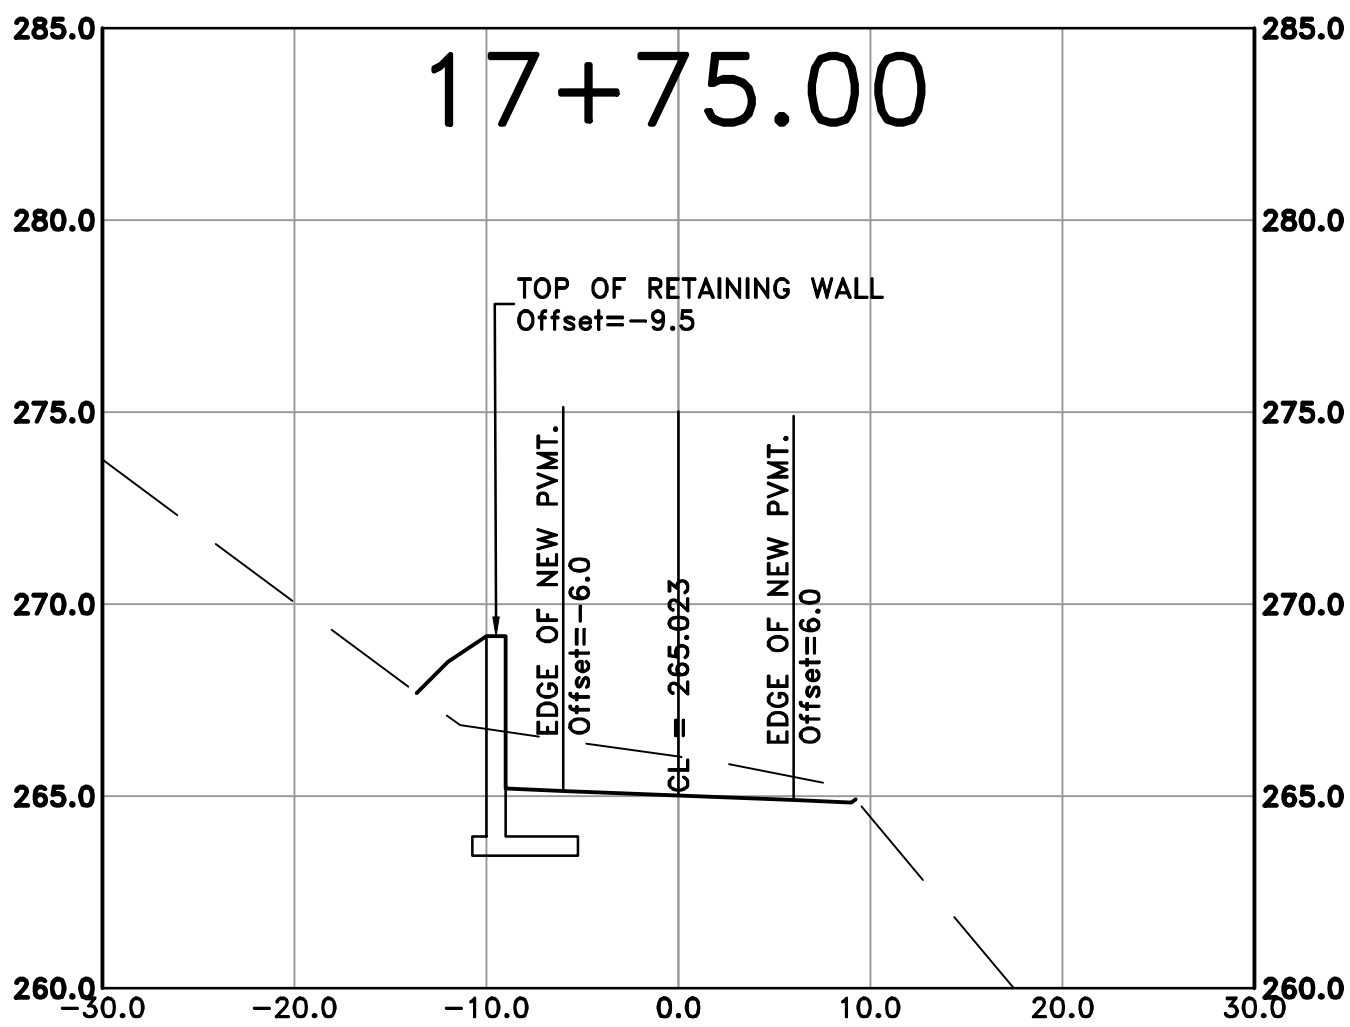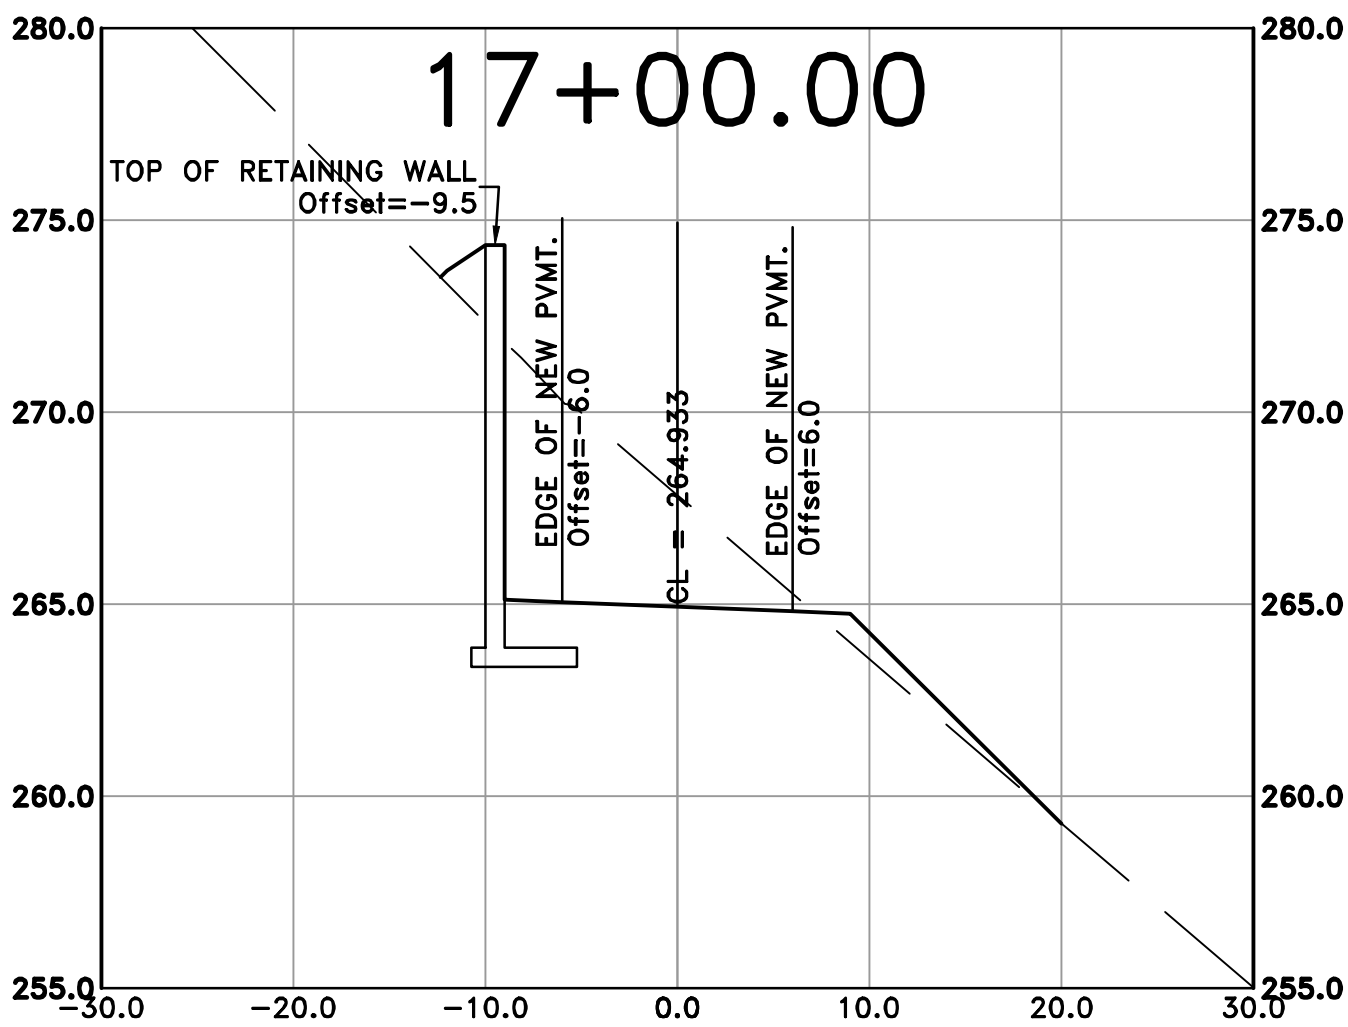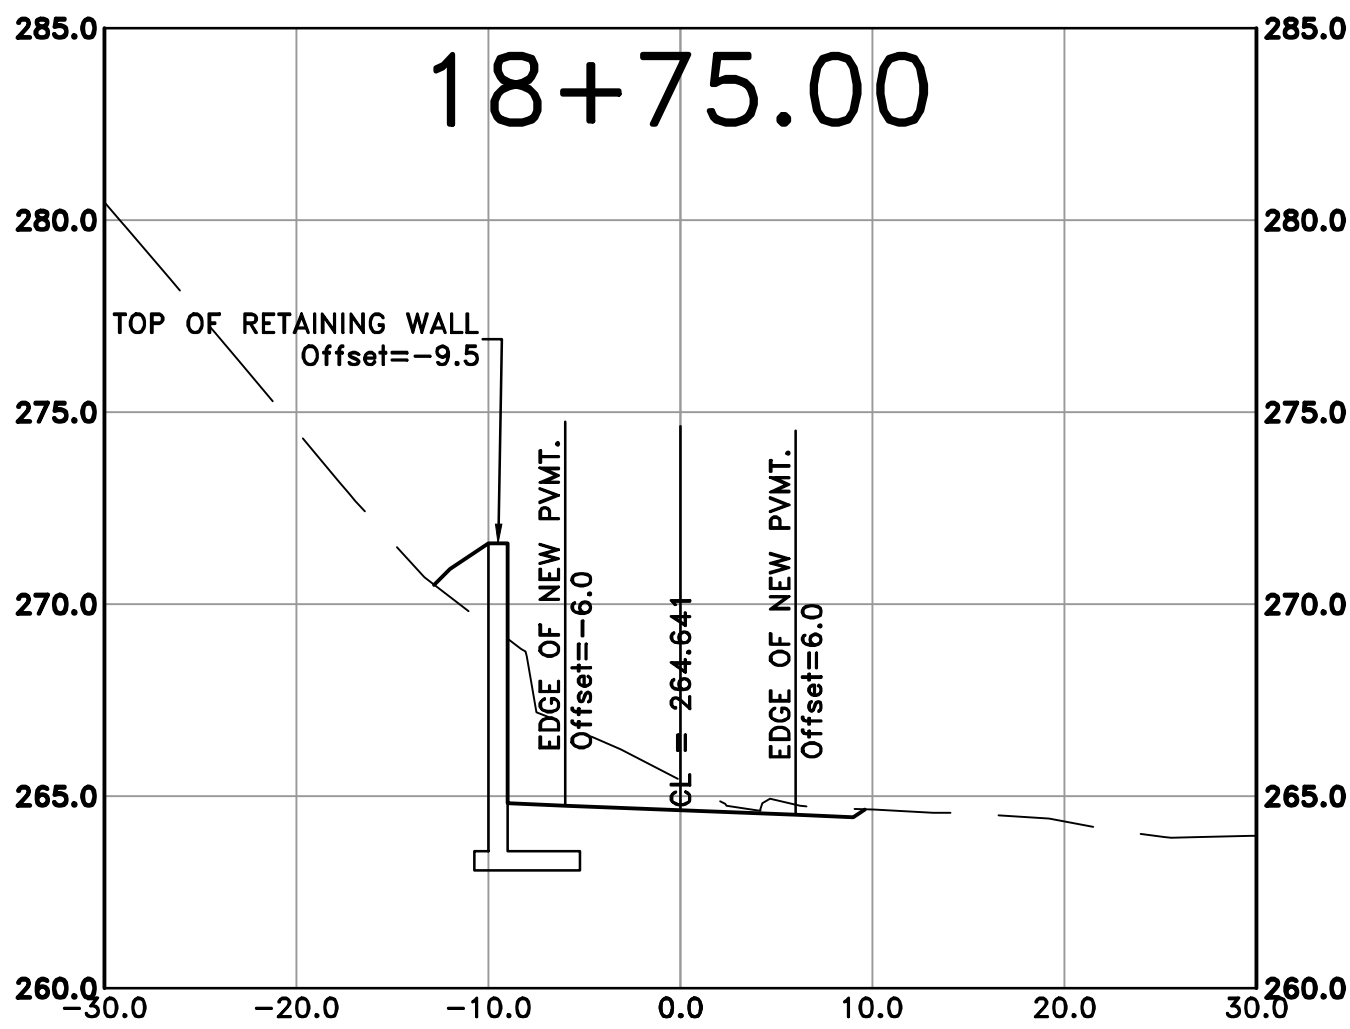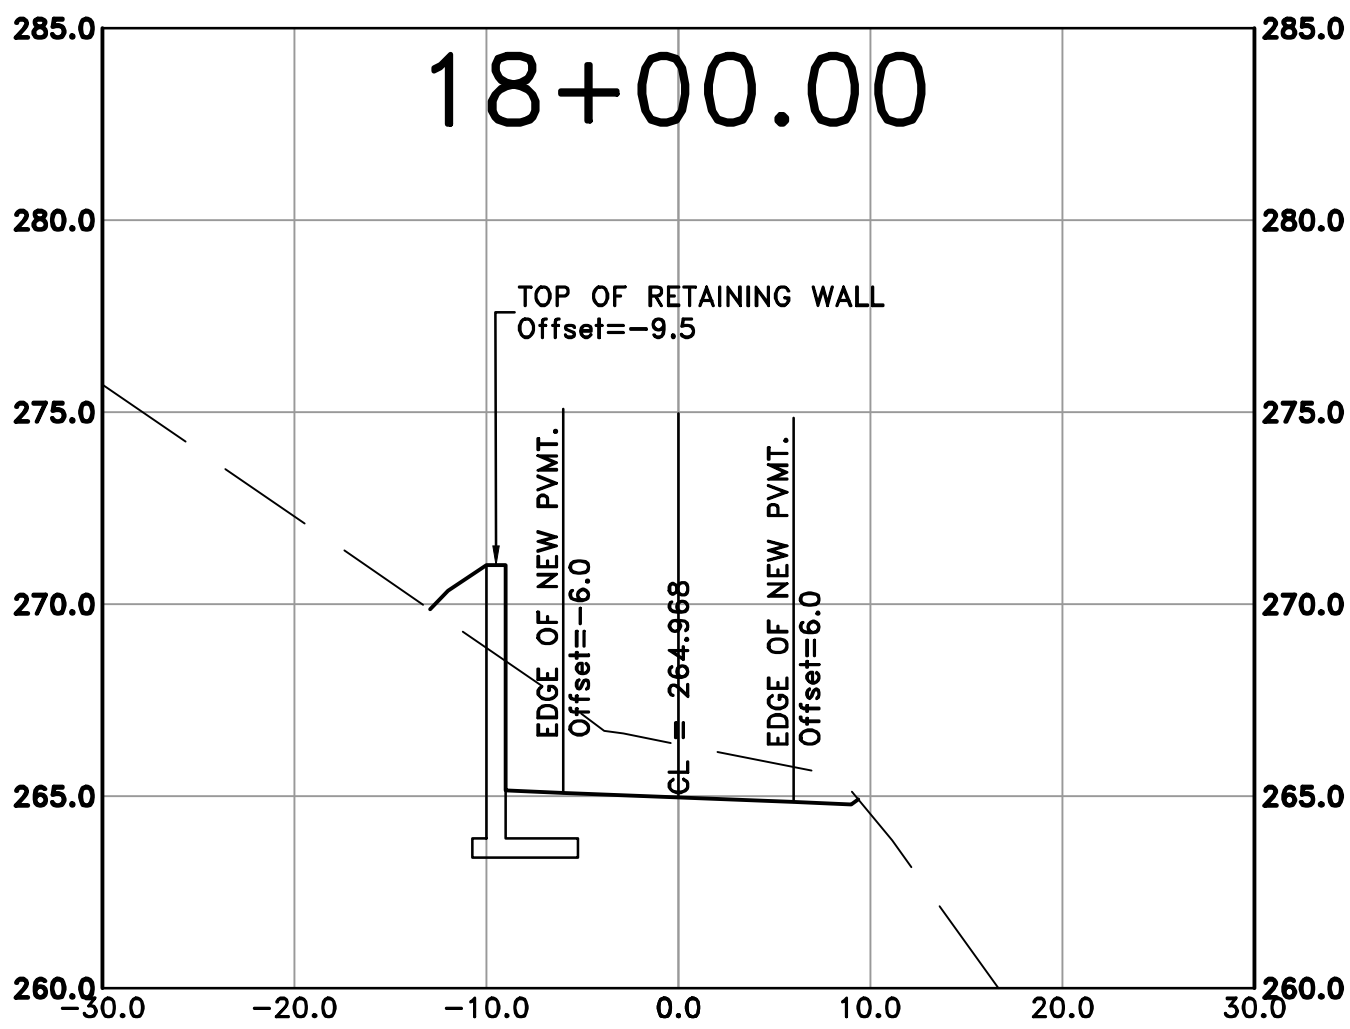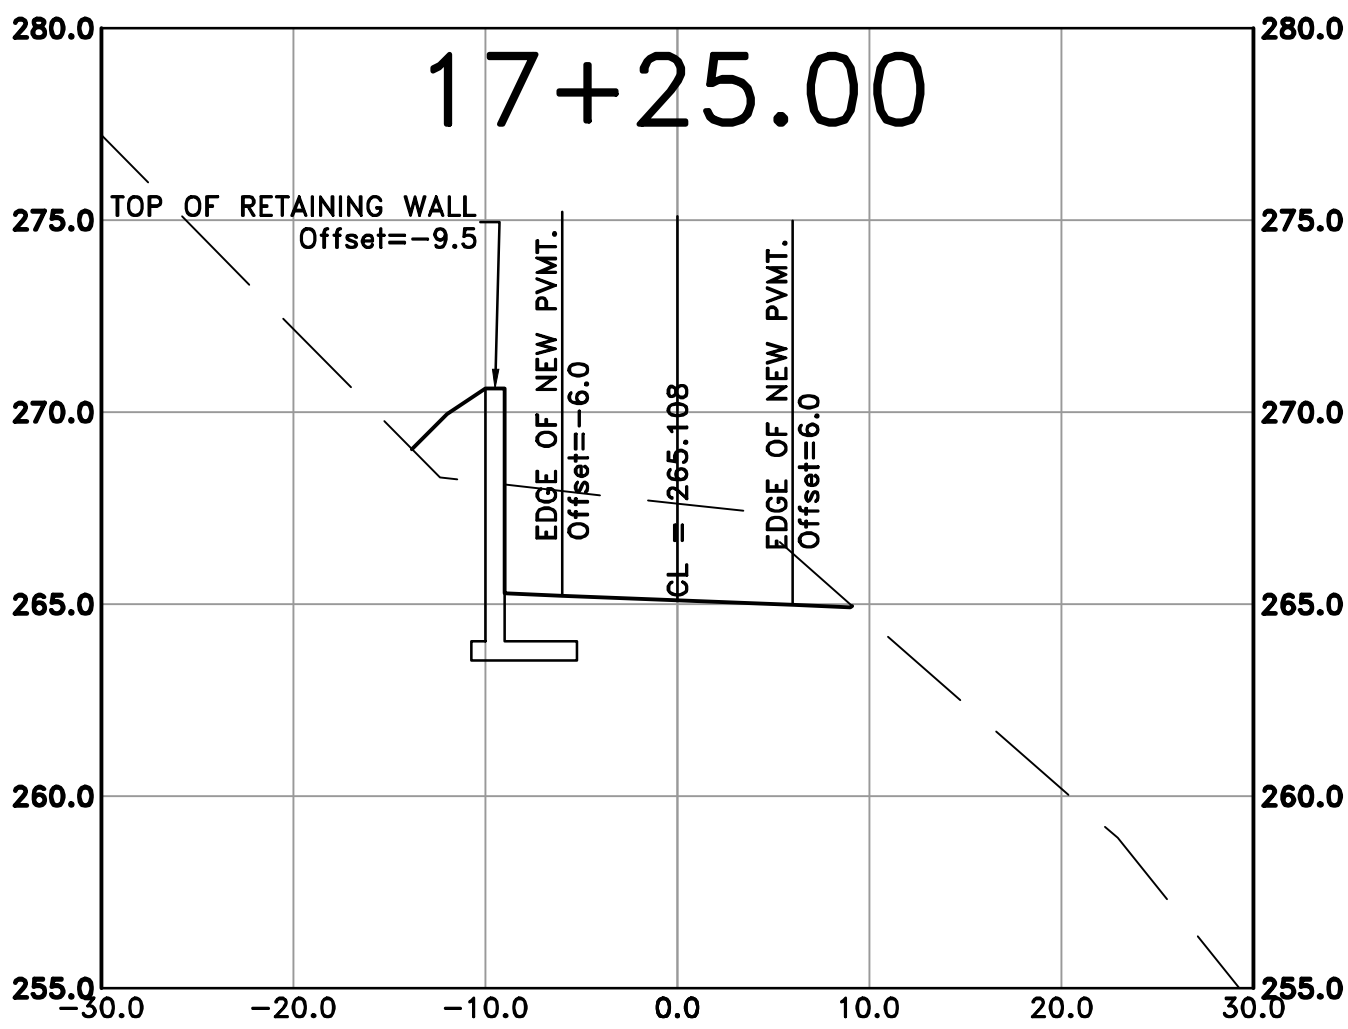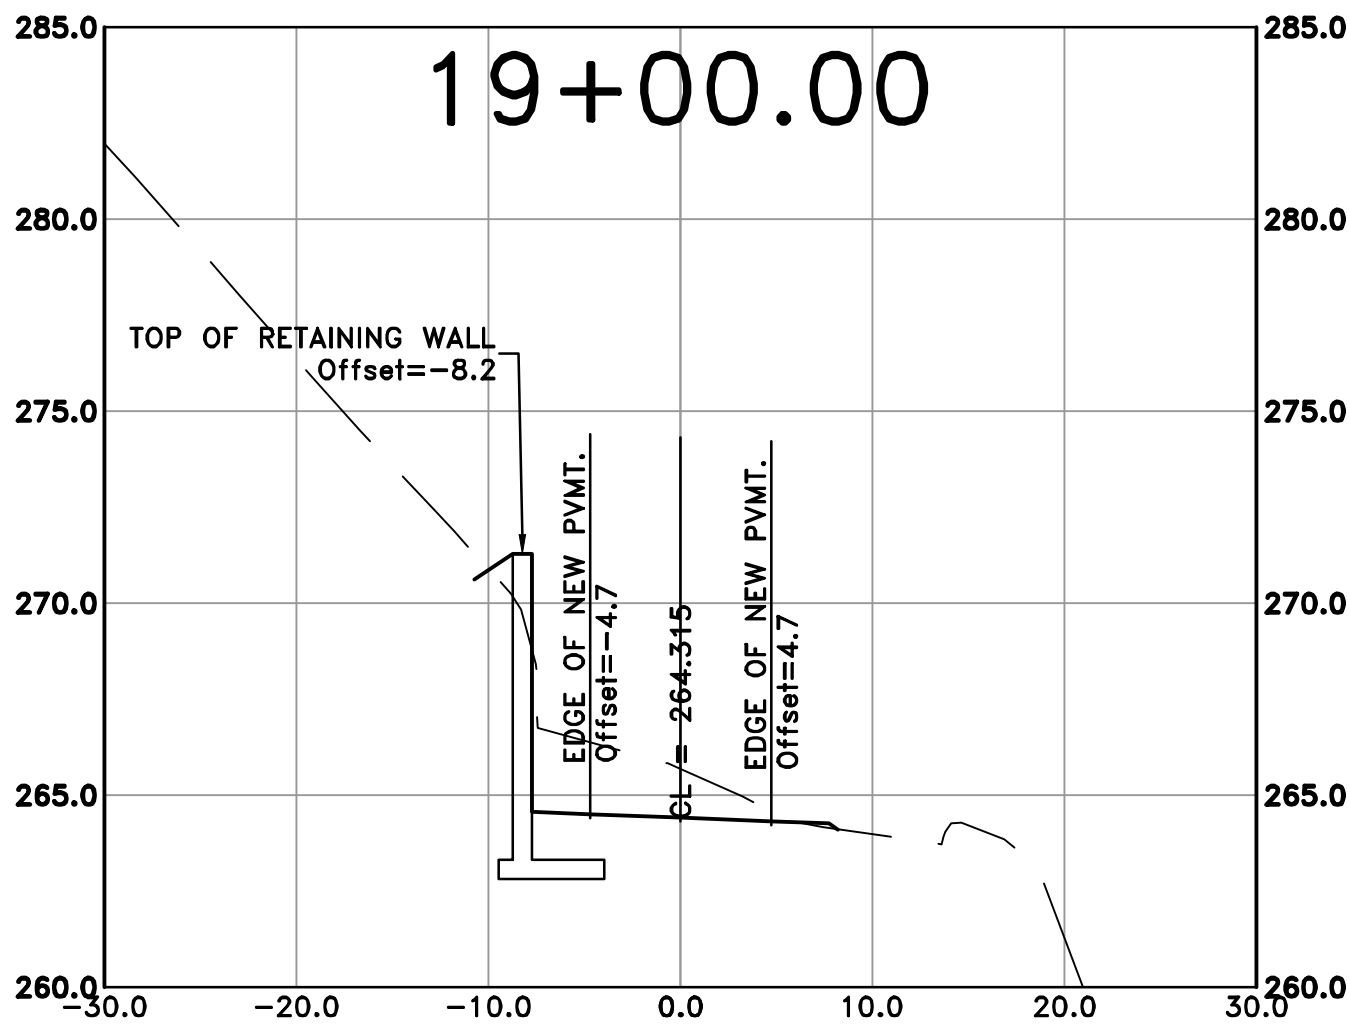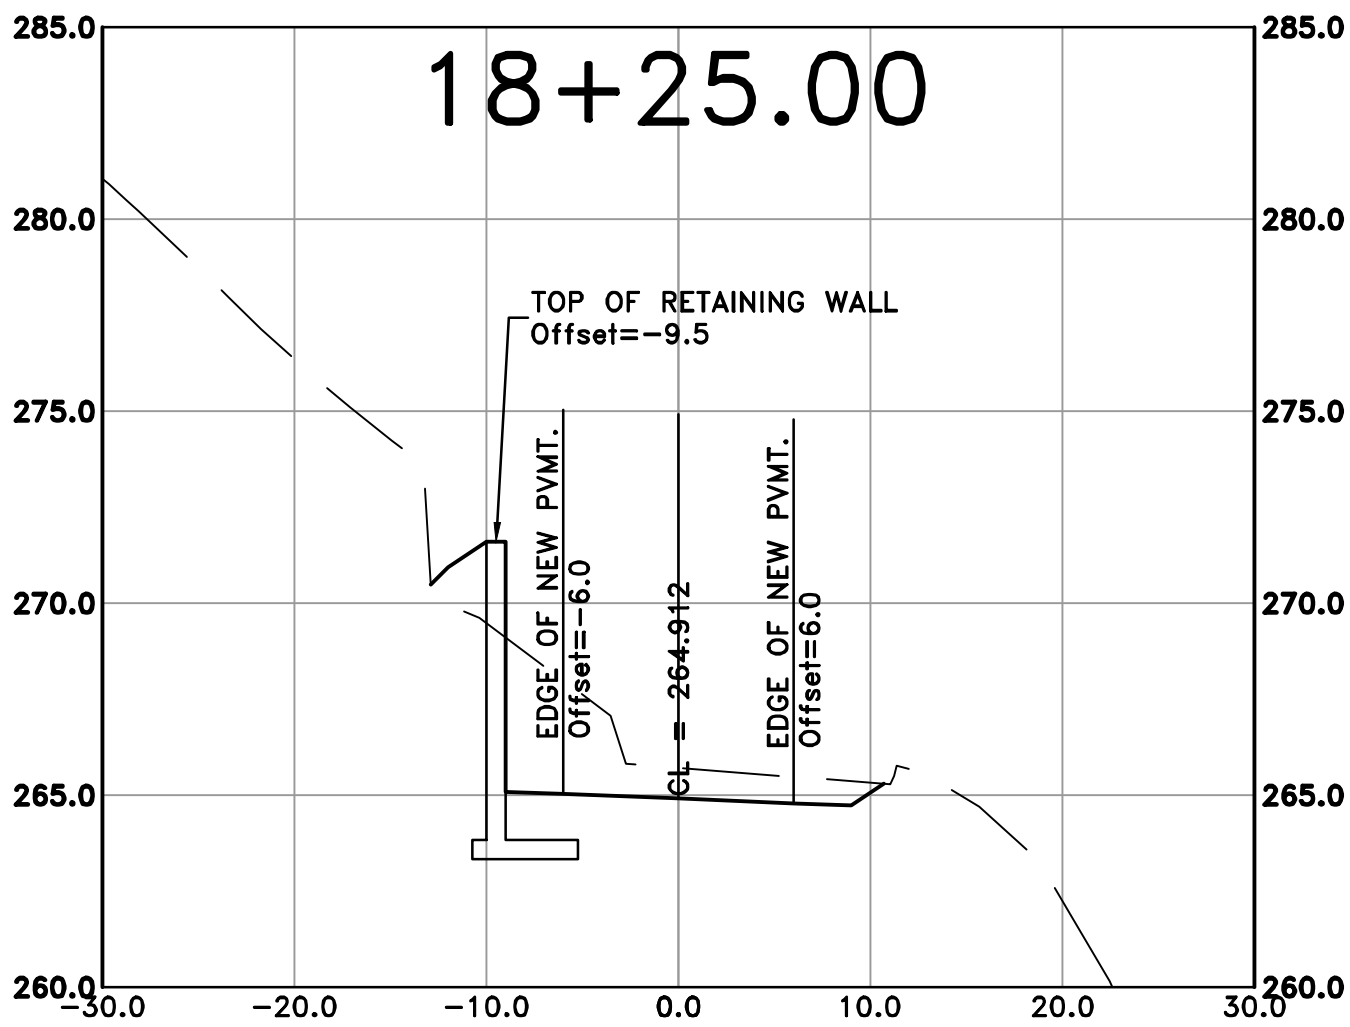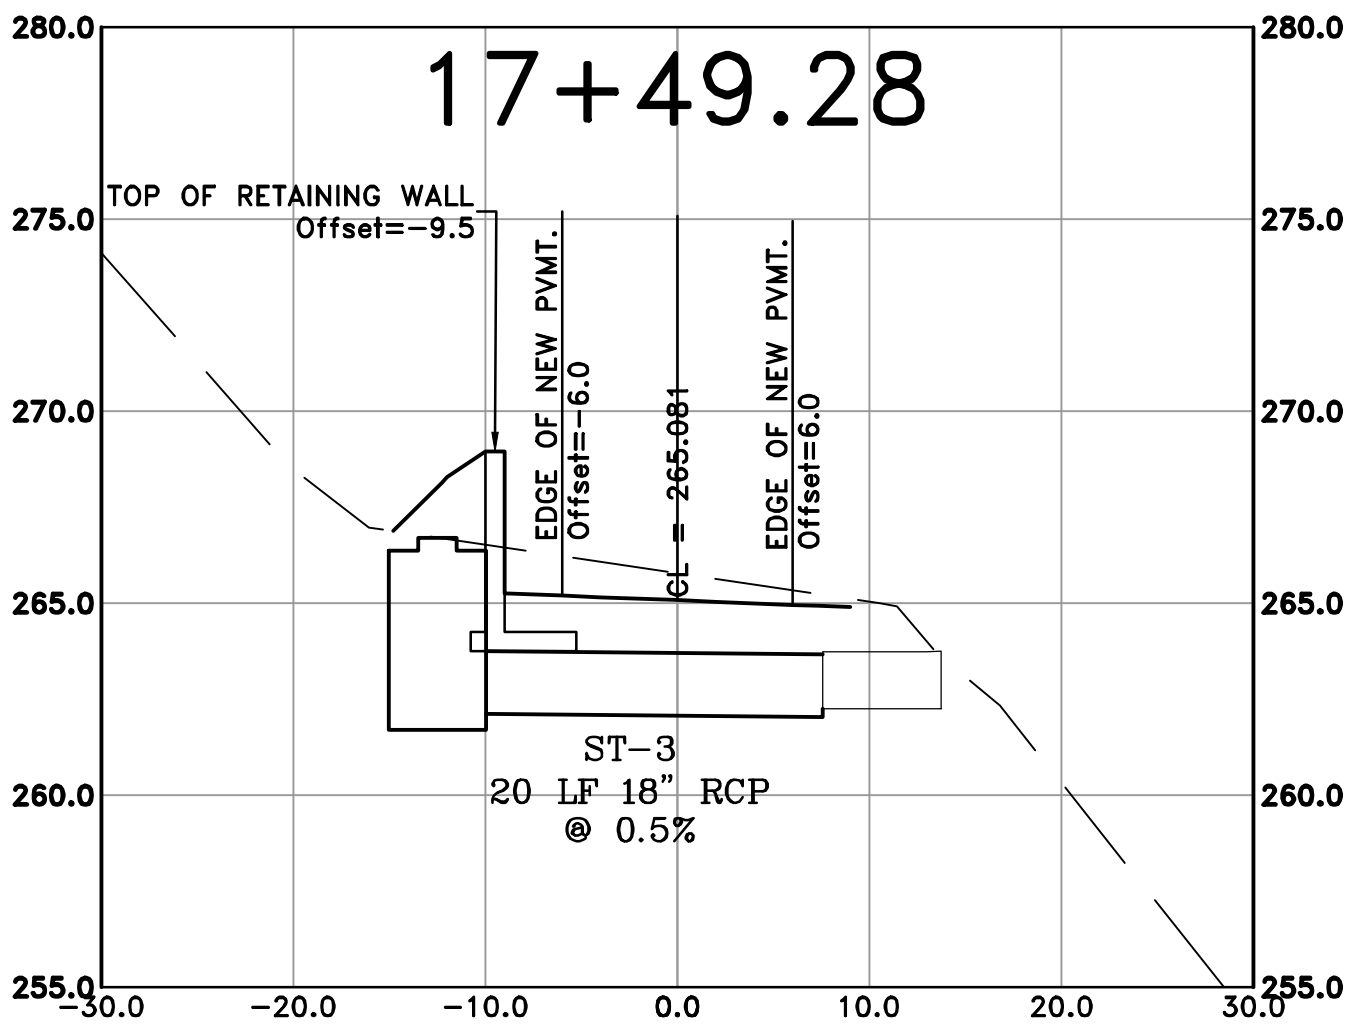

REVISIONS	DATE










CITY OF LITTLE ROCK, ARKANSAS
ROSE CREEK TRAIL
CROSS SECTION SHEET 4

DEPARTMENT OF PUBLIC WORKS
CIVIL ENGINEERING
701 W. MARKHAM
LITTLE ROCK, ARKANSAS 72201



DRAWN BY	AS
DESIGNED	LC
CHECKED	JM
DATE	05-01-2026
SCALE	H: 1"=20' V: 1"=5'
PROJECT NO.	23805201
SHEET NO.	C53

100% SUBMITTAL

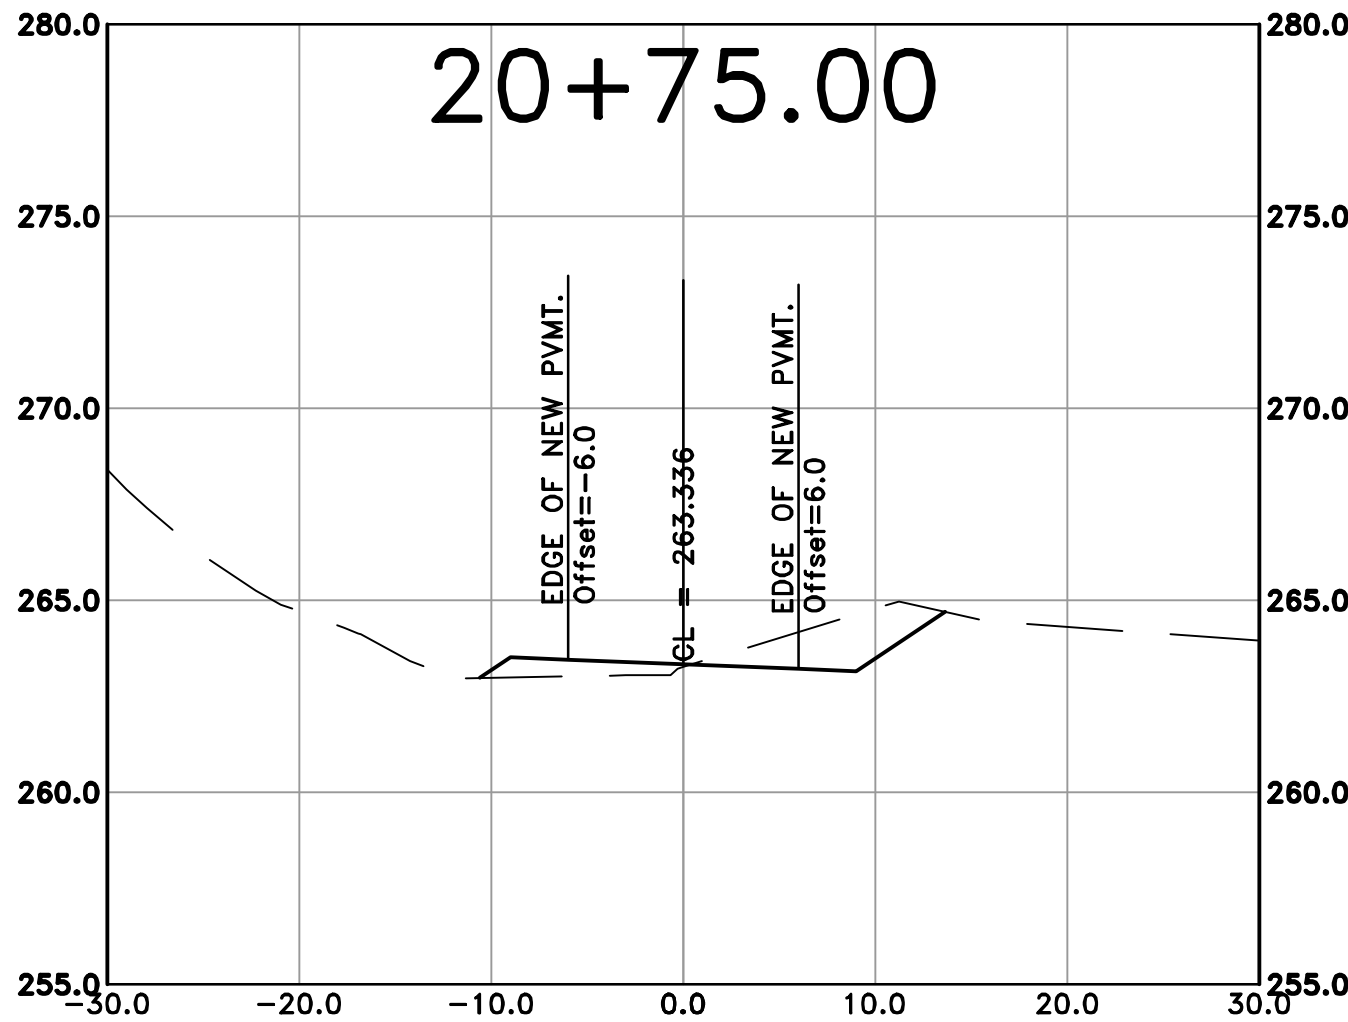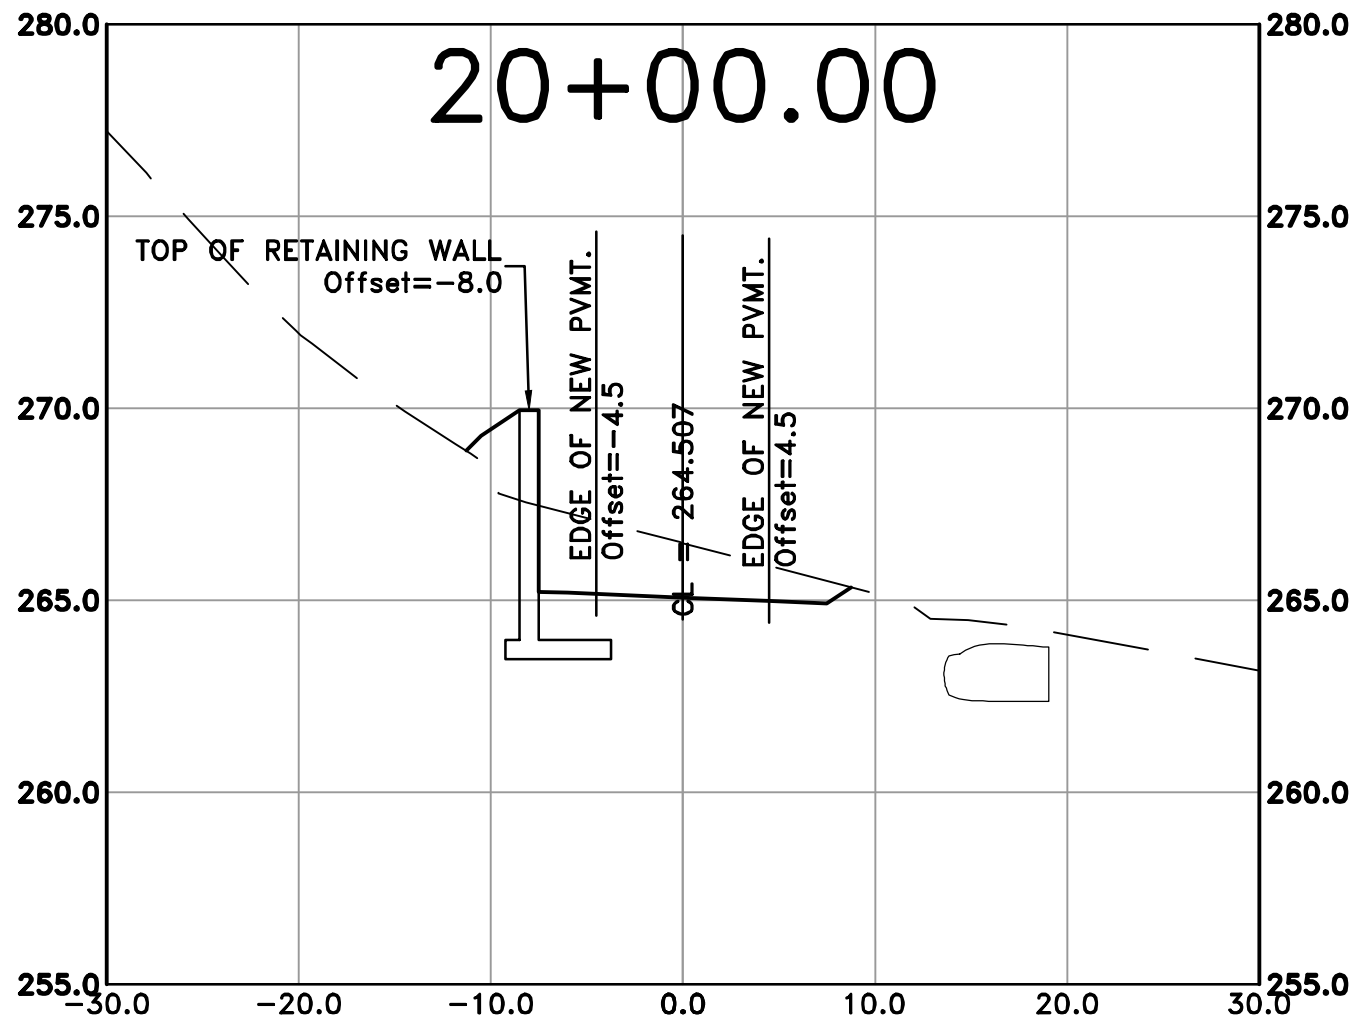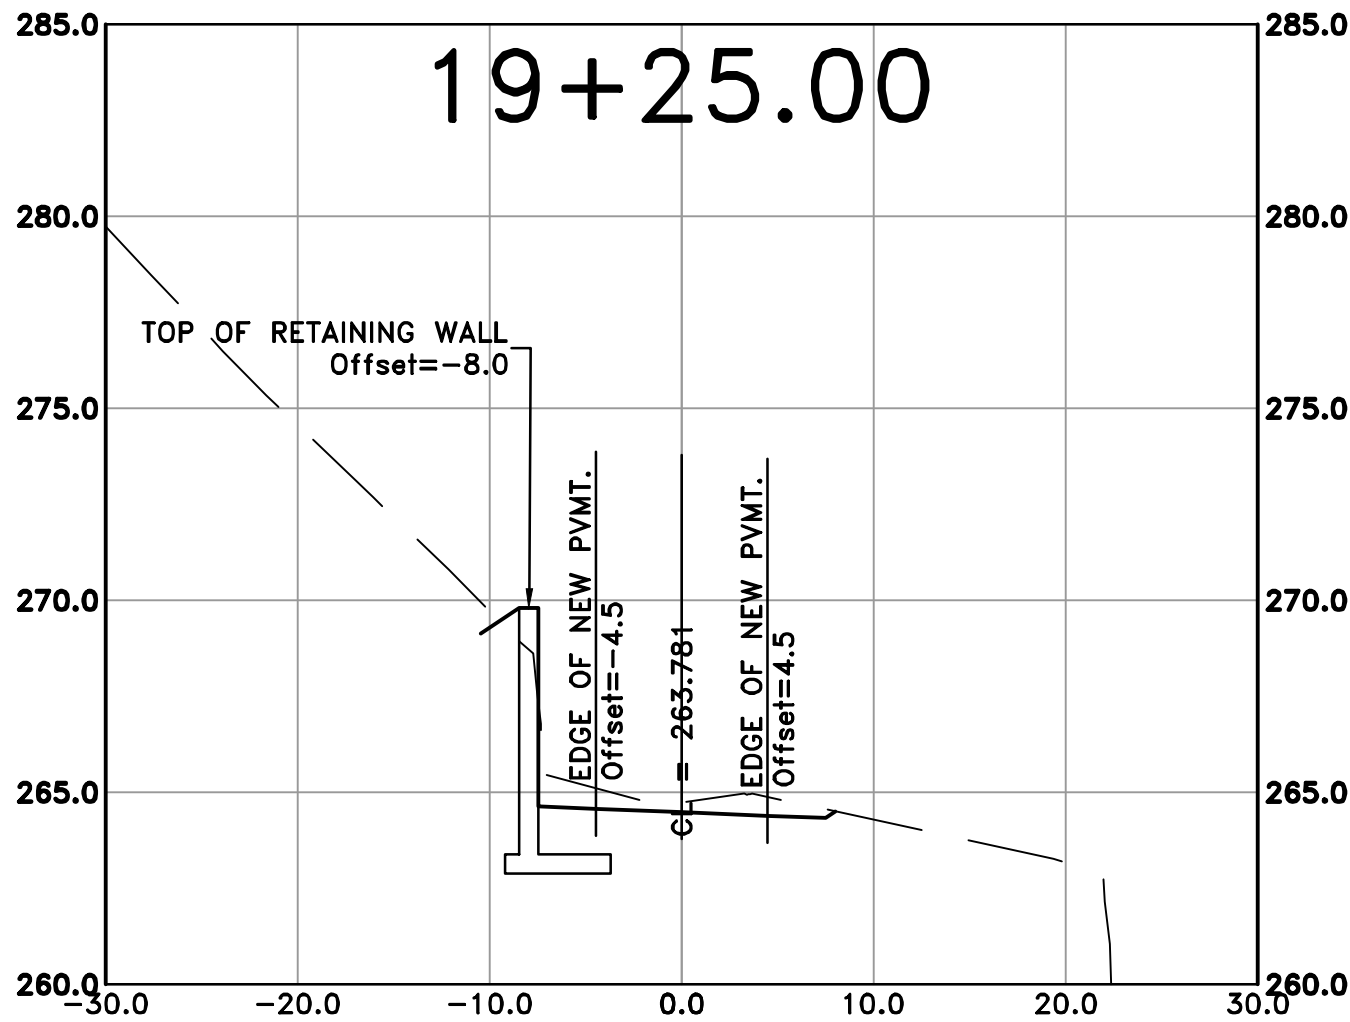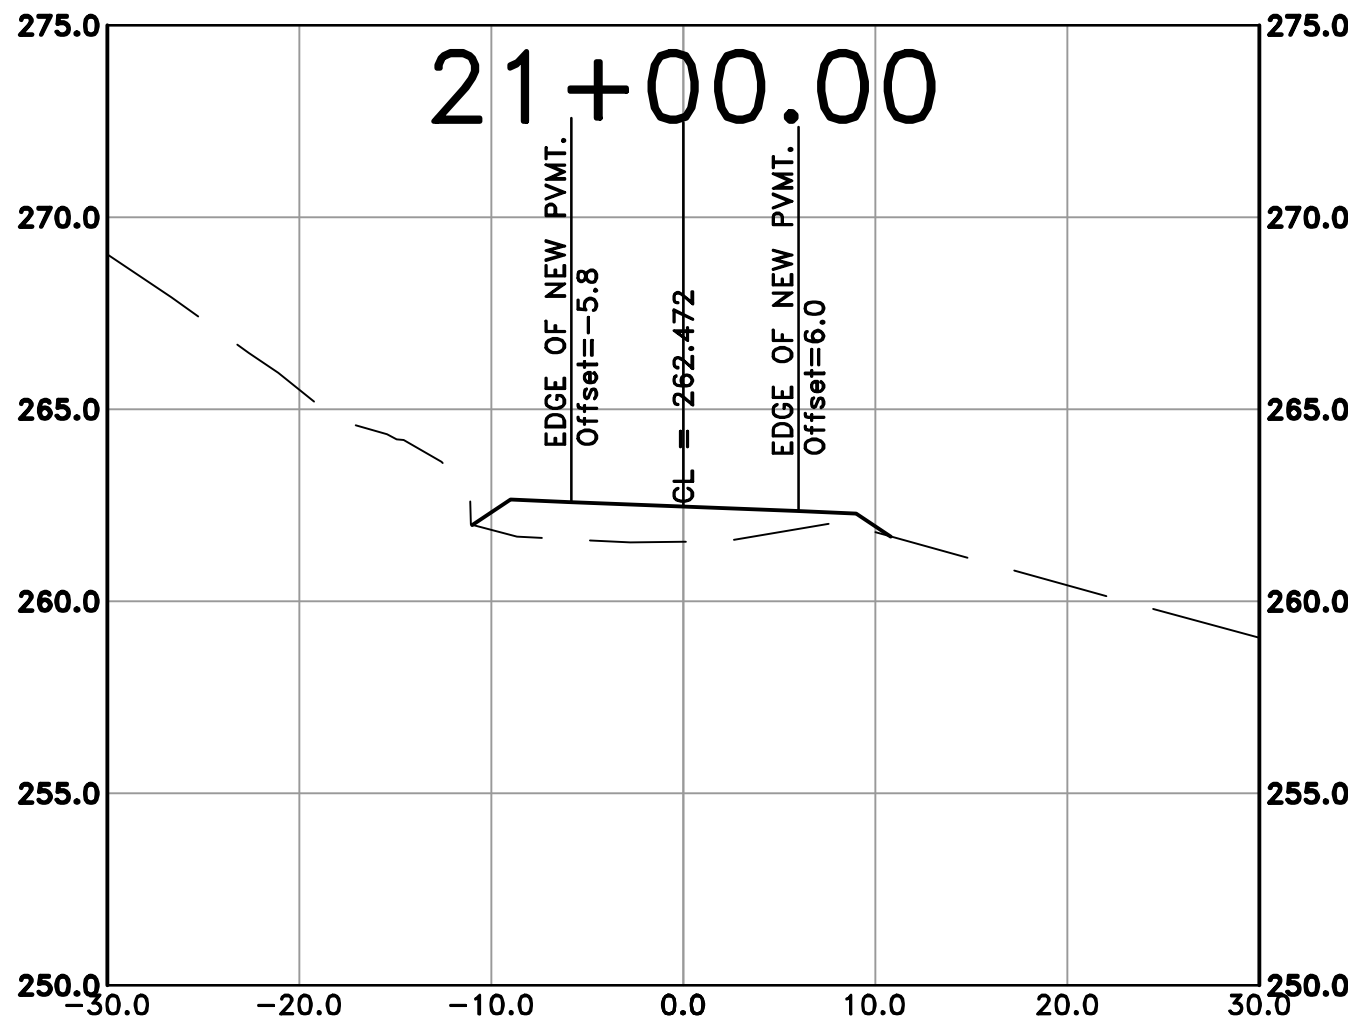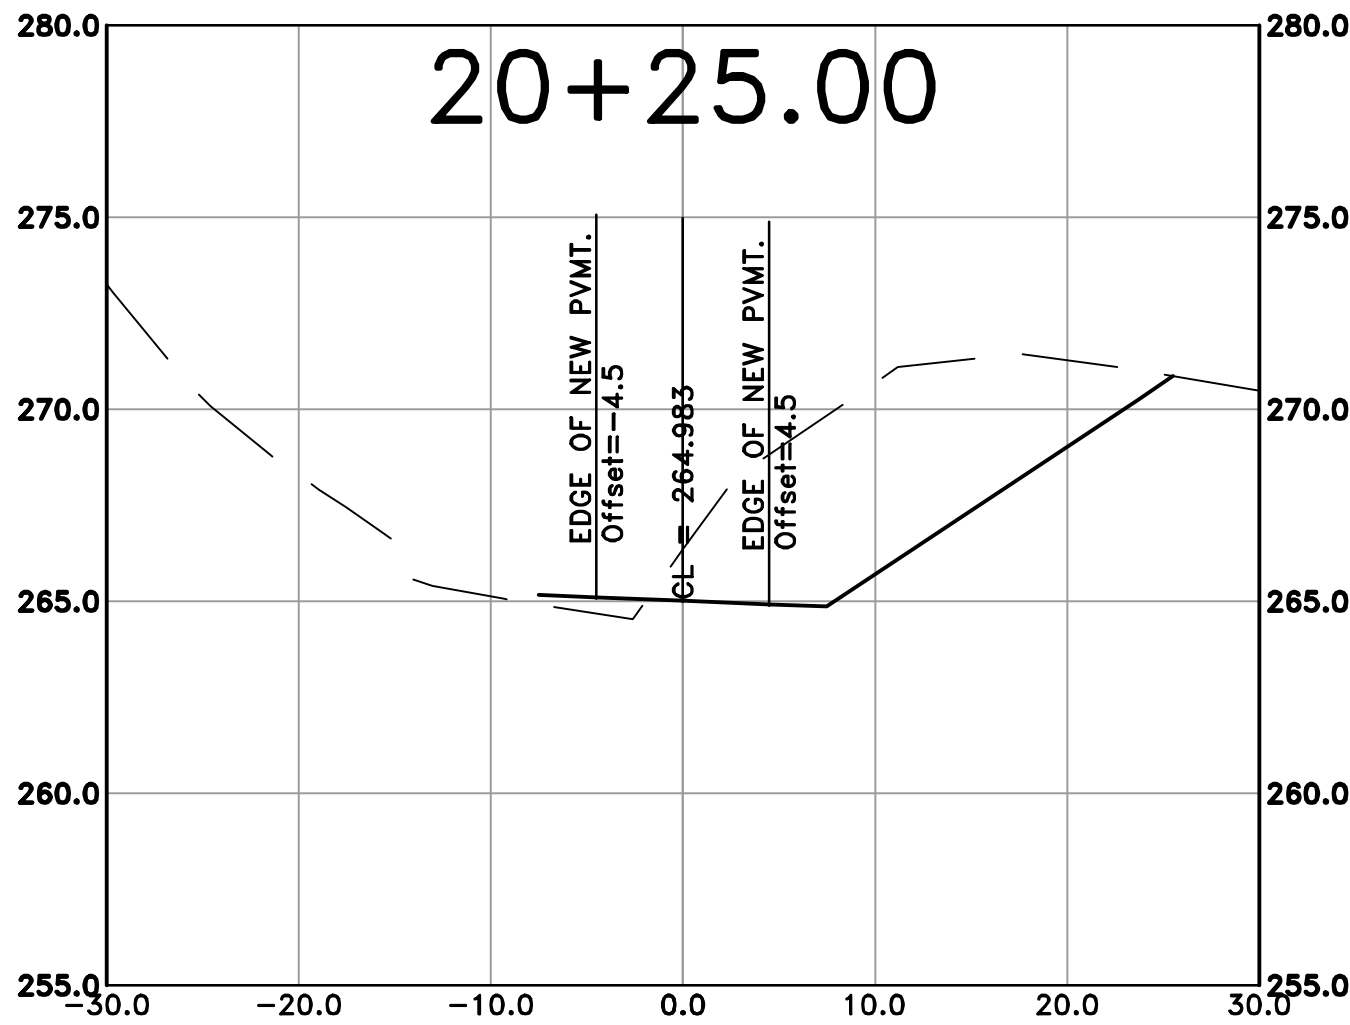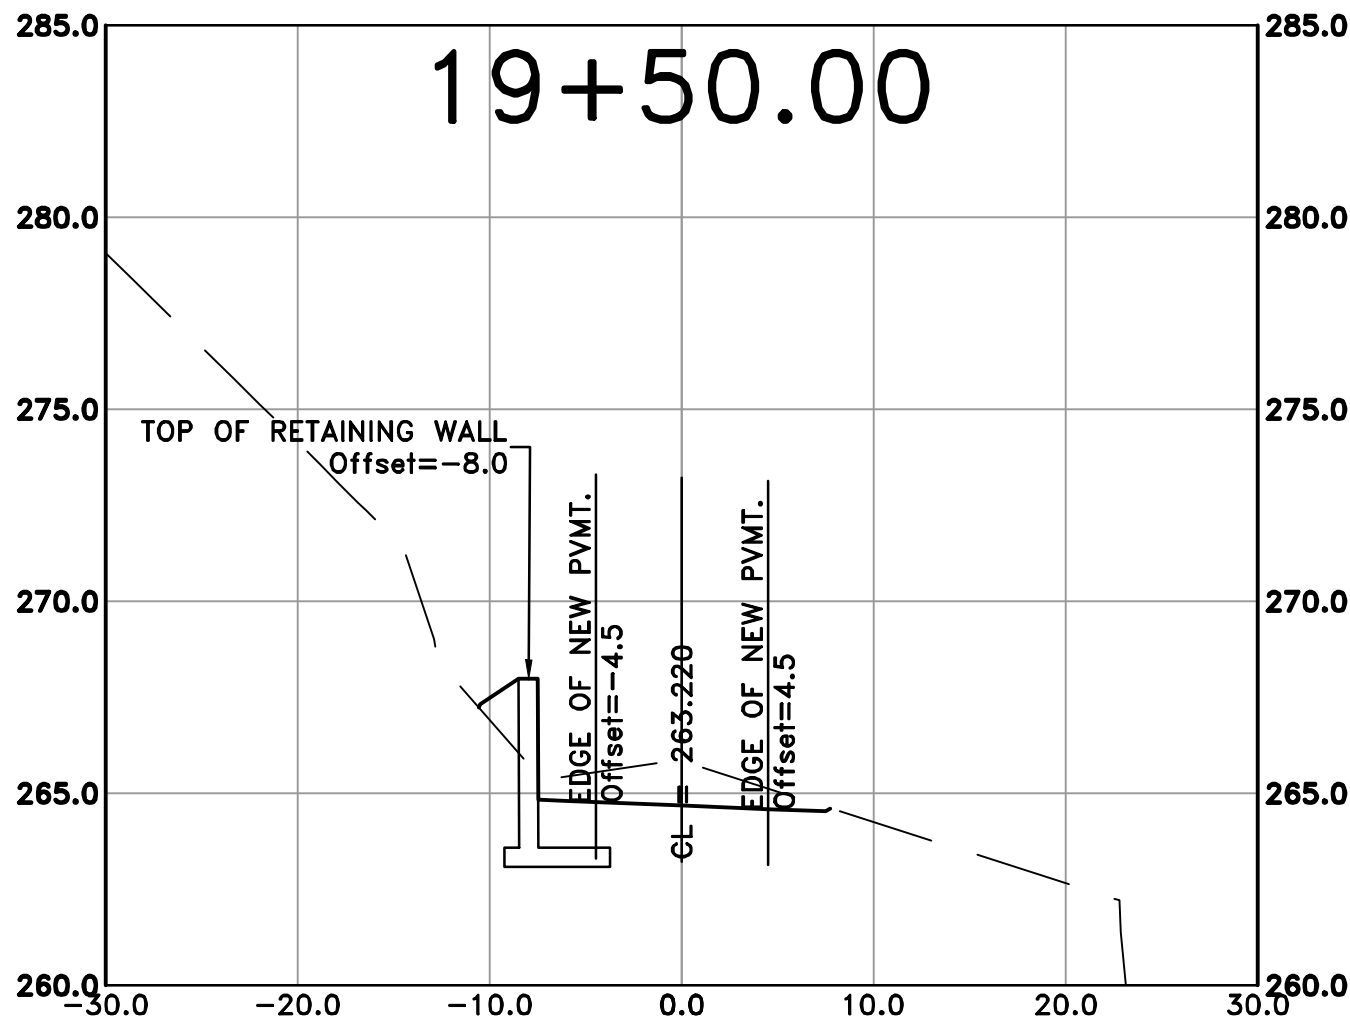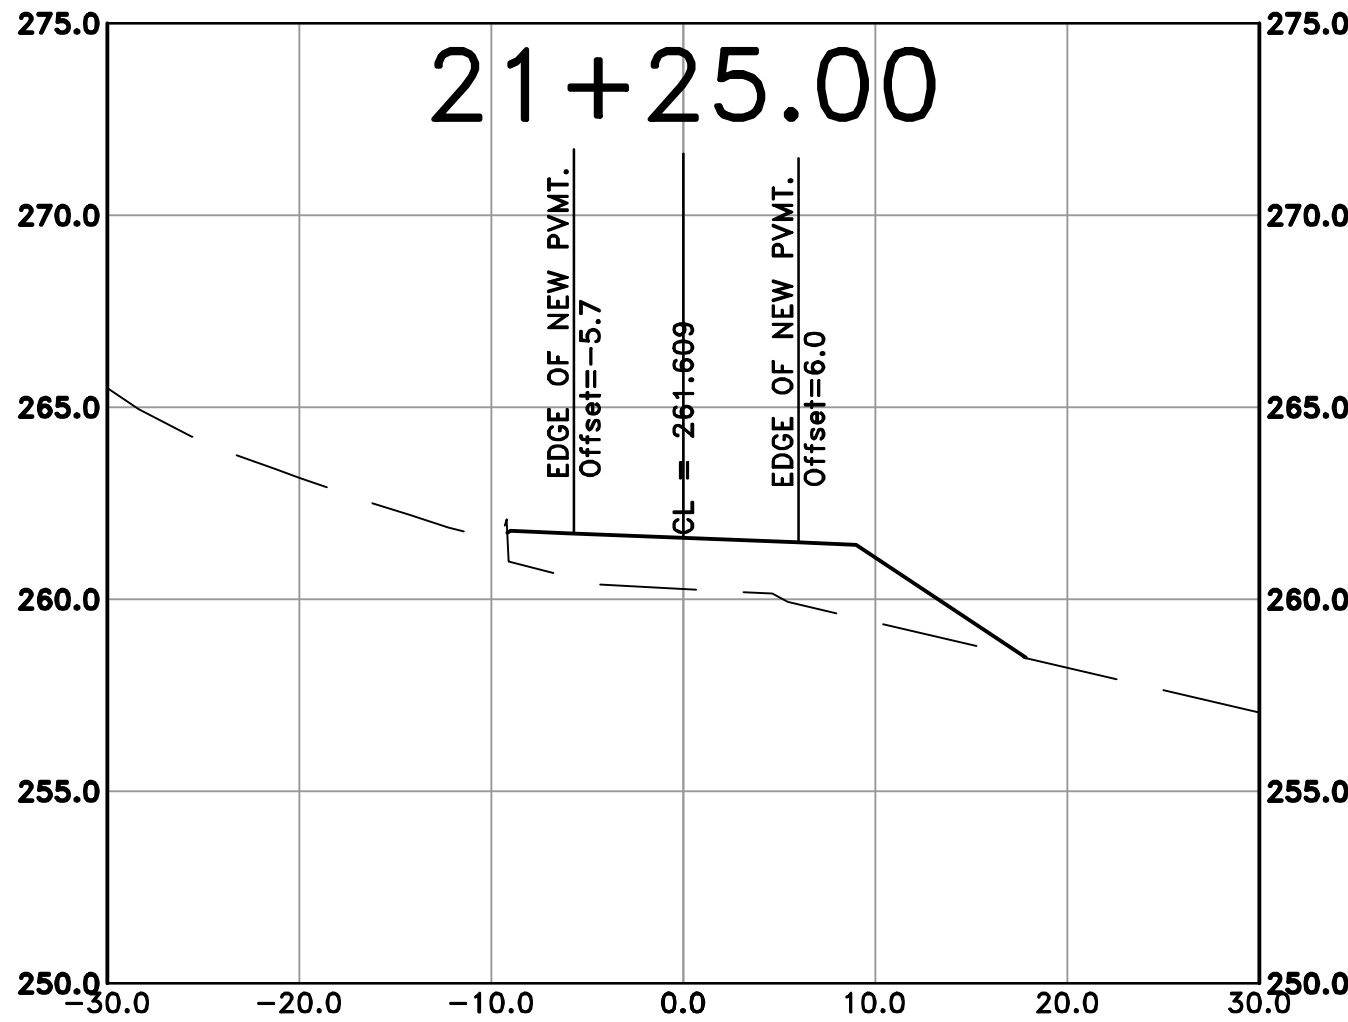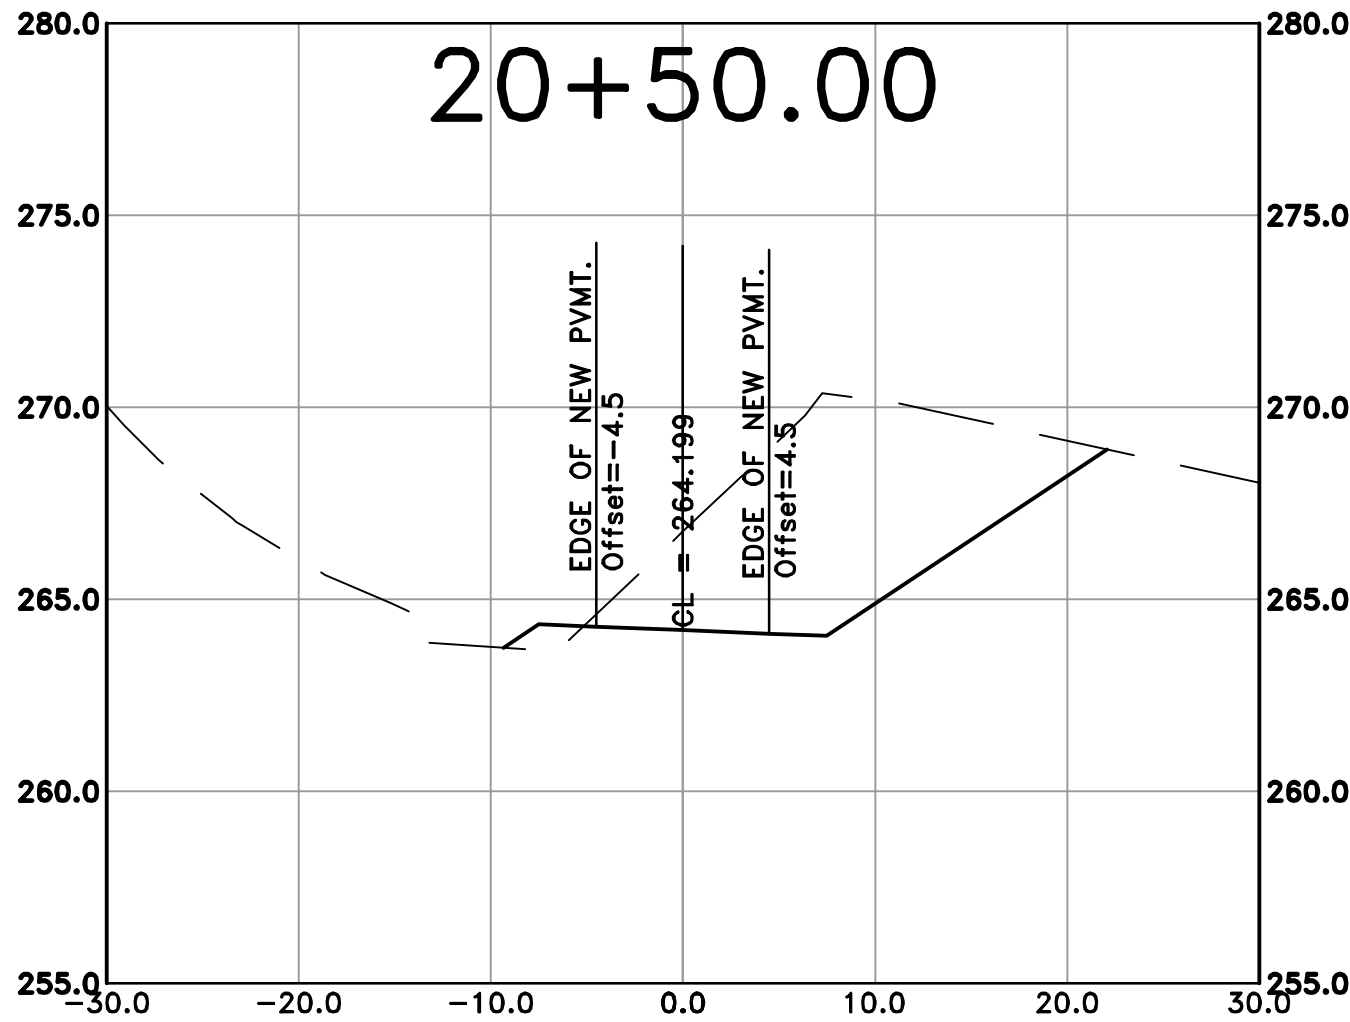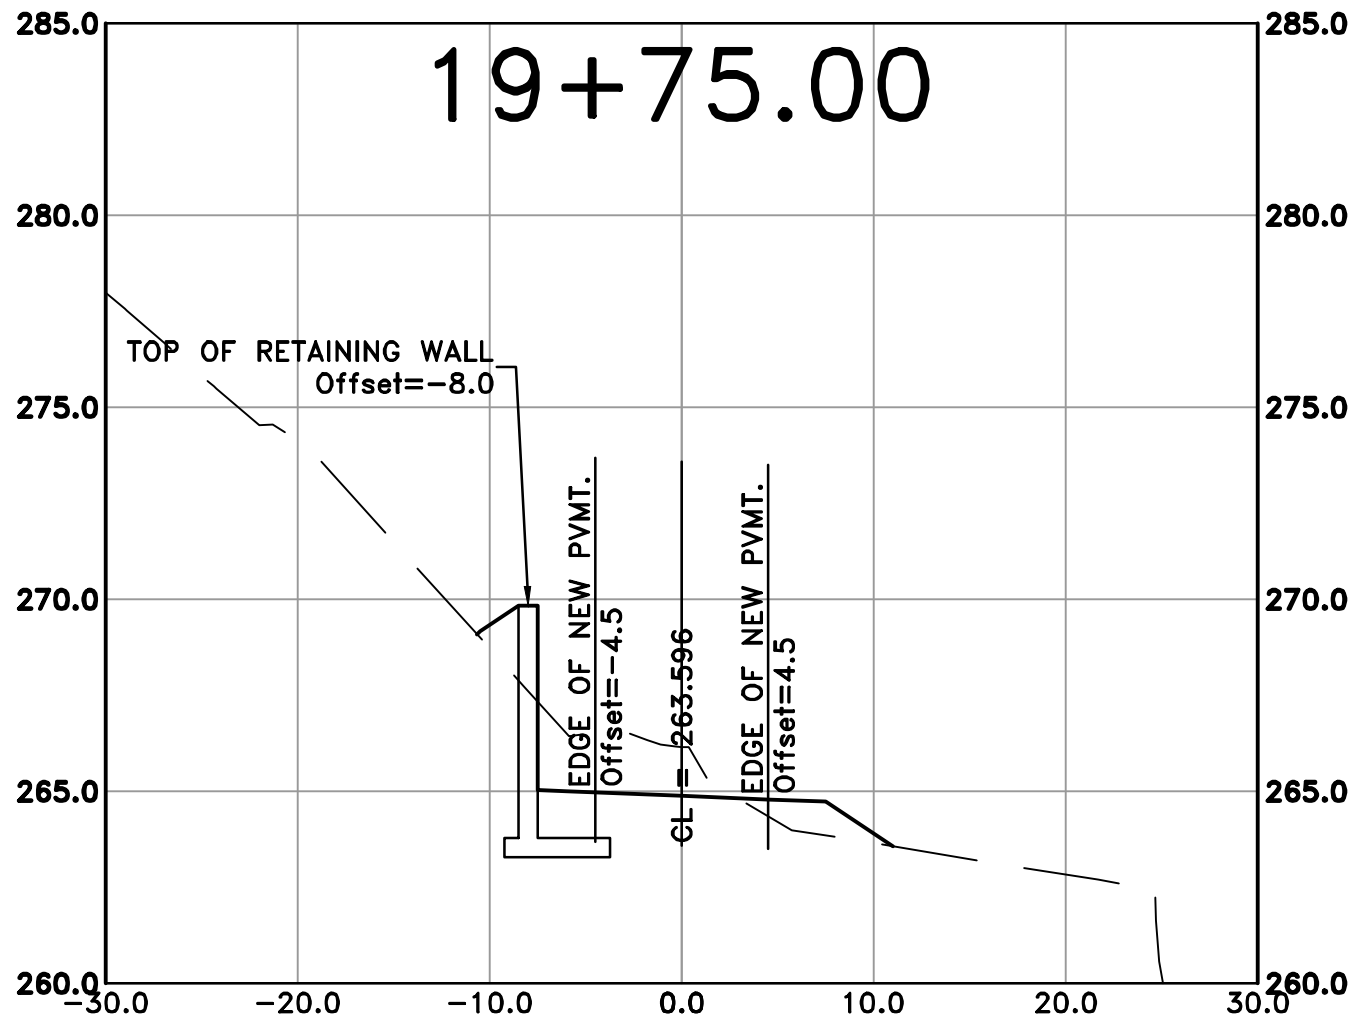

REVISIONS	DATE










CITY OF LITTLE ROCK, ARKANSAS
ROSE CREEK TRAIL
CROSS SECTION SHEET 5

DEPARTMENT OF PUBLIC WORKS
CIVIL ENGINEERING
701 W. MARKHAM
LITTLE ROCK, ARKANSAS 72201



DRAWN BY	AS
DESIGNED	LC
CHECKED	JM
DATE	05-01-2026
SCALE	H: 1"=40' 10' V: 1"=10'
PROJECT NO.	23805201
SHEET NO.	C54

100% SUBMITTAL

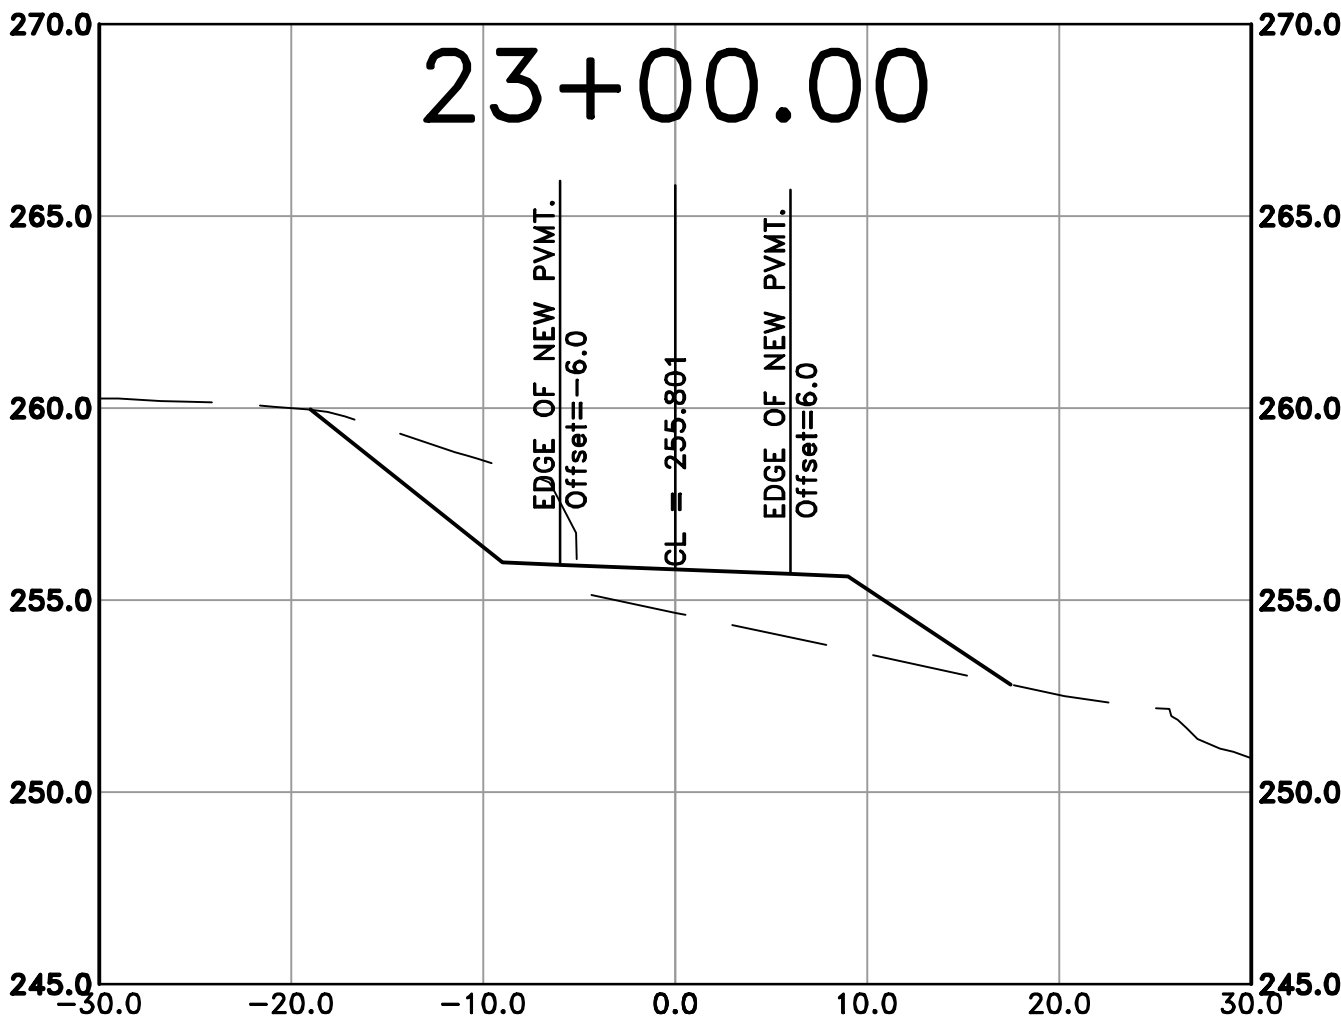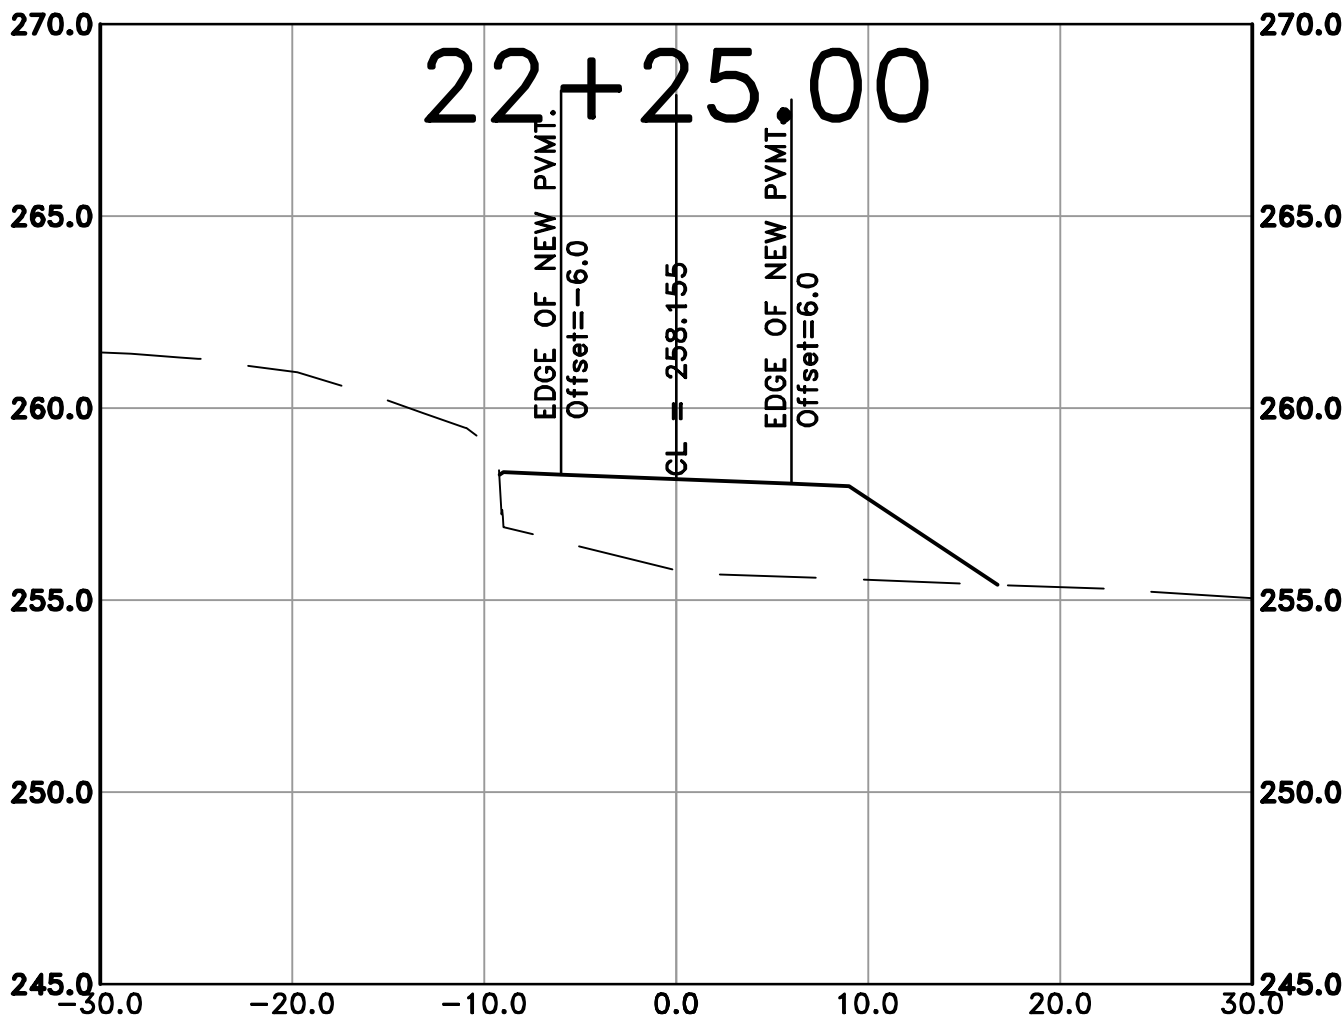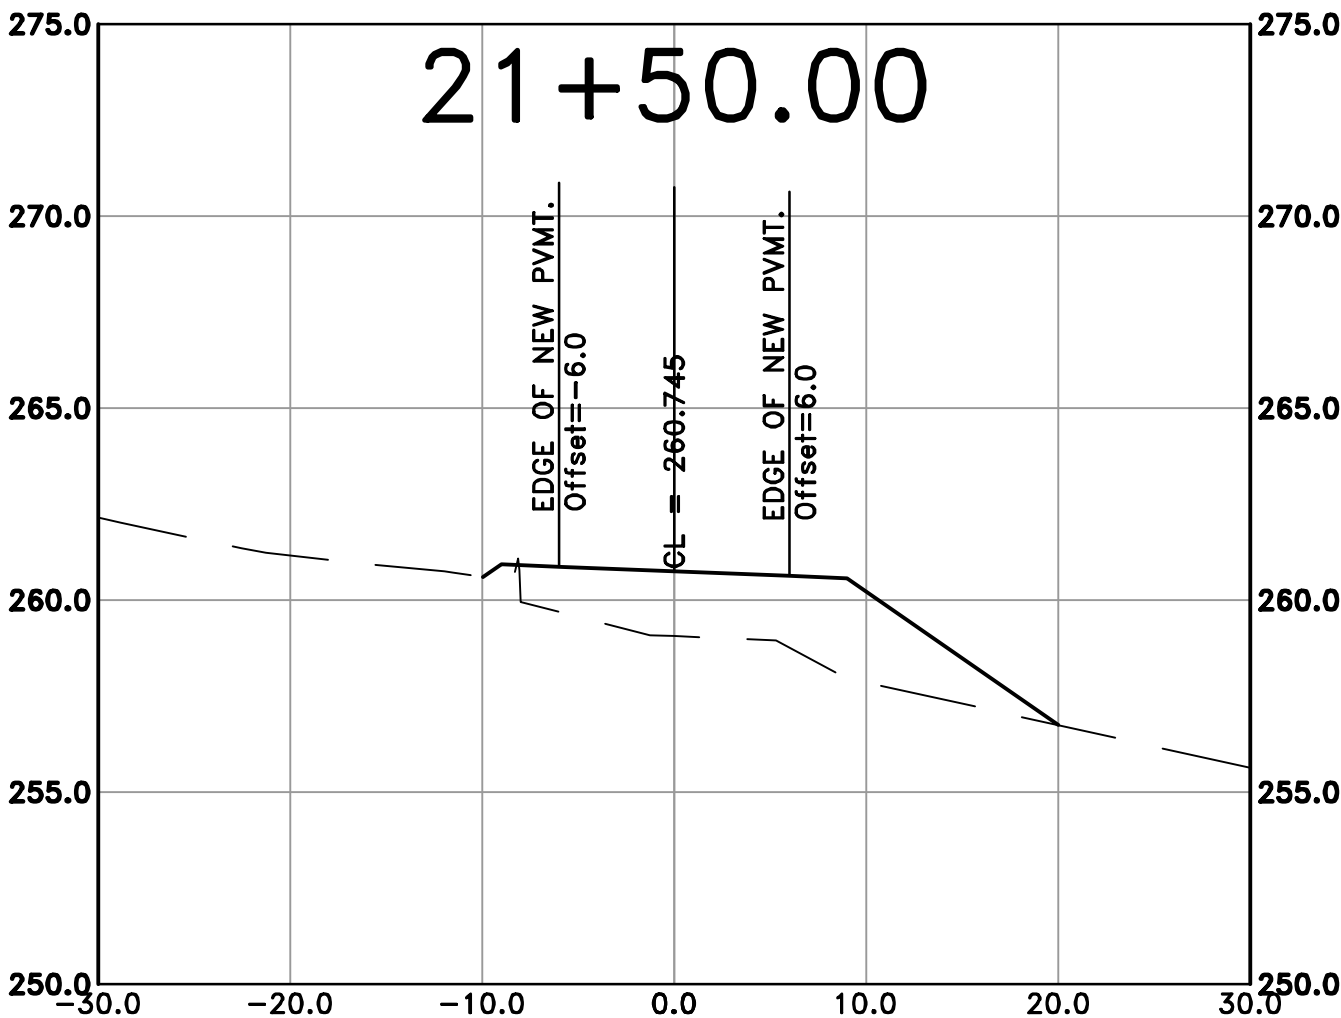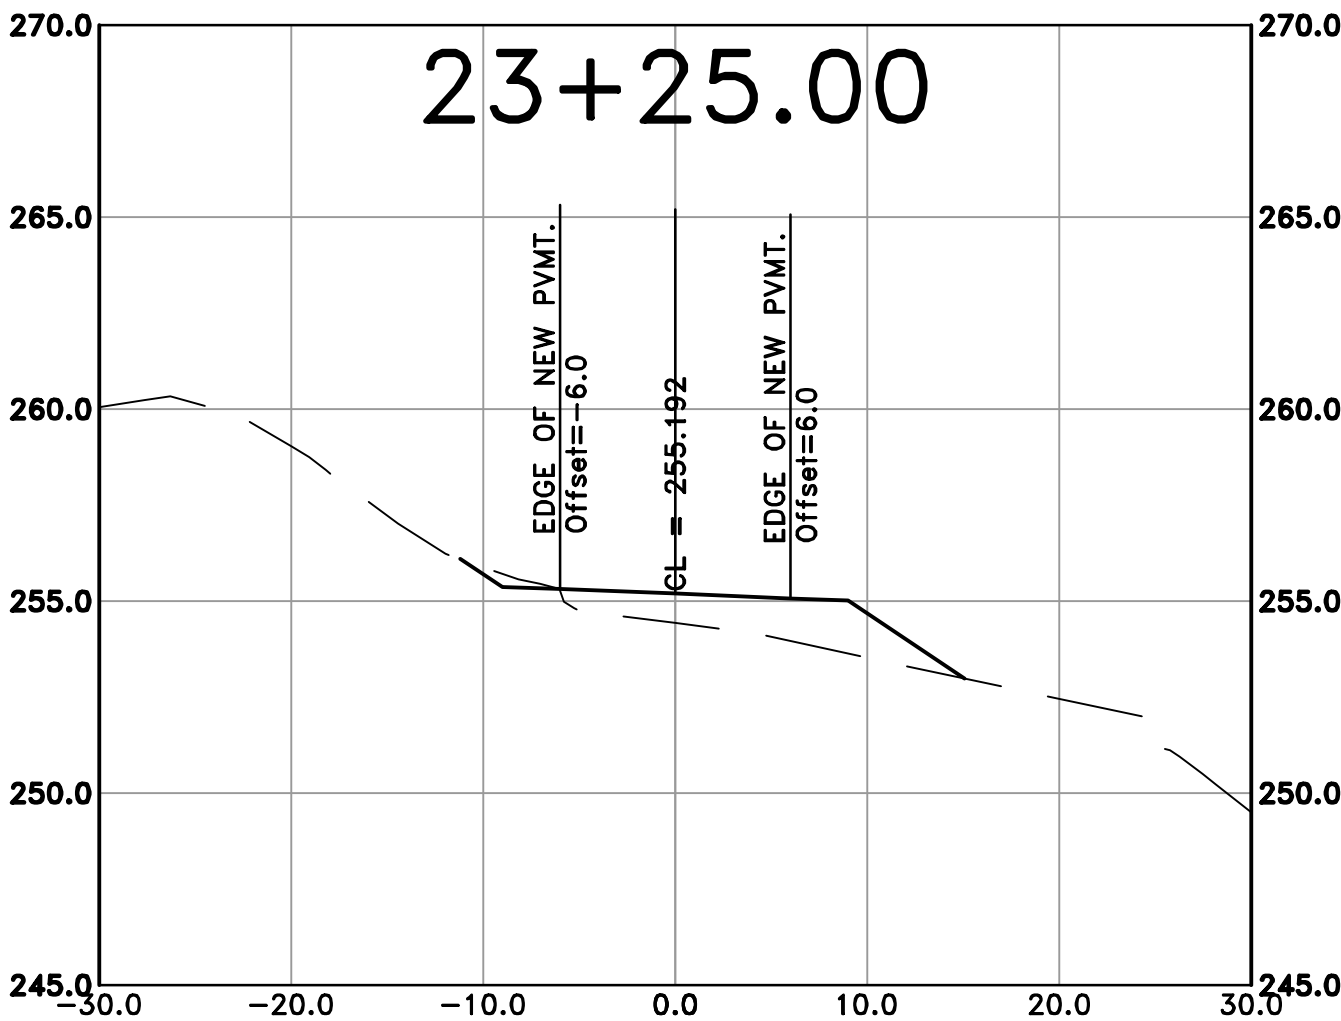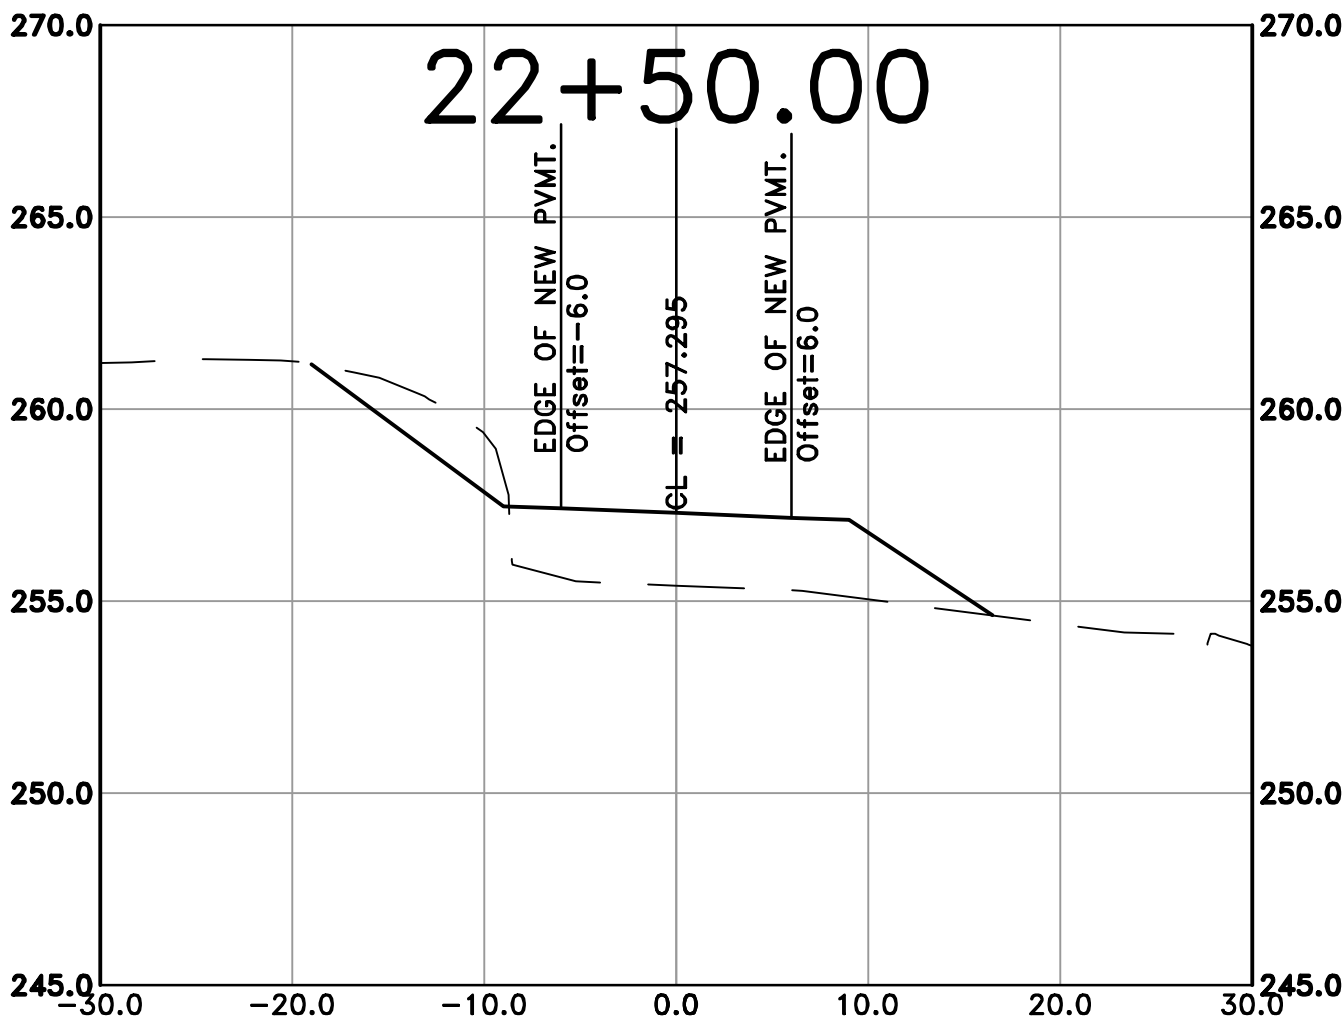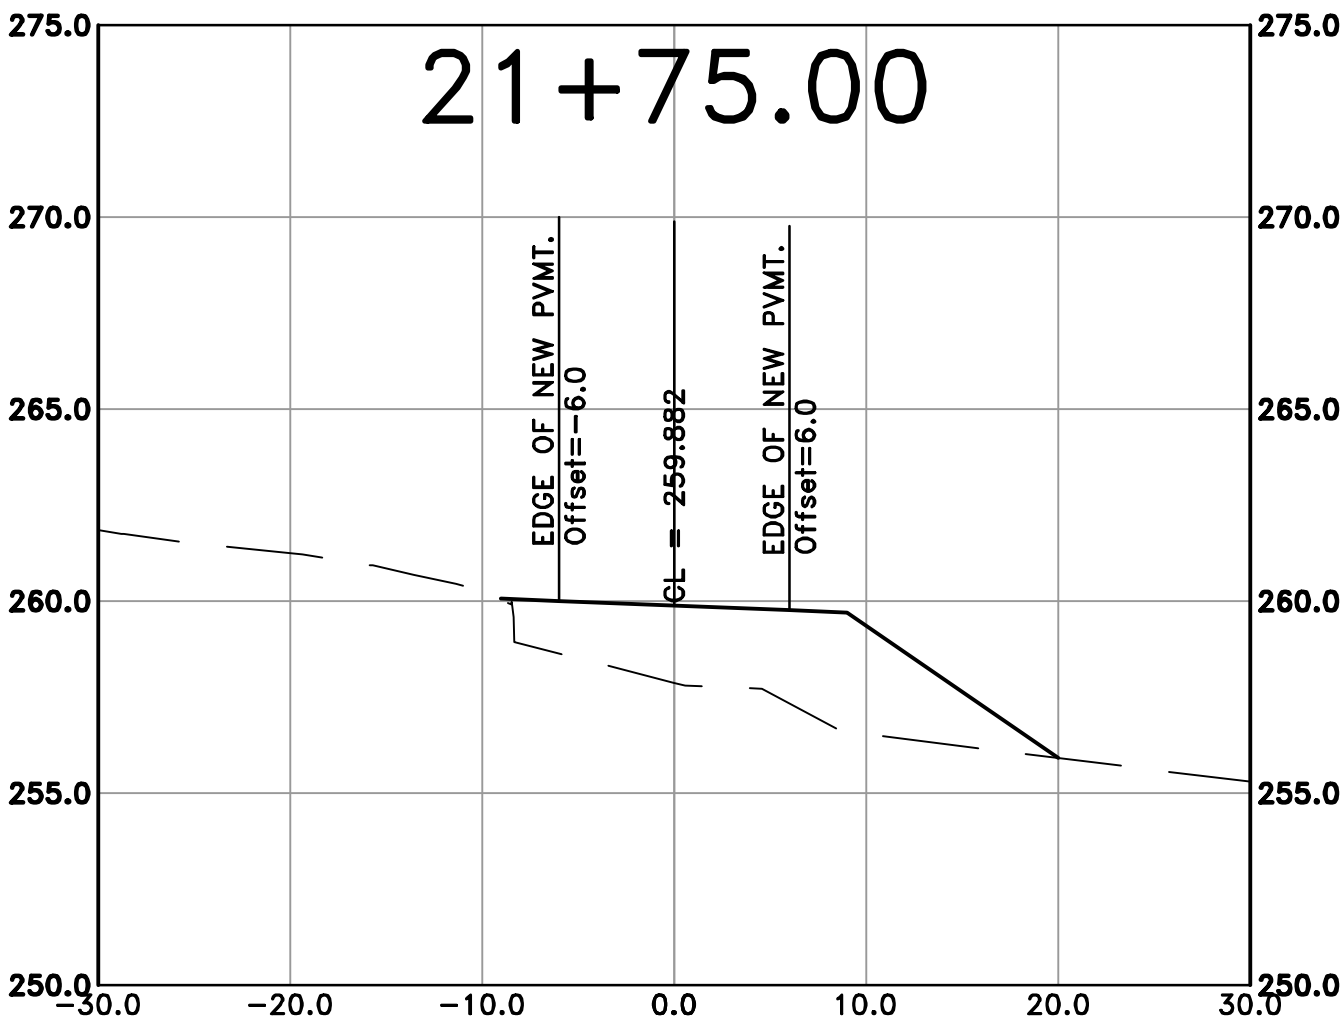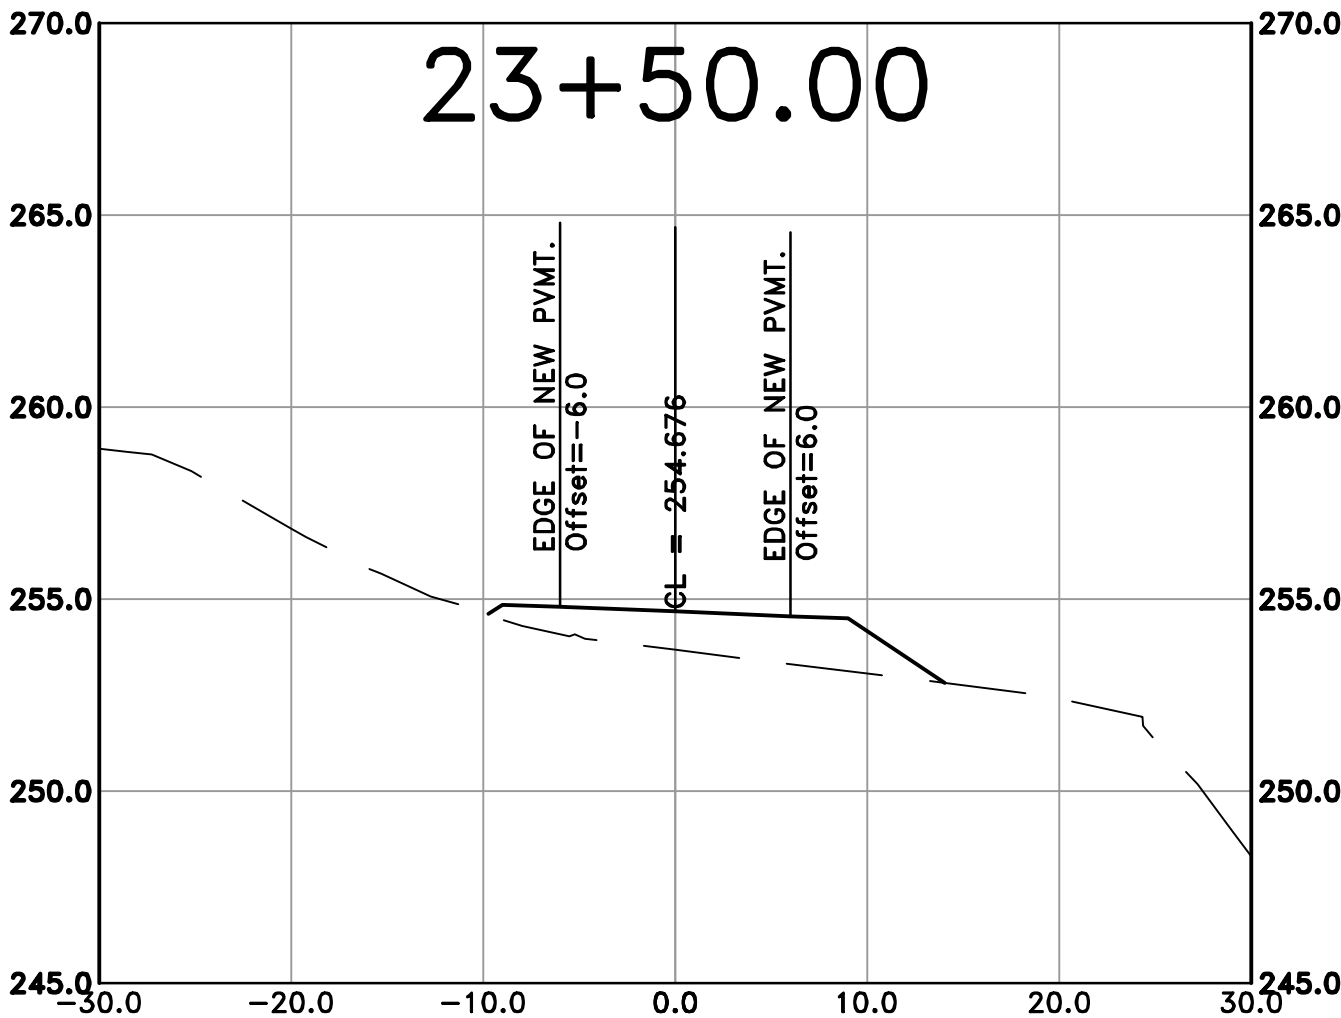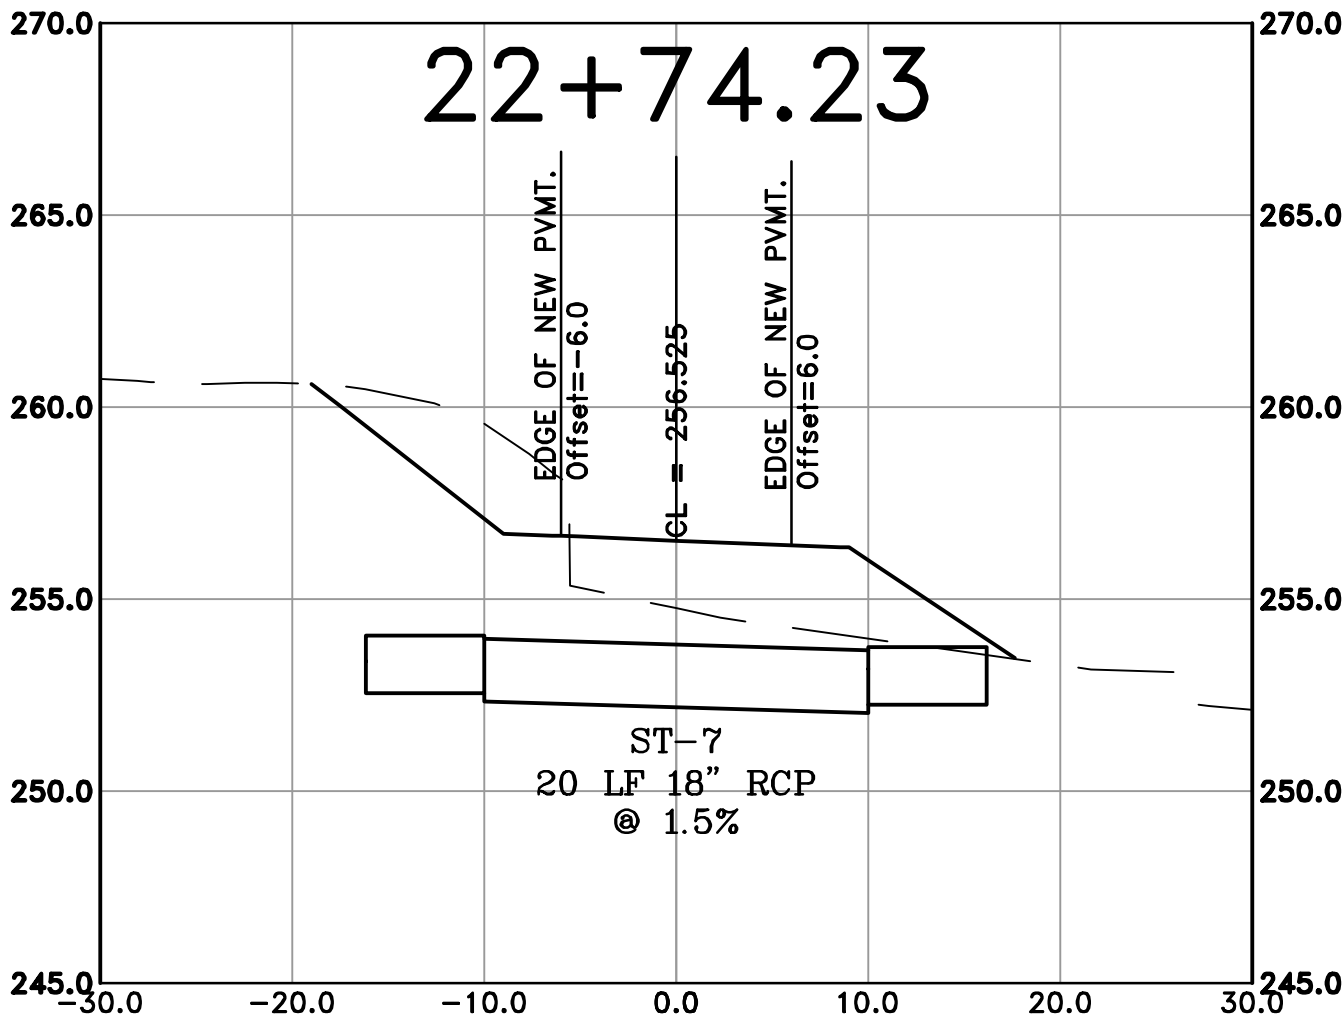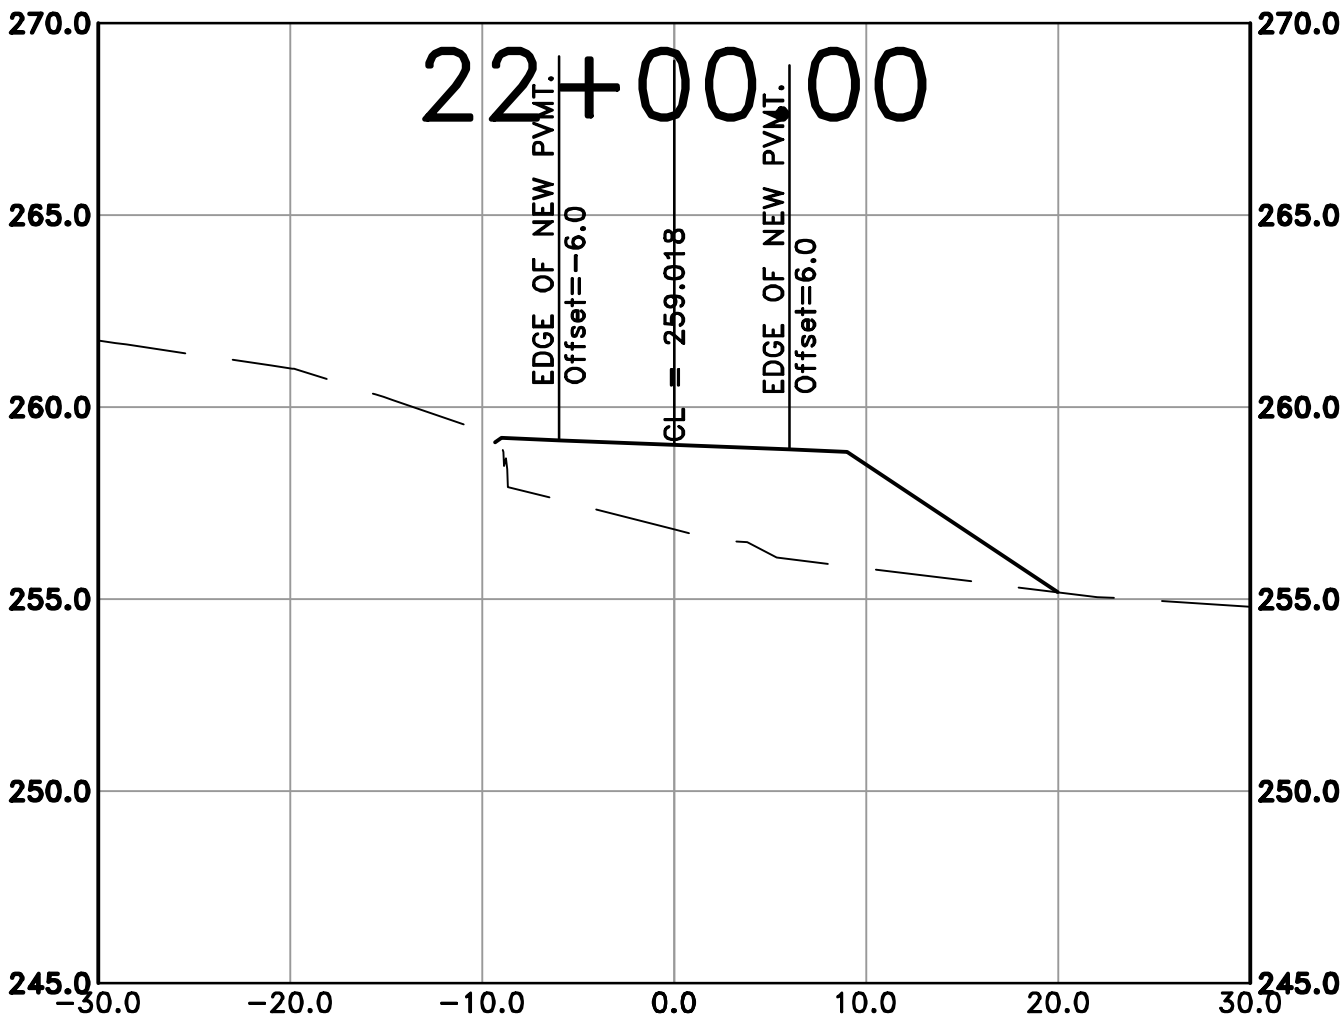

REVISIONS	DATE

CITY OF LITTLE ROCK, ARKANSAS

ROSE CREEK TRAIL

CROSS SECTION SHEET 6

DEPARTMENT OF PUBLIC WORKS

CIVIL ENGINEERING










701 W. MARKHAM

LITTLE ROCK, ARKANSAS 72201



DRAWN BY	AS
DESIGNED	LC
CHECKED	JM
DATE	05-01-2026
SCALE	H: 1"=40' 10'
V: 1"=40'	
PROJECT NO.	23805201
SHEET NO.	C55

100% SUBMITTAL

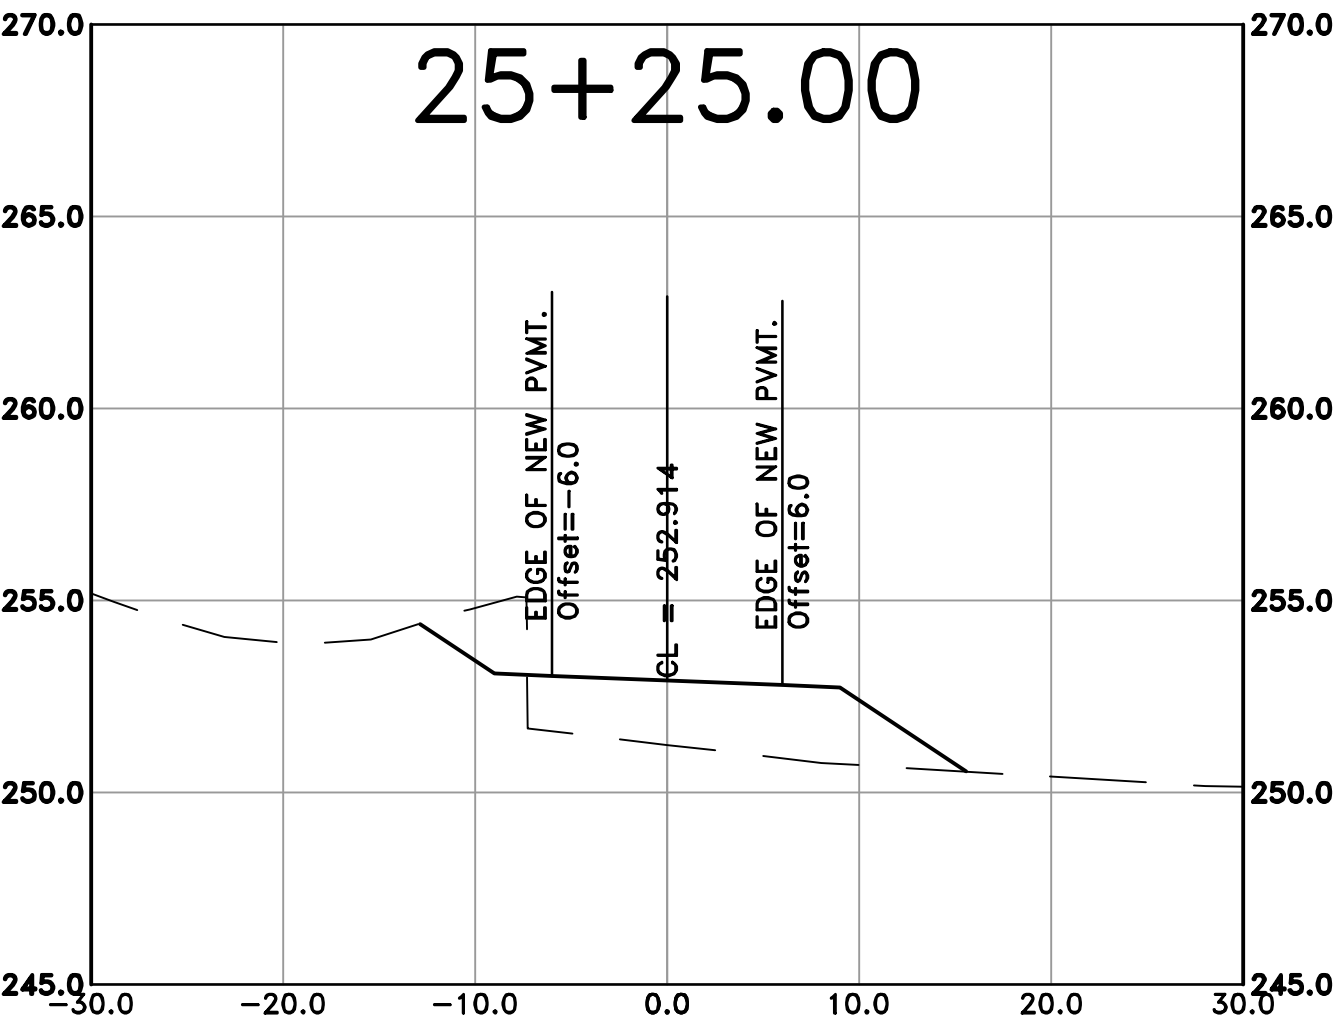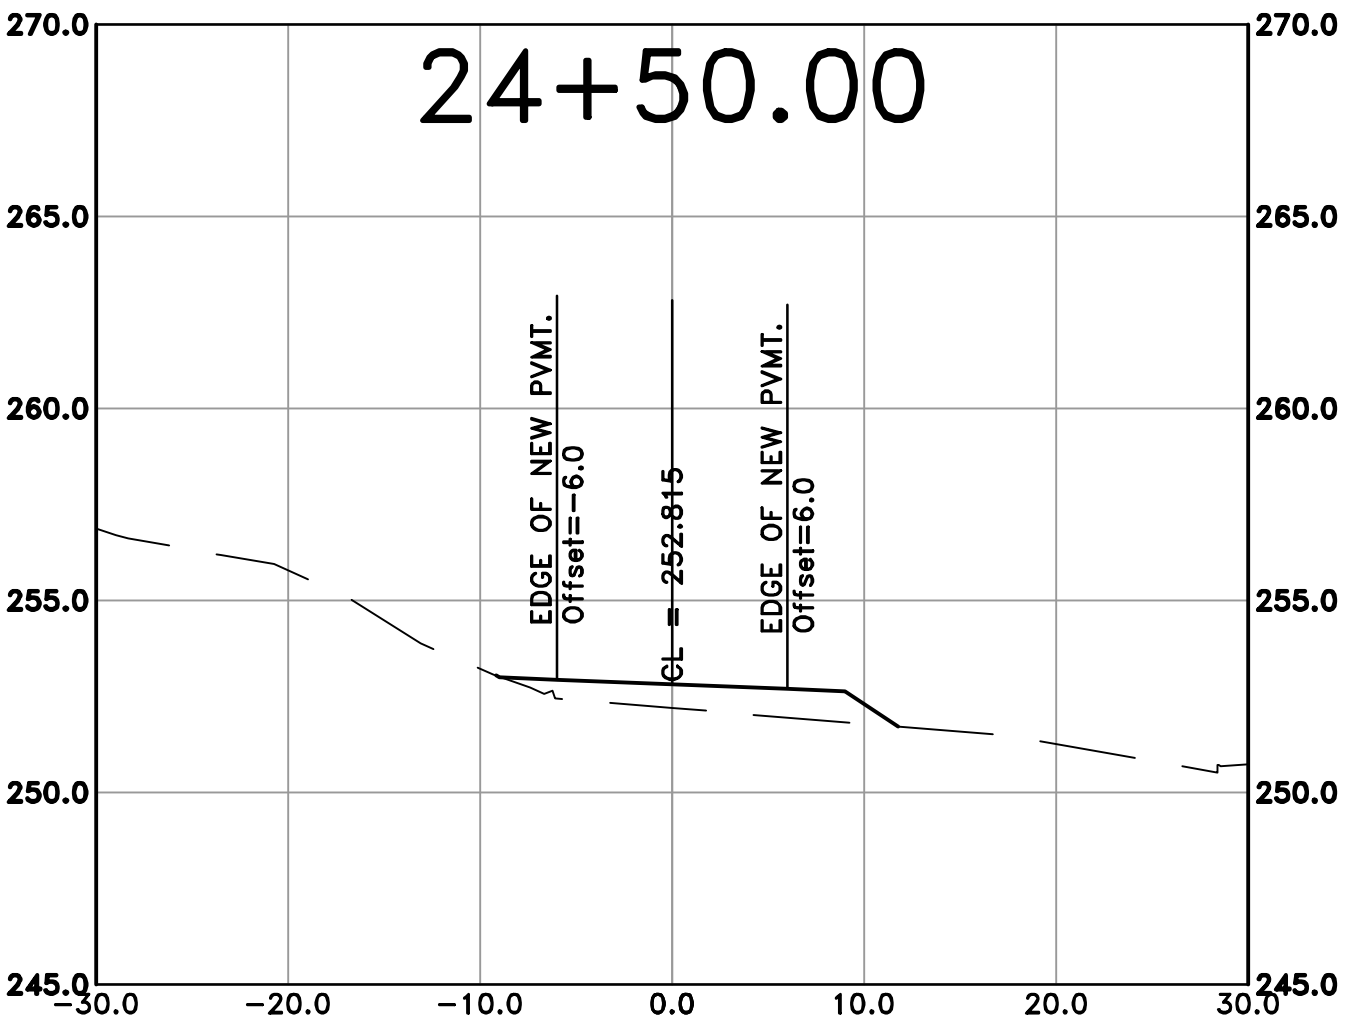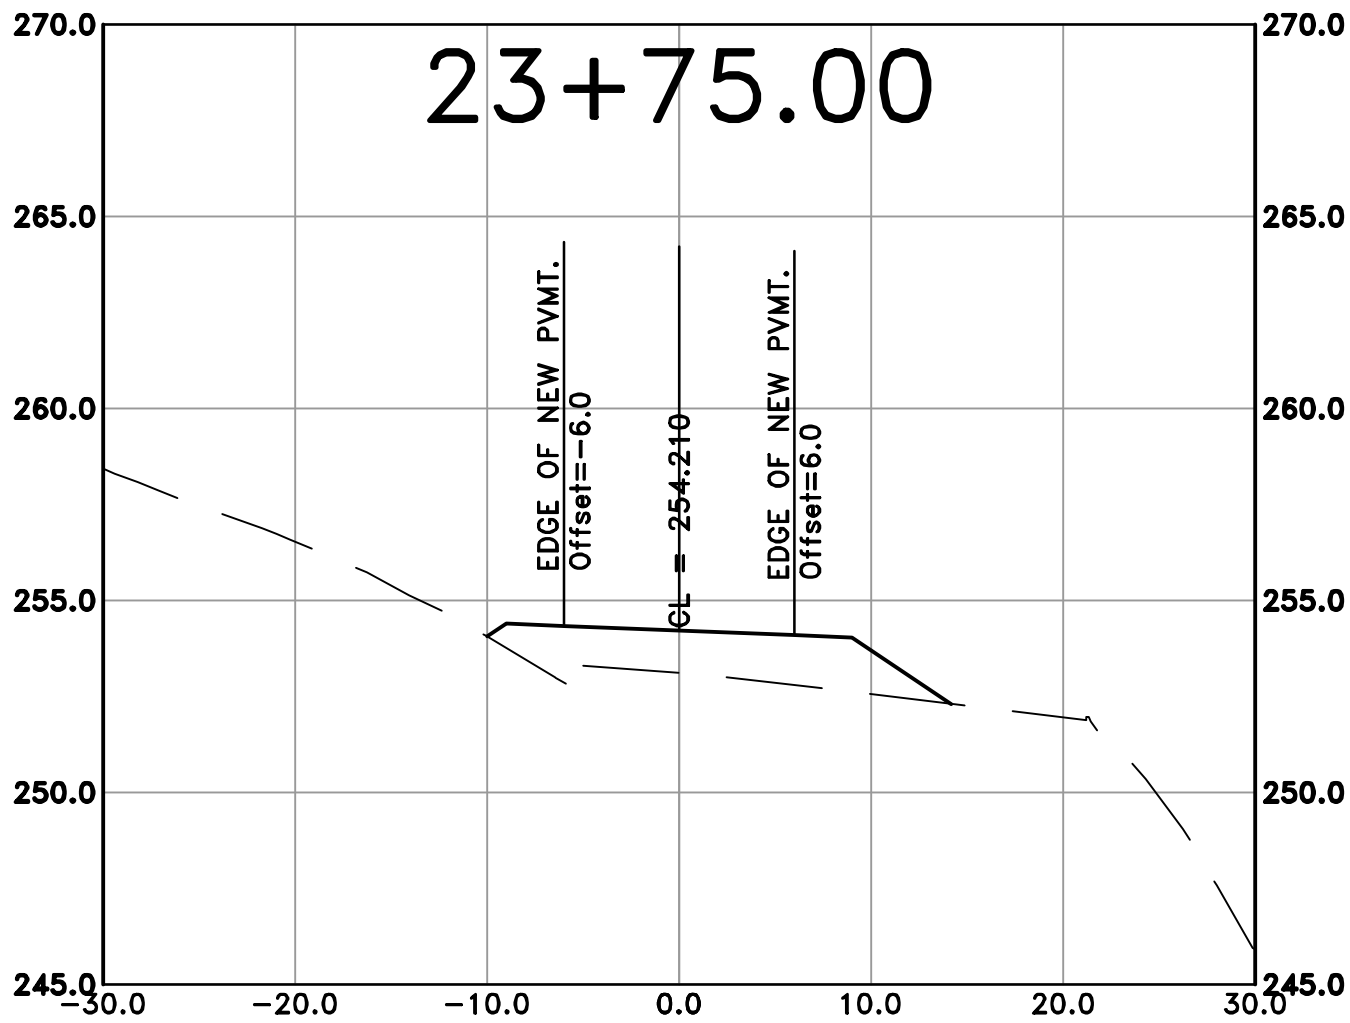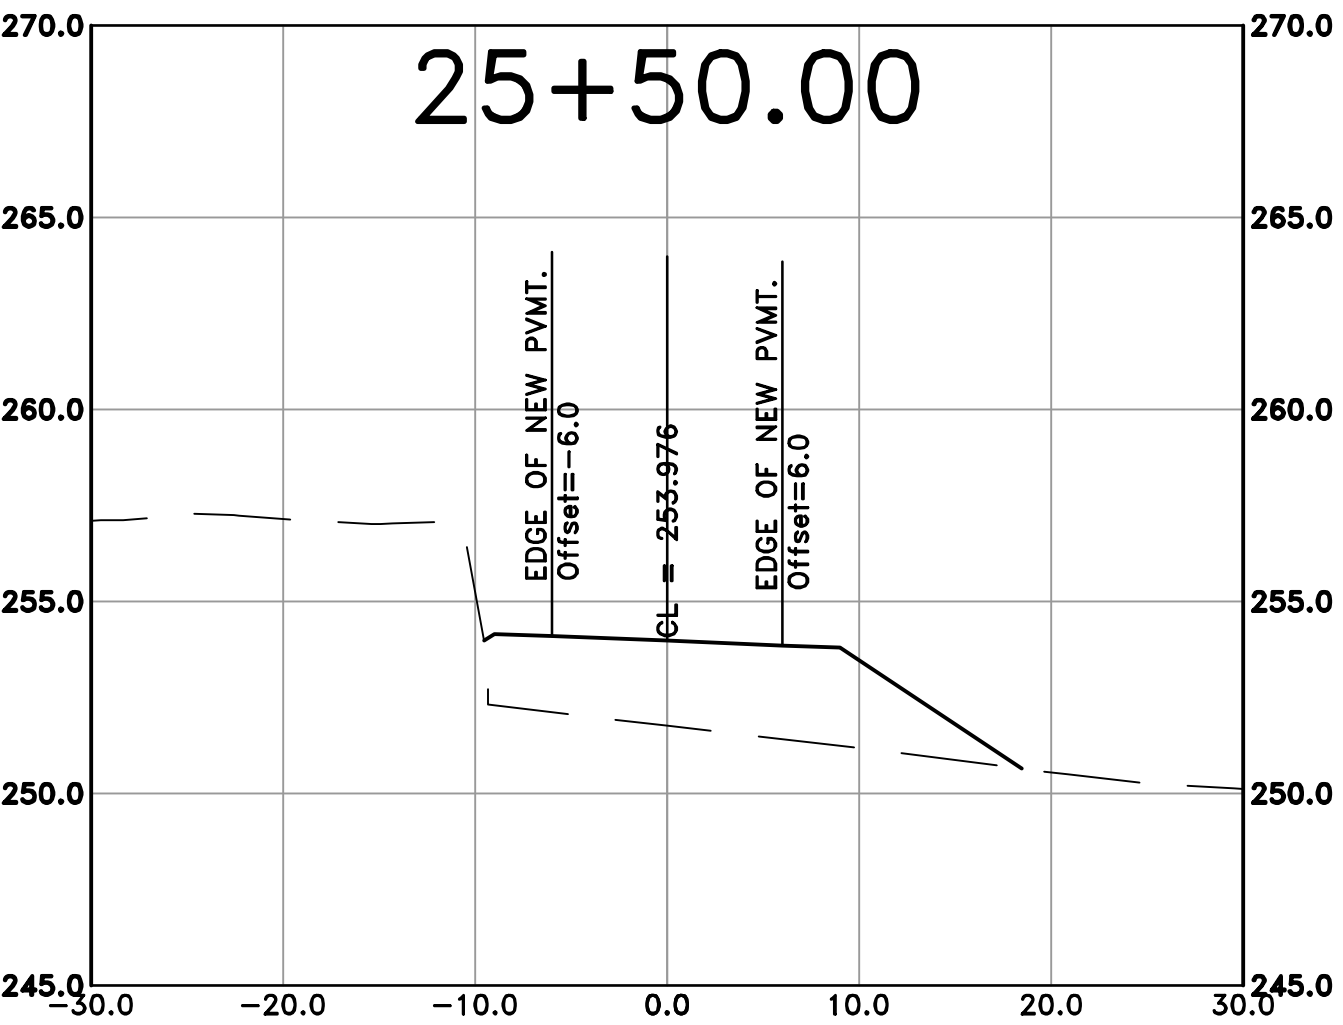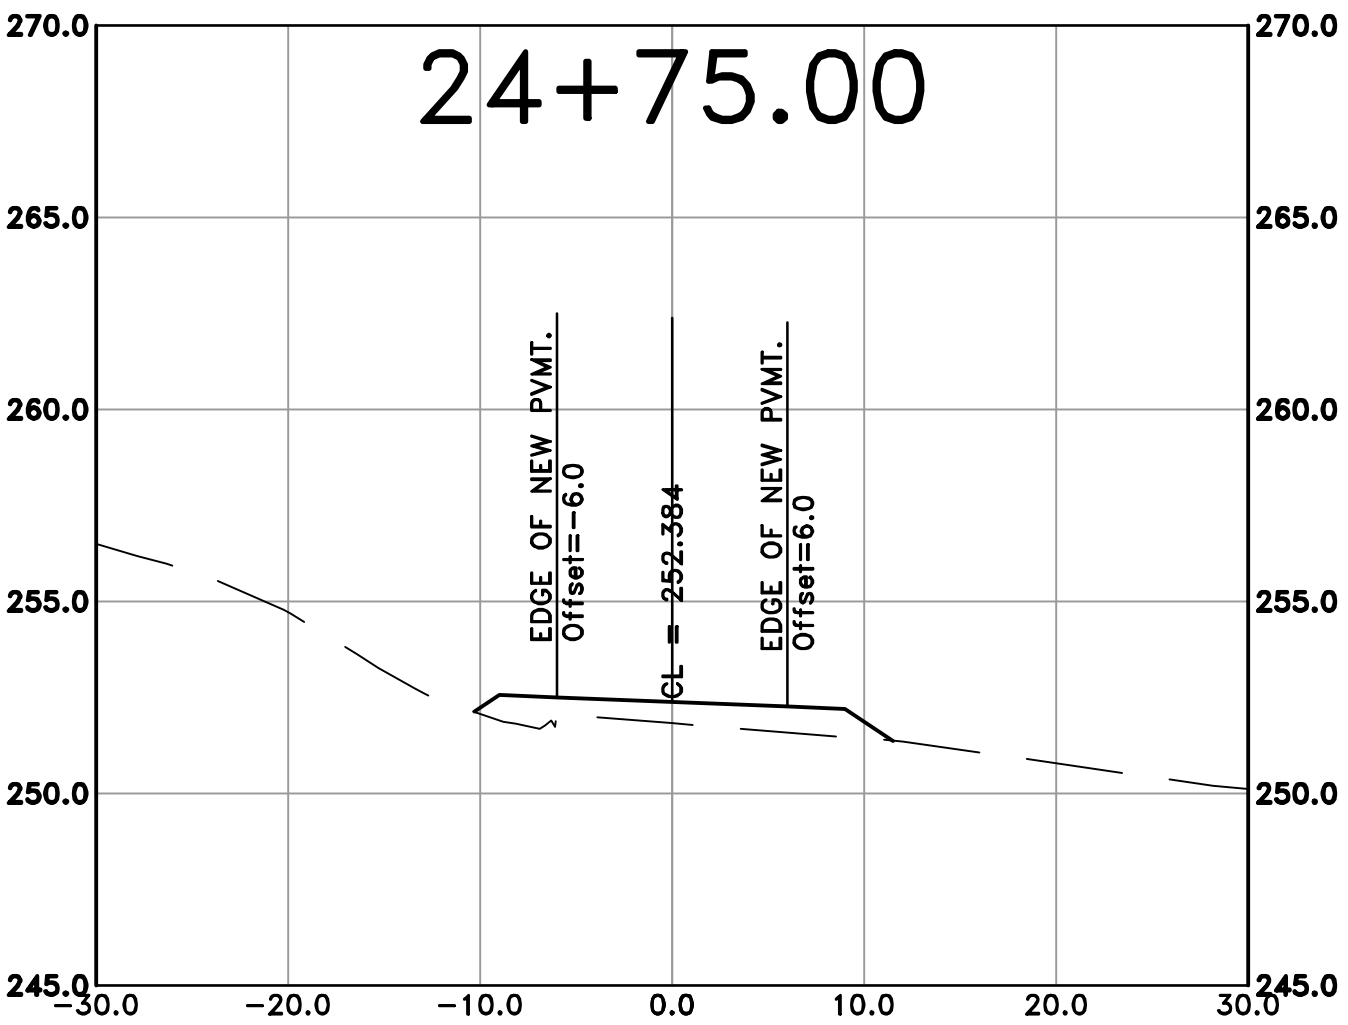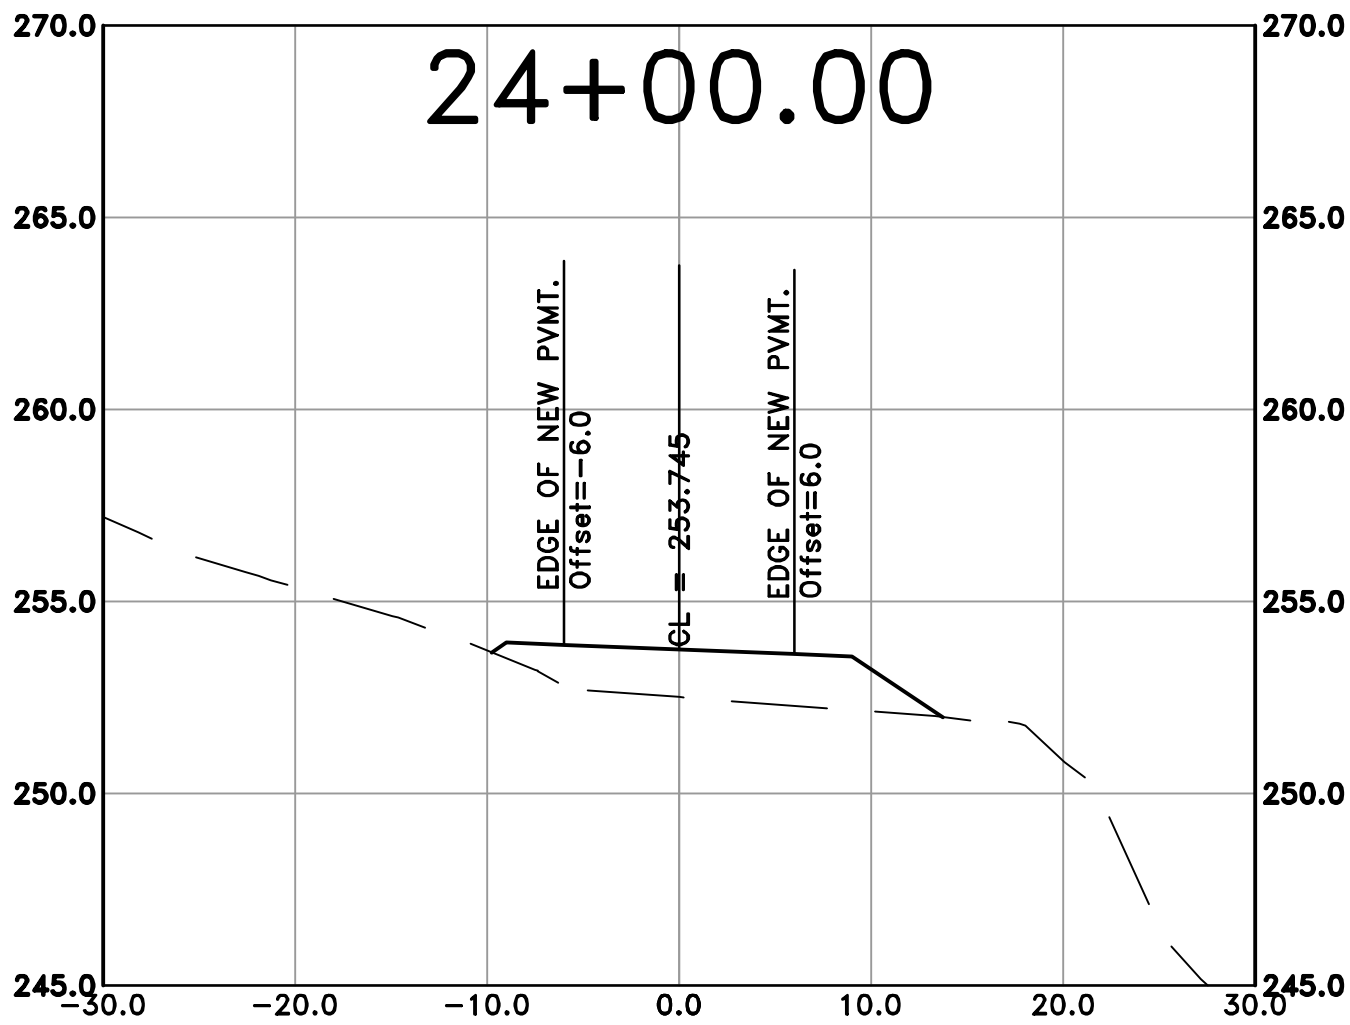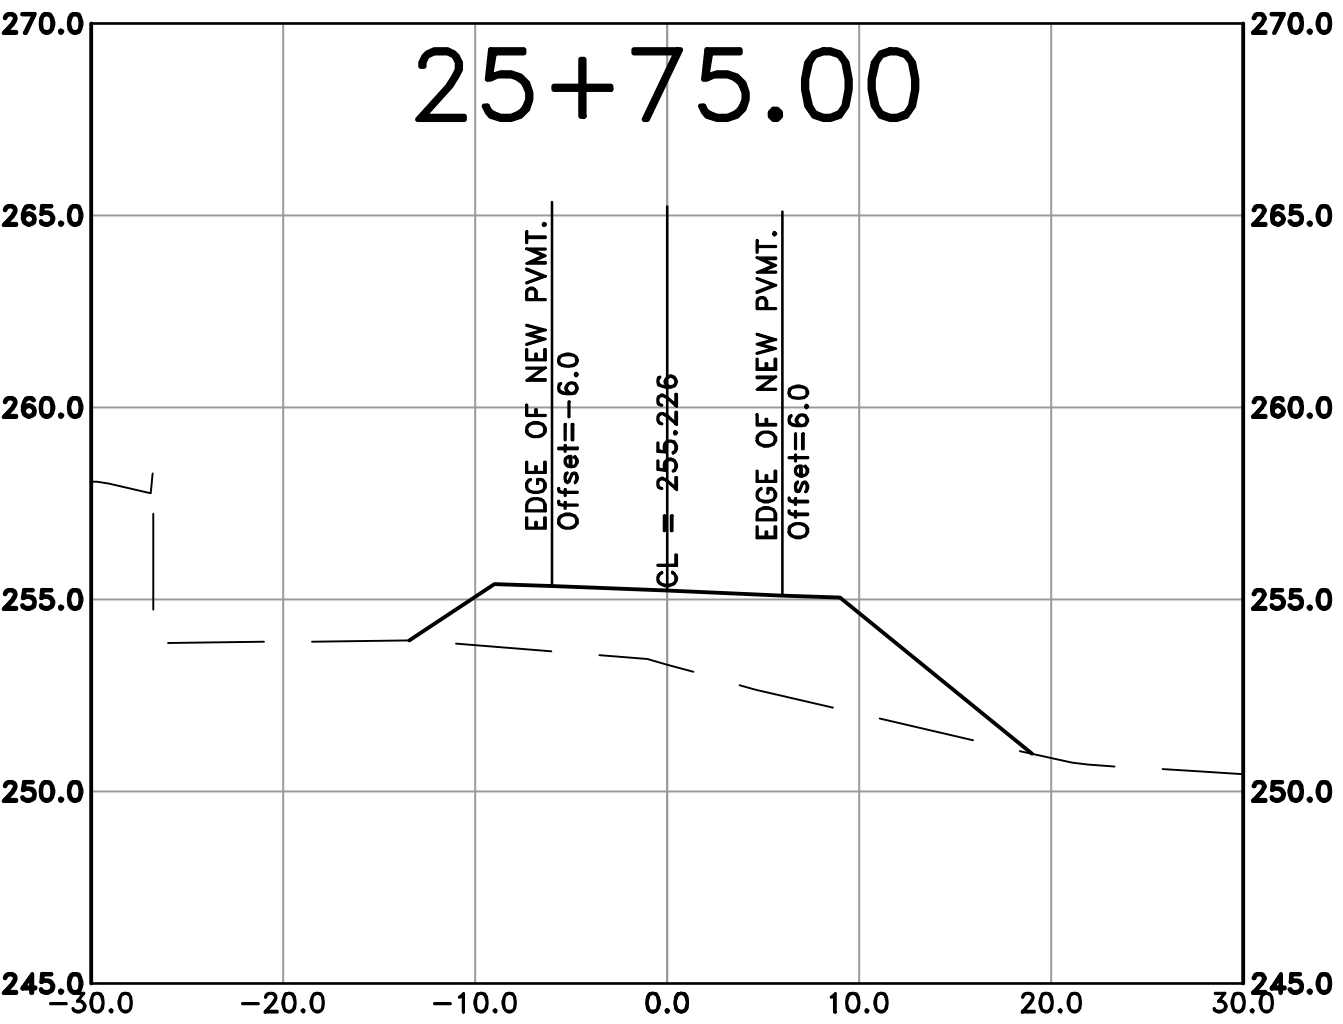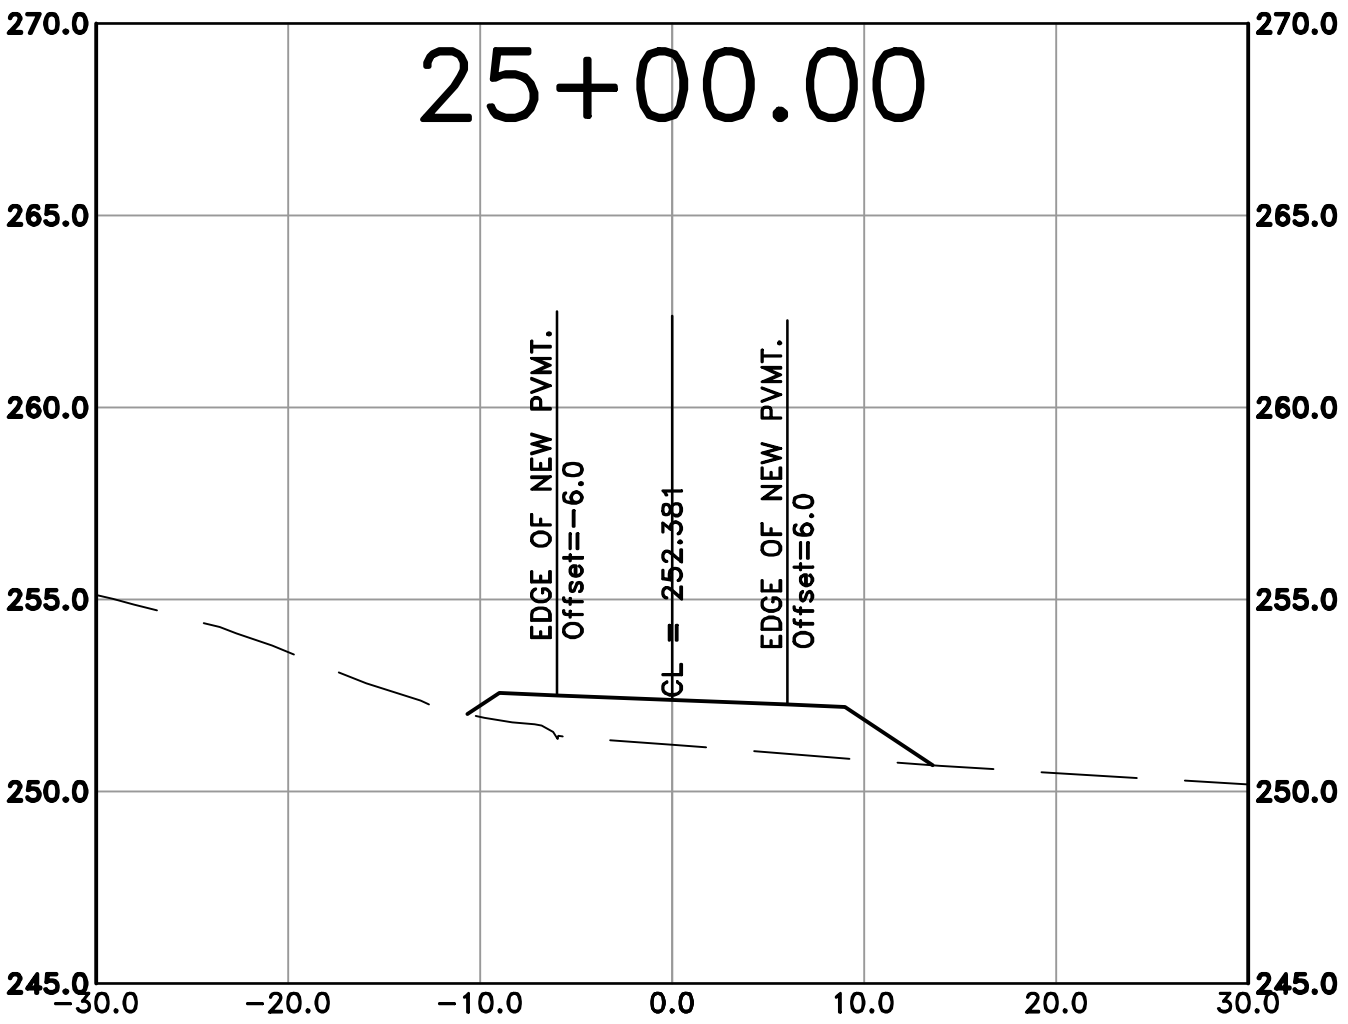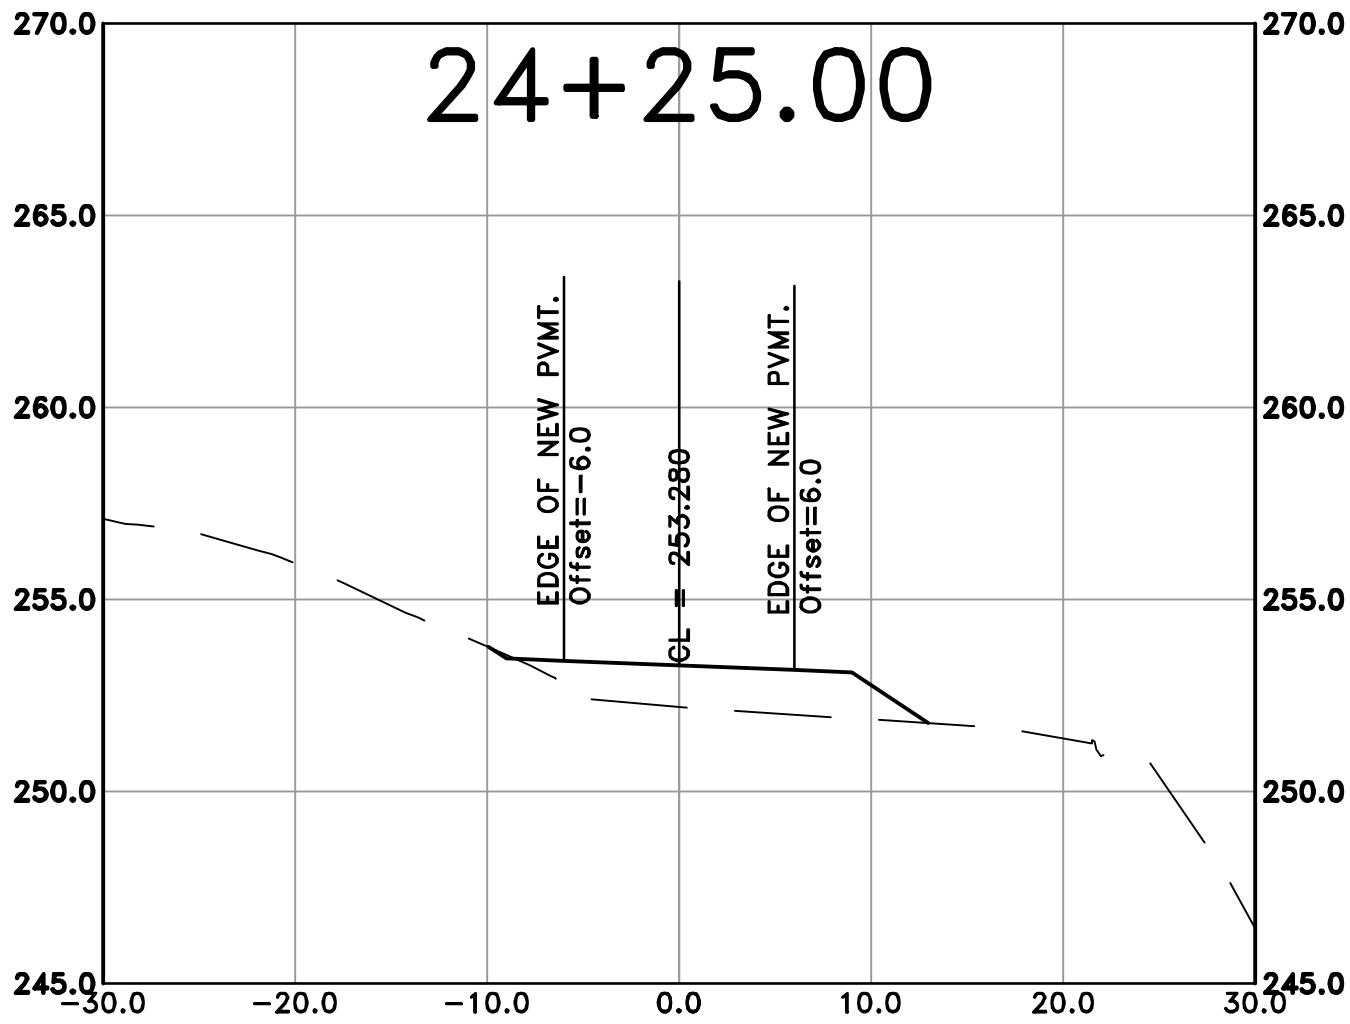

REVISIONS	DATE










CITY OF LITTLE ROCK, ARKANSAS
ROSE CREEK TRAIL
CROSS SECTION SHEET 7

DEPARTMENT OF PUBLIC WORKS
CIVIL ENGINEERING
701 W. MARKHAM
LITTLE ROCK, ARKANSAS 72201



DRAWN BY	AS
DESIGNED	LC
CHECKED	JM
DATE	05-01-2026
SCALE	H: 1"=40' 10' V: 1"=10'
PROJECT NO.	23805201
SHEET NO.	C56

100% SUBMITTAL

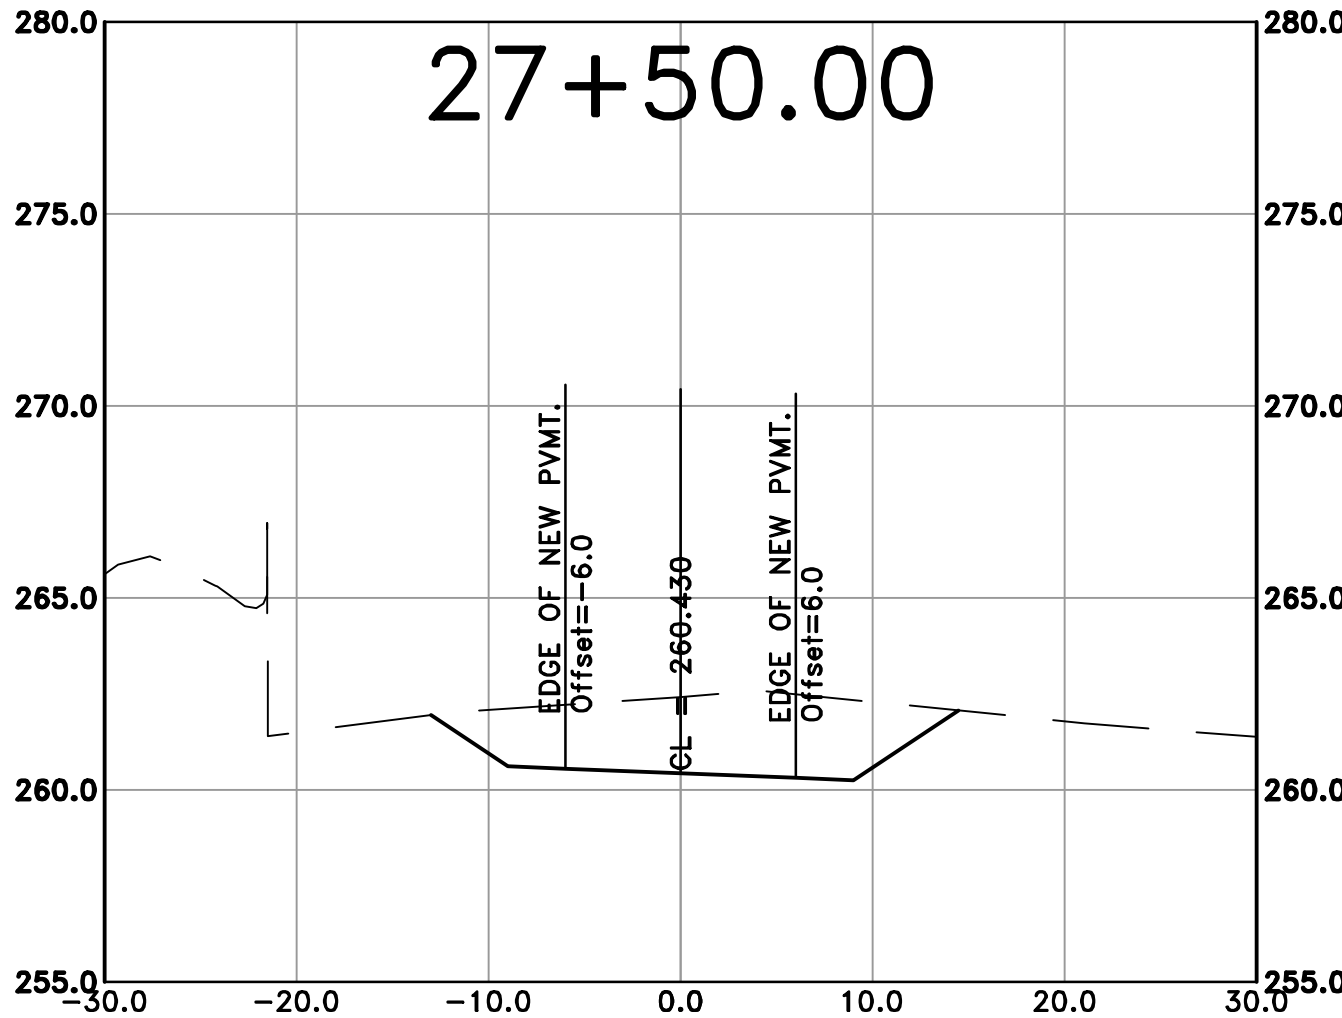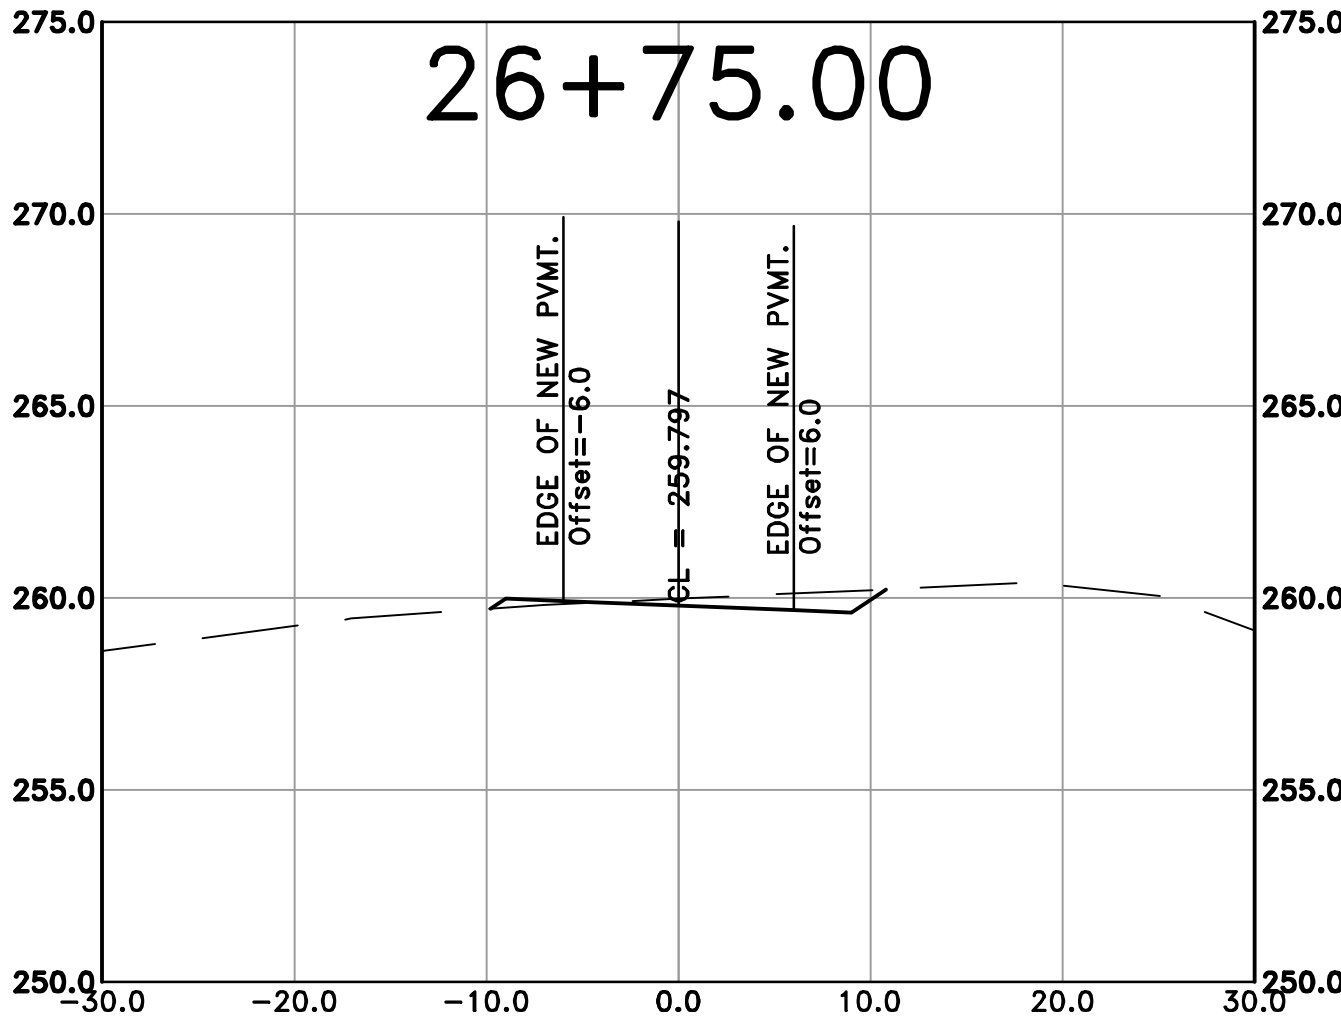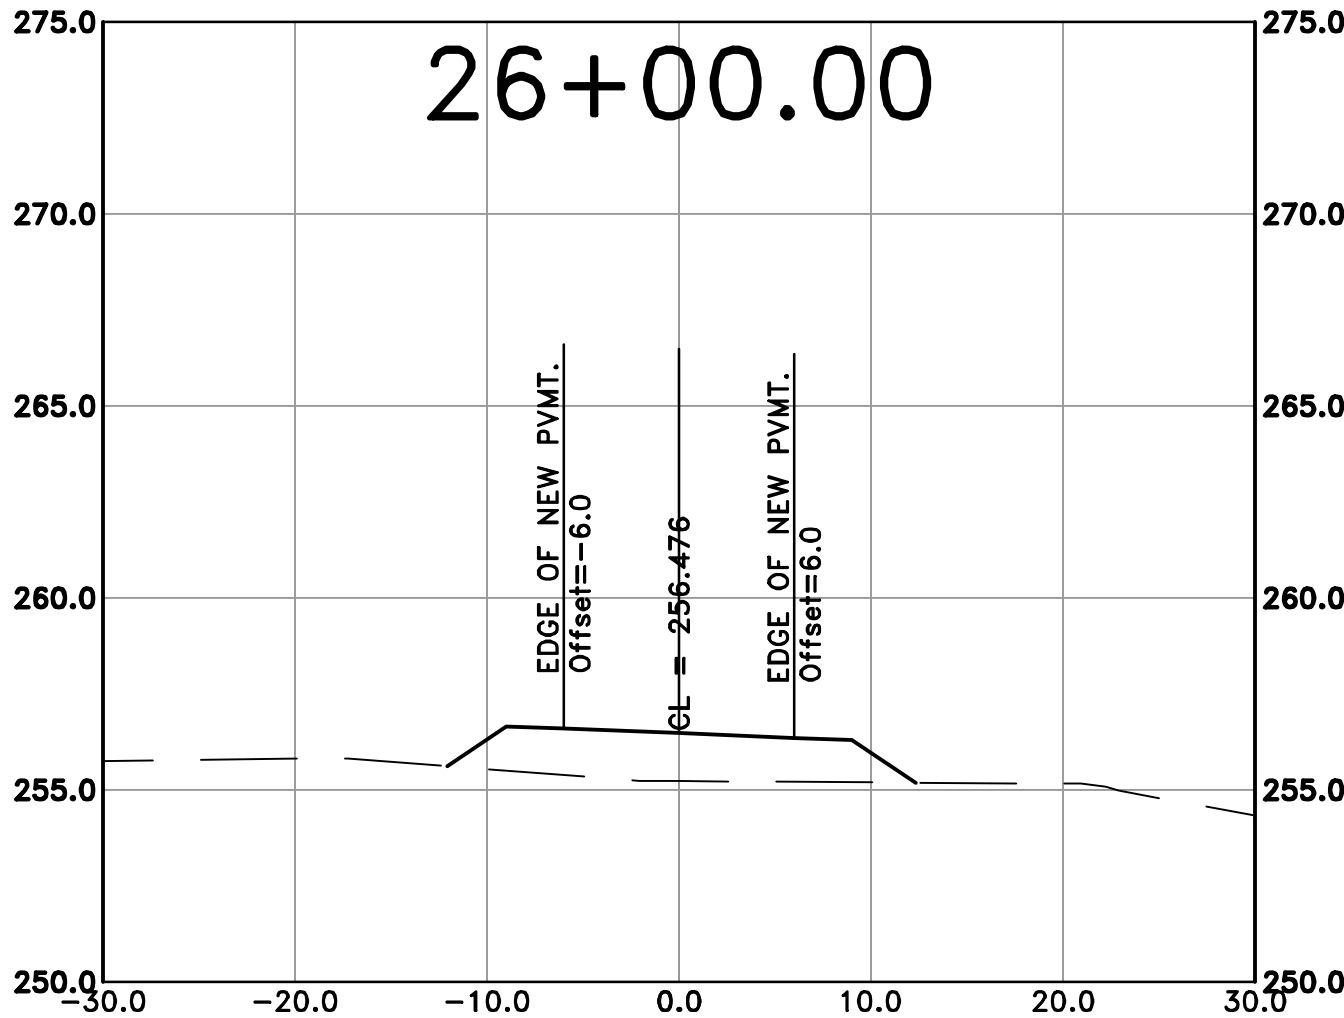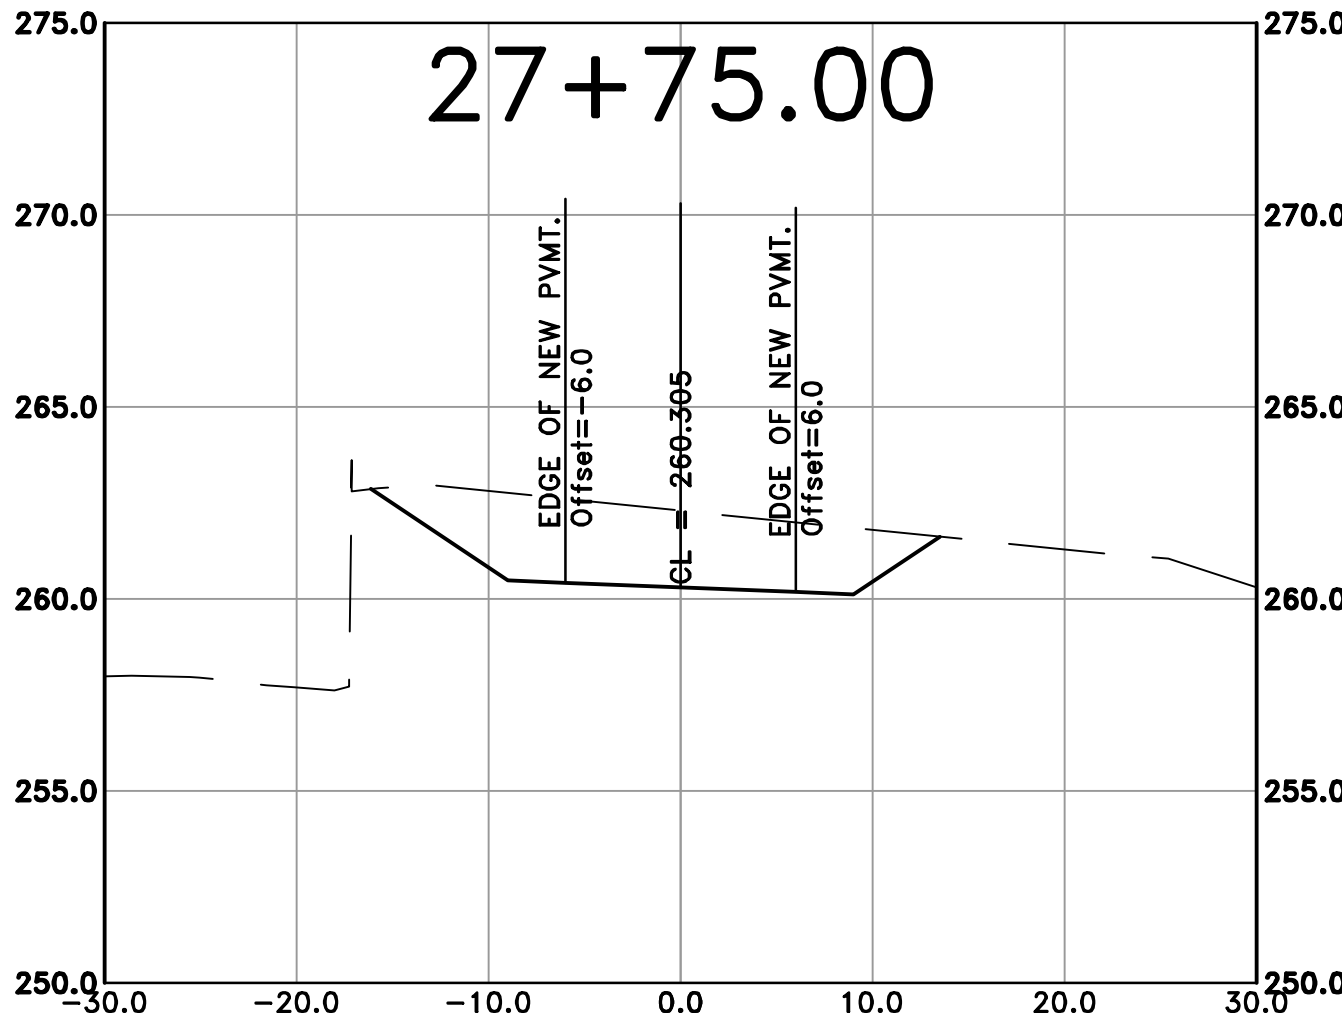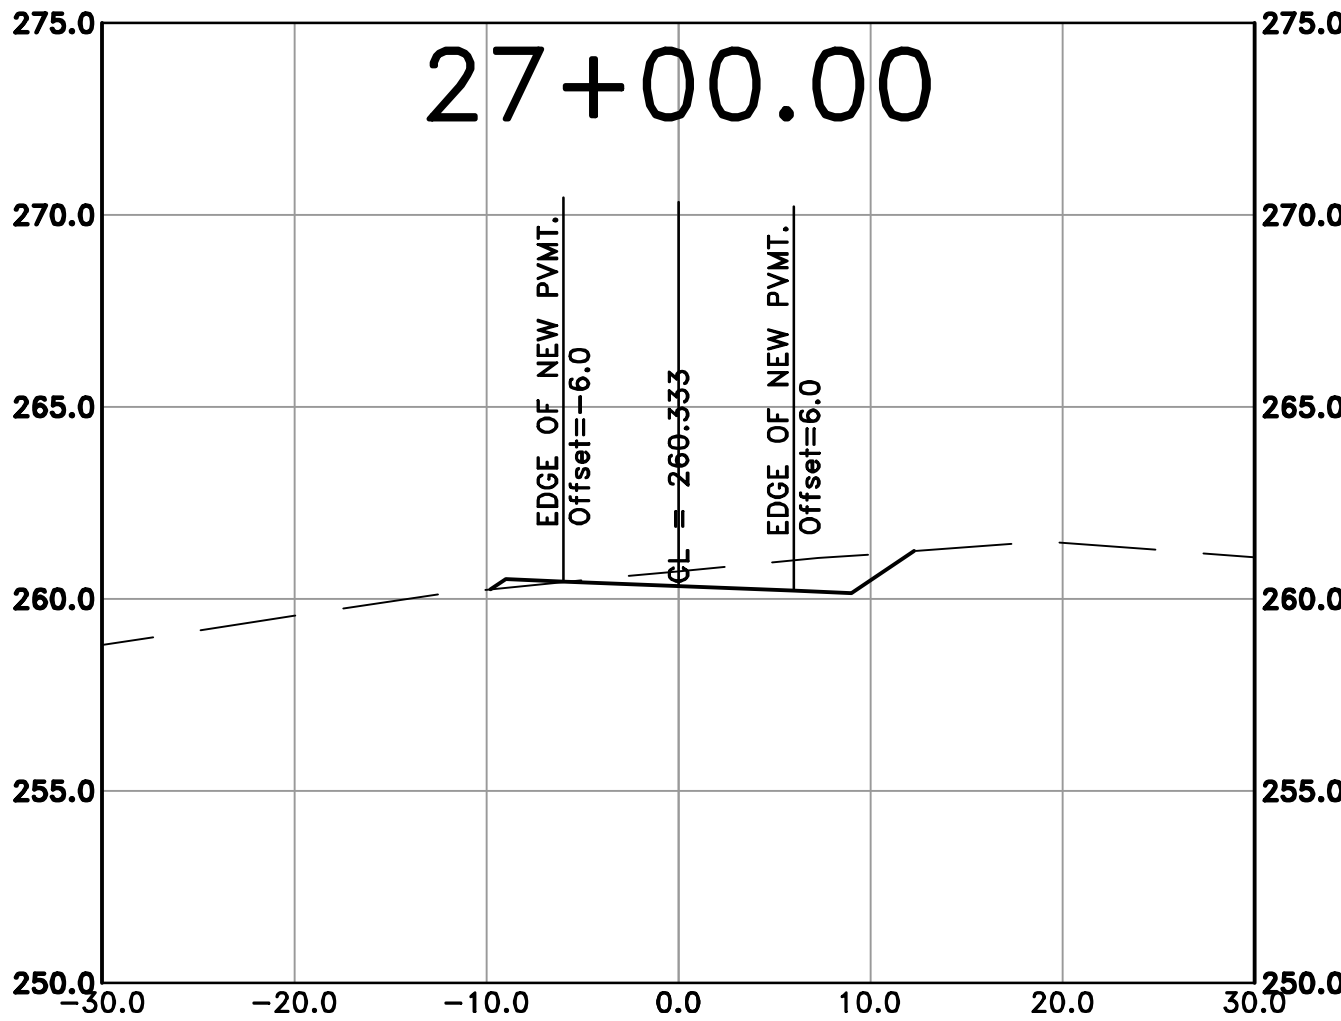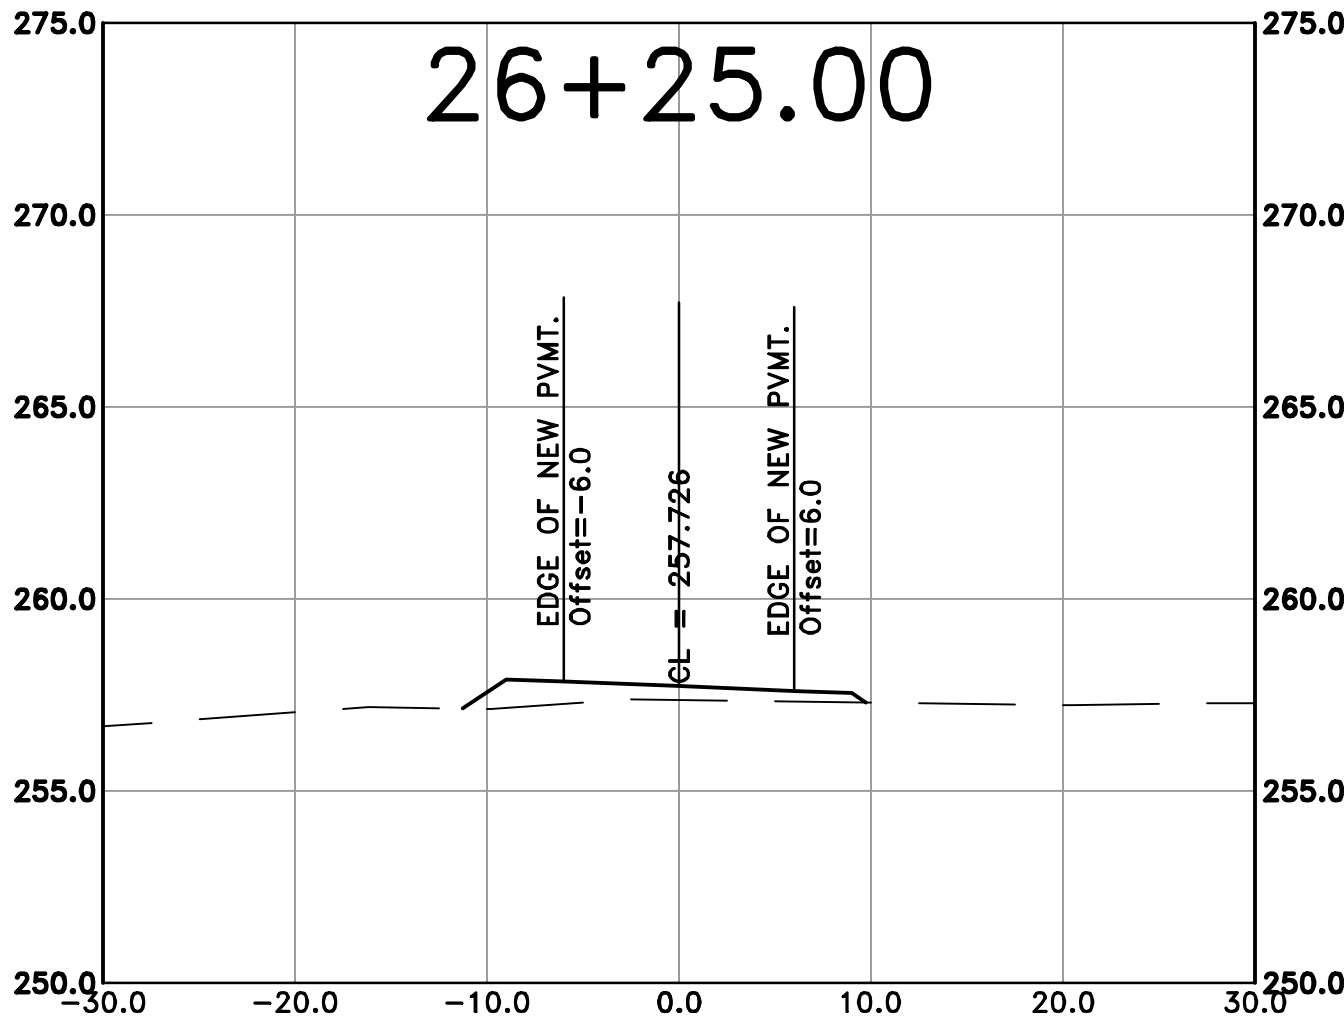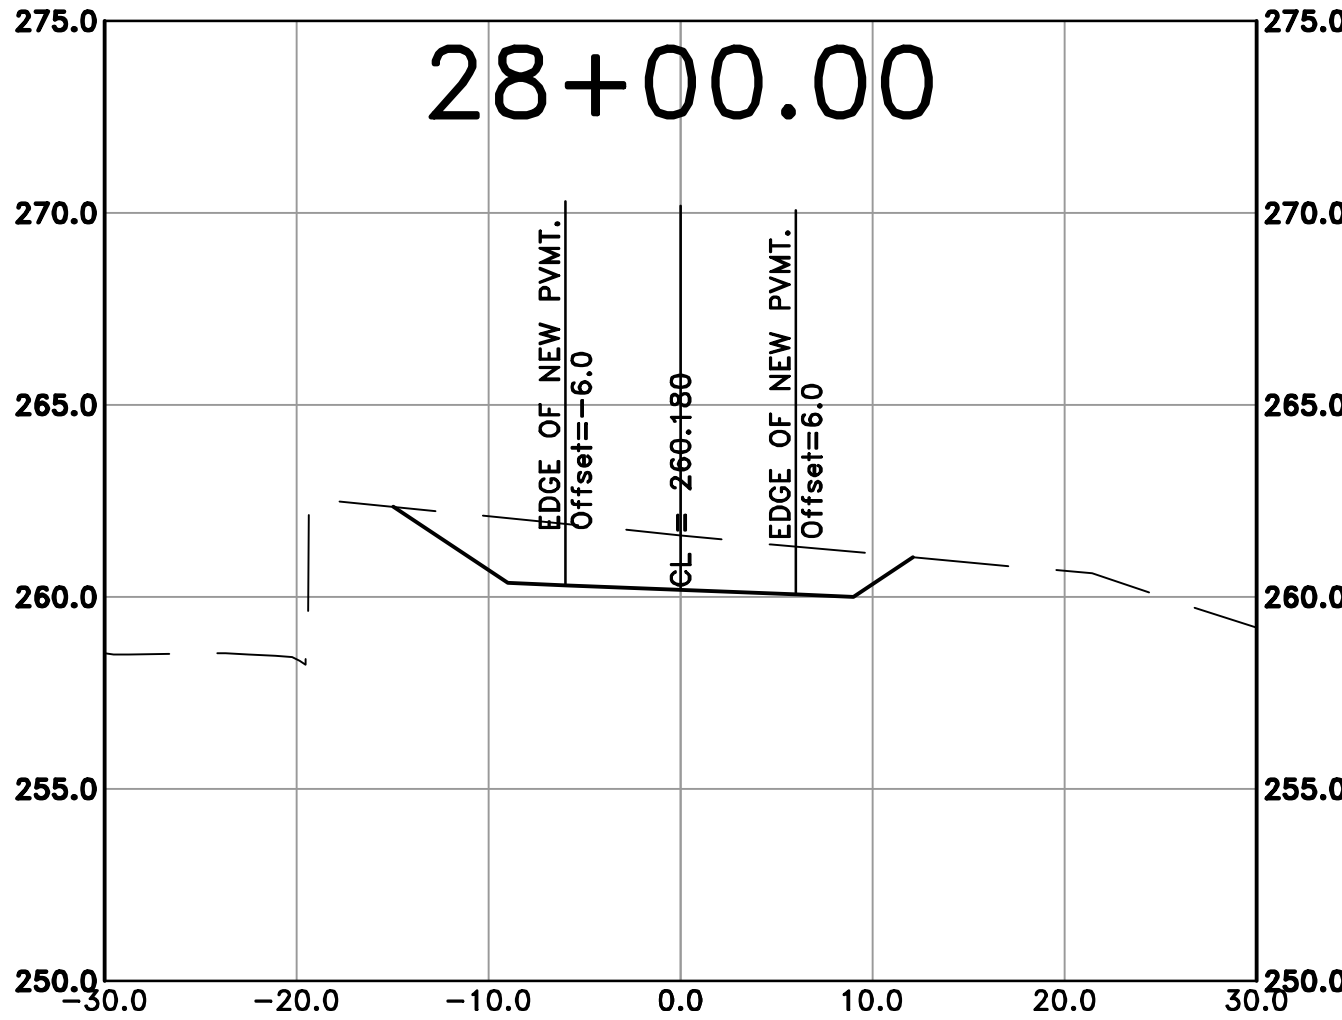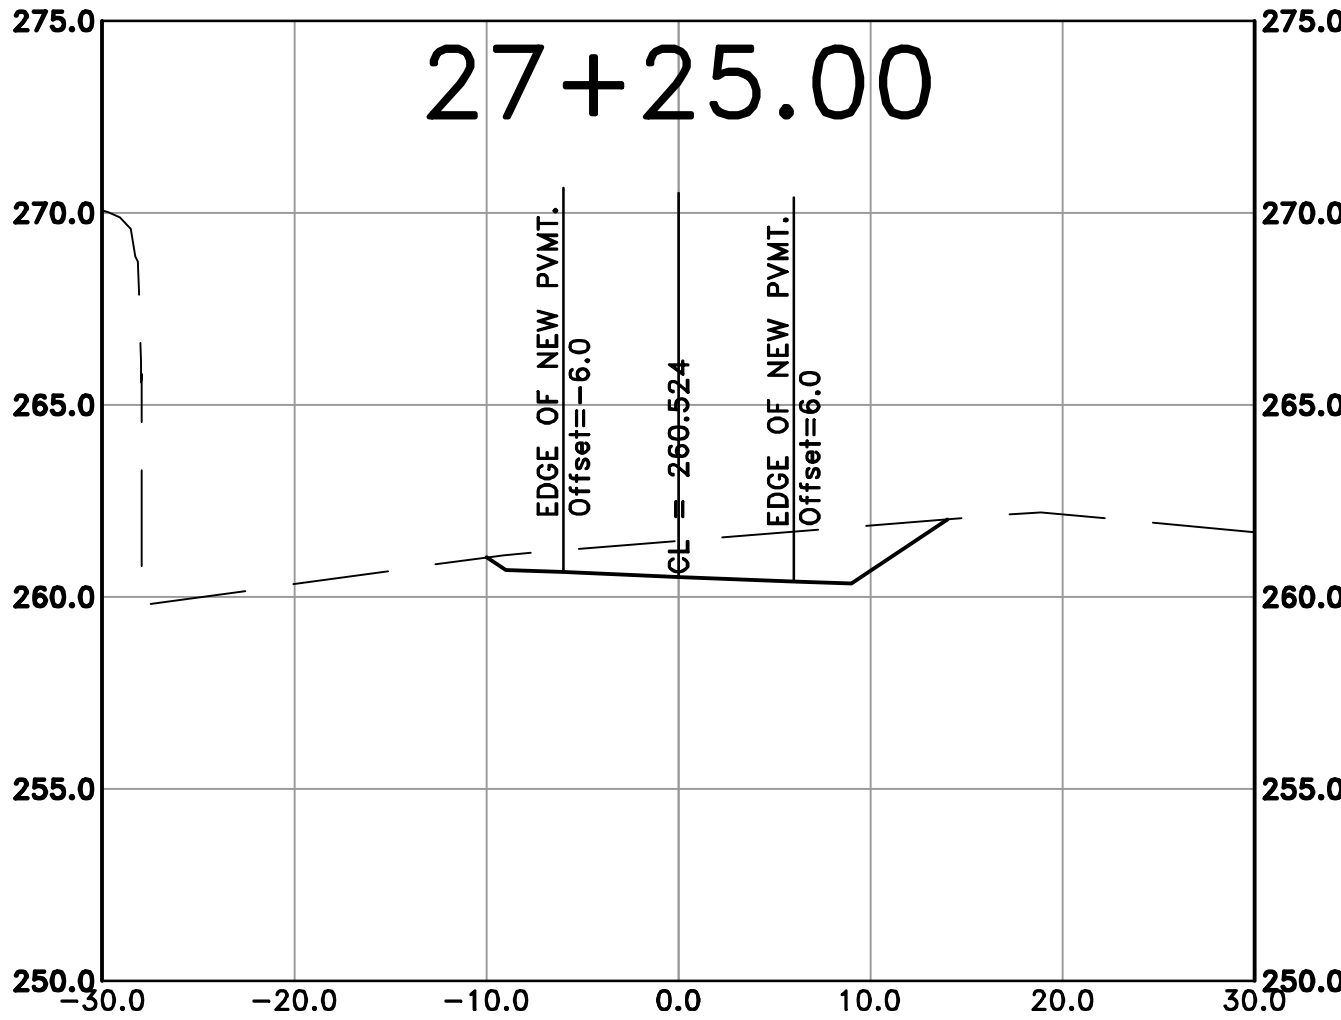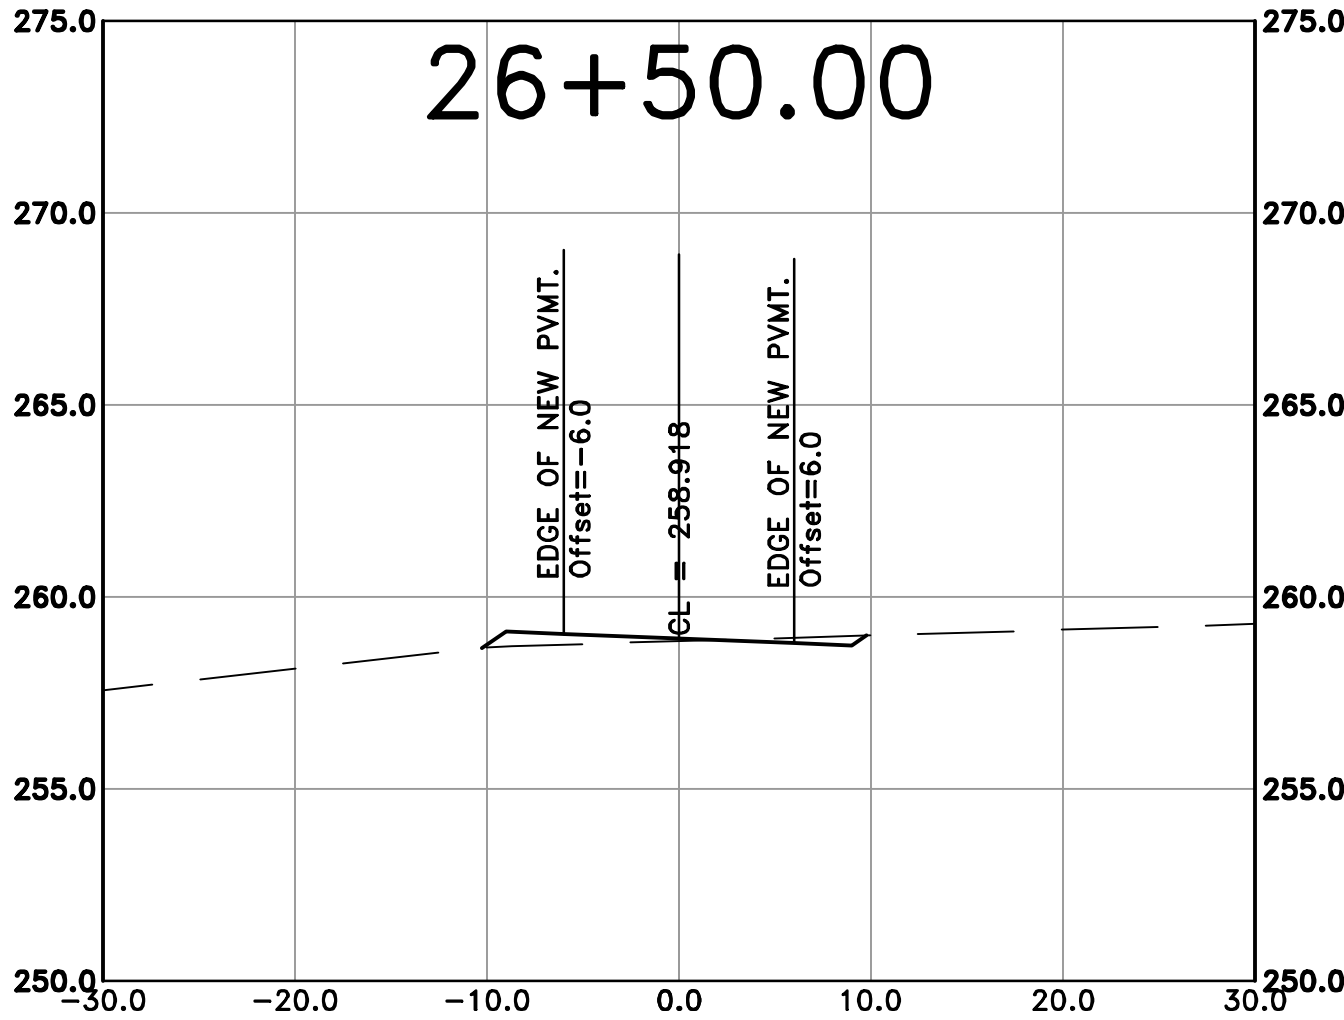

REVISIONS	DATE










CITY OF LITTLE ROCK, ARKANSAS
ROSE CREEK TRAIL
CROSS SECTION SHEET 8

DEPARTMENT OF PUBLIC WORKS
CIVIL ENGINEERING
701 W. MARKHAM
LITTLE ROCK, ARKANSAS 72201



DRAWN BY	AS
DESIGNED	LC
CHECKED	JM
DATE	05-01-2026
SCALE	H: 1"=20' 10'
V: 1"=25'	
PROJECT NO.	23805201
SHEET NO.	C57

100% SUBMITTAL

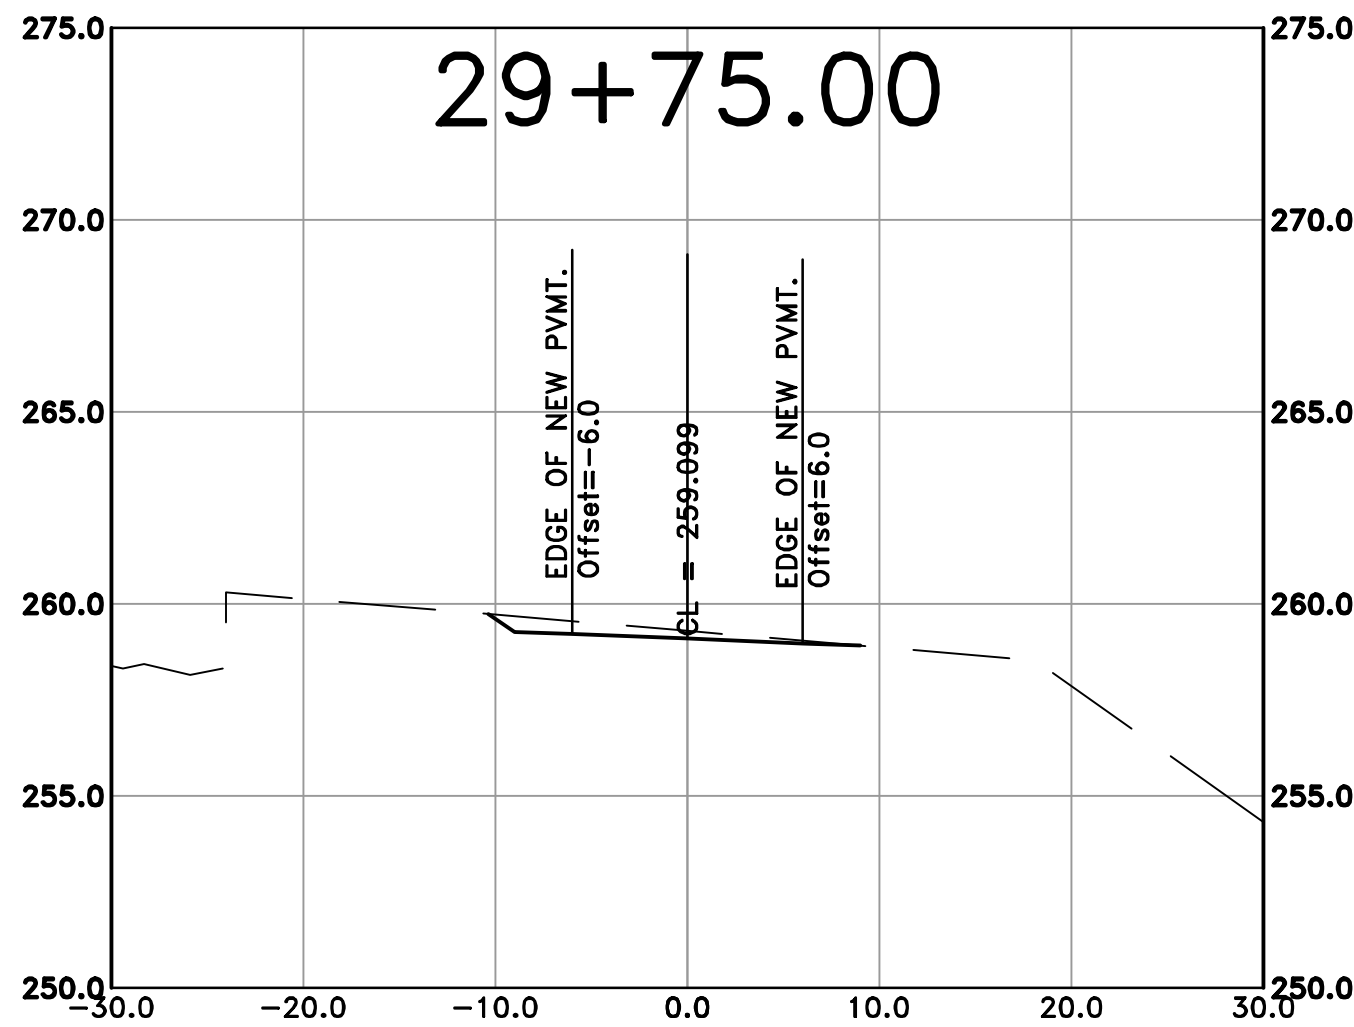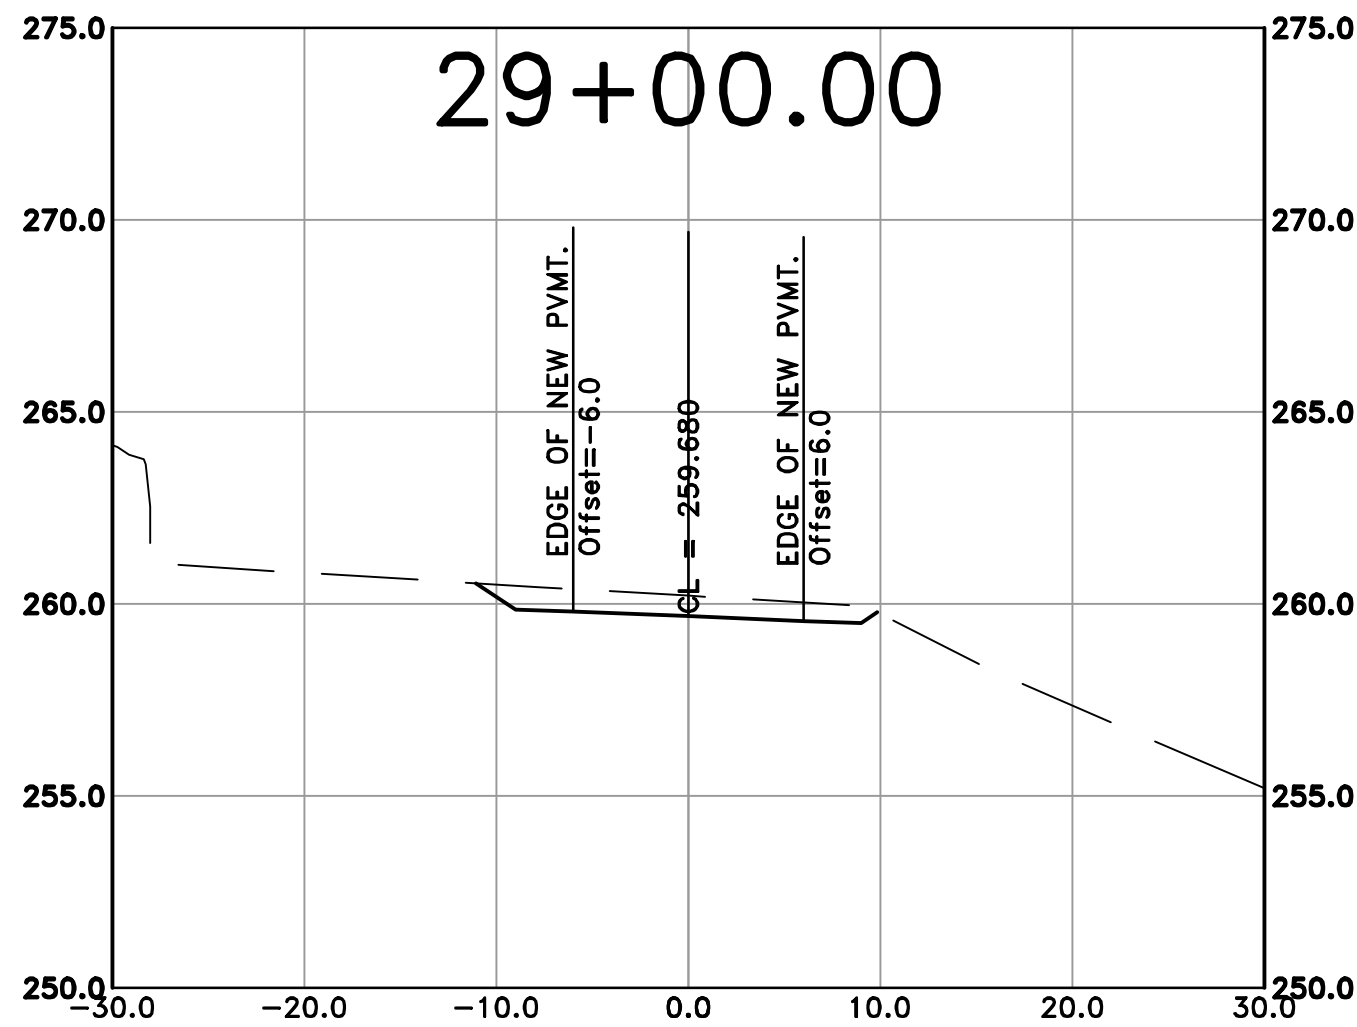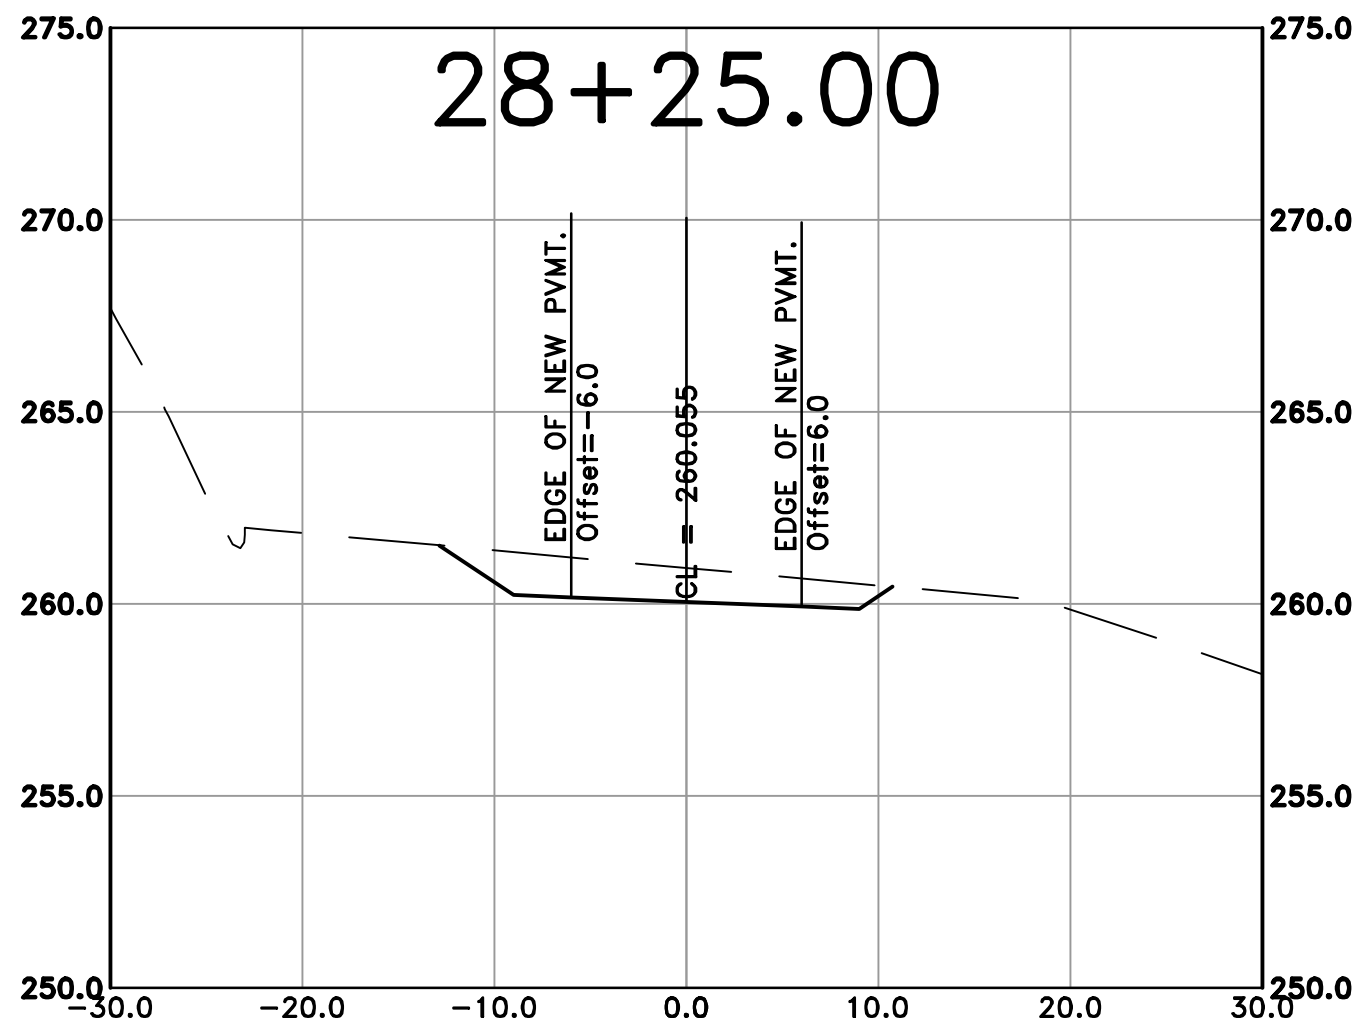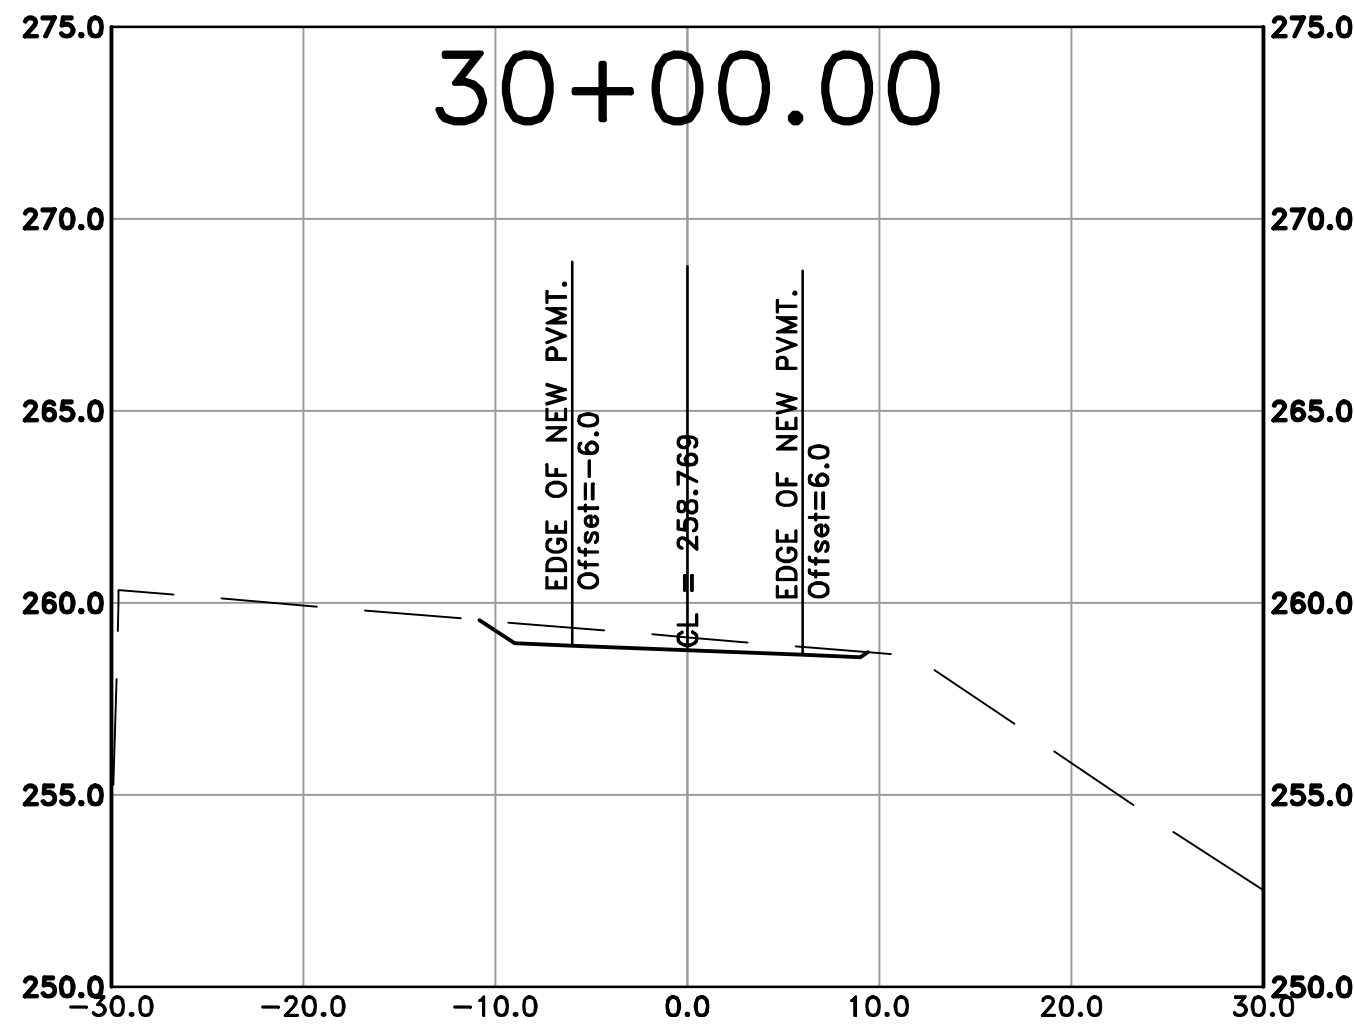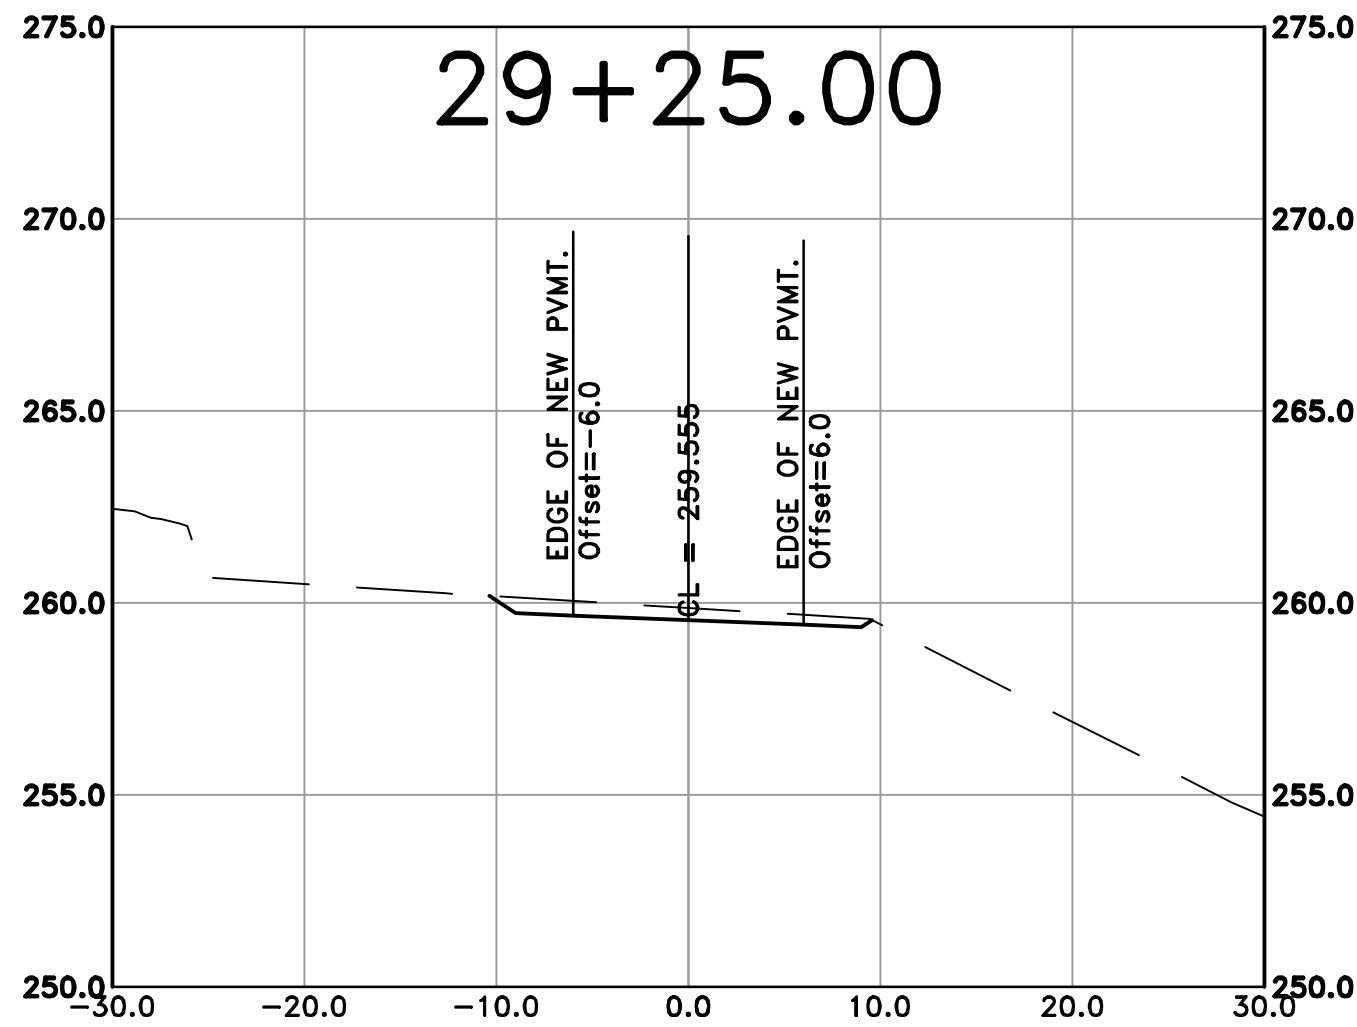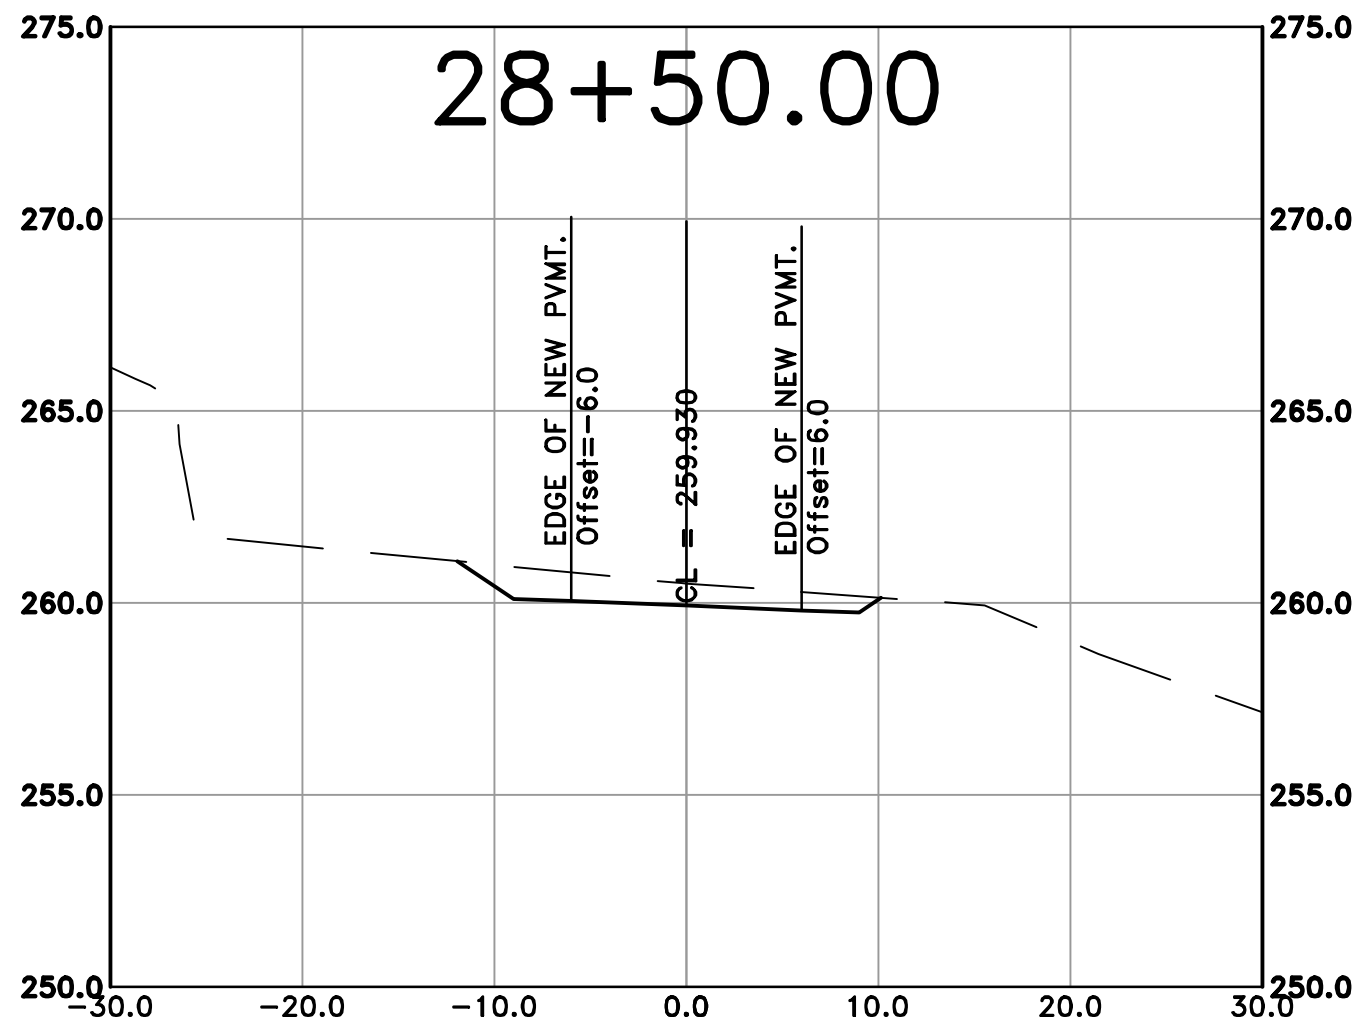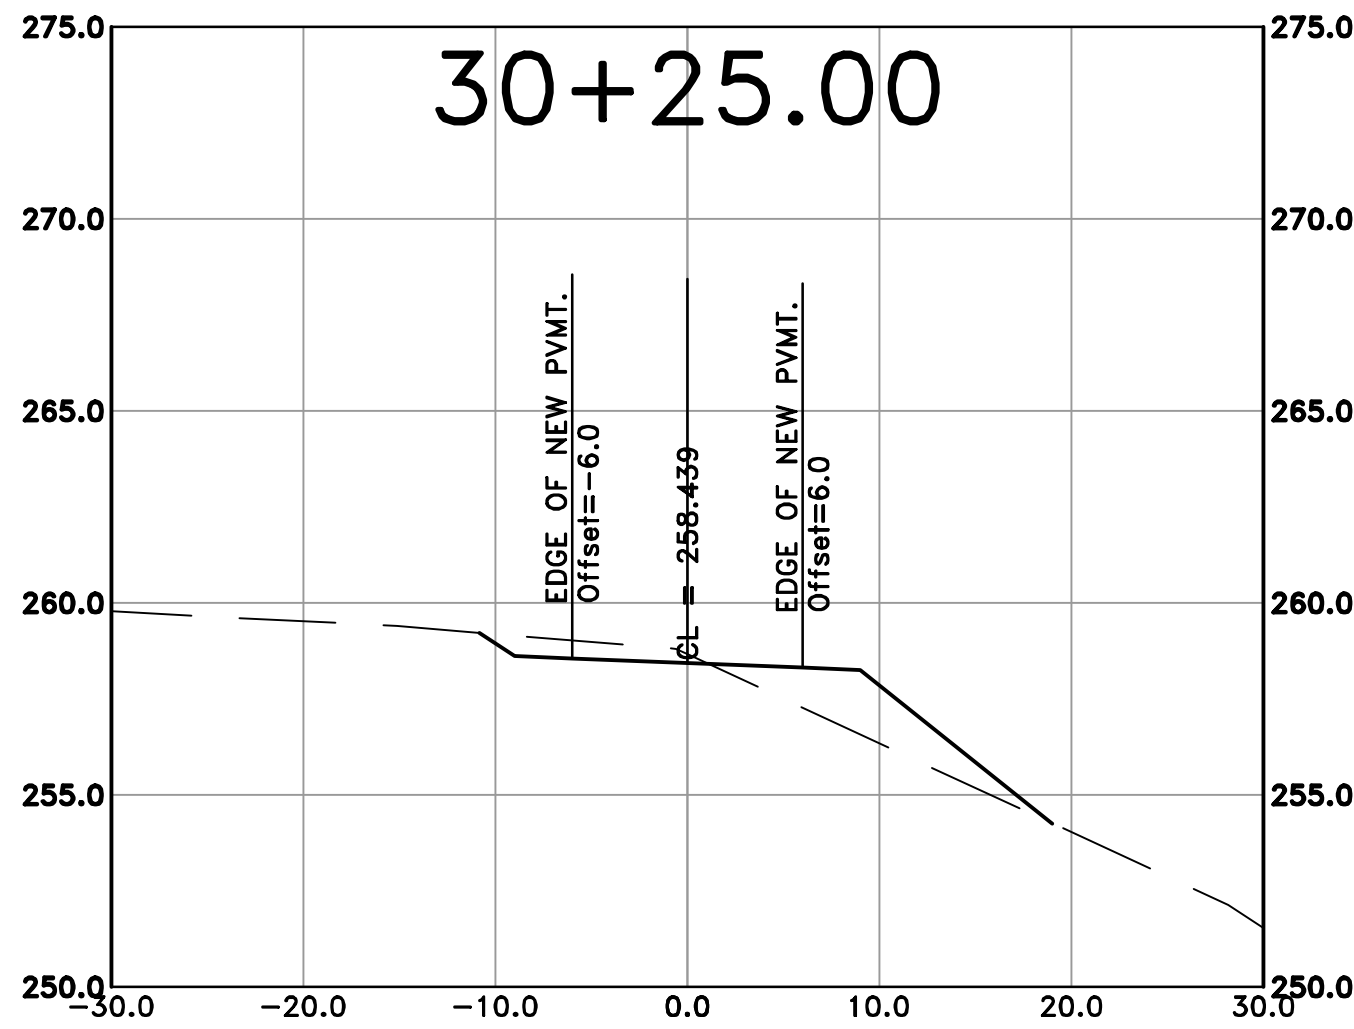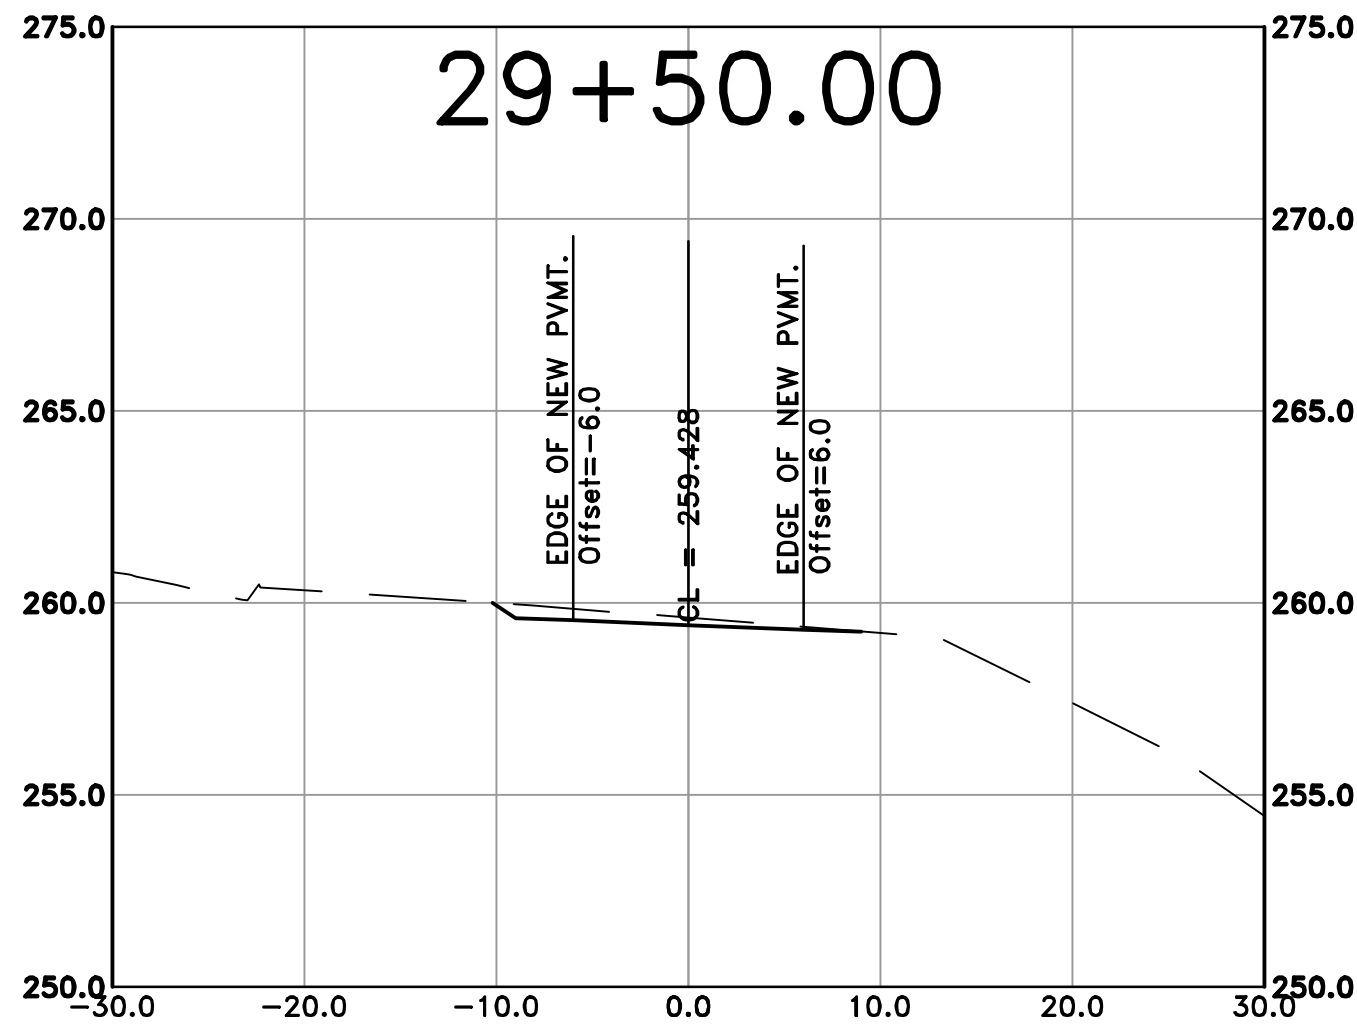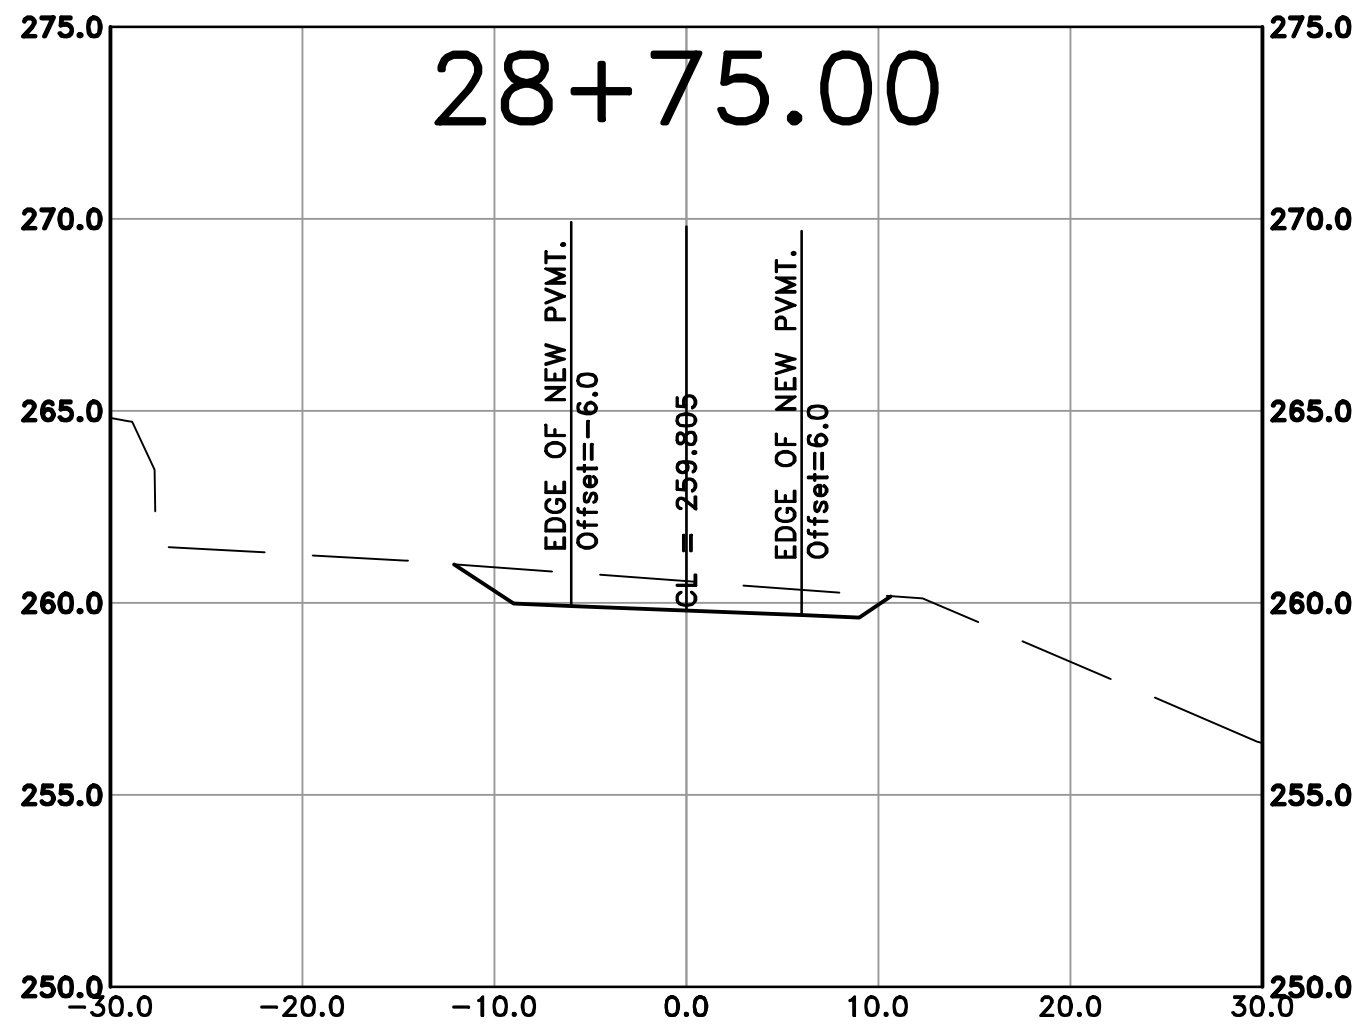

REVISIONS	DATE










CITY OF LITTLE ROCK, ARKANSAS
ROSE CREEK TRAIL
CROSS SECTION SHEET 9

DEPARTMENT OF PUBLIC WORKS
CIVIL ENGINEERING
701 W. MARKHAM
LITTLE ROCK, ARKANSAS 72201



DRAWN BY	AS
DESIGNED	LC
CHECKED	JM
DATE	05-01-2026
SCALE	H: 1"=20'-0"
V: 1"=40'-0"	
PROJECT NO.	23805201
SHEET NO.	C58

100% SUBMITTAL

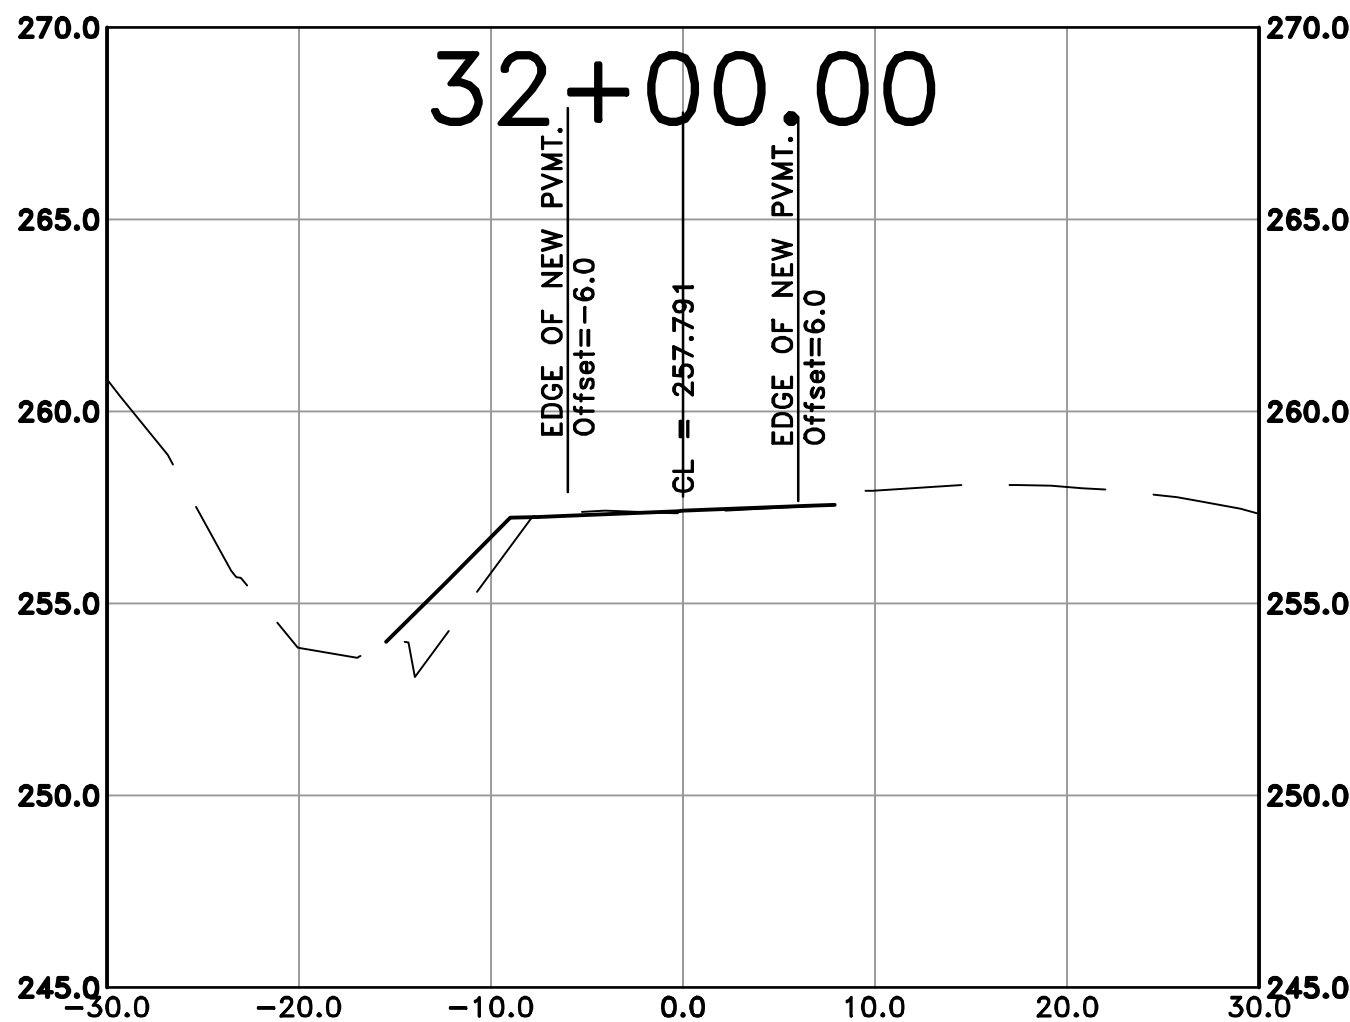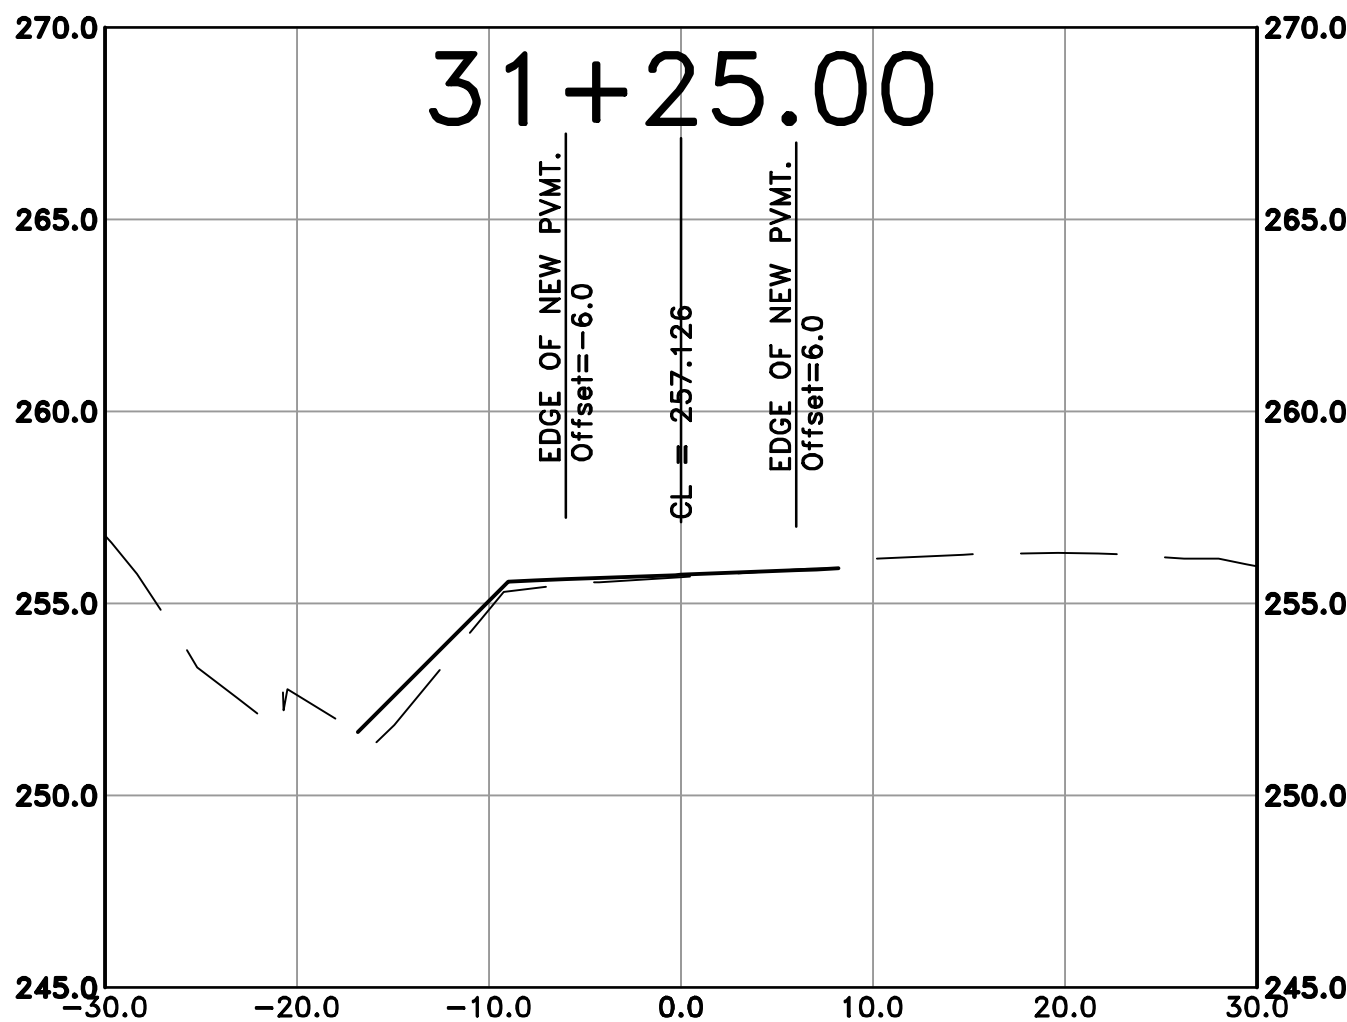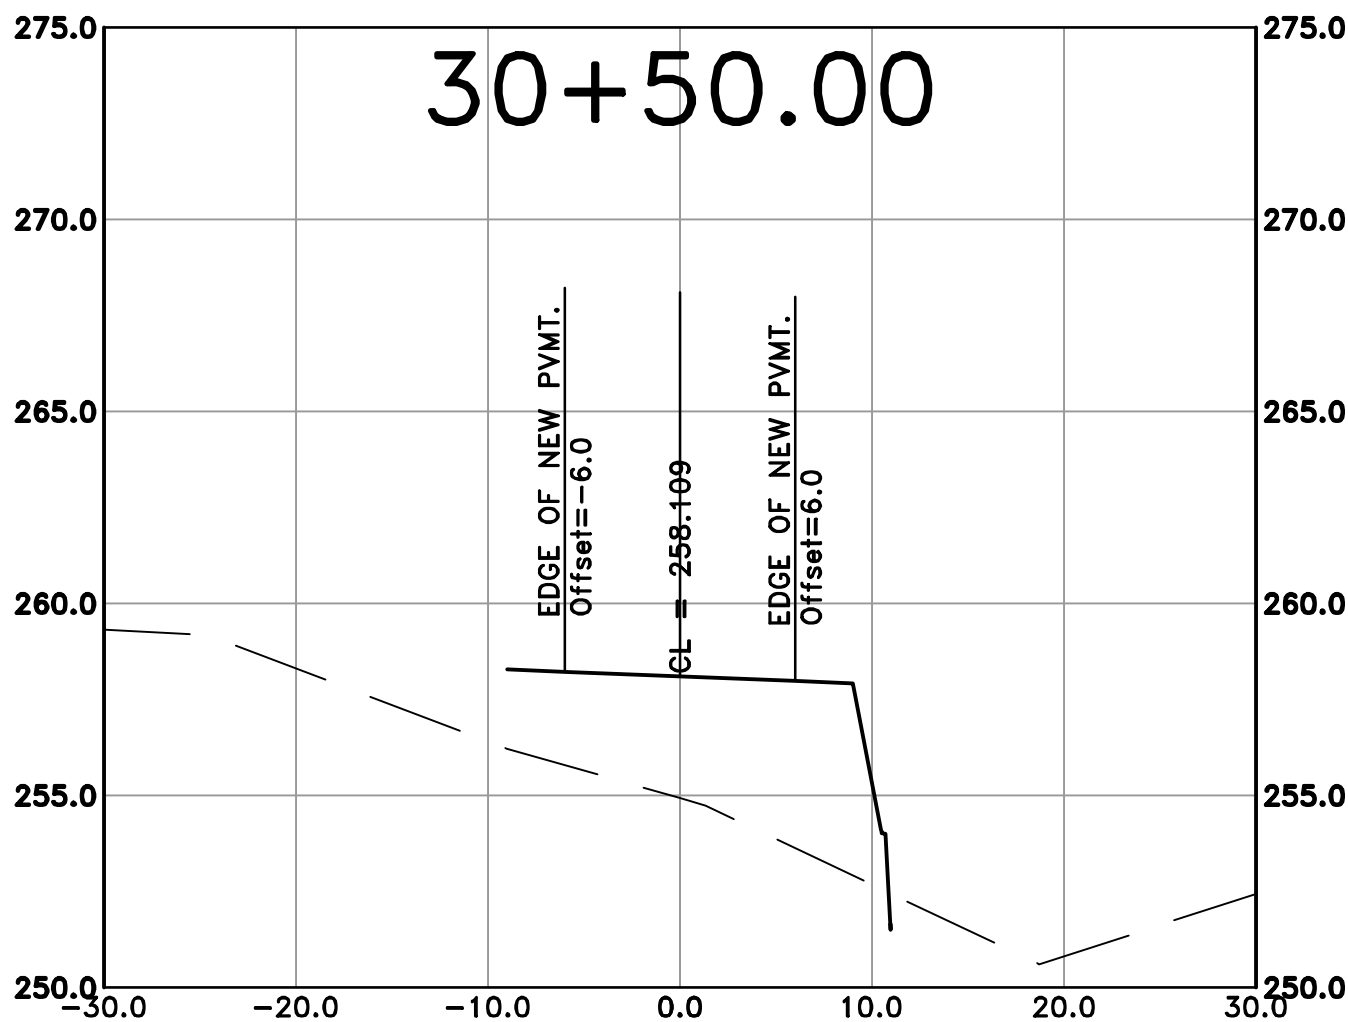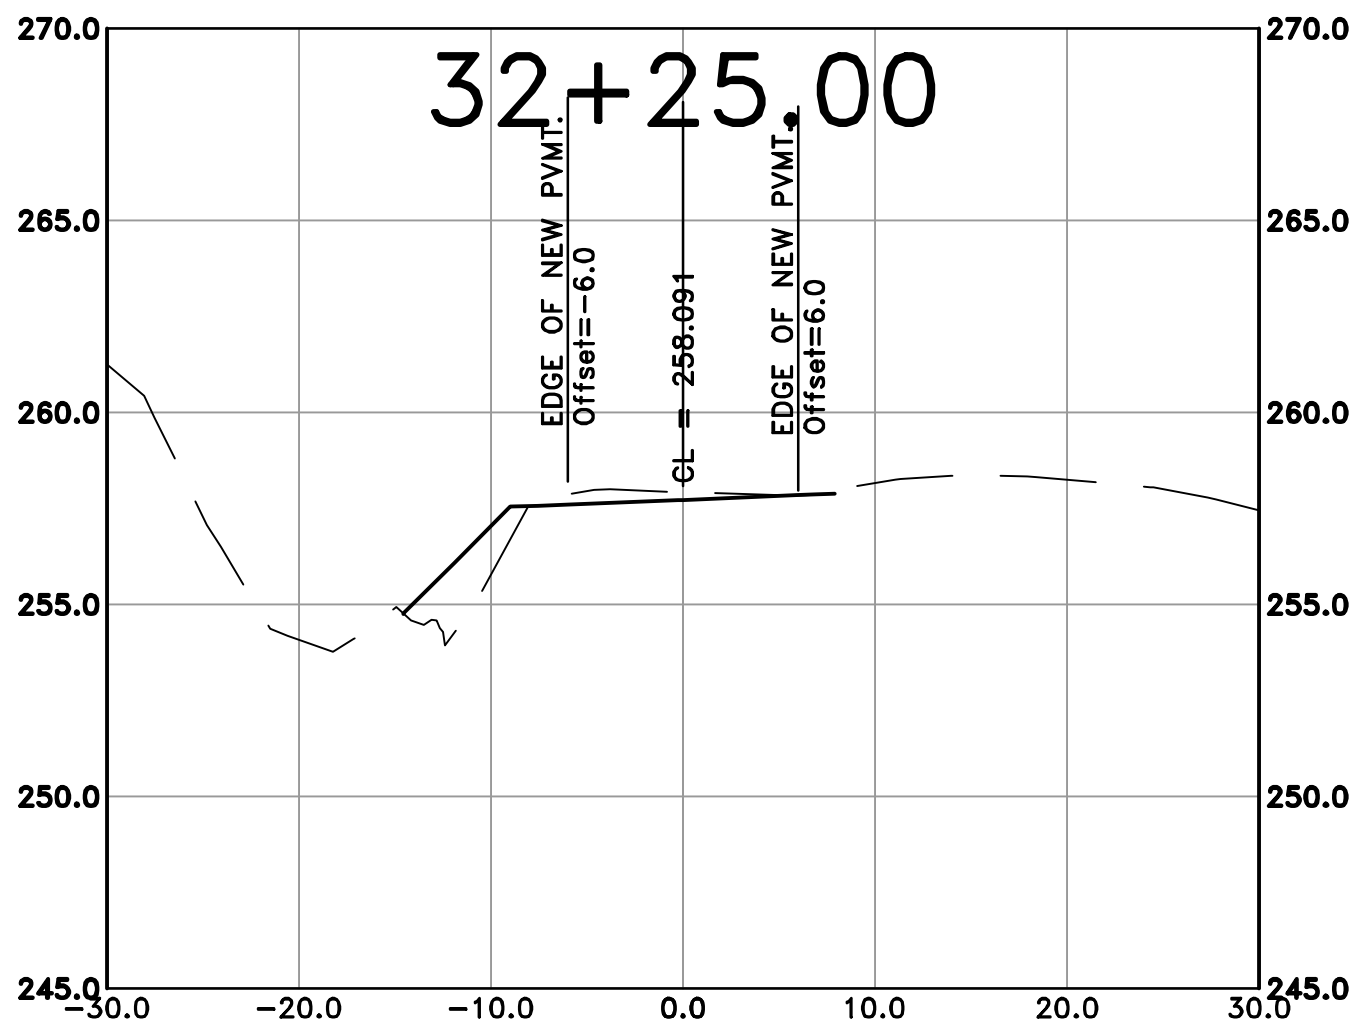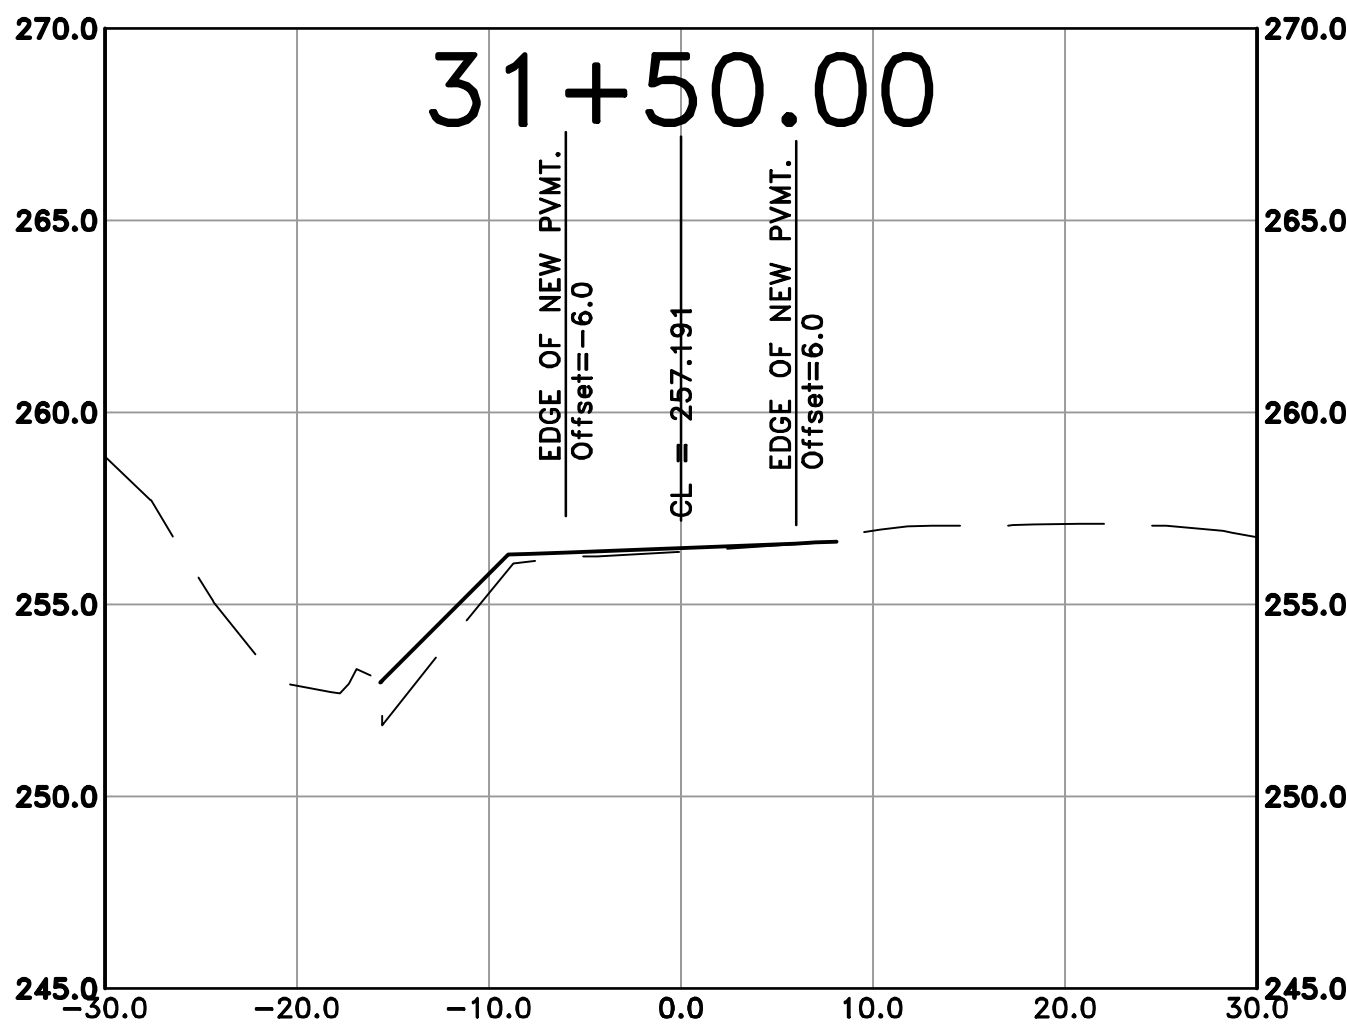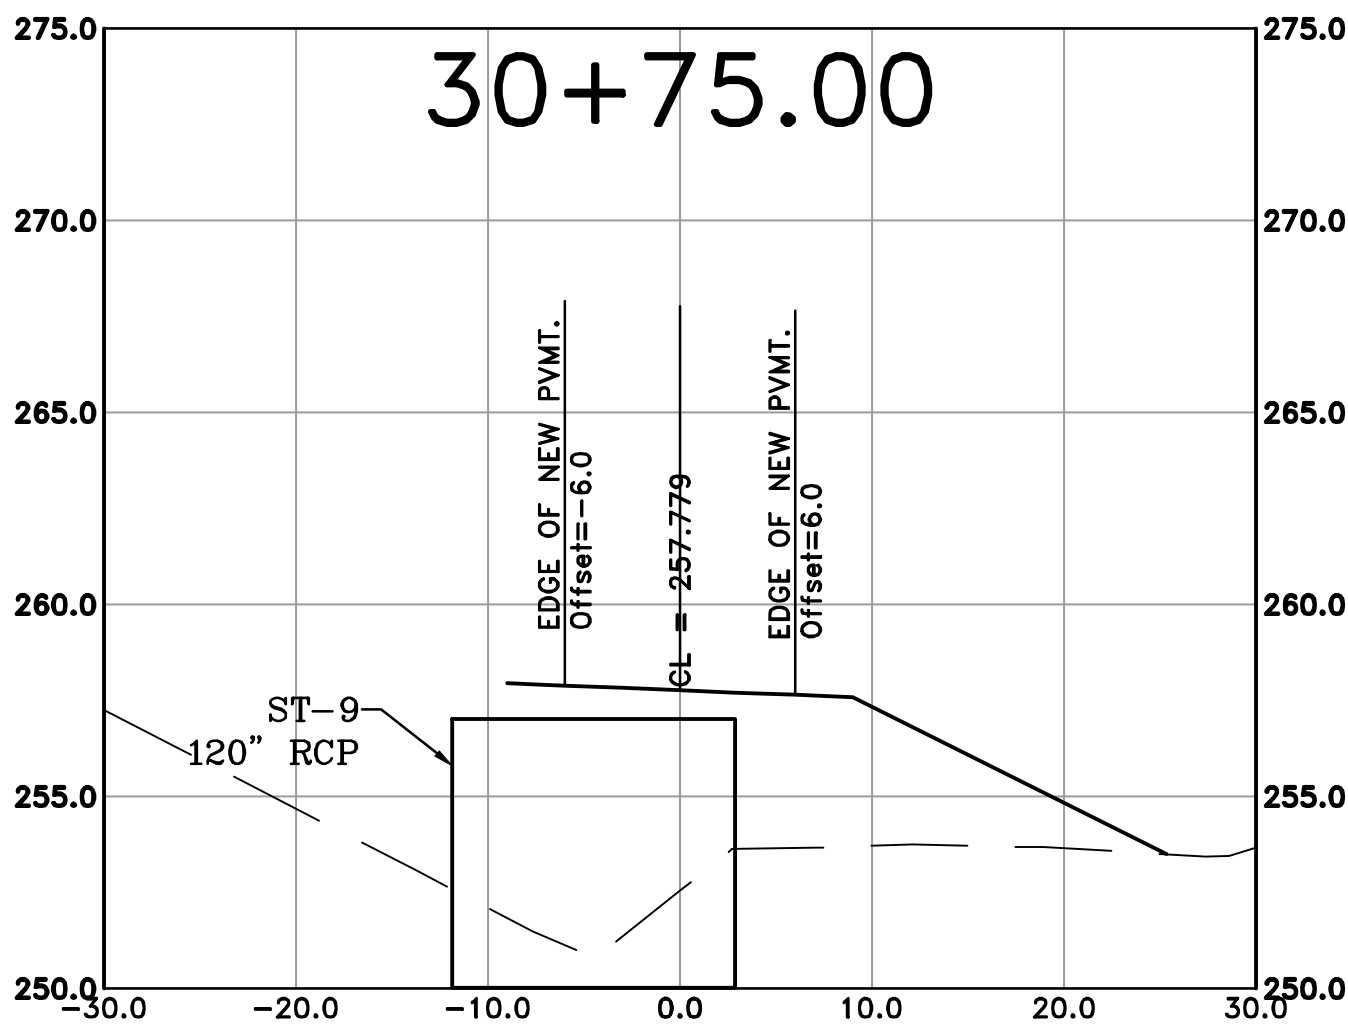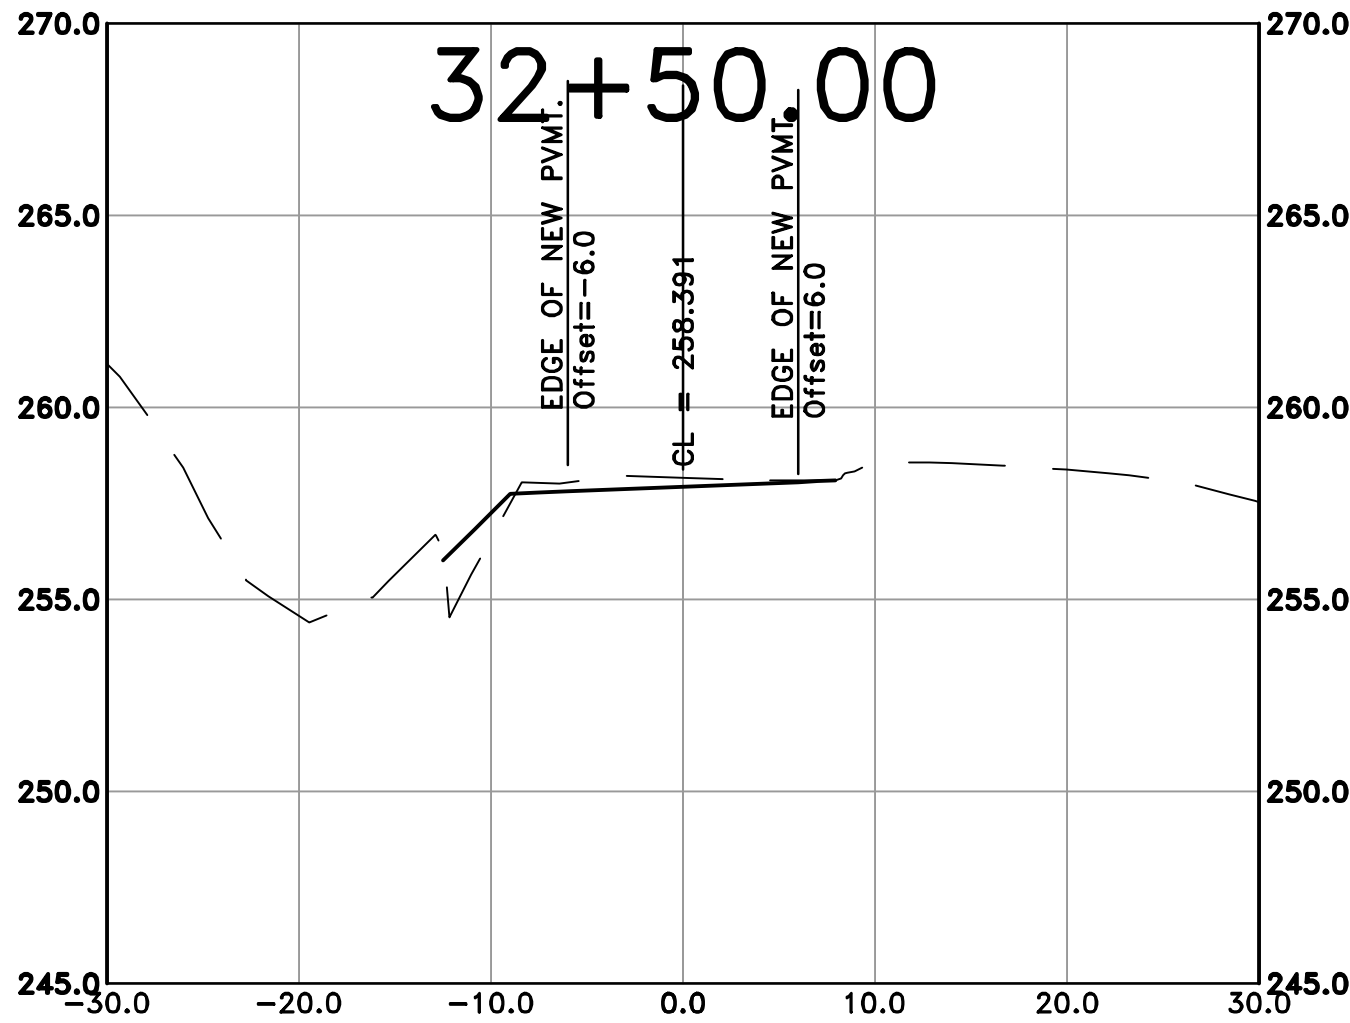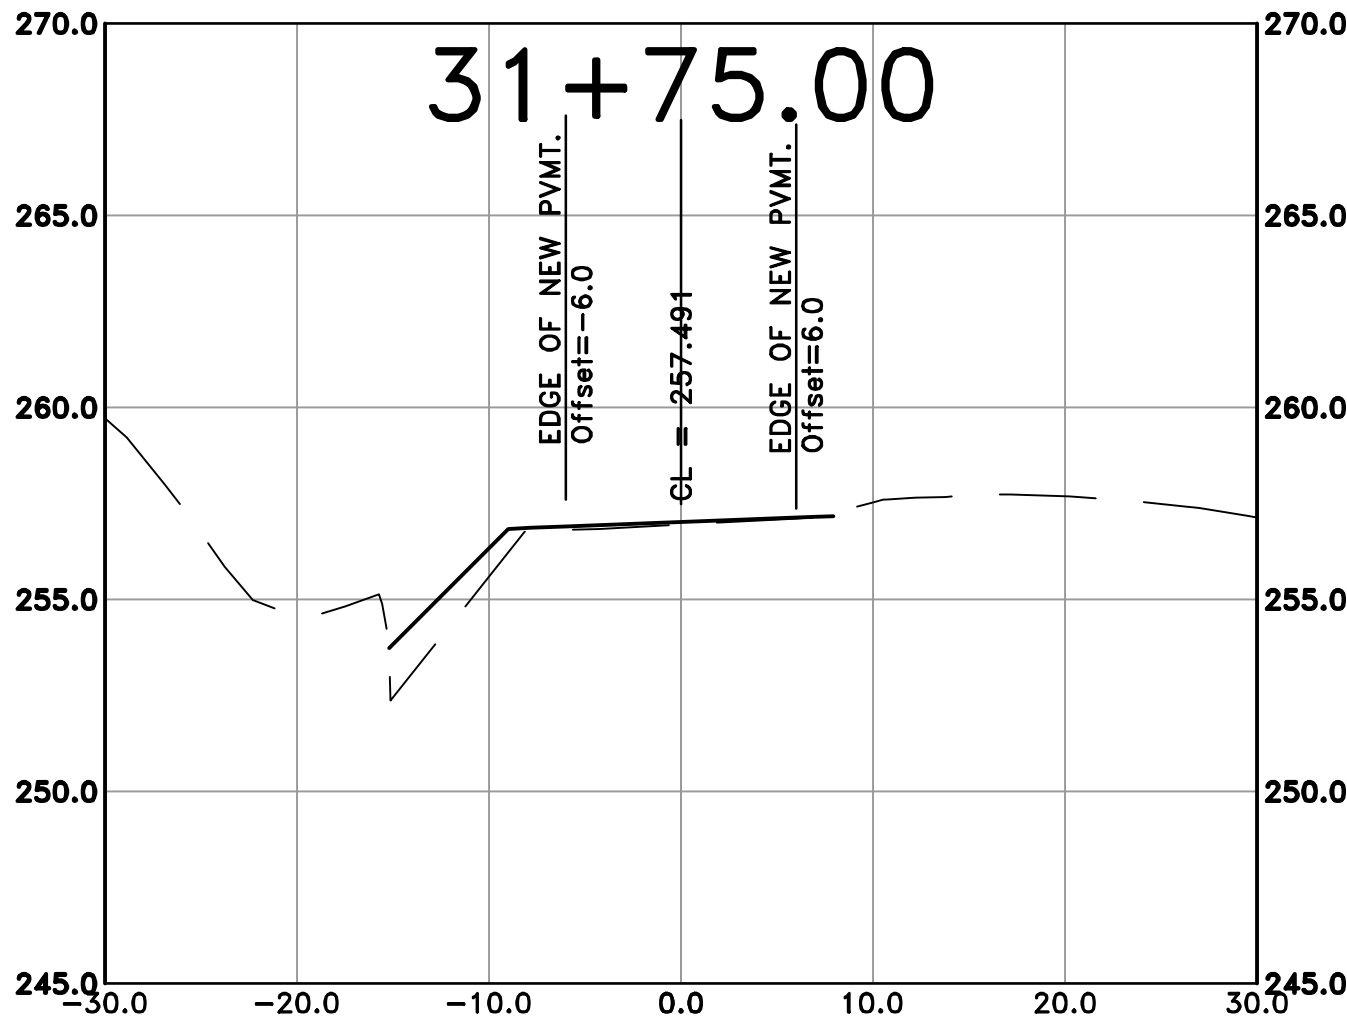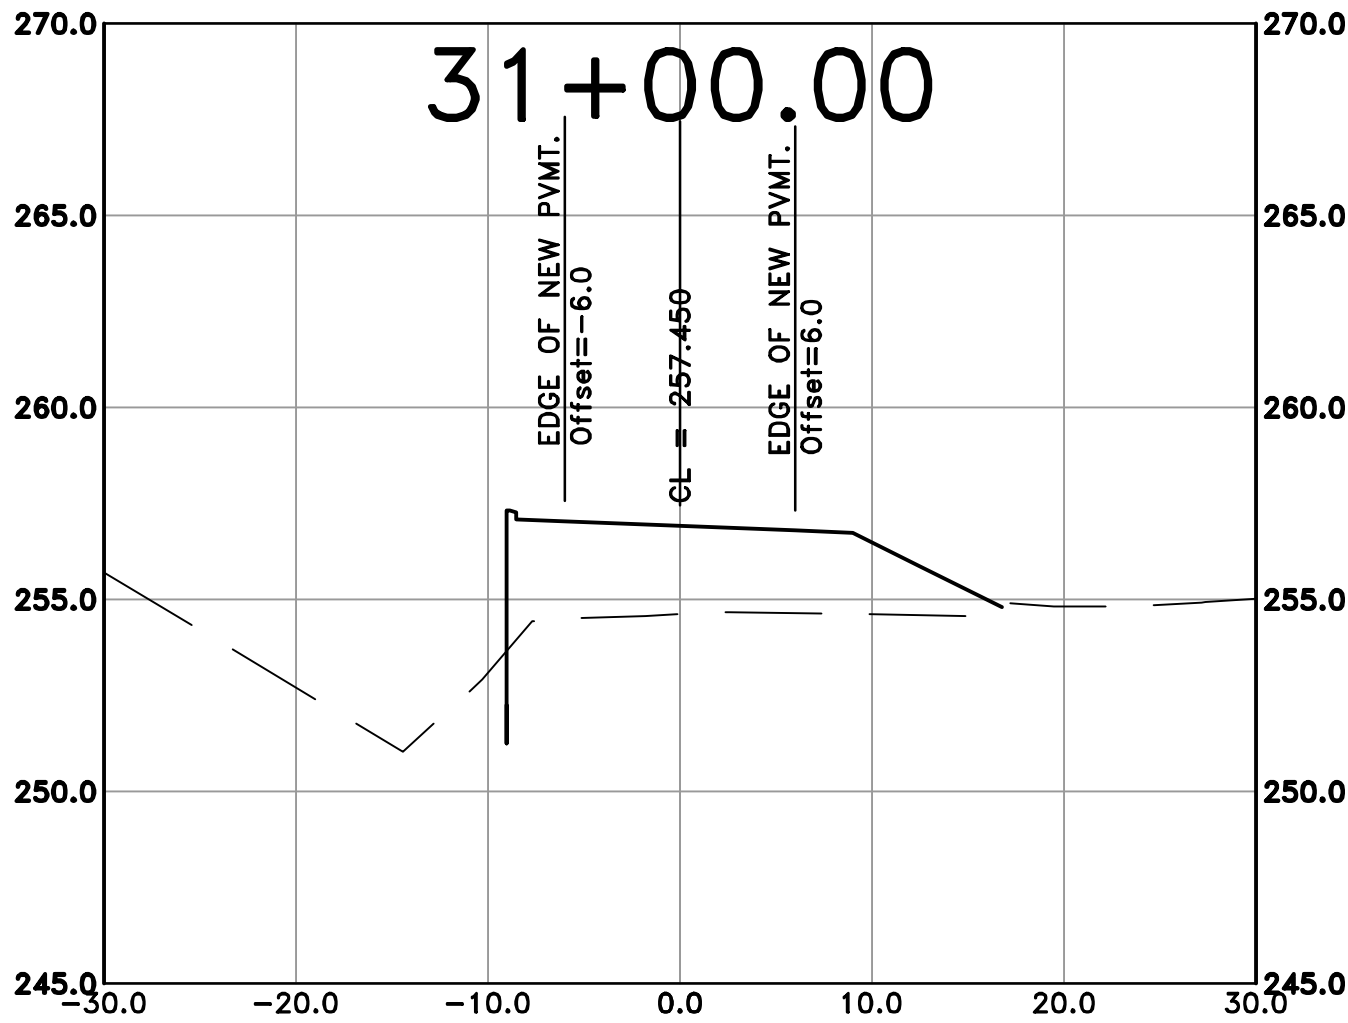

REVISIONS	DATE










CITY OF LITTLE ROCK, ARKANSAS
ROSE CREEK TRAIL
CROSS SECTION SHEET 10

DEPARTMENT OF PUBLIC WORKS
CIVIL ENGINEERING
701 W. MARKHAM
LITTLE ROCK, ARKANSAS 72201



DRAWN BY	AS
DESIGNED	LC
CHECKED	JM
DATE	05-01-2026
SCALE	H: 1"=40'-10"
V: 1"=40'-5"	
PROJECT NO.	23805201
SHEET NO.	C59

100% SUBMITTAL

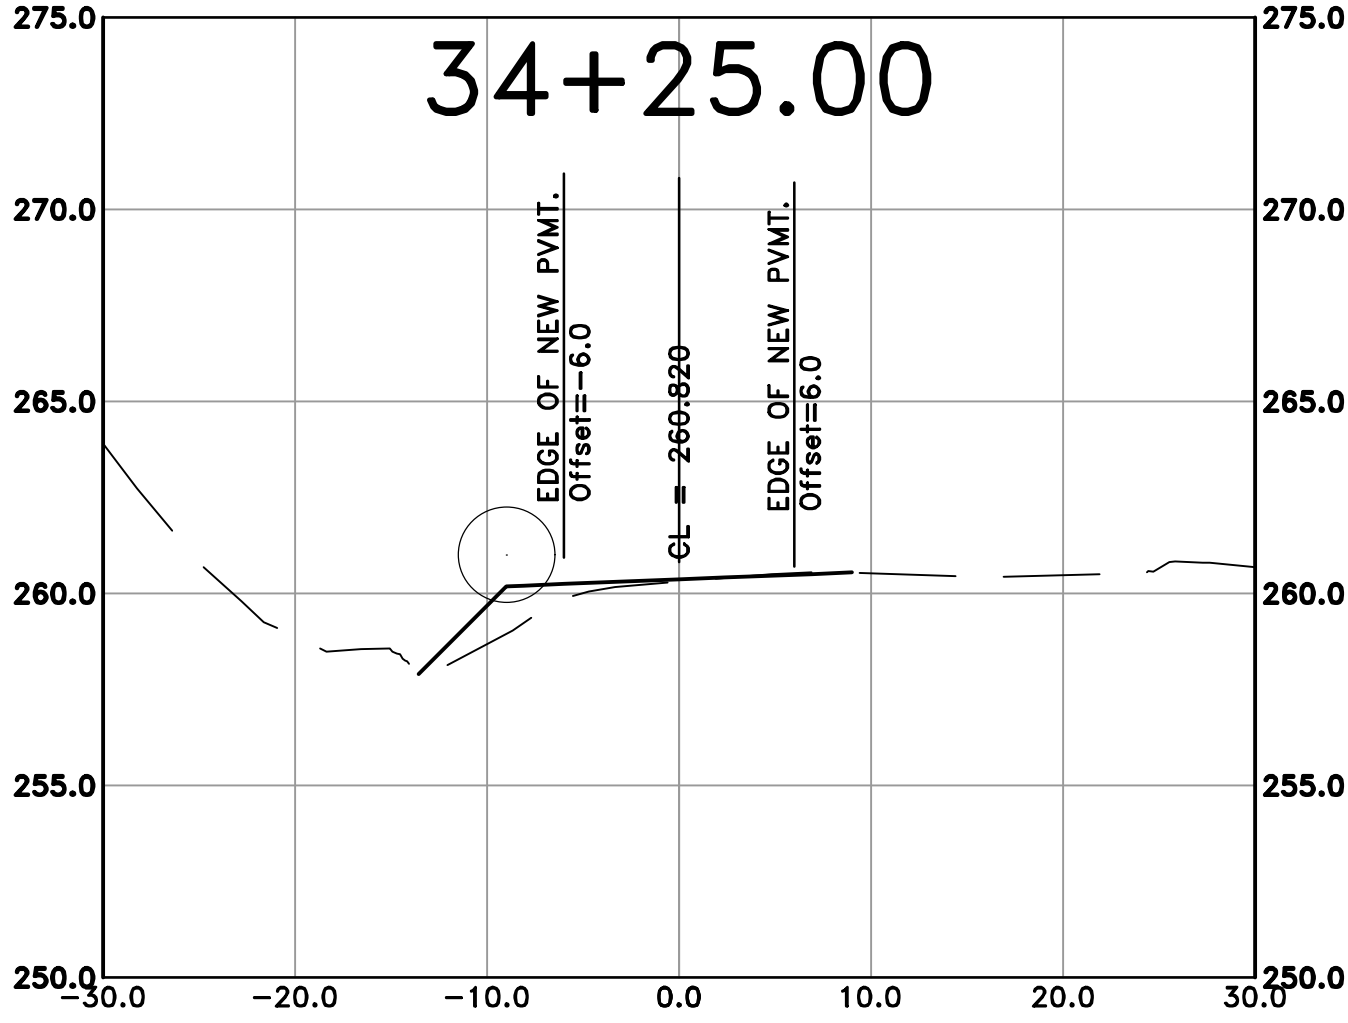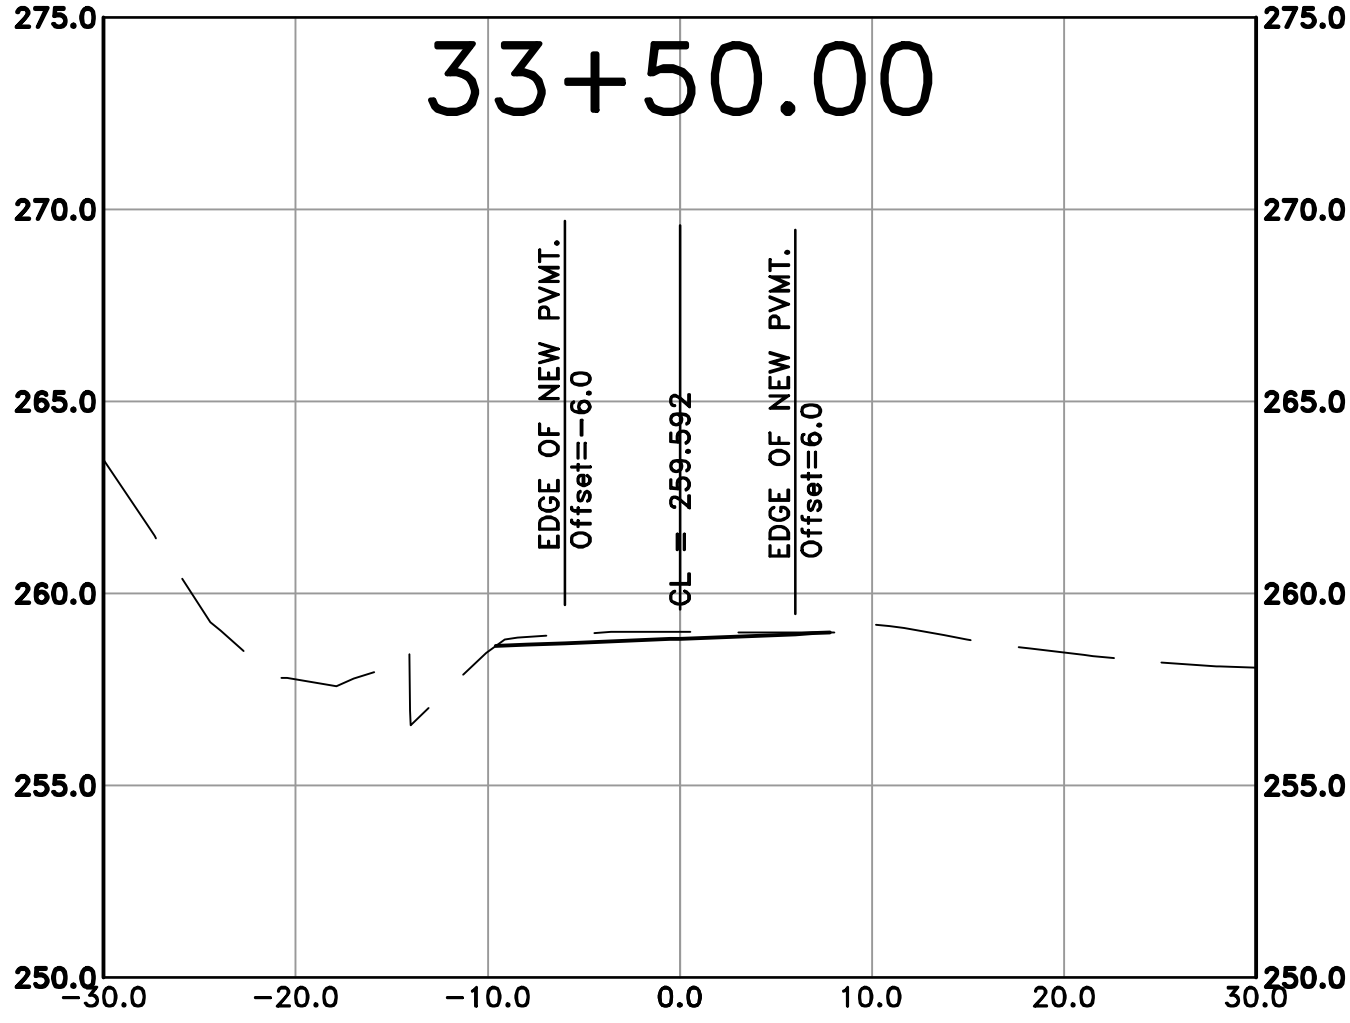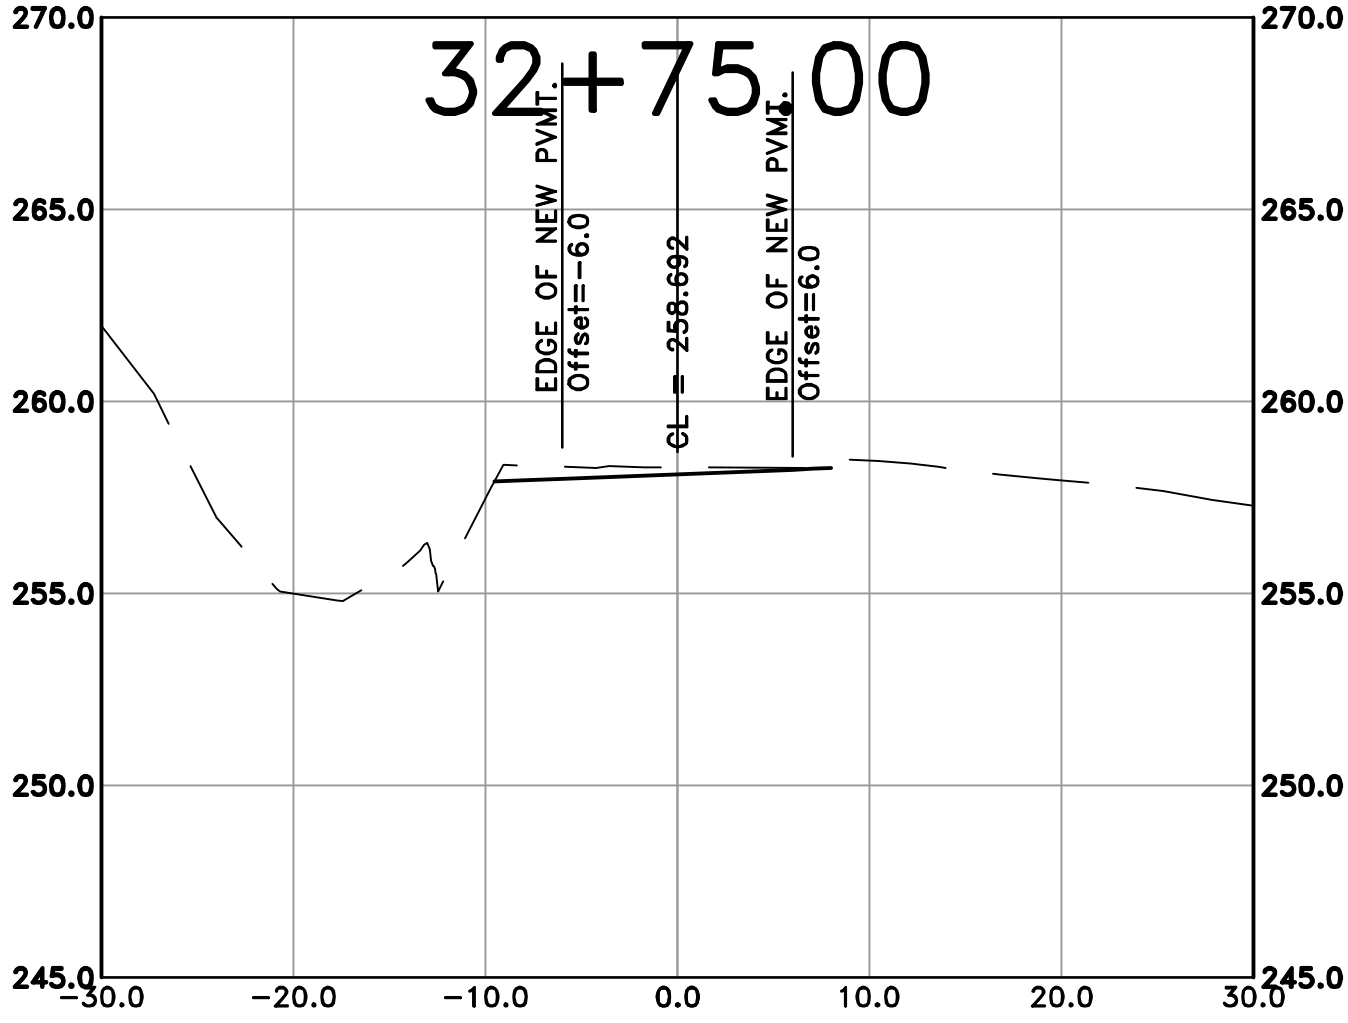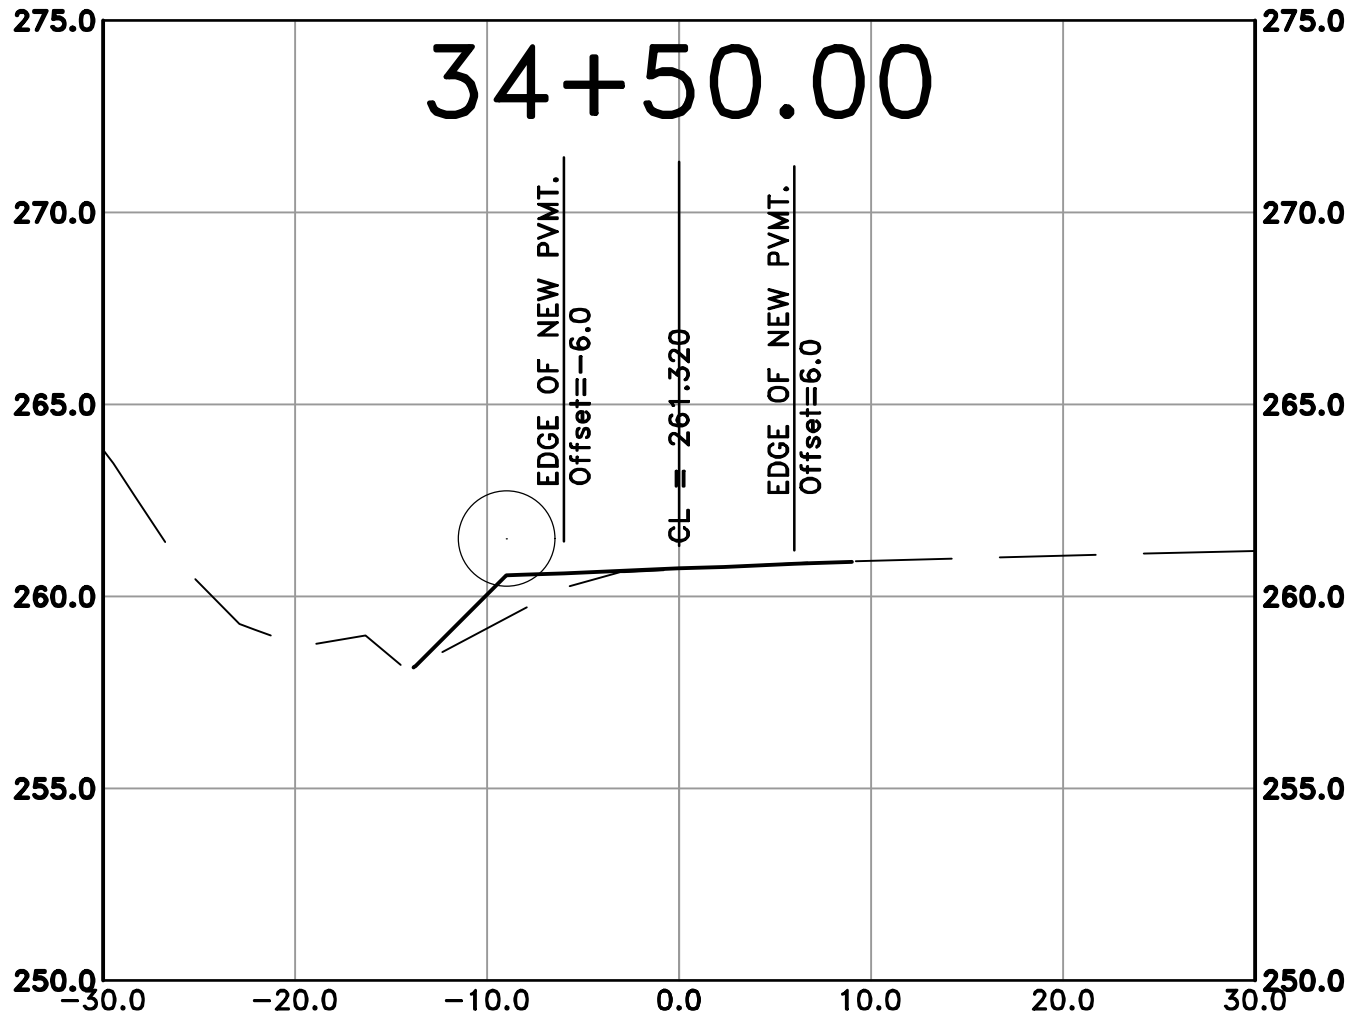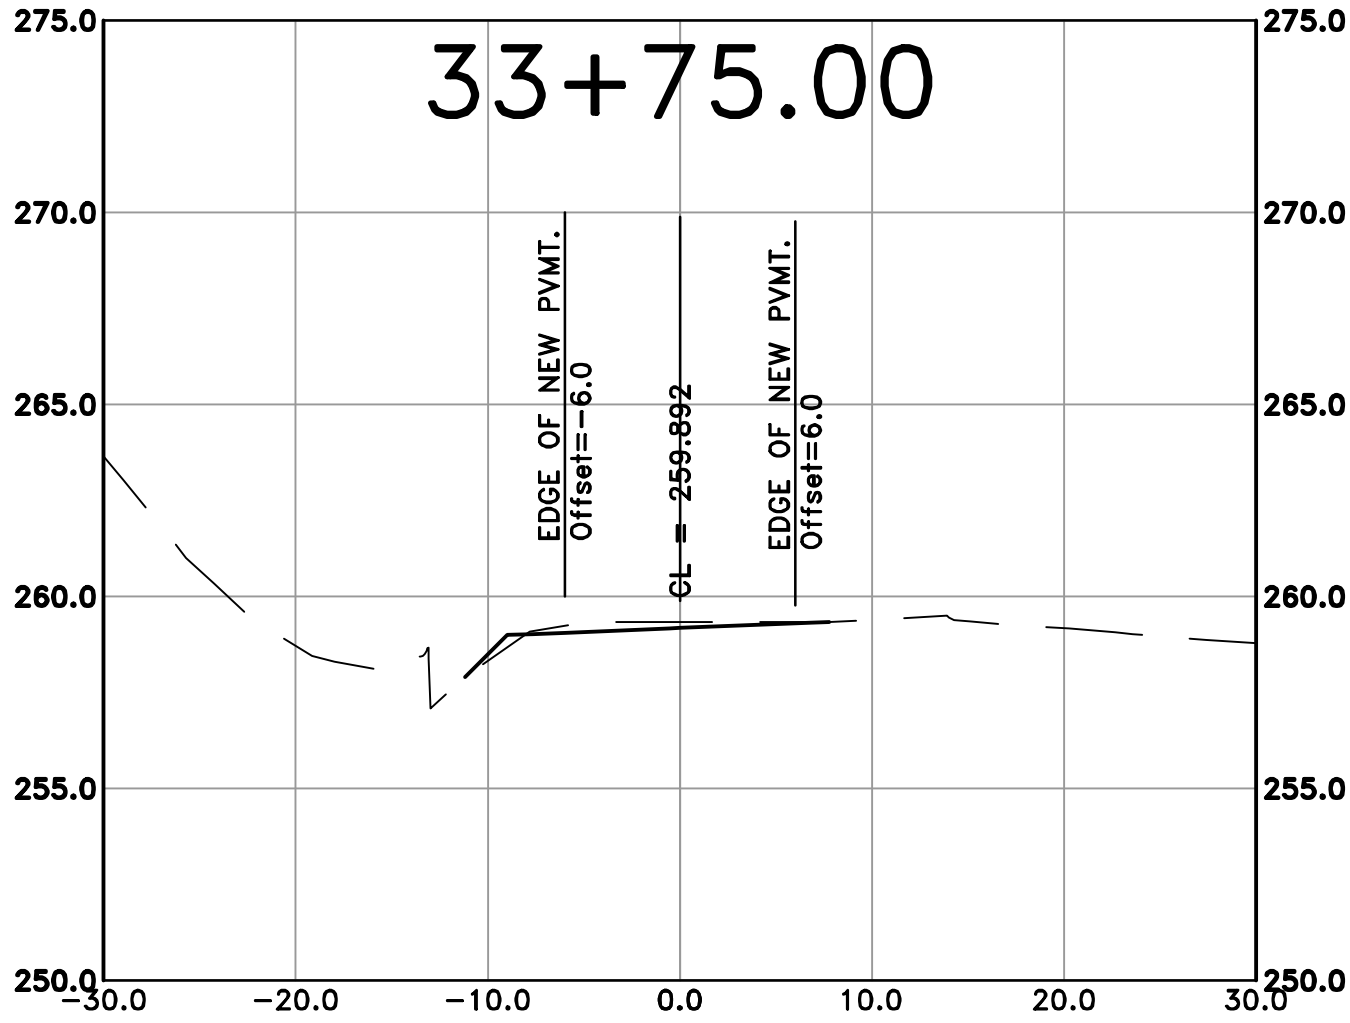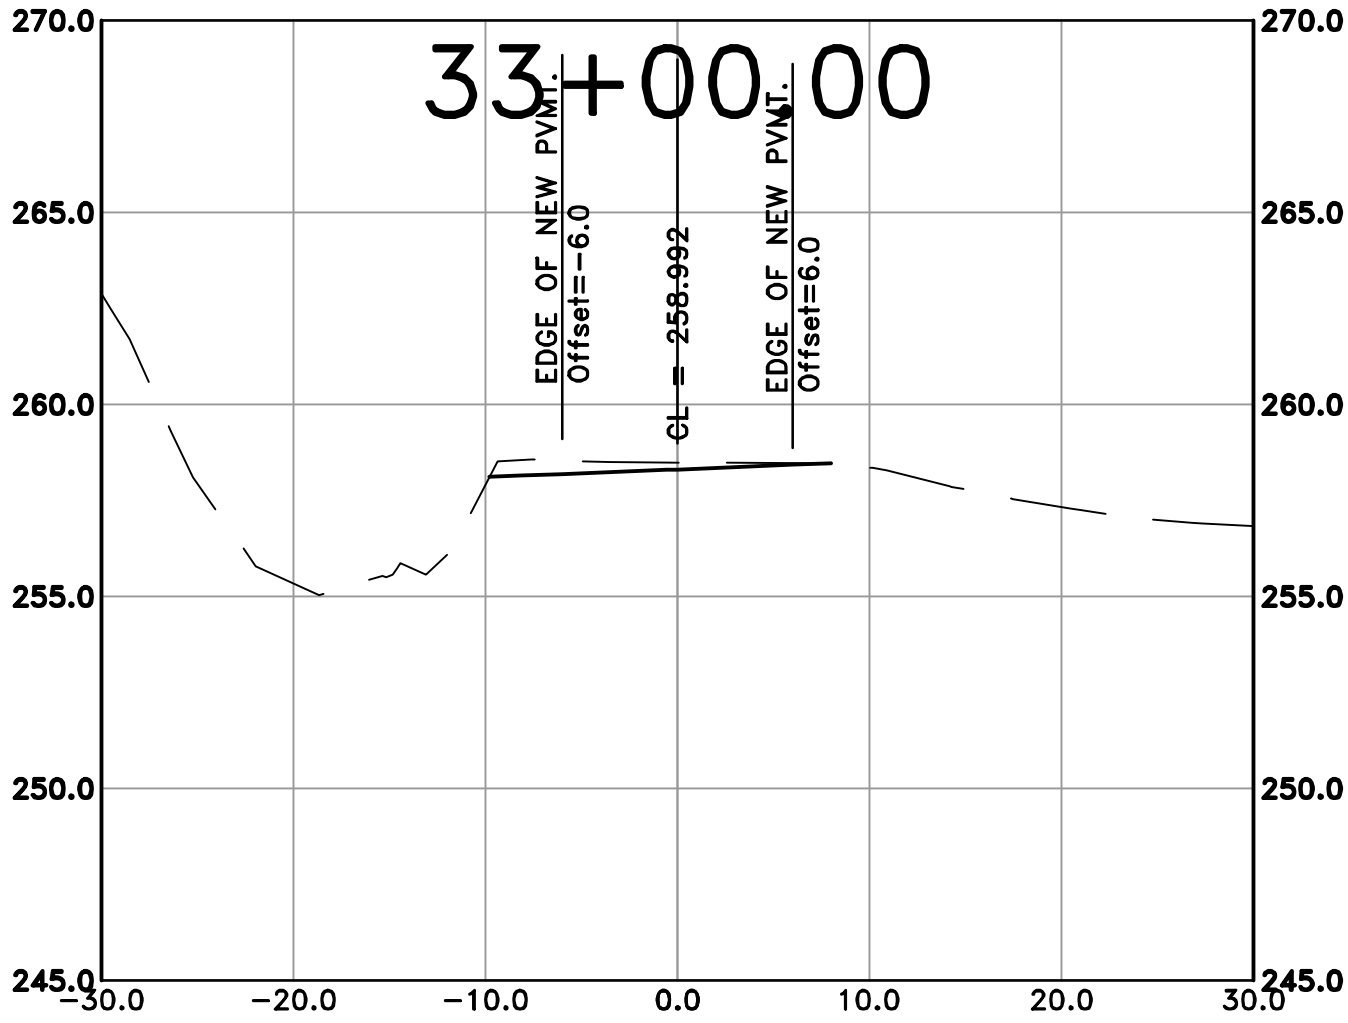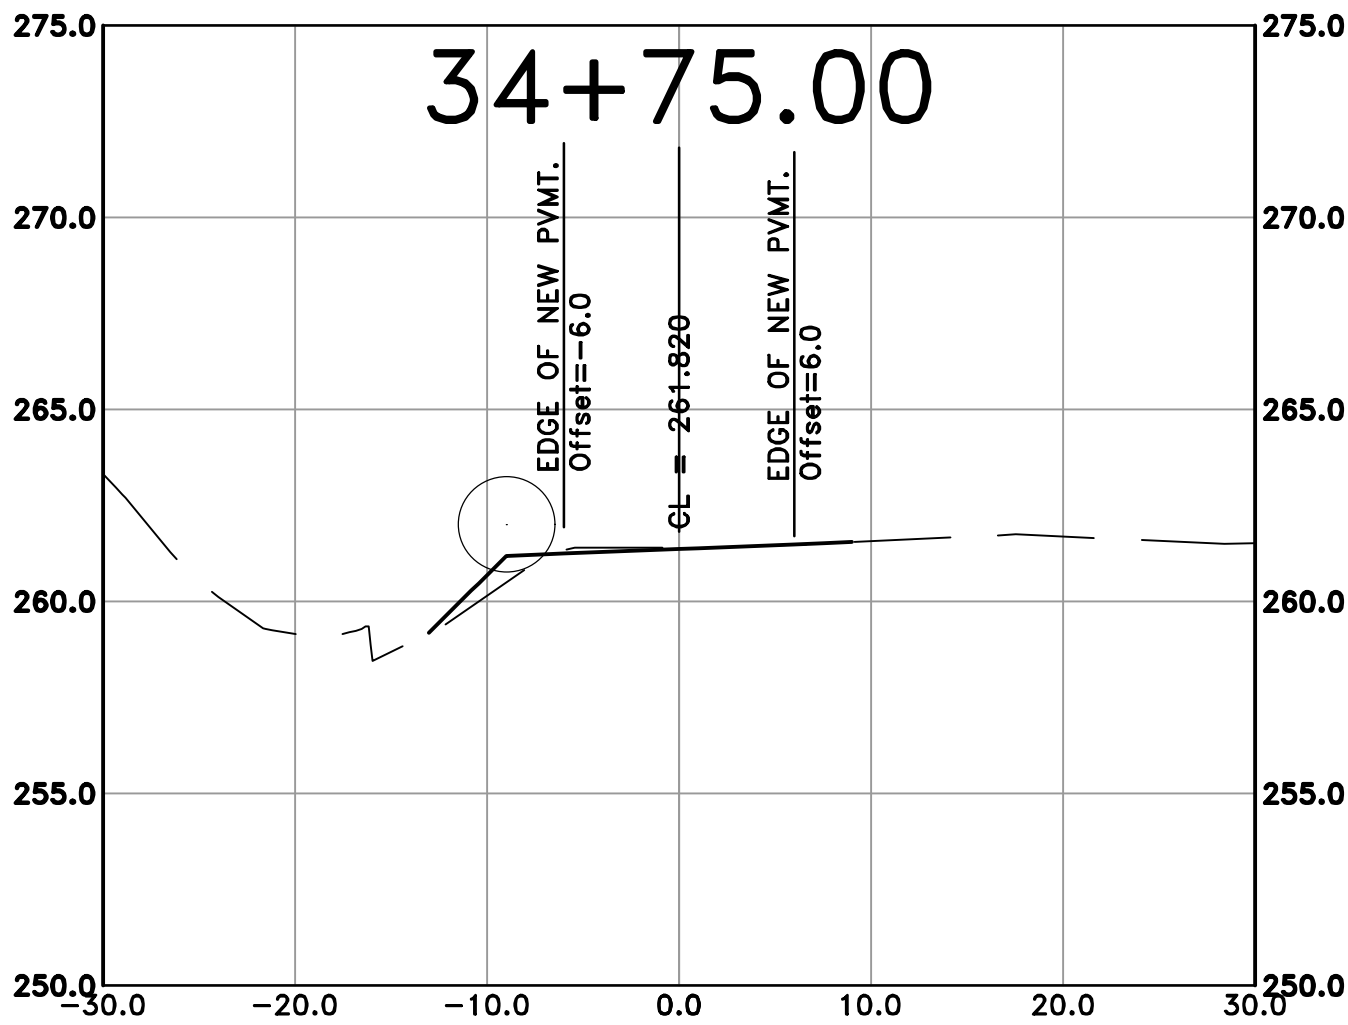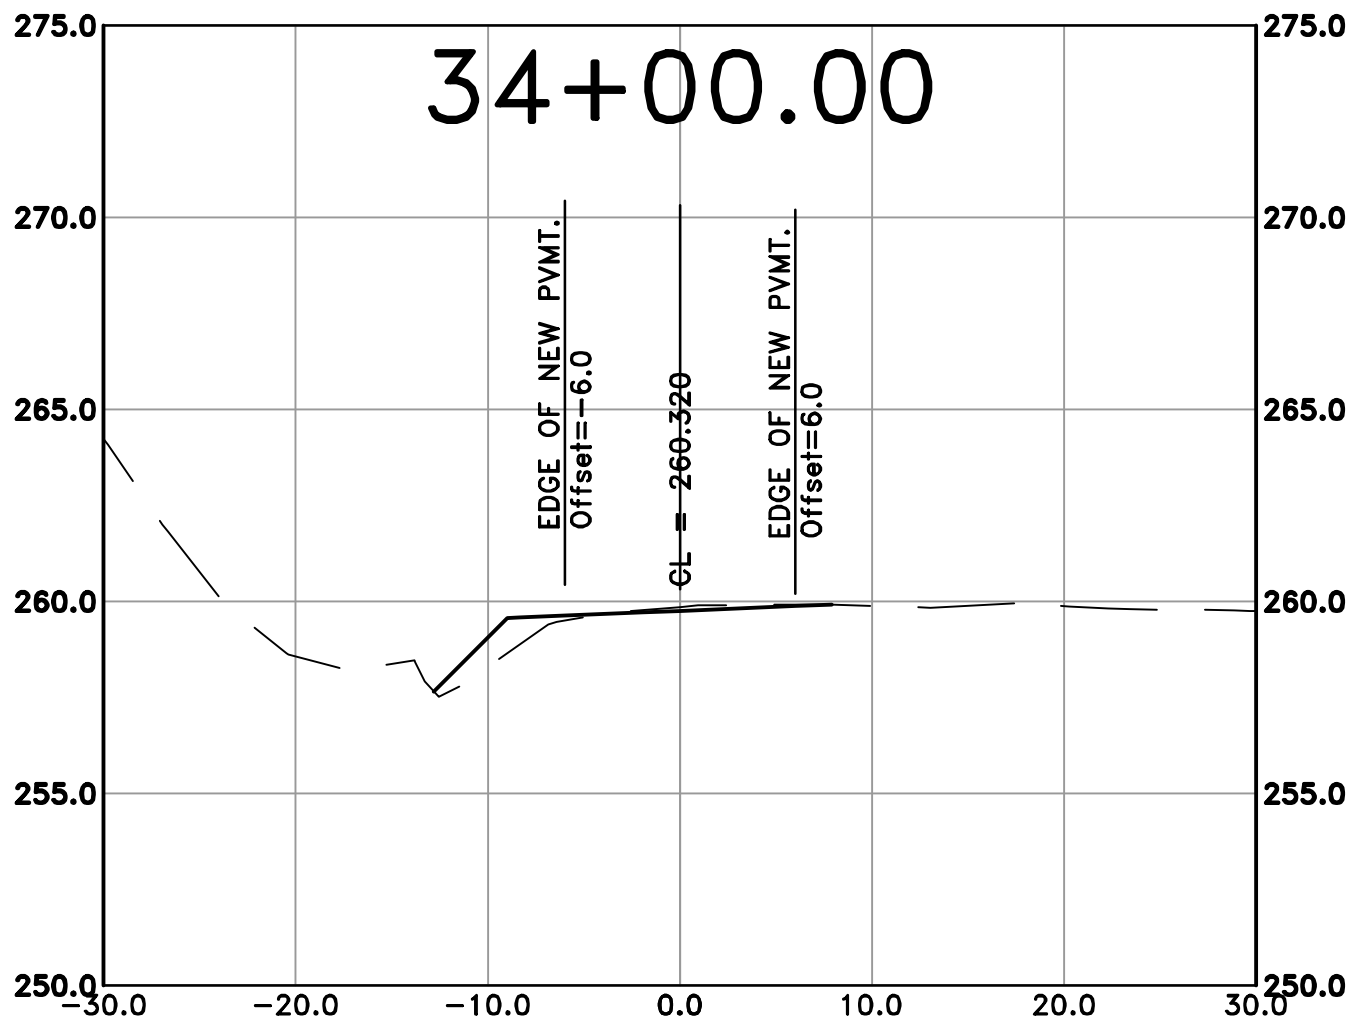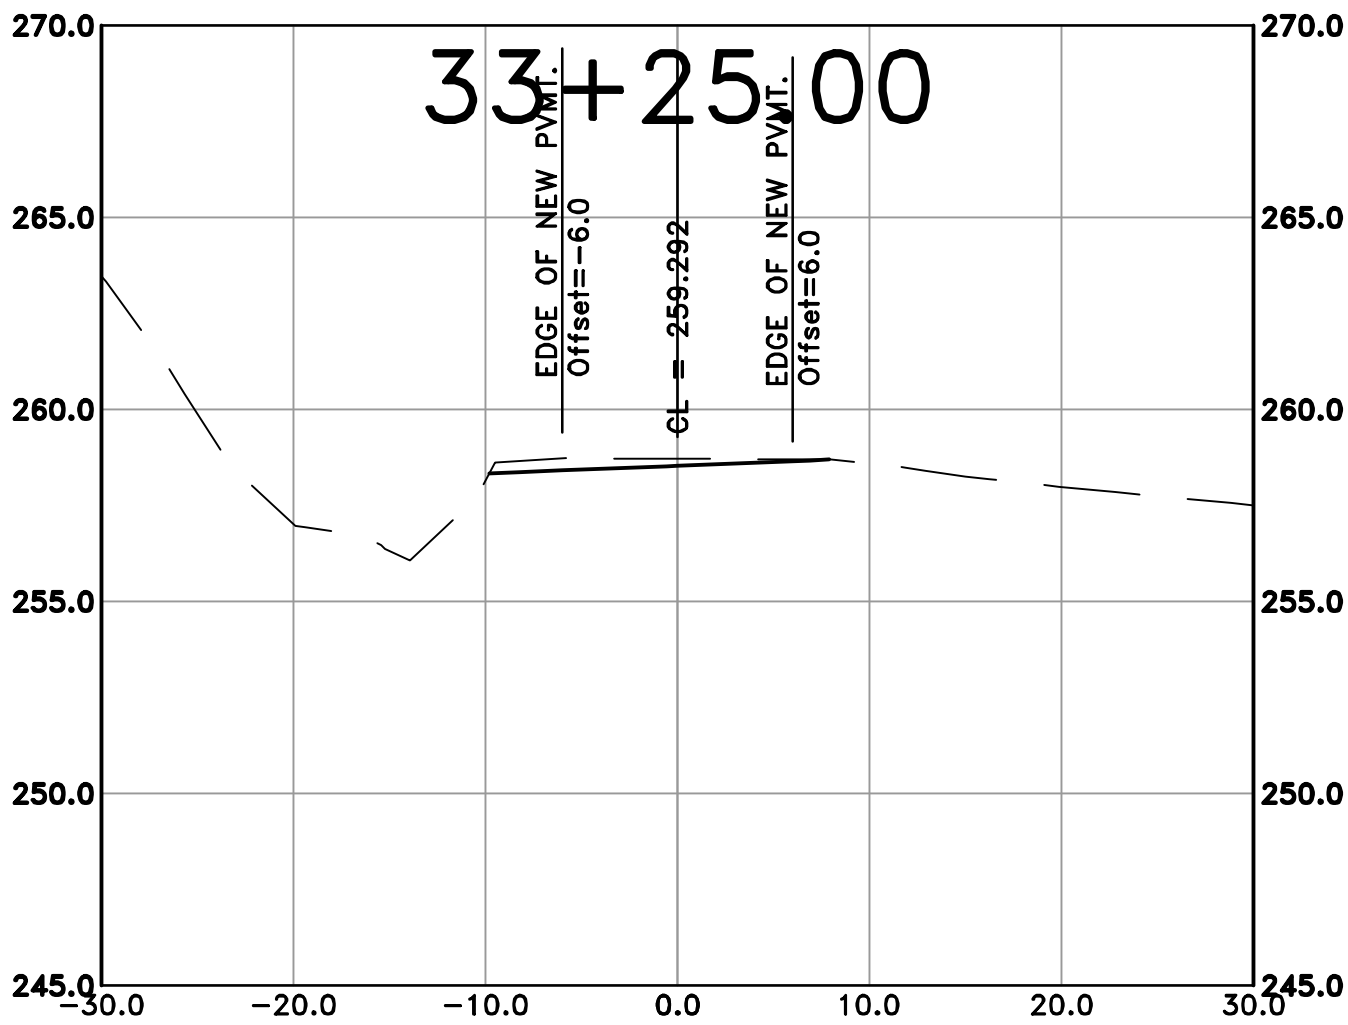

REVISIONS	DATE

CITY OF LITTLE ROCK, ARKANSAS

ROSE CREEK TRAIL

CROSS SECTION SHEET 11

DEPARTMENT OF PUBLIC WORKS

CIVIL ENGINEERING










701 W. MARKHAM

LITTLE ROCK, ARKANSAS 72201



DRAWN BY	AS
DESIGNED	LC
CHECKED	JM
DATE	05-01-2026
SCALE	H: 1"=40' 10'
V: 1"=40'	
PROJECT NO.	23805201
SHEET NO.	C60

100% SUBMITTAL

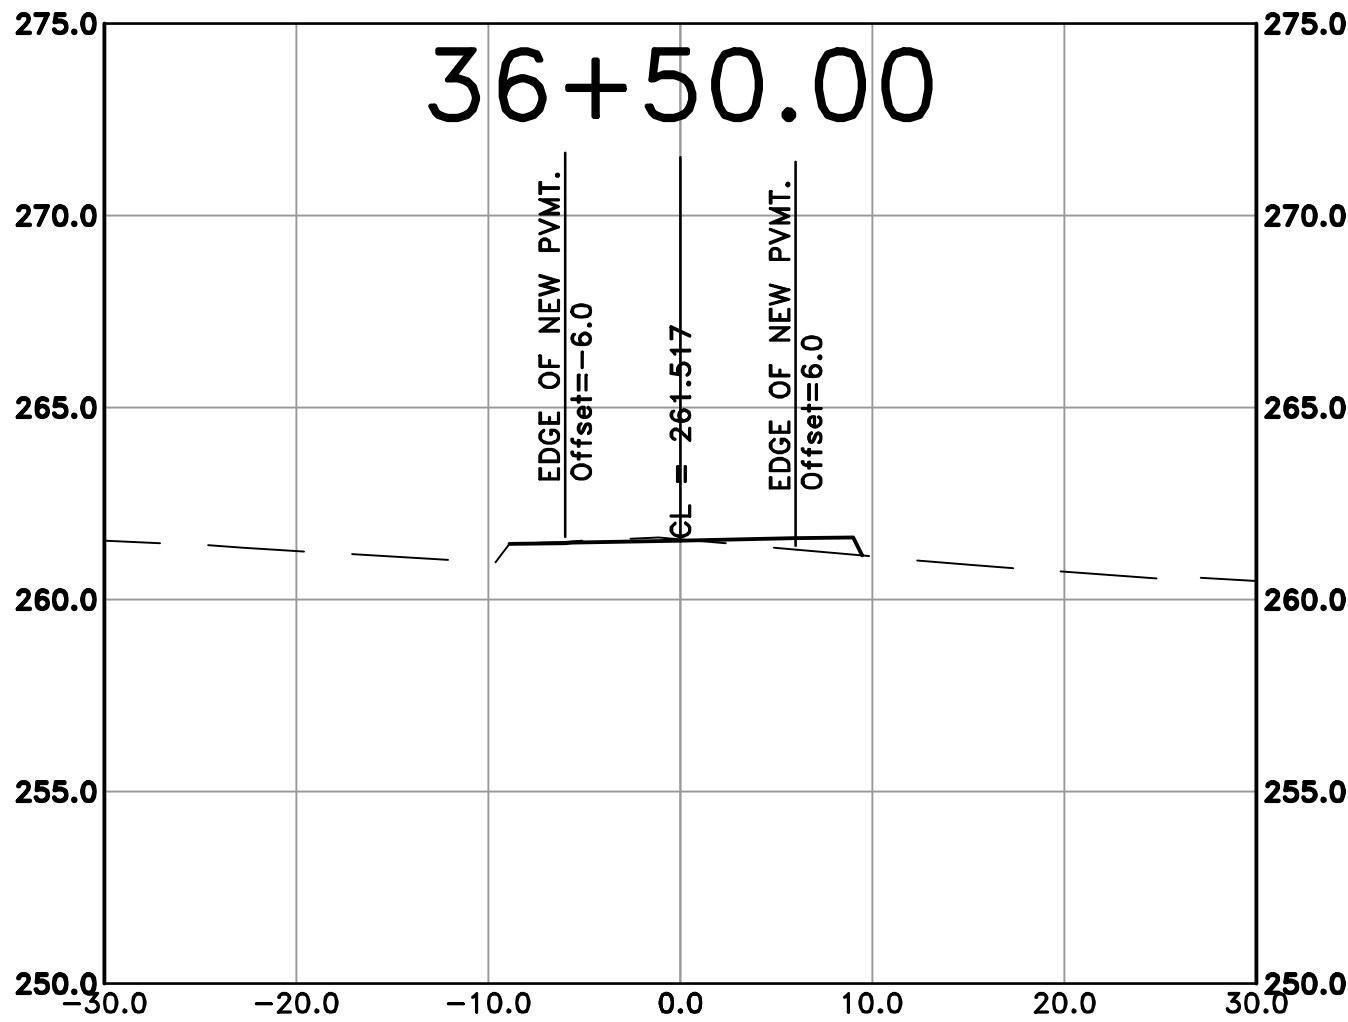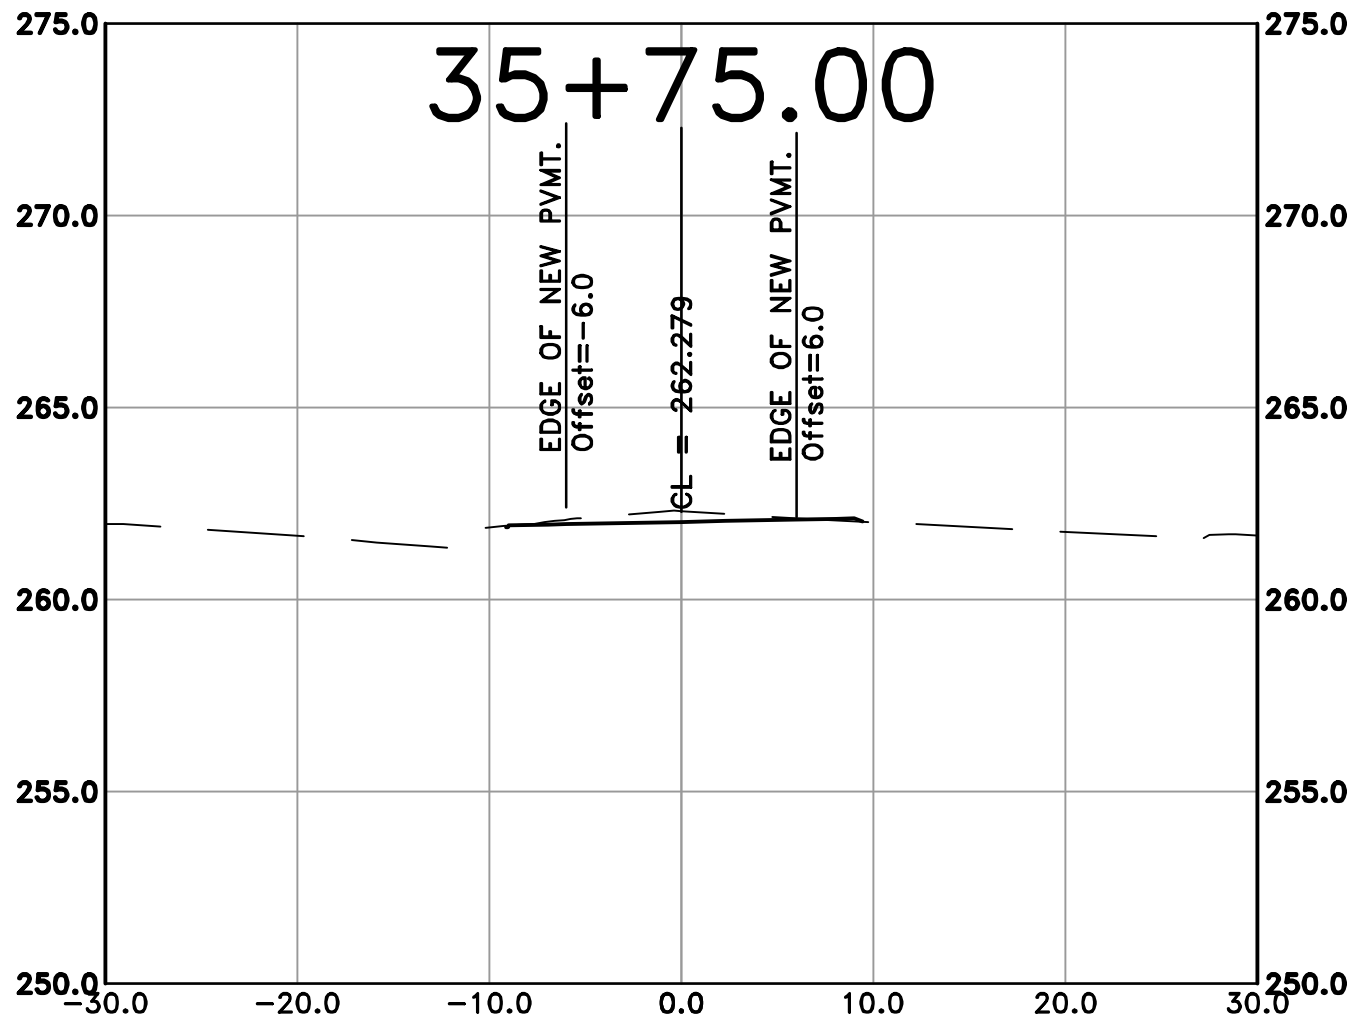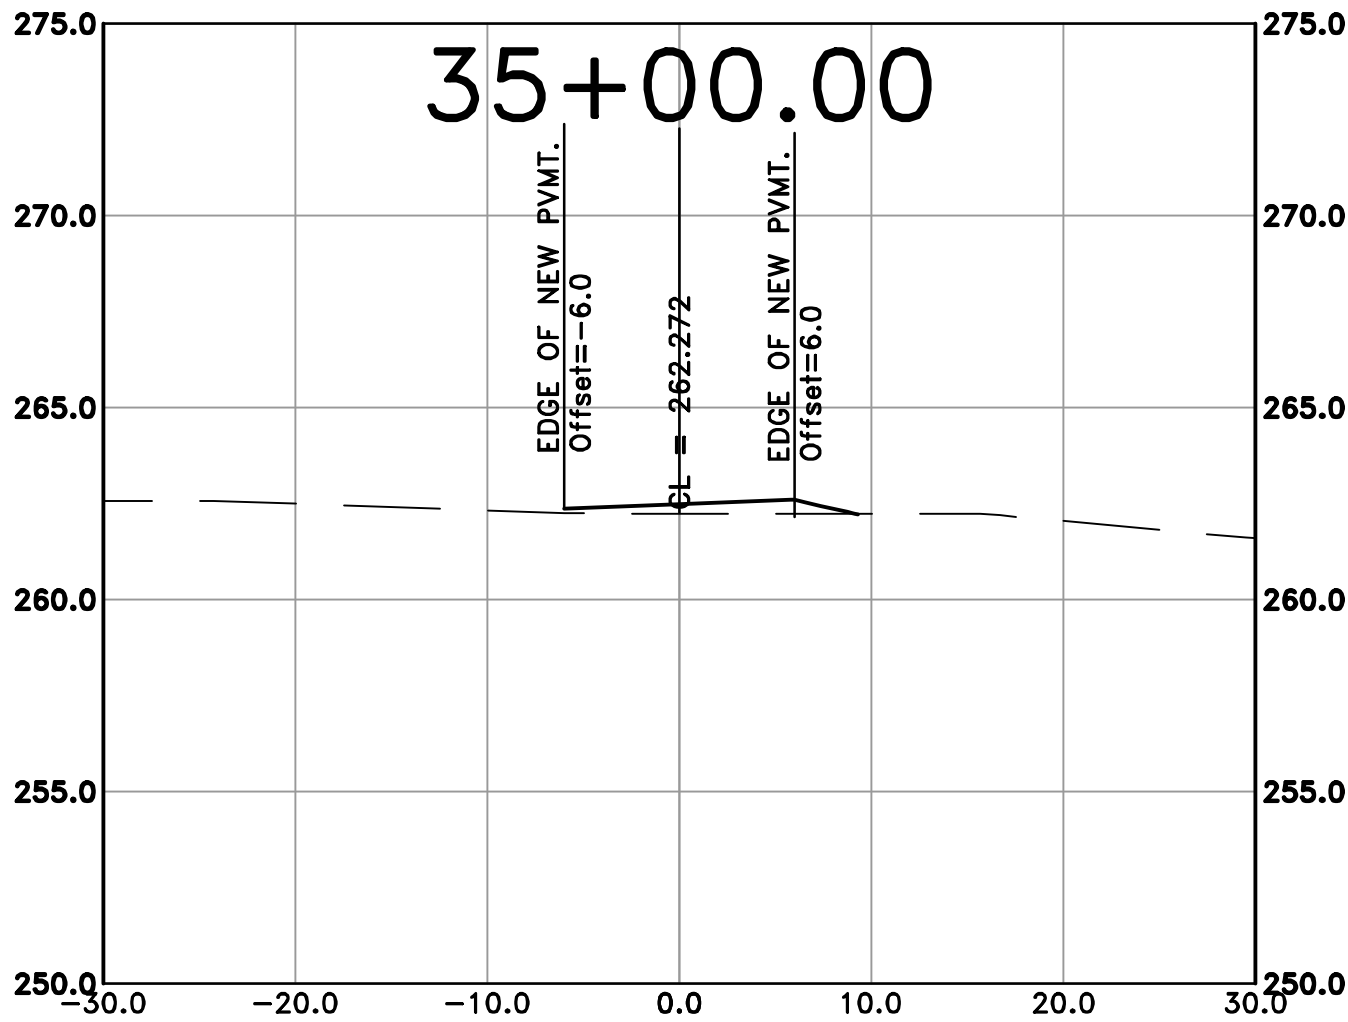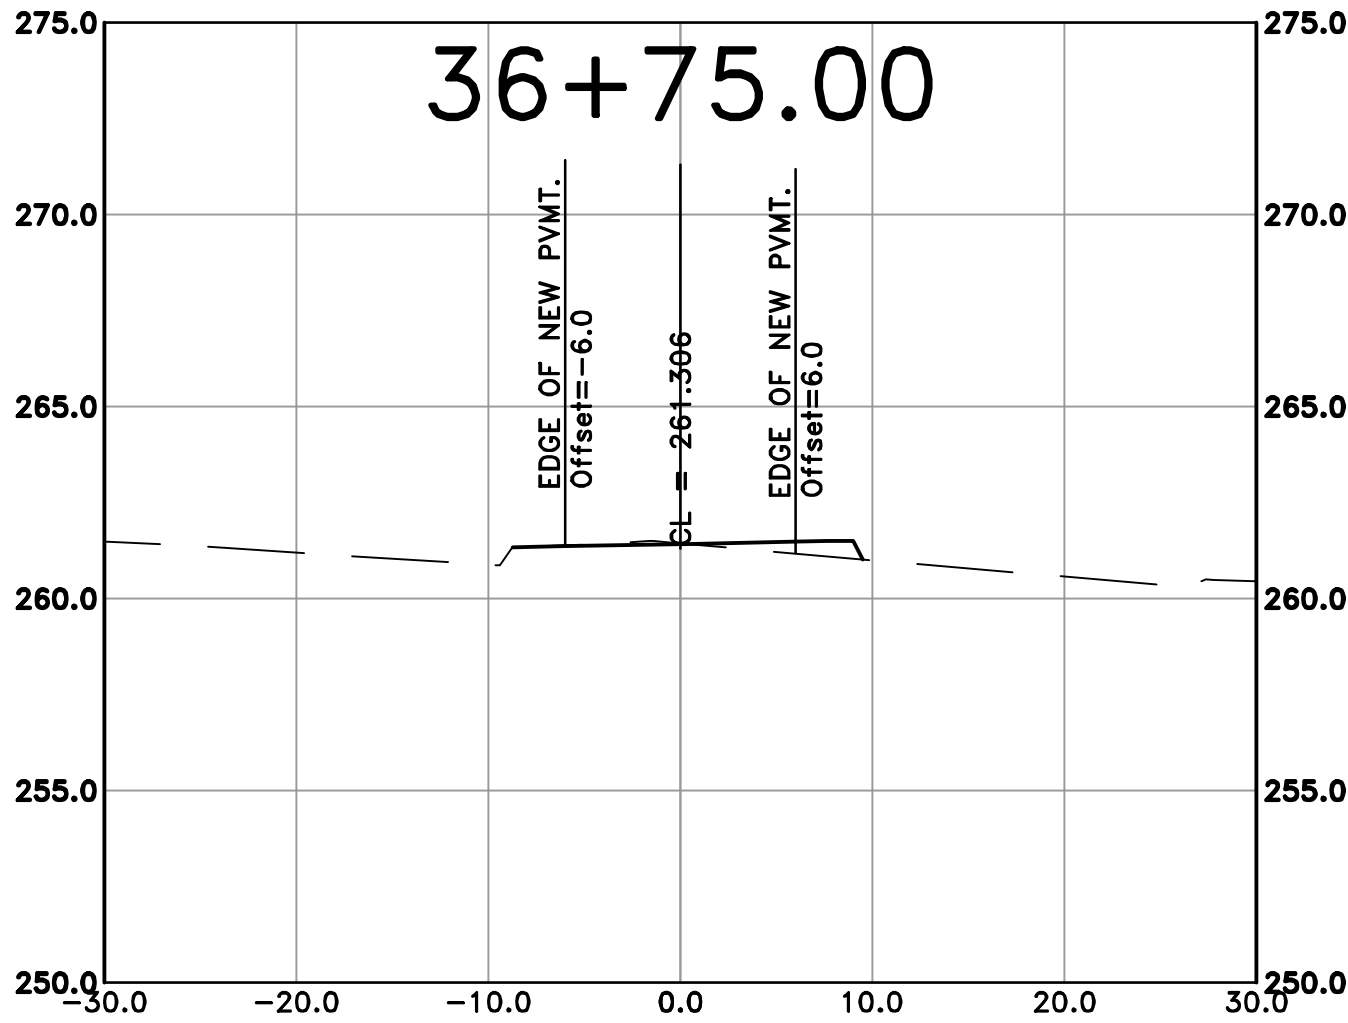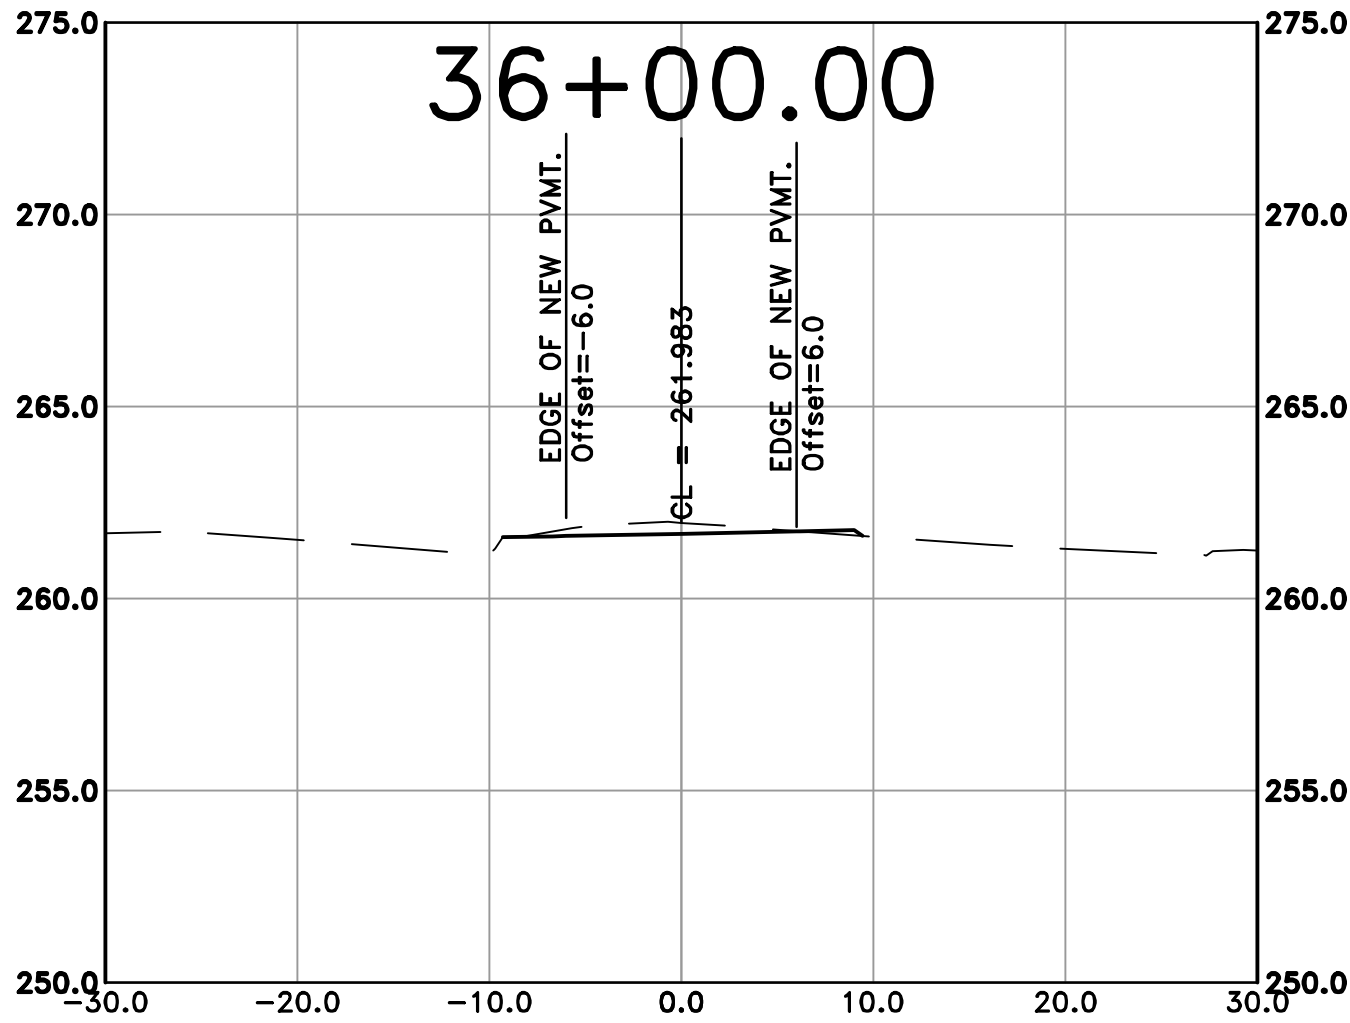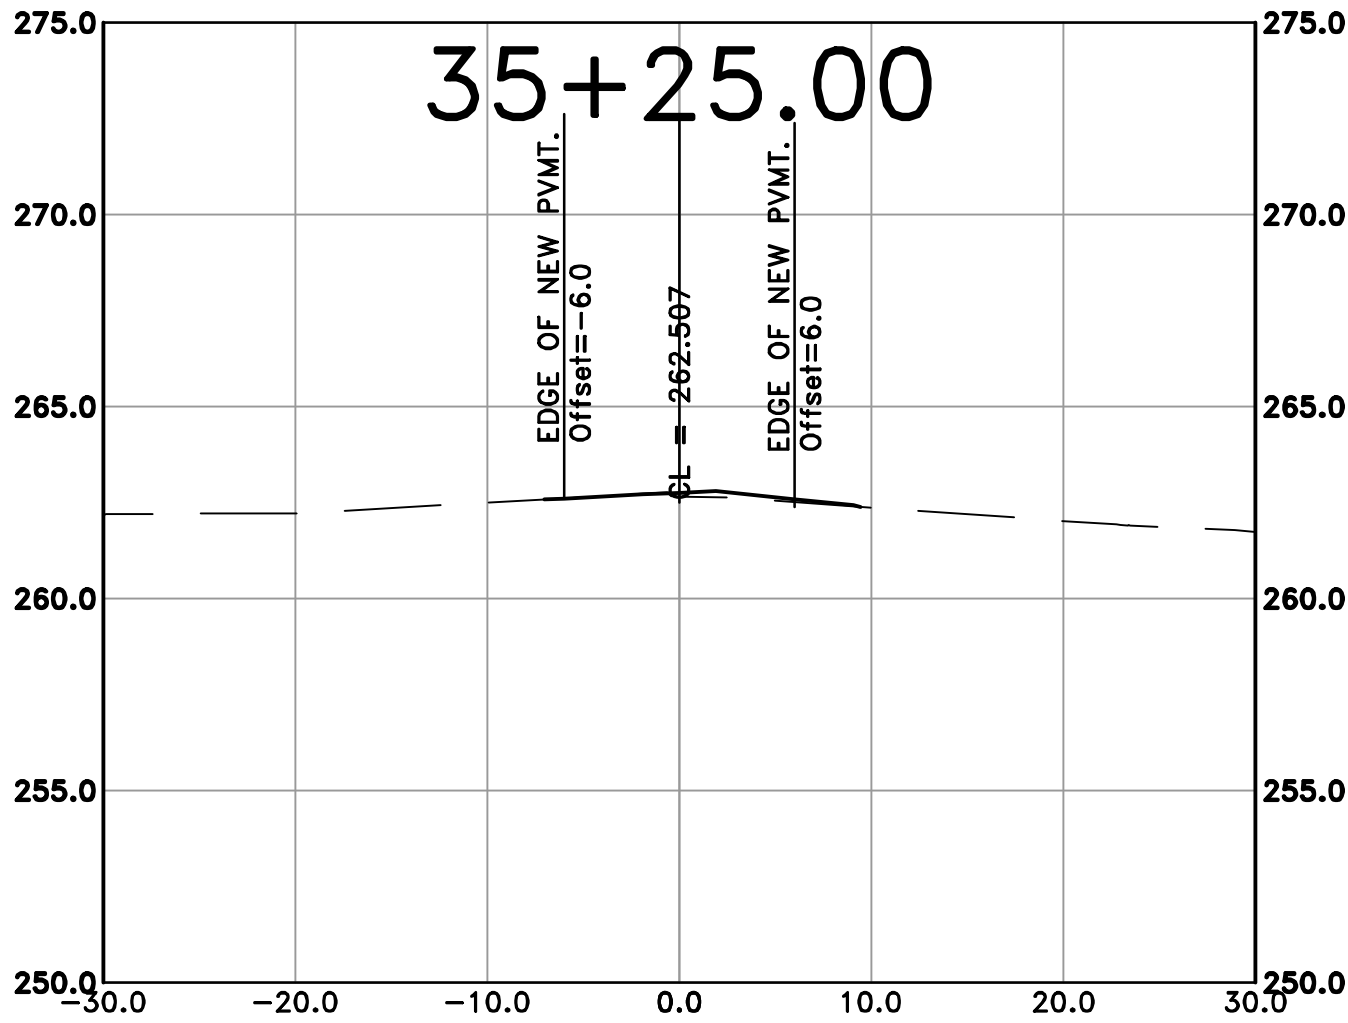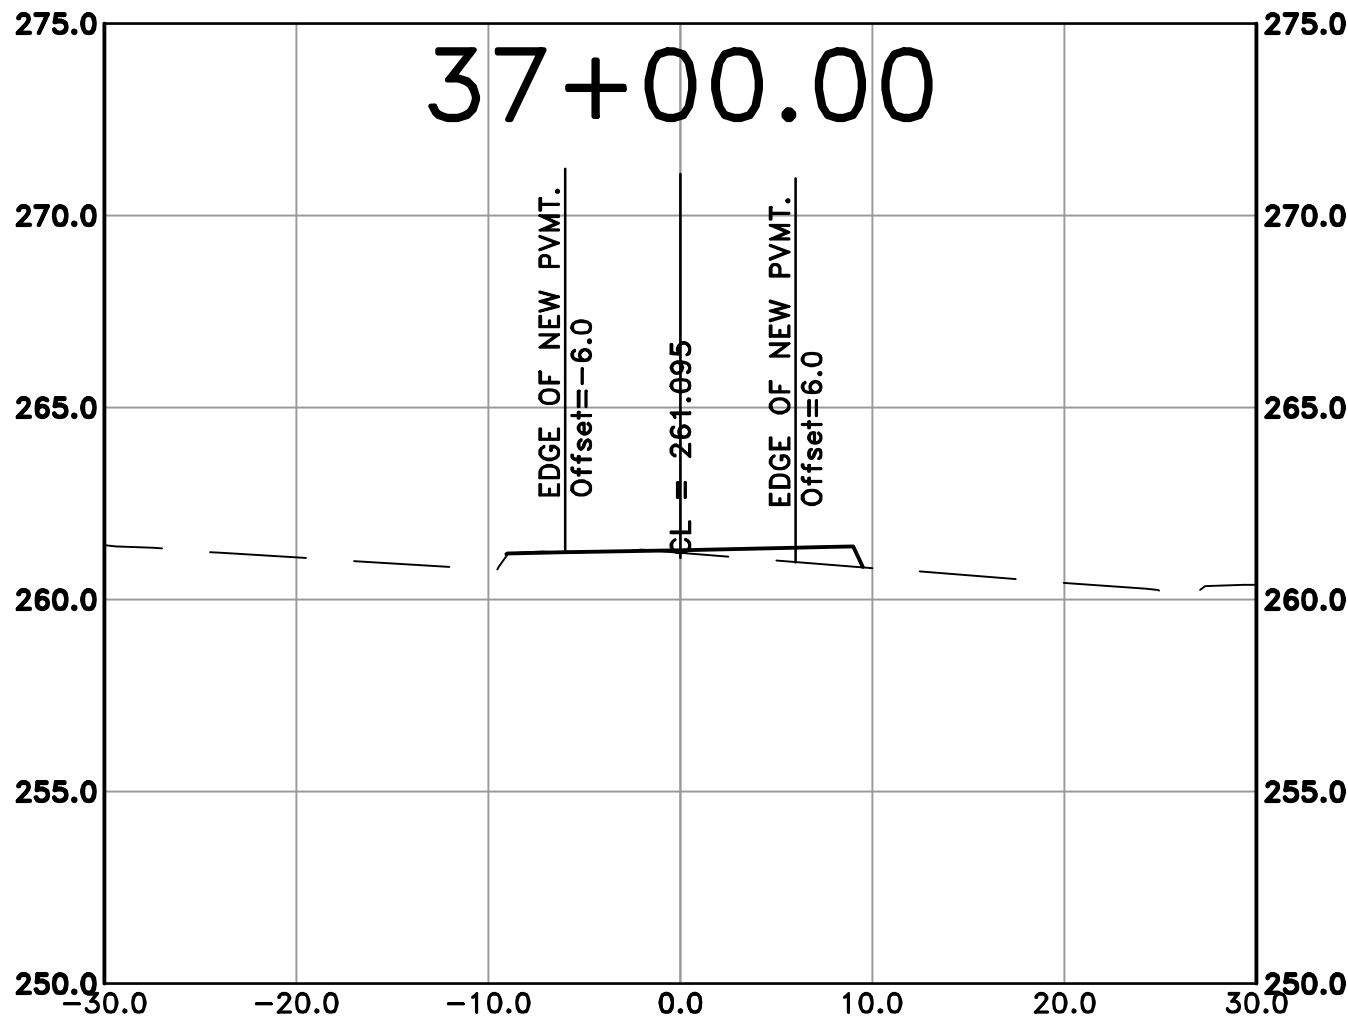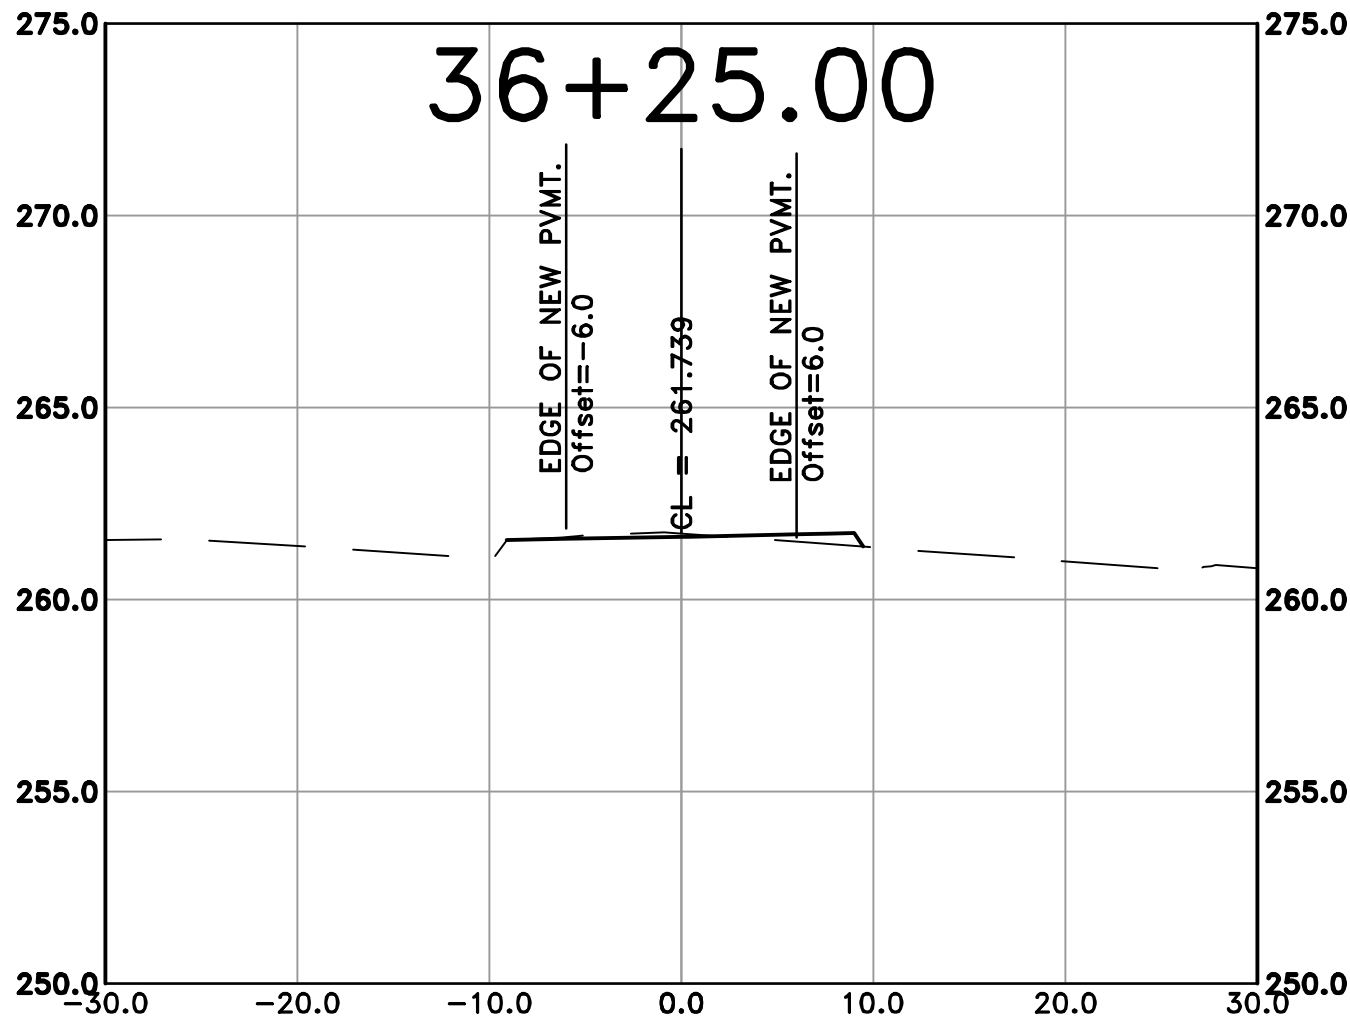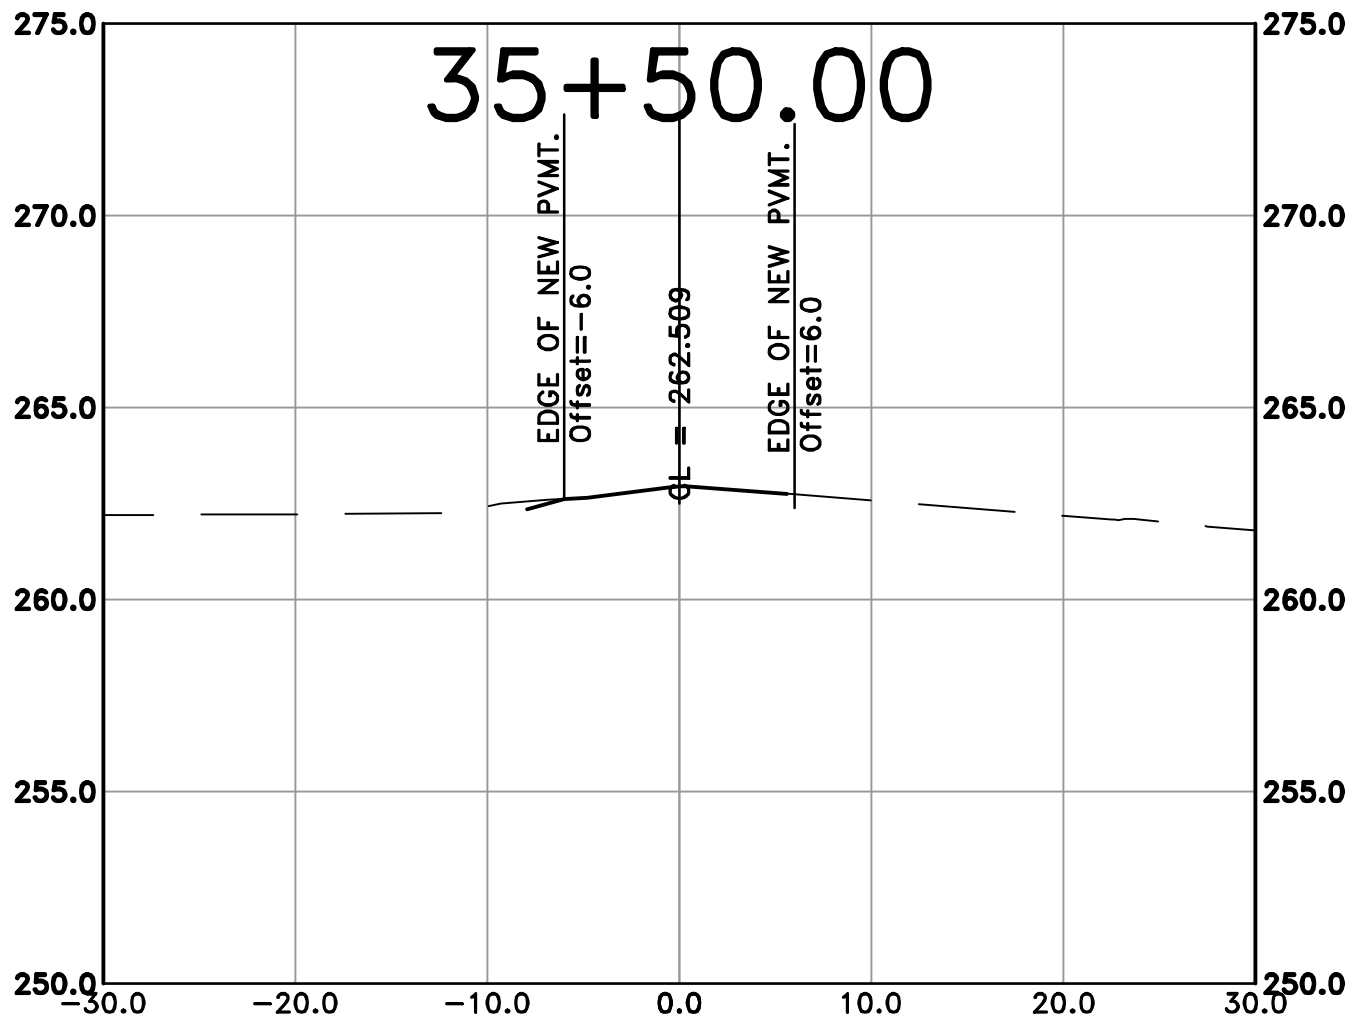

REVISIONS	DATE










CITY OF LITTLE ROCK, ARKANSAS
ROSE CREEK TRAIL
CROSS SECTION SHEET 12

DEPARTMENT OF PUBLIC WORKS
CIVIL ENGINEERING
701 W. MARKHAM
LITTLE ROCK, ARKANSAS 72201



DRAWN BY AS
DESIGNED LC
CHECKED JM
DATE 05-01-2026
SCALE H: 1"=40' V: 1"=10'
PROJECT NO. 23805201
SHEET NO. C61

100% SUBMITTAL

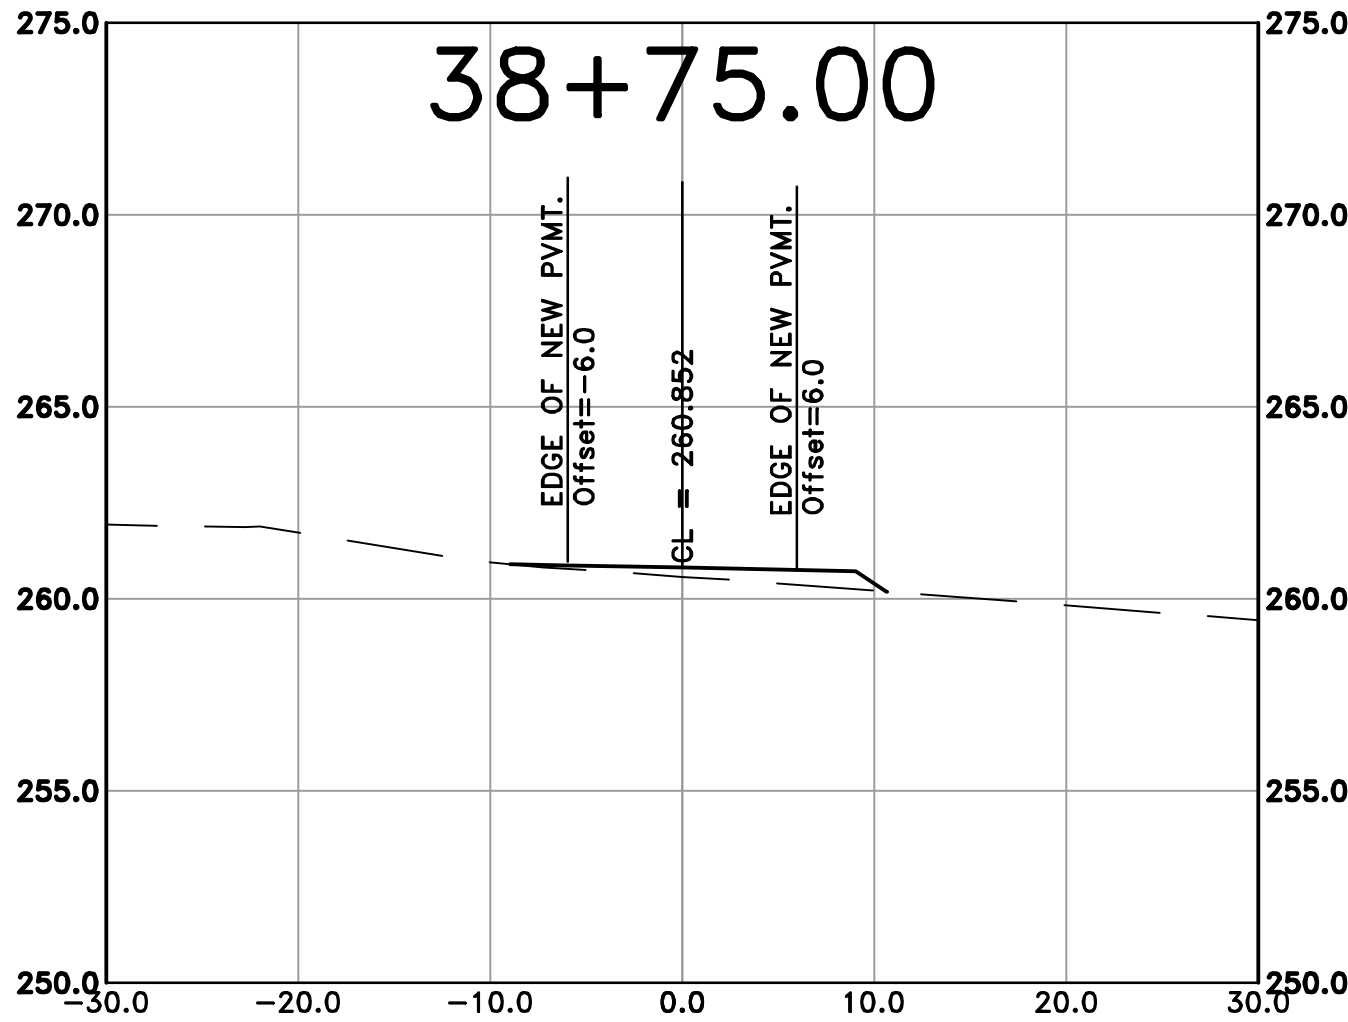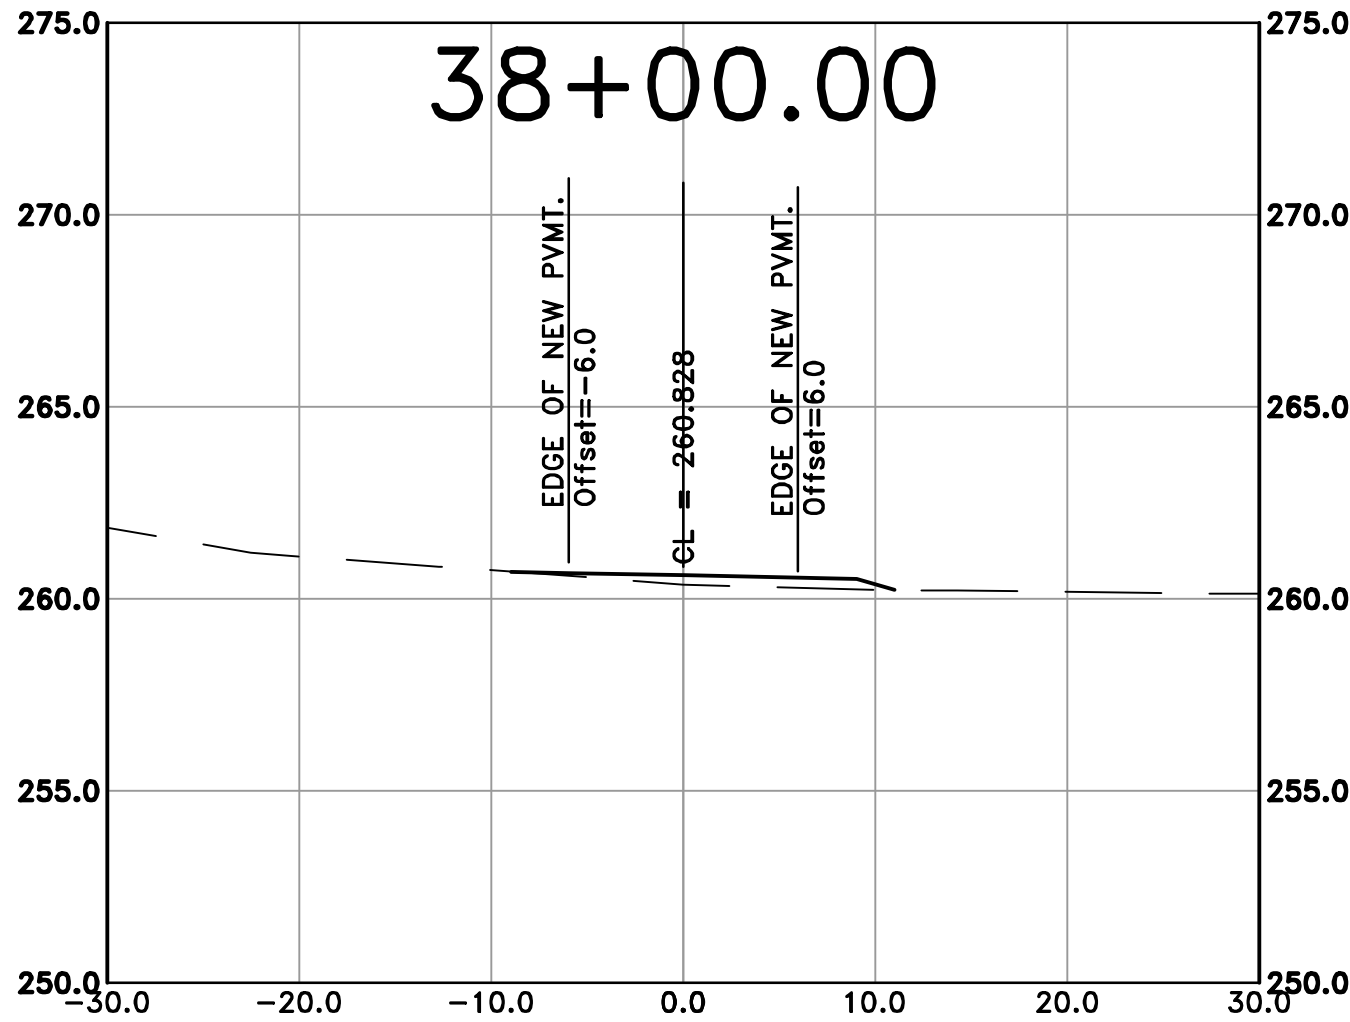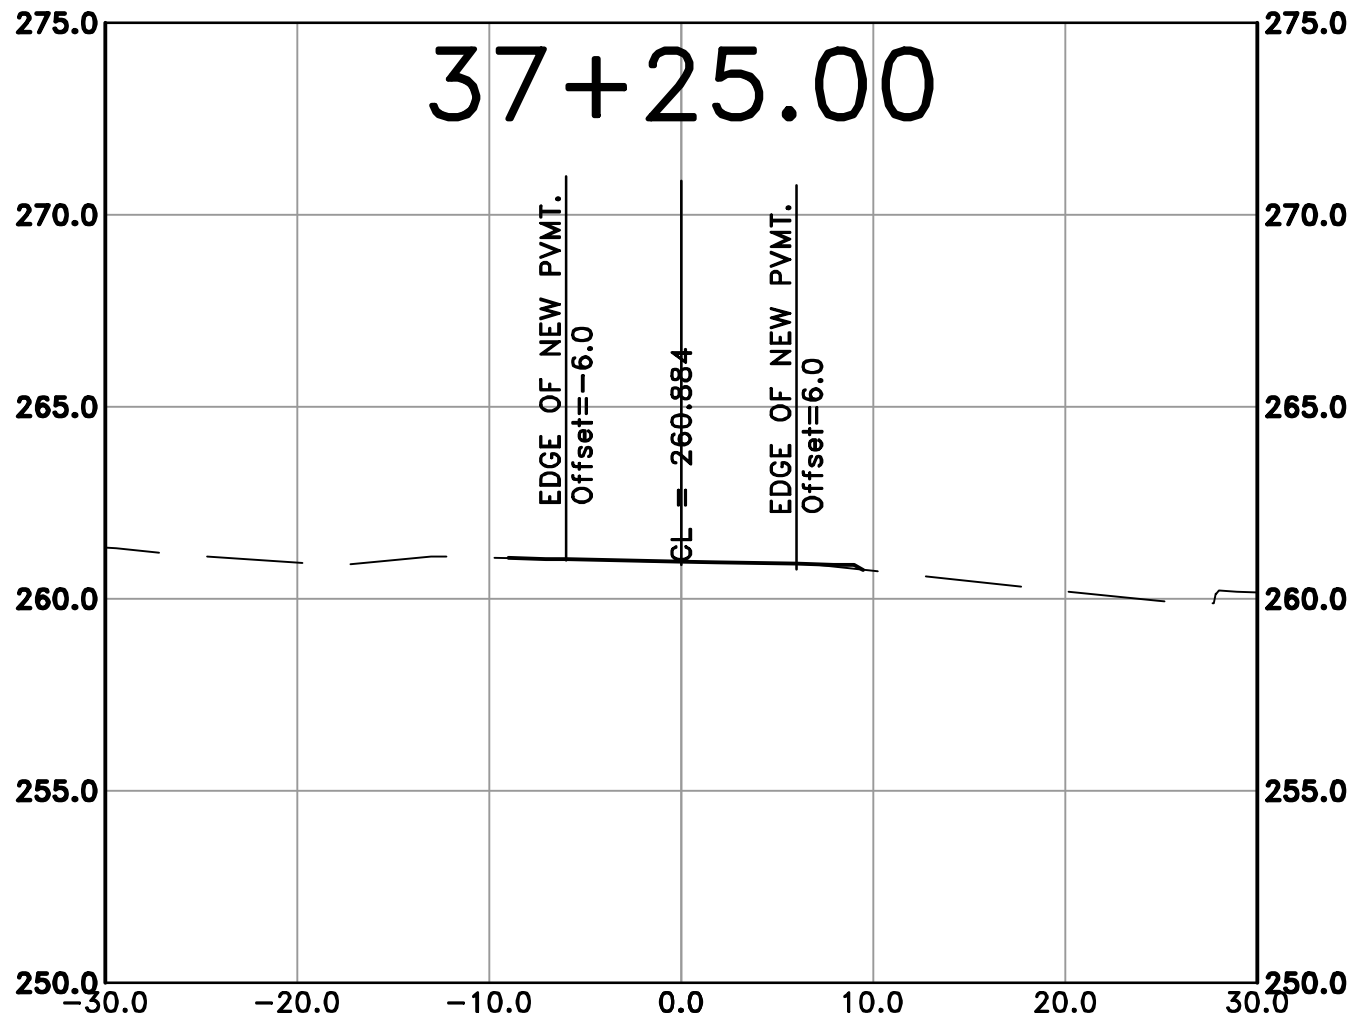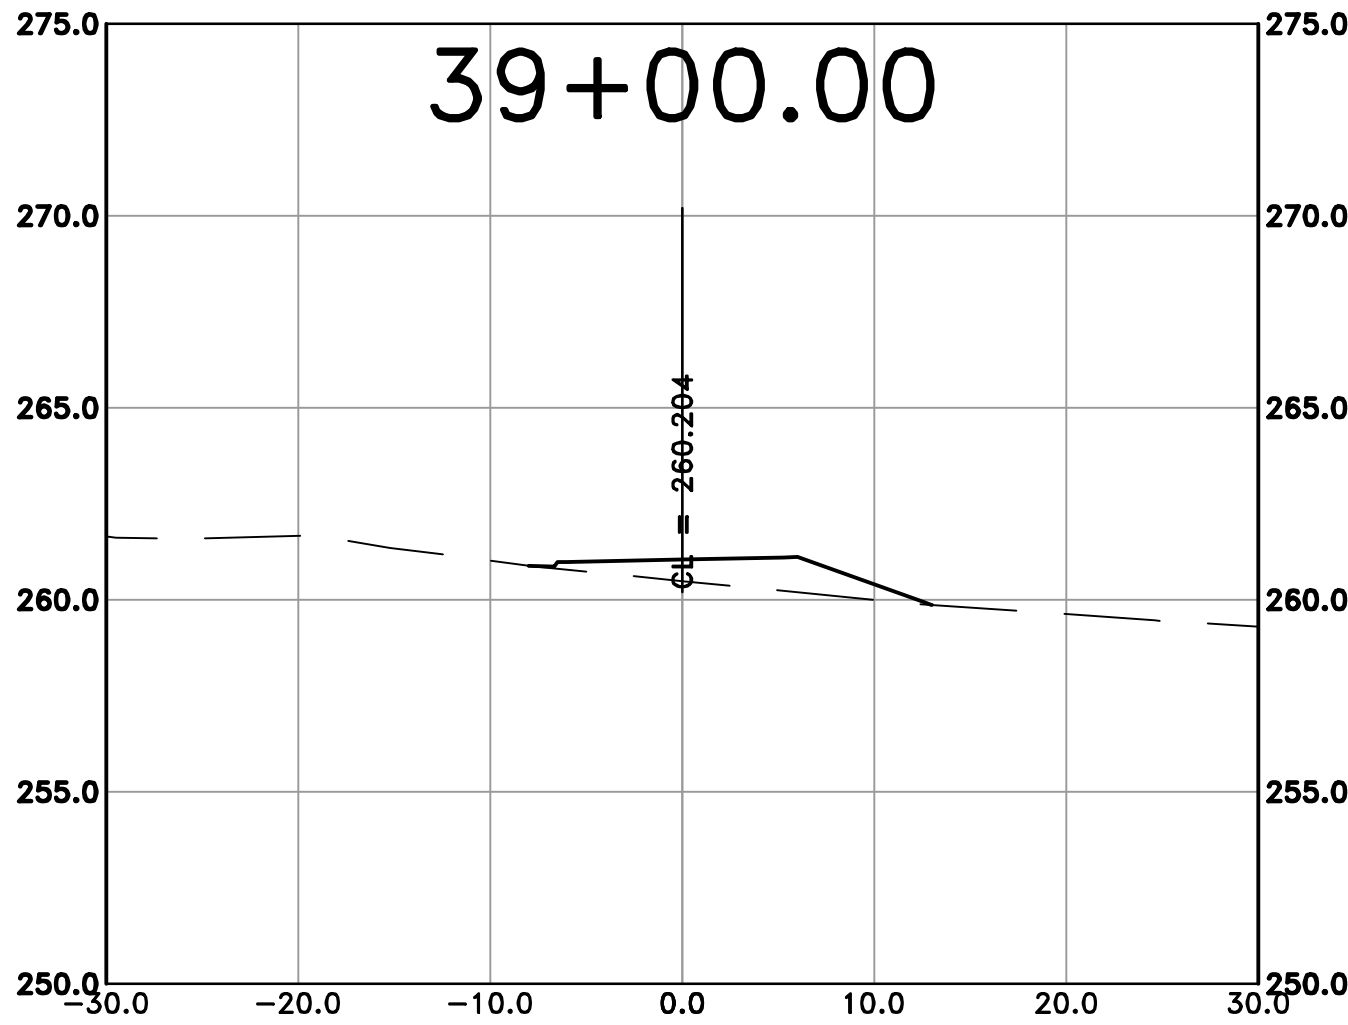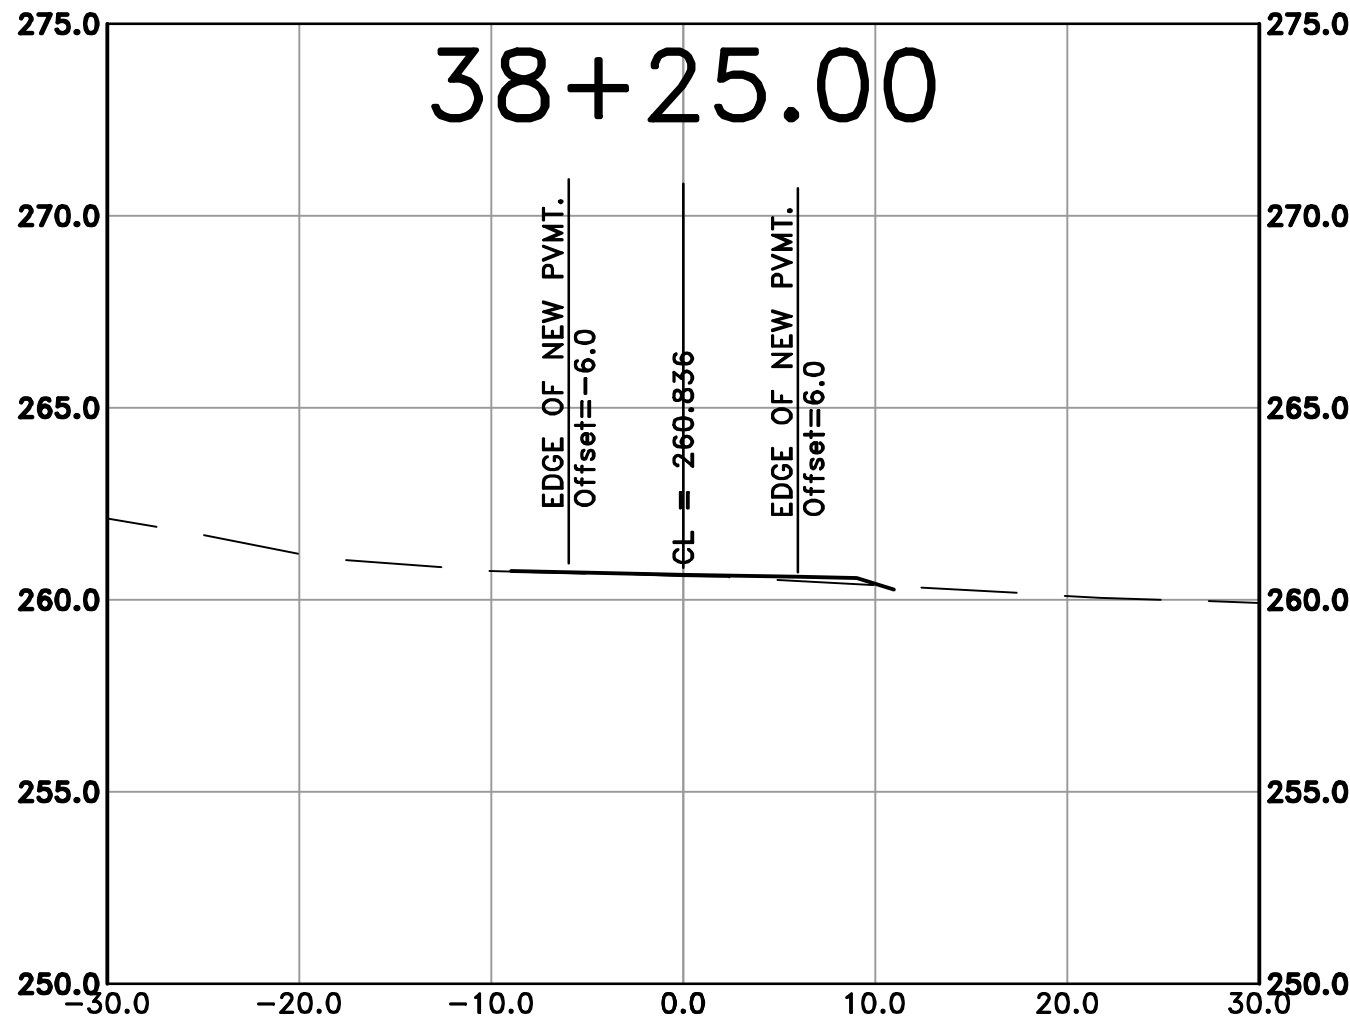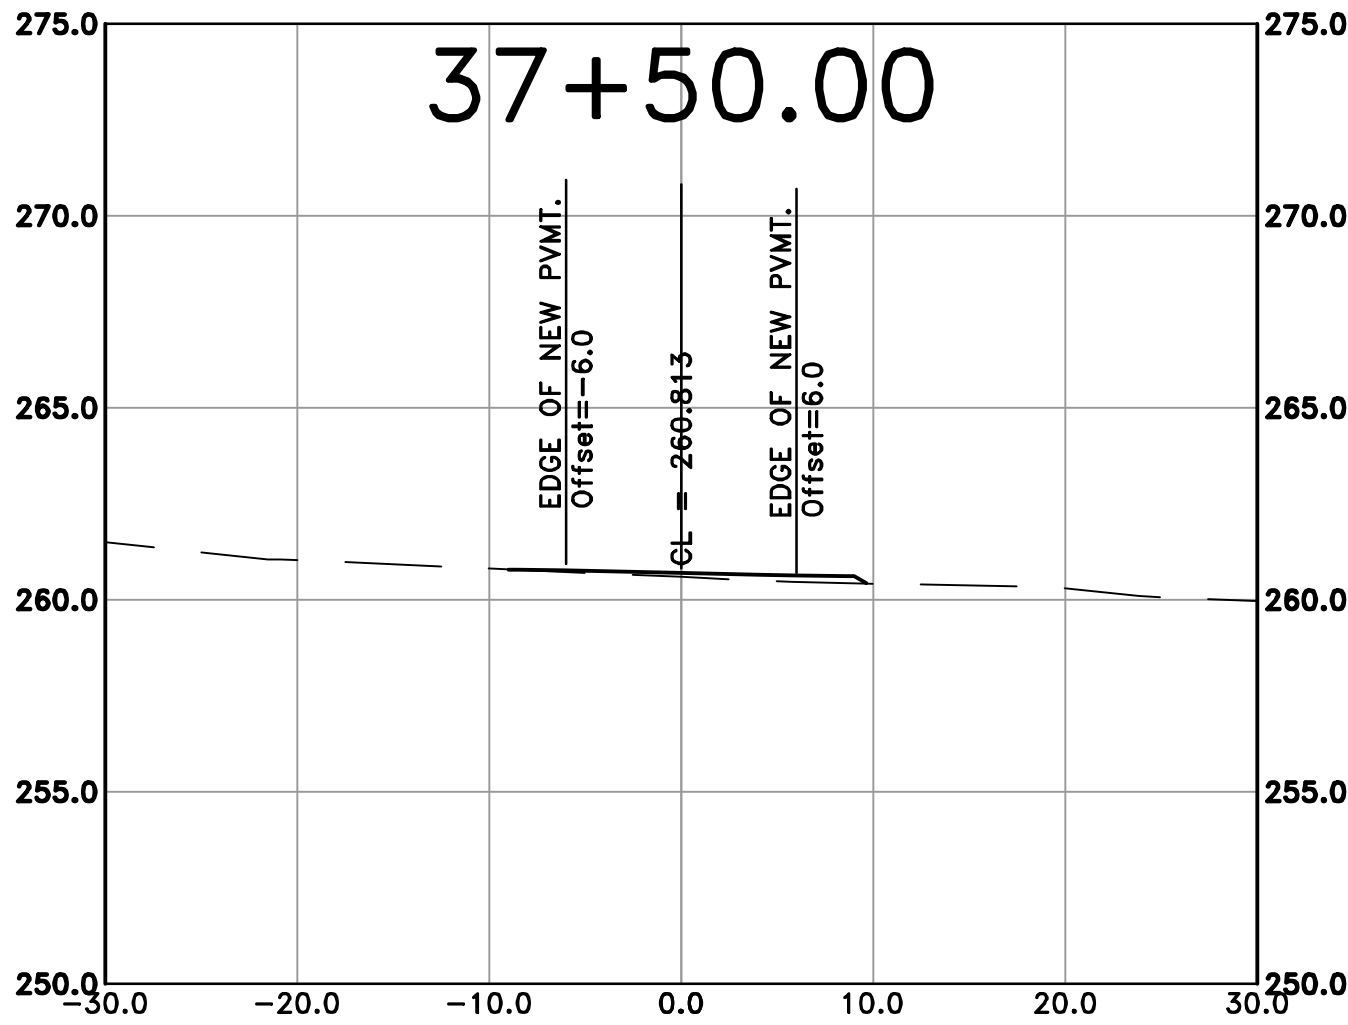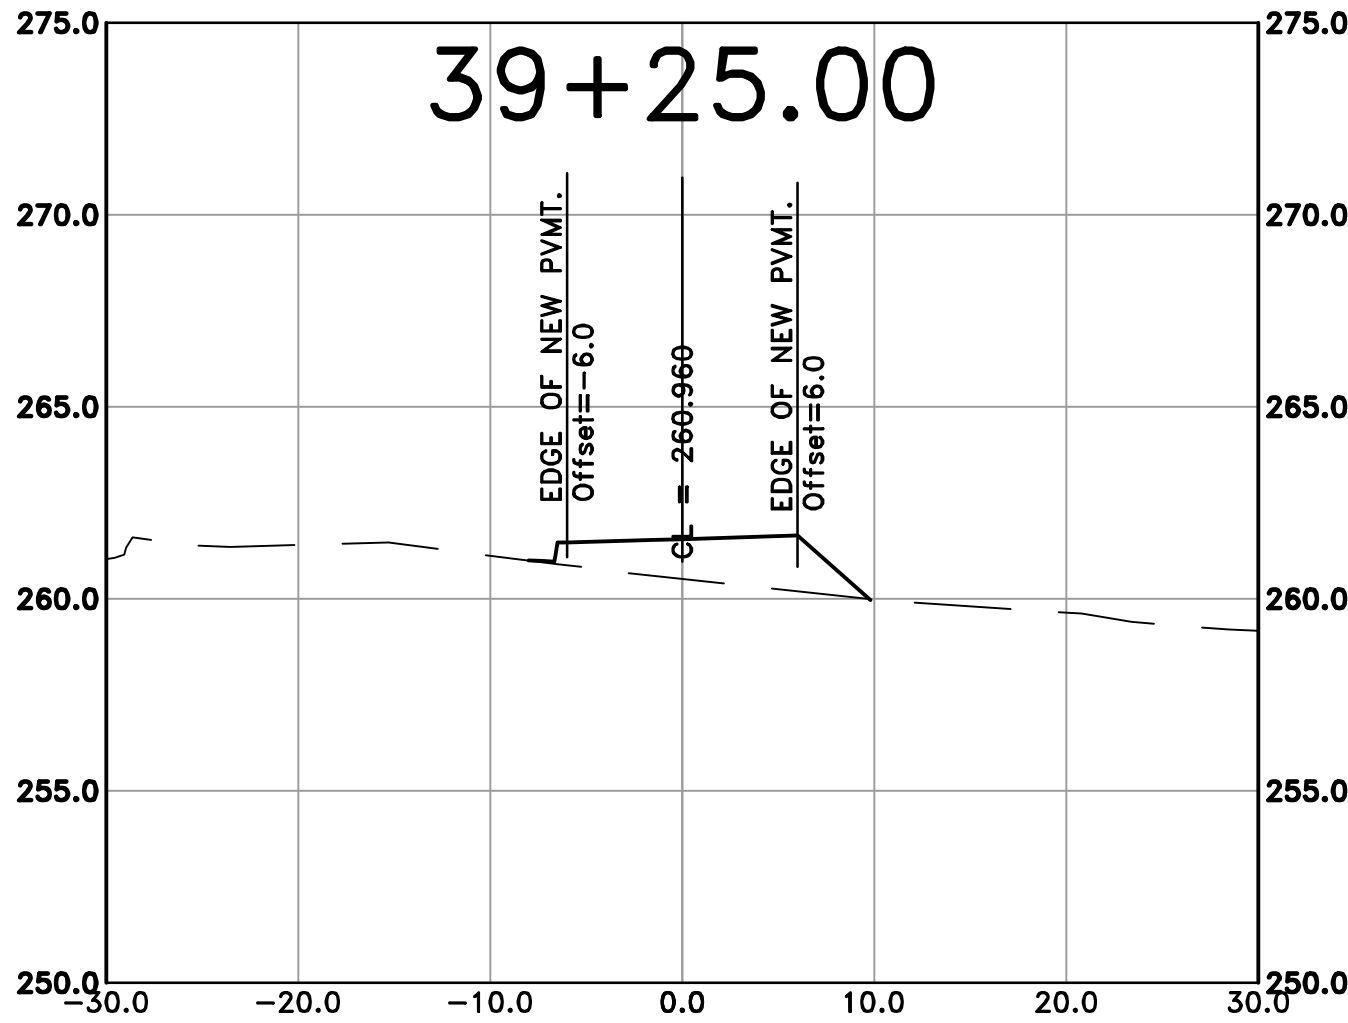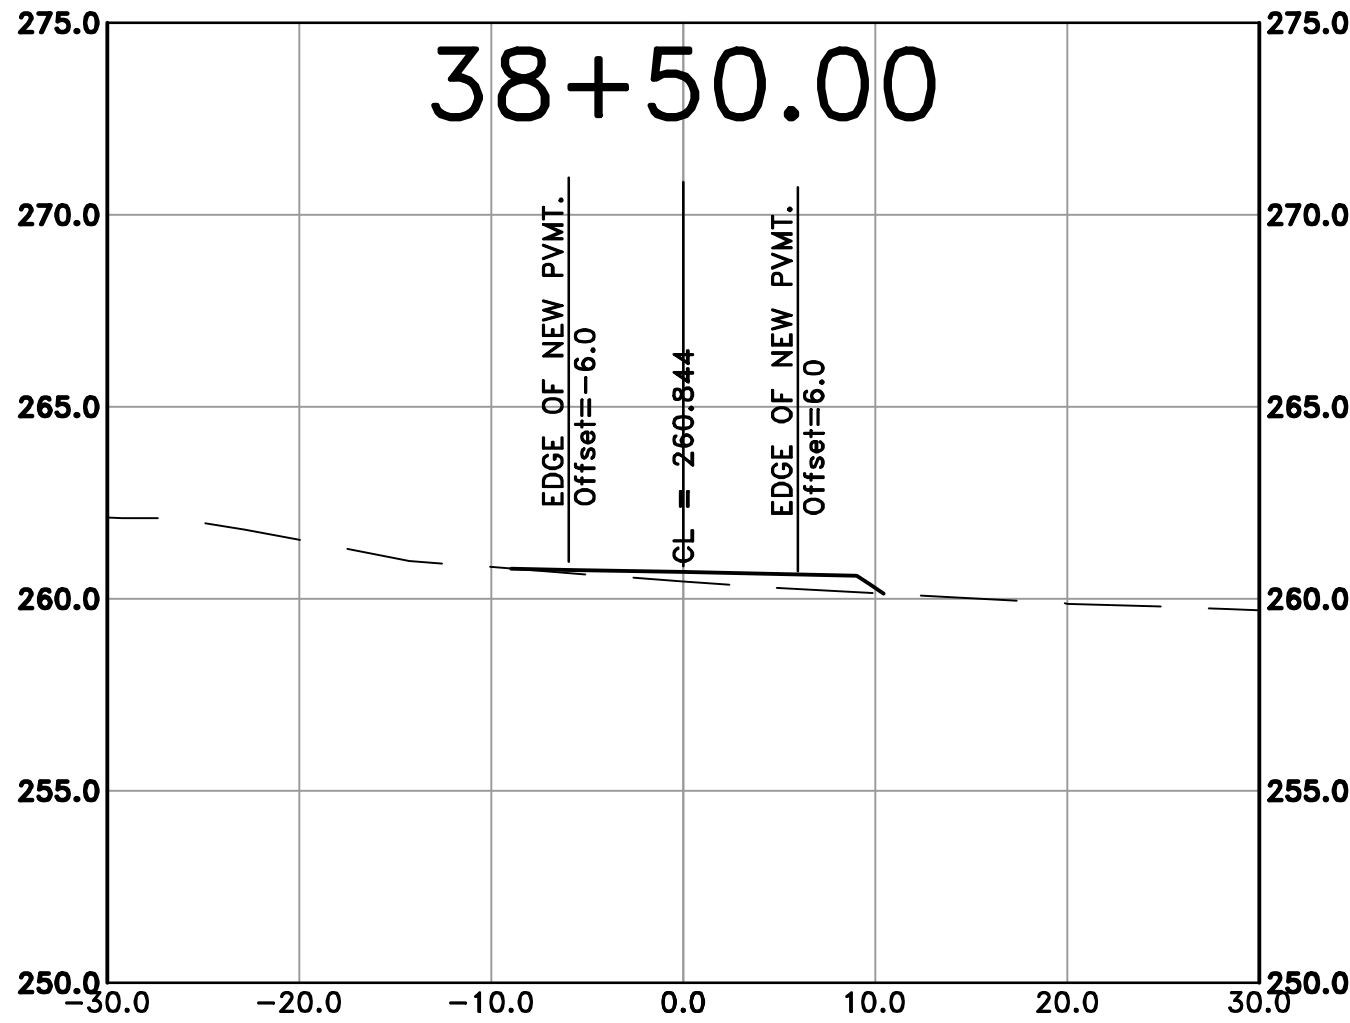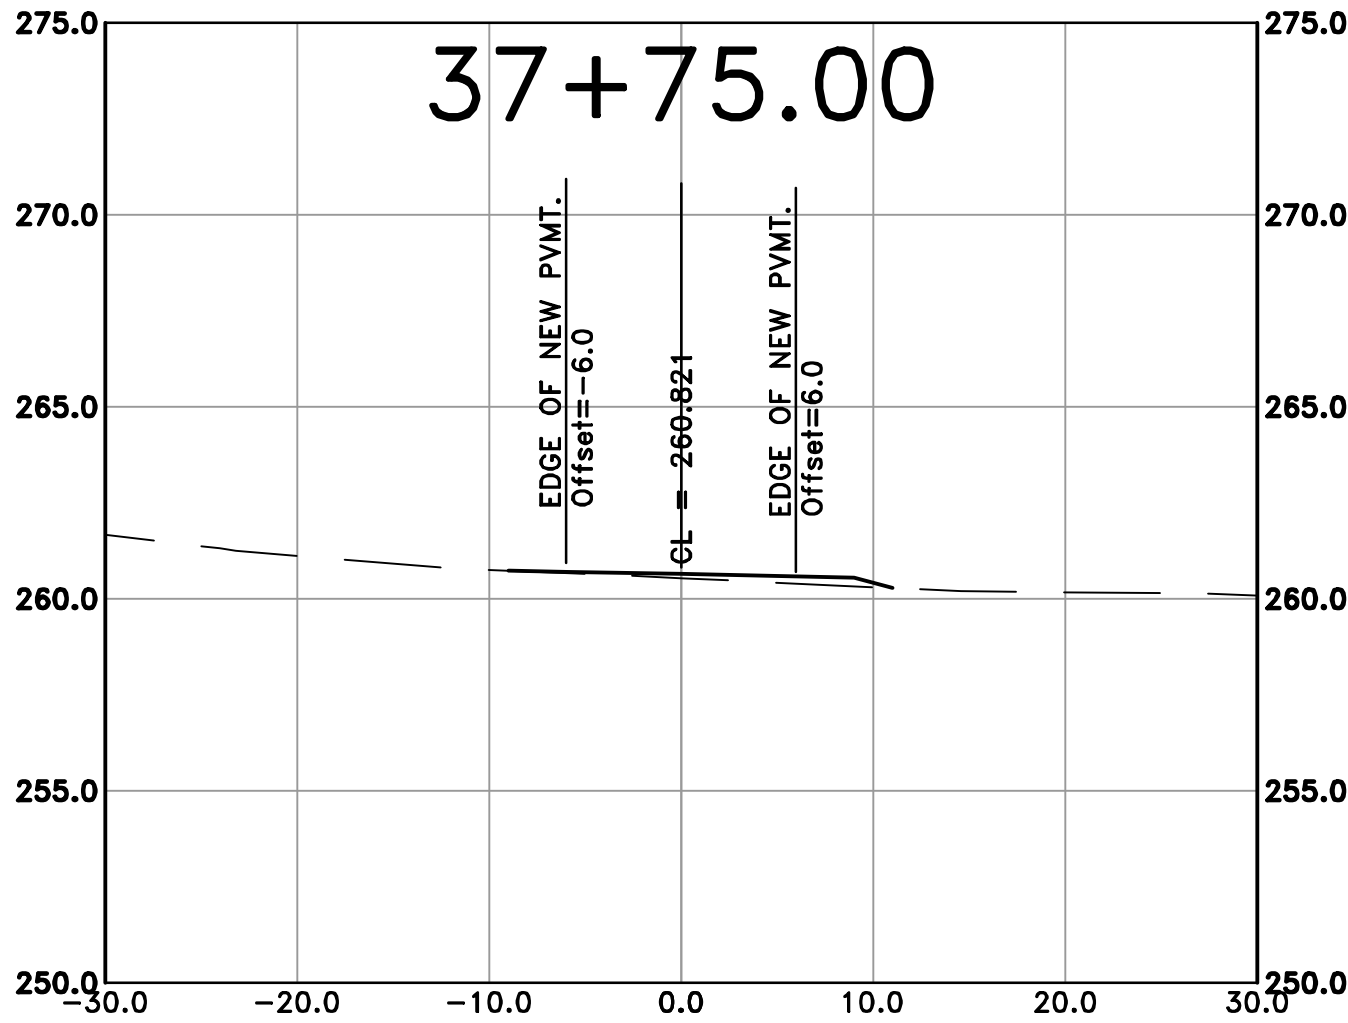

REVISIONS	DATE










CITY OF LITTLE ROCK, ARKANSAS
ROSE CREEK TRAIL
CROSS SECTION SHEET 13

DEPARTMENT OF PUBLIC WORKS
CIVIL ENGINEERING
701 W. MARKHAM
LITTLE ROCK, ARKANSAS 72201



DRAWN BY AS
DESIGNED LC
CHECKED JM
DATE 05-01-2026
SCALE H: 1"=40' V: 1"=10'
PROJECT NO. 23805201
SHEET NO. C62

100% SUBMITTAL

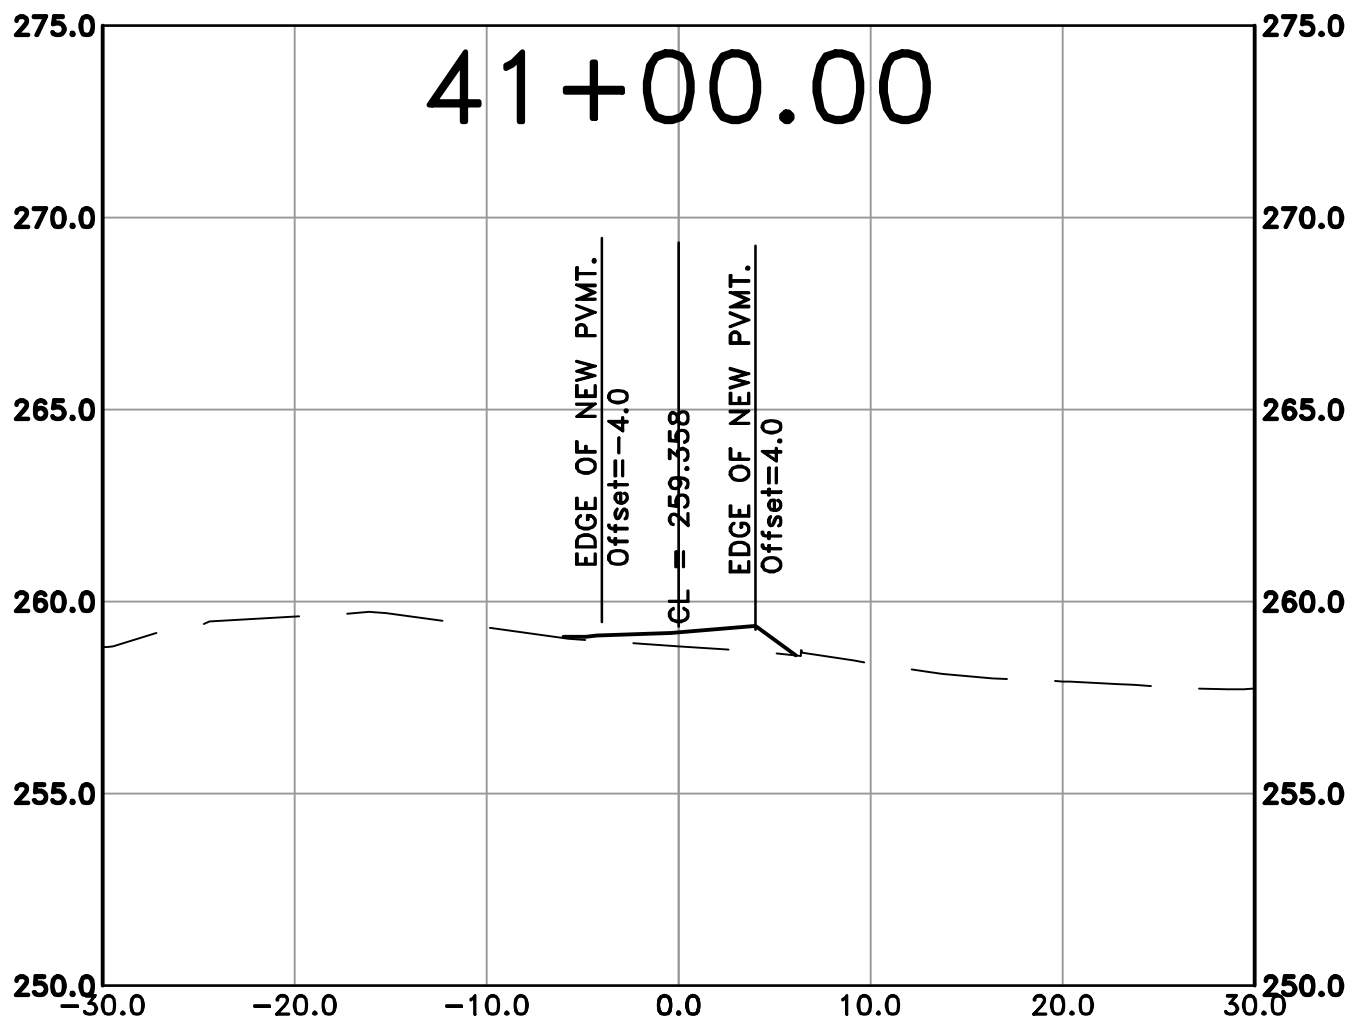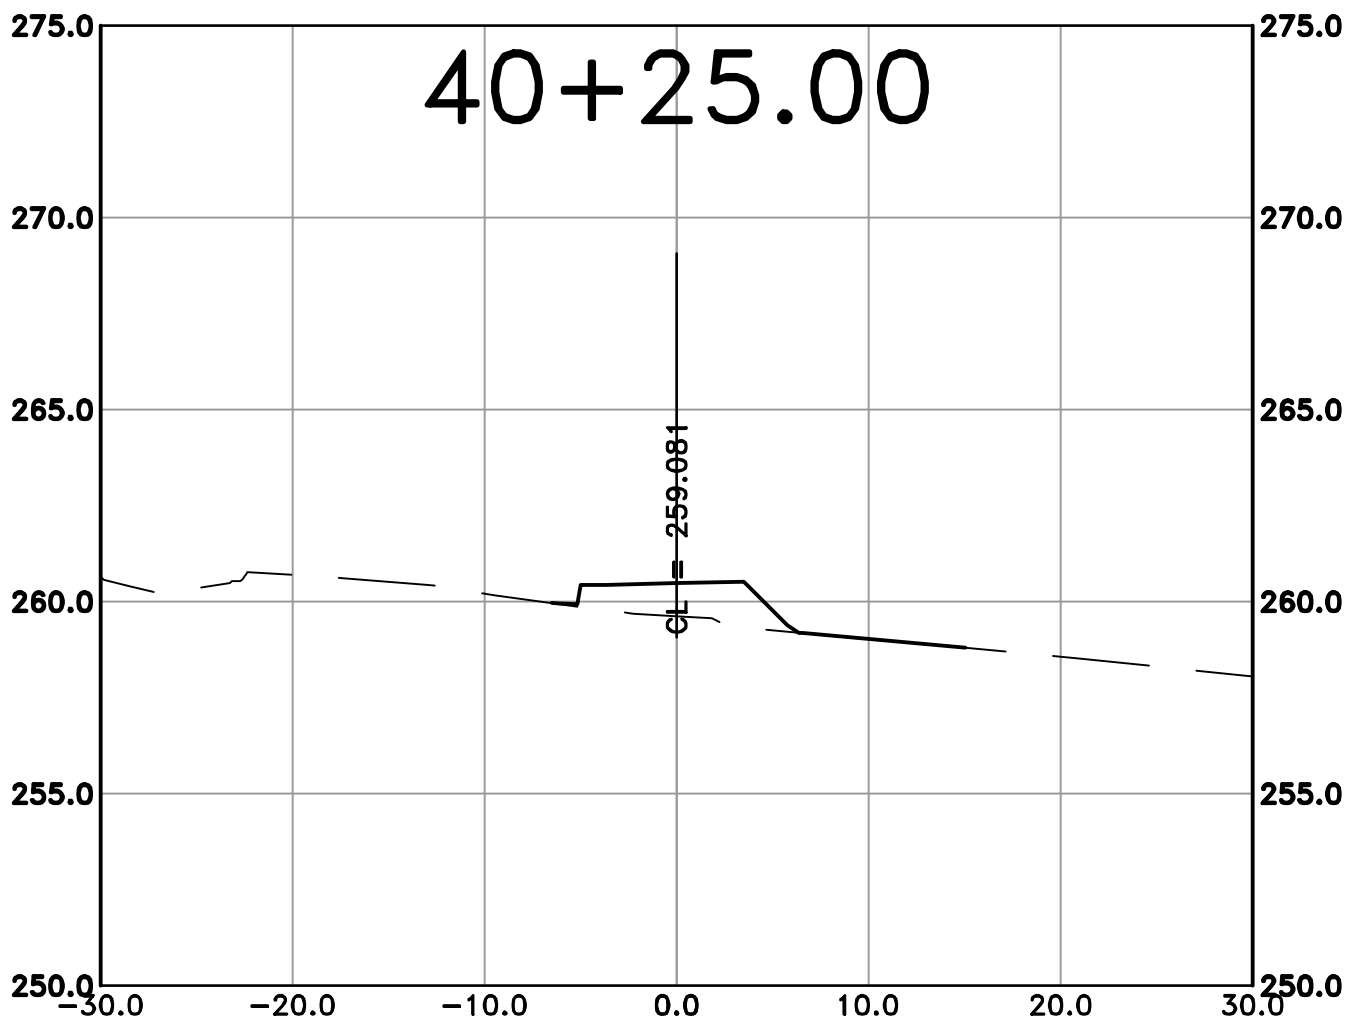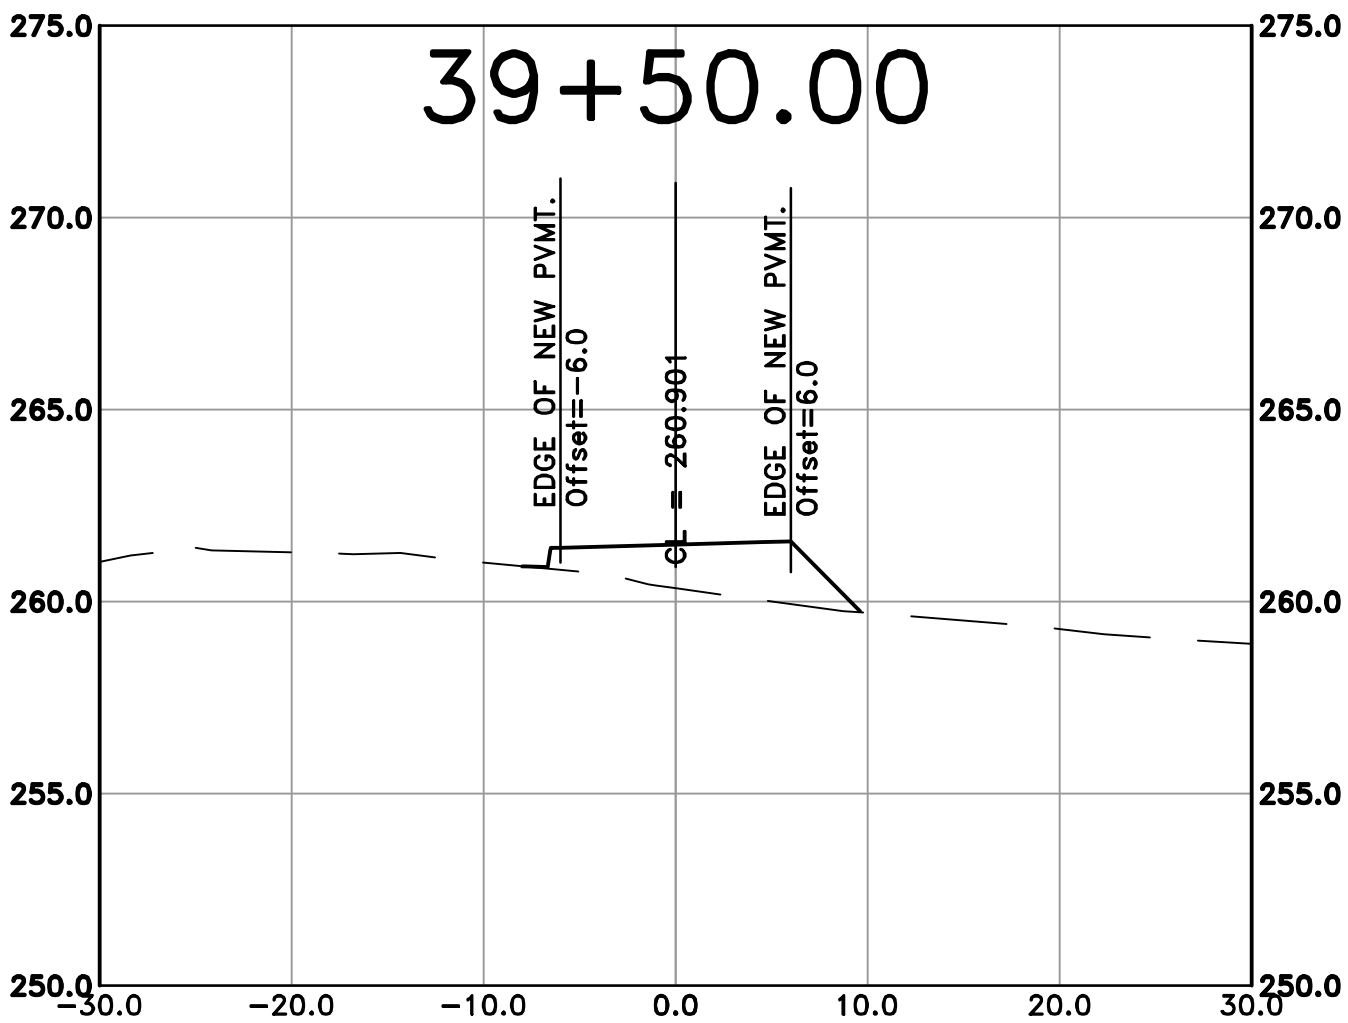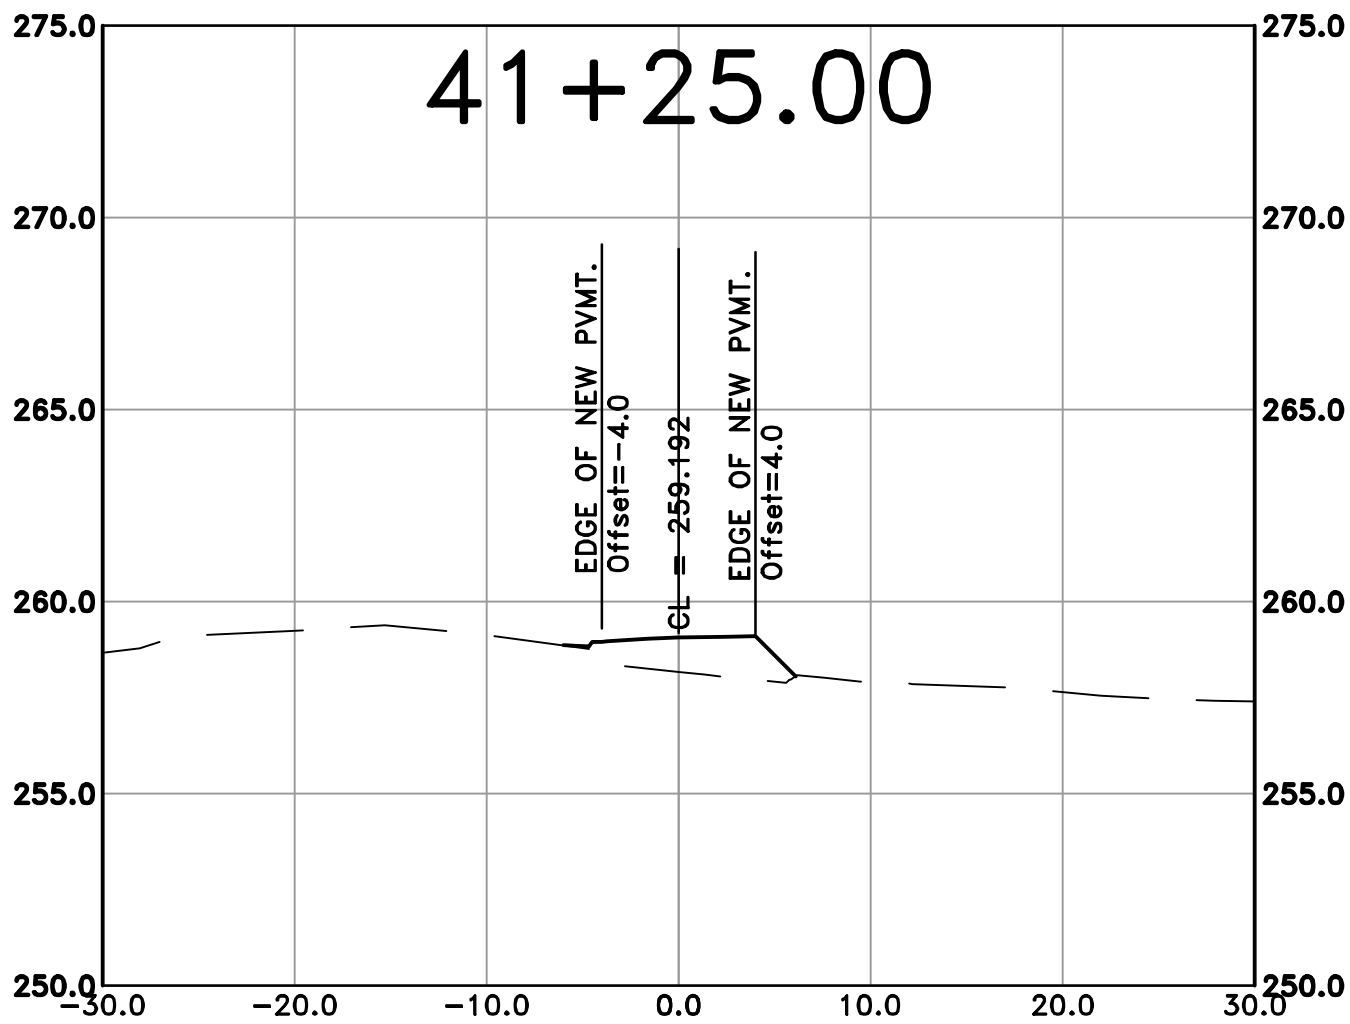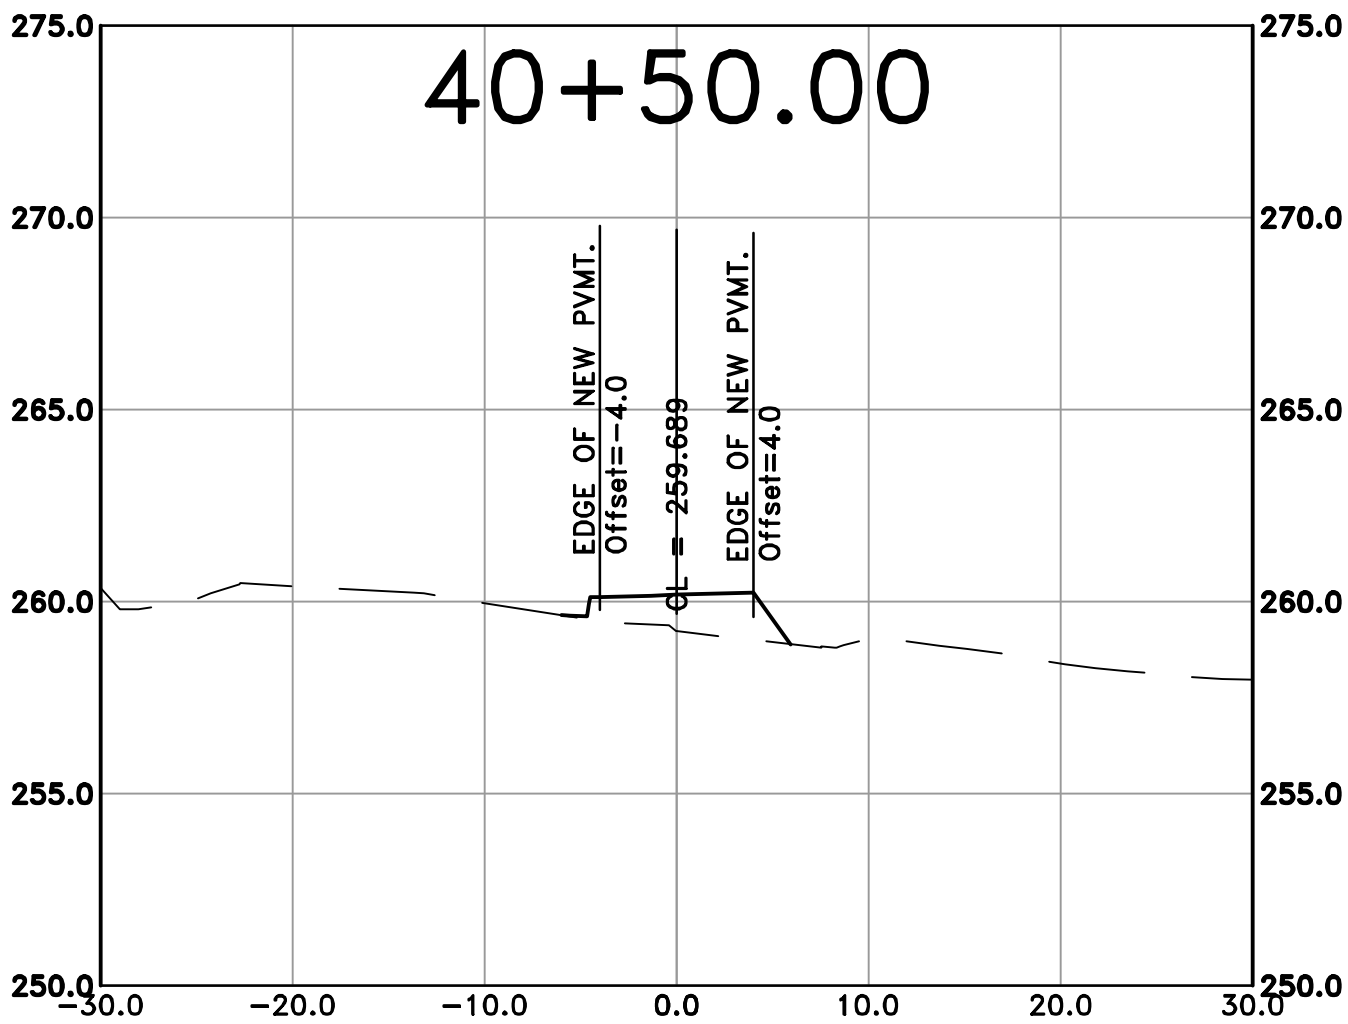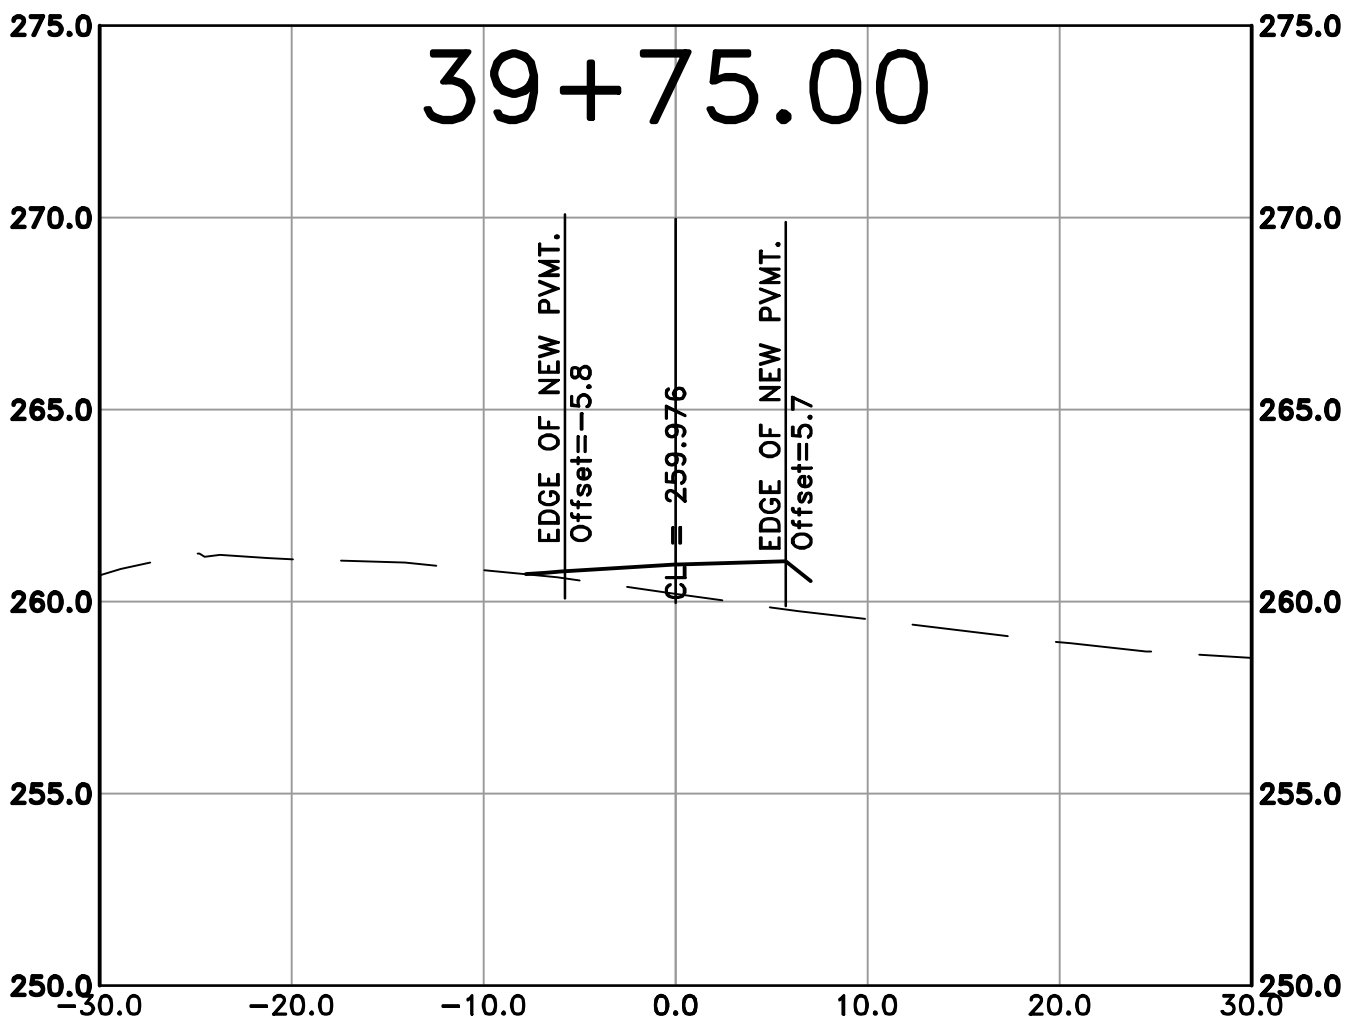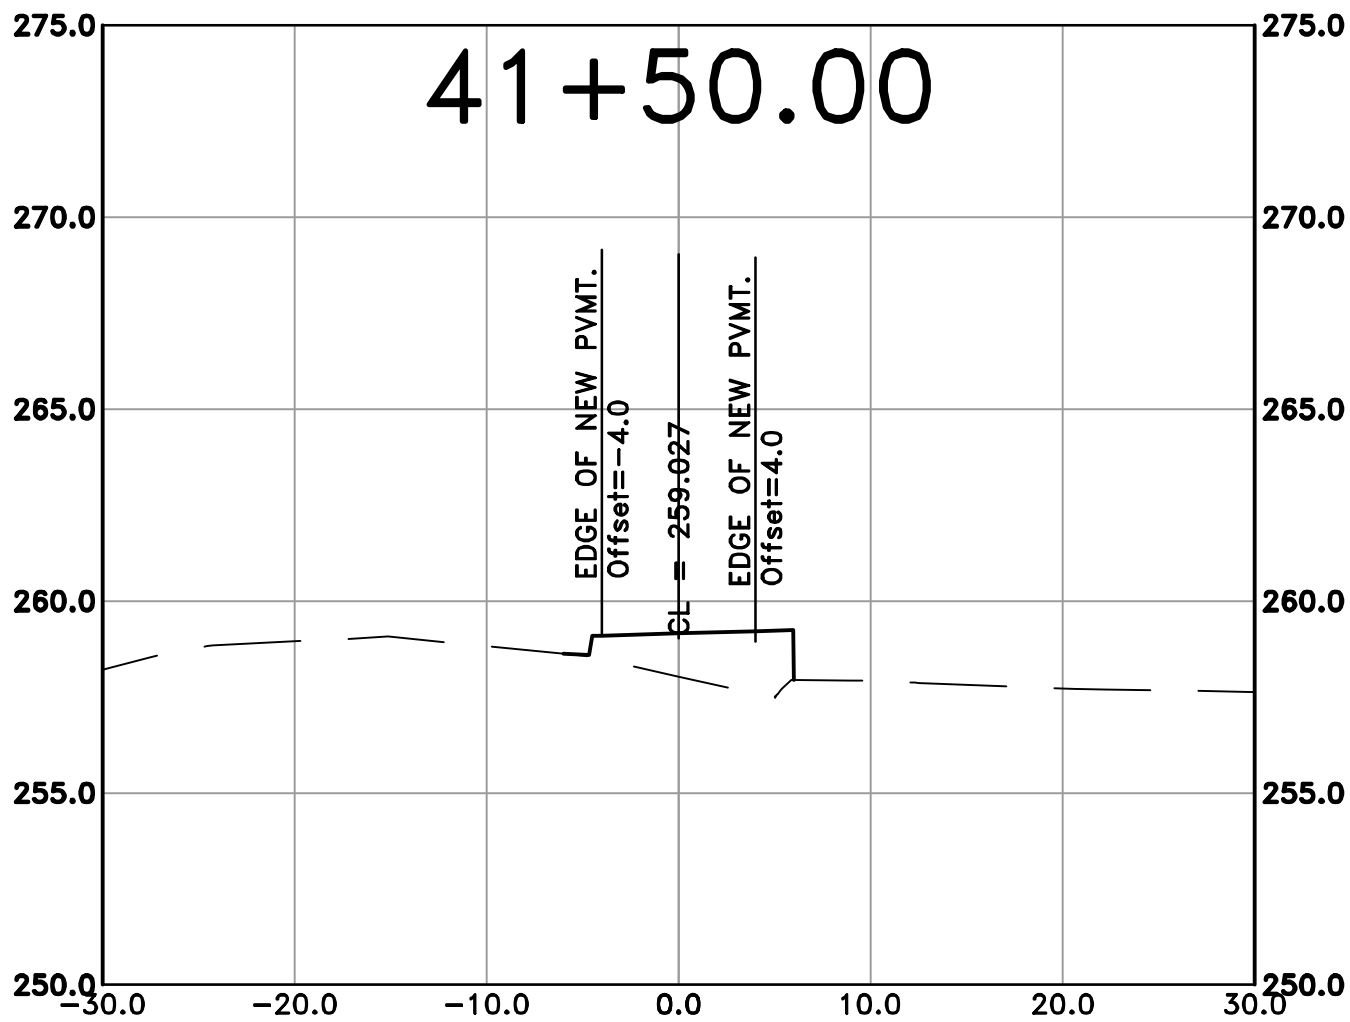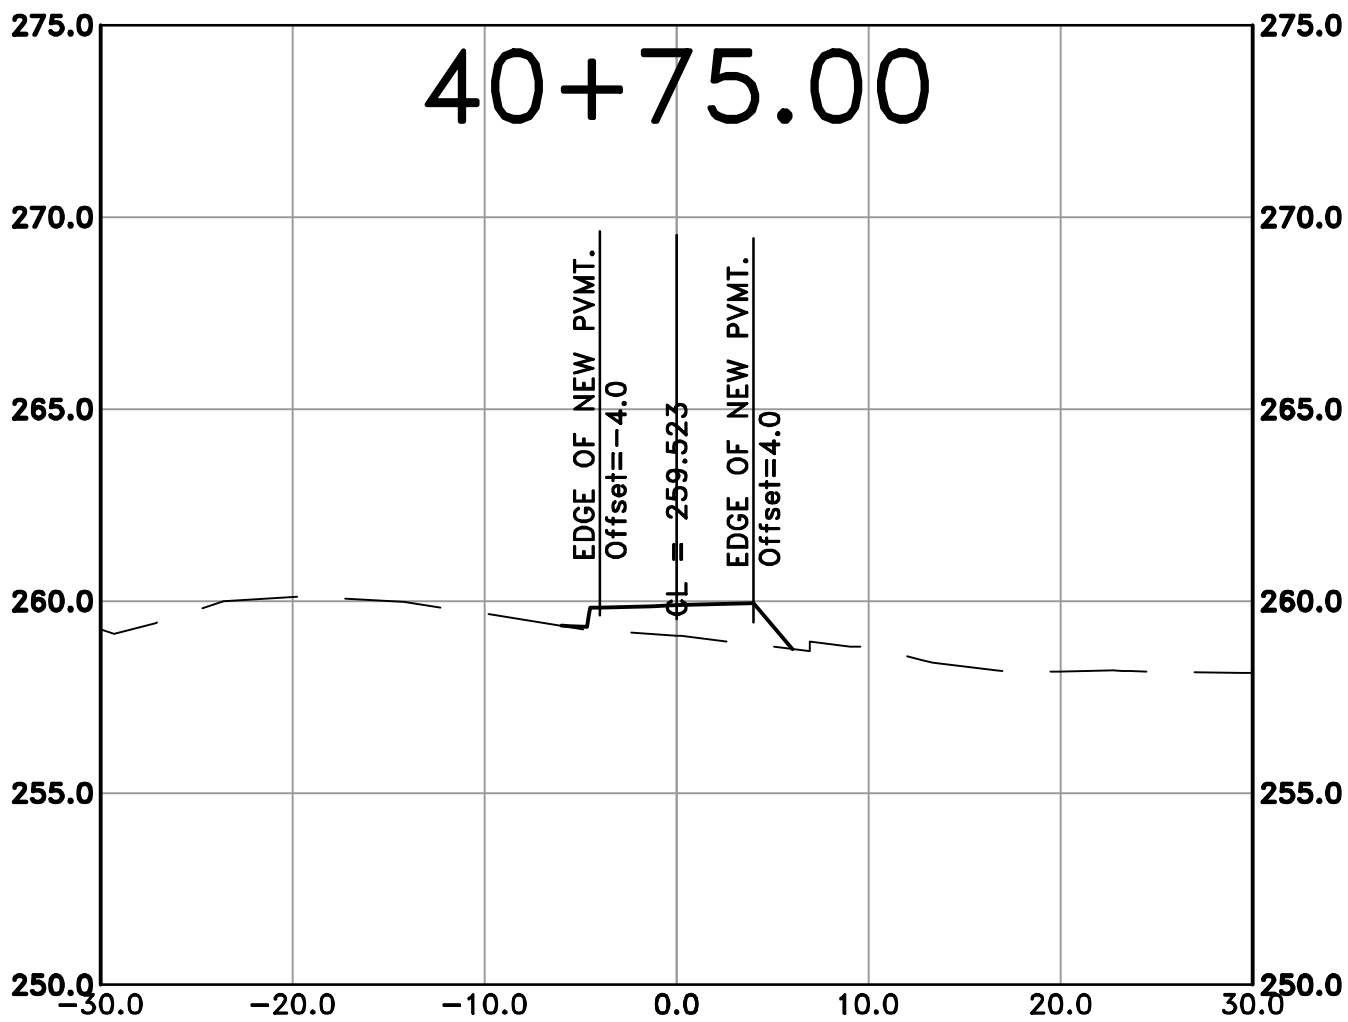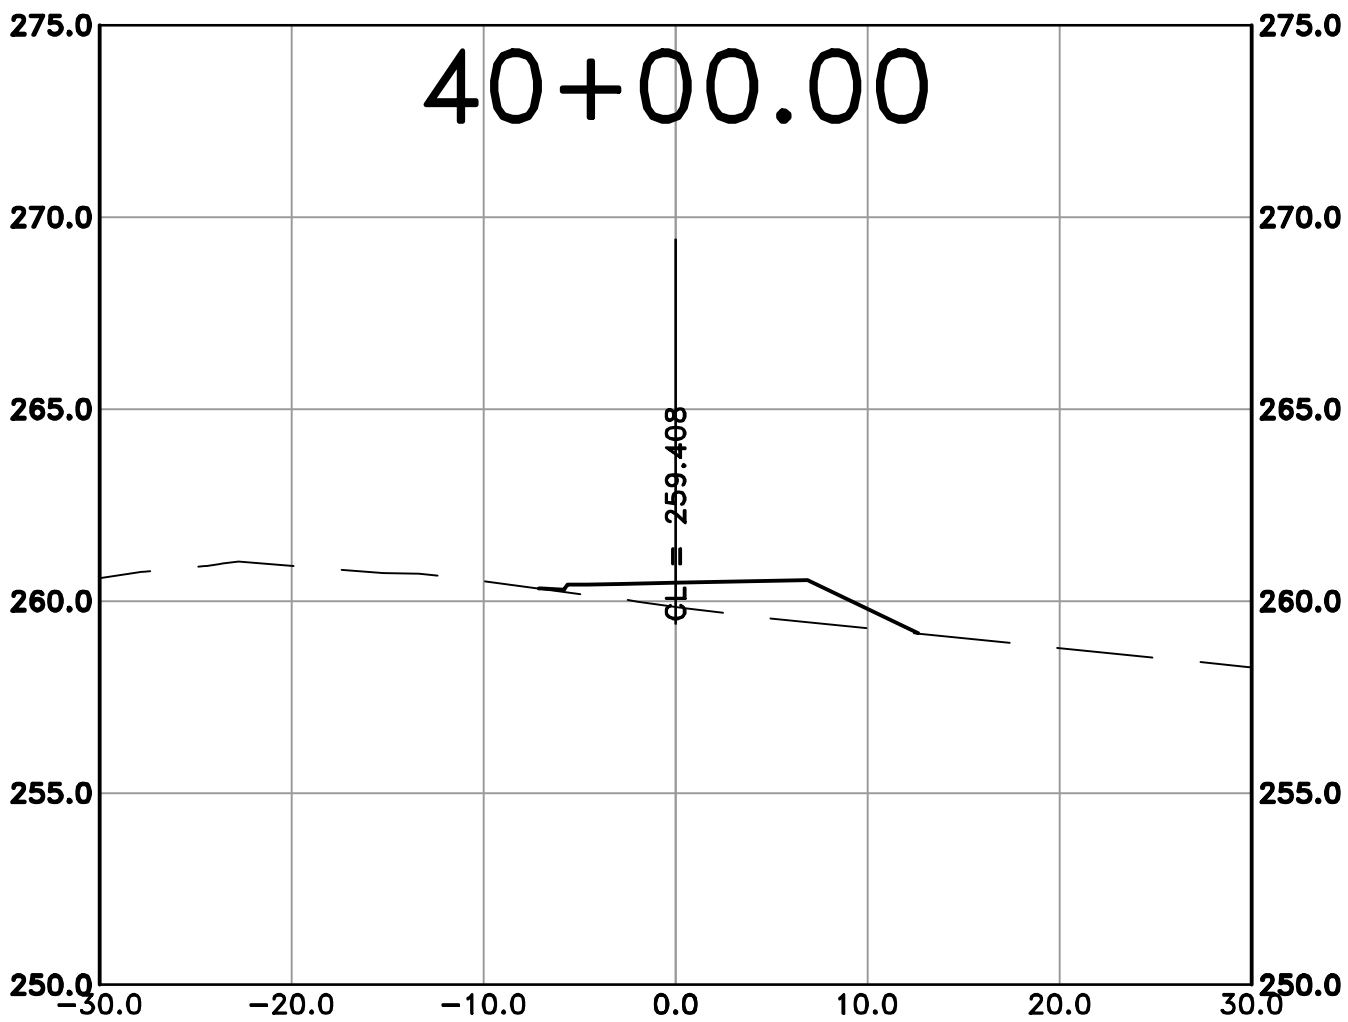

REVISIONS	DATE








CITY OF LITTLE ROCK, ARKANSAS
ROSE CREEK TRAIL
CROSS SECTION SHEET 14

DEPARTMENT OF PUBLIC WORKS
CIVIL ENGINEERING
701 W. MARKHAM
LITTLE ROCK, ARKANSAS 72201



DRAWN BY
AS
DESIGNED
LC
CHECKED
JM
DATE
05-01-2026
SCALE
H: 1"=40'
V: 1"=10'
PROJECT NO.
23805201
SHEET NO.
C63

100% SUBMITTAL

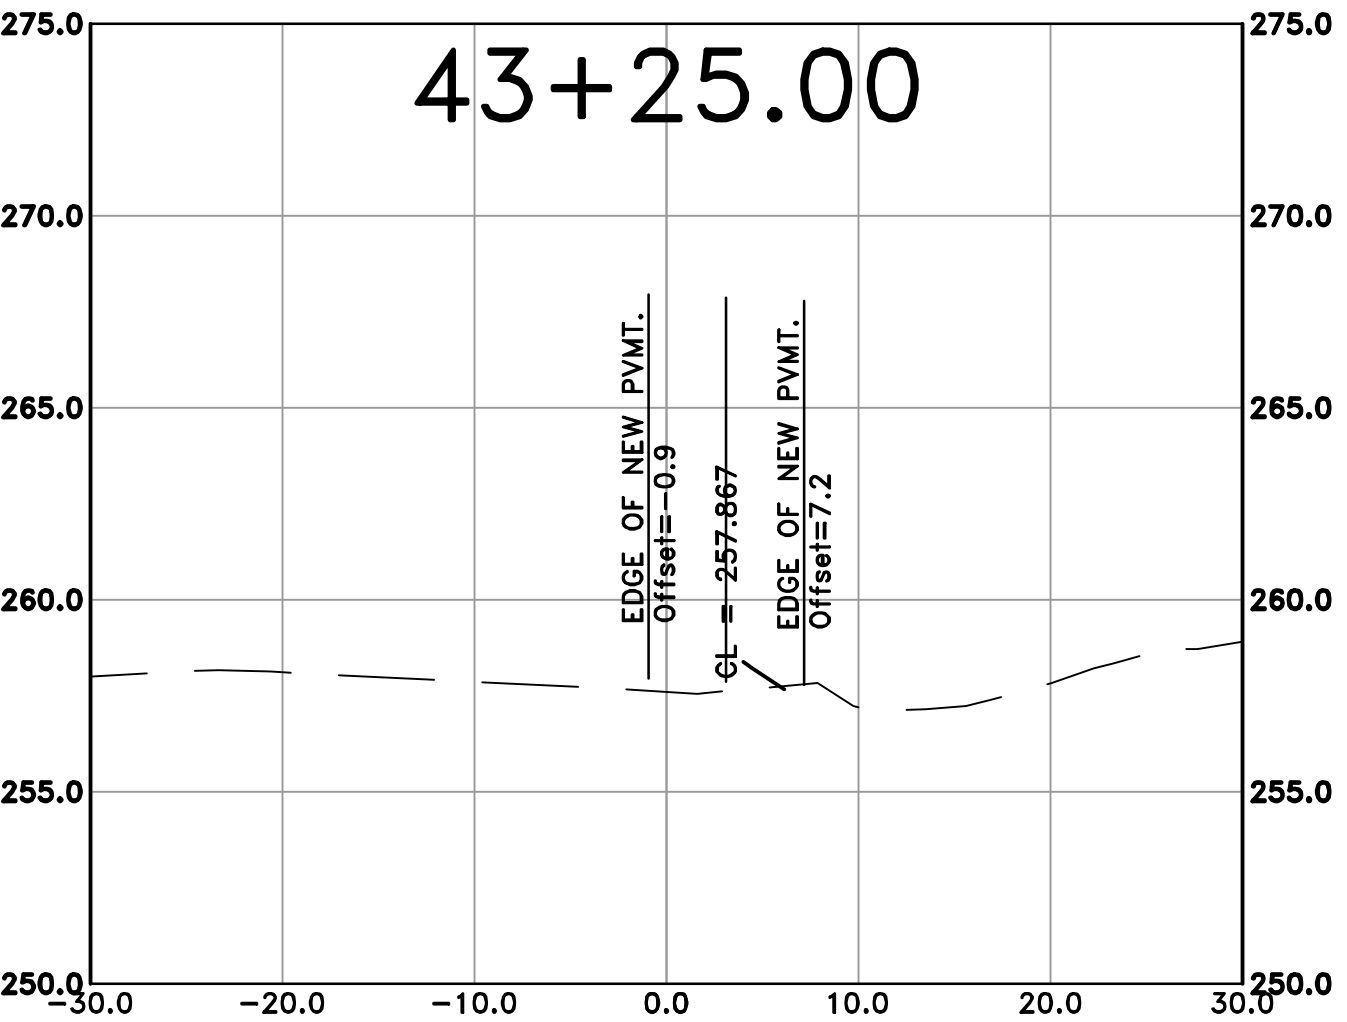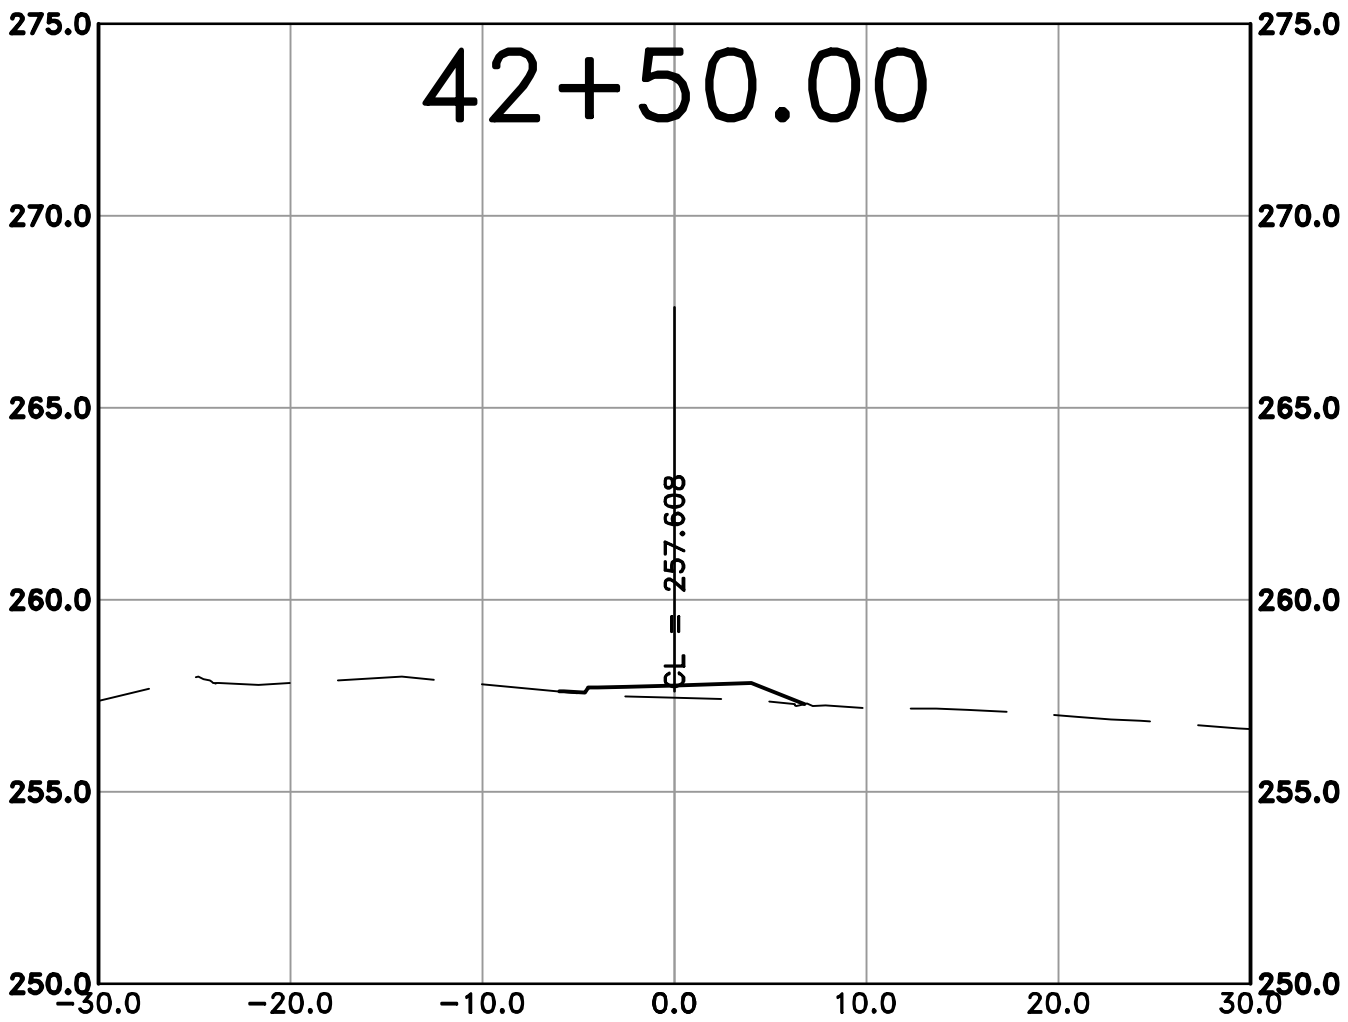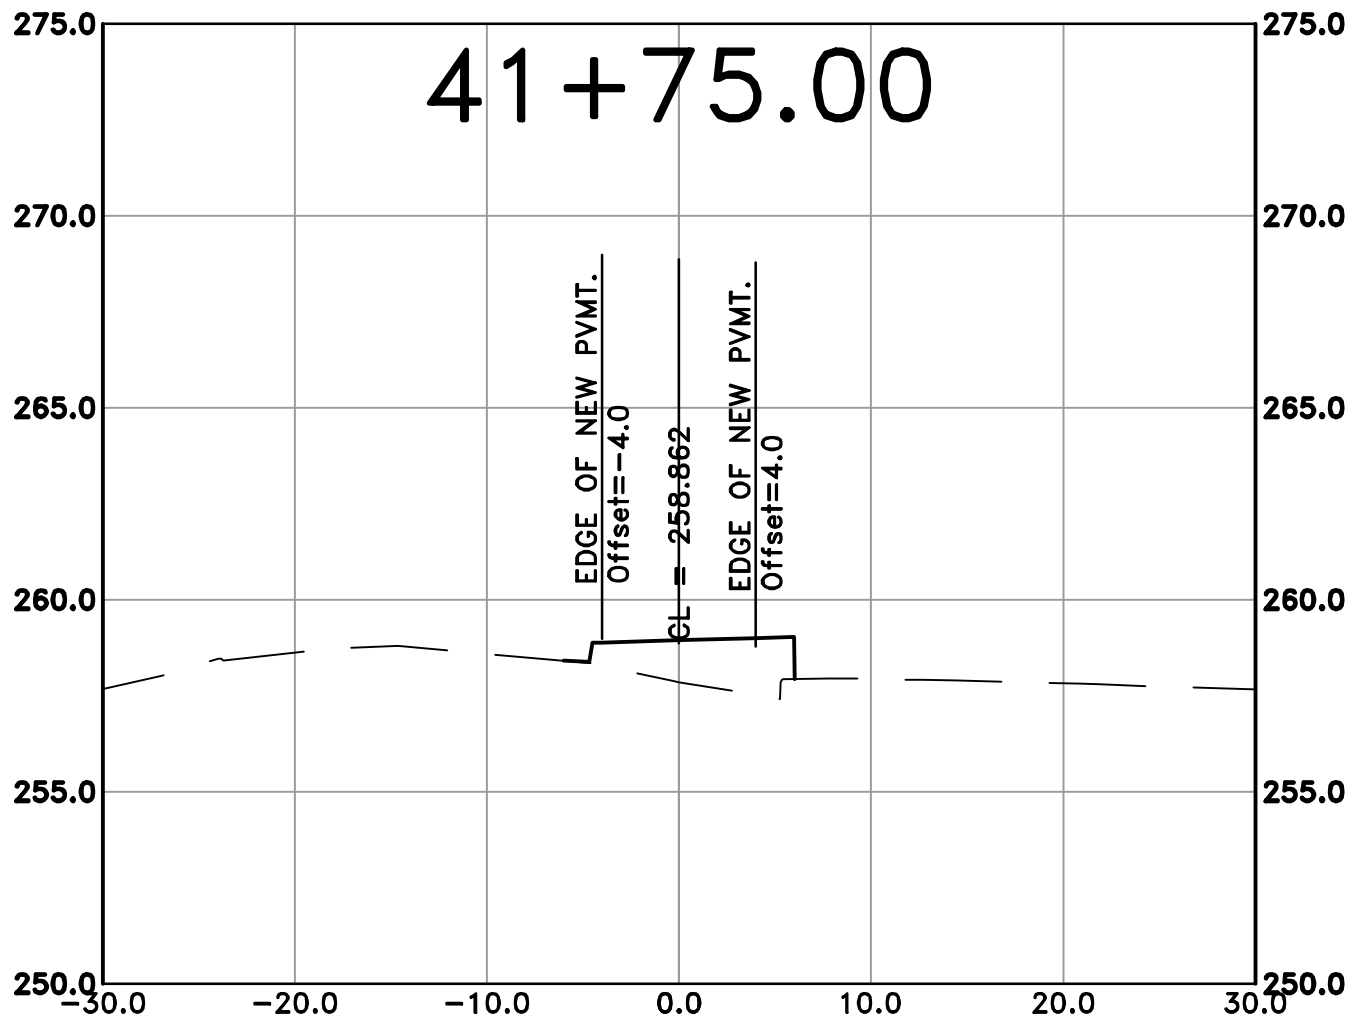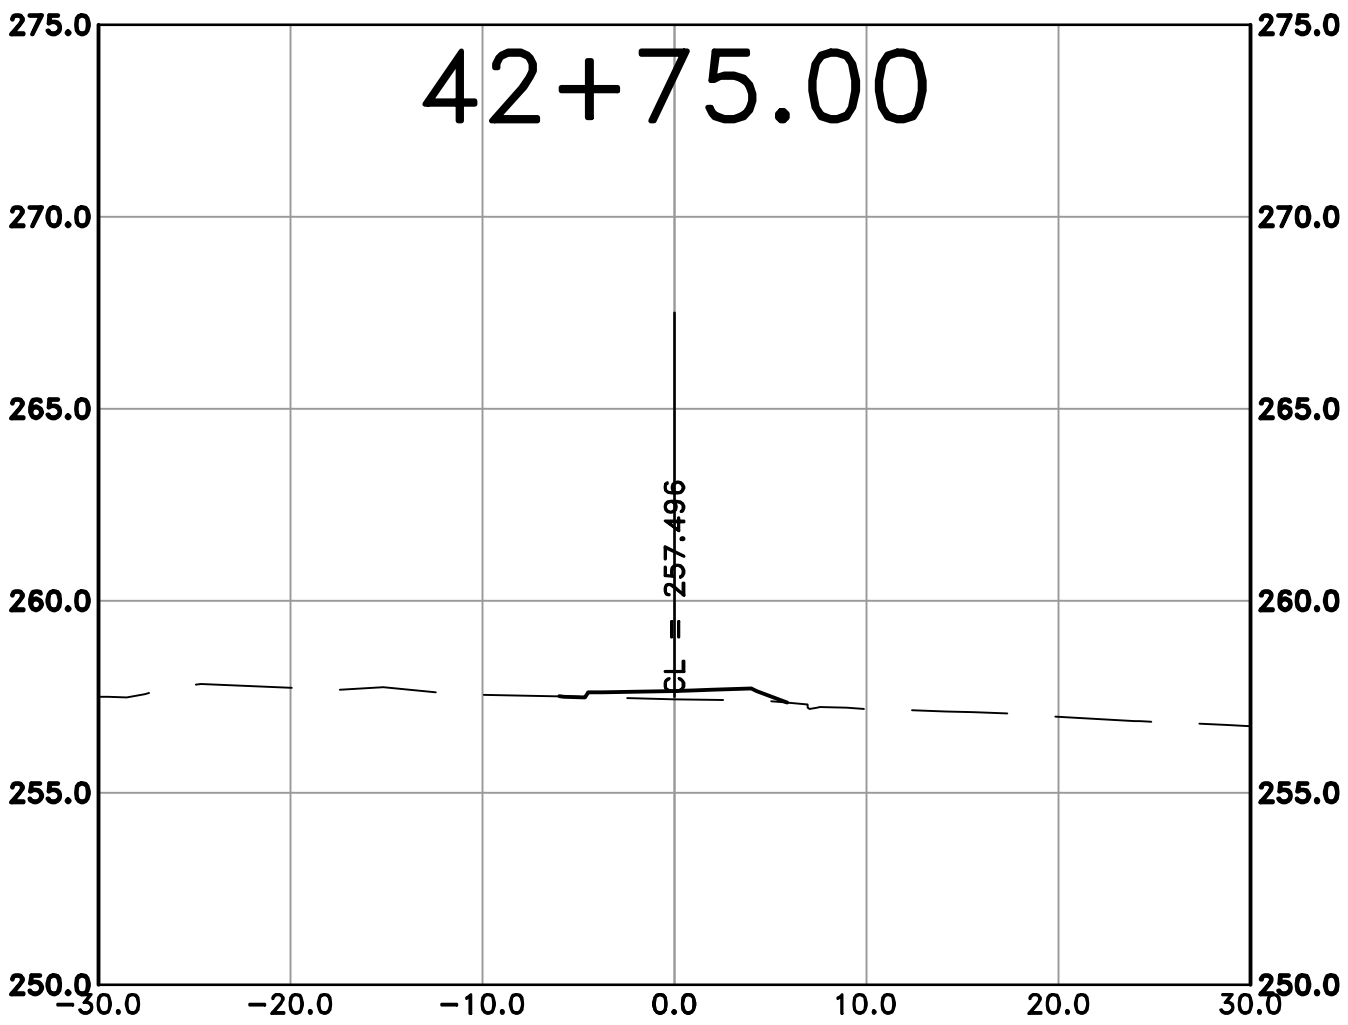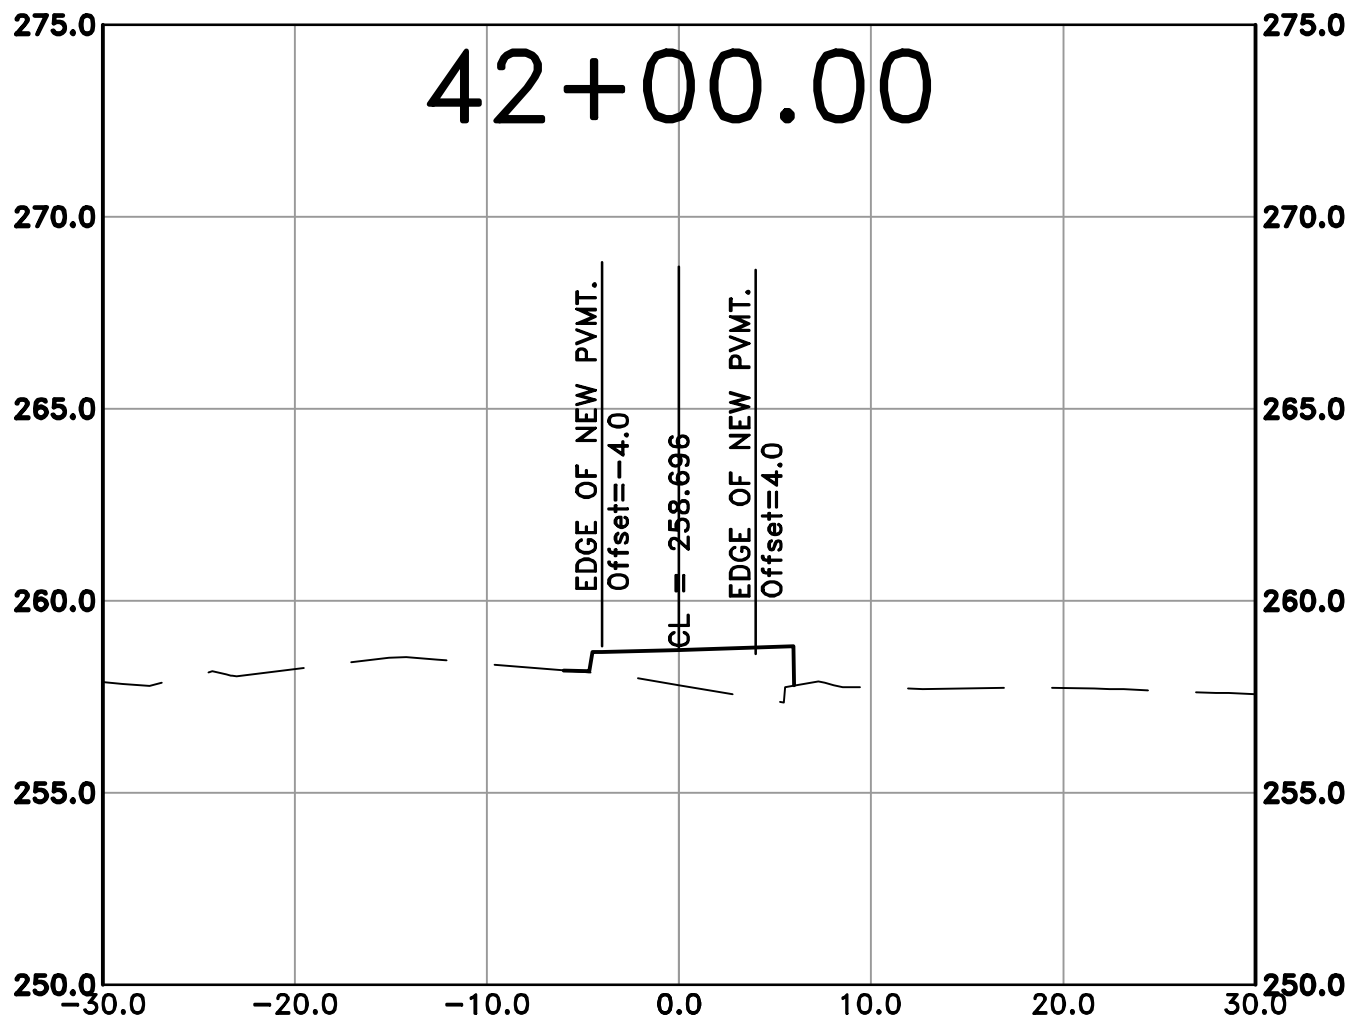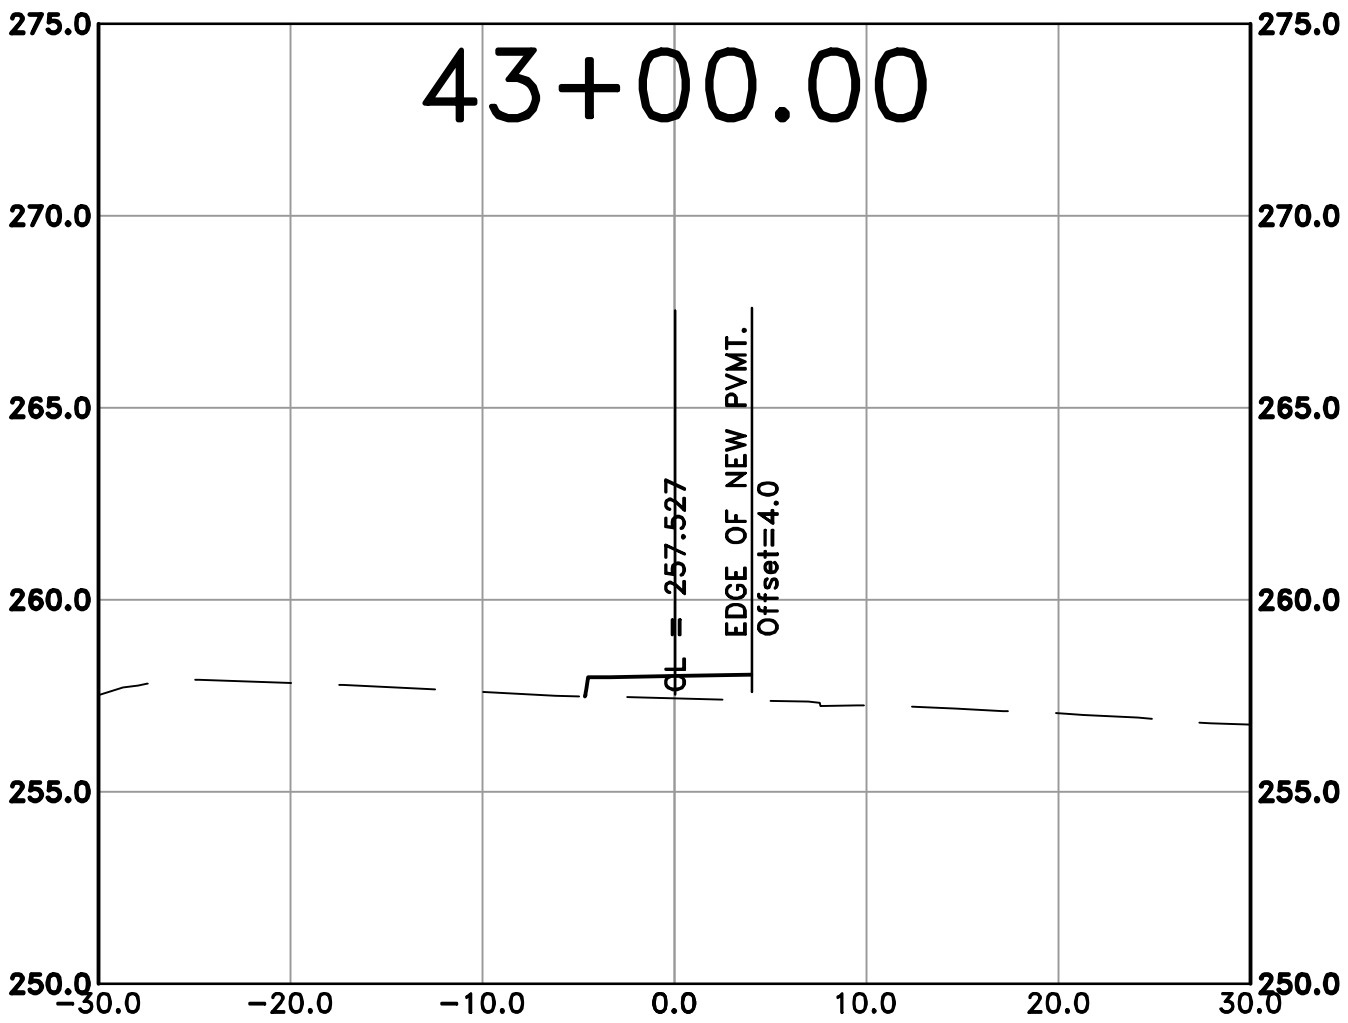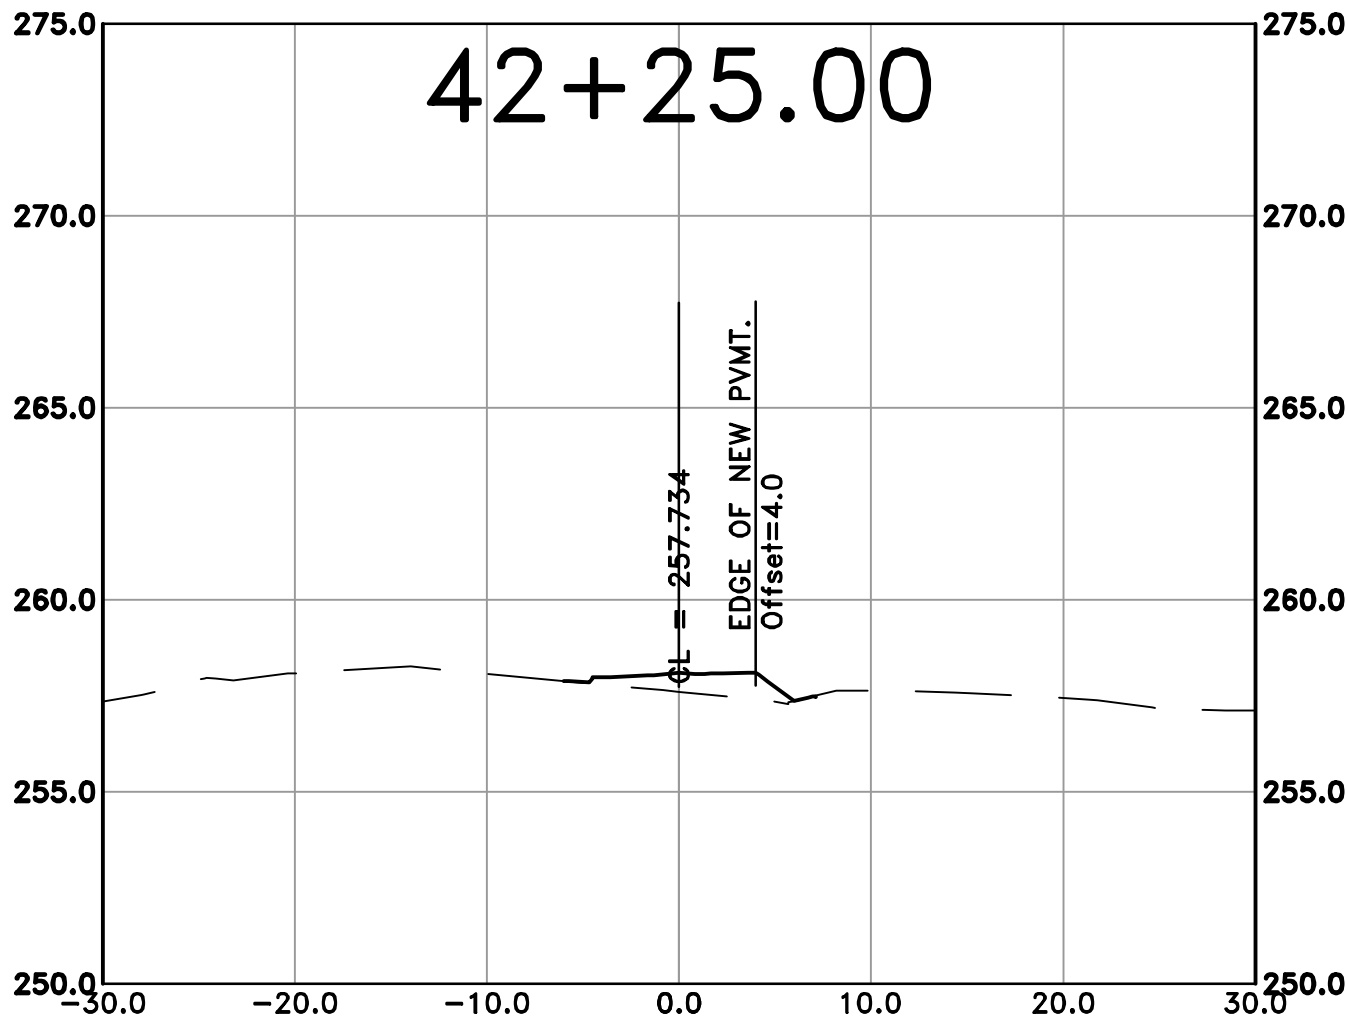

REVISIONS	DATE

CITY OF LITTLE ROCK, ARKANSAS
ROSE CREEK TRAIL
CROSS SECTION SHEET 15

DEPARTMENT OF PUBLIC WORKS
CIVIL ENGINEERING
701 W. MARKHAM
LITTLE ROCK, ARKANSAS 72201



DRAWN BY	AS
DESIGNED	LC
CHECKED	JM
DATE	05-01-2026
SCALE	H: 1"=40' V: 1"=10'
PROJECT NO.	23805201
SHEET NO.	C64